




Call before you Dig.
1-800-227-2600
UNDERGROUND UTILITY SERVICE ALERT

SAFETY ALERT
Call before you Overhead.
593-6111
OVERHEAD SERVICE ALERT

 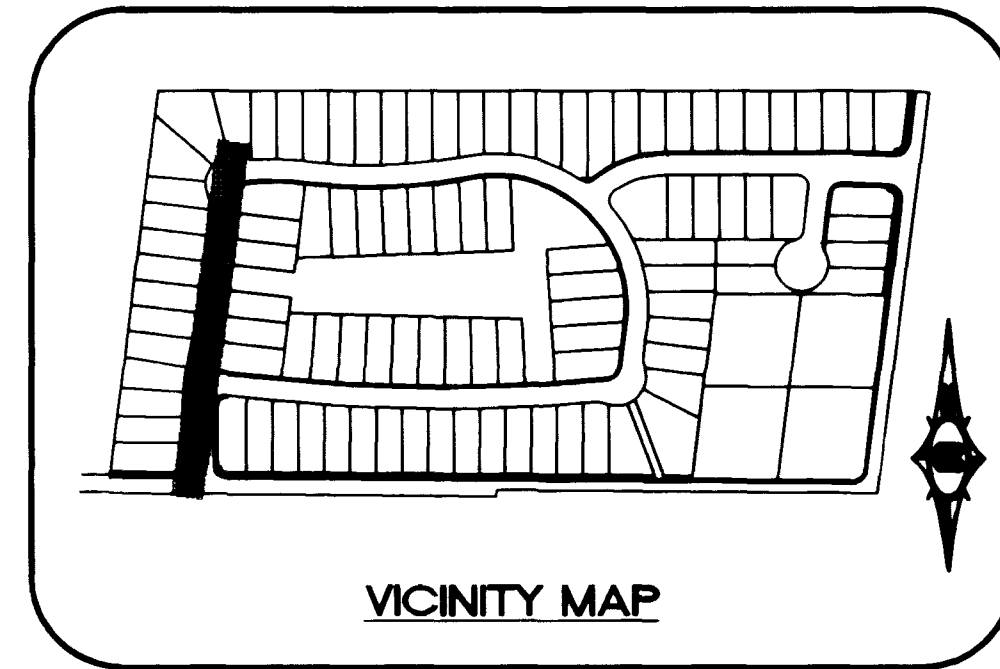


BASIS OF BEARING
NORTH 88°46'05" EAST BEING THE CENTERLINE OF AZURE DRIVE AS SHOWN ON RECORDS OF SURVEY FILE 52 PAGE 70 AND FILE 90 PAGE 44 IN THE OFFICE OF THE COUNTY RECORDER, CLARK COUNTY NEVADA.

BENCHMARK
CITY OF LAS VEGAS BENCHMARK #23 1LV9025M4 BEING AN ALCAP ON REBAR AT THE CENTERLINE INTERSECTION OF CENTENNIAL PKWY. AND BRADLEY ROAD.
NAVD88 ELEVATION: 2302.77' = 701.8865 METERS

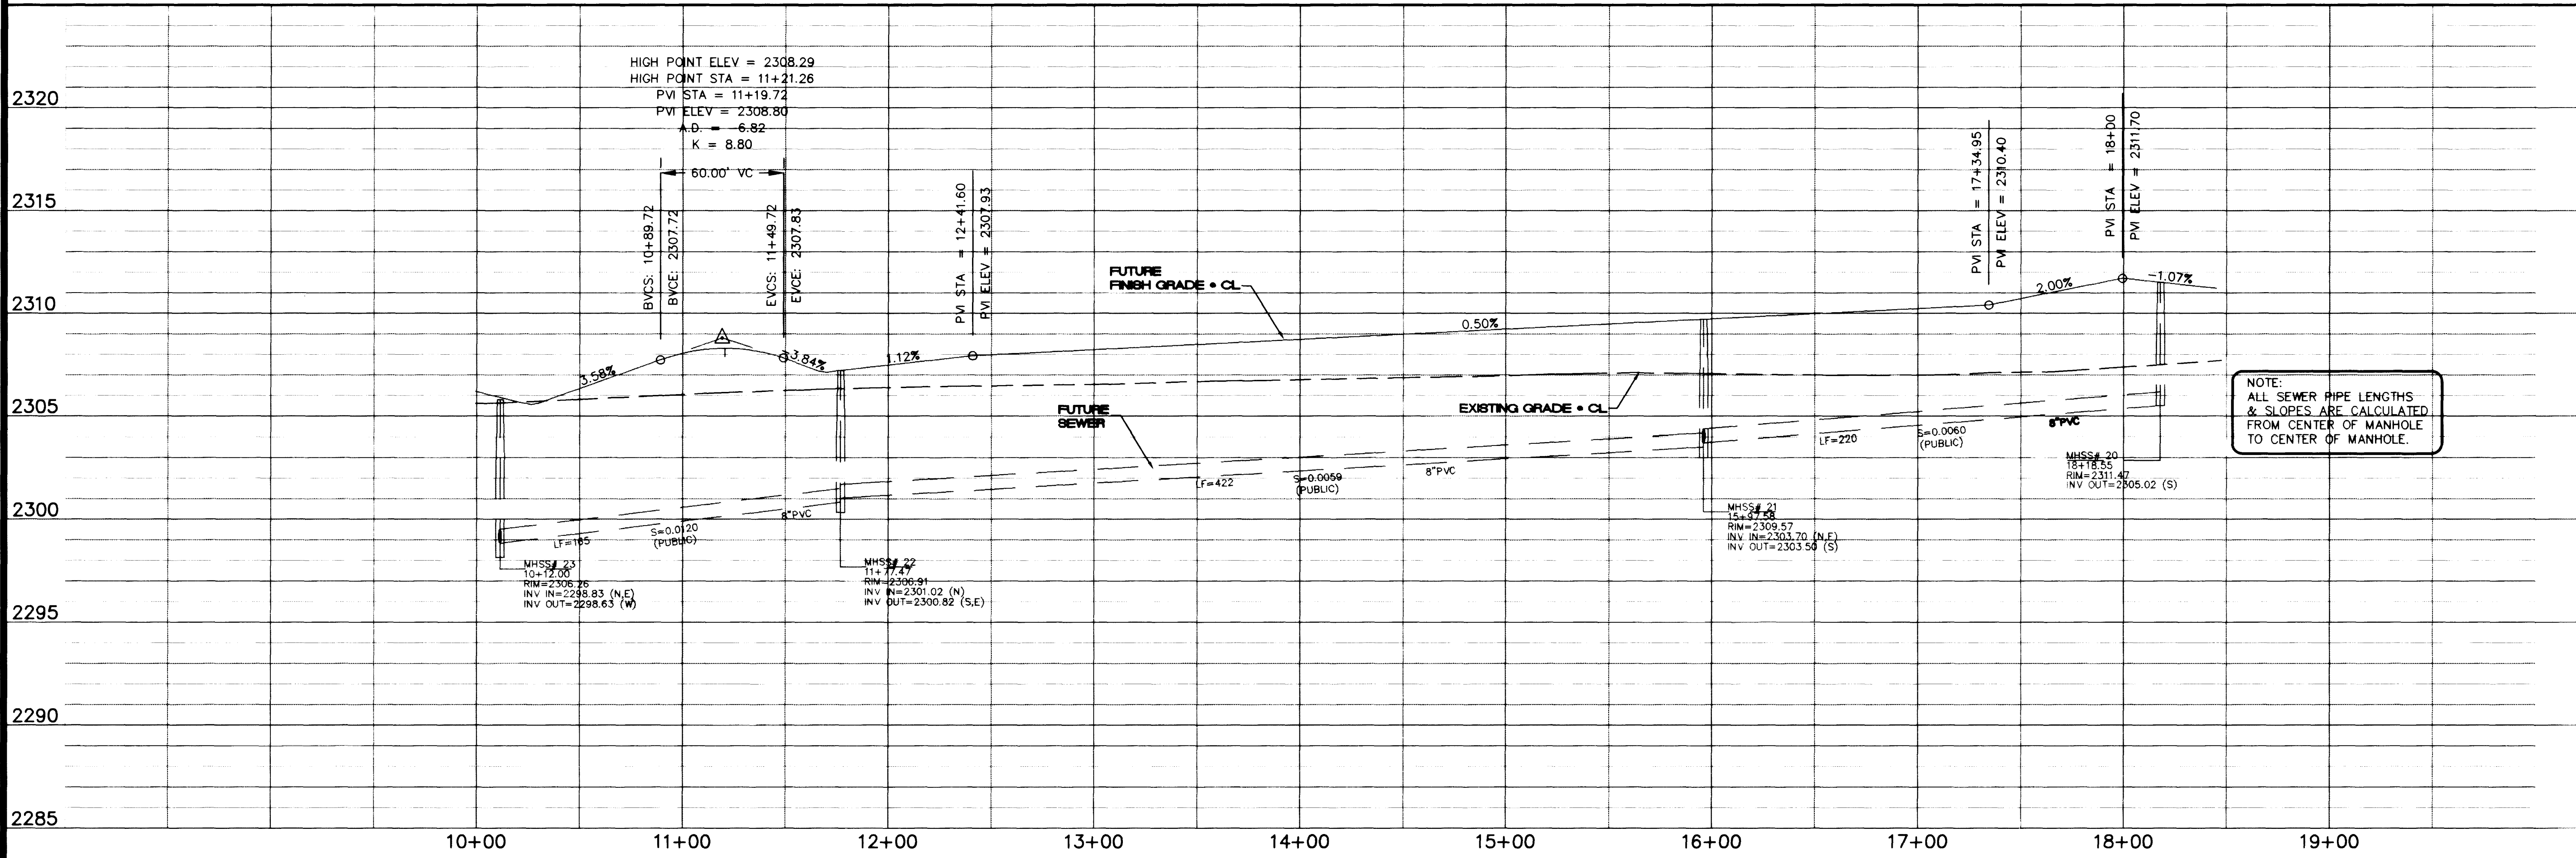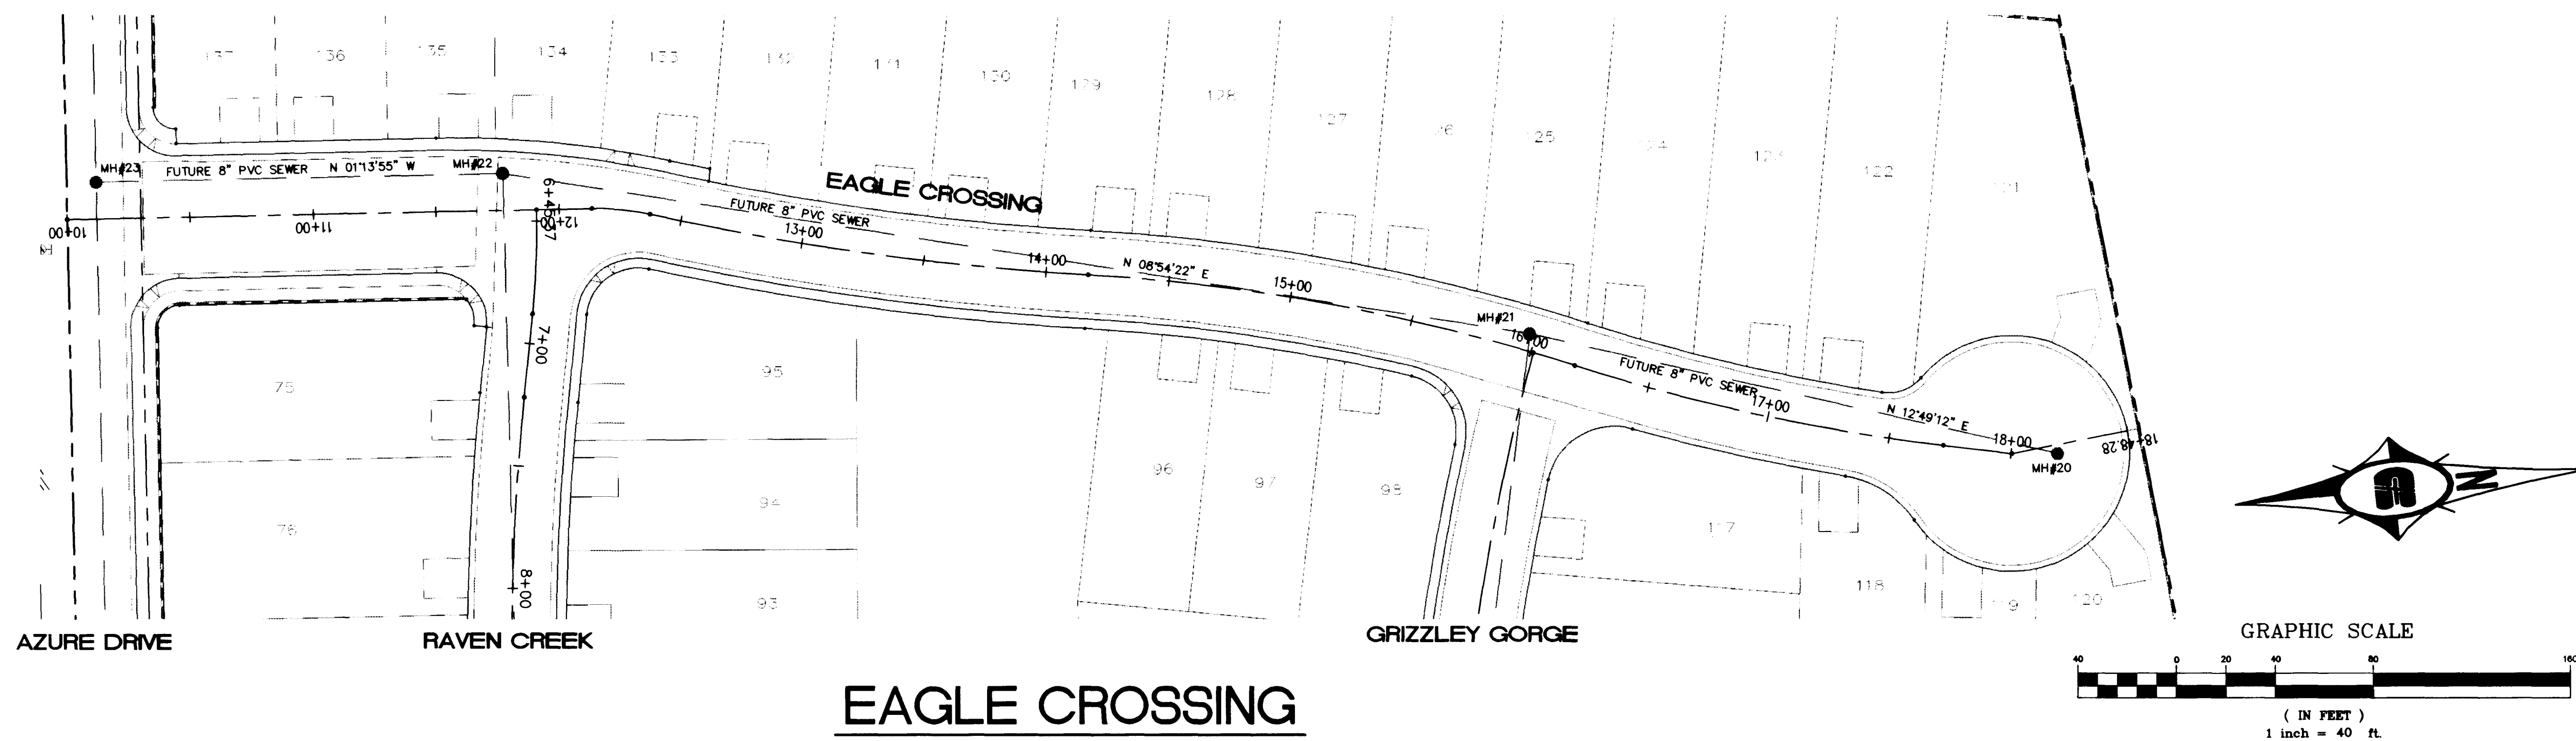



Pulte Homes An American Favorite	Carter :: Burgess 6655 Bermuda road Las Vegas, NV 89119 (702) 938-5400 Fax (702) 938-5454	PLAN AND PROFILE FUTURE OFFSITE SEWER	EAGLE CREEK II PHASE 1	DRAWN BY: RCW	DESIGNED BY: RCW	CHECKED BY: RJT	PROJECT NO.: 98V189	SCALE: 1"=40' 1"=40'	SHEET 16A OF 19 SHEETS DRAWING NO. 3074-4614-1
				PROFESSIONAL ENGINEER-STATE OF NEVADA ROBERT W. JOHNSON CIVIL NO. 13698 8/13/99					



NAME OF HEARING

ALL INFORMATION CONTAINED HEREIN IS UNCLASSIFIED EXCEPT WHERE SHOWN OTHERWISE BY DATE 01-28-2001 AT 10:00 AM BY SP-6 JAC/STP

FRANCIS BLAIR

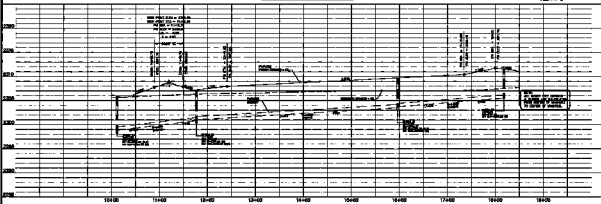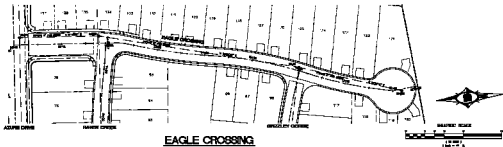[illegible][illegible]