



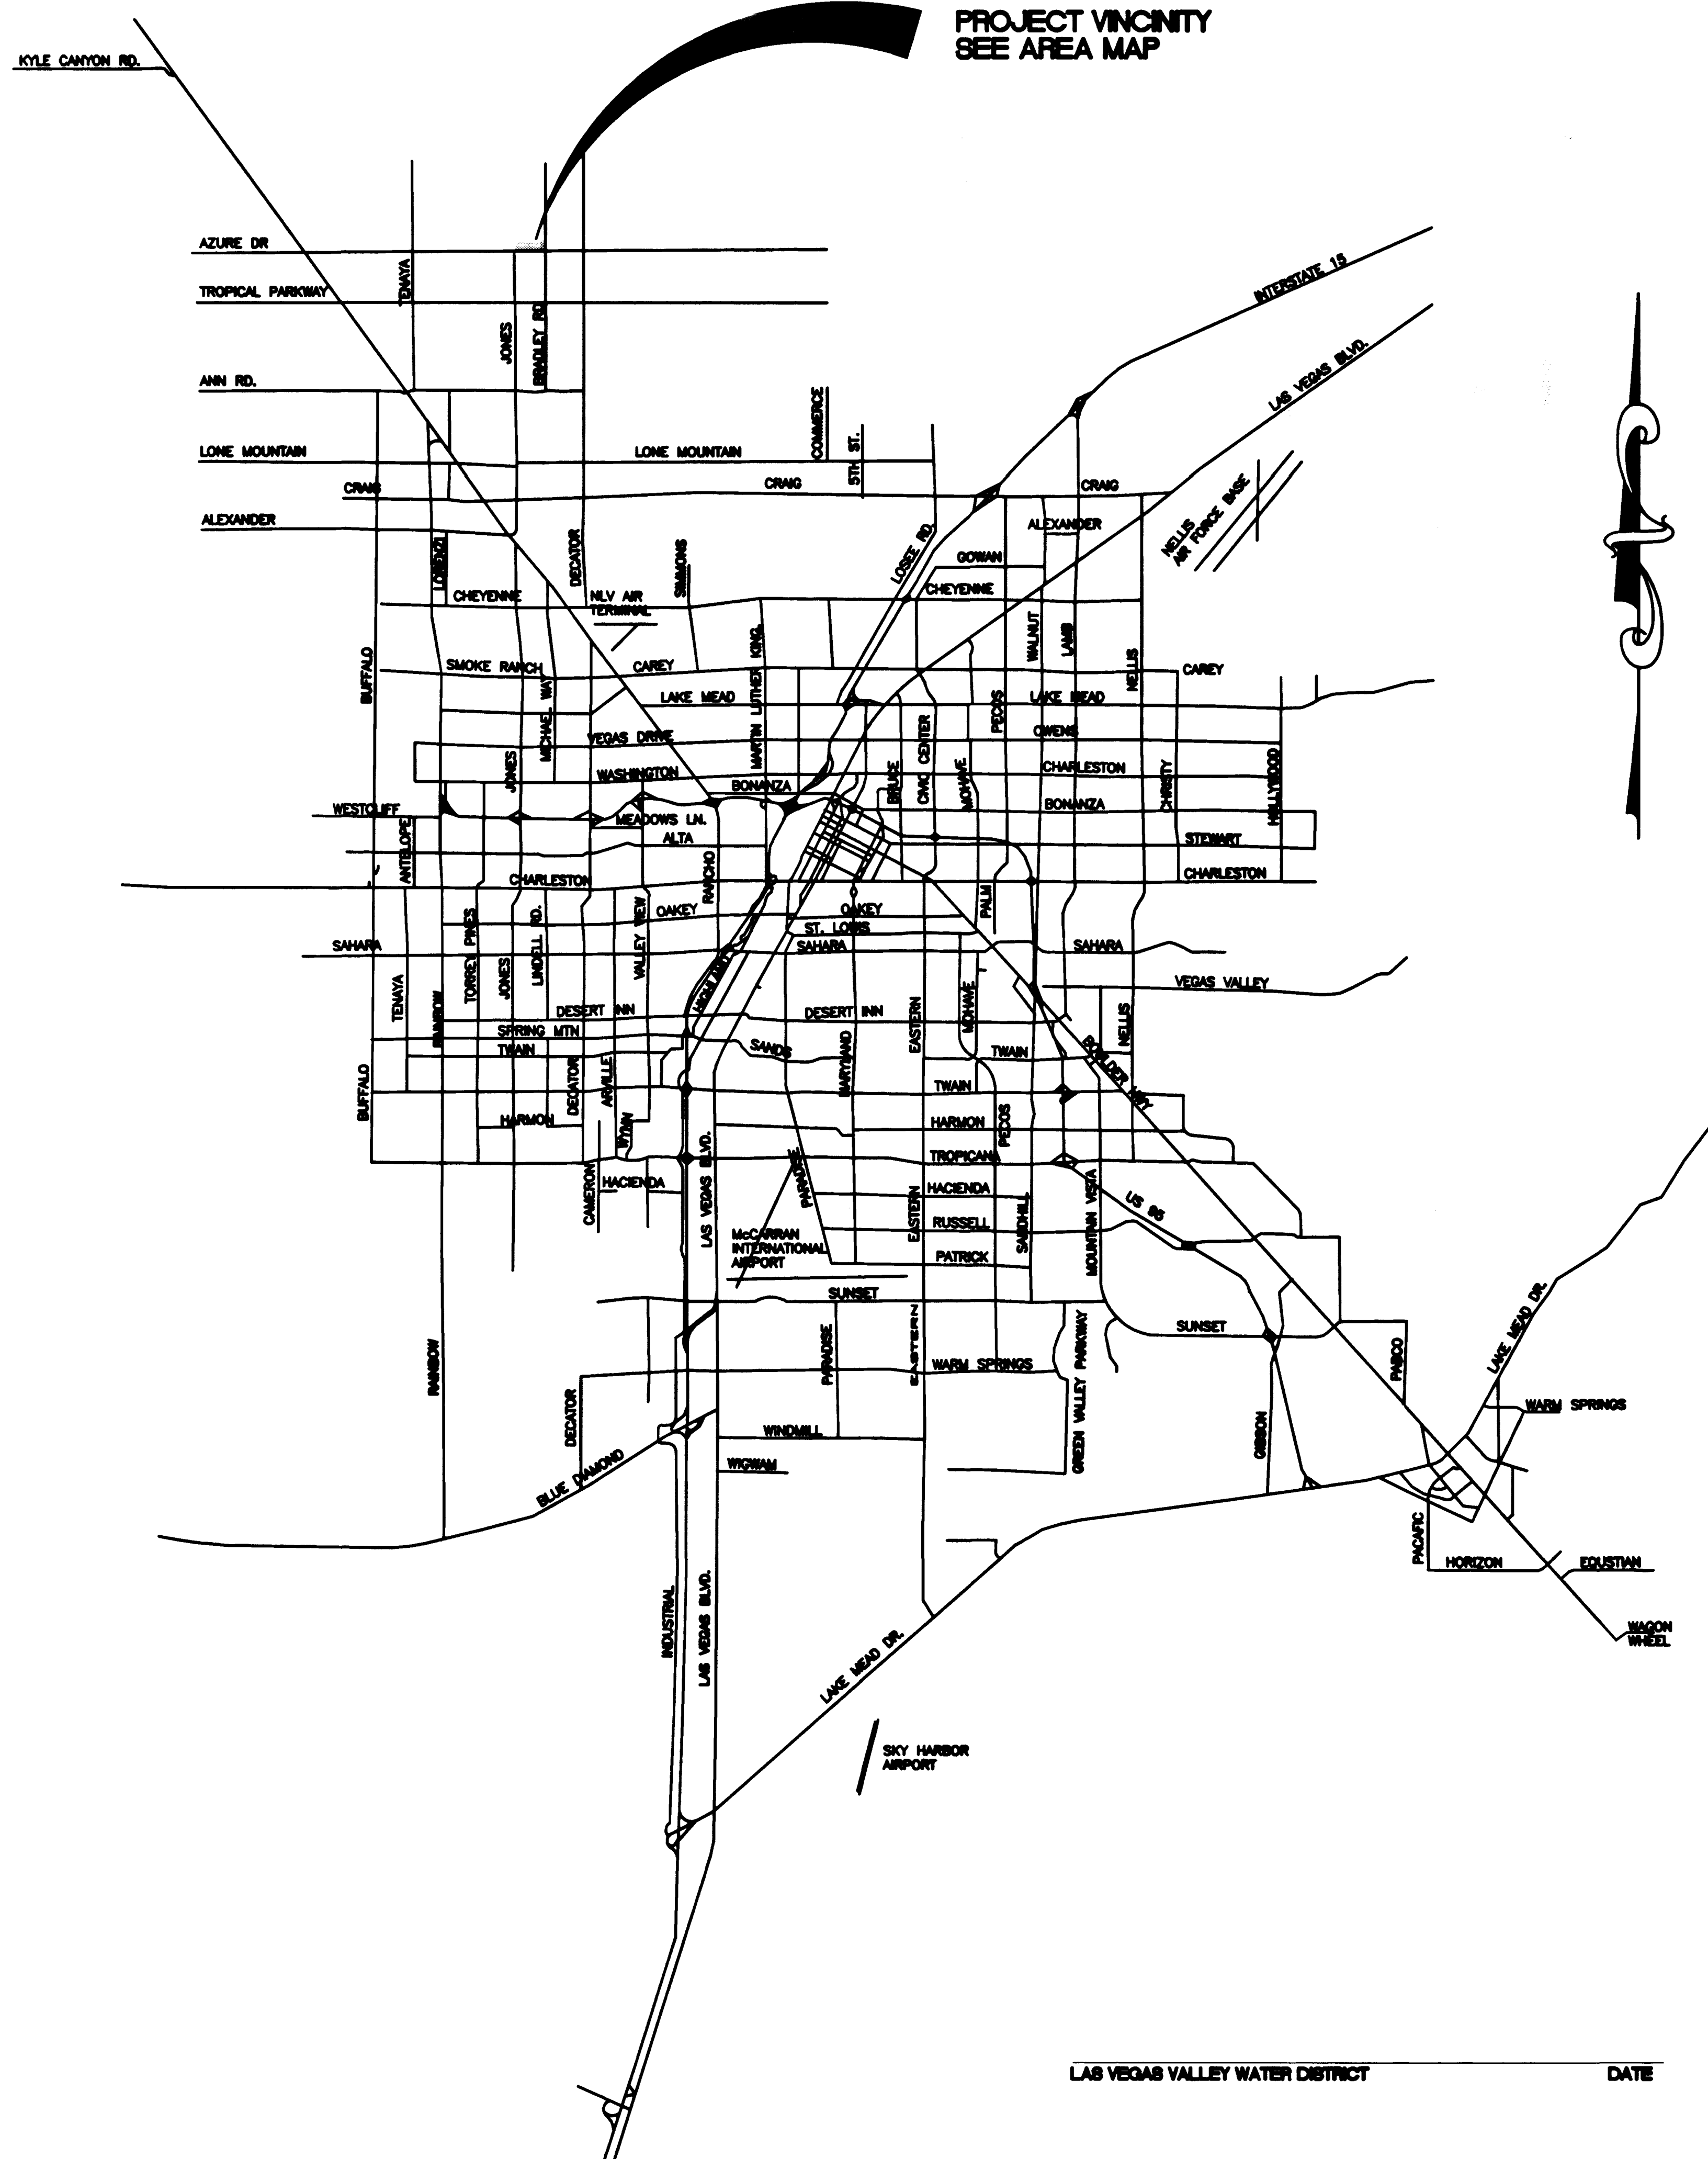

PROJECT VICINITY
SEE AREA MAP

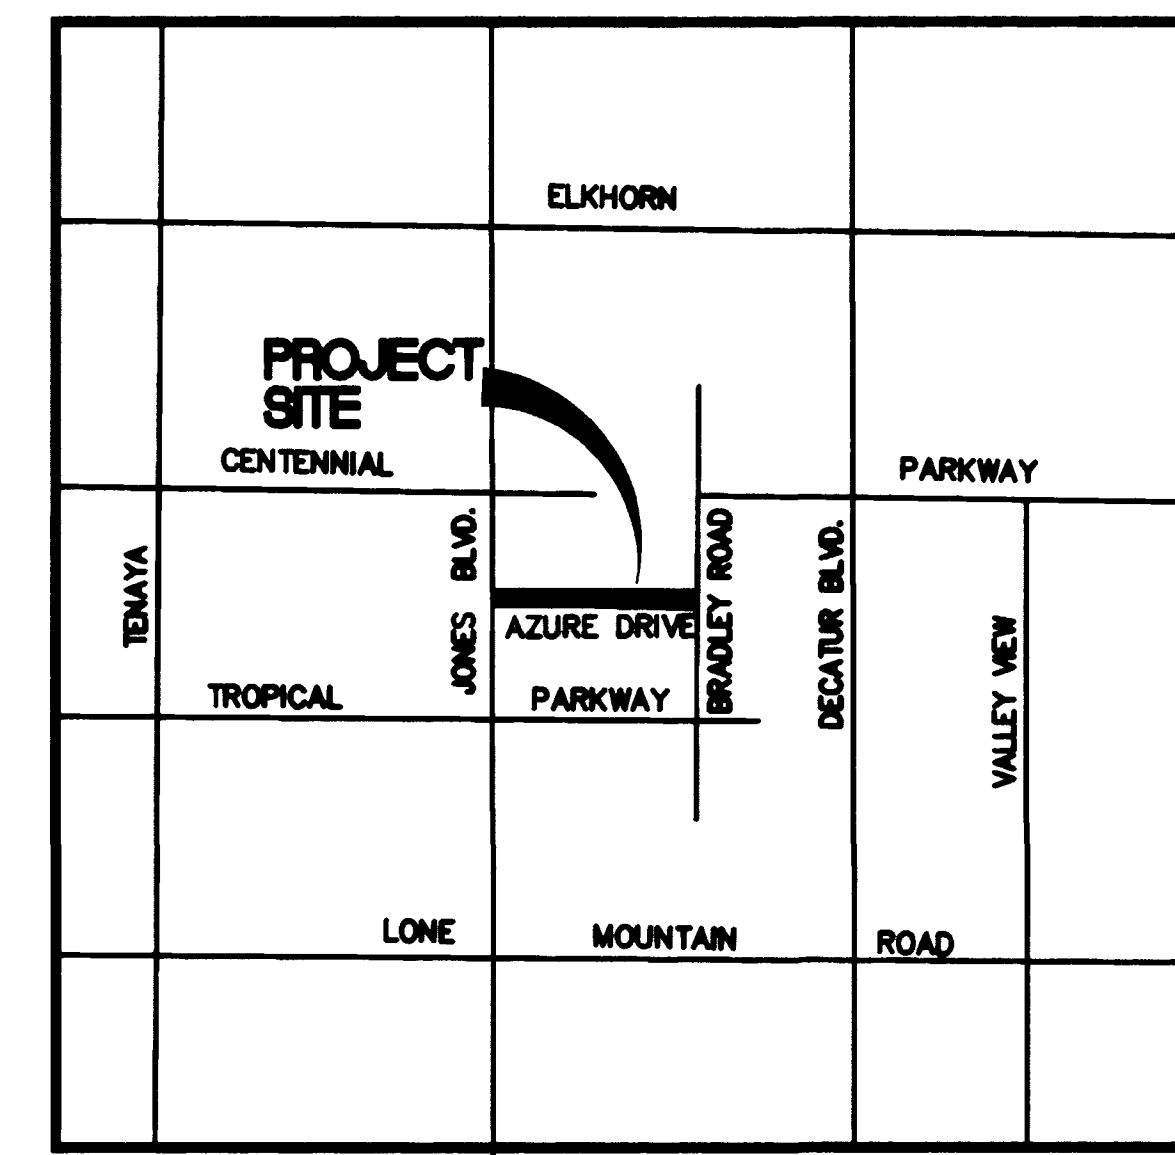

AREA MAP
SCALE: NONE

SHEET No.

1. C1. COVER SHEET
2. C2. VICINITY MAP
3. C3. GENERAL NOTES AND QUANTITIES
4. C4. QUANTITY AND SCHEDULE
5. C5. PLAN AND PROFILE AZURE DR.
6. C6. PLAN AND PROFILE AZURE DR.
7. C7. PLAN AND PROFILE AZURE DR.
8. C8. WATER DETAILS
9. C9. WATER DETAILS
10. C10. WATER DETAILS

UNIT 1
SHEET INDEX

Avoid cutting underground utility lines. It's costly.

Call before you Dig.

1-800-827-8800

UNDERGROUND SERVICE ALERT (USA)

SAFETY ALERT

Call before you Overhead

583-6111

OVERHEAD SERVICE ALERT

Pulte Homes
An American Favorite

CS Carter Burgess
6655 Bermuda road
Las Vegas, NV 89119
Consultants in Planning, Engineering, Architecture, Construction Management, and Related Services (702) 938-5400 Fax (702) 938-5454

VICINITY MAP

EAGLE CREEK II
24" WATER MAIN

DRAWN BY:
RCW

DESIGNED BY:
RCW

CHECKED BY:
RT

 

PROJECT NO:
BPTB010

SCALE:
N/A

DATE:
6/25/99

PROFESSIONAL ENGINEER-STATE OF NEVADA
ROBERT W. JOHNSON
No. 13698

SHEET
C2
2 OF 10 SHEETS
DRAWING NO.
5674-4614

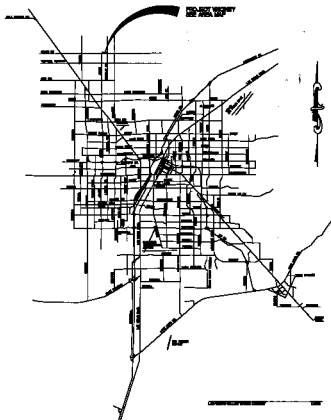

AREA MAP
SEE SHEET

SHEET No.		UNIT 1
		SEWERAGE
1.	01 COVER INSET	
2.	02 VERTICAL MAP	
3.	03 GENERAL NOTES AND QUANTITIES	
4.	04 QUANTITY AND SCHEDULE	
5.	05 PLAN AND PROFILE ADJUST OR	
6.	06 PLAN AND PROFILE ADJUST OR	
7.	07 PLAN AND PROFILE ADJUST OR	
8.	08 WATER DETAILS	
9.	09 WATER DETAILS	
10.	010 WATER DETAILS	

