



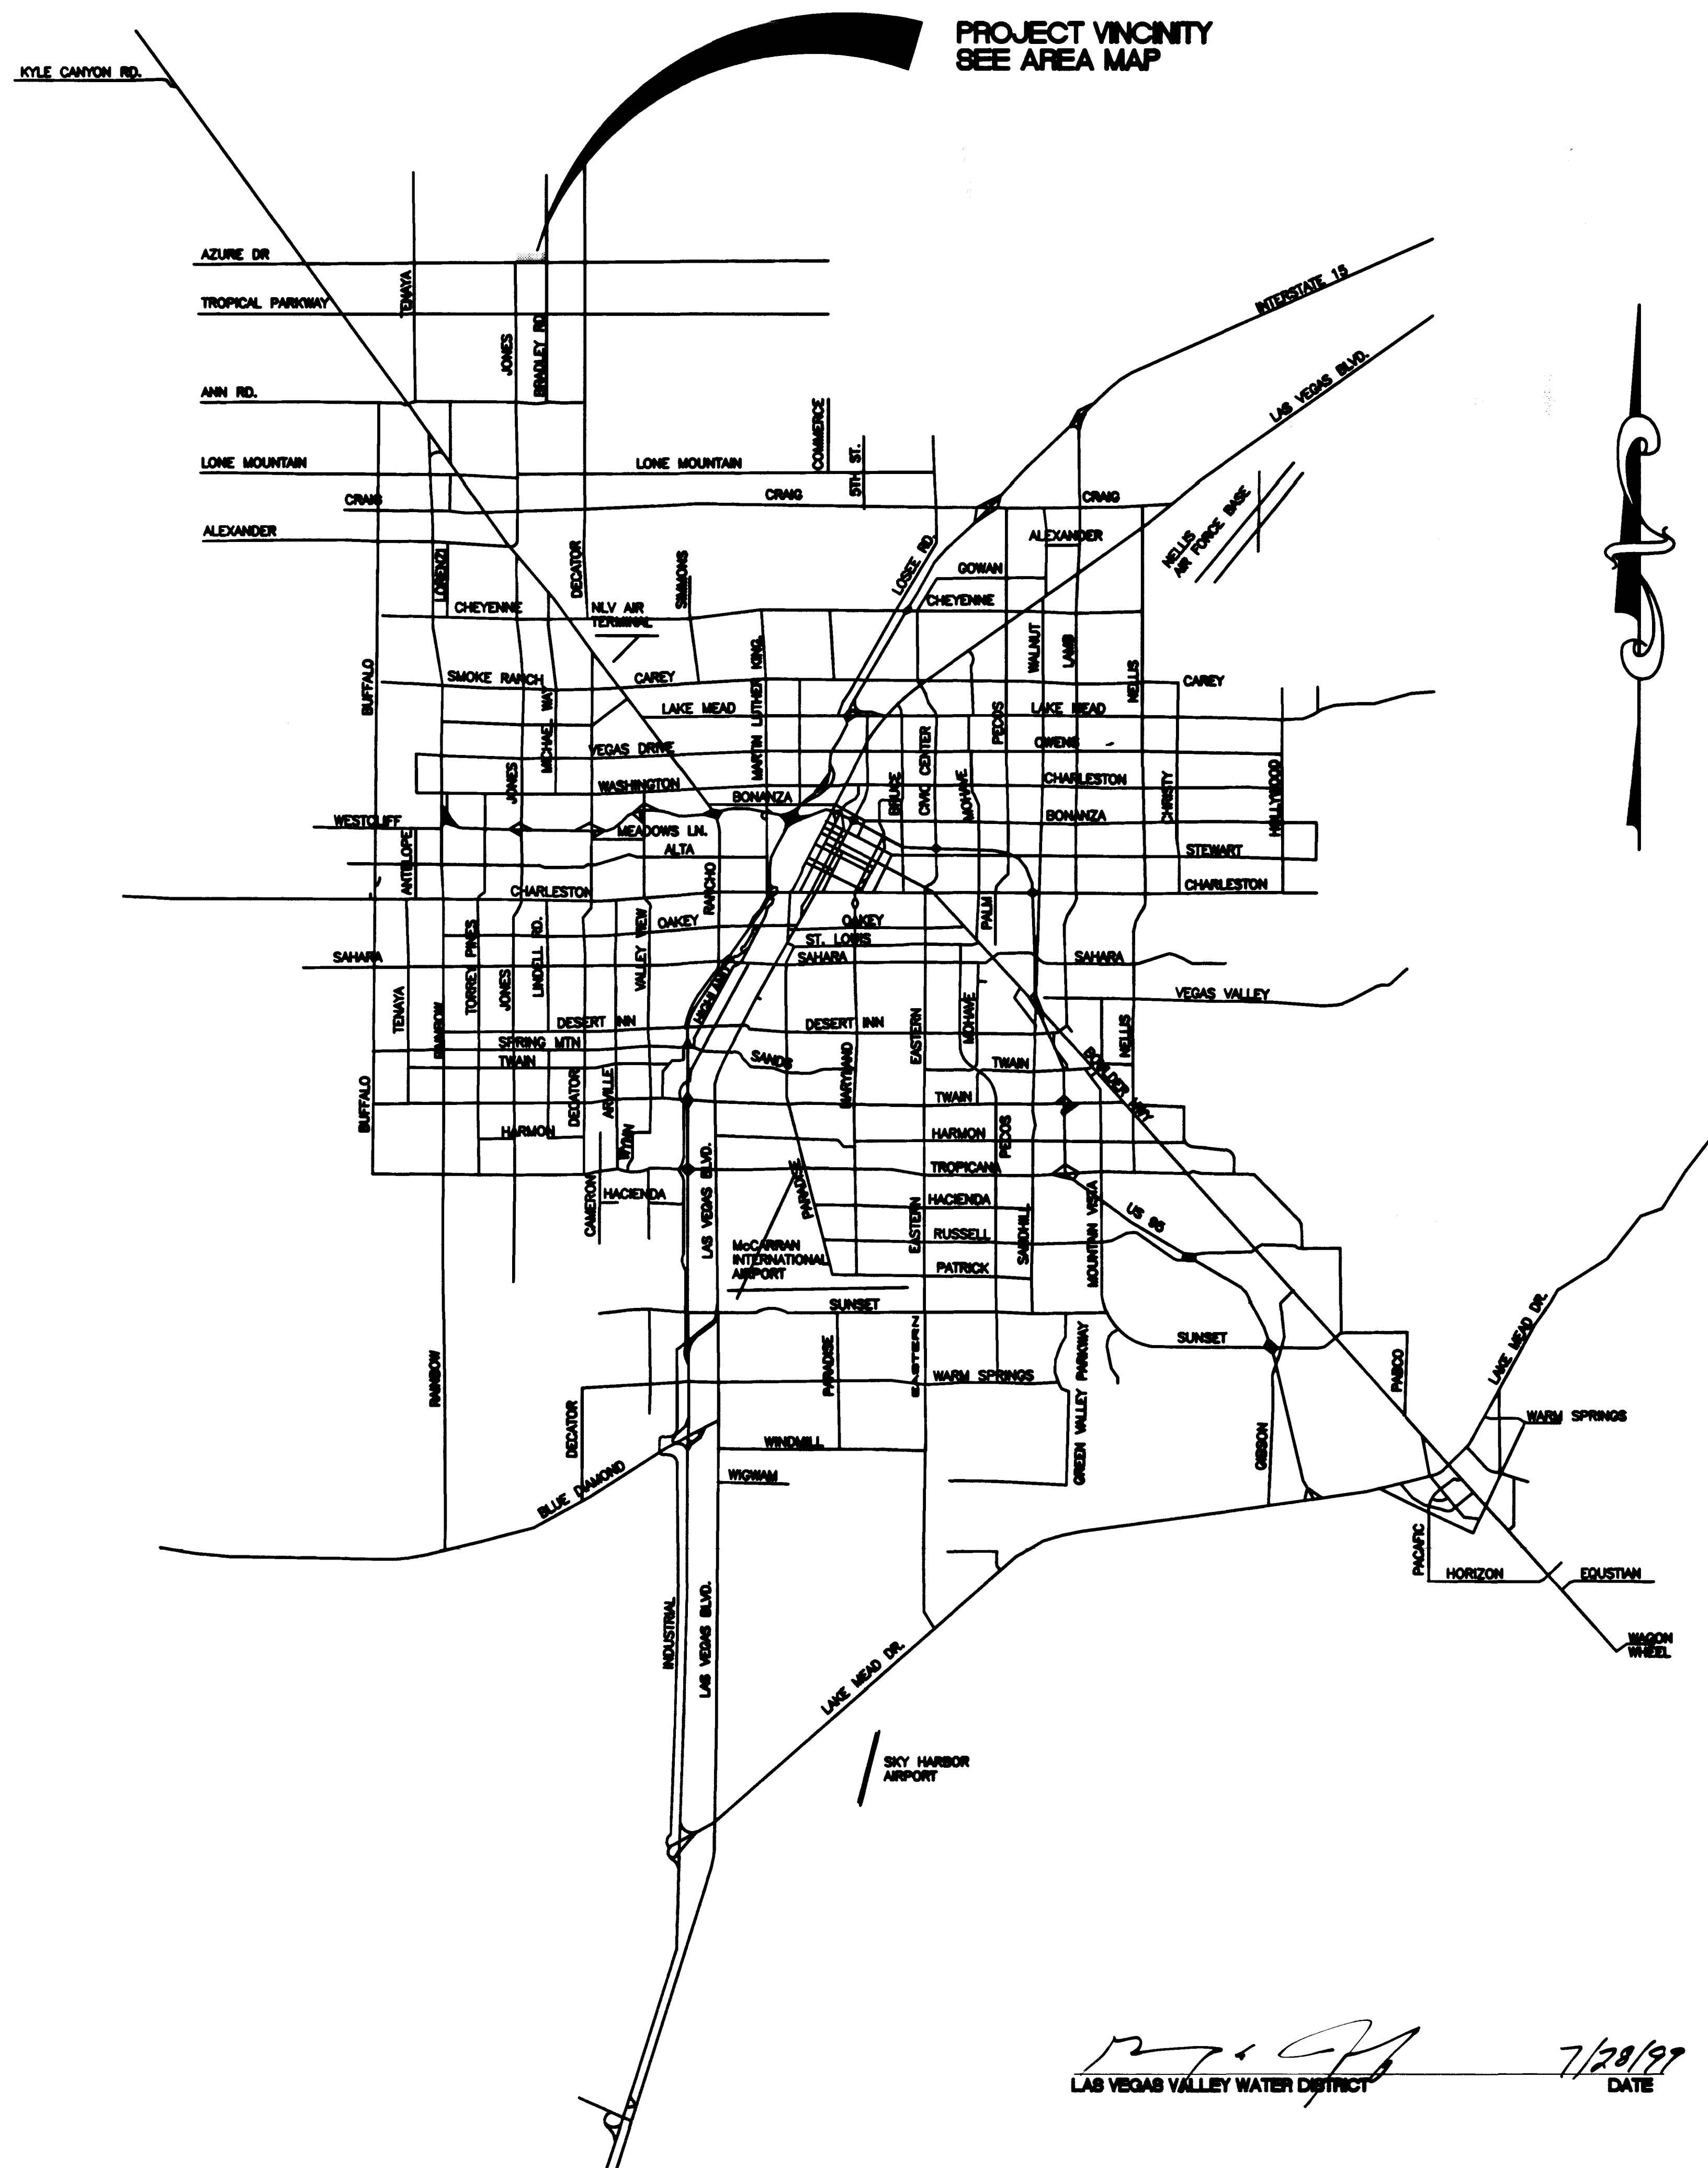

PROJECT VICINITY
SEE AREA MAP

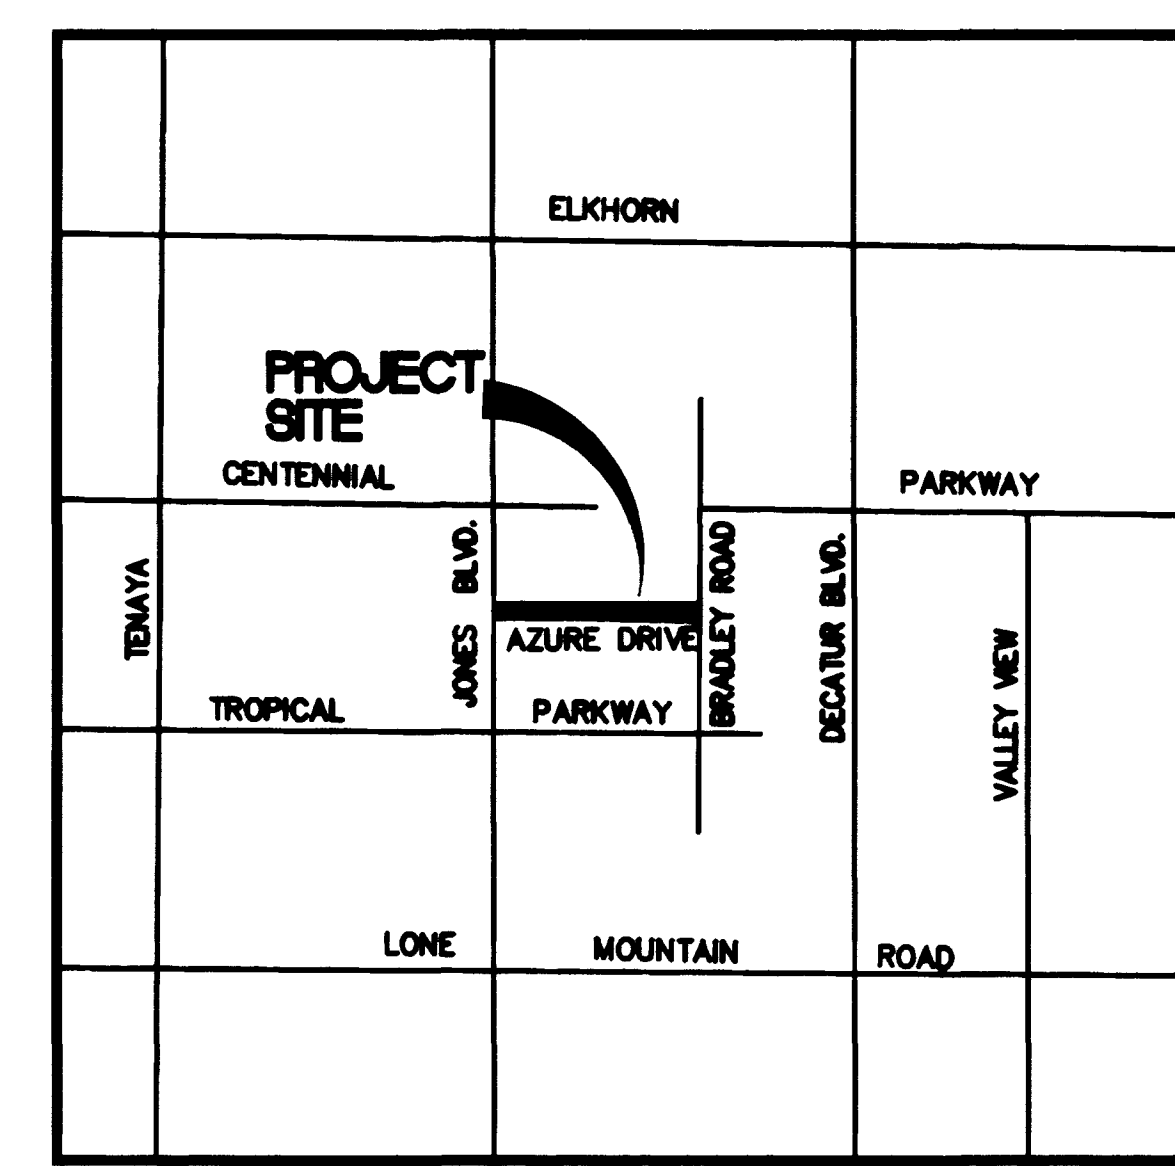

AREA MAP
SCALE: NONE

SHEET No.		UNIT 1 SHEET INDEX	
1.	C1. COVER SHEET		
2.	C2. VICINITY MAP		
3.	C3. GENERAL NOTES AND QUANTITIES		
4.	C4. QUANTITY AND SCHEDULE		
5.	C5. PLAN AND PROFILE AZURE DR.		
6.	C6. PLAN AND PROFILE AZURE DR.		
7.	C7. PLAN AND PROFILE AZURE DR.		
8.	C8. WATER DETAILS		
9.	C9. WATER DETAILS		
10.	C10. WATER DETAILS		

Avoid cutting underground utility lines. It's costly.

Call before you Dig.

1-800-827-8800

UNDERGROUND SERVICE ALERT (USA)

SAFETY ALERT

Call before you Overhead

593-6111

OVERHEAD SERVICE ALERT

[Signature] 7/29/99
LAS VEGAS VALLEY WATER DISTRICT DATE

Pulte Homes An American Favorite		Carter Burgess 6655 Bermuda Road Las Vegas, NV 89119 Consultants in Planning, Engineering, Architecture, Construction Management, and Related Services (702) 888-5400 Fax (702) 888-5454	
VICINITY MAP EAGLE CREEK I 24" WATER MAN		DRAWN BY: RCM DESIGNED BY: RCM CHECKED BY: JKT PROJECT NO: 5074-4614 SCALE: N/A DATE: 6/25/99	
SHEET C2 2 OF 10 SHEETS DRAWING NO. 5074-4614		PROFESSIONAL ENGINEER-STATE OF NEVADA ROBERT W. JOHNSON No. 13698 6/25/99	

