



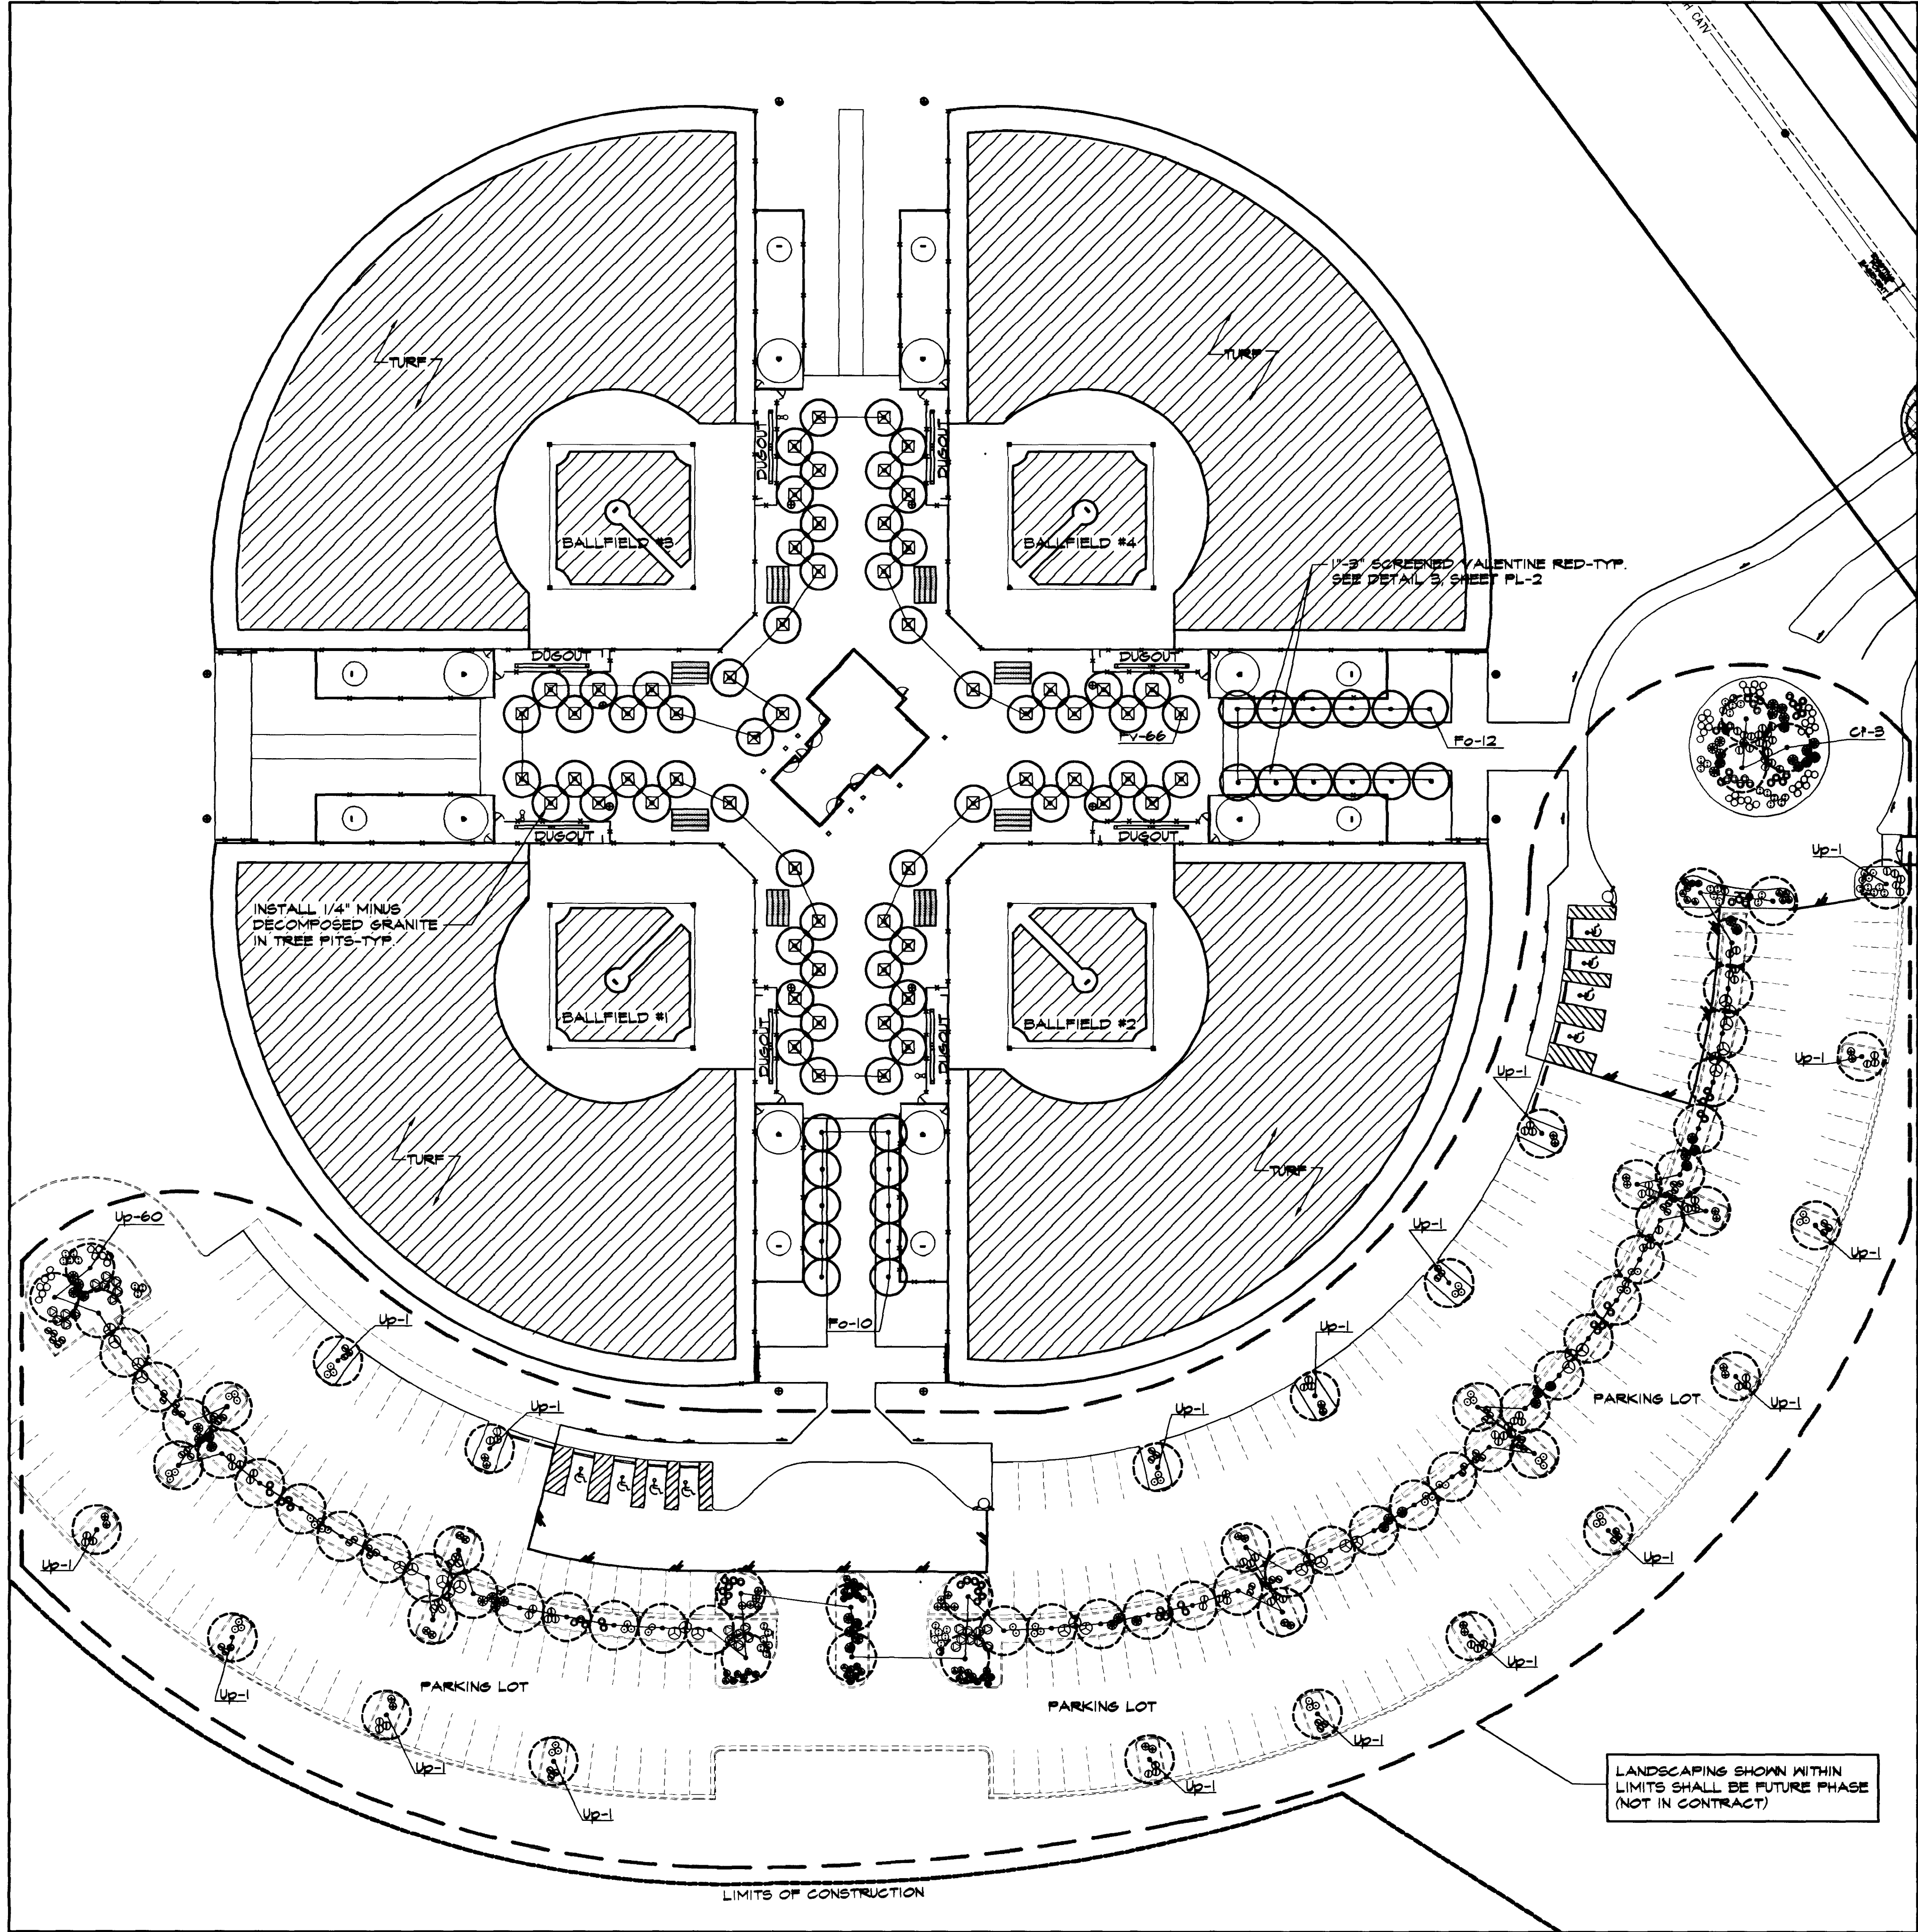

BALLFIELD PLANTING

13171

SCALE: 1"=40'-0"

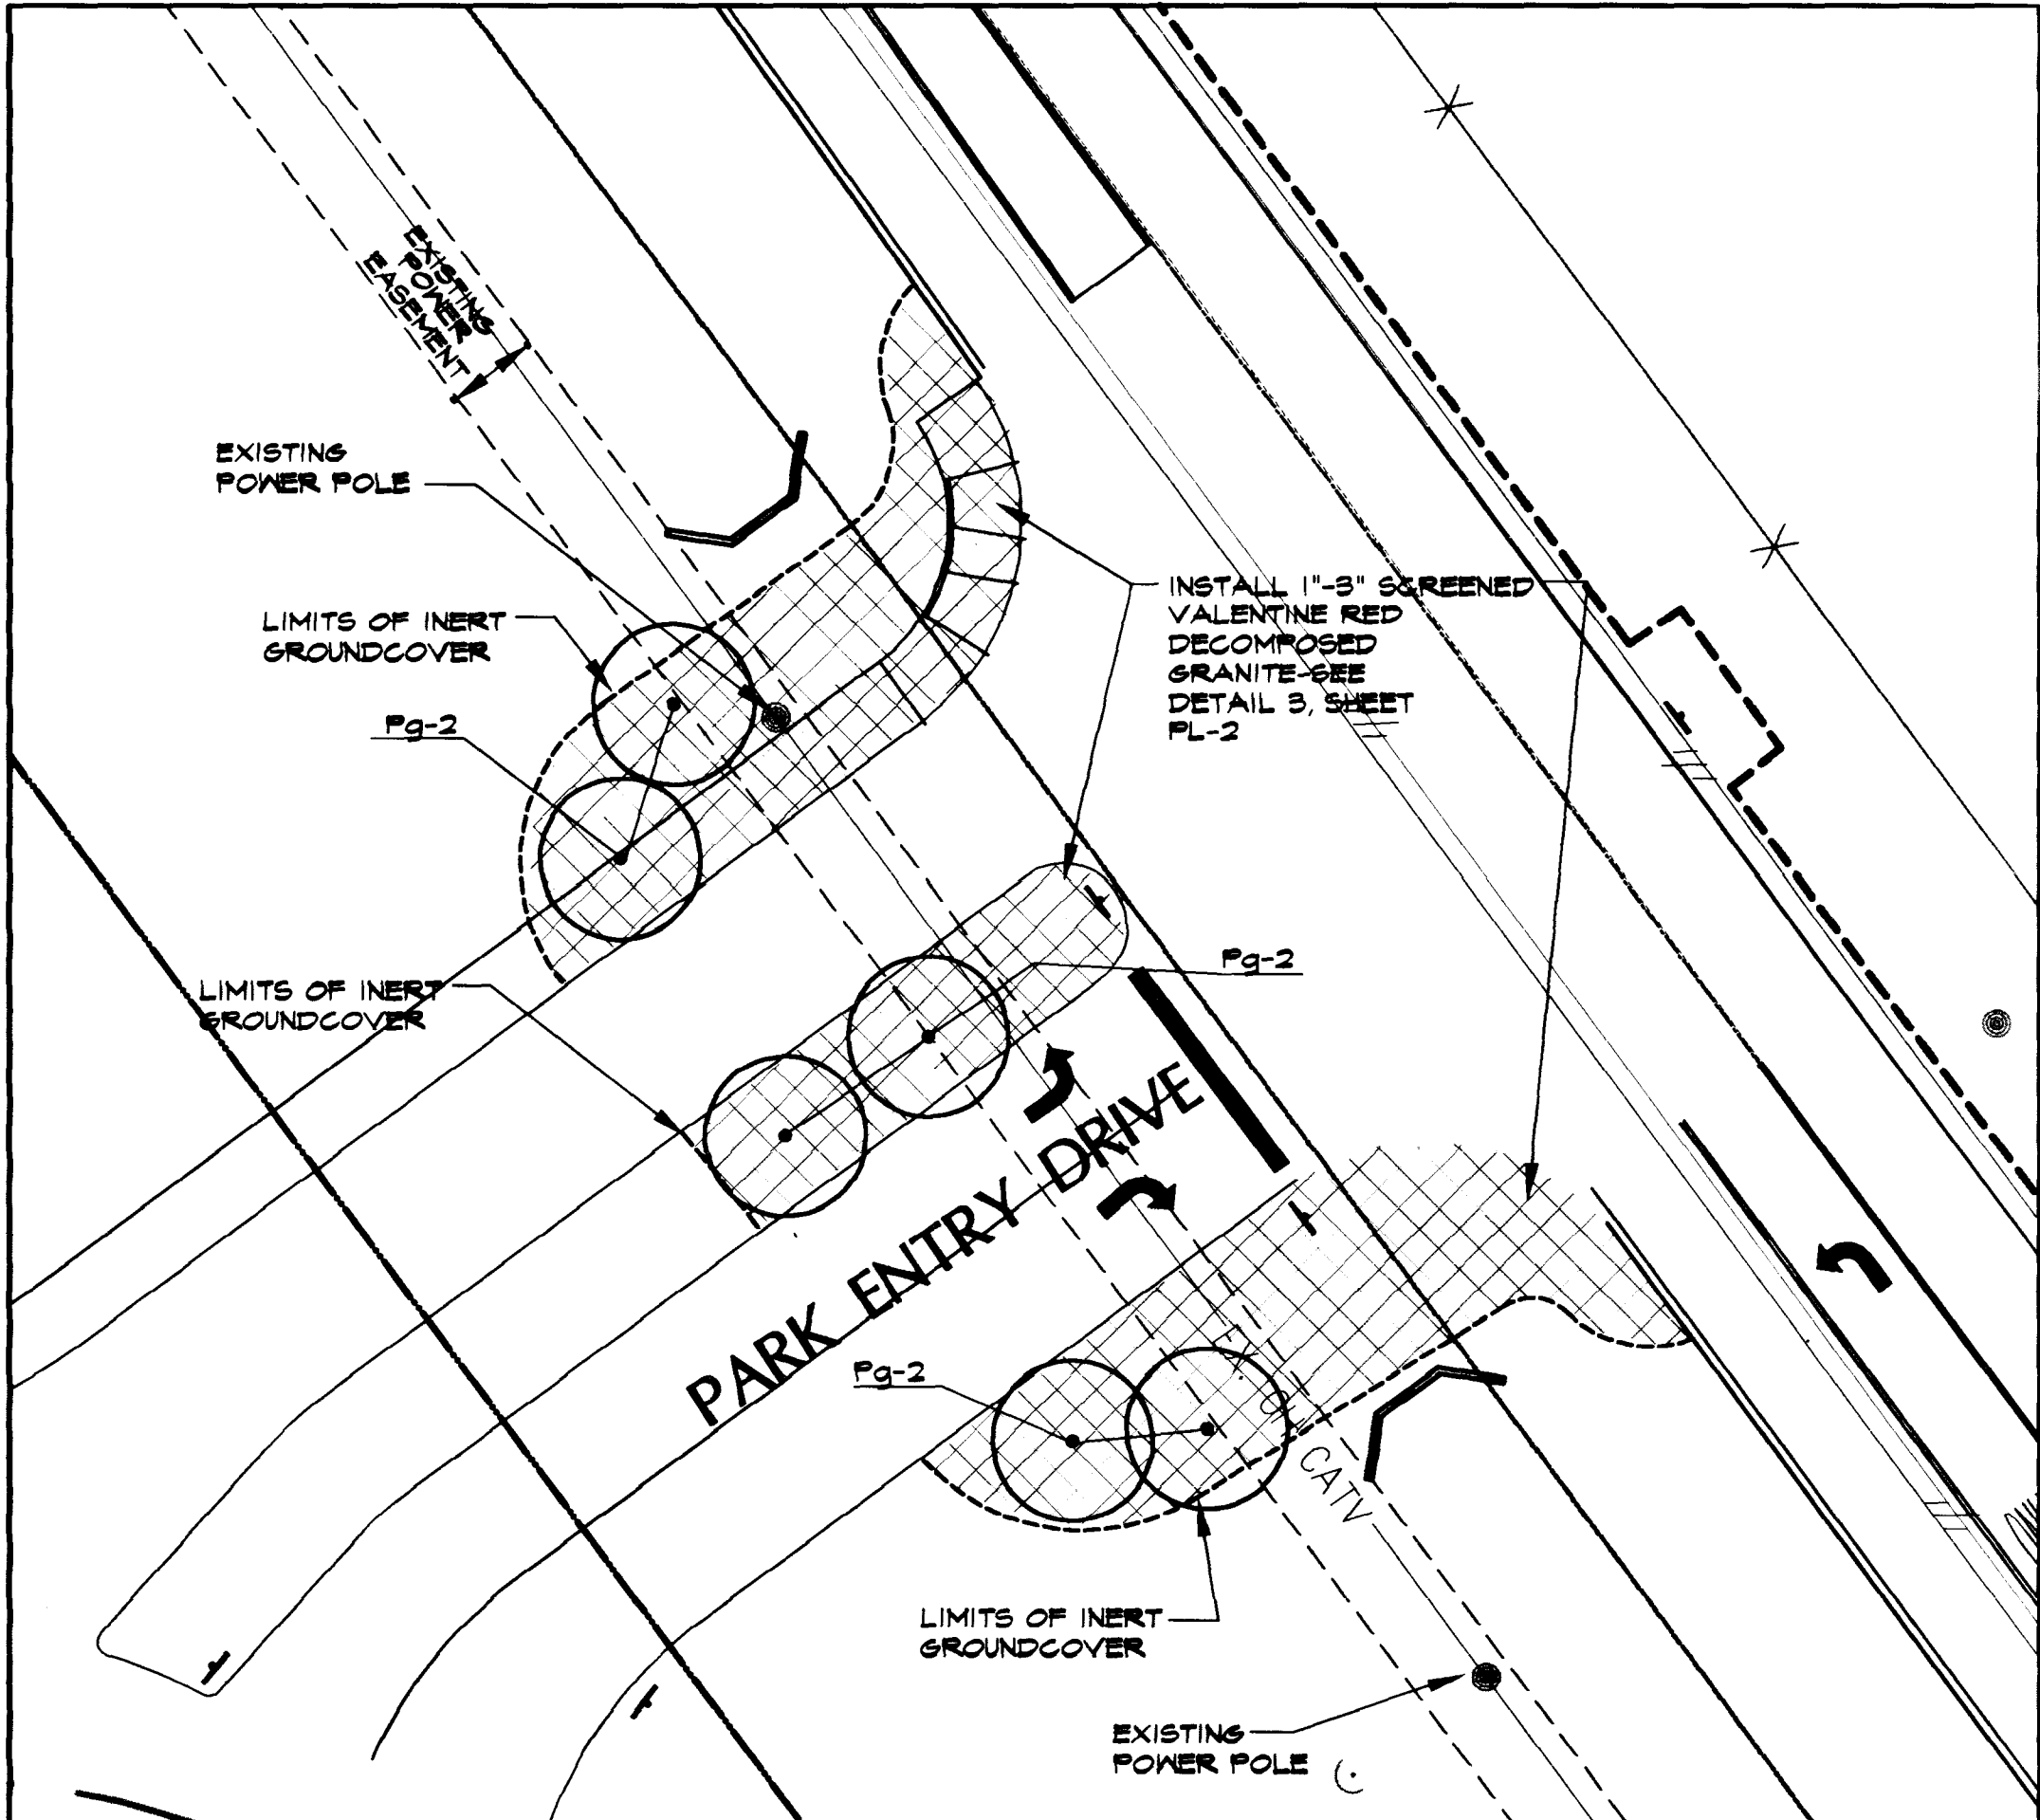

ENTRY PLANTING


SCALE: 1"=20'-0"

PLANT SCHEDULE

TREES

KEY	QTY	BOTANICAL NAME	COMMON NAME	SIZE	MIN. SPEC.	REMARK
Pg	6	Prosopis glandulosa Torreyana	Honey Mesquite	24" Box	8' x 4' x 15'	Multi-trunk
Po	82	Fraxinus viridis 'Raynood'	Raynood Ash	24" Box	14' x 8' x 150"	Standard
Fv	64	Fraxinus velutina Rio Grande	Pan-Tex Ash	24" Box	10' x 8' x 150"	Standard

NOTE: CONTRACTOR SHALL VERIFY ALL QUANTITIES OFF PLANS

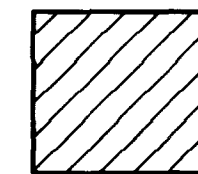

SEE SPEC'S SECTION 02400 FOR ROCK TYPE AND SOURCE

PLANTING NOTES

- Landscape contractor shall coordinate with the General Contractor for the location of all underground utilities prior to construction. Landscape Contractor shall verify depths of all utilities in vicinity of new construction. Should any conflicts arise, notify the Landscape Architect immediately. All project General Notes shall apply regarding F.O.S. and existing utilities. See Civil Utility Plans.
- See landscape specifications for additional information which are a part of these contract documents.
- Landscape Contractor shall coordinate with the Electrical Contractor and shall review Electrical Plans for locations of all electrical equipment and lighting standards. Landscape Contractor shall adjust plant material and irrigation locations as necessary to avoid any conflicts. All work shall be coordinated with the General Contractor.
- Construction project representative shall approve all plant material prior to installation. Notification shall be a minimum of 48 hours in advance.
- Plant material shall have identification tags on minimum of 10% of total quantity of each species.

PLANT SCHEDULE-FUTURE PHASE (NOT IN CONTRACT)

TREES

KEY	QTY	BOTANICAL NAME	COMMON NAME	SIZE	MIN. SPEC.	REMARK
Up	10	Ulmus parvifolia Drake	Evergreen Elm	24" Box	8' H X 8' W X 1.25'	Standard
Cf	5	Cercidium floridum	Blue Palo Verde	36" Box	10' H X 8' W X 2'	Multi-trunk

SH-RUBS

45	Dasylirion wheeleri	Desert Spoon	5 gal.	
100	Leucophyllum zygophyllum 'Sierran' TM	Sierran Ranger	5 gal.	
26	Leucophyllum revolutum 'Sierra Magic' TM	Sierra Magic Ranger	5 gal.	
65	Muhlenbergia capillaris 'Regal Mist' TM	Regal Mist Deer Grass	5 gal.	
61	Hesperaloe parviflora	Red Yucca	5 gal.	
48	Yucca recurvifolia	weeping Yucca	5 gal.	
49	Convolvulus cheiranthus	Bush Morning Glory	5 gal.	
47	Lantana 'Neri Gold'	Neri Gold Lantana	5 gal.	
65	Calliandra eriophylla	Pink Dustier	5 gal.	
46	Chrysothamnus mexicanus	Damianita	5 gal.	

GROUND COVER

24	Acacia dealbens 'Desert Carpet' TM	Desert Carpet Acacia	5 gal.	5' O.C.
----	------------------------------------	----------------------	--------	---------

NOTE: CONTRACTOR SHALL VERIFY ALL QUANTITIES OFF PLANS

TM -TRADEMARK (REQUIRES TAGS ON PLANTS FOR APPROVAL BY LANDSCAPE ARCHITECT)
5 GALLON MINIMUM SPEC. - 12" x 12"
1 GALLON MINIMUM SPEC. - 6" x 6"

NOTE: 1'-3" SCREENED DECOMPOSED GRANITE IN ALL LANDSCAPE PLANTERS.
SEE DETAIL 5, SHEET PL-2



NOTE TO CONTRACTOR:
CELLA BARR ASSOCIATES, INC. (CBA) HAS
DESIGNED TO PROVIDE ACCURATE UTILITY
INFORMATION BASED ON THE MOST CURRENT
DATA AVAILABLE. THE CONTRACTOR SHALL
VERIFY THE LOCATION AND DEPTH OF ALL
UTILITIES SHOWN ON THIS PLAN AND SHALL
BE RESPONSIBLE FOR ANY DAMAGE TO
UTILITIES CAUSED BY THE CONTRACTOR'S
WORK. THE CONTRACTOR SHALL BE
RESPONSIBLE FOR OBTAINING ALL
NECESSARY PERMITS AND FOR THE
PROTECTION OF ALL UTILITIES.
UNDERGROUND SERVICE ALERT (USA)
1-800-227-2600

Use of the information contained in this
document for other than the specific
purpose for which it was created and
for other than the client for whom it
was prepared is prohibited. CBA and its
associates and Cella Barr Associates
shall have no liability to any user of the
information without their written consent.

Call before you Dig
1-800-227-2600
UNDERGROUND SERVICE ALERT (USA)


Call before you Overhead
1-702-593-6111
NEVADA POWER OVERHEAD &
UTILITY SERVICES, INC.



REVISIONS
CONSULTANT

CELLA BARR ASSOCIATES
Landscape Architecture Engineering Planning Surveying
1771 E. Flamingo Road #102-8 Las Vegas, Nevada 89119 (702) 881-7779
Offices in Arizona, California and Nevada

ELKHORN AND DURANGO
BALLFIELD COMPLEX
PLANTING PLAN

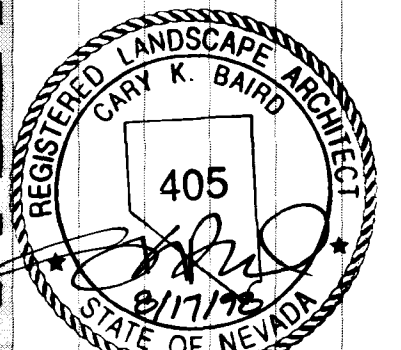

DEPARTMENT OF PUBLIC WORKS ARCHITECTURAL SERVICES

400 EAST STEWART AVENUE
LAS VEGAS, NEVADA 89101
PHONE: (702) 229-6535
FAX: (702) 382-3232
TDD: (702) 386-9108

ARCHITECT
RICHARD DANIELSON AIA

DRAWN
FILE
DATE
SCALE
PROJECT
SHEET NO.

PL-1
SHEET 16 OF 34

650.48

V:\880154\880154PLANT.dwg Tue Aug 18 08:27:14 1998 Robert S. Lee

