


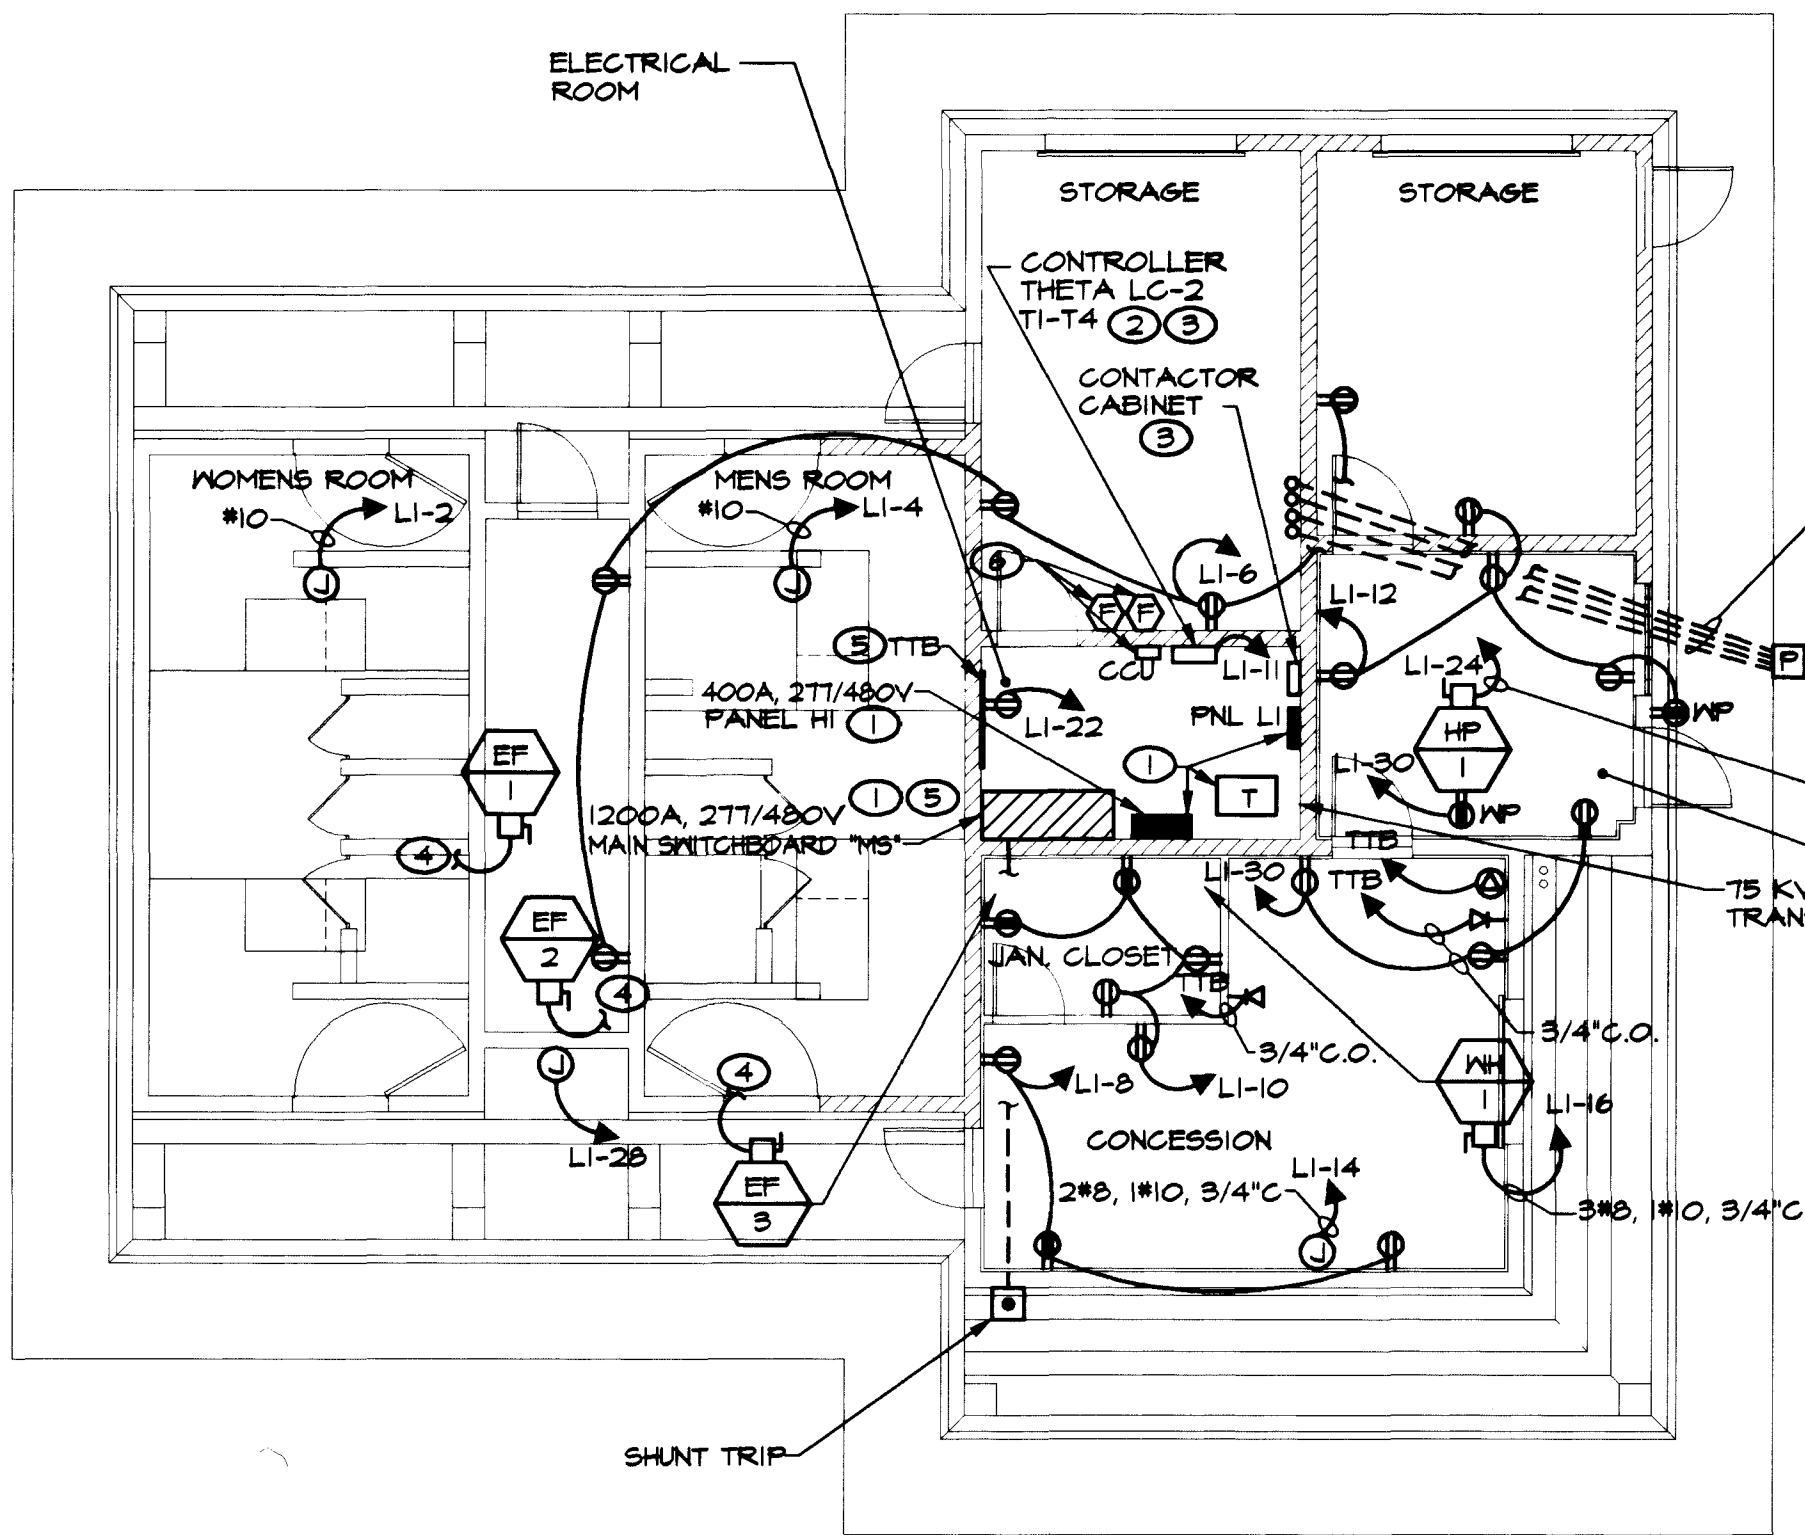


2 ENLARGED RESTROOM BUILDING ELECTRICAL POWER PLAN

SCALE: 1/8"=1'-0"


NOTES:


- SEE ONELINE DIAGRAM FOR CONDUIT AND WIRE SIZES FOR PANELS AND TRANSFORMERS.
- BALLFIELD LIGHTS SHALL BE CONTROLLED BY THETA LAB LC-2. PROVIDE (1) DEDICATED TELEPHONE CONDUIT TO CONTROLLER LOCATION FROM TTB.
- CONTACTORS AND THETA LAB CONTROLLER UNIT SHALL BE LOCATED IN ELECTRICAL ROOM.
- CONNECT TO ROOM LIGHTING CIRCUIT FOR SWITCHING. SEE PANEL LI SCHEDULE.
- SEE SITE PLAN FOR FEEDER CONDUIT ROUTING FROM UTILITY SERVICE POINT.
- PROVIDE 3#12, 1/2" EMT TO PANEL LI. SEE PANEL SCHEDULE.

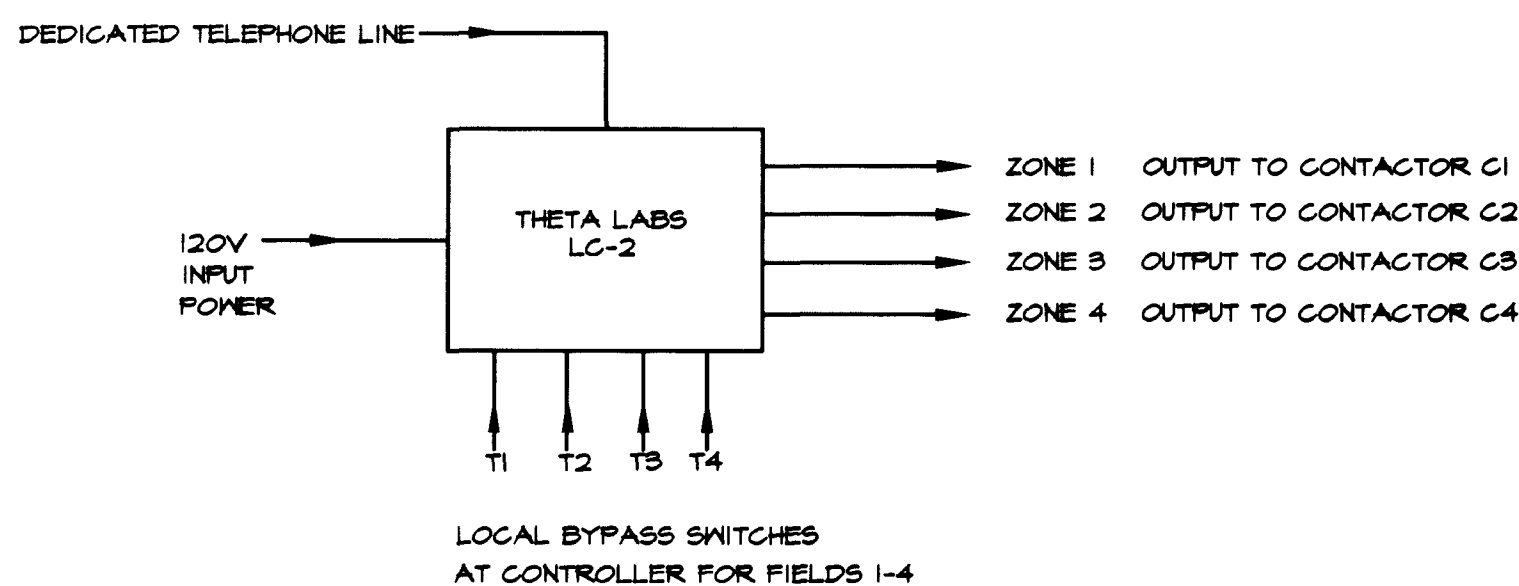

4 BALLFIELD LIGHTING CONTROL DIAGRAM

NOT TO SCALE

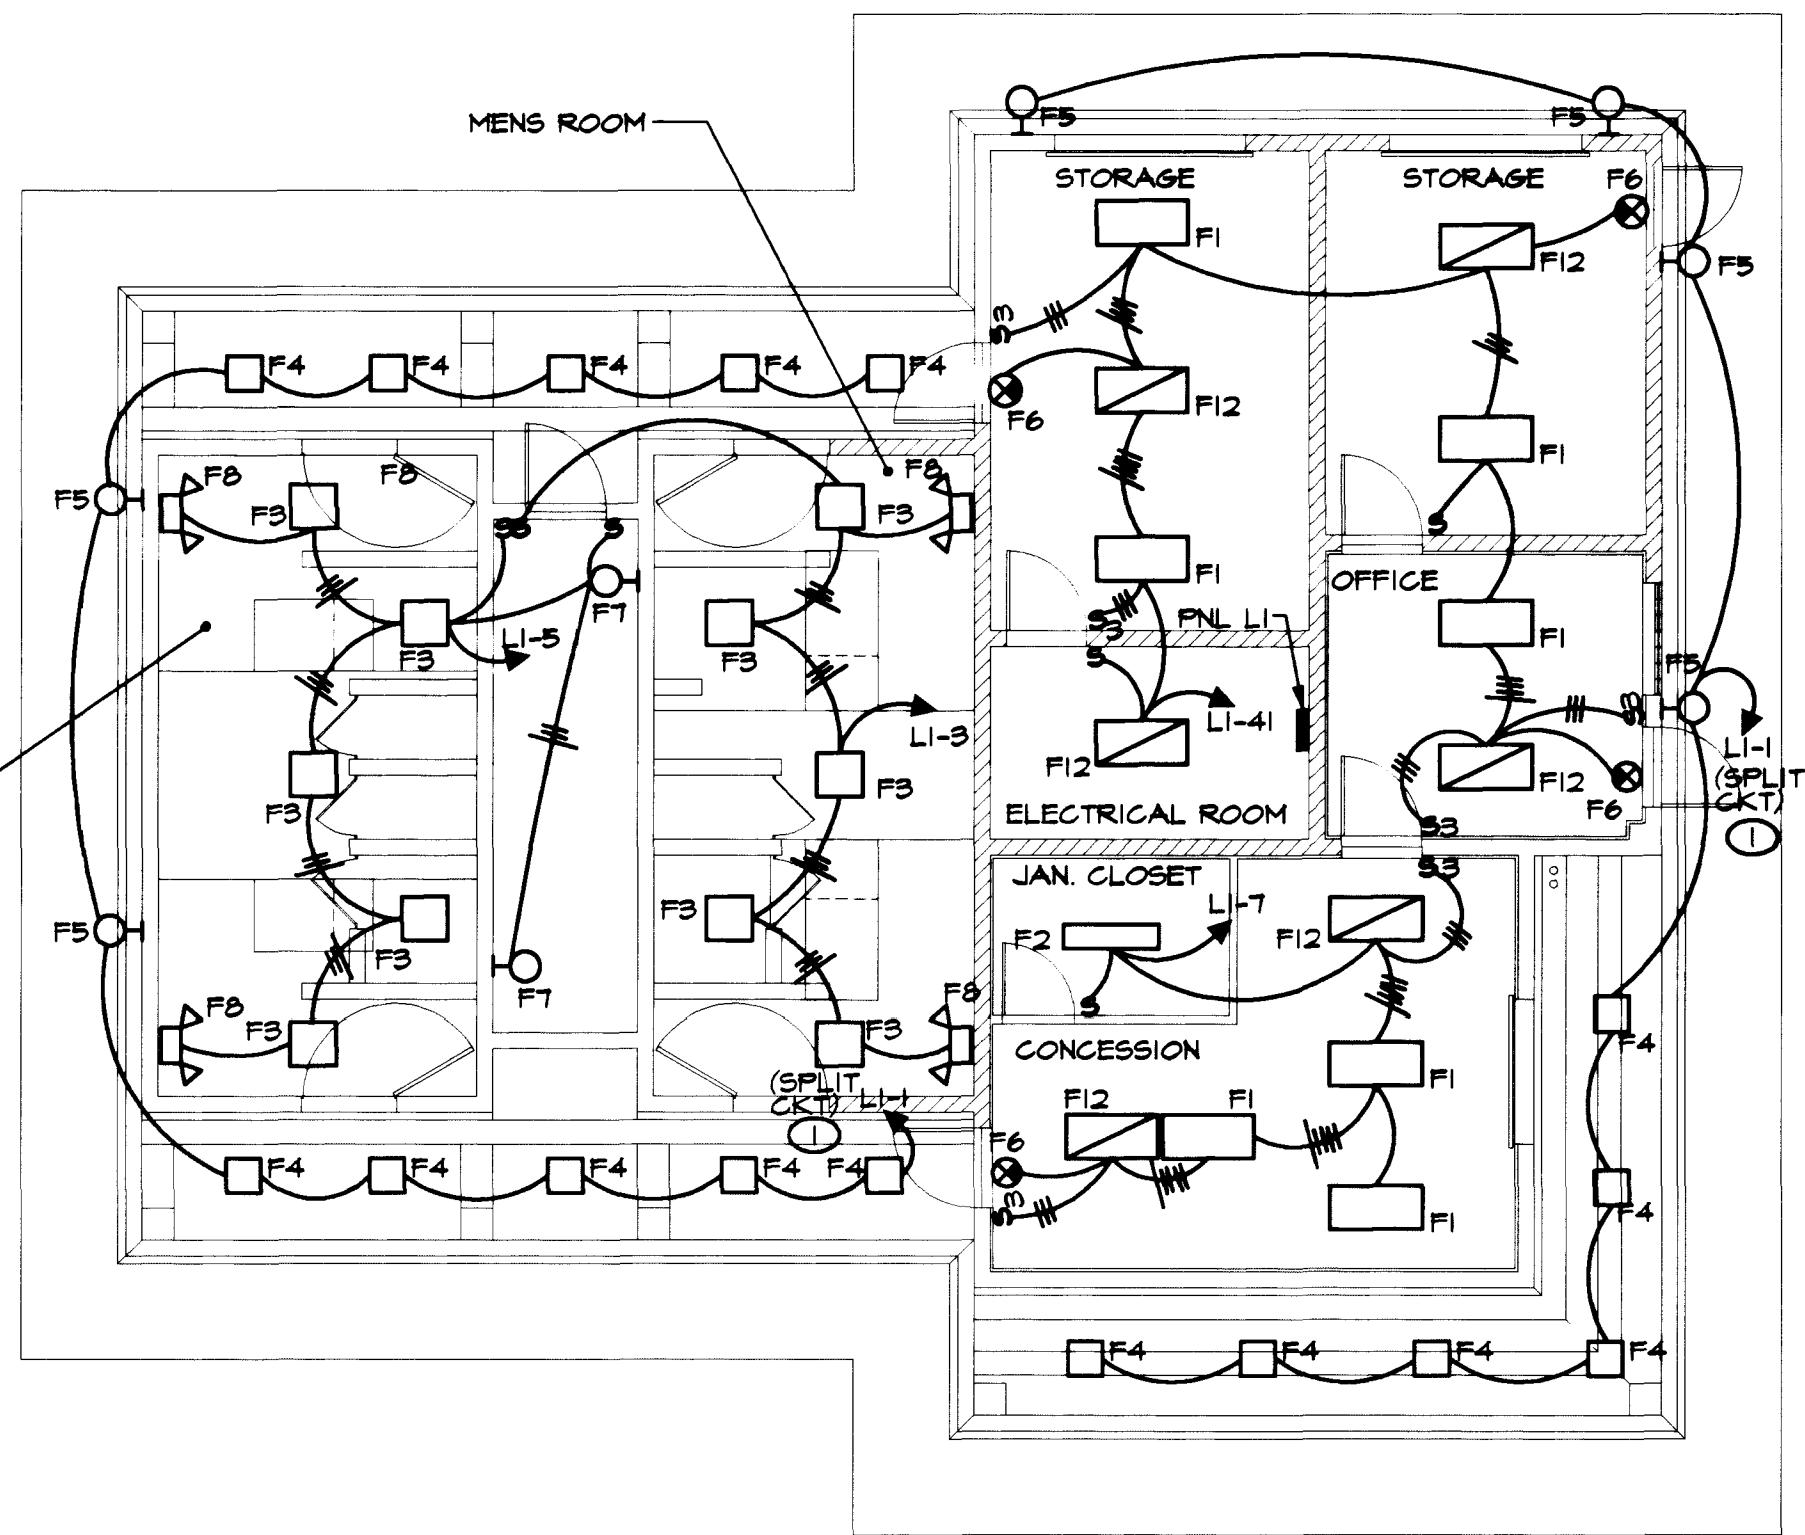


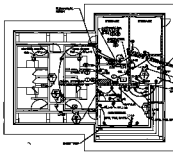


1
DETAILED RESTROOM BUILDING
ELECTRICAL POWER PLAN
SCALE: 1/8" = 1'-0"

NOTES:

 1. SEE GENERAL REQUIREMENTS FOR ELECTRICAL AND TELECOMMUNICATIONS FOR THIS PROJECT.
2. **RECEIVER POWER SUPPLY FOR TELEPHONE**
3. ALL EQUIPMENT SHALL BE INSTALLED IN ACCORDANCE WITH THE NATIONAL ELECTRICAL CODE (NEC) AND THE NATIONAL FIRE PROTECTION ASSOCIATION (NFPA) 70-1996.
4. ALL EQUIPMENT SHALL BE INSTALLED IN ACCORDANCE WITH THE NATIONAL ELECTRICAL CODE (NEC) AND THE NATIONAL FIRE PROTECTION ASSOCIATION (NFPA) 70-1996.
5. PROVIDE 10' FROM WALL TO CENTER OF CONDUIT.




2
BALLFIELD LIGHTING COMPEL DIAGRAM
SCALE: 1/8" = 1'-0"

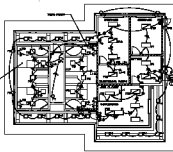

3
DETAILED RESTROOM BUILDING
ELECTRICAL LIGHTING PLAN
SCALE: 1/8" = 1'-0"

NOTES:

1. SEE GENERAL REQUIREMENTS FOR ELECTRICAL AND TELECOMMUNICATIONS FOR THIS PROJECT.

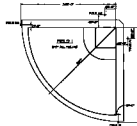

4
BALLFIELD POLE LOCATION DETAIL
SCALE: 1/8" = 1'-0"



NECA
NATIONAL ELECTRICAL CONTRACTORS ASSOCIATION

DESIGN AND DETAILED
BALLFIELD COMPLEX
ELECTRICAL DETAILS



IBEW
INTERNATIONAL BROTHERHOOD OF ELECTRICAL WORKERS

PROJECT NO.
DATE
BY
CHECKED
APPROVED

1/2" = 1'-0"
1/8" = 1'-0"