

NOTES:



- 1. ALL CONSTRUCTION SHALL CONFORM TO THE LATEST REVISED UNIFORM STANDARD DRAWINGS & SPECIFICATIONS FOR PUBLIC WORKS COMPILED FOR CLARK COUNTY AREA.
- 2. SEE SITE PLAN FOR REMOVAL OF EXIST HOUSE AND TREES.

BENCH MARK


NORTH RIM OF SEWER MANHOLE LOCATED AT THE SW COR. OF PROPERTY, UG+C'S DATUM.
ELEVATION 1761.97

BONANZA ROAD

DIAMOND HEAD DR.
MESQUITE AVE.
(SEE SHEET 25-7)

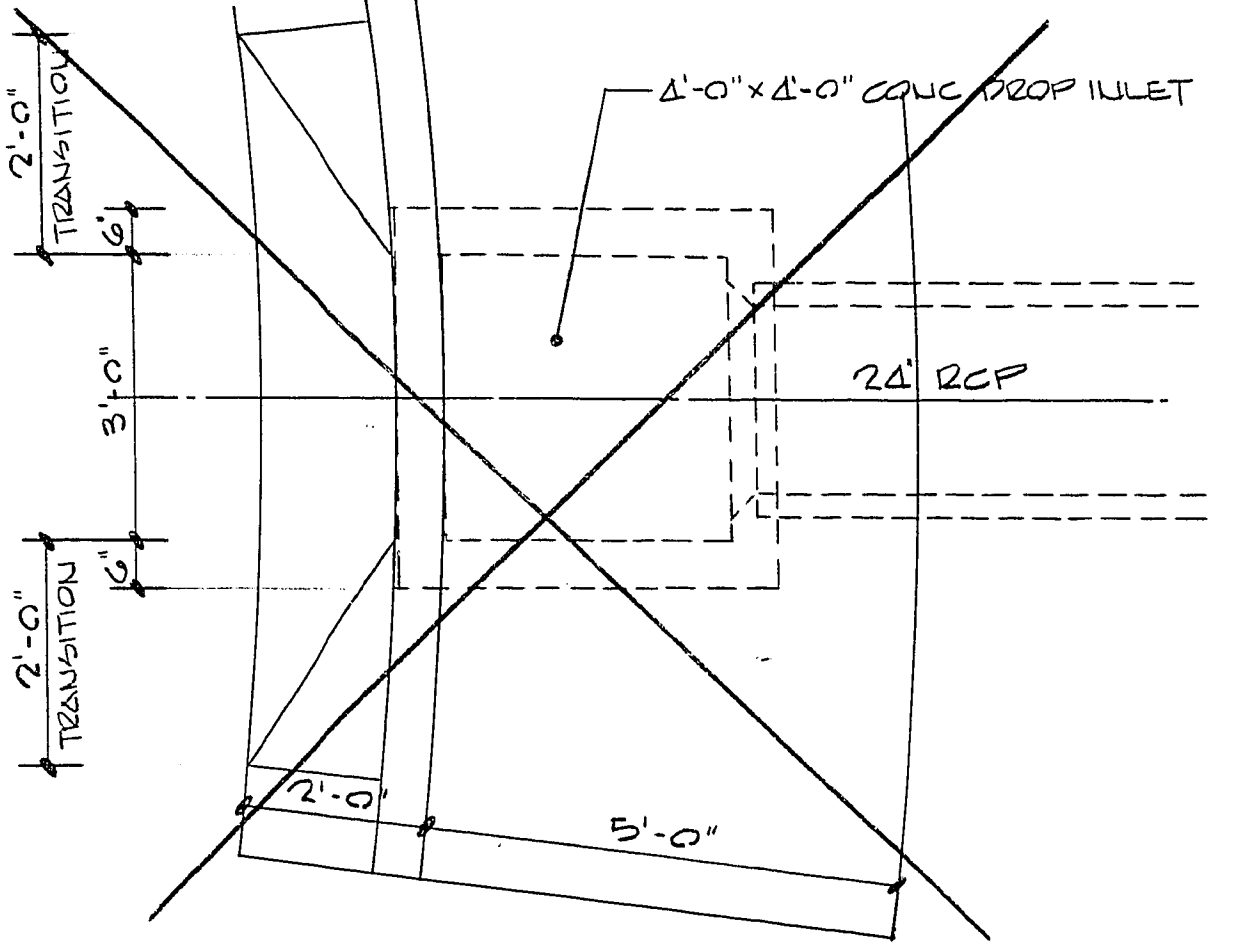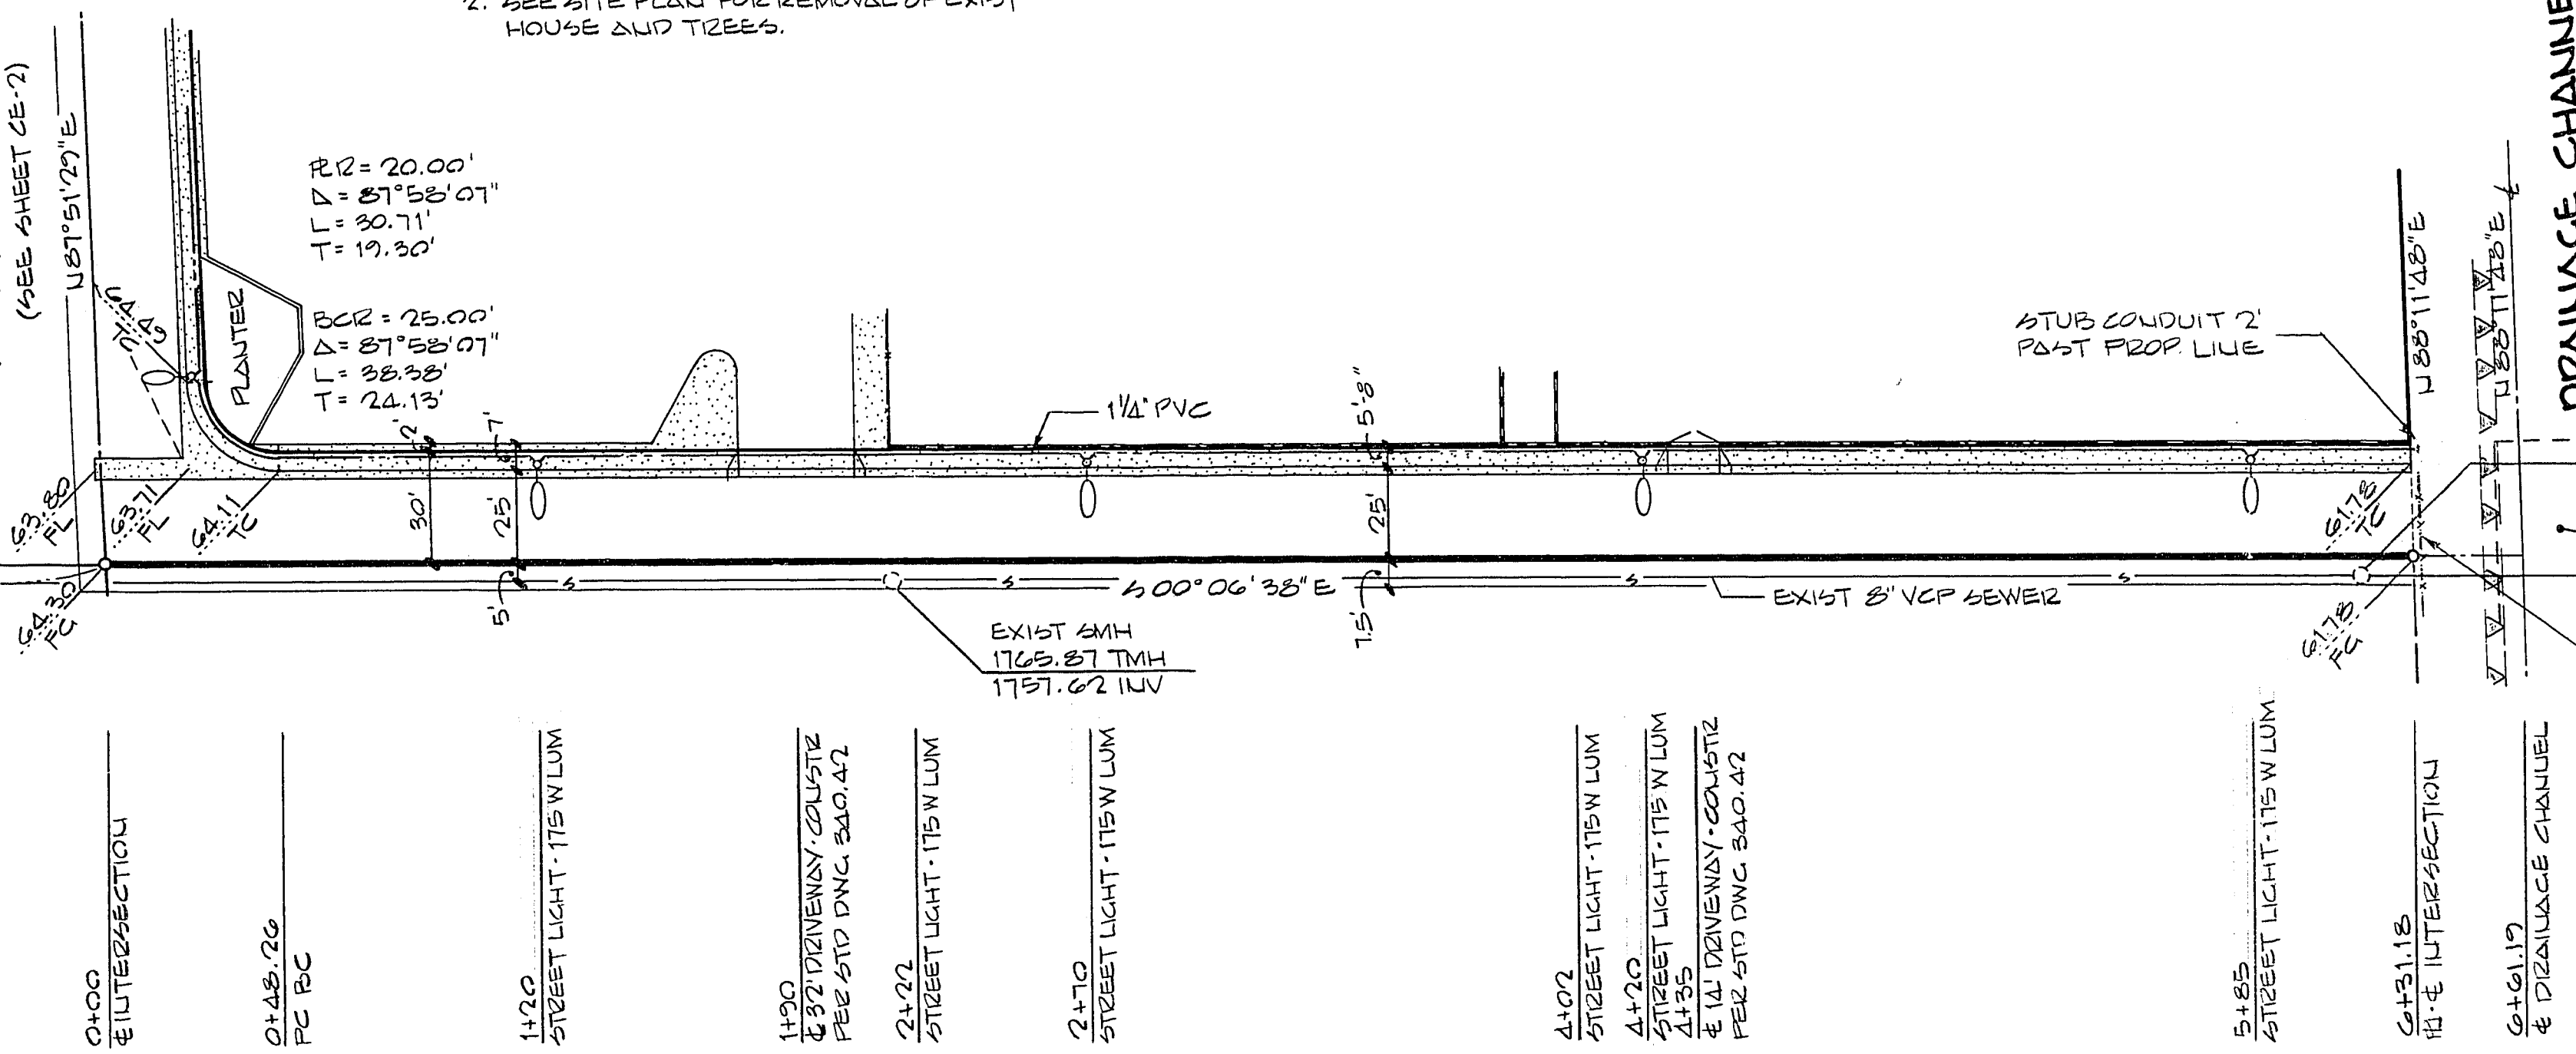


DETAIL 1

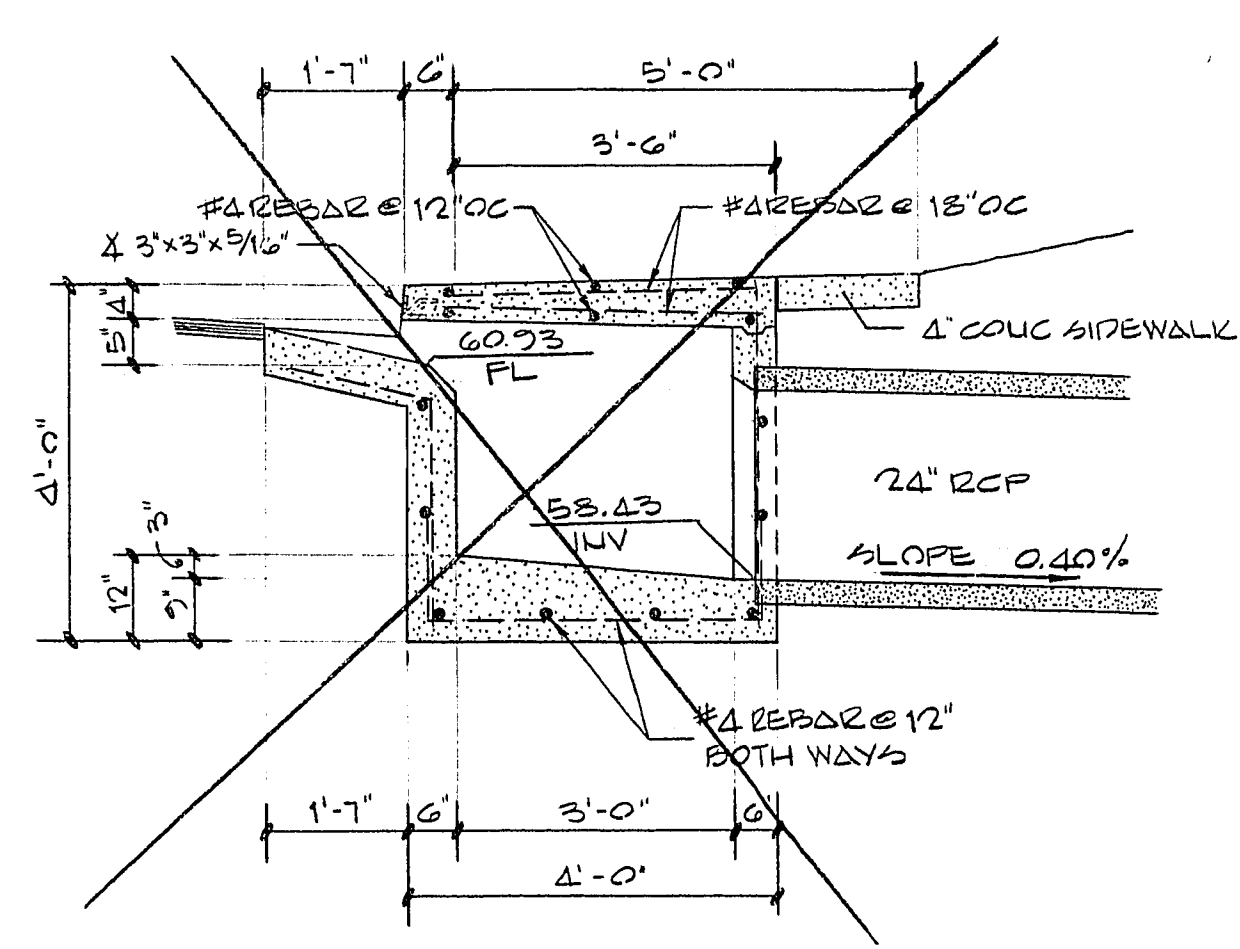

SECTION A

P A C E A V E N U E

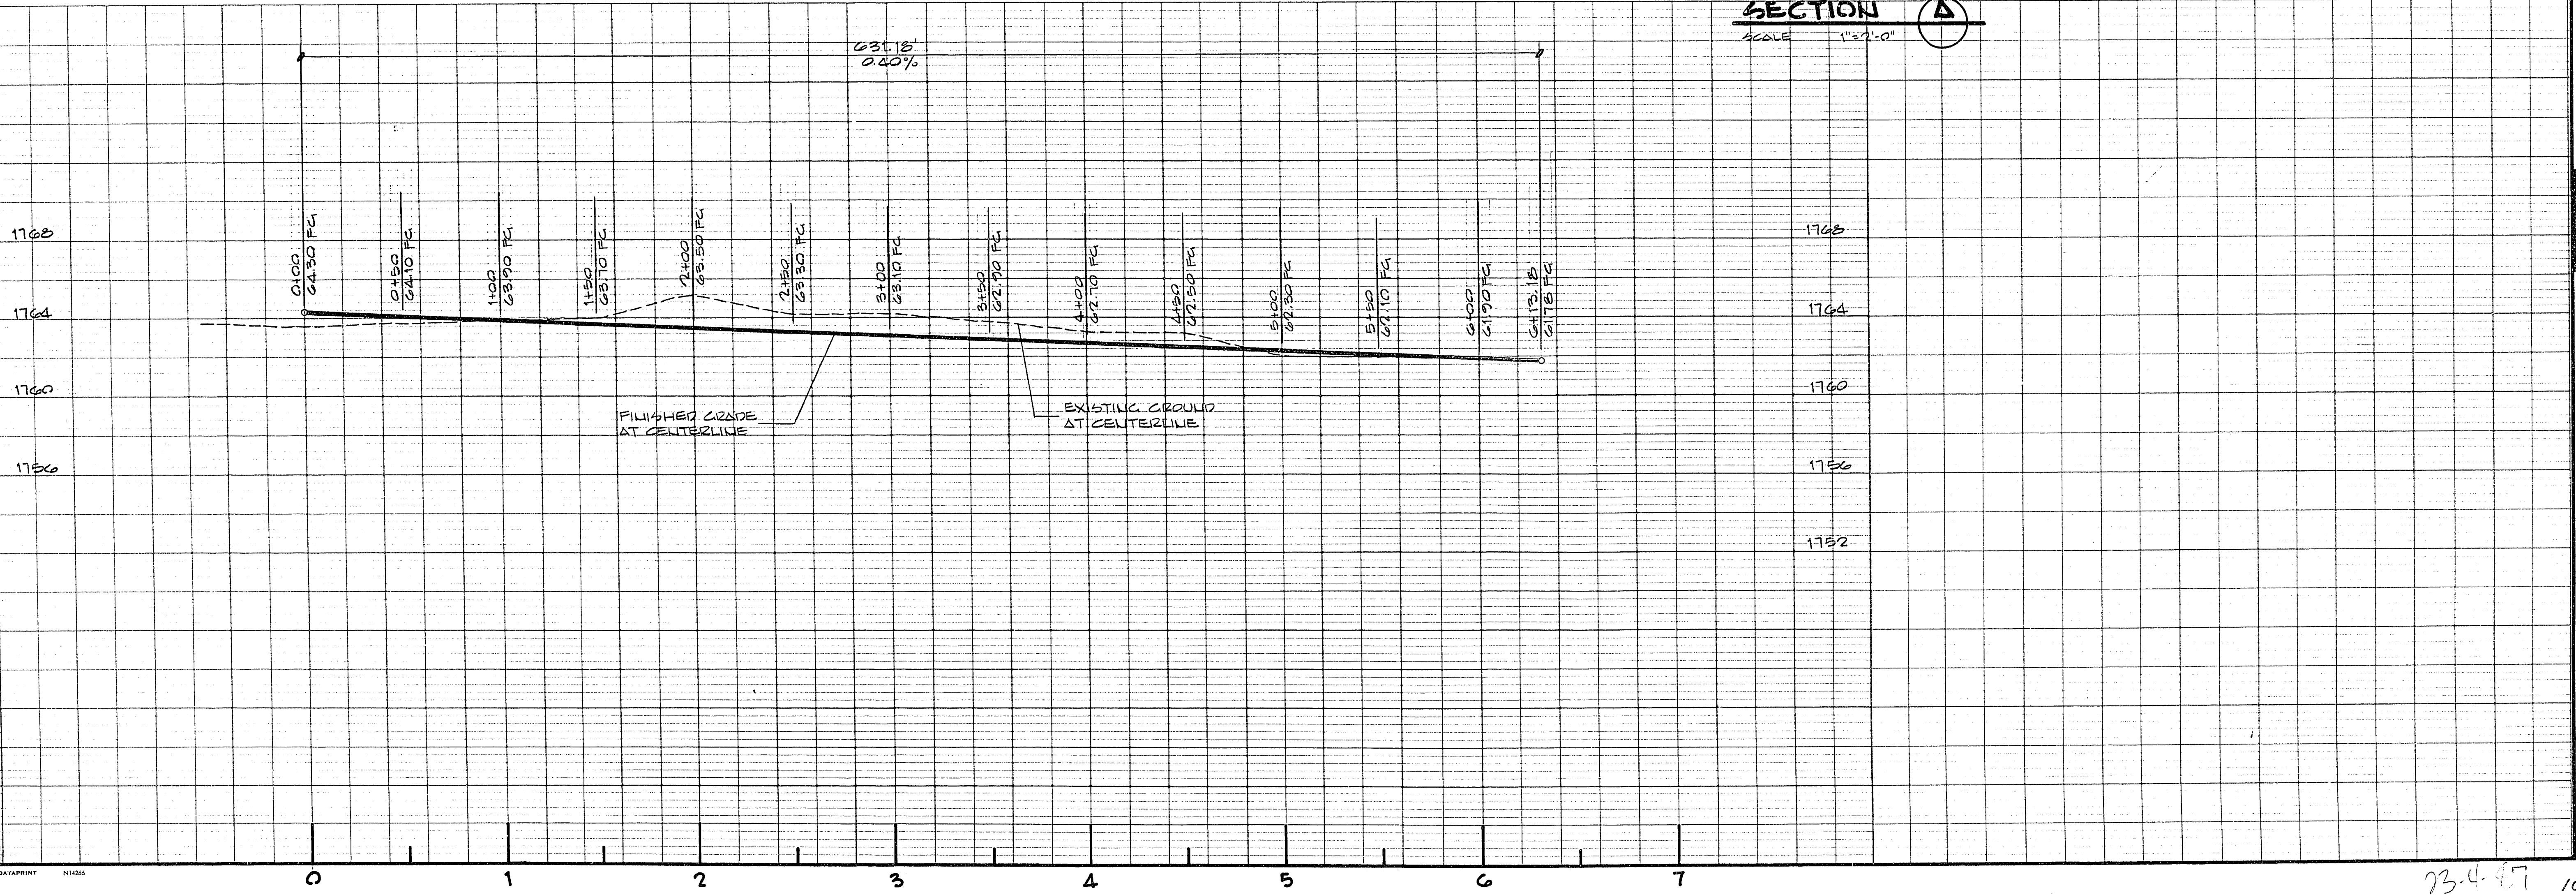

SCALE
HORIZ 1"=40'
VERT 1"=4'

APPROVALS

CLV ELECTRICAL SUPT. 5-4-76
CLV ELECTRICAL COORDINATOR 5-8-76
CITY ENGINEER 7/7/76
CITY OF LAS VEGAS FIELD ENGINEER

REVISIONS

DATE	NO.	REVISIONS
	1	1. UNIT CORRECTED, ALL BACK CALCULATIONS AND INCREASE OVERSIGHTS TO BE SPECIFIC.

PREPARED FOR: WELLES, TATE & KENNEDY ARCHITECTS, AIA

DATE: 5-4-76
DRAWN: ANM
CHECK: BJB
SCALE: AS NOTED

DATE: 5-4-76
DESIGN: BAUGHMAN, HAUGHT & TURNER
MINING ENGINEERS
CIVIL ENGINEERS
LAND SURVEYORS
2335 WEST CHARLESTON BOULEVARD
LAS VEGAS, NEVADA 89102
702-370-8771

STREET & STREET LIGHT DESIGN
PACE AVENUE
SECTION 32, TOWNSHIP 20 SOUTH, RANGE 62 EAST, N.D.B.
CITY OF LAS VEGAS, NEVADA

PROJ. NO. 107-V970
SHEET 11 OF 11
FB 10A P 49