
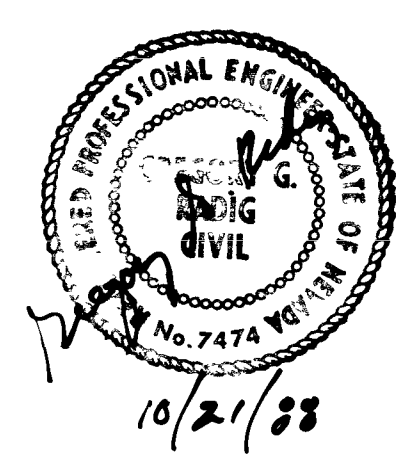
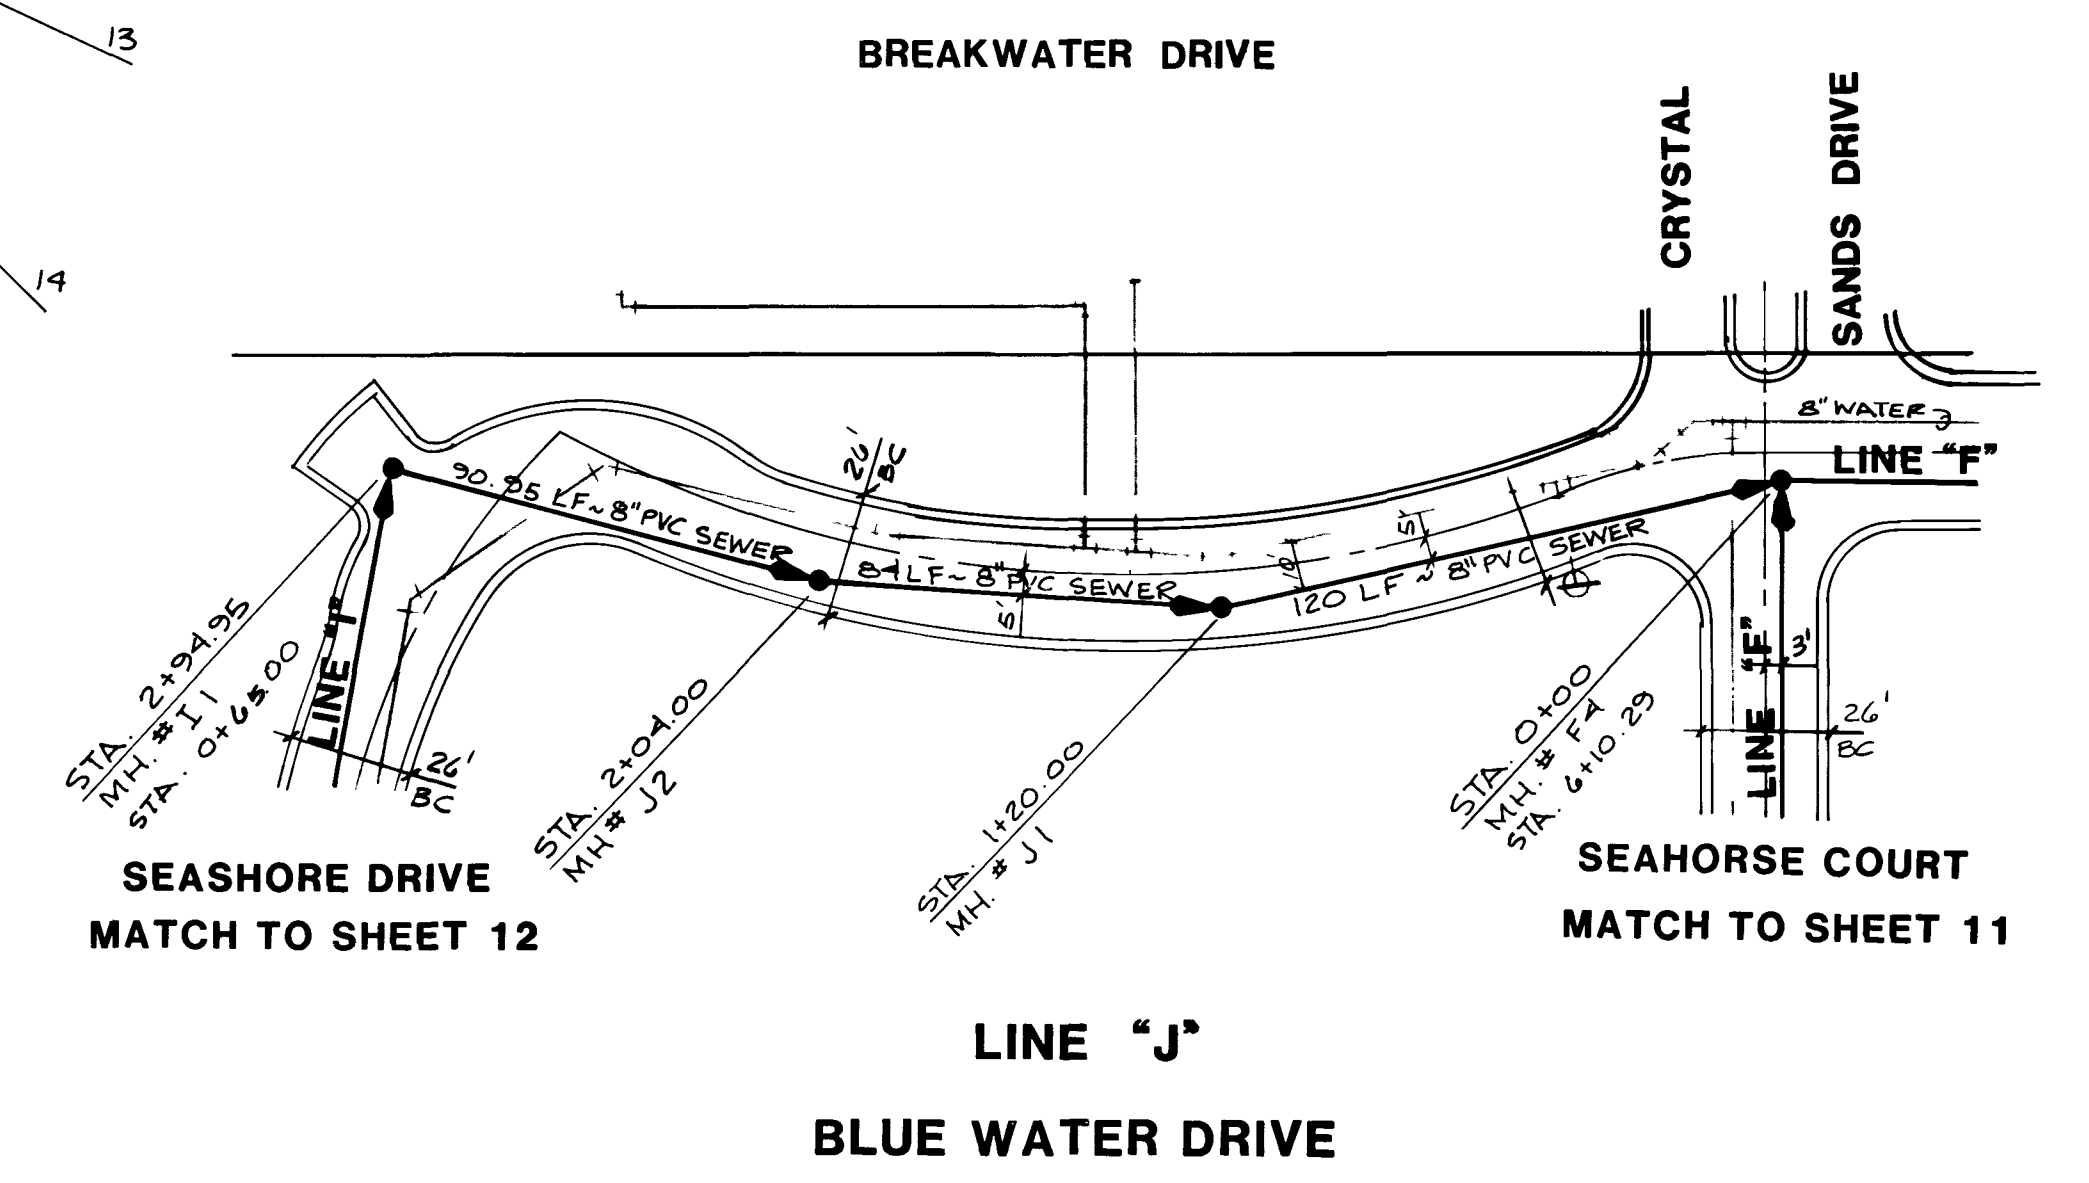
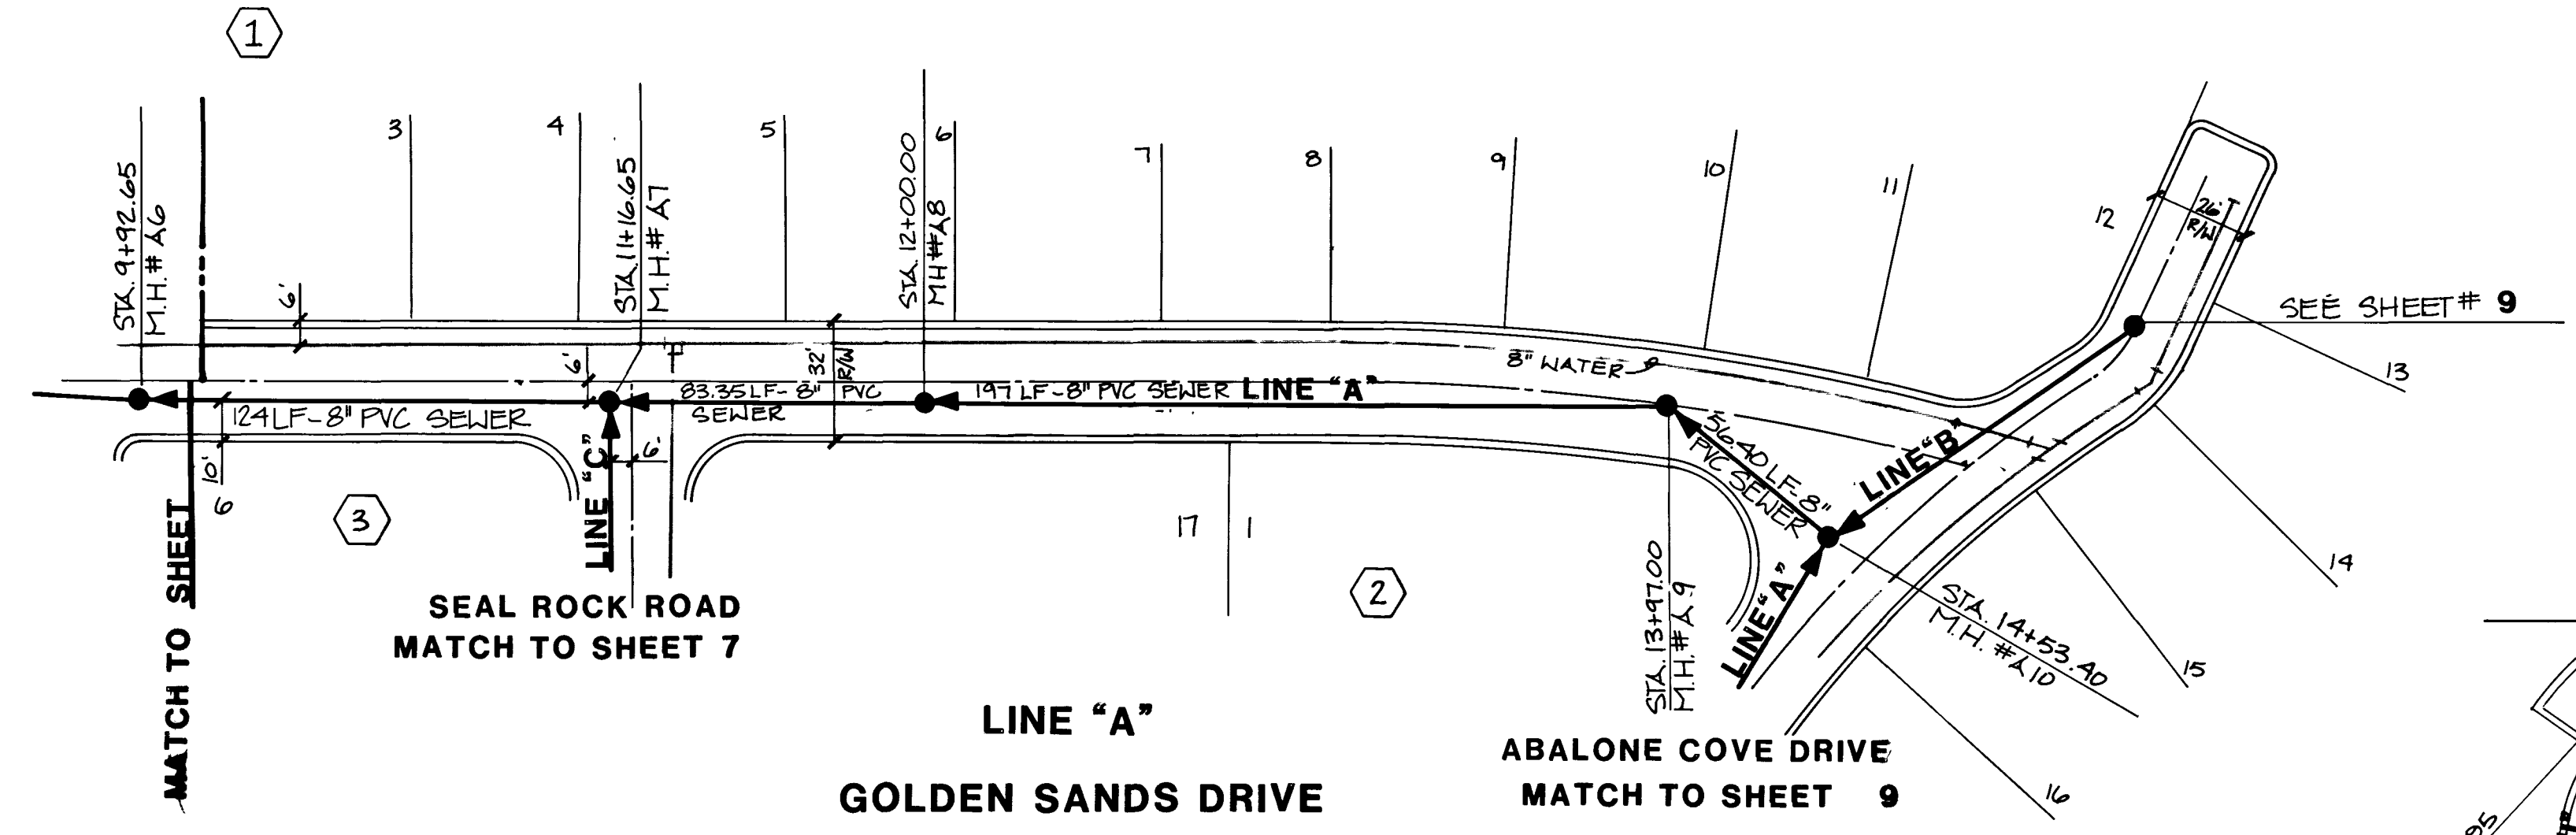



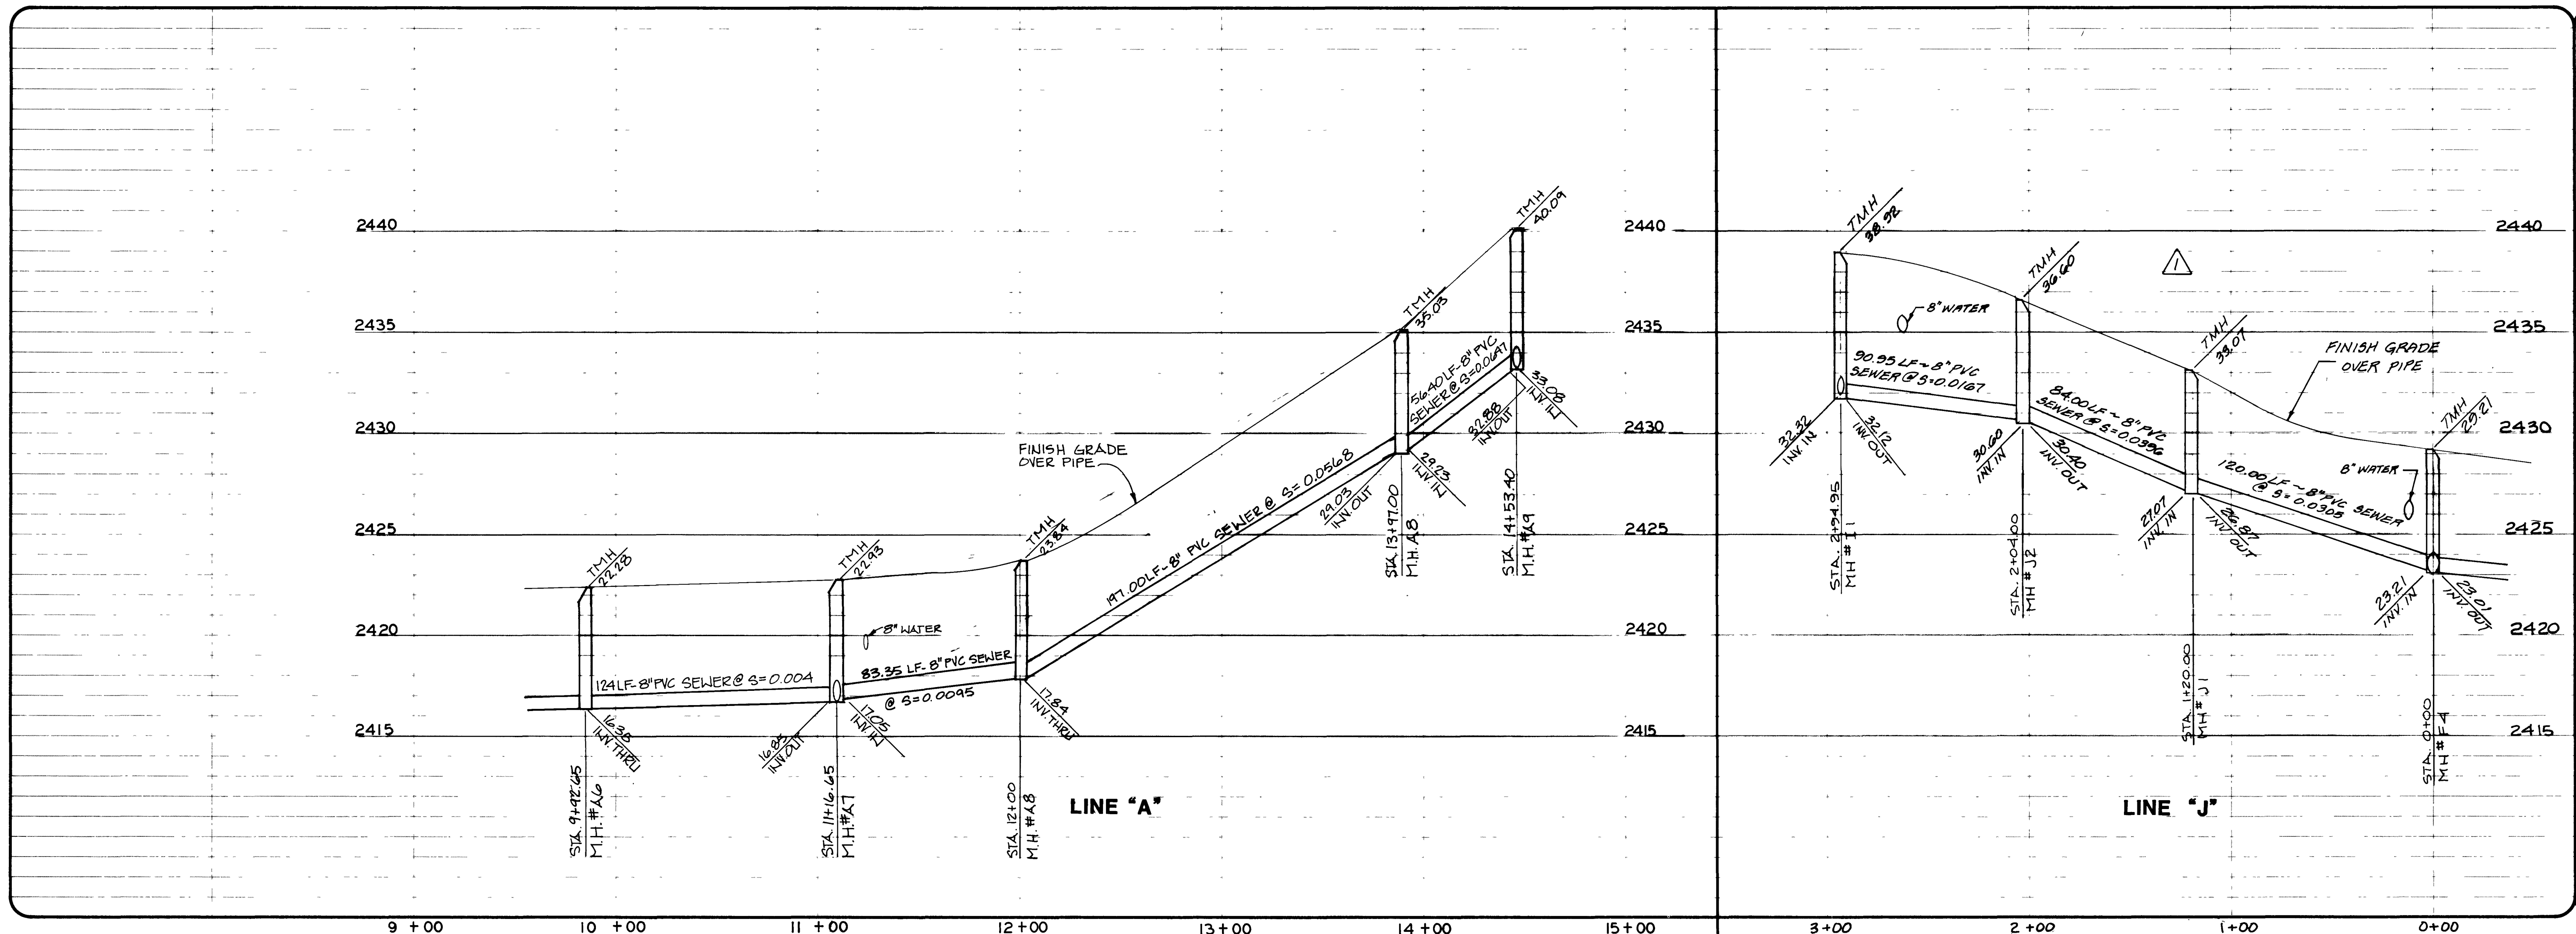


BERGHEER NEVADA CITY OF LAS VEGAS		REVISION DATE BY
PROJECT DESERT SHORES RAQUET CLUB (LOT 9)		PLANNERS CONSULTING ENGINEERS - 2300 PASEO DEL PRADO BUILDING A SUITE 100 LAS VEGAS, NEVADA 89102 PHONE (702) 873-7550

SEWER PLAN AND PROFILE	
LINE "A" 9+92.65 - 14+53.40 LINE "J" 0+00.00 - 2+94.95	TITLE PROJECT DESERT SHORES RAQUET CLUB (LOT 9)

NO. NO. 3691 BY PV/PC DATE OCT. 1988 SCALE HORIZ: 1"=40' VERT: 1"=4'	SHEET 8 OF 13 SHEETS
--	-----------------------------------

501

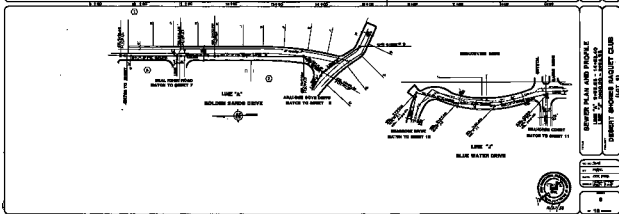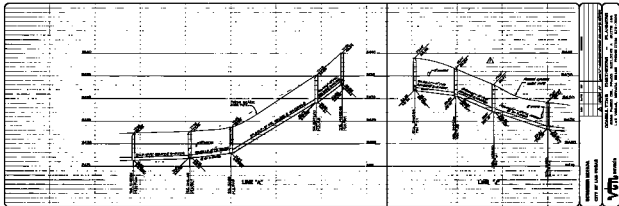

SEWER DESIGN
CITY OF LAS VEGAS

SEWER PLAN AND PROFILE
LINE 1A - 14-14-10
LINE 1B - 14-14-10
DESERT SHORES RAQUET CLUB
(SHEET 3)

DATE: 10/1/80
BY: J. J. J.
CHECKED: J. J. J.
SCALE: 1" = 40'

10/1/80