


MATCHLINE  
SEE SHEET 5


MATCHLINE  
SEE SHEET 6

FUTURE  
UNIT  
NO. 9

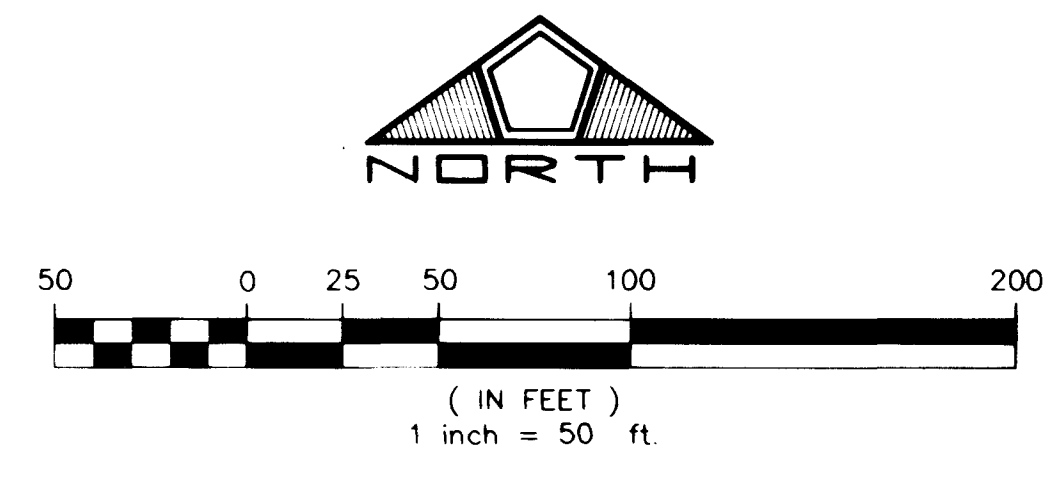

**APPROVALS**

*Darryl P. Rodwein* 1-29-76  
LAS VEGAS VALLEY WATER DISTRICT DATE

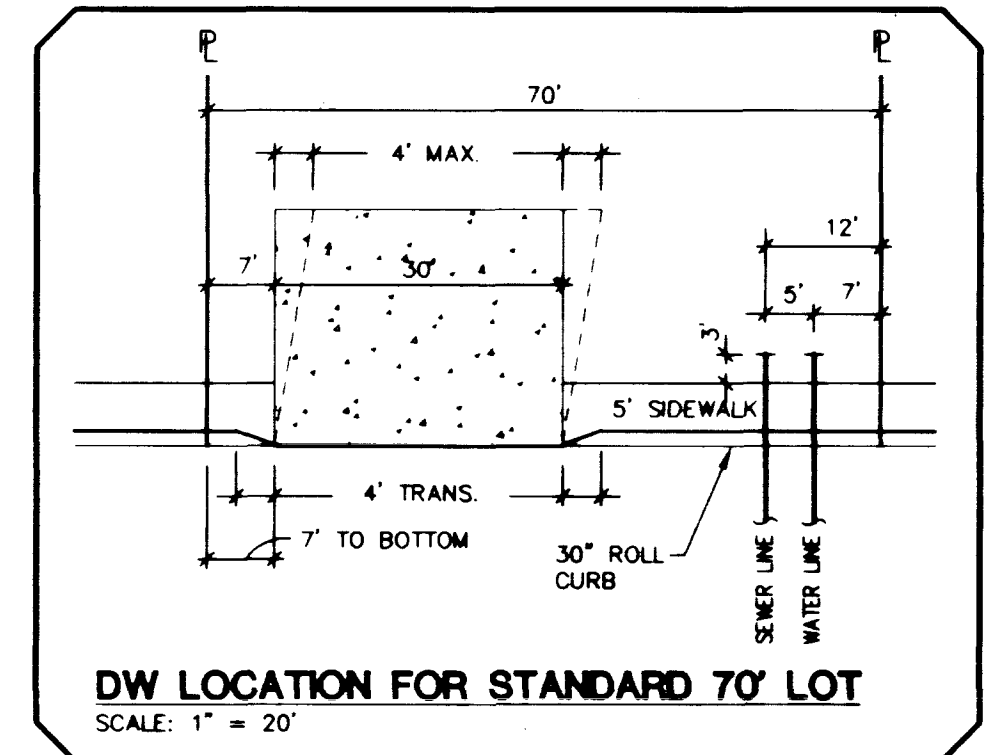

**SEWER CONNECTION NOTE:**

ONE OR MORE SEGMENTS OF THE DOWNSTREAM SEWER SYSTEM THAT WILL SERVE THIS PROJECT HAS NOT BEEN COMPLETED AND/OR ACCEPTED FOR MAINTENANCE BY THE CITY OF LAS VEGAS. ANY WORK DONE ON THIS PROJECT PRIOR TO COMPLETION AND/OR ACCEPTANCE OF THE DOWNSTREAM SEWER SYSTEM(S) SHALL BE DONE AT THE DEVELOPER'S OWN RISK. THE CITY OF LAS VEGAS RESERVES THE RIGHT TO PREVENT THE PHYSICAL CONNECTION OF THIS PROJECT INTO THE DOWNSTREAM SEWER SYSTEM UNTIL ALL SEGMENTS HAVE BEEN COMPLETED AND ACCEPTED FOR MAINTENANCE, OR UNTIL SUCH TIME AS THEY ARE DEEMED AVAILABLE FOR SERVICE.

**FITTINGS LEGEND**

1	8" GATE VALVE
2	STANDARD FIRE HYDRANT ASSEMBLY
3	8" TEE
4	8" 90° BEND
5	8" 45° BEND
6	8" 22 1/2° BEND
7	2" BLOW OFF
8	8" X 6" TEE


Avoid cutting underground utility lines. It's costly.

**Call before you Dig.**

**1-800-227-2600**

UNDERGROUND SERVICE ALERT (USA)


NO.	DESCRIPTION	DATE	APP'D.
3	C.I.V. REVISIONS	10/7/95	
2	UTILITY REVISIONS	8/27/95	
1	C.I.V. REVISIONS	8/17/95	

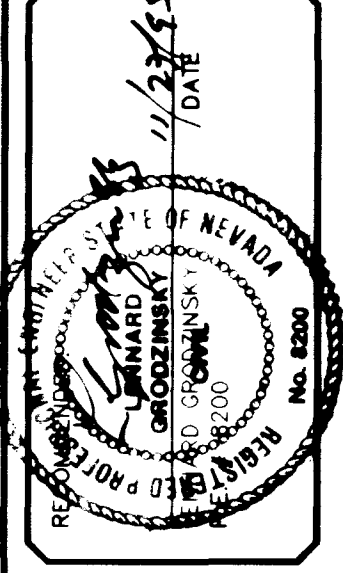

DATE	11/27/95
DRAWN BY	D.D.
DESIGNED BY	M.S.G.
CHECKED BY	
JOB NO.	1714 0009
SCALE	1" = 50'

**PENTACORE**  
Engineering, Inc.  
(702) 258-0115  
6763 West Charleston Boulevard  
Las Vegas, Nevada 89102

AMERICAN WEST HOMES, INC.  
EL CAPITAN RANCH - UNIT NO. 8  
UTILITY PLAN  
SHEET  
**4**  
OF 18

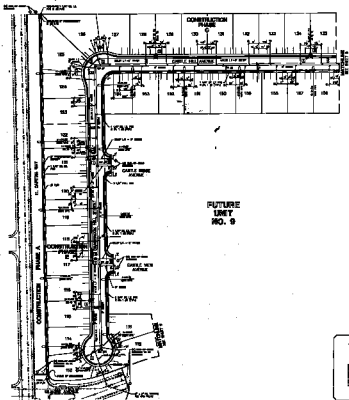

FUTURE  
UREY  
NO. 9



REVISED

*James E. Johnson*  
LAWYER  
1000 W. 10th St. S.W. OKLAHOMA CITY, OKLA. 73101



**ATTENTION:**

- 1. See notes
- 2. See notes
- 3. See notes
- 4. See notes
- 5. See notes
- 6. See notes
- 7. See notes
- 8. See notes
- 9. See notes
- 10. See notes

**Before Call**

**1-800-368-5888**

**PENTACORE**
  
 REGISTERED PROFESSIONAL ENGINEER

---

ADDRESS: 1000 W. 10th St. S.W. OKLAHOMA CITY, OKLA. 73101  
 EL. ENGINEER: JAMES E. JOHNSON  
 PROJECT NO.: 1000 W. 10th St. S.W. OKLAHOMA CITY, OKLA. 73101

---

**4**