
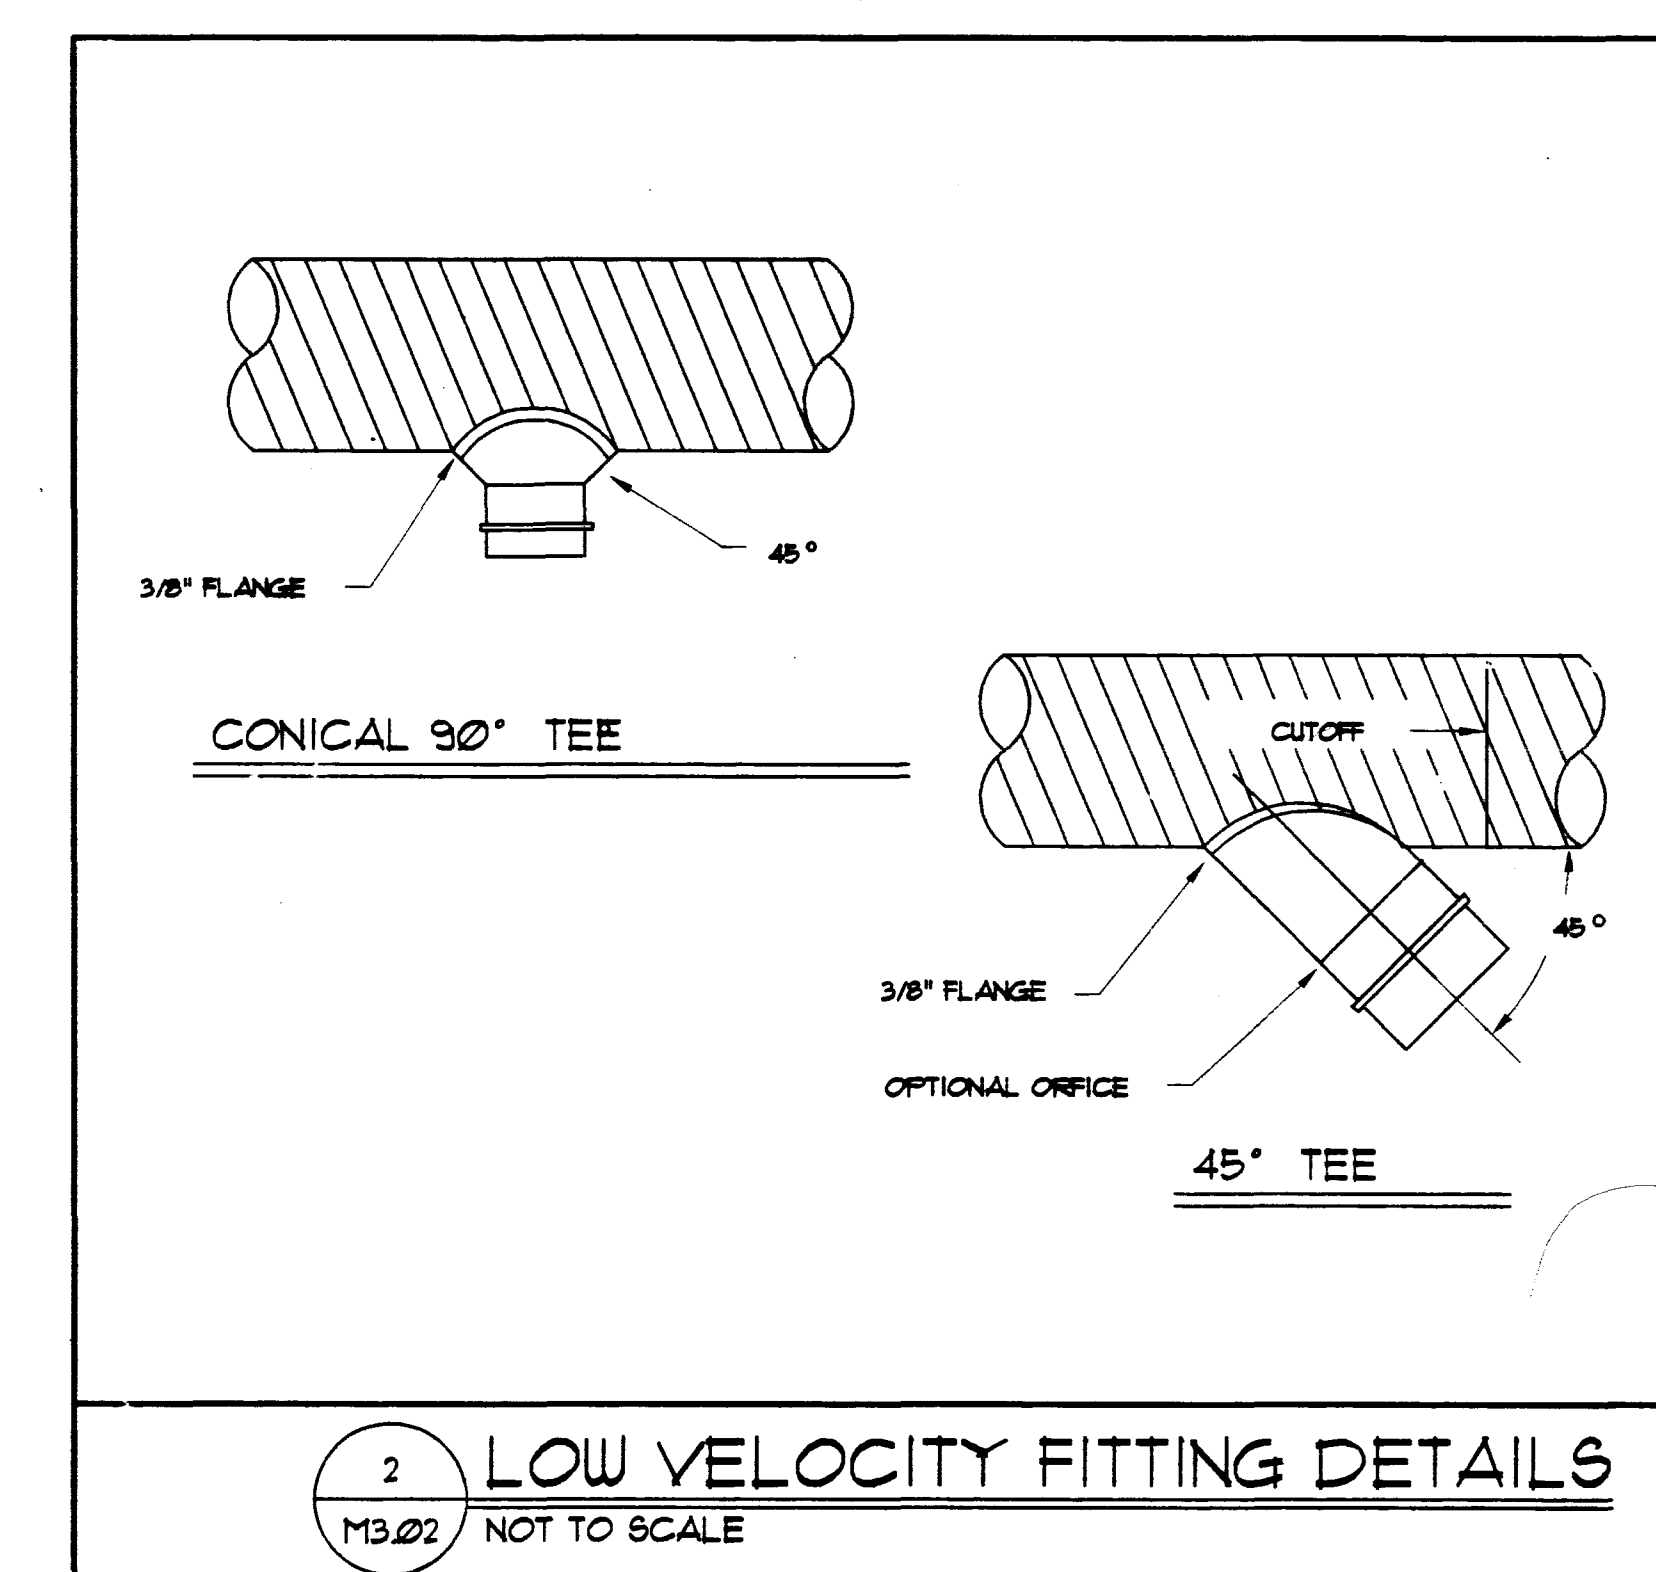
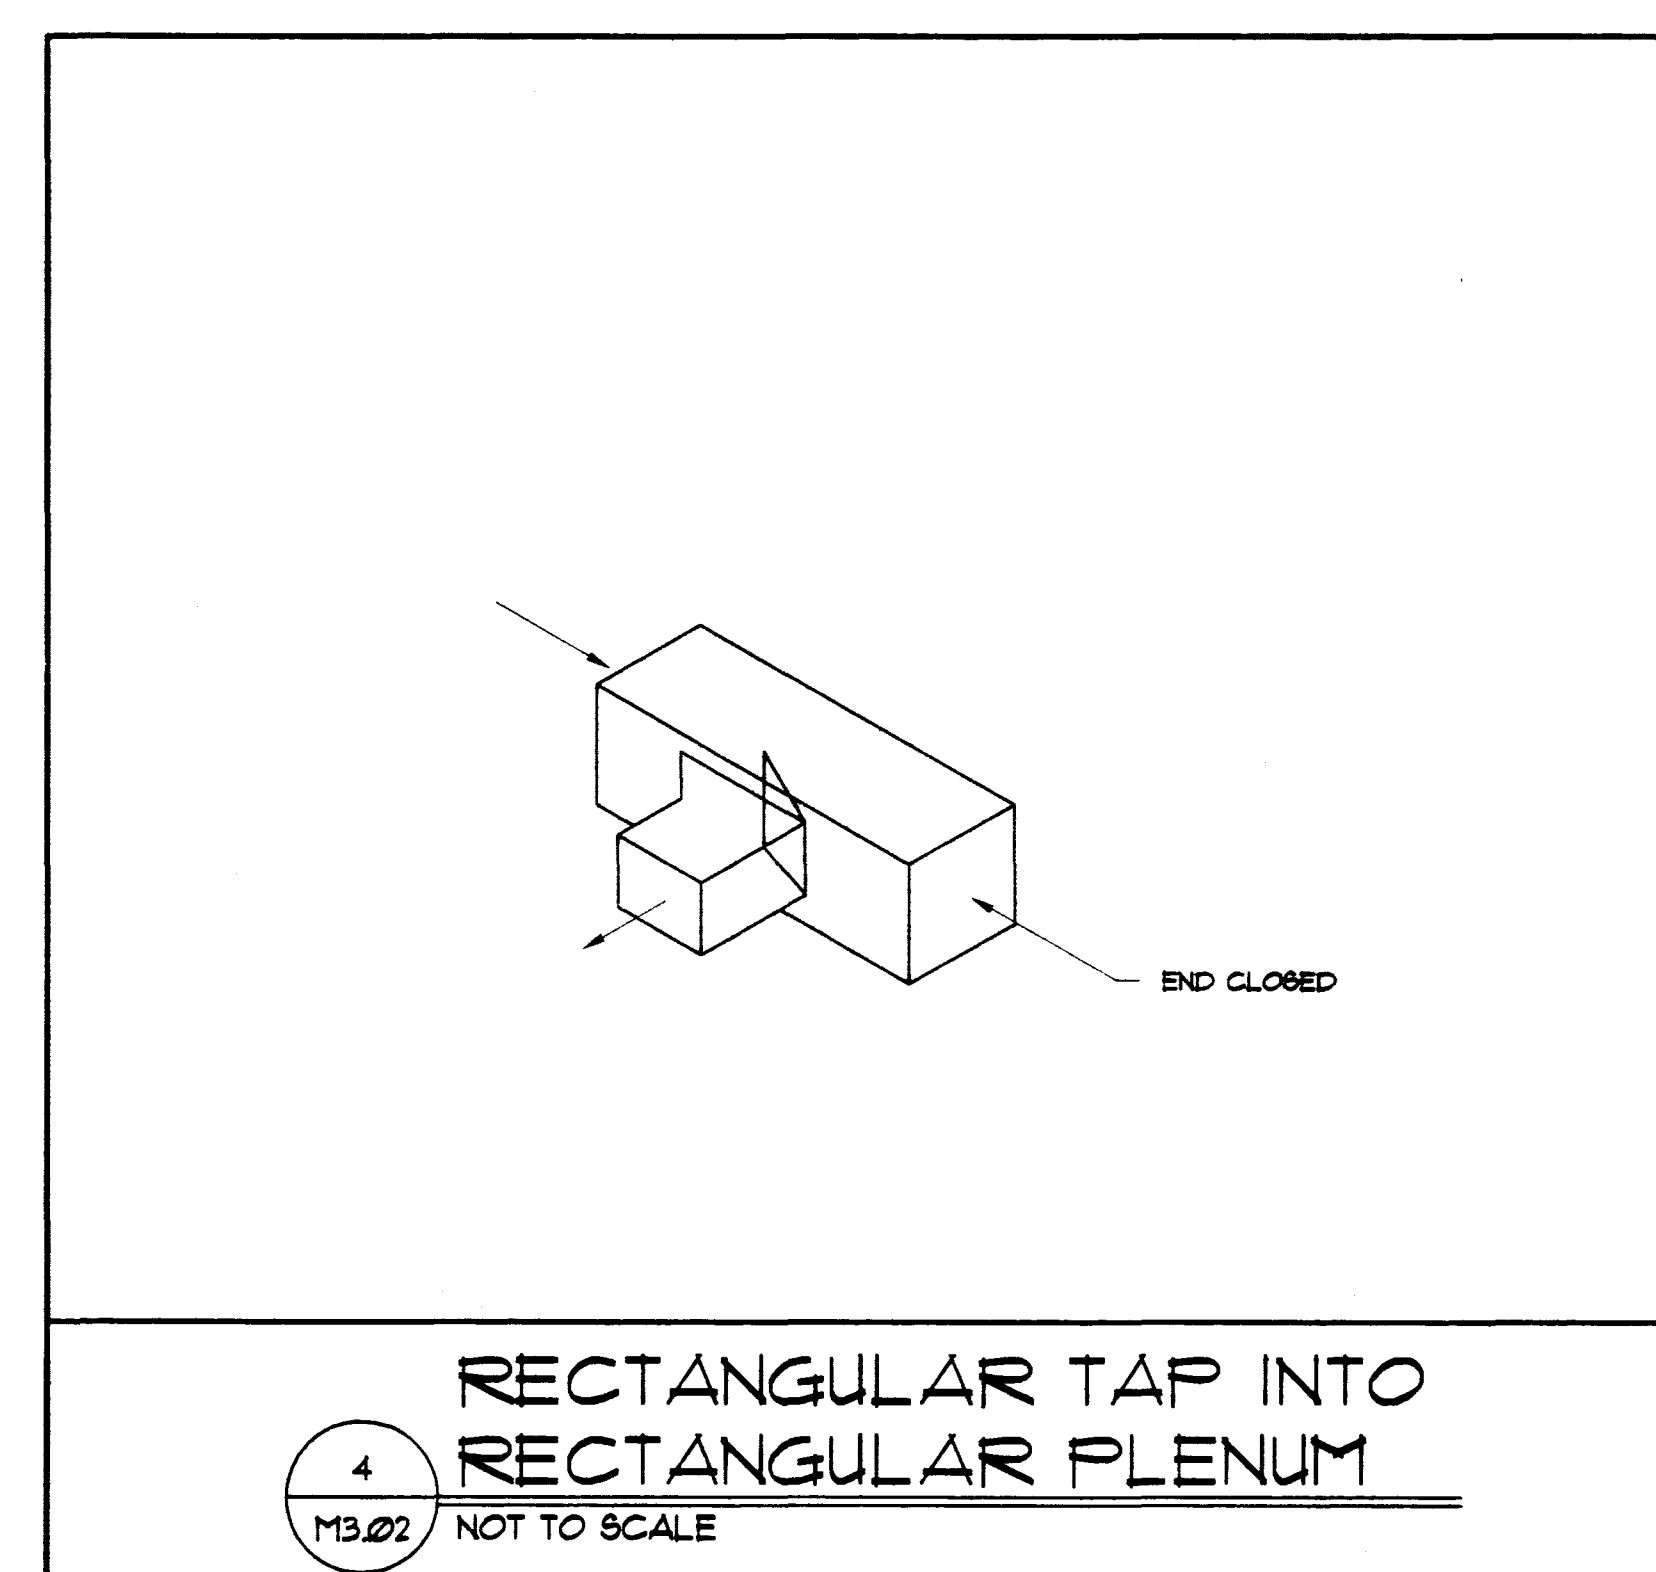
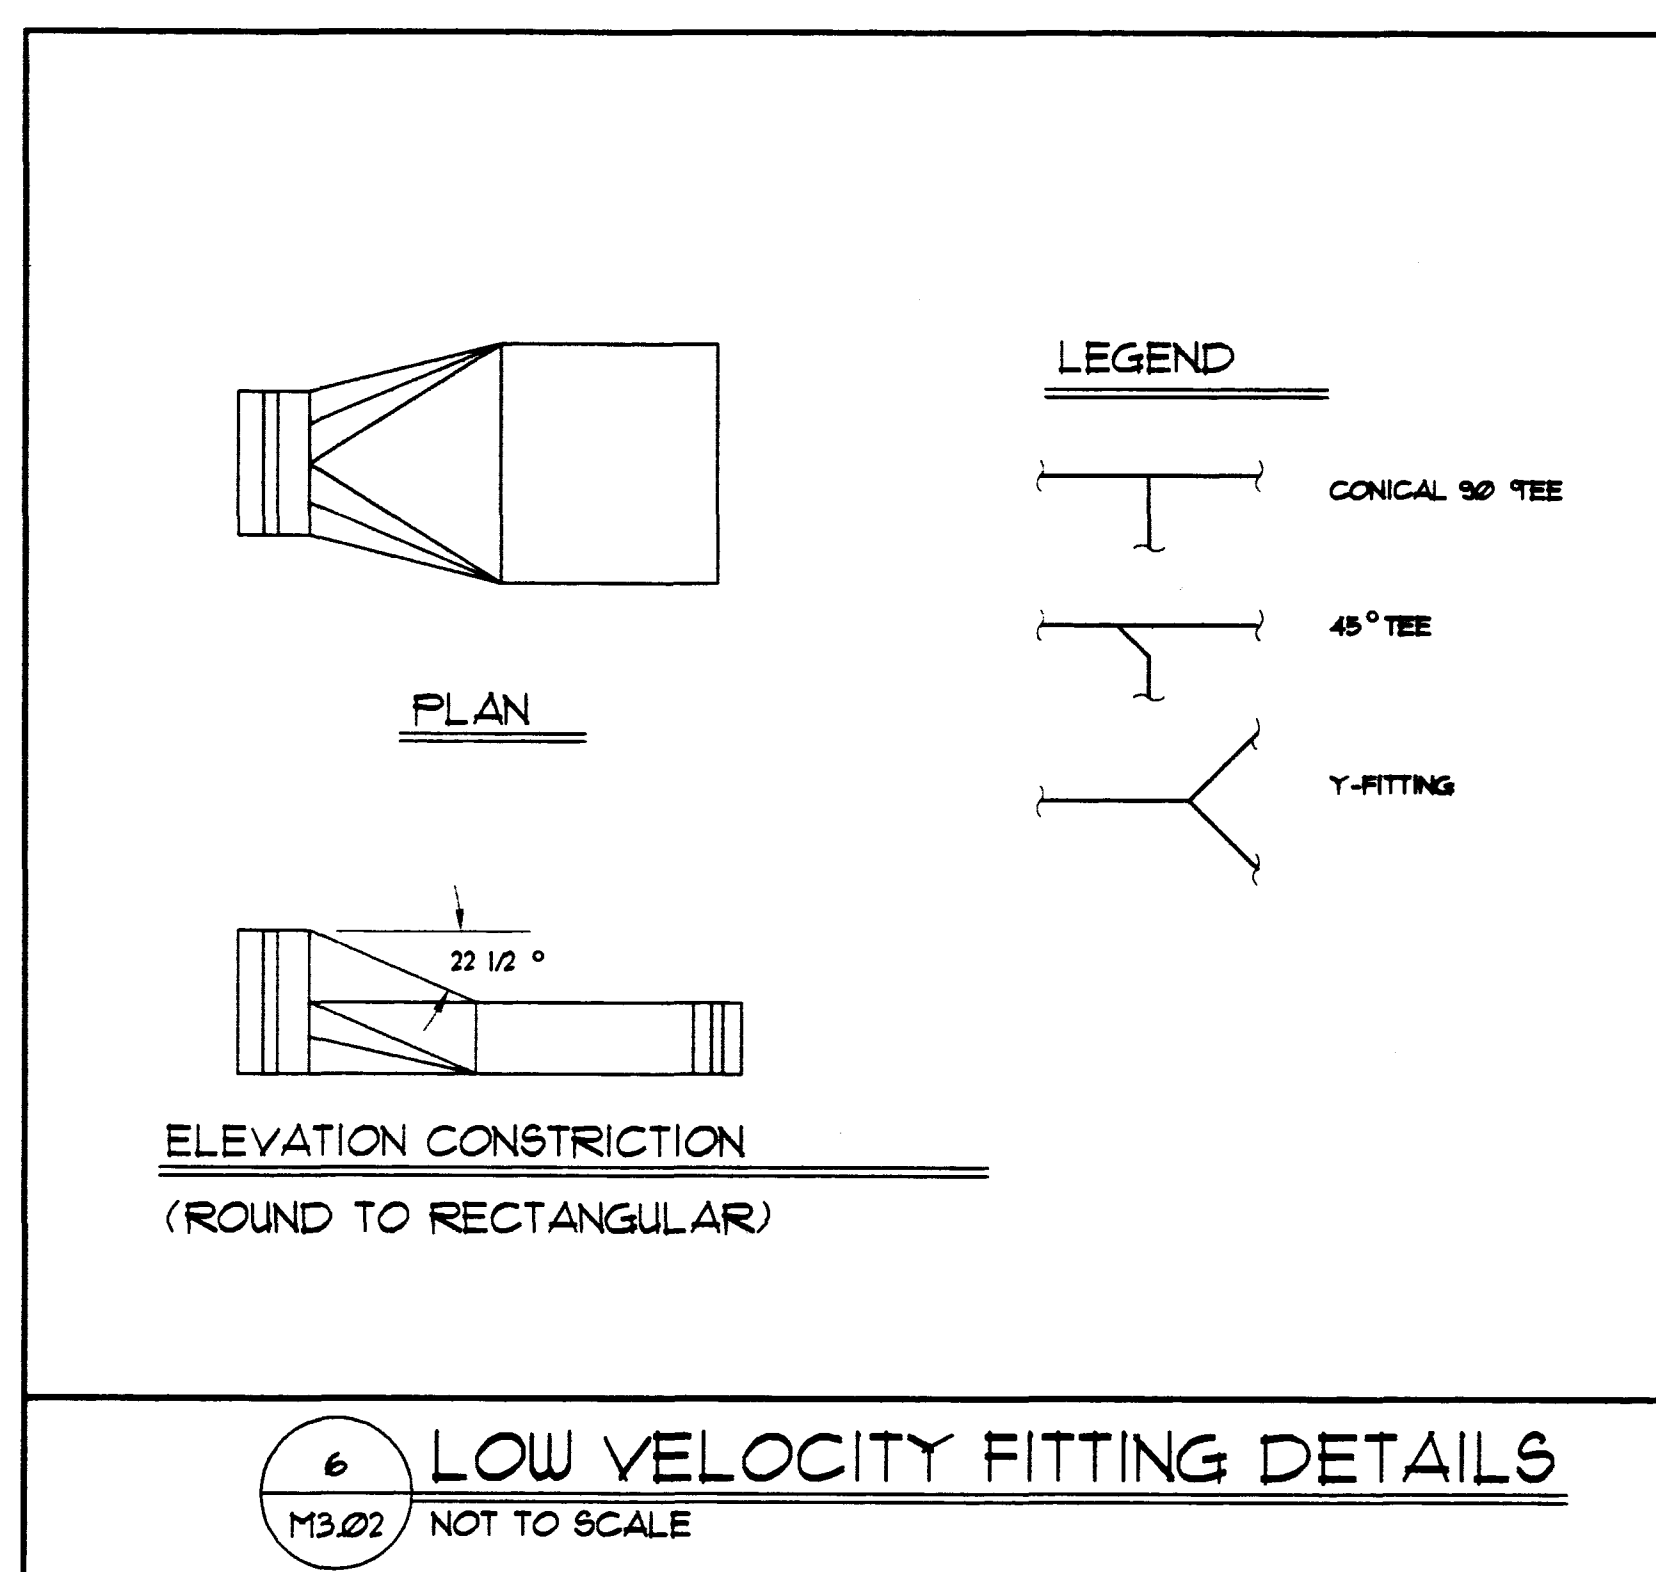
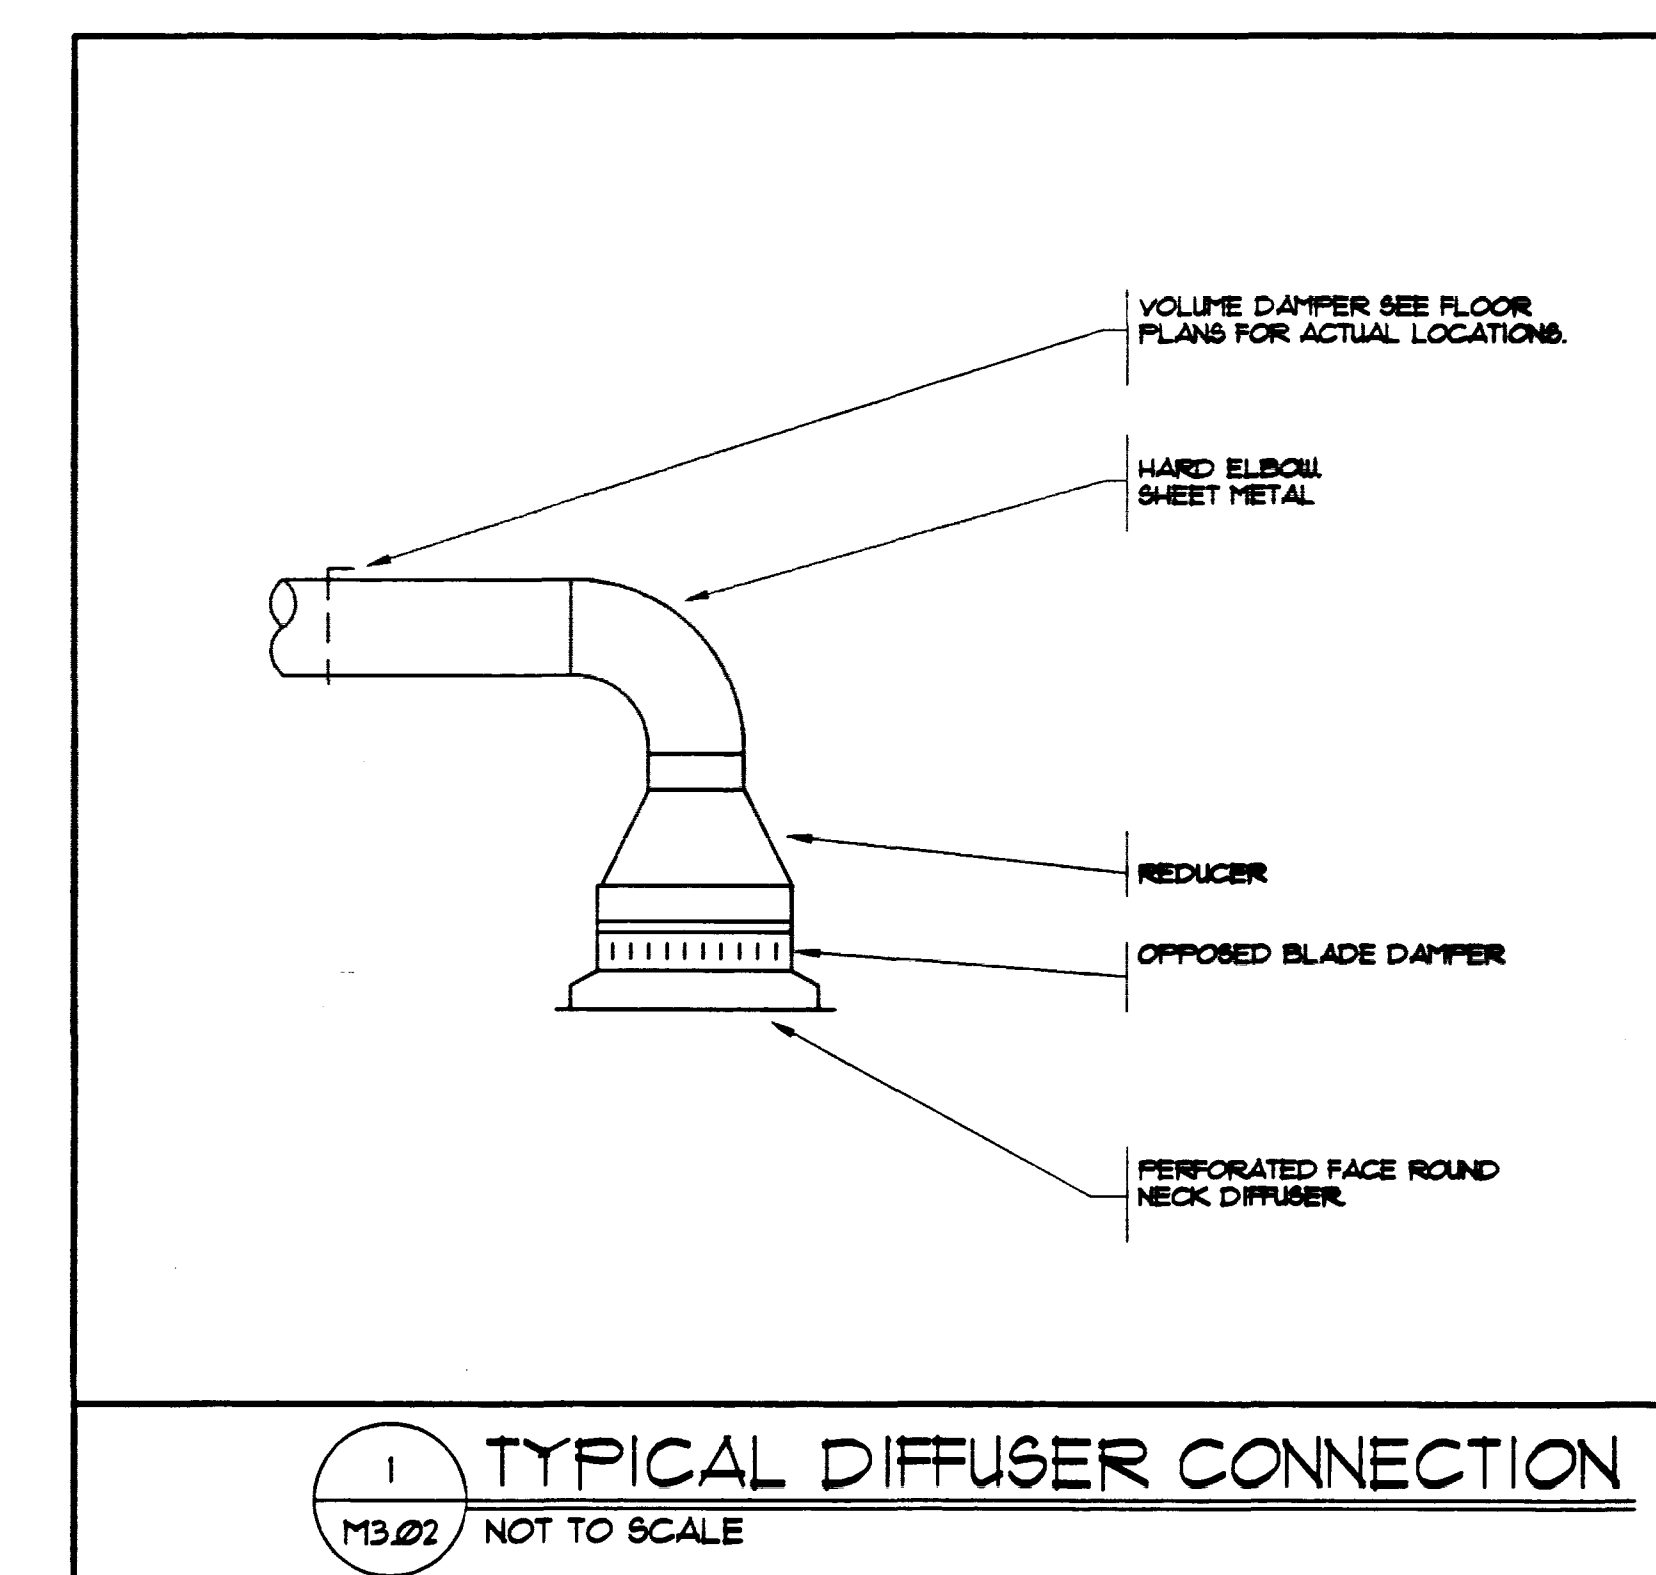
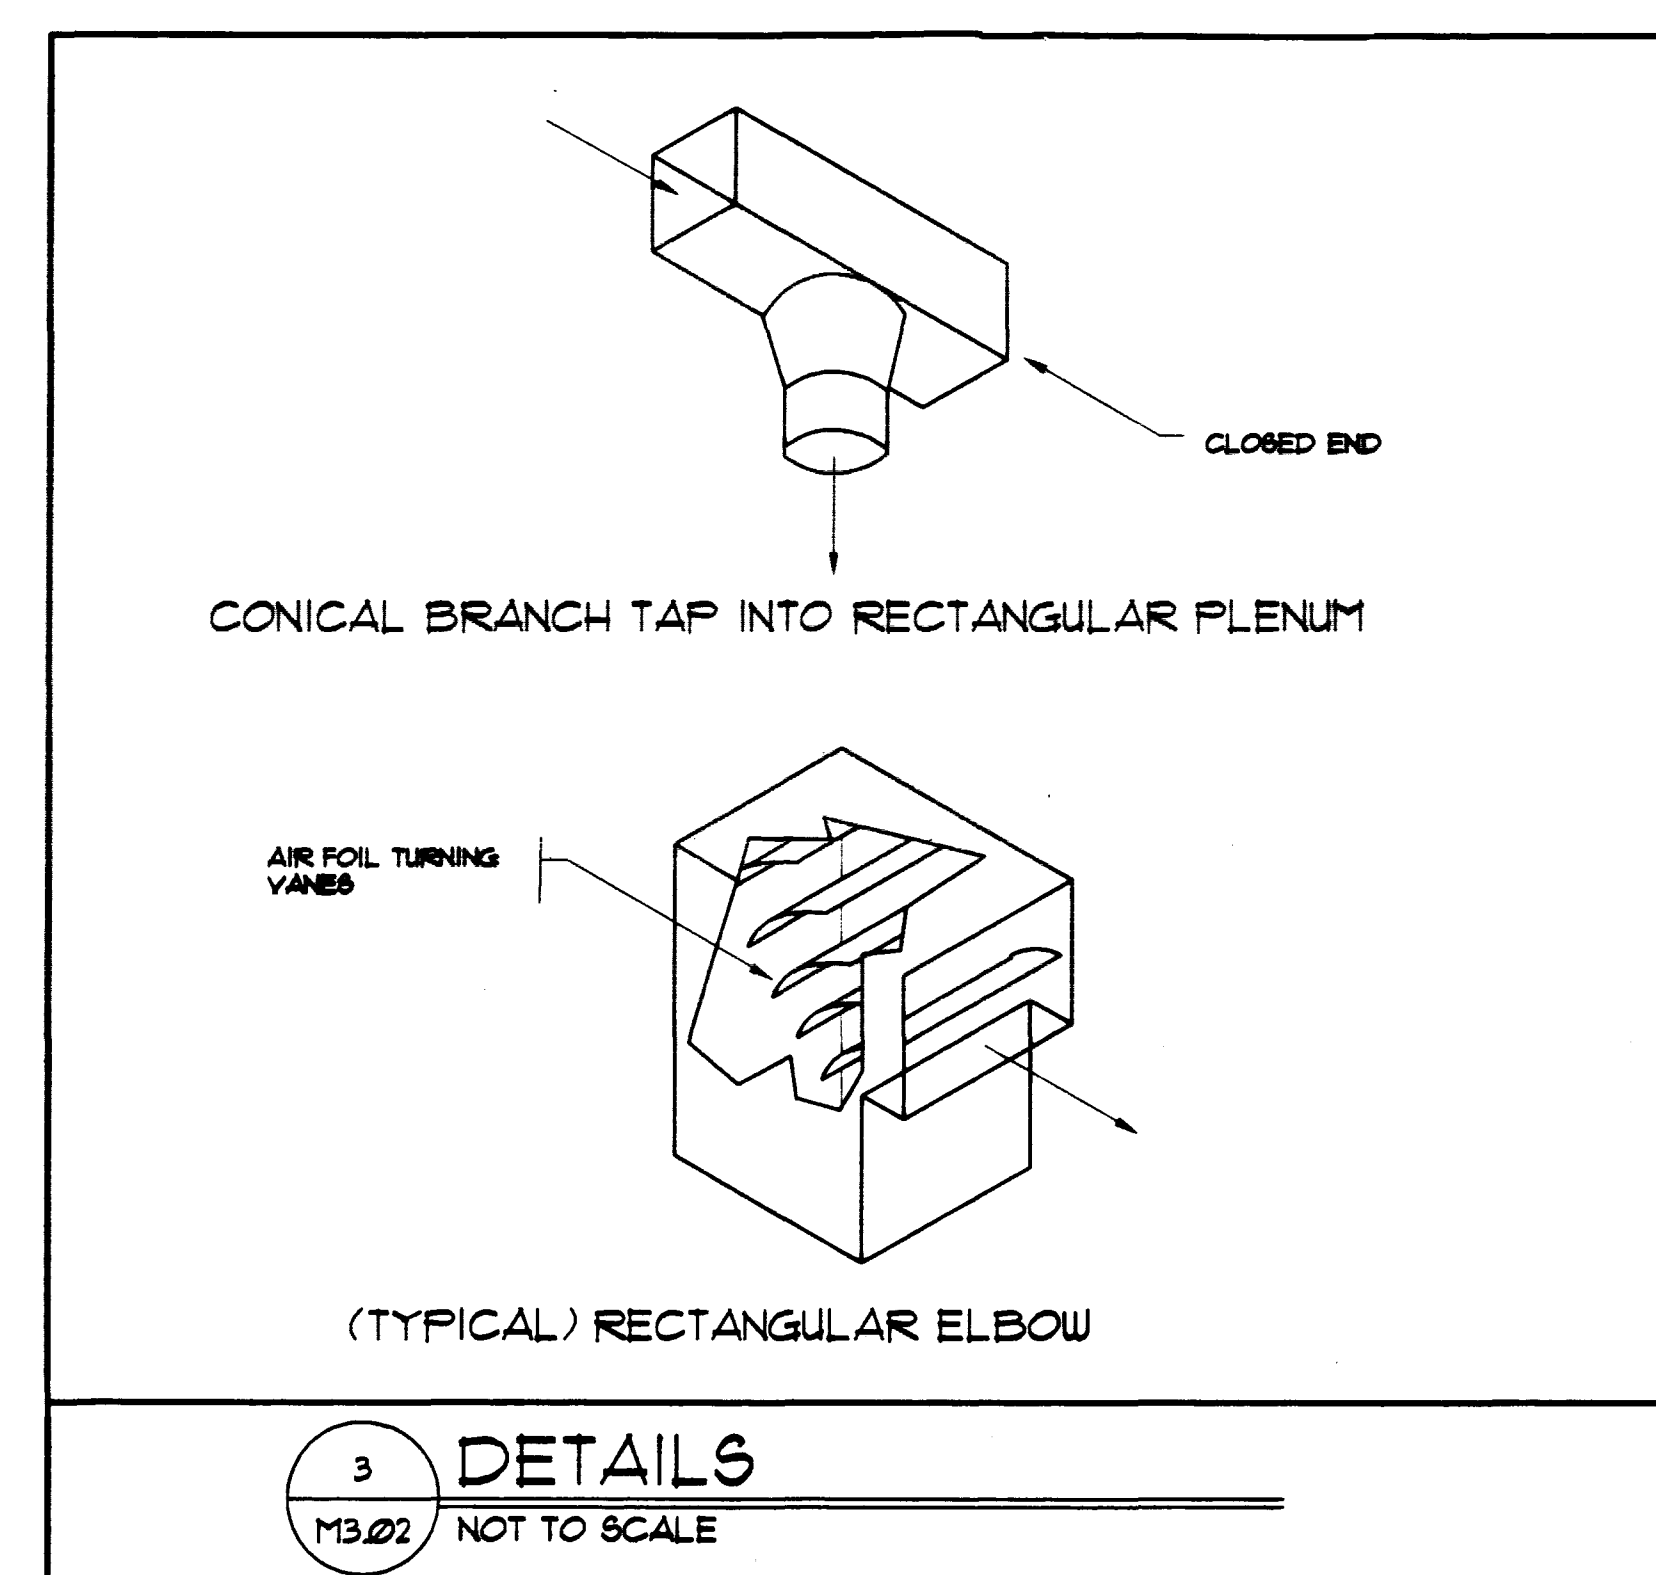


M3.02

5-13-96


952600

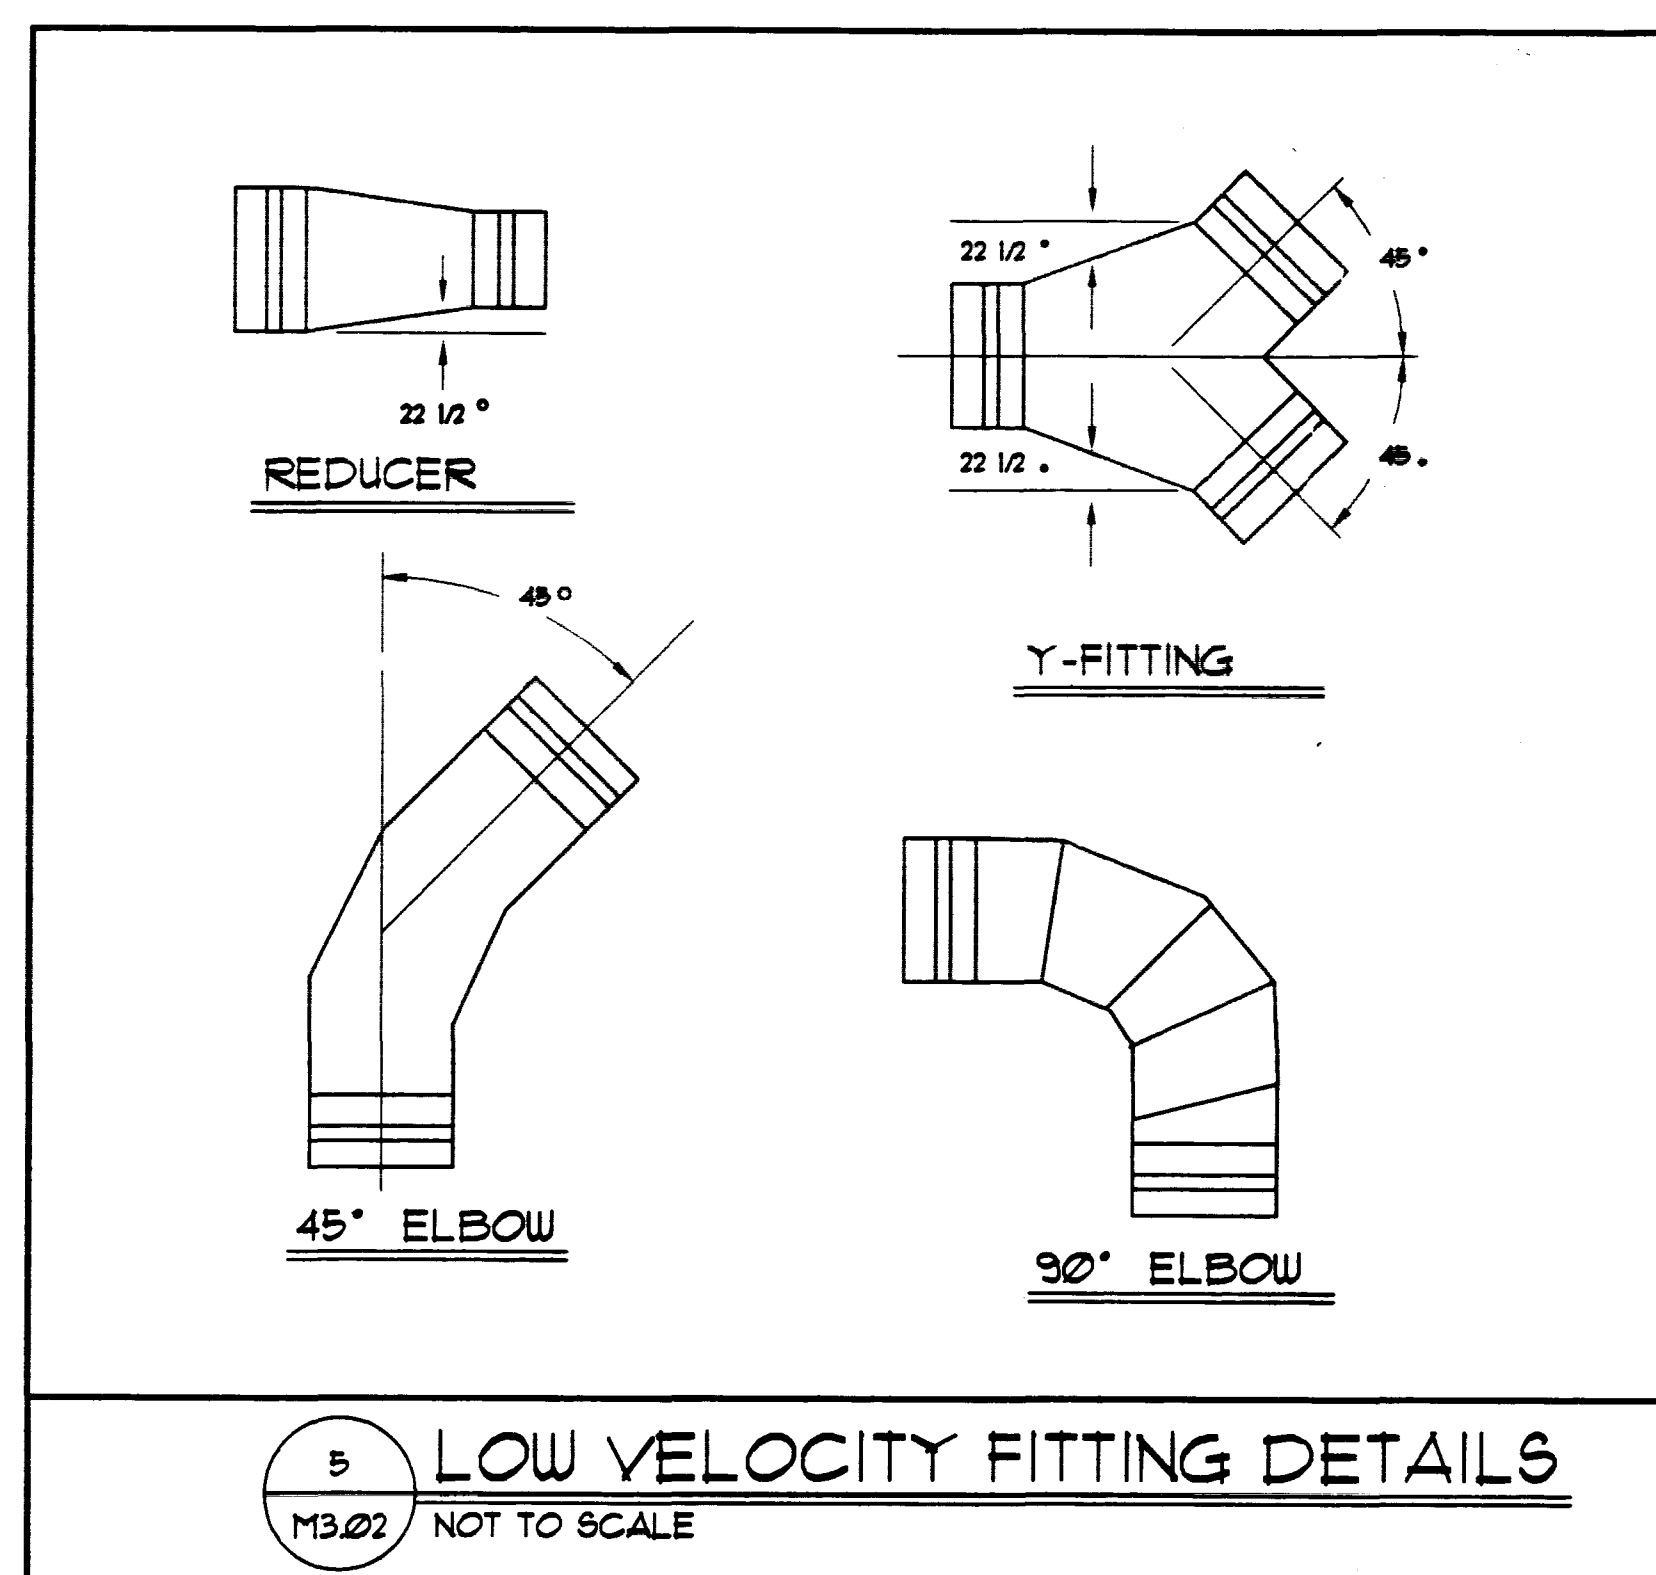

AS BUILT DRAWING
DATE 5/13/96

DRAWING ISSUE LOG			
SYM.	DESCRIPTION	DATE	BY


DO NOT SCALE DRAWINGS

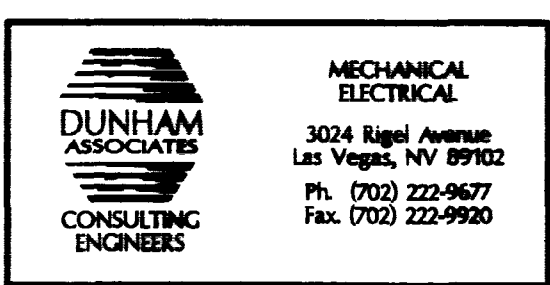

All designs, arrangements and plans indicated or presented by this drawing, as instruments of service, are owned by and the property of DOMINGO CAMBEIRO CORPORATION. To alter these documents for any project by anyone other than the original architect is a violation of NRS 523. The plans and/or specifications shall be restricted to the original site for which they were prepared and publication thereof is expressly limited to such use. Reproduction, publication or re-use by any method in whole or in part, is prohibited. None of such designs, arrangements or plans shall be used by or disclosed to any person, firm, agency, or corporation without the written permission of DOMINGO CAMBEIRO CORPORATION. Visual contact with these plans and specifications shall constitute prima facie evidence of acceptance of these restrictions.

© DOMINGO CAMBEIRO CORPORATION 1996

SEAL

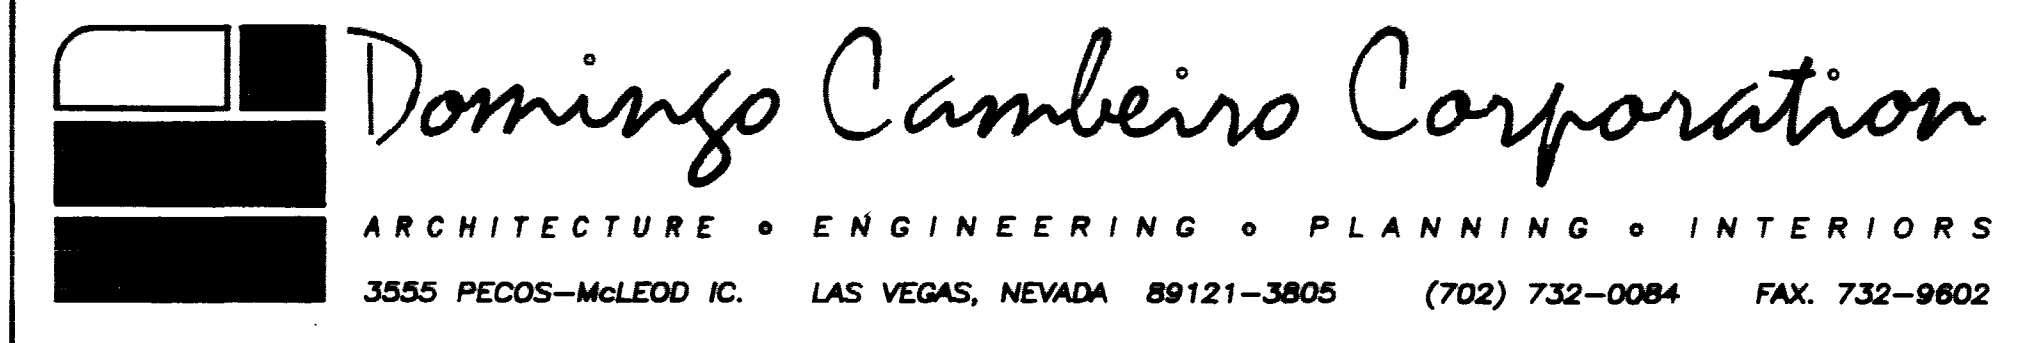

REVISIONS			
REV	DESCRIPTION	DATE	BY

PROJECT
CITY OF LAS VEGAS
1996 DETENTION FACILITY EXPANSION
3100 EAST STEWART AVENUE
LAS VEGAS, NEVADA

MECHANICAL DETAILS







DRAWING NO.
M3.02
DATE
5/13/96
JOB NO. 98021
FILE NO.
513-55cb Sheet 50 of 92

MS.02

51396

90760

257 10 2047

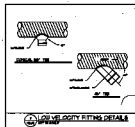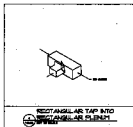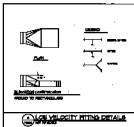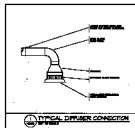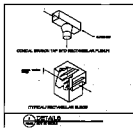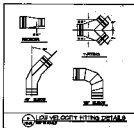

AS BUILT DRAWING
DATE 12/13/03

NO.	REV.	DATE	BY	CHKD.



Domingos Combios Corporation
 MANUFACTURING • ENGINEERING • PLANNING • DISTRIBUTION
 10000 W. 10th St., Suite 1000, Denver, CO 80202

NO.	REV.	DATE	BY	CHKD.

SCALE: AS SHOWN
 THIS DRAWING IS THE PROPERTY OF DOMINGOS COMBIOS CORPORATION
 AND IS NOT TO BE REPRODUCED OR TRANSMITTED IN ANY FORM OR BY ANY MEANS
 WITHOUT THE WRITTEN PERMISSION OF DOMINGOS COMBIOS CORPORATION

PROJECT NO.	MS.02
DATE	12/13/03
SCALE	AS SHOWN
BY	
CHKD.	