



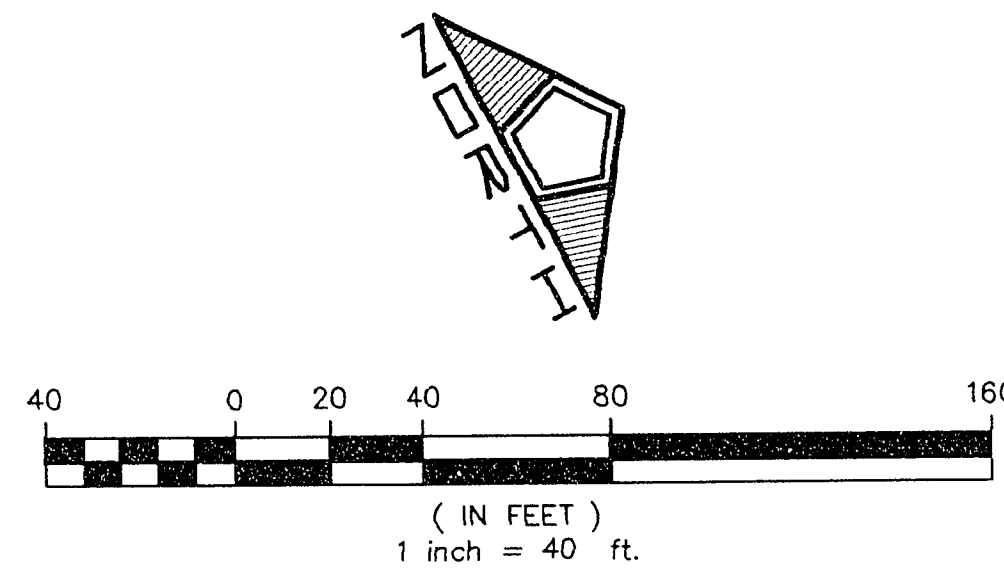

CAUTION
4TH STREET CONTAINS FIBER OPTIC
TELEPHONE AND TELEVISION CABLES.

Avoid cutting underground
utility lines. It's costly.
**Call
before you
Dig.**
1-800-227-2600
UNDERGROUND SERVICE ALERT (USA)

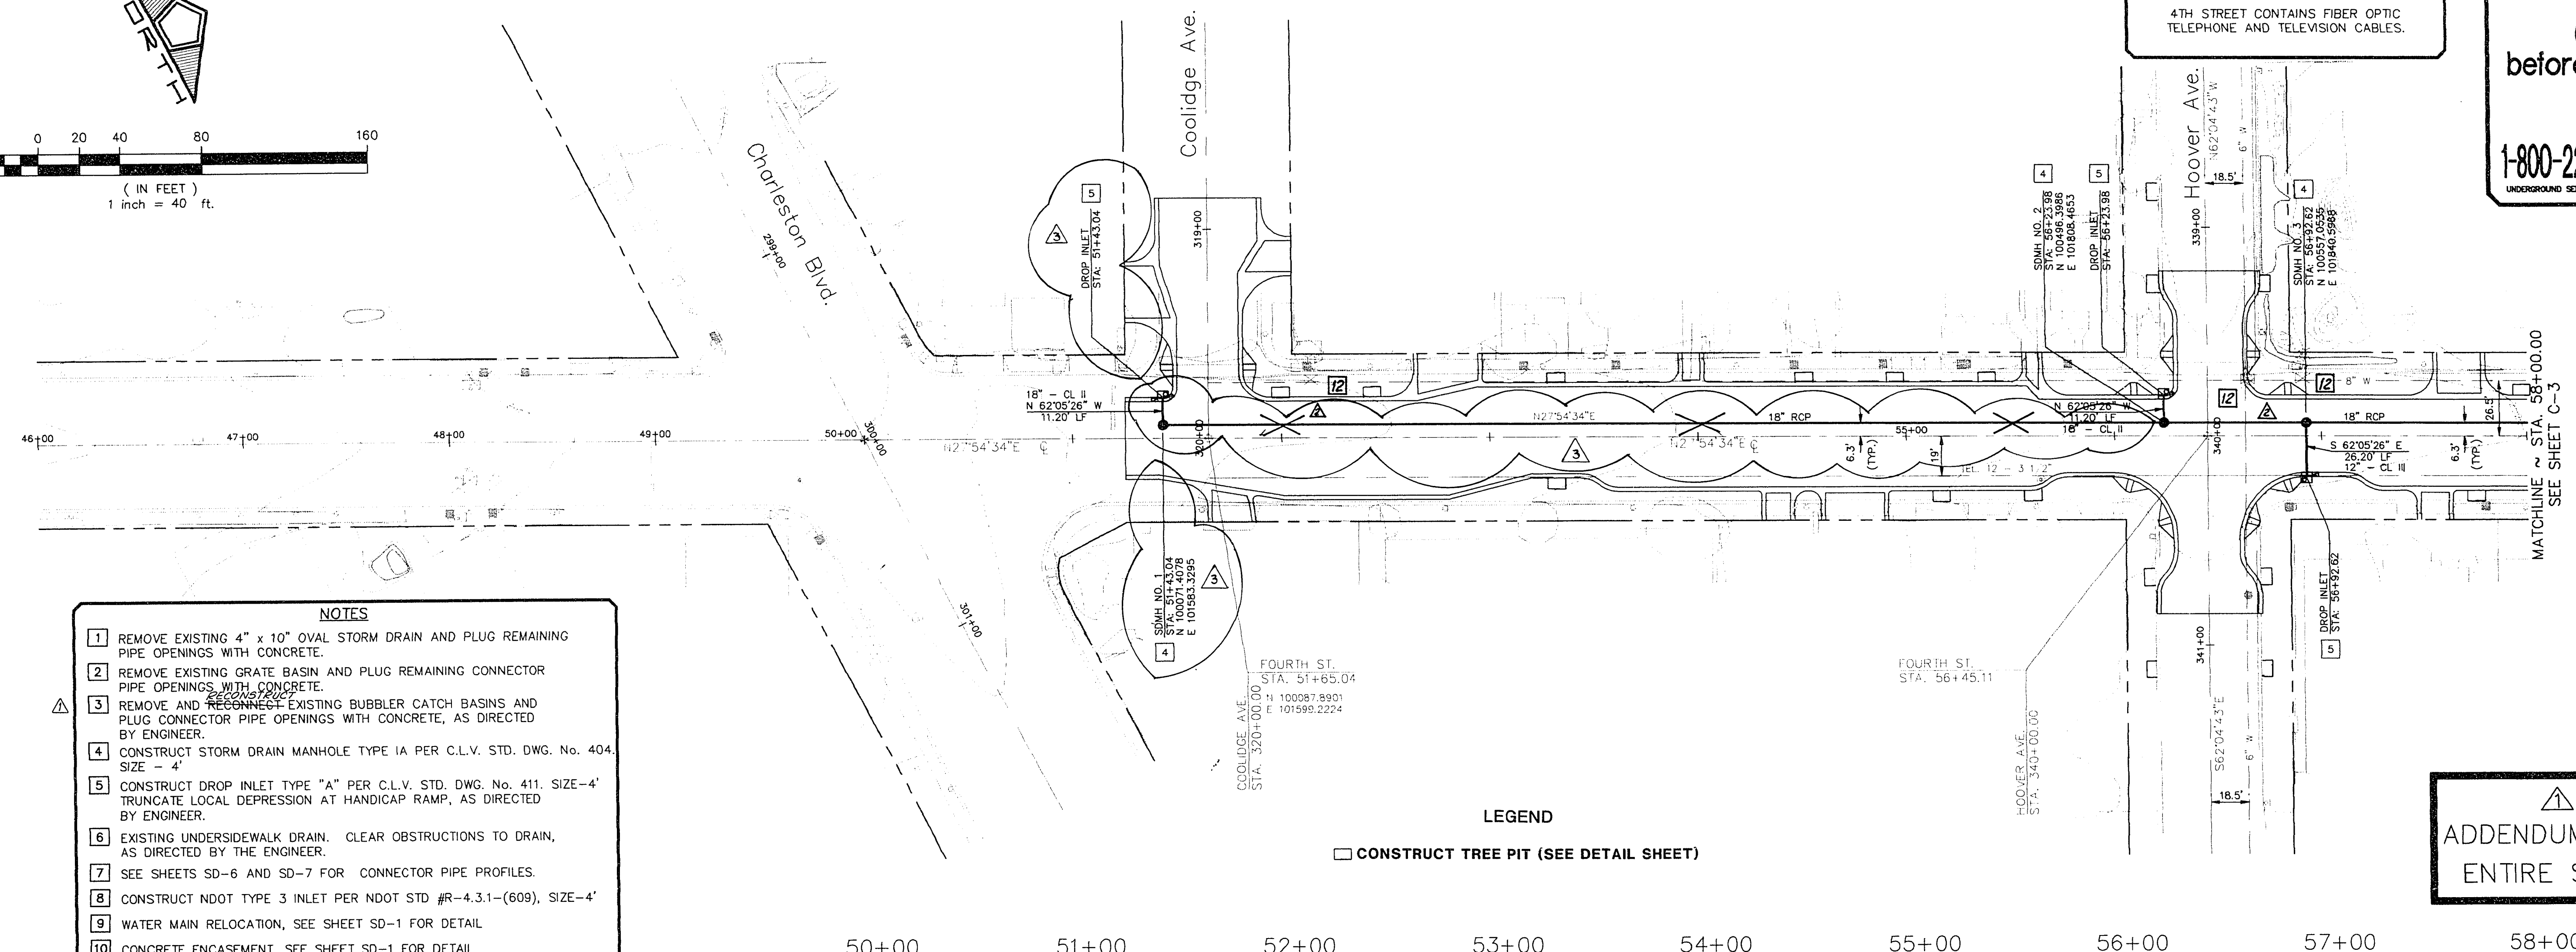


- NOTES**
- 1 REMOVE EXISTING 4" x 10" OVAL STORM DRAIN AND PLUG REMAINING PIPE OPENINGS WITH CONCRETE.
 - 2 REMOVE EXISTING GRATE BASIN AND PLUG REMAINING CONNECTOR PIPE OPENINGS WITH CONCRETE.
 - 3 REMOVE AND RECONNECT EXISTING BUBBLER CATCH BASINS AND PLUG CONNECTOR PIPE OPENINGS WITH CONCRETE, AS DIRECTED BY ENGINEER.
 - 4 CONSTRUCT STORM DRAIN MANHOLE TYPE 1A PER C.L.V. STD. DWG. NO. 404. SIZE - 4'.
 - 5 CONSTRUCT DROP INLET TYPE "A" PER C.L.V. STD. DWG. NO. 411. SIZE - 4'. TRUNCATE LOCAL DEPRESSION AT HANDICAP RAMP, AS DIRECTED BY ENGINEER.
 - 6 EXISTING UNDERSIDEWALK DRAIN. CLEAR OBSTRUCTIONS TO DRAIN, AS DIRECTED BY THE ENGINEER.
 - 7 SEE SHEETS SD-6 AND SD-7 FOR CONNECTOR PIPE PROFILES.
 - 8 CONSTRUCT NDOT TYPE 3 INLET PER NDOT STD #R-4.3.1-(609), SIZE - 4'.
 - 9 WATER MAIN RELOCATION, SEE SHEET SD-1 FOR DETAIL.
 - 10 CONCRETE ENCASUREMENT, SEE SHEET SD-1 FOR DETAIL.
 - 11 REMOVE EXISTING CONCRETE OR BRICKWORK SEAL; CONNECT 18" STORM DRAIN TO EXISTING 18" STUB.

LEGEND
□ CONSTRUCT TREE PIT (SEE DETAIL SHEET)

ADDENDUM NO. 1
ENTIRE SHEET


ADJUST TO GRADE PER L.V.V.W.D. STD. PLATE #8

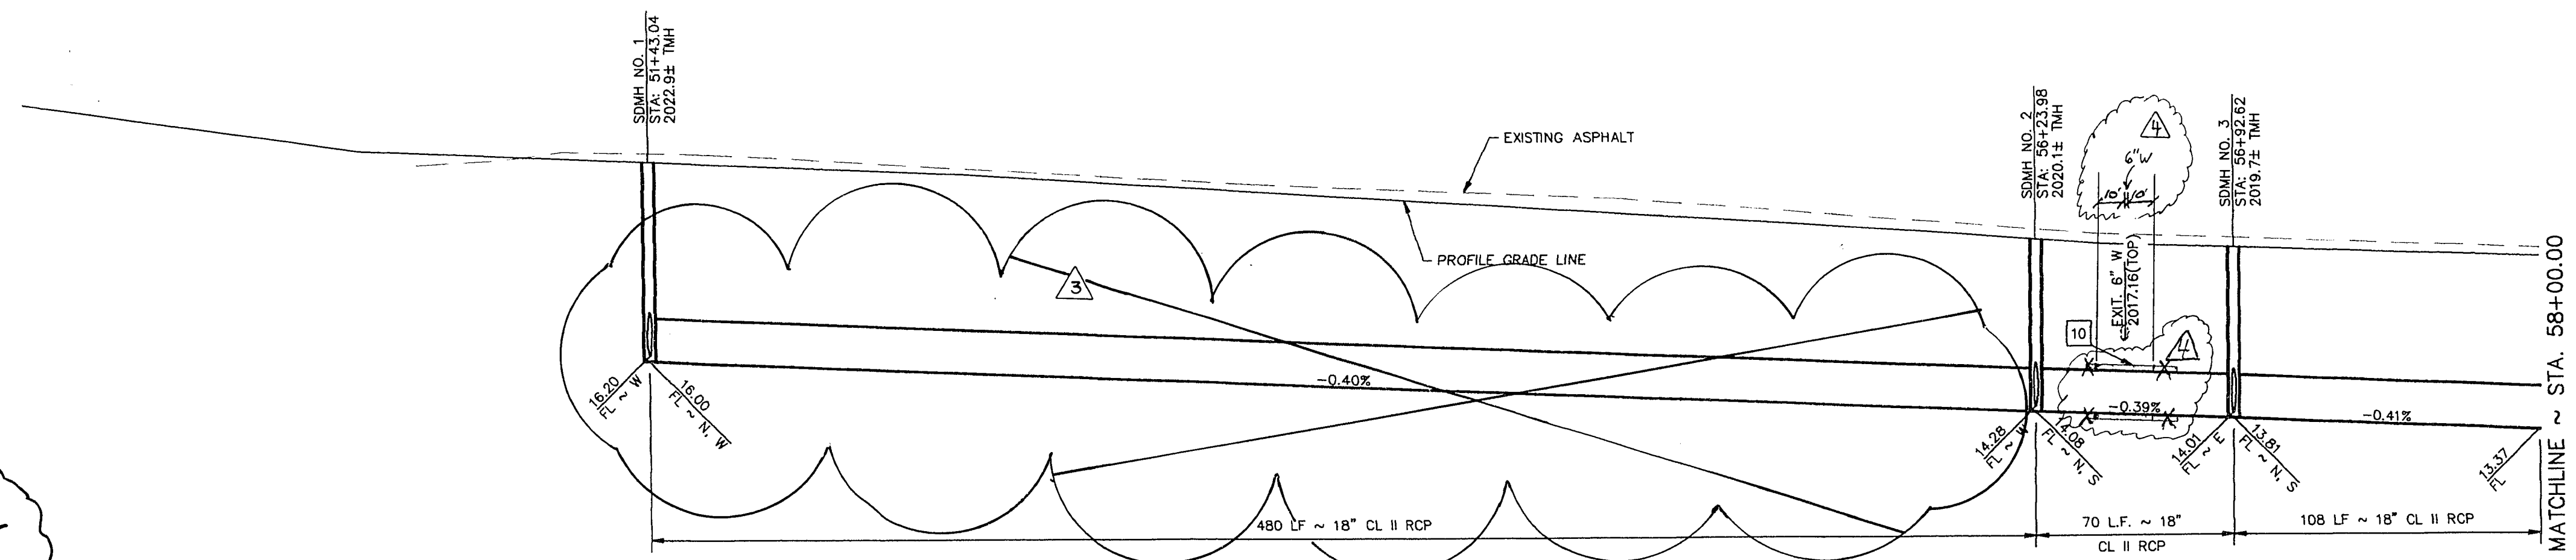

for
[Signature]
11-16-95


△ CLEARIFICATION, CONCRETE ENCASUREMENT TO EXTEND 10' EITHER SIDE OF WATER LINE WALL. 4-20-95

NO.	REVISIONS	DATE	BY
1	REVISION NO.1 ISSUED AS ADDENDUM NO.1, ENTIRE SHEET. MODIFICATIONS MADE TO NOTES, CONCRETE ENCASUREMENT ADDED TO PROFILE, CL II RCP ADDED TO PROFILE, 0.2' DROP IN INVERTS OF CONNECTOR PIPE.	12-10-94	DBB
2	PER L.V.V.W.D. REVIEW	1-13-95	LAB
3	REVISION NO.3, ISSUED AS CCO, REMOVE PIPE BETWEEN STA 56+23.98 TO STA 51+43.04, C.B. & M.H. @ STA 51+43.04.	1-31-95	DBB

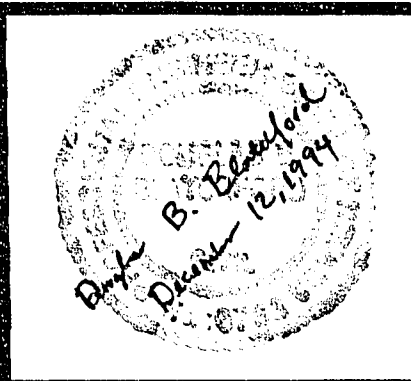

PENTACORE
Engineering, Inc.
6763 West Charleston Boulevard
Las Vegas, Nevada 89102
(702) 258-0115

DESIGNED BY DBB
DRAWN BY KOZ
CHECKED BY
NOTE BOOK NO.

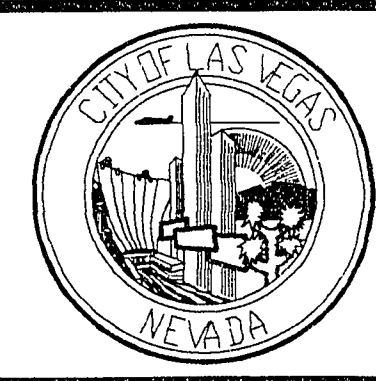

DOWNTOWN CORRIDOR IMPROVEMENTS
CITY OF LAS VEGAS DEPT. OF PUBLIC WORKS
LAS VEGAS, NEVADA

CONFORMED:
1-16-95
DATE 12/05/94
SCALE
HORIZ: 1" = 40'
VERT: 1" = 4'

STORM DRAIN
PLAN AND PROFILE
STA.55+90 TO STA.58+00

DWG. NO.
107-V-2288
FILE NO.
0135.0105
SHEET 19 of 51
SD-2

20-2-66