


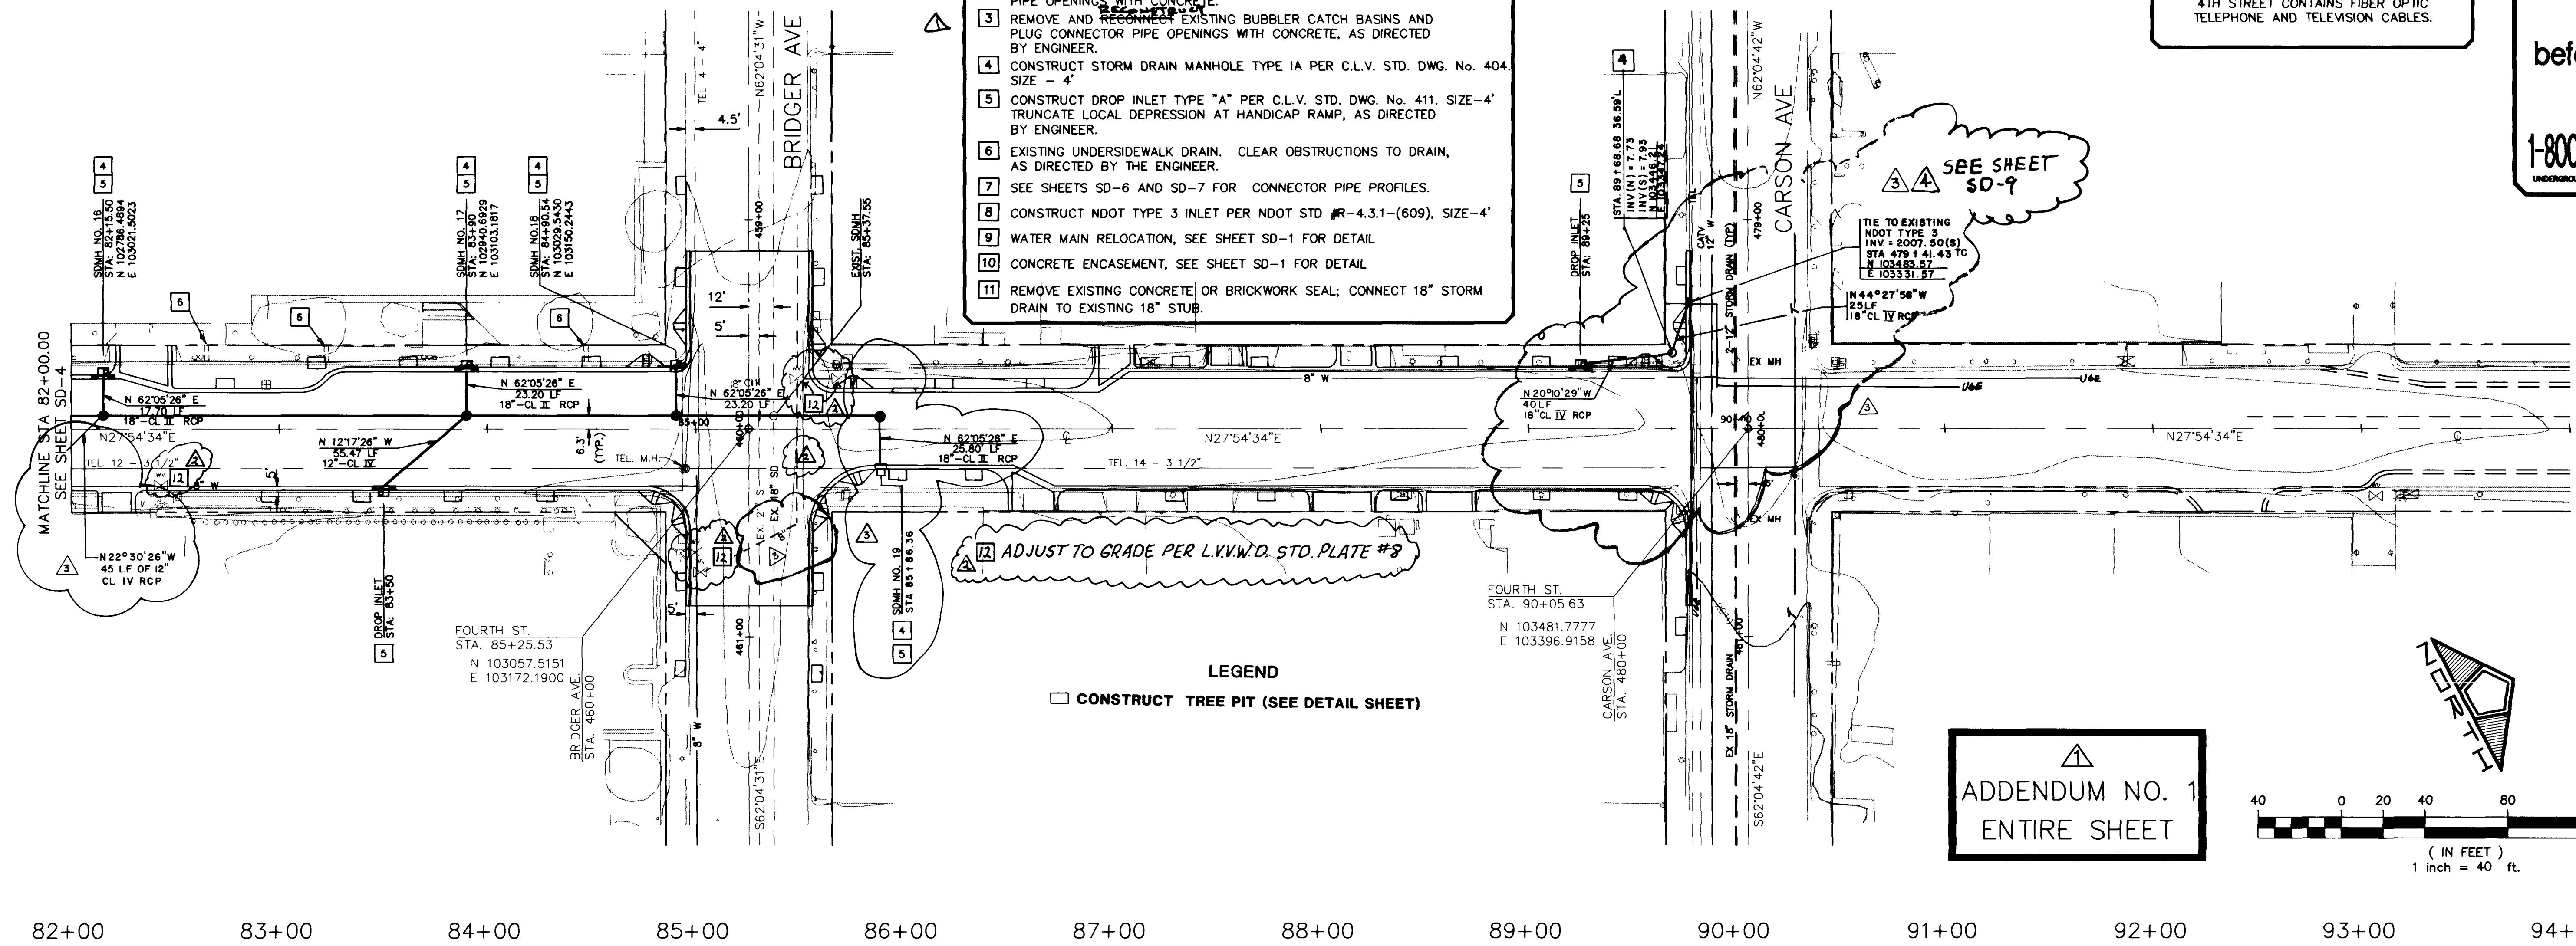


- NOTES**
- 1 REMOVE EXISTING 4" x 10" OVAL STORM DRAIN AND PLUG REMAINING PIPE OPENINGS WITH CONCRETE.
 - 2 REMOVE EXISTING GRATE BASIN AND PLUG REMAINING CONNECTOR PIPE OPENINGS WITH CONCRETE.
 - 3 REMOVE AND RECONSTRUCT EXISTING BUBBLER CATCH BASINS AND PLUG CONNECTOR PIPE OPENINGS WITH CONCRETE, AS DIRECTED BY ENGINEER.
 - 4 CONSTRUCT STORM DRAIN MANHOLE TYPE 1A PER C.L.V. STD. DWG. No. 404. SIZE - 4'.
 - 5 CONSTRUCT DROP INLET TYPE "A" PER C.L.V. STD. DWG. No. 411. SIZE - 4' TRUNCATE LOCAL DEPRESSION AT HANDICAP RAMP, AS DIRECTED BY ENGINEER.
 - 6 EXISTING UNDERSIDEWALK DRAIN. CLEAR OBSTRUCTIONS TO DRAIN, AS DIRECTED BY THE ENGINEER.
 - 7 SEE SHEETS SD-6 AND SD-7 FOR CONNECTOR PIPE PROFILES.
 - 8 CONSTRUCT NDOT TYPE 3 INLET PER NDOT STD. #R-4.3.1-(609). SIZE - 4'.
 - 9 WATER MAIN RELOCATION, SEE SHEET SD-1 FOR DETAIL.
 - 10 CONCRETE ENCASUREMENT, SEE SHEET SD-1 FOR DETAIL.
 - 11 REMOVE EXISTING CONCRETE OR BRICKWORK SEAL; CONNECT 18" STORM DRAIN TO EXISTING 18" STUB.


CAUTION
4TH STREET CONTAINS FIBER OPTIC TELEPHONE AND TELEVISION CABLES.

Avoid cutting underground utility lines. It's costly.
Call before you Dig.
1-800-227-2600
UNDERGROUND SERVICE ALERT (USA)

ADDENDUM NO. 1
ENTIRE SHEET

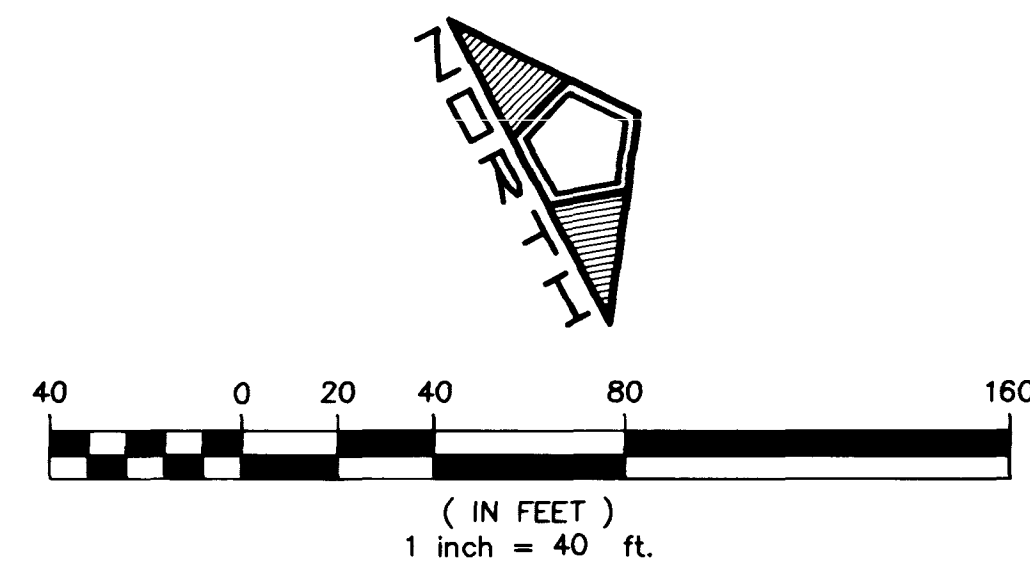

82+00 83+00 84+00 85+00 86+00 87+00 88+00 89+00 90+00 91+00 92+00 93+00 94+00


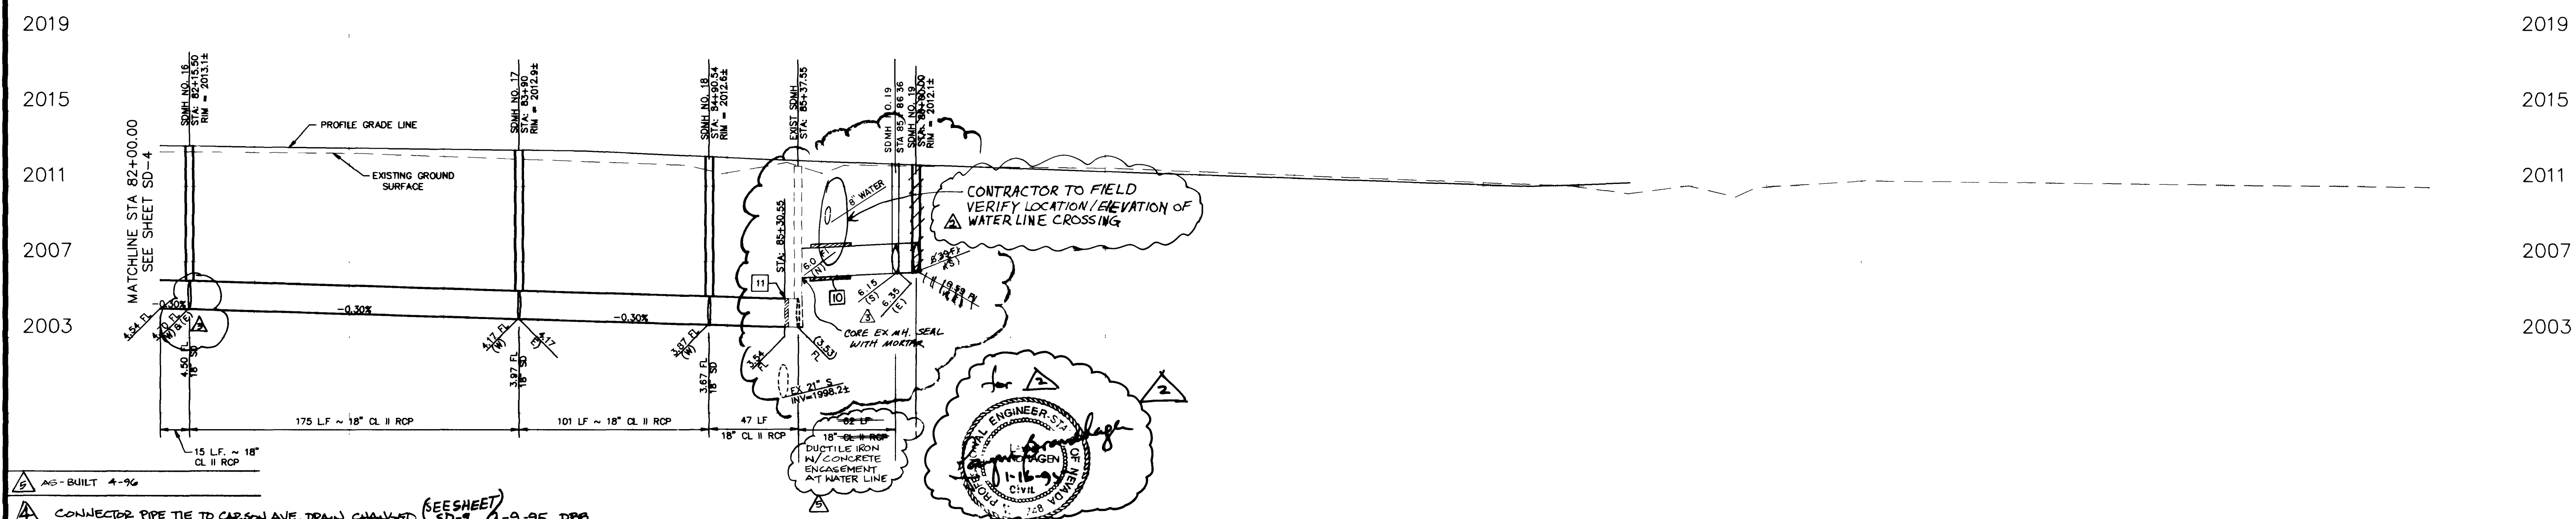


REVISION NO. 1, ISSUED AS ADDENDUM NO. 1, ENTIRE SHEET. THIS REVISION MODIFIES THE MAINLINE BETWEEN BRIDGER AND CARSON AVE, THE NOTES, MANHOLE AND CATCH BASIN LOCATIONS, 0.2' DROP IN CONNECTOR PIPE INVERTS.			12-10-94	DBB	DESIGNED BY DBB DRAWN BY KOZ CHECKED BY NOTE BOOK NO.	 DOWNTOWN CORRIDOR IMPROVEMENTS CITY OF LAS VEGAS DEPT. OF PUBLIC WORKS LAS VEGAS, NEVADA	CONFORMED: 1-16-95 DATE 10/06/94 SCALE HOR: 1" = 40' VERT: 1" = 4'	STORM DRAIN PLAN AND PROFILE STA. 82+00 TO STA. 85+37.55	DWG. NO. 107-V-2200 FILE NO. 0135.0105 SHEET 22 of 51 SD-5
PER L.V.V.W.D. REVIEW			1-13-95	DBB					
REVISION NO. 3, ISSUED AS CCO, MODIFIES PROFILE AND CARSON AVENUE, 4TH STREET INTERSECTION, ADPS CON. PIPE, STA. 82+15.50			1-31-95	DBB					
REVISIONS			DATE	BY					
NO.									

6763 West Charleston Boulevard
Las Vegas, Nevada 89102

PENTACORE
Engineering, Inc.
(702) 258-0115

20-2-71

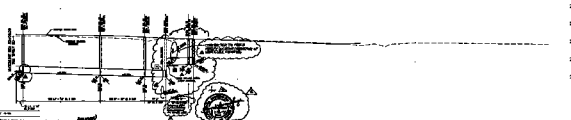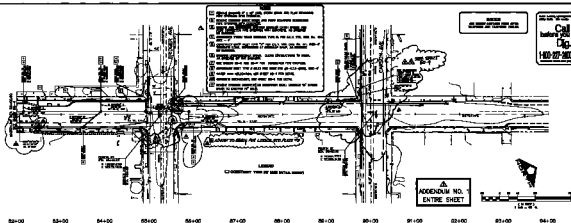

PENTACORE CIVIL ENGINEERING 1000 N. 10TH AVE., SUITE 100 LAS VEGAS, NEVADA 89101 (702) 735-1000		DESIGNED BY: LMS DRAWN BY: LMS CHECKED BY: LMS DATE: 08/10/00	CITY OF LAS VEGAS DEPT. OF PUBLIC WORKS LAS VEGAS, NEVADA	PROJECT NO.: 00-0000 SHEET NO.: 00-0000 DATE: 08/10/00	STORM DRAIN PLAN AND PROFILE STA. 82+00 TO STA. 85+37.50	PREPARED BY: LMS DATE: 08/10/00 SHEET NO.: 00-0000 DATE: 08/10/00
--	--	--	--	--	---	--