

- NOTES**
- 1 REMOVE EXISTING 4" x 10" OVAL STORM DRAIN AND PLUG REMAINING PIPE OPENINGS WITH CONCRETE.
 - 2 REMOVE EXISTING GRATE BASIN AND PLUG REMAINING CONNECTOR PIPE OPENINGS WITH CONCRETE.
 - 3 REMOVE AND RECONNECT EXISTING BUBBLER CATCH BASINS AND PLUG CONNECTOR PIPE OPENINGS WITH CONCRETE, AS DIRECTED BY ENGINEER.
 - 4 CONSTRUCT STORM DRAIN MANHOLE TYPE I PER C.L.V. STD. DWG. No. 403, SIZE - 4'.
 - 5 CONSTRUCT DROP INLET TYPE "A" PER C.L.V. STD. DWG. No. 411, SIZE-4' TRUNCATE LOCAL DEPRESSION AT HANDICAP RAMP, AS DIRECTED BY ENGINEER.
 - 6 EXISTING UNDERSIDEWALK DRAIN. CLEAR OBSTRUCTIONS TO DRAIN, AS DIRECTED BY THE ENGINEER.
 - 7 SEE SHEETS SD-6 AND SD-7 FOR CONNECTOR PIPE PROFILES.
 - 8 CONSTRUCT NDOT TYPE 3 INLET PER NDOT STD #R-4.3.1-(609), SIZE-4'.
 - 9 WATER MAIN RELOCATION, SEE SHEET SD-1 FOR DETAIL.
 - 10 CONCRETE ENCASUREMENT, SEE SHEET SD-1 FOR DETAIL.
 - 11 REMOVE EXISTING CONCRETE OR BRICKWORK SEAL; CONNECT 18" STORM DRAIN TO EXISTING 18" STUB.

CAUTION!

IT SHALL BE THE CONTRACTOR'S RESPONSIBILITY TO LOCATE ALL UTILITY INTERFERENCES, THIS SHEET. THE STORM DRAIN LOCATION IS SCHEMATIC ONLY AND MAY CHANGE WITH FURTHER UTILITY INVESTIGATION. QUANTITIES, INCLUDING BUT NOT LIMITED TO 18" CLASS II RCP, RCP MANHOLES AND CATCH BASINS (TYPE "A") MAY VARY.

LEGEND

□ CONSTRUCT TREE PIT (SEE DETAIL SHEET)

△ - ENTIRE SHEET

ADDENDUM NO. 1


ENTIRE SHEET

Avoid cutting underground utility lines. It's costly.

Call before you Dig.

1-800-227-2600

UNDERGROUND SERVICE ALERT (USA)

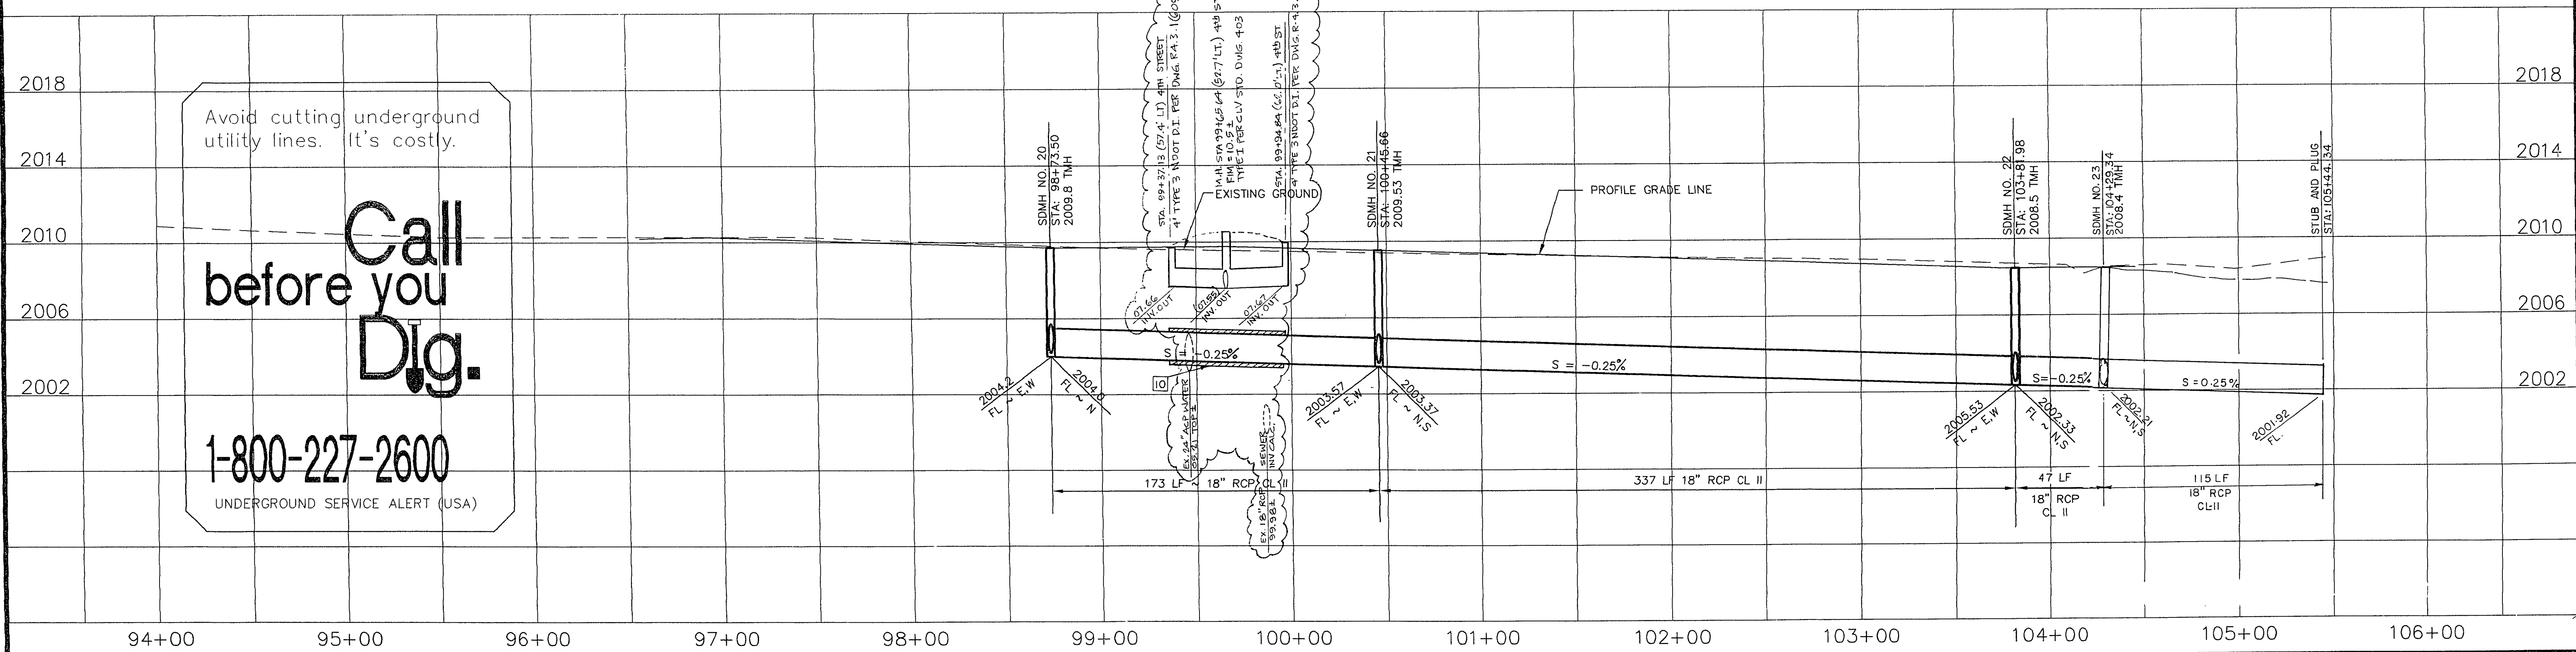

REVISIONS		NO.	DATE	BY
1 REVISION 1, ISSUED AS ADDENDUM NO. 1, ENTIRE SHEET, ADD STORM DRAIN ON PLAN AND PROFILE.		12/10/94	DBB	
2 REVISION 3, ISSUED AS CCO ENTIRE SHEET, ADD UTILITIES IN PLAN AND PROFILE, CONC. ENCASUREMENT, MODIFY STUB OUT ON STEWART, MODIFY CB'S AT STA 103+81.98 TO NDOT TYPE 3.		01/31/95	DBB	
AS-BUILT/AS FOUND IN FIELD		4-96		

PENTACORE Engineering, Inc. 6763 West Charleston Boulevard Las Vegas, Nevada 89102 (702) 258-0115		DESIGNED BY DBB	DRAWN BY KOZ	CHECKED BY	NOTE BOOK NO.
--	--	-----------------	--------------	------------	---------------

CITY OF LAS VEGAS DOWNTOWN CORRIDOR IMPROVEMENTS CITY OF LAS VEGAS DEPT. OF PUBLIC WORKS LAS VEGAS, NEVADA		CONFIRMED: 1-16-95 DATE 12/06/94	PLAN AND PROFILE STA. 94+00 TO STA. 106+00		DWG. NO. 107-V-2288 FILE NO. 9903.02 SHEET 23 of 51 SD-6
--	--	--	---	--	---