




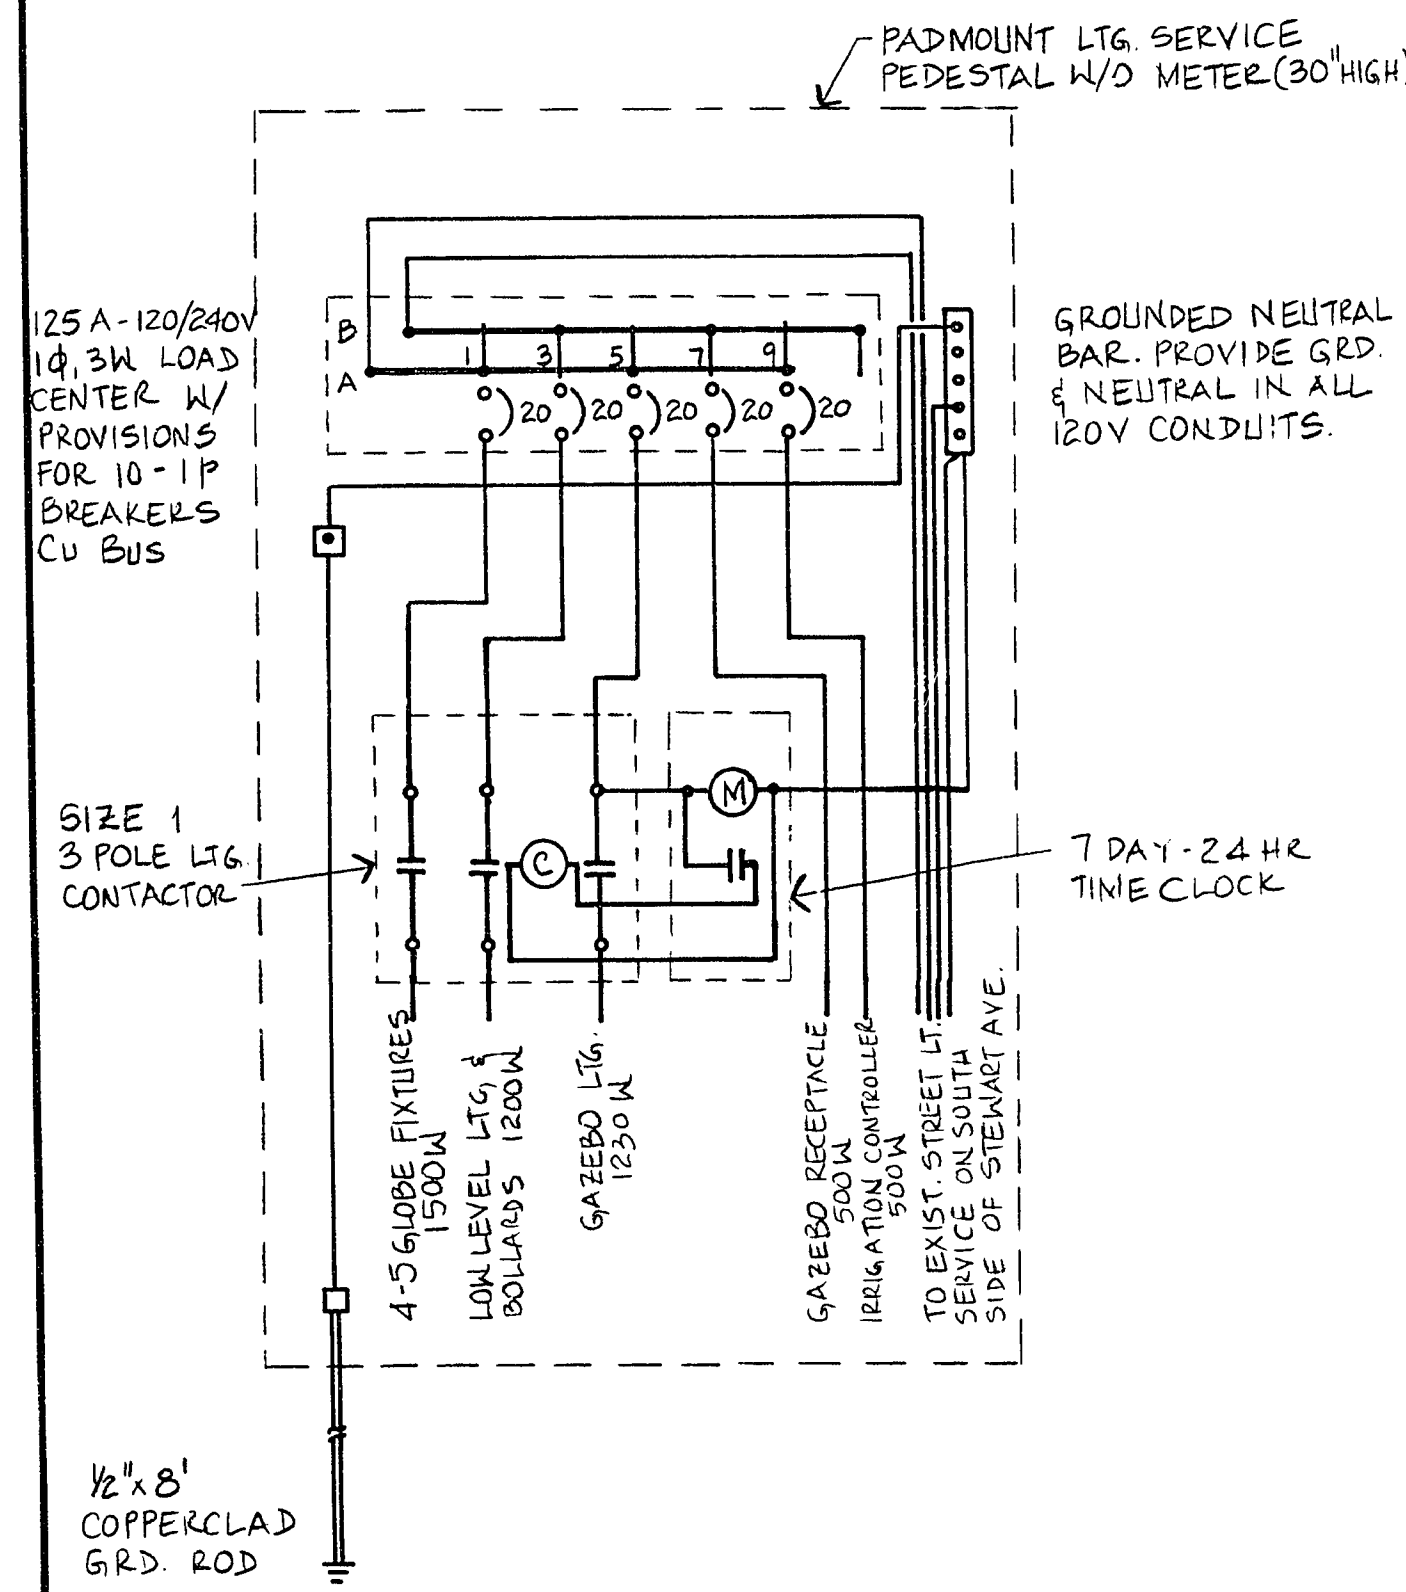


PAD MOUNTED LIGHTING SERVICE PANEL AT GAZEBO

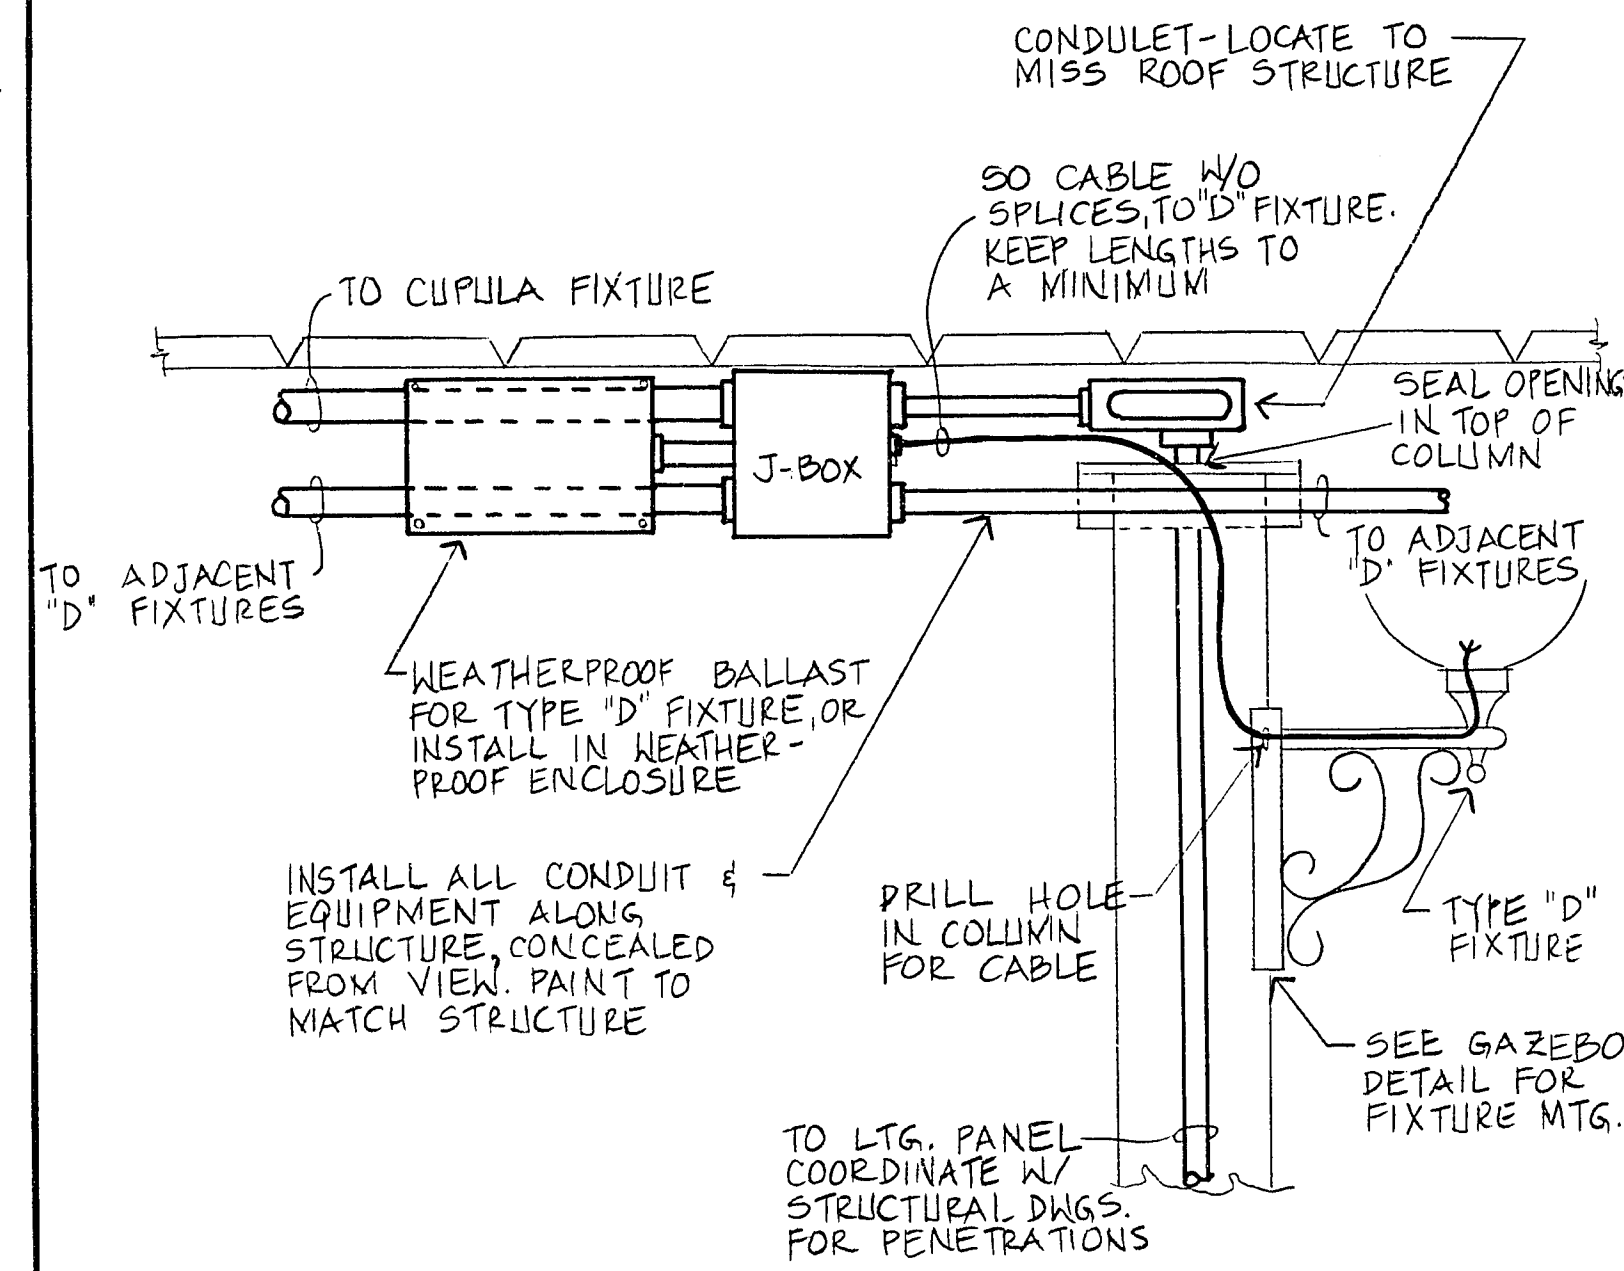


CONDUIT DETAIL - D FIXTURE & BALLAST

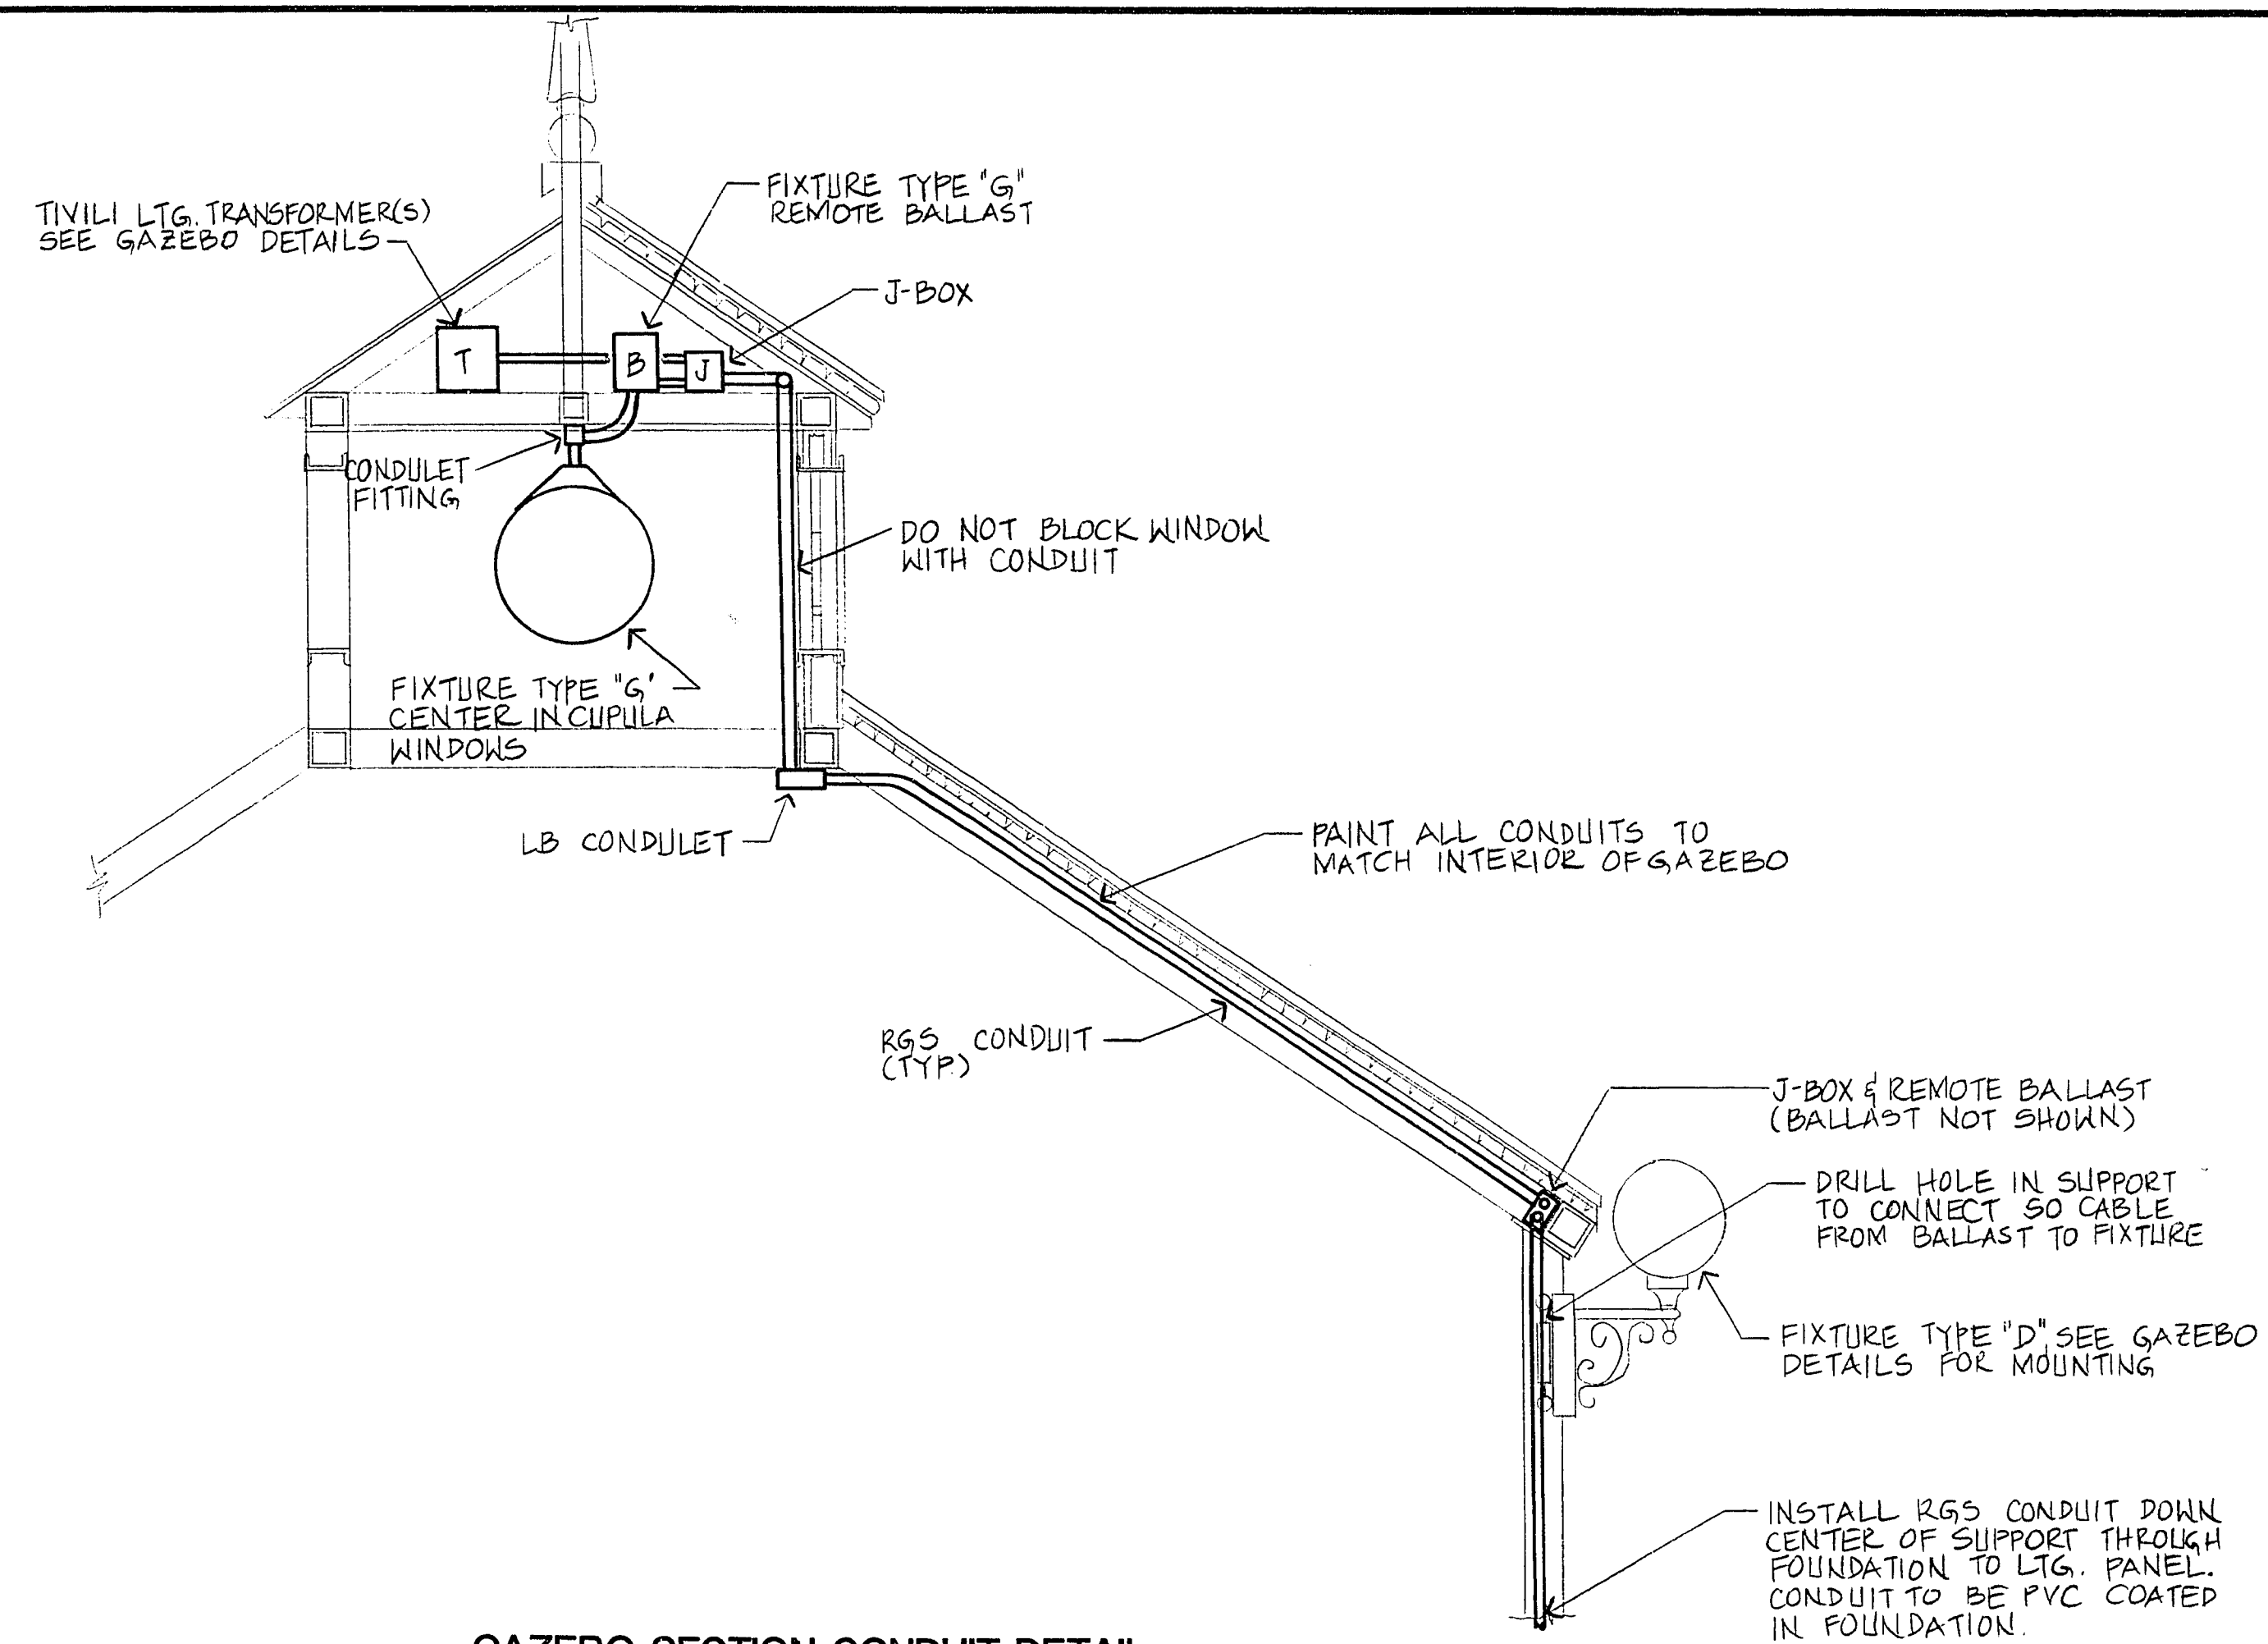


GAZEBO SECTION CONDUIT DETAIL (LOOKING WEST)

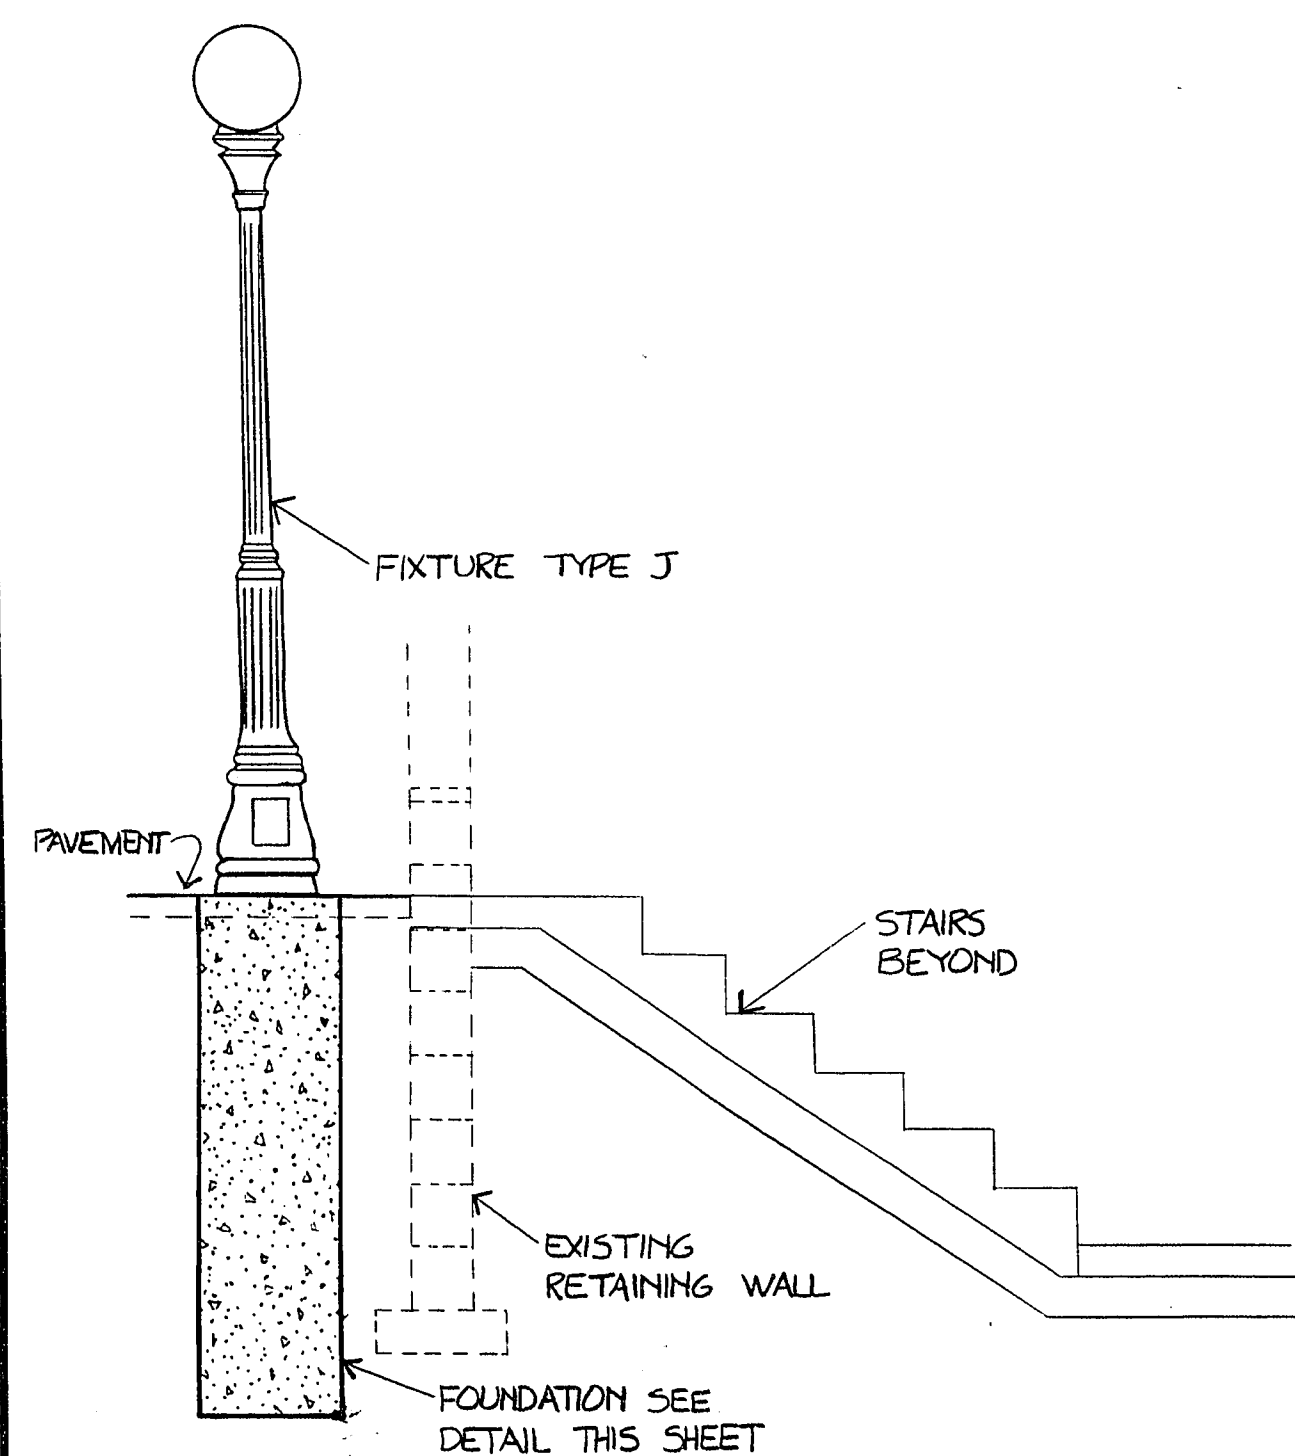

SECTION A-A
SCALE: 1/2" = 1'

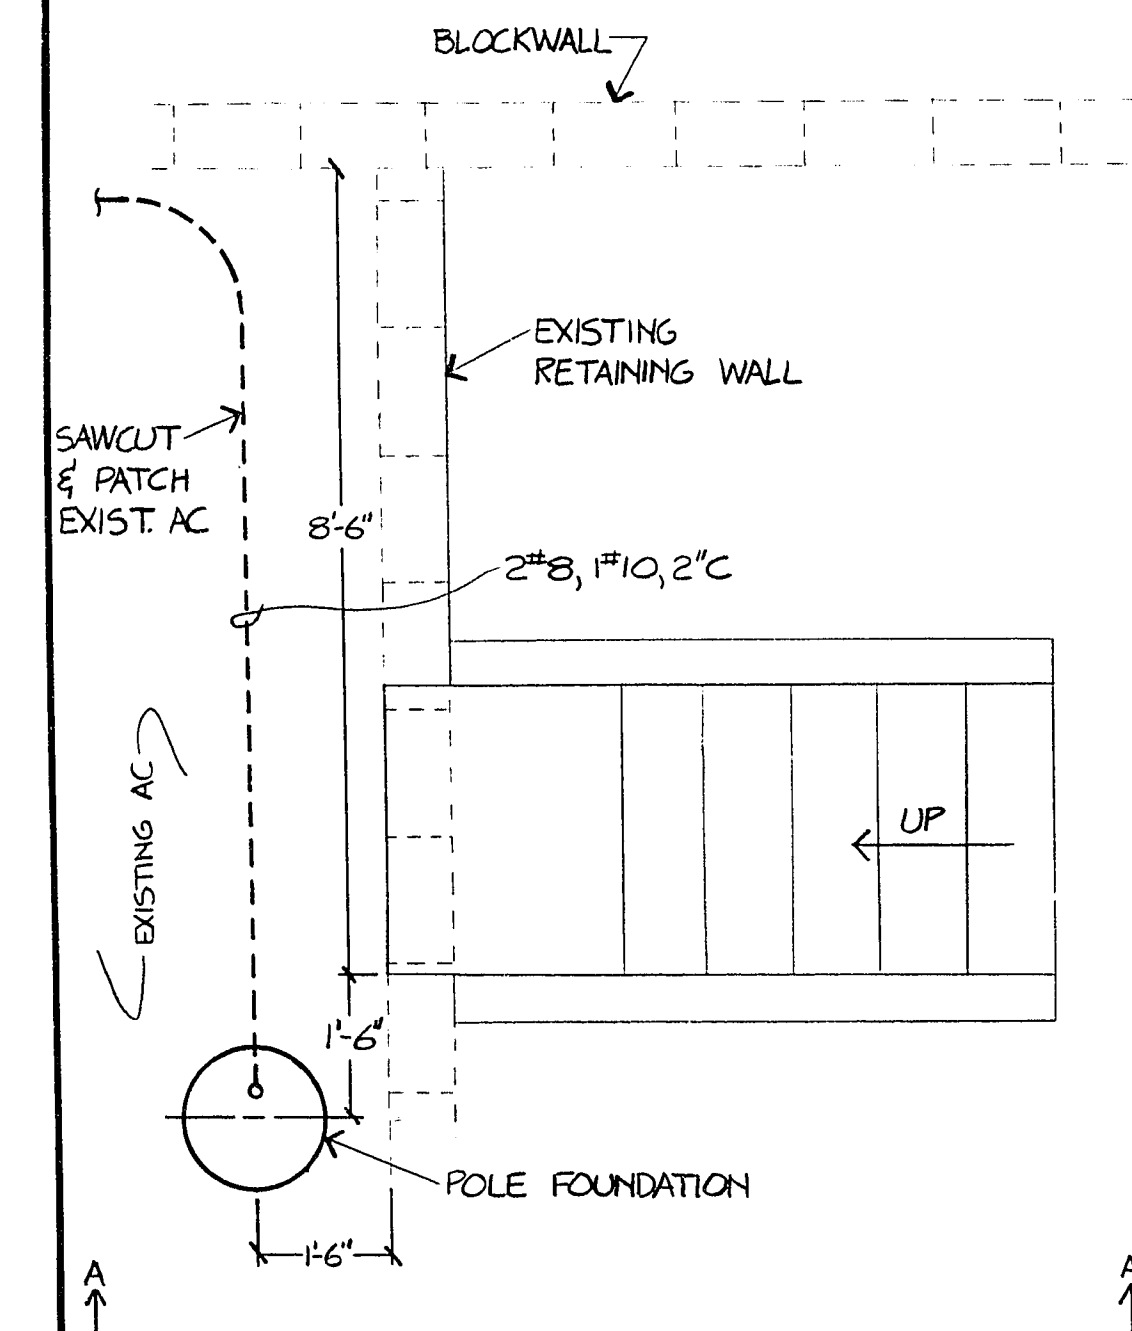

DETAIL FIXTURE TYPE J
SCALE: 1/2" = 1'

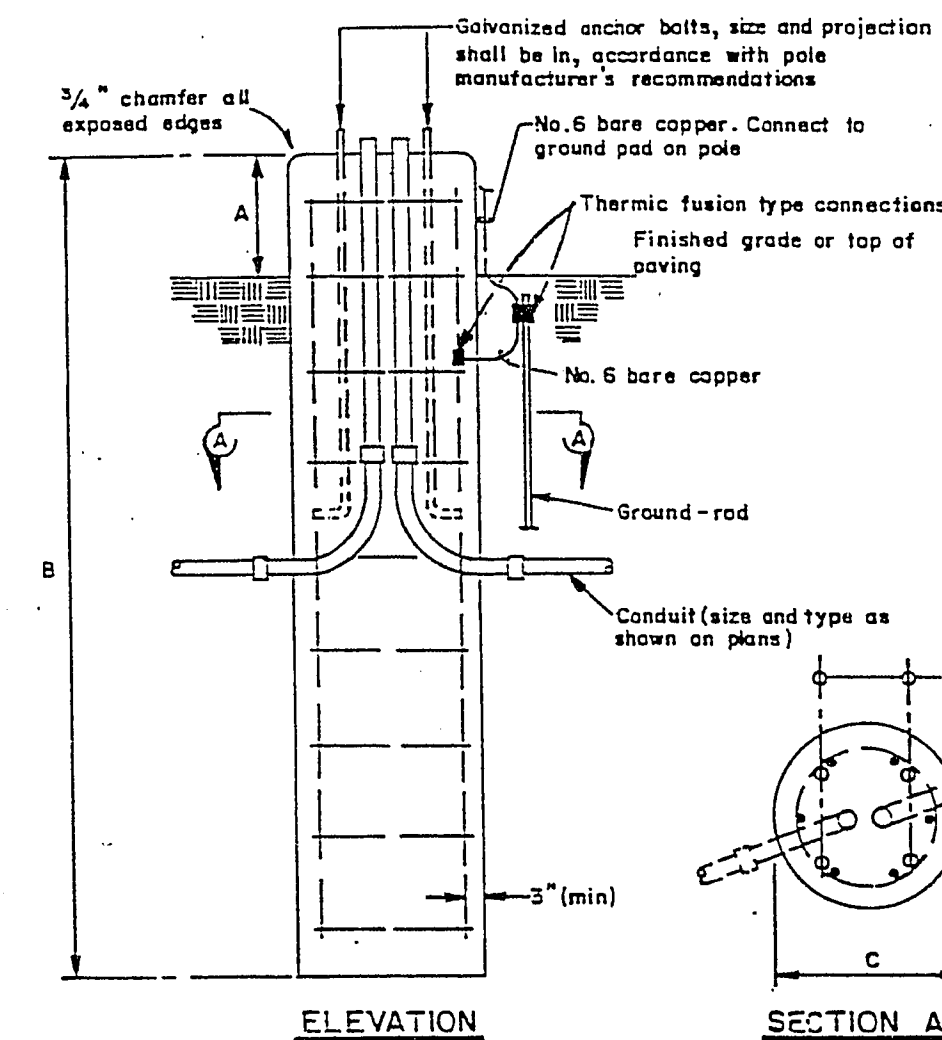


DIMENSIONS			
Location	A	B	C
Paved Area	0'-0"	5'-6"	1'-6"
All Others	0'-0"	5'-6"	1'-6"

REINFORCING BARS			
Type	No.	Size	Spacing
Vert.	6	#5	EQUAL
Ties		#3	12" O.C.

NOTES:
1. All reinforcing steel to be round, deformed steel bars, free of rust and grease.
2. Concrete to be 3000-psi, 3/4" aggregate.

FIXTURE TYPE J FOUNDATION DETAIL
NO SCALE

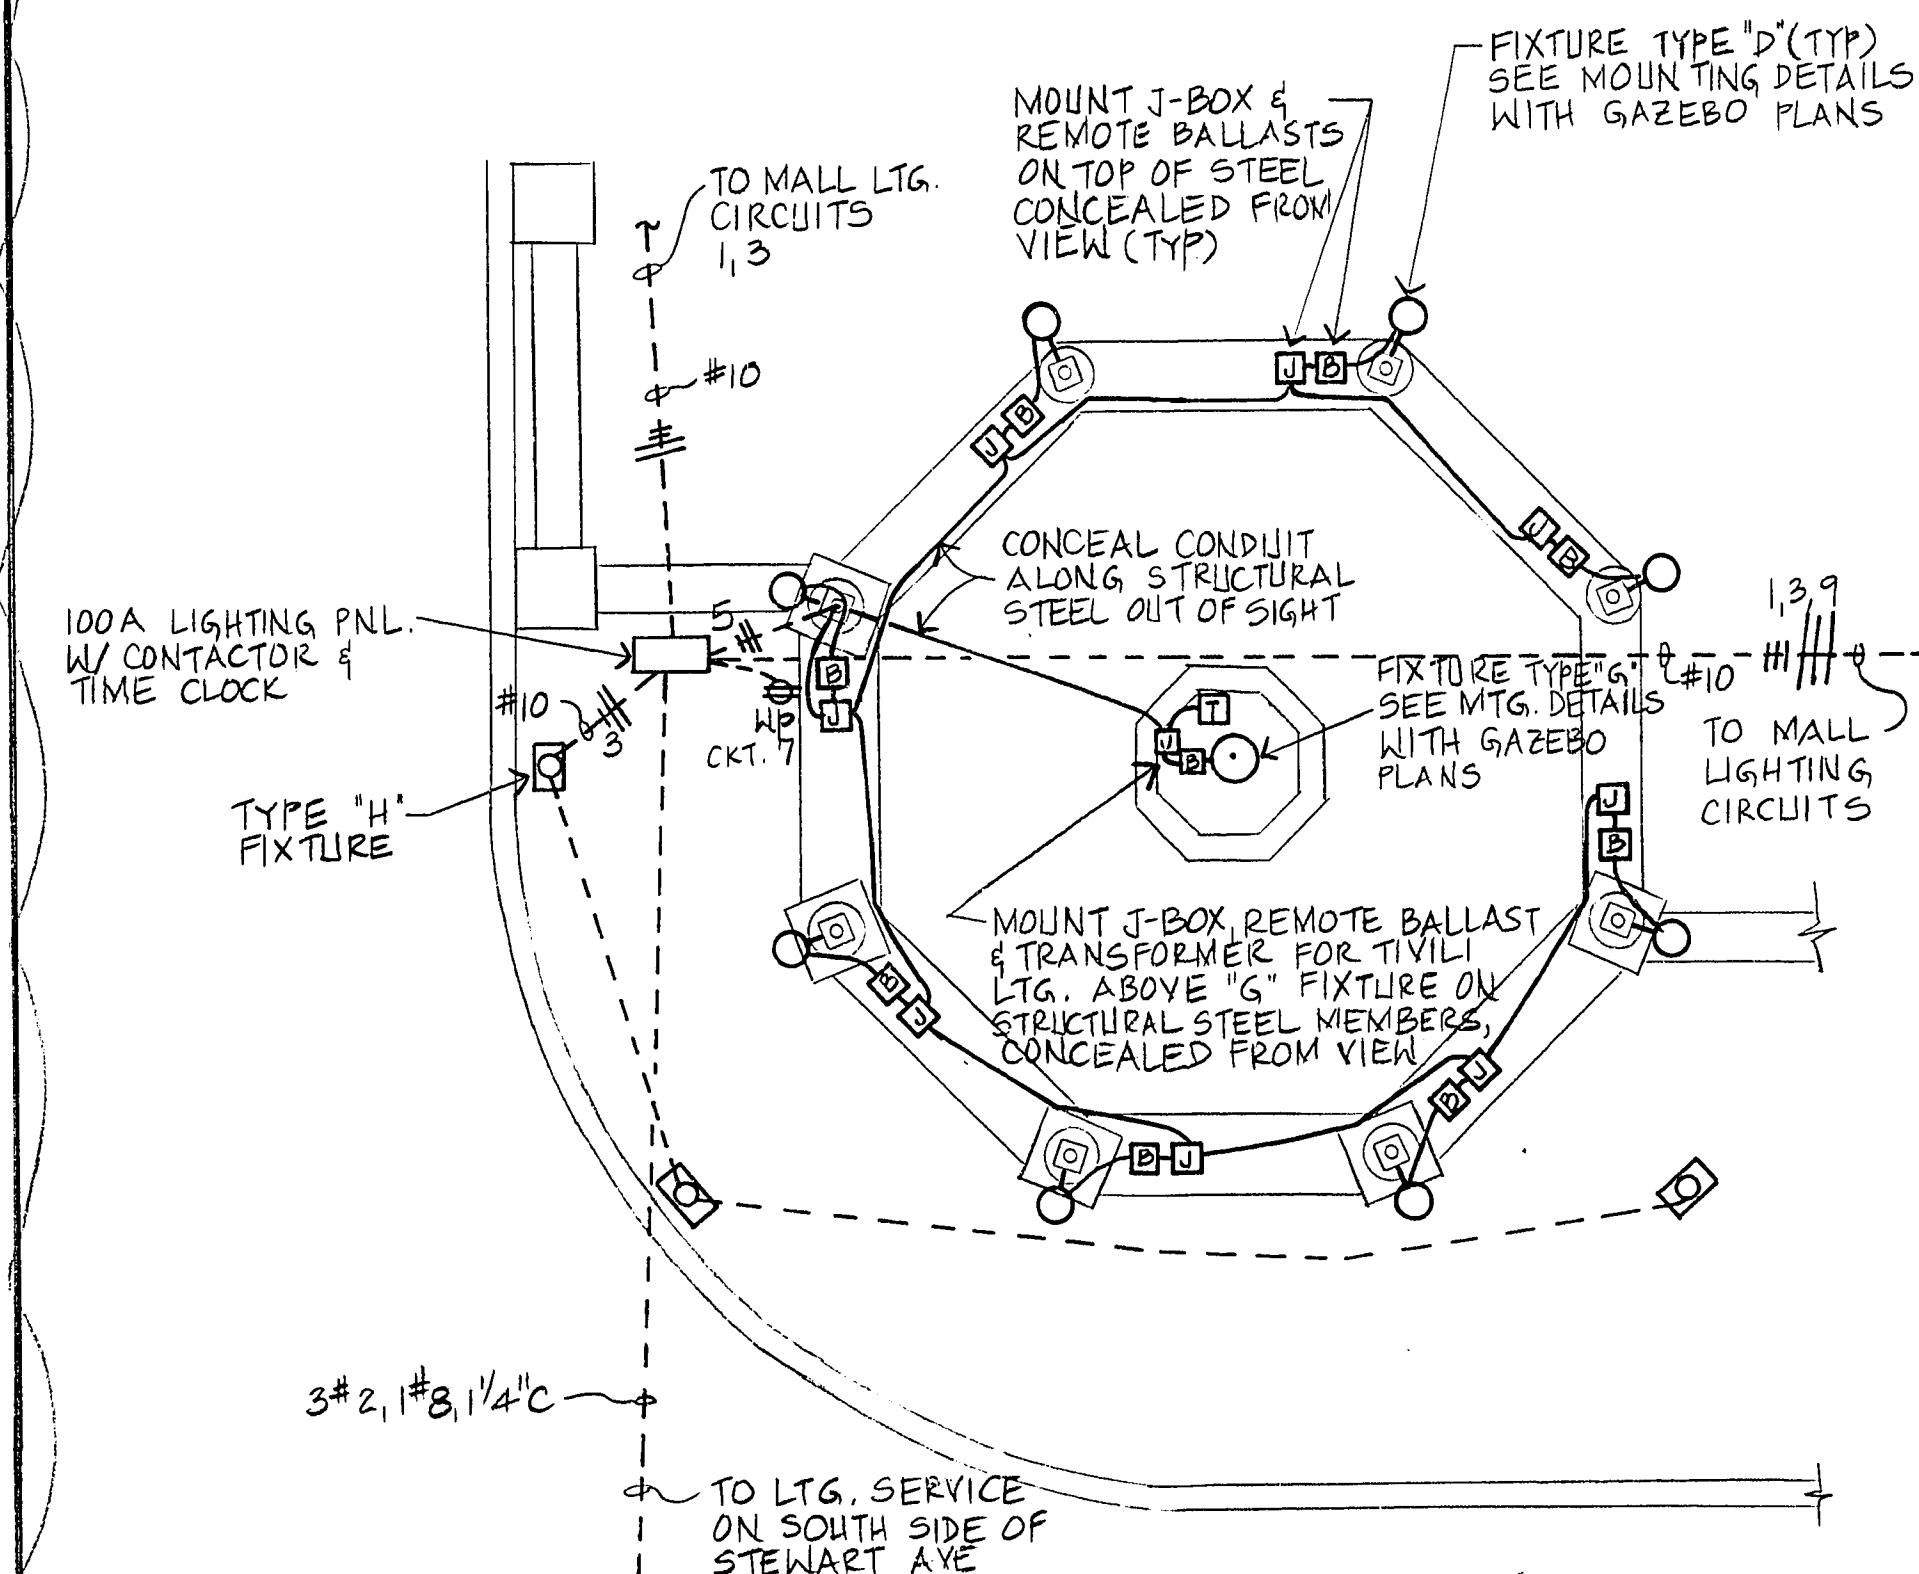

GAZEBO LIGHTING PLAN

CONTRACT
DRAWING
APRIL 25, 1986

Department of Public Works Engineering Design Division
ELECTRICAL LIGHTING DETAILS
DOWNTOWN TRANSPORTATION CENTER
OFFSITE IMPROVEMENTS



Drawing no. 590-2D 51/51

3013-103

4-20-86

Thomas J. Kue

Scale (h)
Fid. bk. no.
Design by

Scale (v)
Date

W.A.
Drawn by

Revisions
7-22-86
Date