
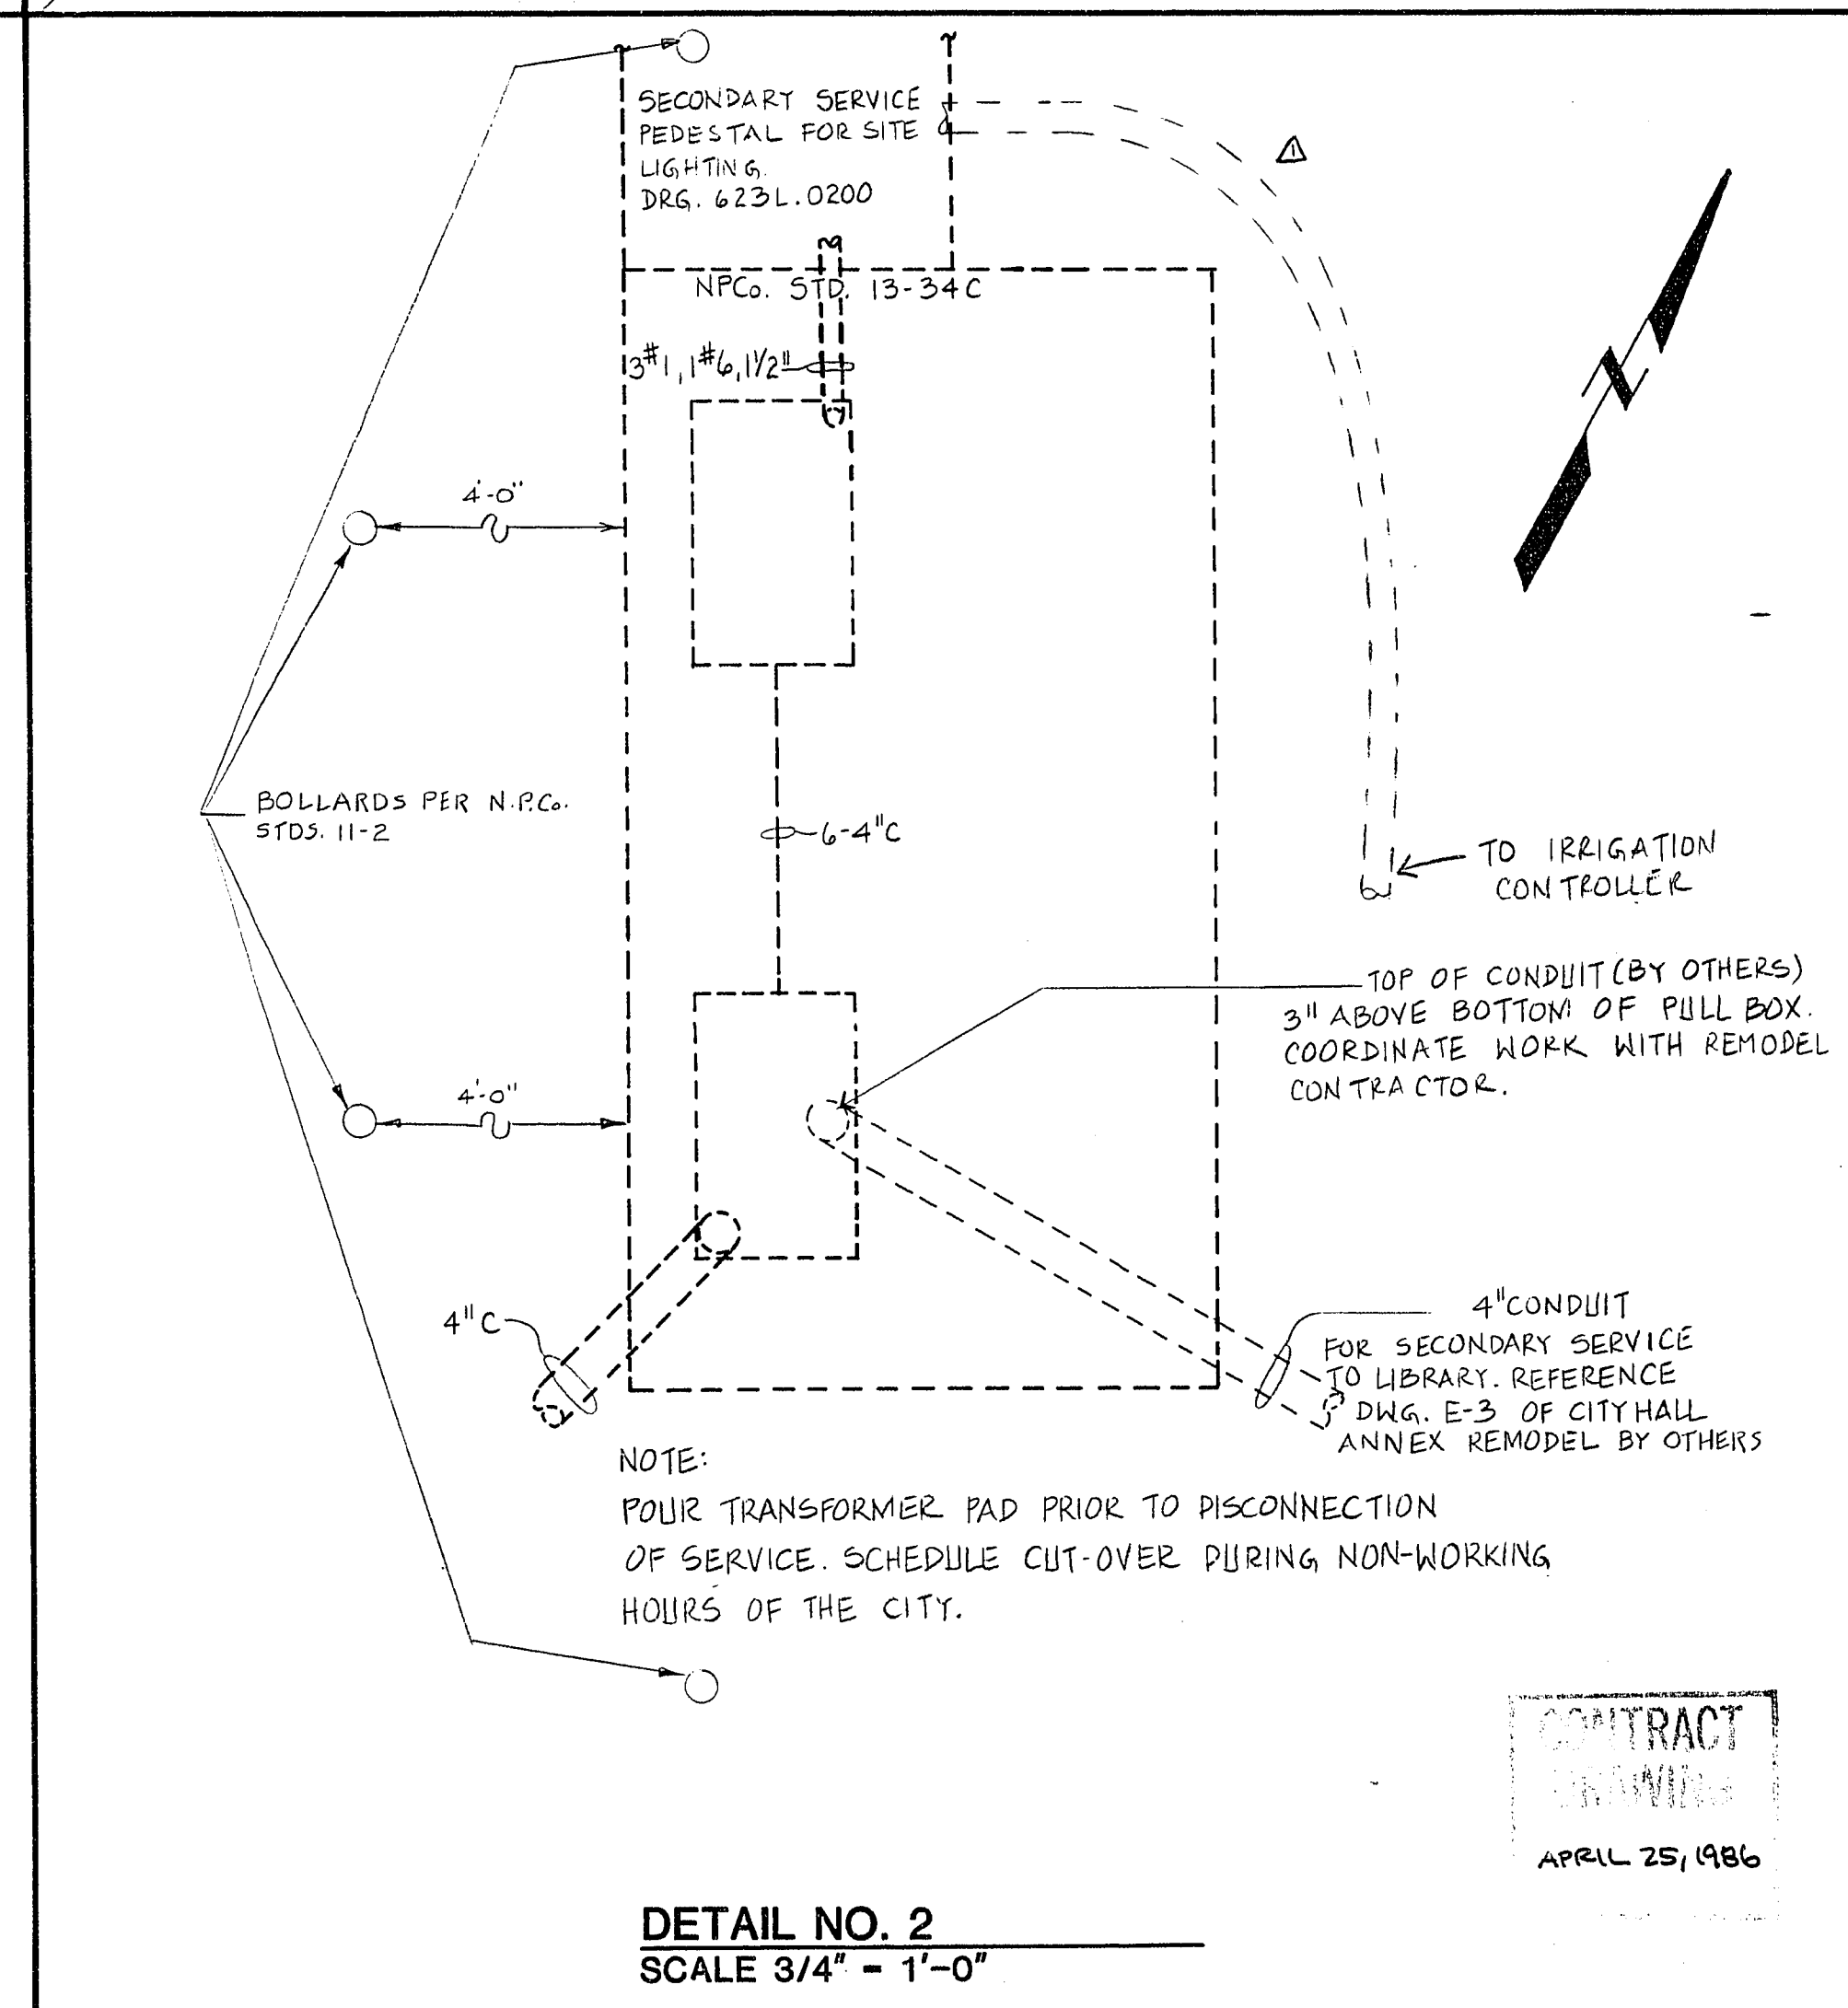
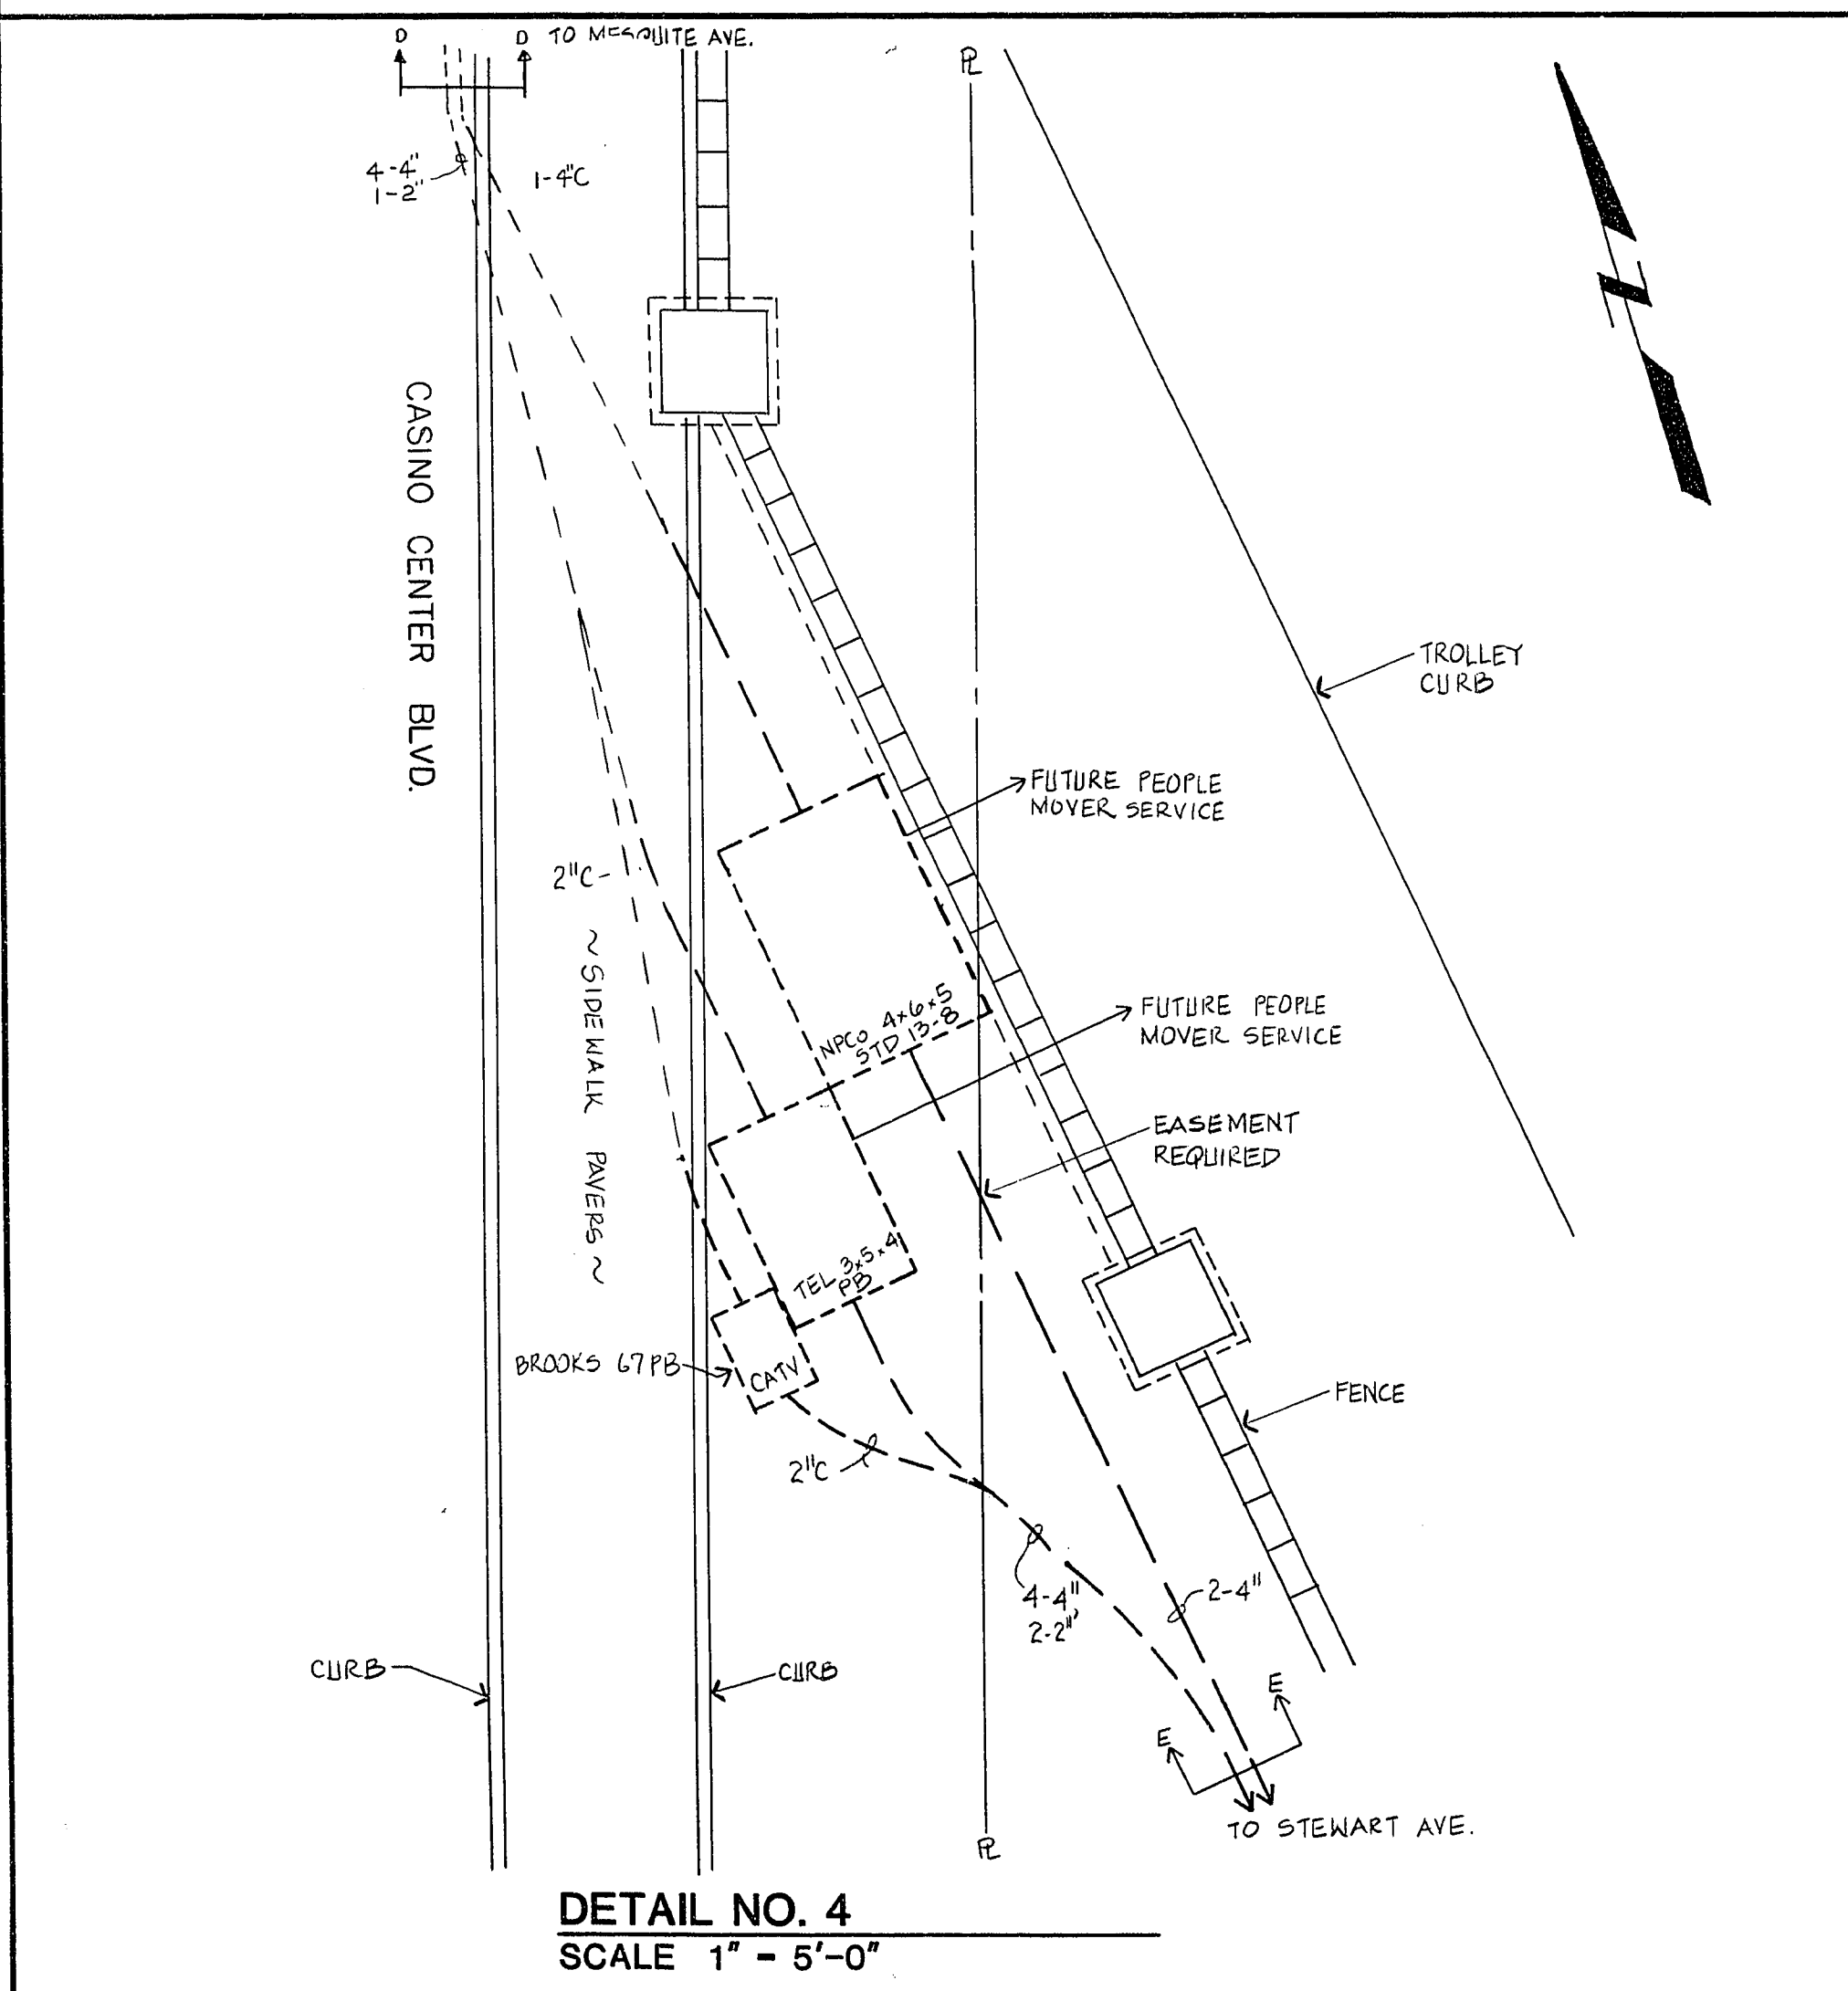
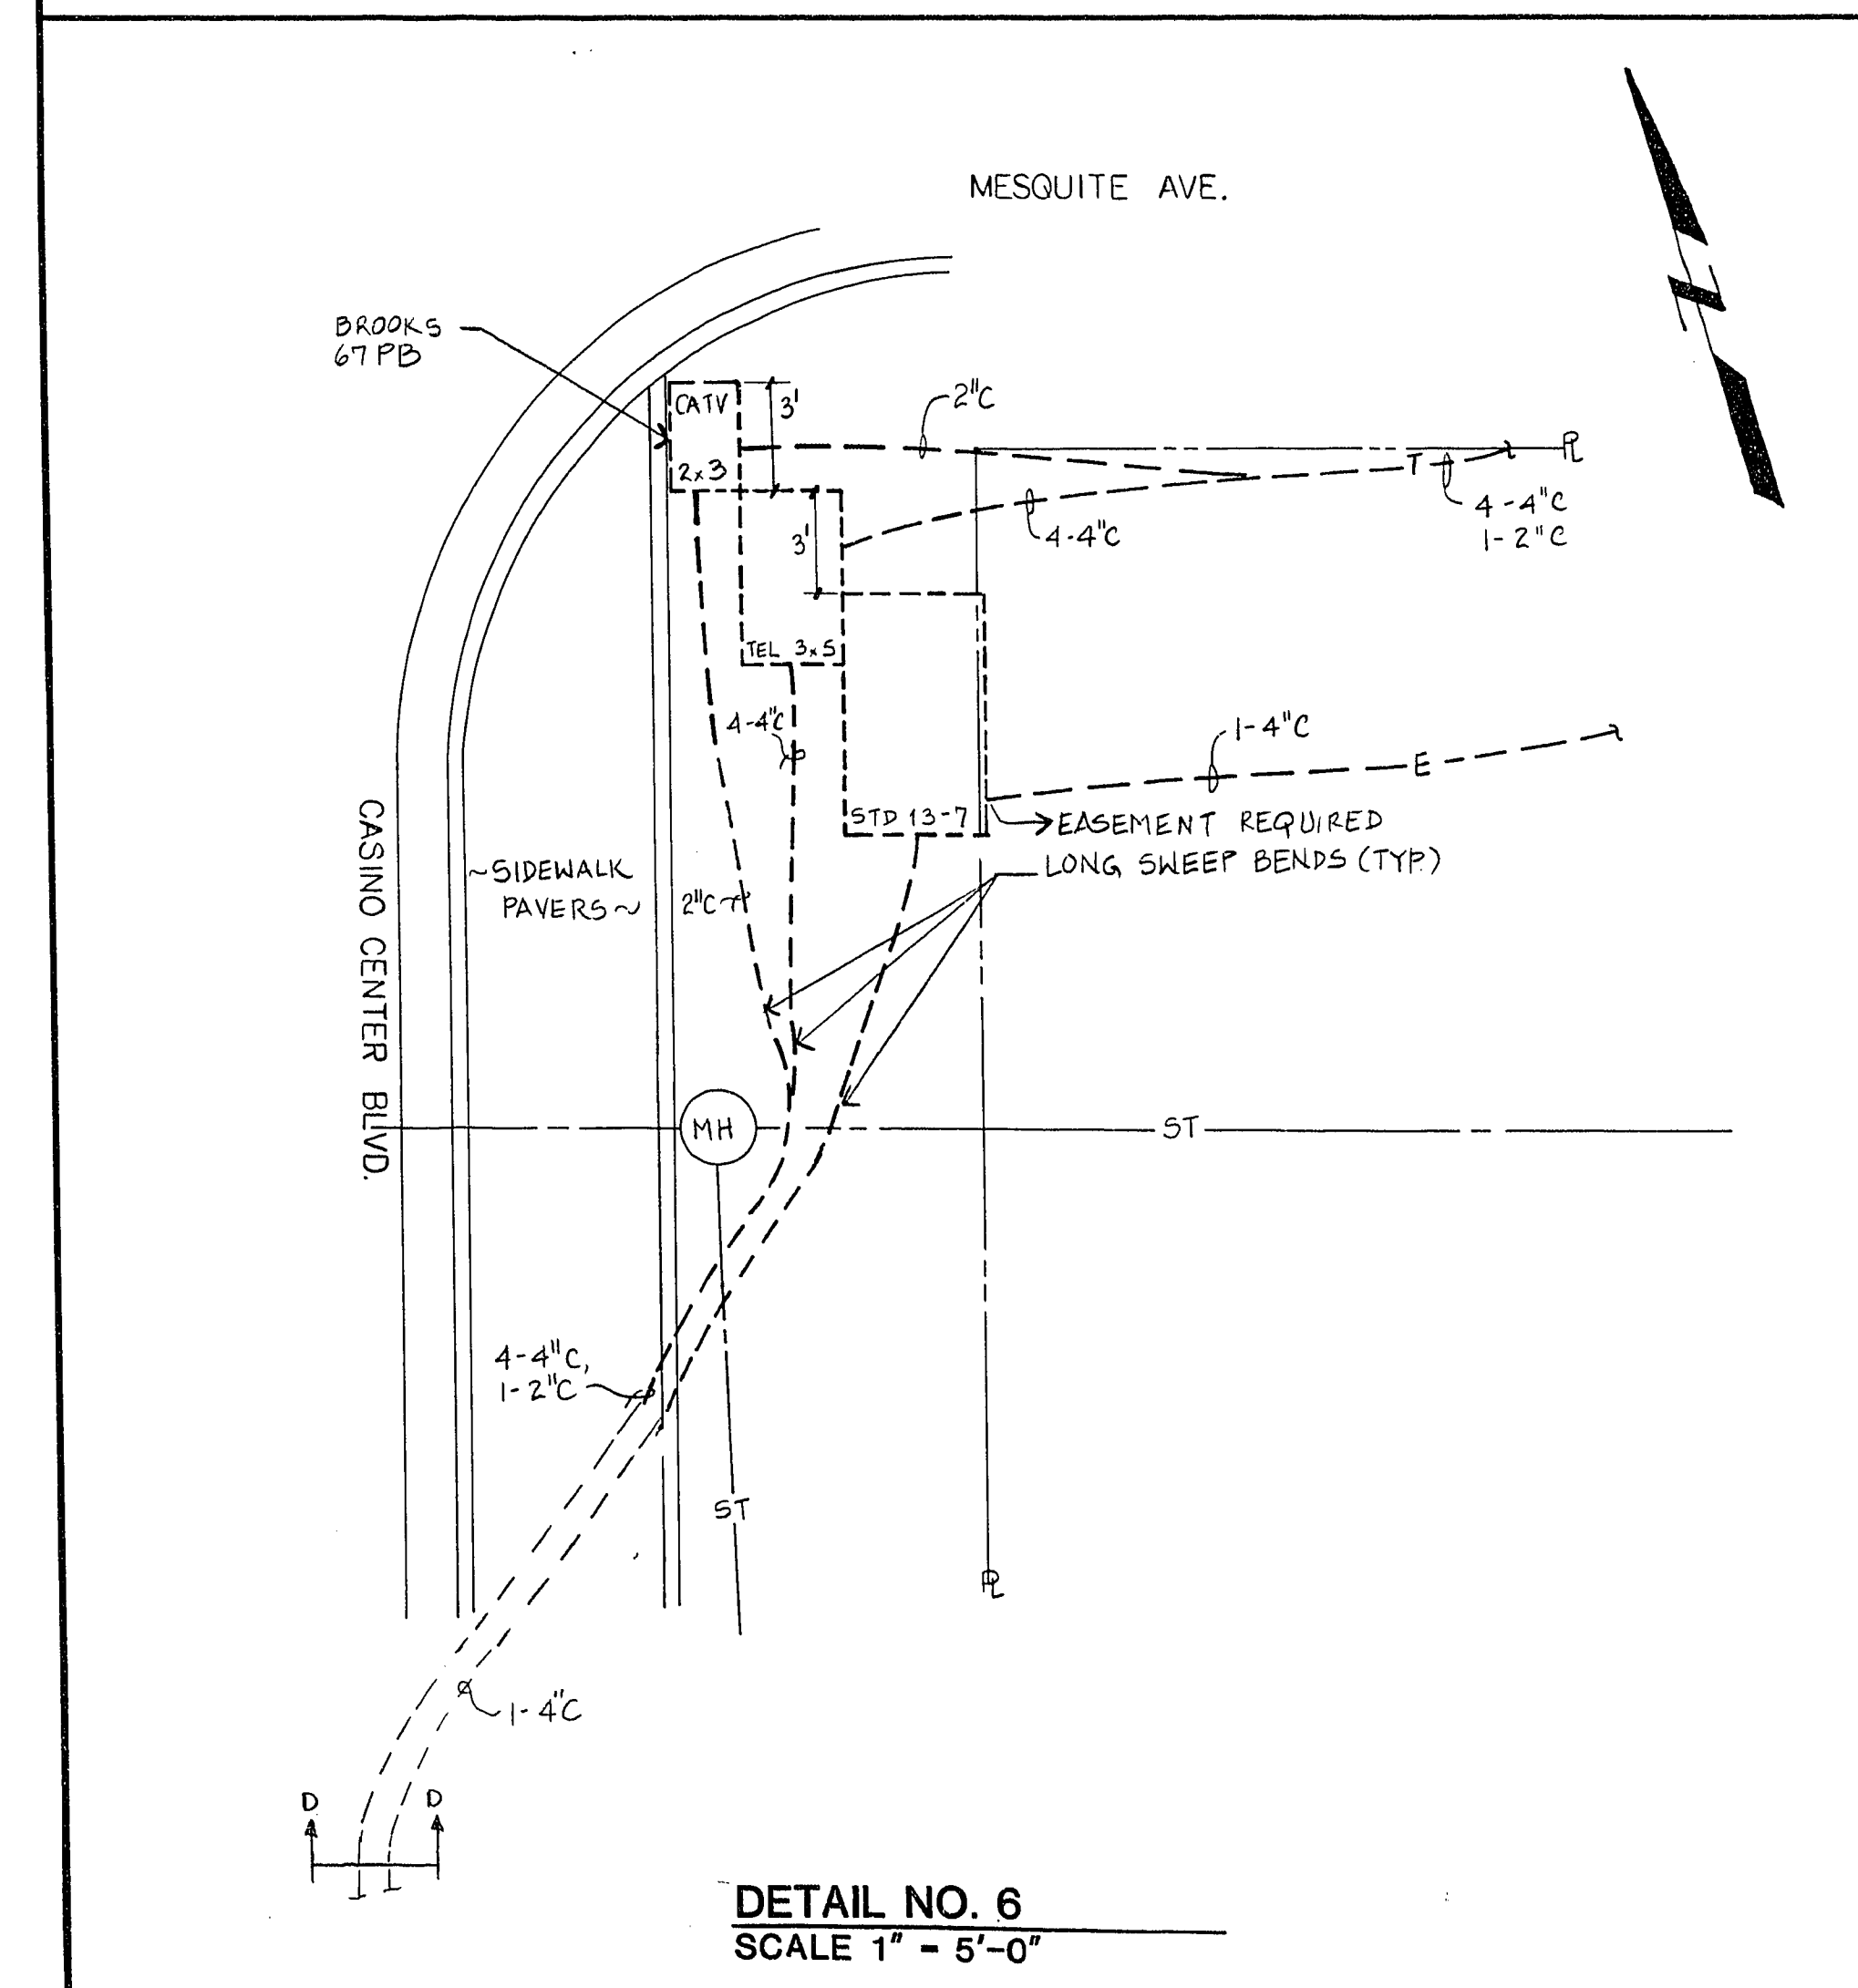
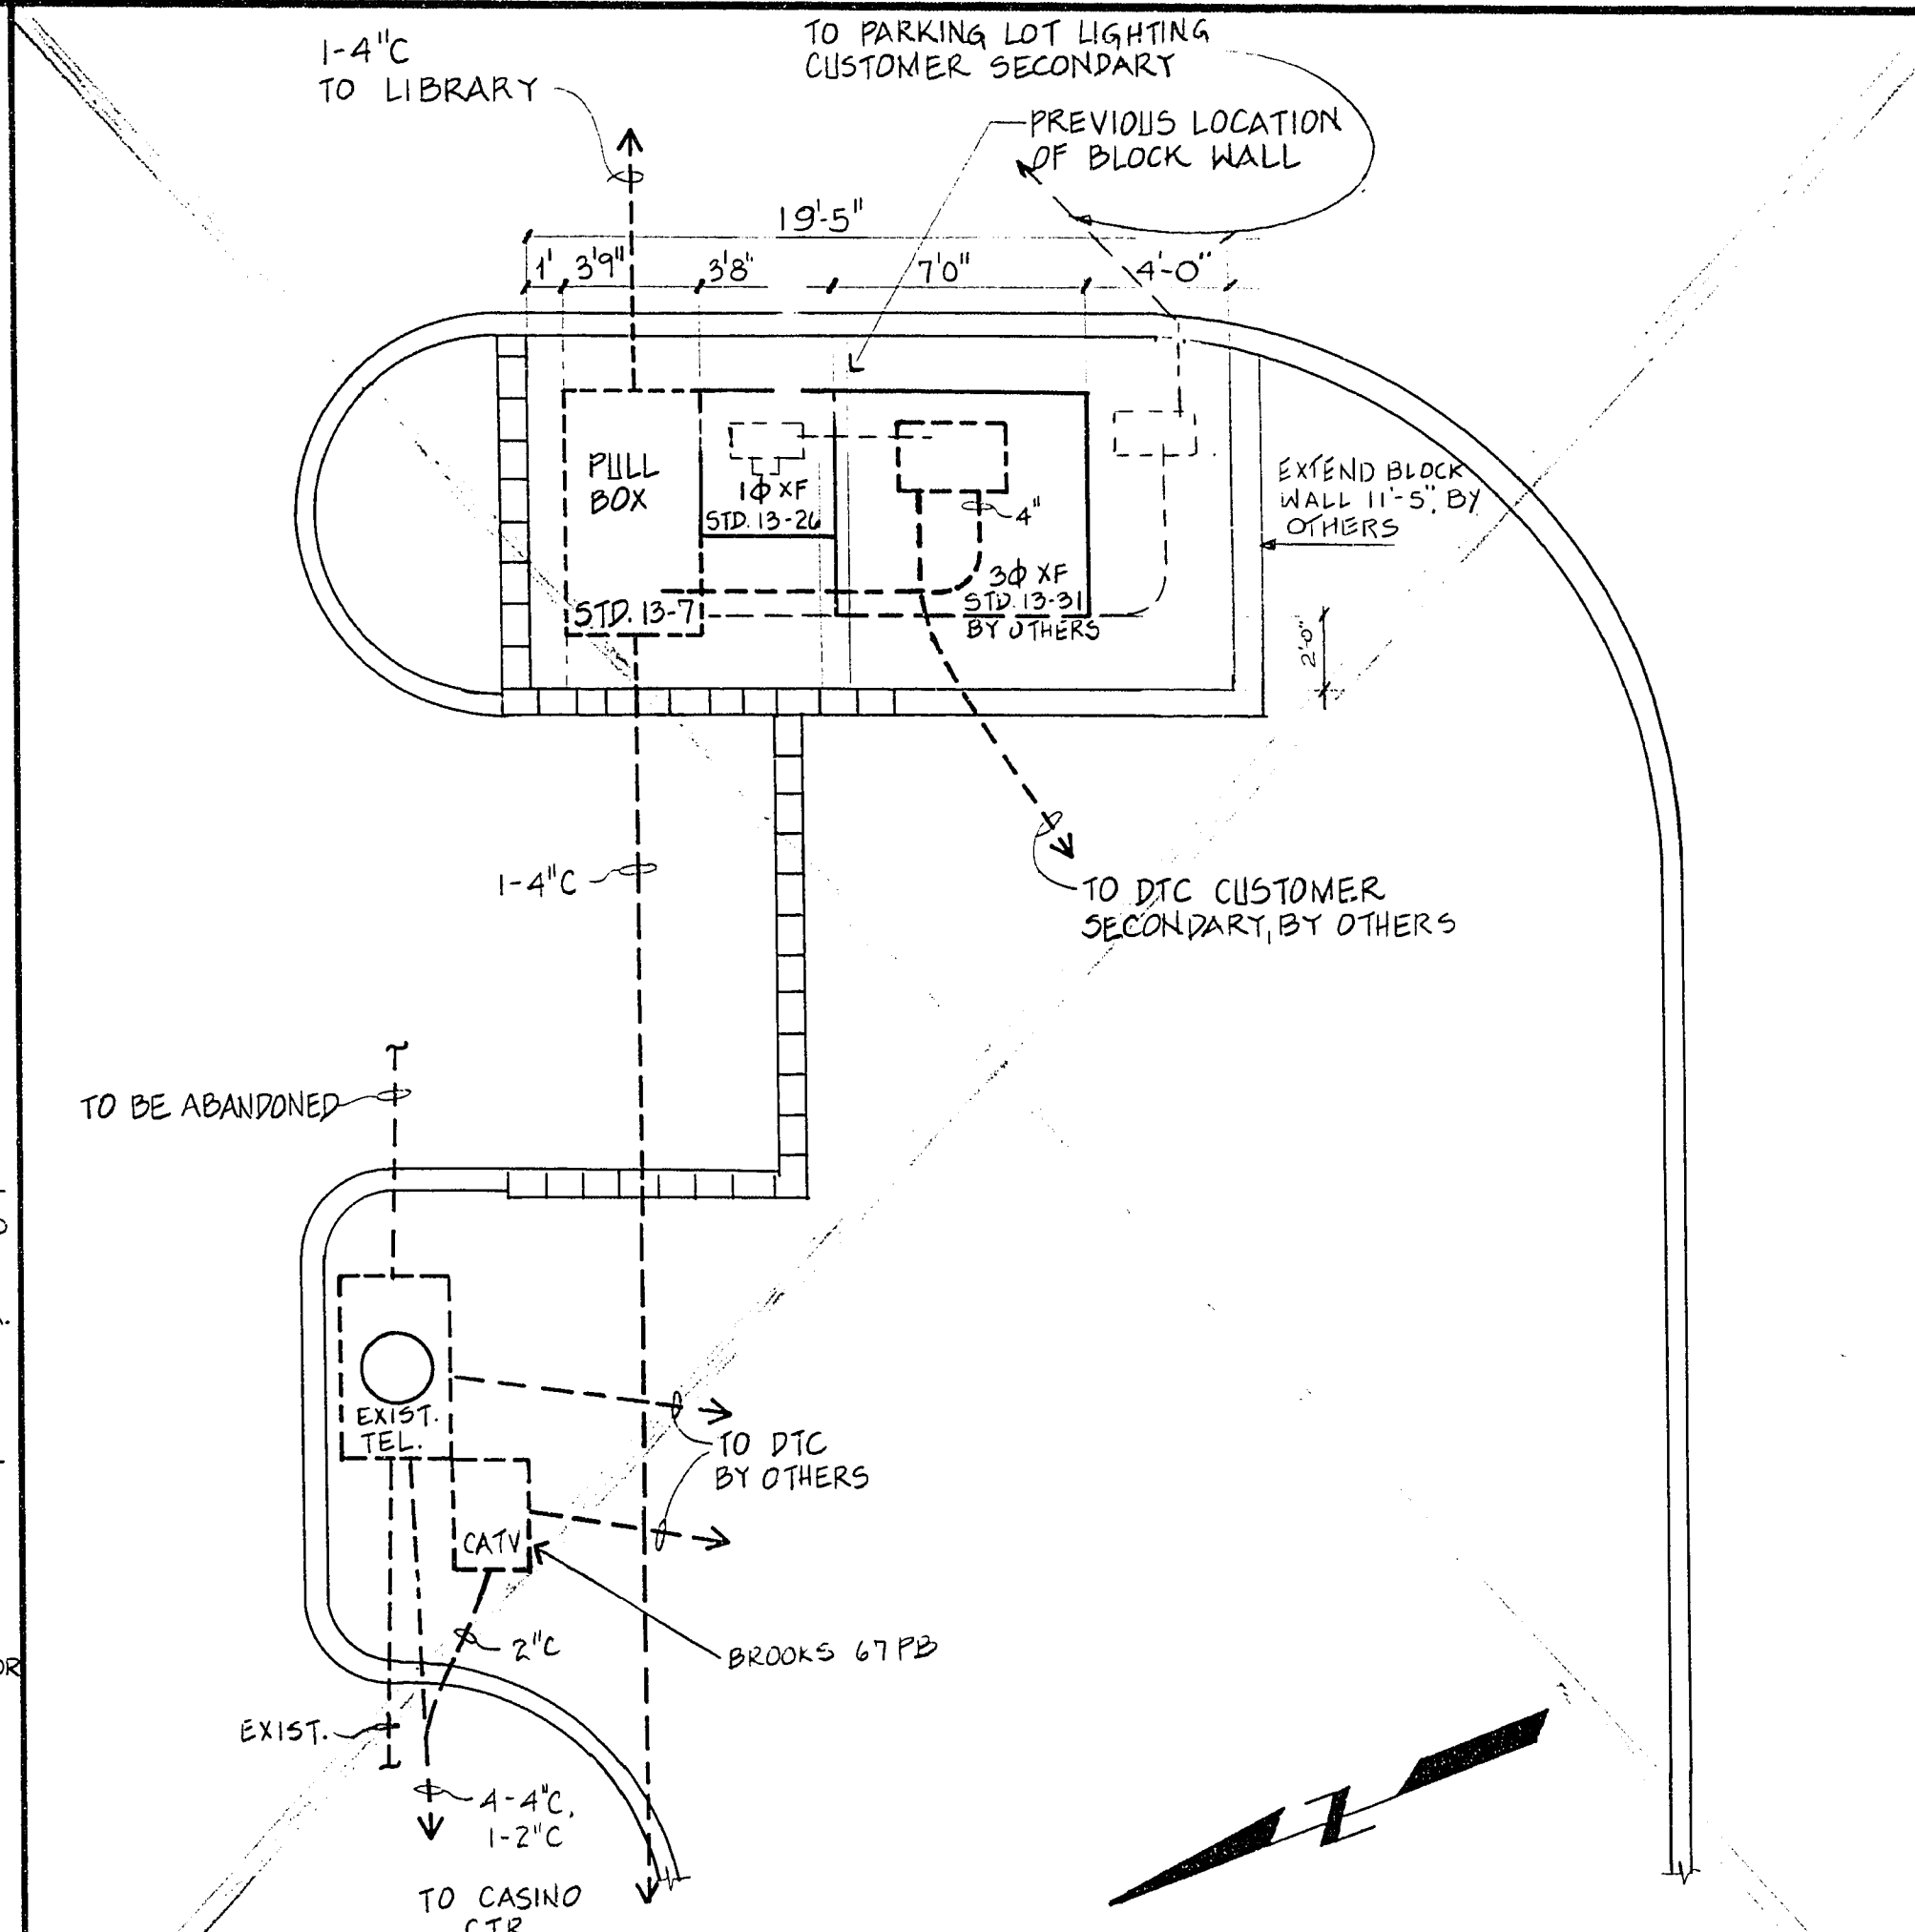
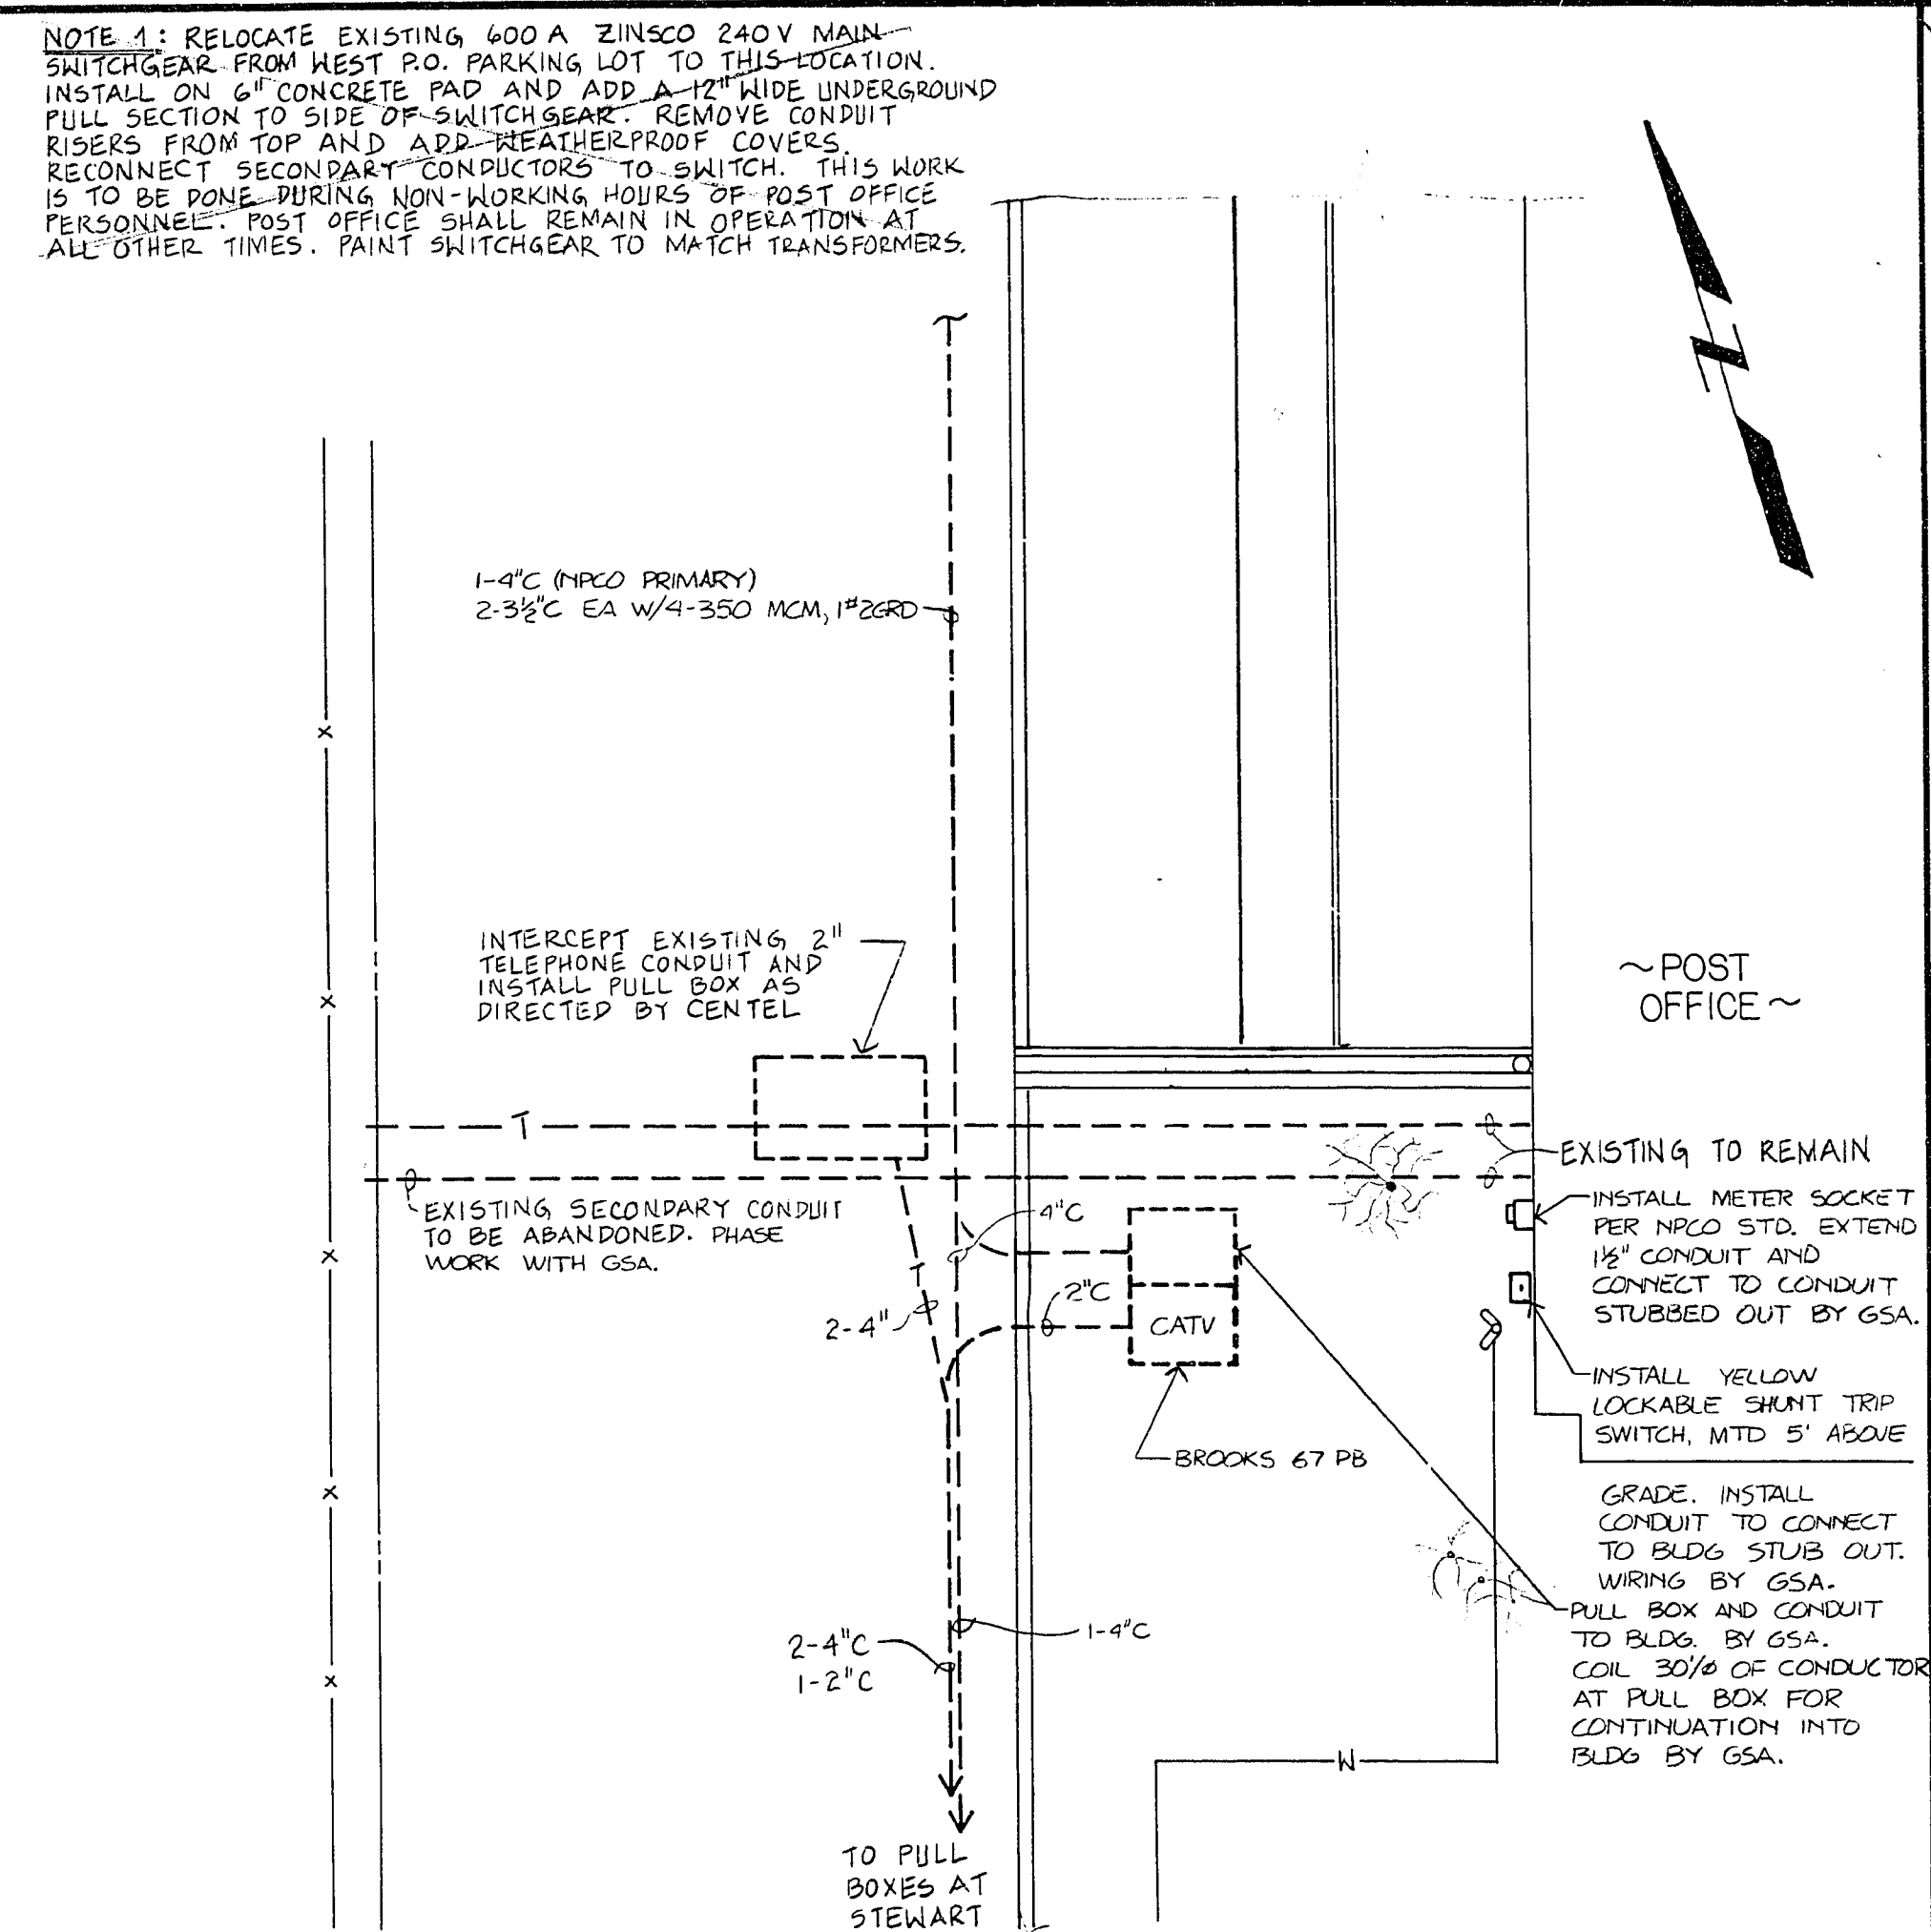


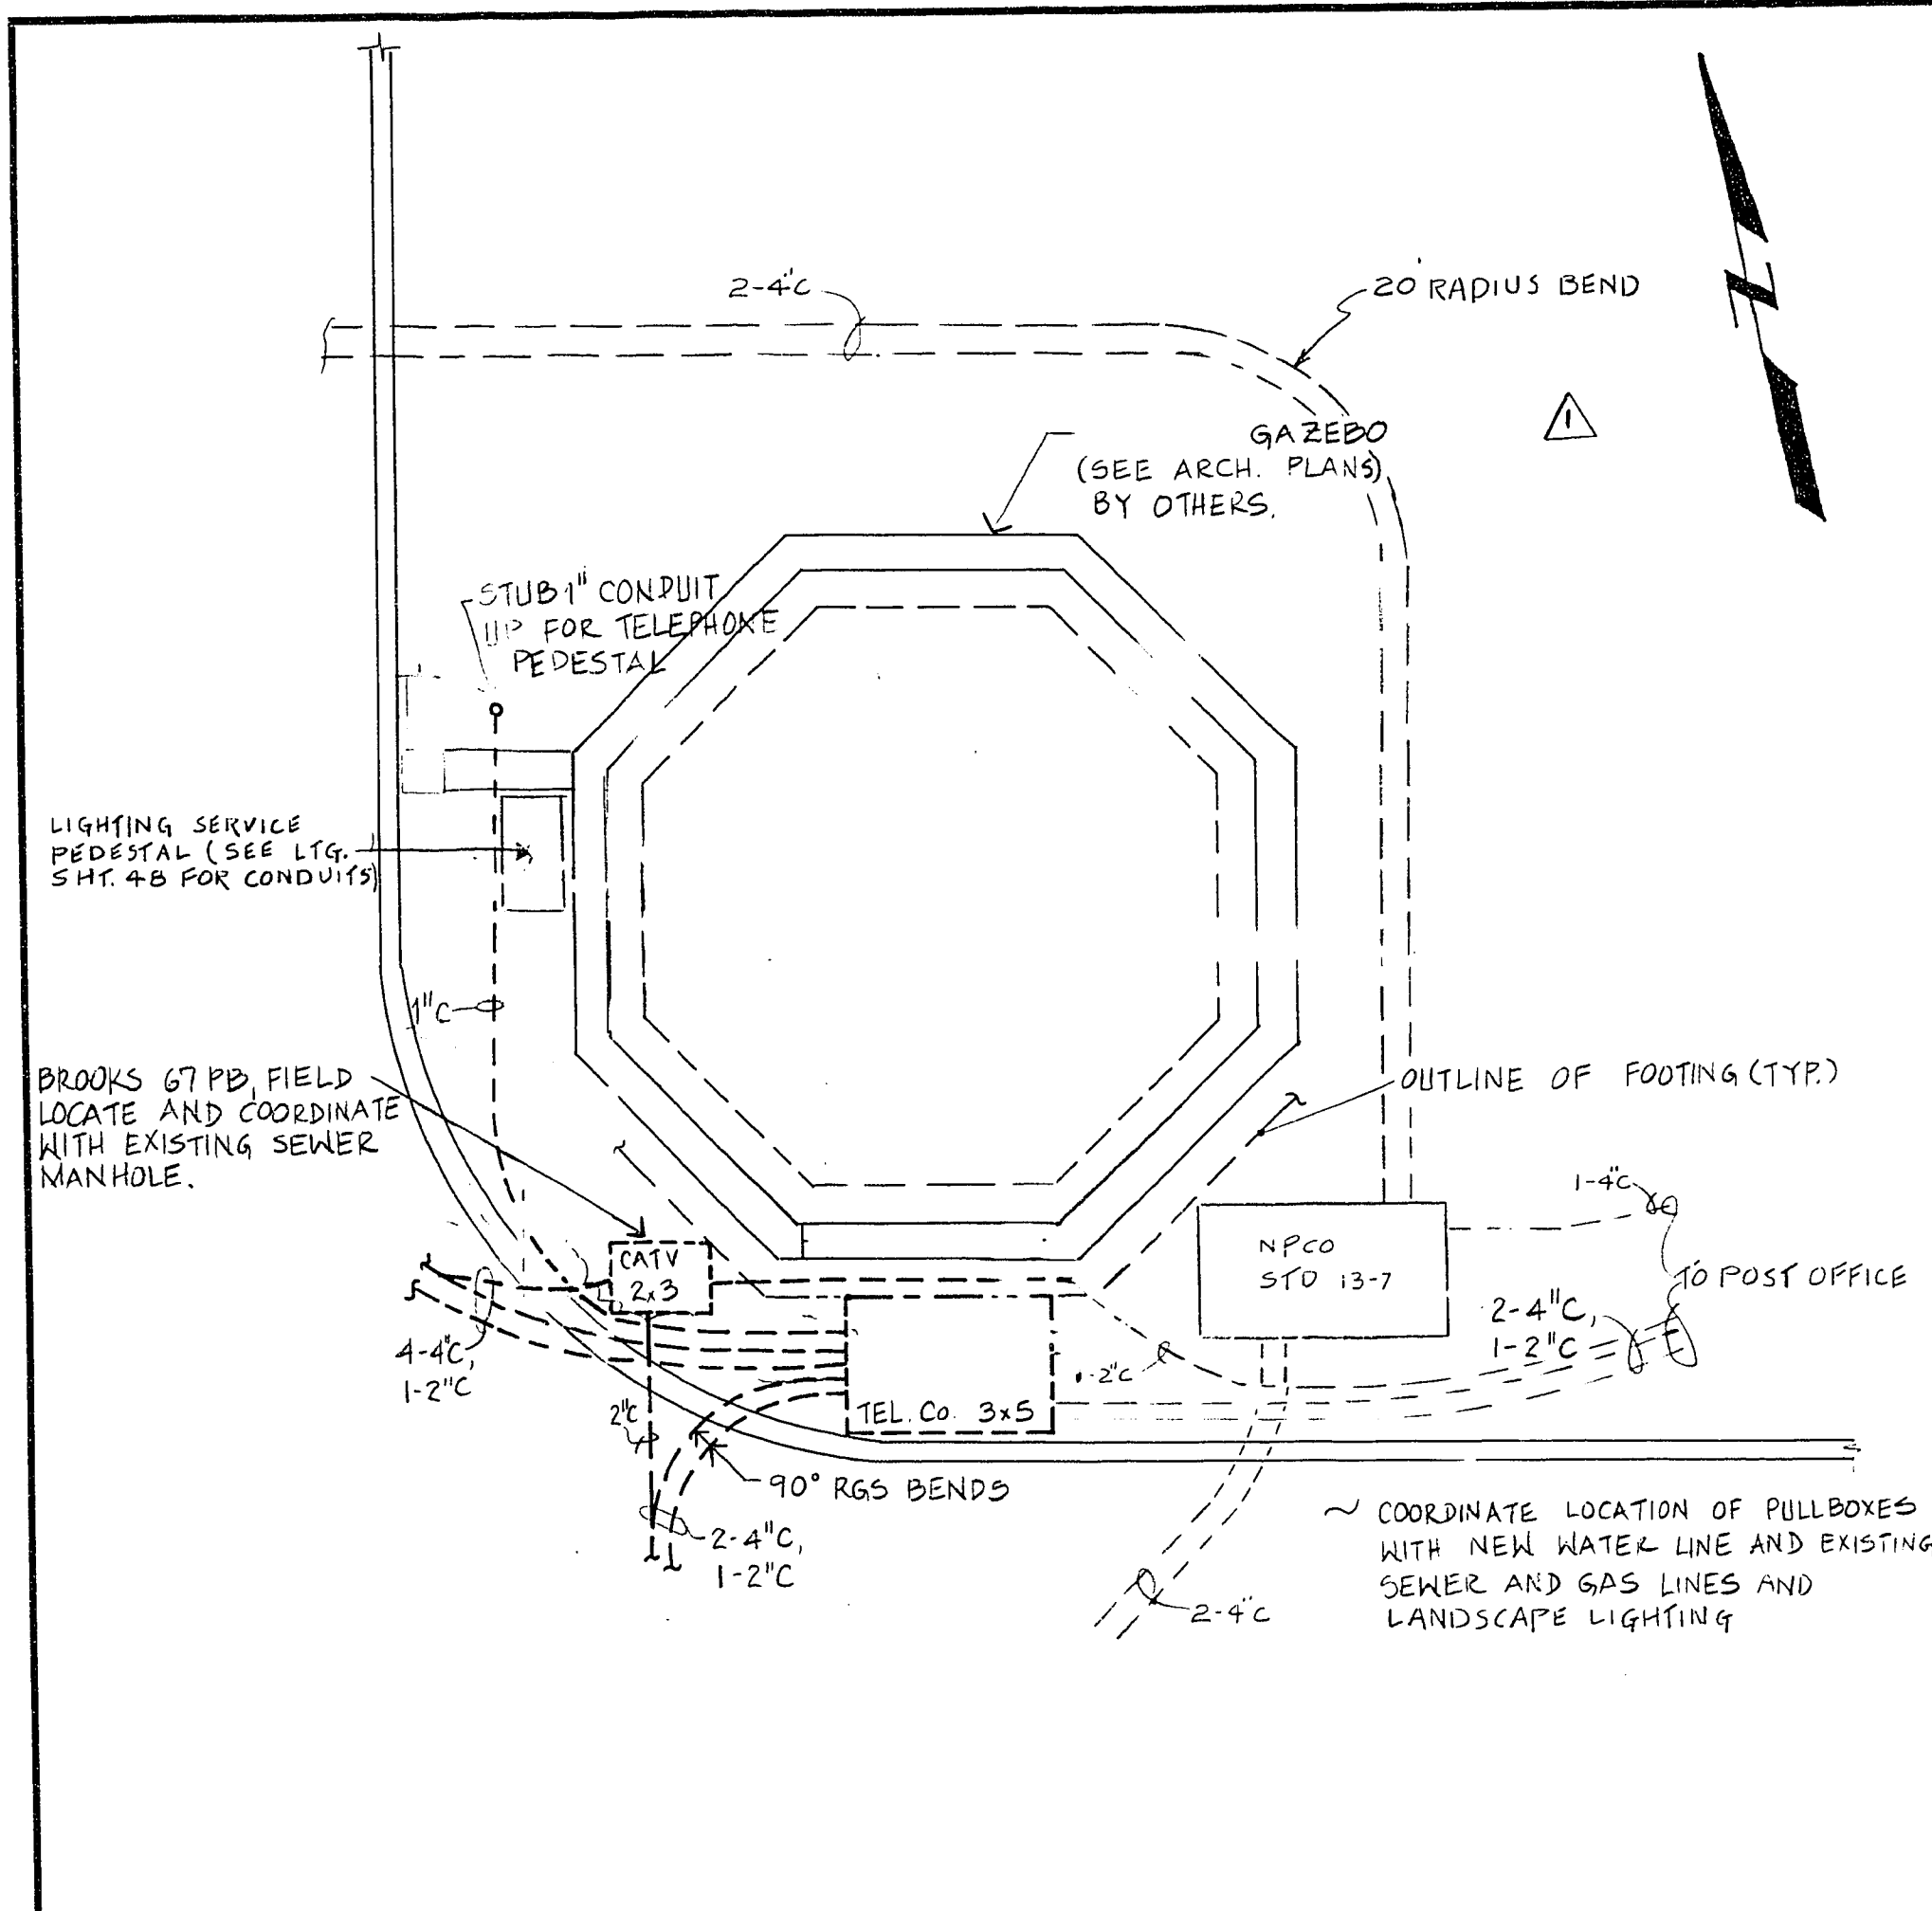

	Department of Public Works Engineering Design Division		Scale (HAS NOTED) Scale (V) W.A.	
	ELECTRICAL DETAILS		Fld. bk. no. Date	
	DOWNTOWN TRANSPORTATION CENTER	OFFSITE IMPROVEMENTS	Design by Drawn by	
				
Drawing no. 590-2D		49/50		REUSE FOR GSA 6-25-86 4-21-86
				Revisions
				Date