


NOTE: THE CONTRACTOR SHALL BE RESPONSIBLE FOR SEQUENCING WORK WITH OTHER CONTRACTORS IN THE AREA. ALL SCHEDULING SHALL BE COORDINATED WITH THE CITY.

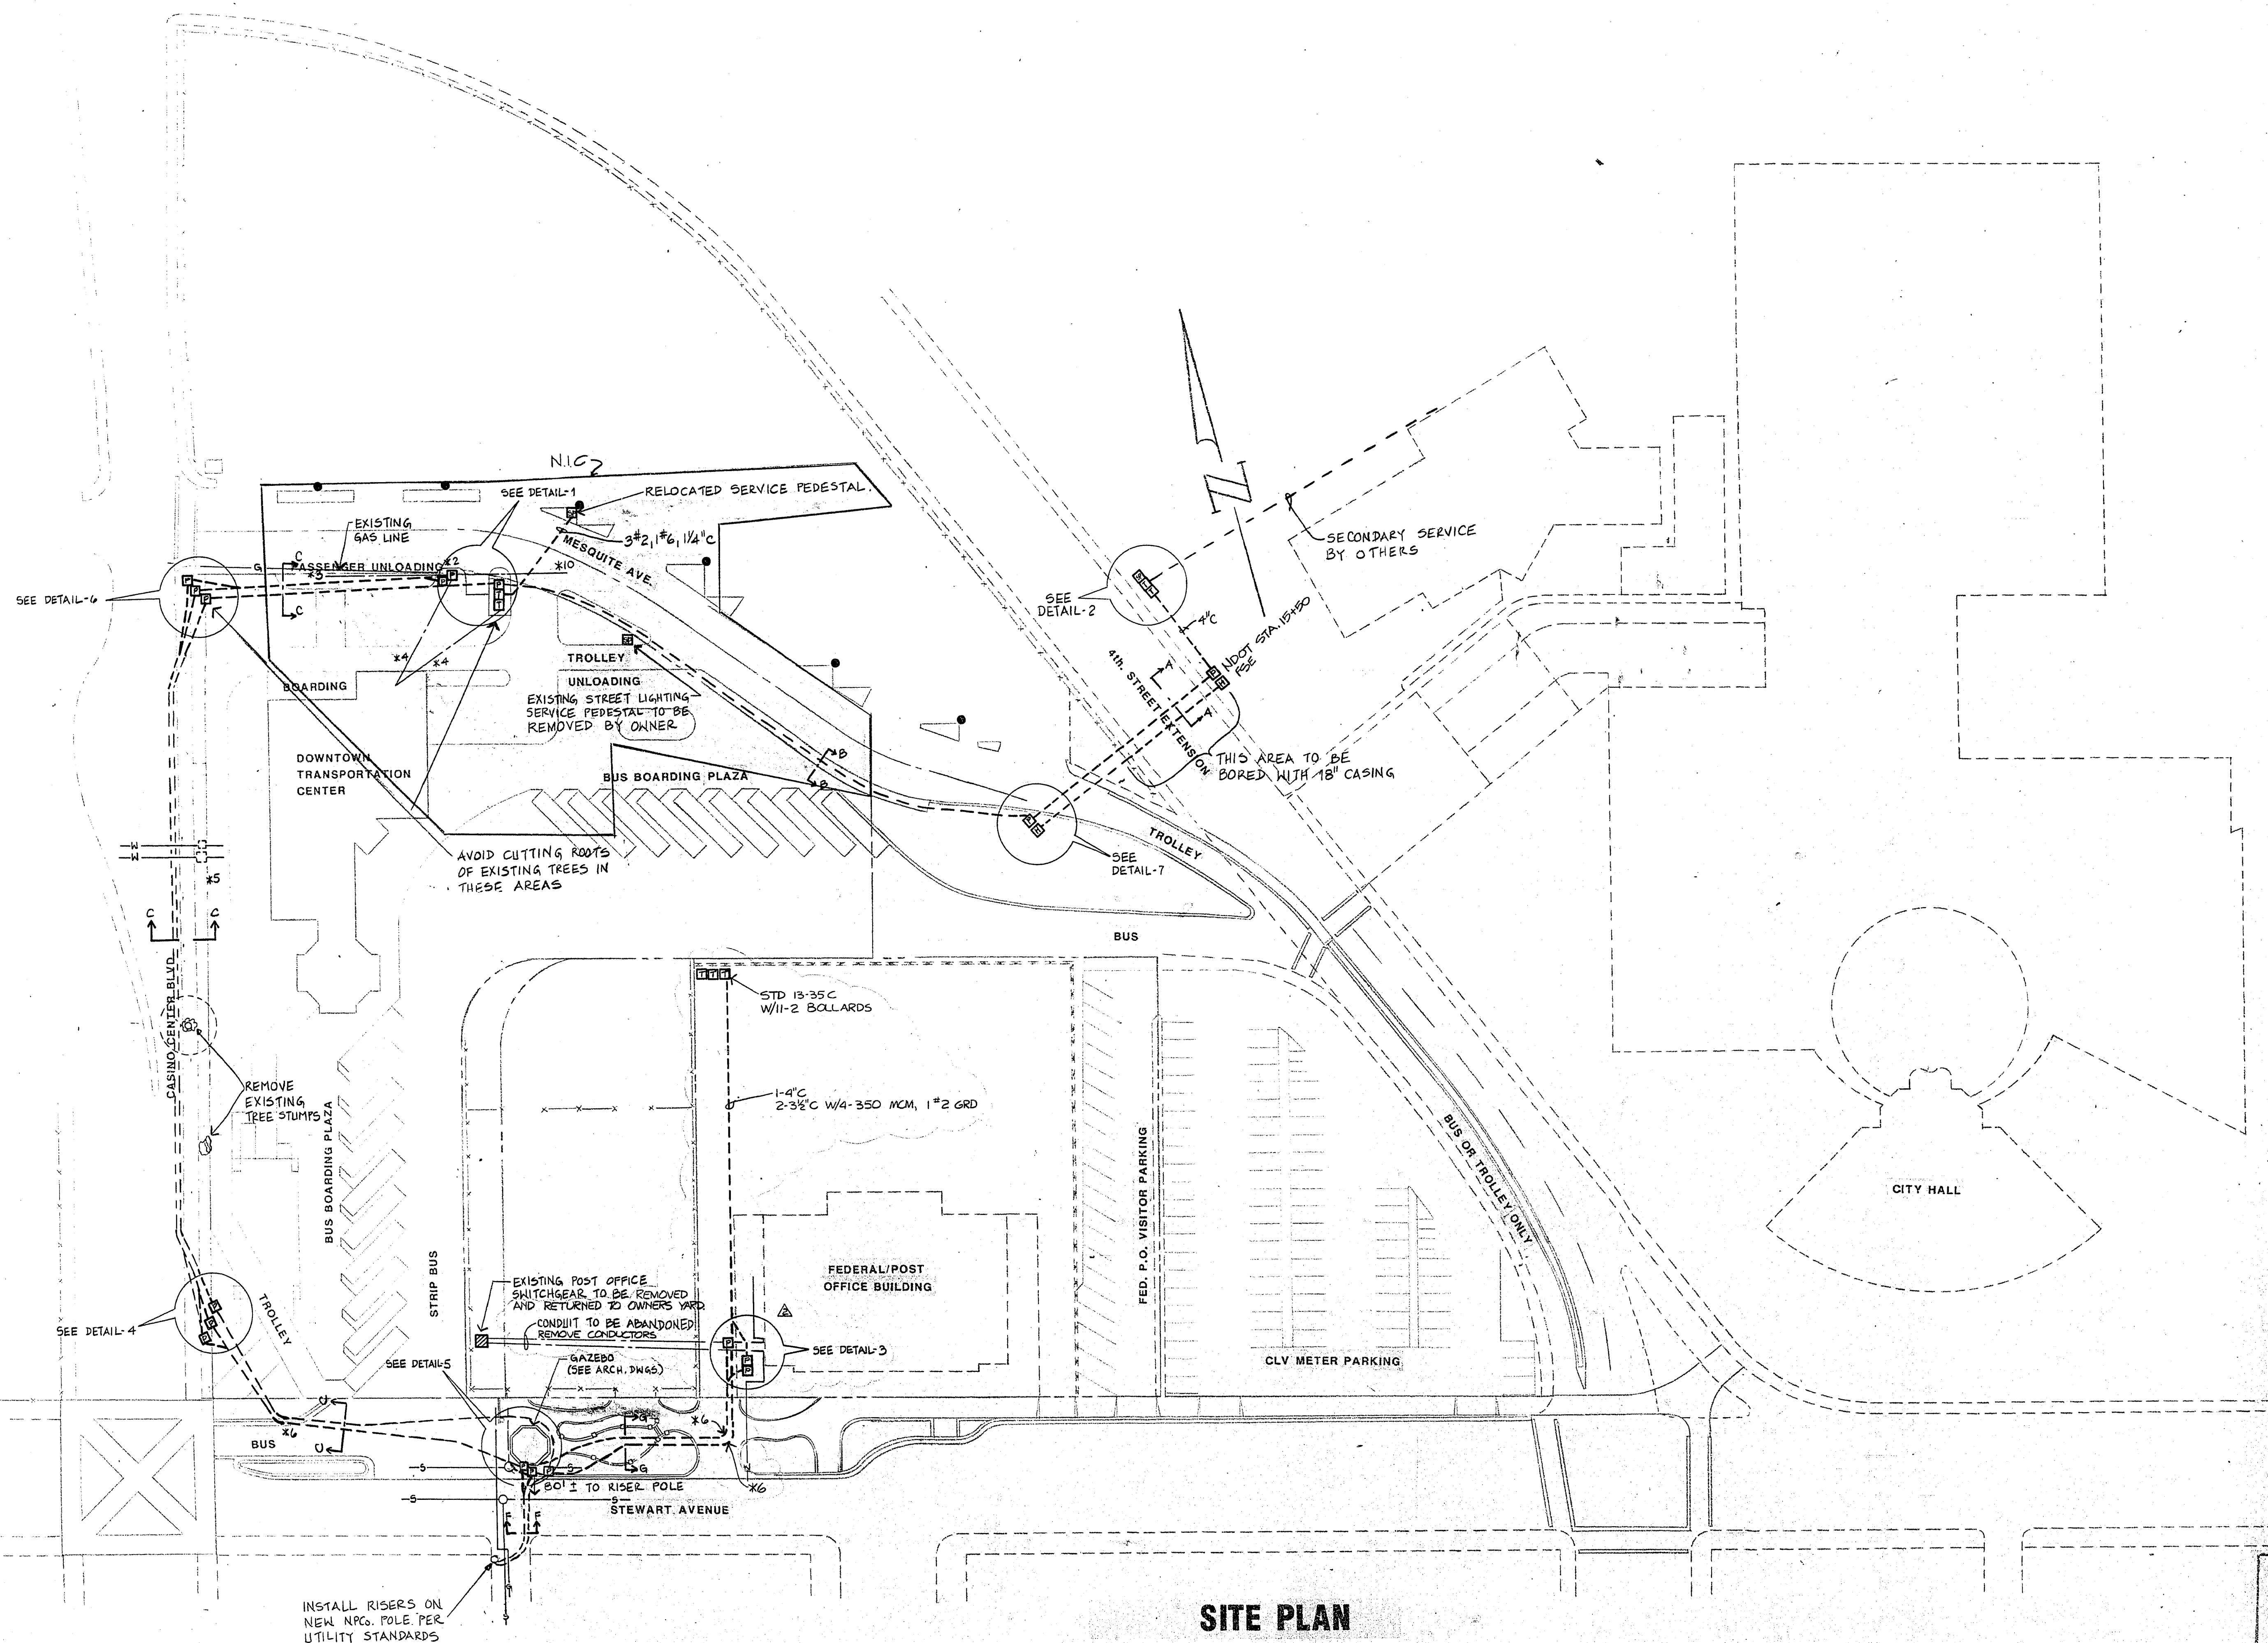

SITE PLAN

CONTRACT
DRAWING
APRIL 25, 1986



Drawing no. 47/
590-2D 51

Department of Public Works
Engineering Design Division
DOWNTOWN TRANSPORTATION CENTER
OFFSITE IMPROVEMENTS

ELECTRICAL
SITE PLAN



Engineering Design Division

Scale (h) 1"=40'

Scale (v)

Date

Fid. bk. no.

Design by HANAHAN/STONE

W.A.

Drawn by NORMA GOMEZ

Revisions	Date
REUSE FOR GSA	6-25-86
REVISE NOTE	4-21-86

30-13-98