
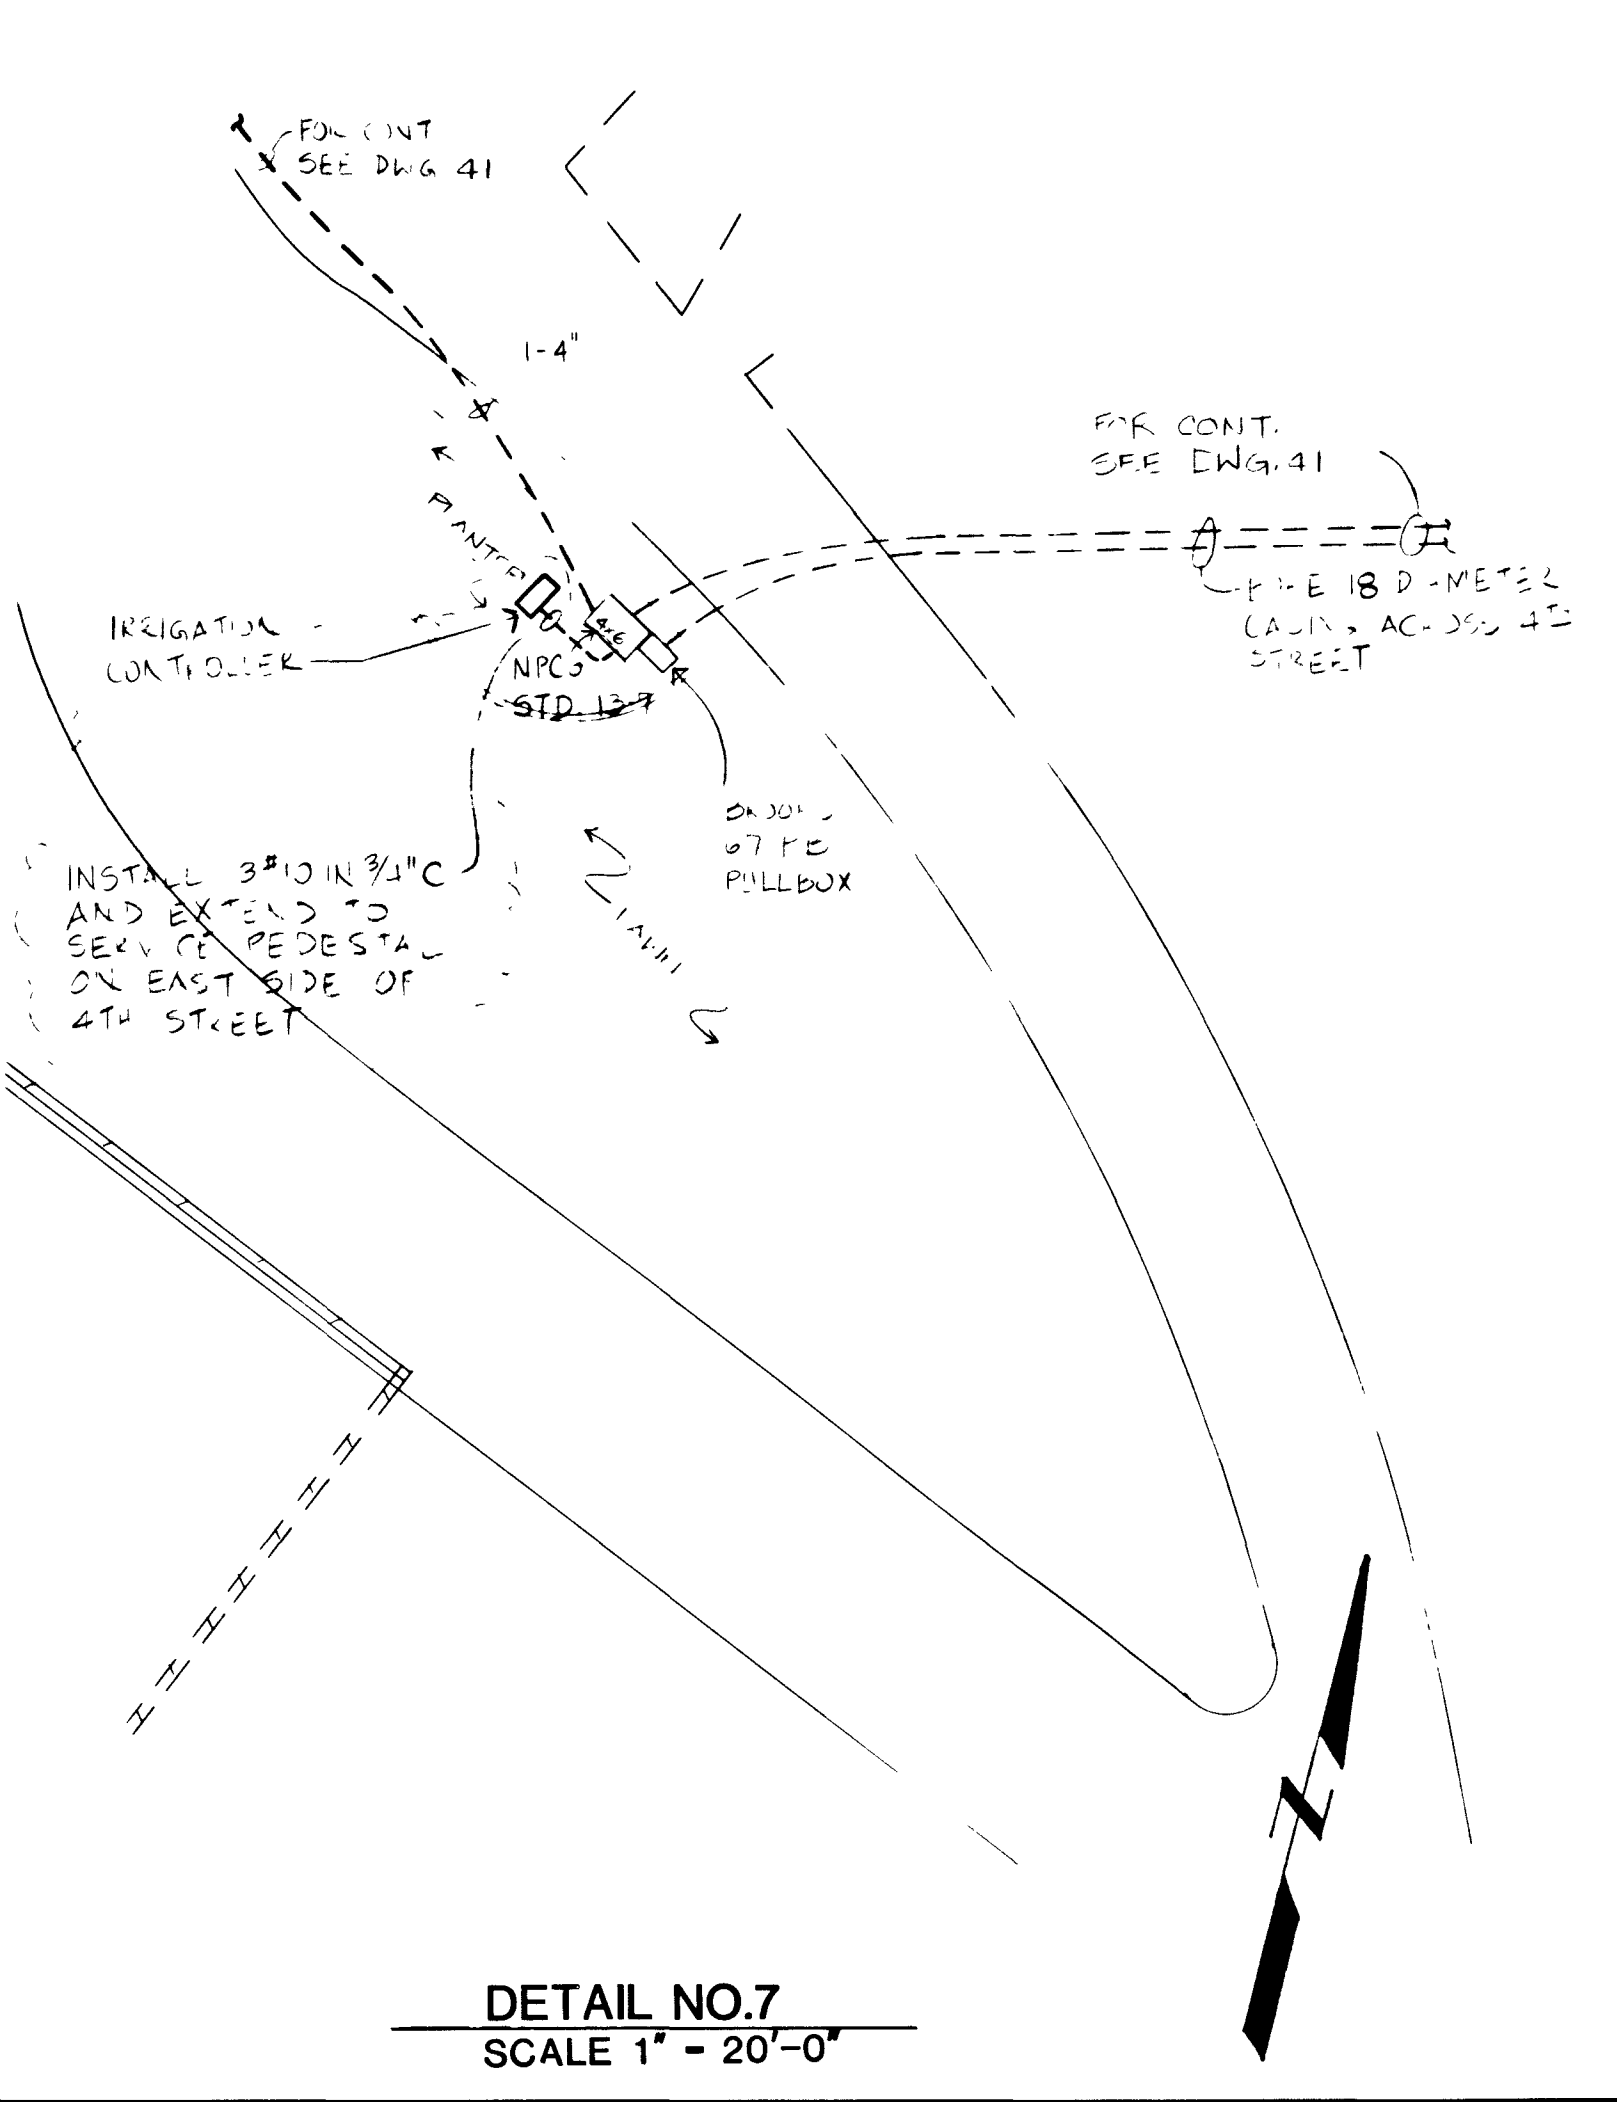


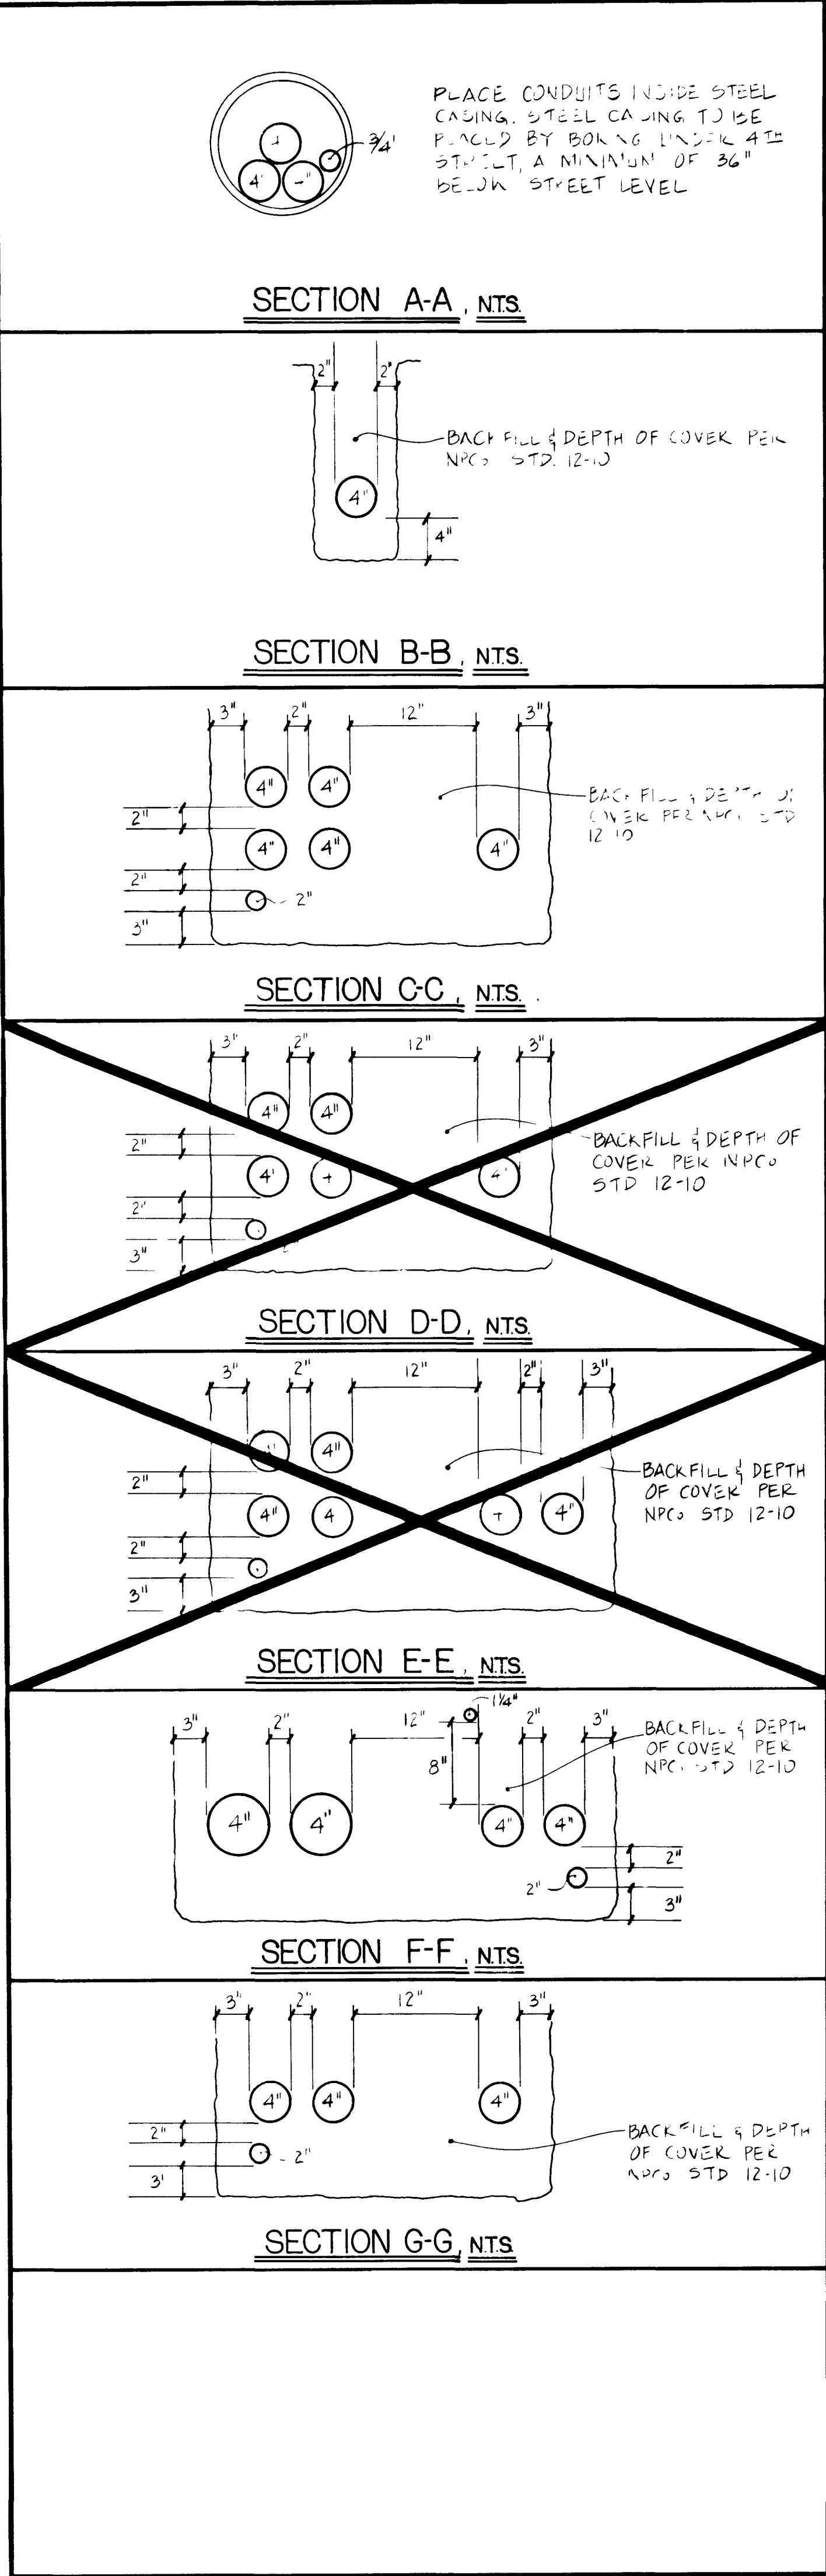

ELECTRICAL LEGEND

NEW EXISTING

POLE, SIZE AND CLASS AS NOTED ON DRAWINGS IF APPLICABLE

POLE MOUNTED LIGHTING FIXTURE

POLE WITH DOWN GUY AND ANCHOR

POLES WITH HEAD GUY

POLE MOUNTED EQUIPMENT. LETTER DENOTES TYPE:
C = CAPACITOR STATION
F = FUSED DISCONNECT SWITCH
L = LOAD BREAK DISCONNECT SWITCH
M = METERING
S = SOLID BLADE DISCONNECT SWITCH
T = TRANSFORMER STATION

OVERHEAD CIRCUIT CONDUCTORS. LETTERS INDICATE PHASING CONFIGURATION WHEN USED. EXISTING AS NOTED ON PLANS

UNDERGROUND DISTRIBUTION EQUIPMENT. LETTER DENOTES TYPE:
H = HANDHOLE
M = PAD MOUNTED METERING STATION
MH = MANHOLE
P = PULL BOX
SP = DISTRIBUTION SERVICE PEDESTAL
T = PAD MOUNTED TRANSFORMER
V = VAULT
S = PAD MOUNTED SWITCH

UNDERGROUND DISTRIBUTION AS NOTED ON PLANS

SWITCHBOARD

PANELBOARD

TERMINAL CABINET

CONTROL PANEL

DISCONNECT SWITCH F = FUSIBLE

MAGNETIC CONTRACTOR

CONTROL STATION

PHOTOELECTRIC SWITCH

TELEPHONE TERMINAL CABINET

PAY TELEPHONE OUTLET

- GENERAL NOTES
1. An asterisk by a number on the drawings refers to the note number in these notes.
 2. Existing Centel Pull box #38.
 3. Existing Centel Cable.
 4. DTC Telephone and electric service by others (NIC).
 5. Route around proposed fire vault.
 6. Concrete encase all bends with a minimum 2" concrete envelope.
 7. Conduit runs are diagrammatic, install as close to locations shown as practical.
 8. Contractor shall review all drawings, Civil, Structural, Architectural, etc. for work to be included or coordinated with Division 16 work.
 9. All work to be in accordance with local codes and the specifications.
 10. Existing telephone conduit to be abandoned east of existing pull box.
 11. Existing street light to be removed by City. Remove existing foundations and add pull boxes at the locations shown and reconnect or extend circuits inside of pull box.
 12. The contractor shall examine the drawings and shall notify the Owner's Representative of any discrepancies he may find before proceeding with the work.
 13. All omissions or conflicts between the various elements of the working drawings shall be brought to the attention of the Owner's Representative before proceeding with any work so involved.
 14. The contractor shall verify and be responsible for all site conditions and dimensions. He shall notify the Owner's Representative of any discrepancies between actual conditions and information shown on the drawings before proceeding with the work.
 15. The contractor shall supervise and direct his own work and he shall be solely responsible for construction means, methods, techniques, sequences and procedures.
 16. The contractor shall remove and replace all in-kind pavement, curbs, gutter, lawns, walls, underground utilities, pipes, turf, etc. which have been disturbed, to a condition equal to that which existed before construction started.
 17. The location of the existing utilities and other features on these plans is approximate only and is derived from existing plans. The contractor shall notify each respective utility company or City where appropriate 48 hours in advance of working in the area of the utility. The engineer assumes no liability for their accuracy or for any utilities not shown on the plans.
 18. The contractor shall be responsible for repairing any damage to existing utilities that are damaged during construction.
 19. DRAWINGS OF EXISTING CONDITIONS AND CONTRACTS IN PROCESS WILL BE MADE AVAILABLE TO ALL SUCCESSFUL BIDDING FOR USE IN STAGING AND LAYOUT OF PULL BOXES AND TRENCHING

Scale (h)AS NOTED Scale (v) W.A.

Fld. bk. no. Date

Design by Drawn by

Revisions

REVISION QUANTITIES 4-21-86

Date

Department of Public Works Engineering Design Division

ELECTRICAL LEGEND , NOTES & DETAILS

DOWNTOWN TRANSPORTATION CENTER OFFSITE IMPROVEMENTS

Drawing no. 46 51

590-2D

APRIL 25, 1986

161

Revisions have been made to this drawing. See original.

