


agency	approved	date
Director of Public Works	<i>Richard D. Goecke</i>	2-28
City Engineer	<i>Carl P. Malone</i>	28 Feb 86
Chief of Civil Engineering	<i>Carl P. Malone</i>	28 Feb 86
Chief of Traffic Engineering	<i>Carl P. Malone</i>	2/27/86
City Project Administrator	N/A	
Chief of Project Control	N/A	
Chief of Construction Services	<i>Carl P. Malone</i>	2/27/86
Director of General Services	N/A	
Chief of Maintenance	N/A	
Director of Parks, Recreation & Senior Activities	<i>David J. Gorman</i>	3/24/86
Director of Design & Development	<i>Carl P. Malone</i>	2-28-86
Chief of Electrical Services	<i>Benjamin J. Gorman</i>	3-11-86
Director of Community Planning & Development	N/A	
Director of Building & Safety	N/A	
Regional Transportation Commission	N/A	
Nevada State Department of Transportation	N/A	
Central Telephone Company	<i>Nyle Smith</i>	3-3-86
Las Vegas Valley Water District	<i>Reinold Hill</i>	3-3-86
Nevada Power Company	<i>R. Miller</i>	3-3-86
Southwest Gas	<i>Thomas J. Garcia</i>	3-3-86
Cable Television		
General Service Administration	<i>James D. Smith</i>	3-7-86


City of Las Vegas

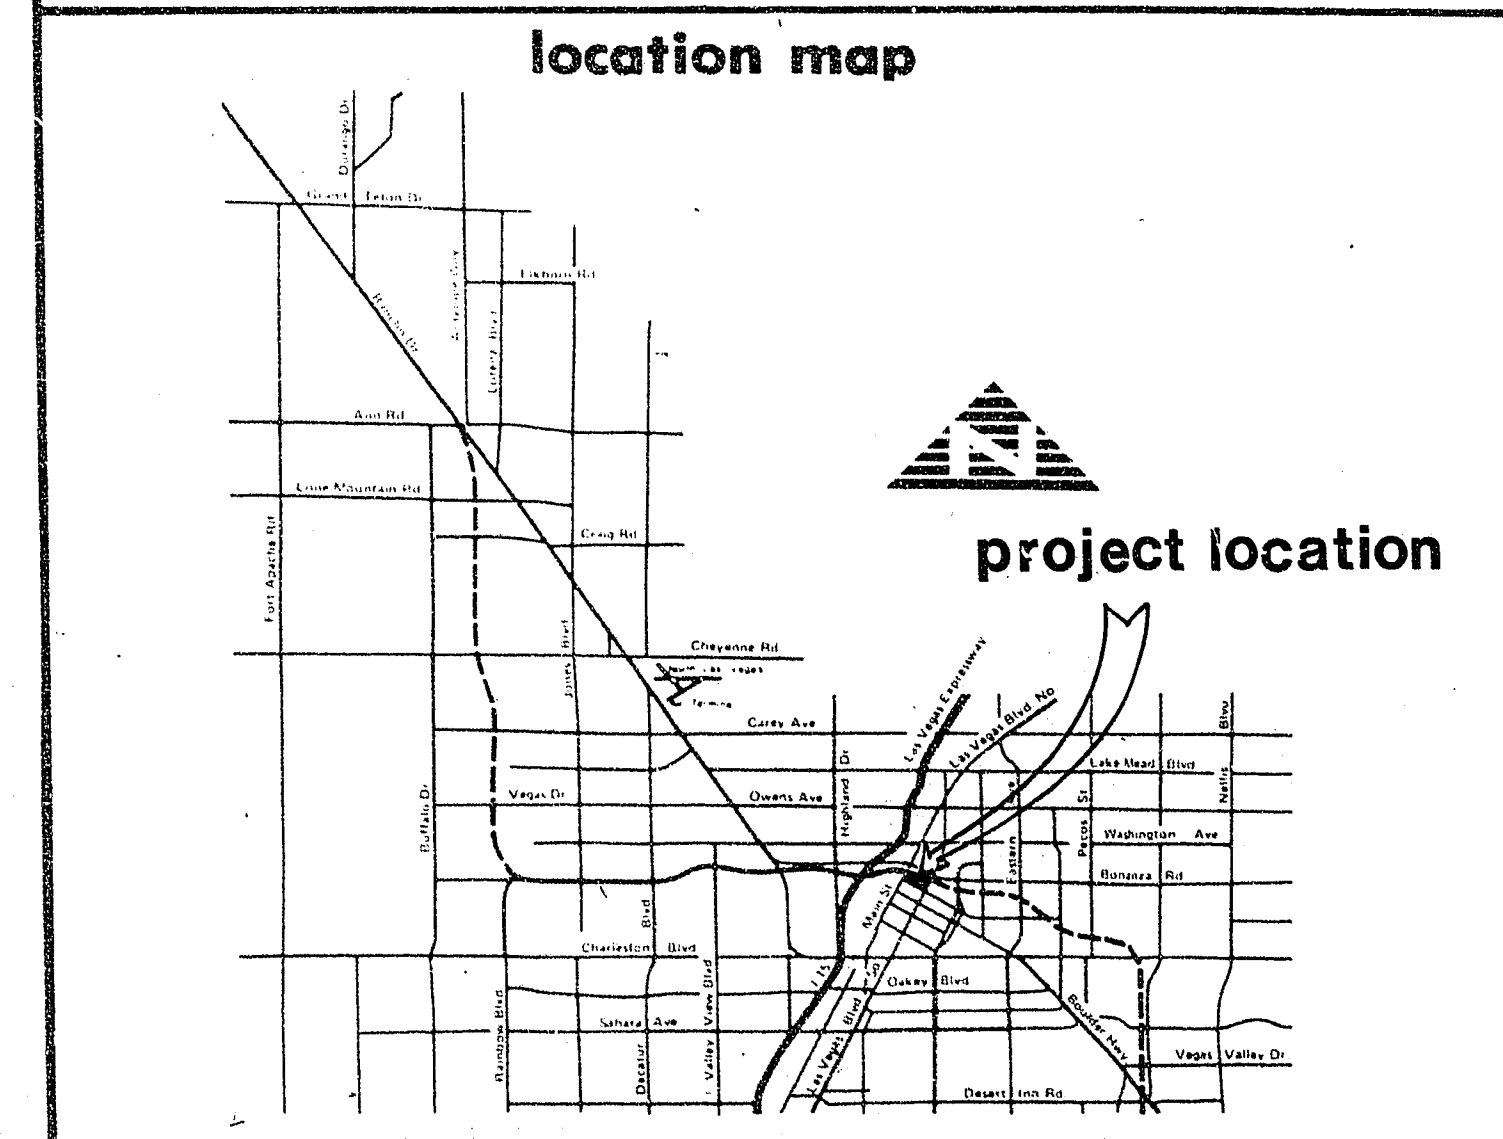

mayor:
 Bill Briare
 councilmen:
 Ron Lurie
 Al Levy
 Bob Nolen
 W. Wayne Bunker

city manager:
 Ashley Hall
 director of public works:
 Richard D. Goecke
 city engineer:
 Carl P. Malone R.P.E. 04410

index of sheets			
no.	description		
1.	TITLE SHEET		
2.	GENERAL NOTES, LEGEND		
3.	IMPROVEMENT SITE PLAN		
4.	IMPROVEMENT SITE PLAN - BID GROUP IDENTIFICATION		
5.	IMPROVEMENT SITE PLAN-BID GROUP IDENTIFICATION		
6.	IMPROVEMENT SITE PLAN-BID GROUP IDENTIFICATION		
7.	SITE PLAN - EXISTING UTILITIES		
8.	DEMOLITION STA. 7+00 TO 12+12.5 STEWART, CASINO CTR., 3rd. ST.		
9.	DEMOLITION STA. 2+56 TO 7+00 STEWART & 4th. ST.		
10.	DEMOLITION 4th. ST. AND MESQUITE AVE.		
11.	DEMOLITION CASINO CTR. BLVD. AND STEWART		
12.	DEMOLITION MESQUITE AND 4th. ST.		
13.	STEWART AVE. OVERLAY SECTION STA. 12+12.5 TO STA. 18+71.5		
14.	CASINO CENTER AVE./BONANZA RD. PERMANENT PATCH (LVVWD #434)		
15.	PEDESTRIAN MALL - STEWART AVE. RECONSTRUCTION		
16.	STEWART AVE. RECONSTRUCTION GRADING PLAN & PROFILE		
17.	STEWART AVE. OVERLAY SECTION STA. 0+31.08 TO STA. 2+56.00		
18.	INTERSECTION - STEWART AVE. & CASINO CENTER BLVD. GRADING PLAN & PROFILE		
19.	STEWART AVE. - CASINO CENTER BLVD/INTERSECTION GEOMETRICS		
20.	STEWART AVE. - CASINO CENTER BLVD/INTERSECTION DETAILS		
21.	GENERAL NOTES & TYPICAL VALLEY GUTTER DETAILS		
22.	3rd. ST. - STEWART AVE. 4th. ST. - STEWART AVE.		
23.	1st. ST. & OGDEN AVE. 3rd. ST. & BRIDGER AVE. V. & G. RAMPS		
24.	STREET PROFILES 1st. & 3rd. STS.		
25.	SIDEWALK - THIRD ST. TO FOURTH ST./ALTERNATES (STEWART AVE.)		
26.	BUS LANE/MESQUITE AVE. - GEOMETRICS		
27.	BUS LANE/MESQUITE AVE. - IMPROVE/PLAN & PROFILE		
28.	FOURTH ST. SANITARY SEWER/BUS LANE MEDIAN ISLAND PROFILE		
29.	BUS LANE/MESQUITE AVE. - RECONSTRUCTION		
30.	CASINO CENTER CURB AND GUTTER REPLACEMENT		
31.	SIDEWALK IMPROVEMENTS - CASINO CENTER BLVD. ALTERNATES		
32.	DETAILS - VALVE BOX ADJUSTMENT		
	ECCENTRIC MANHOLE - DROP INLET		
	CONCRETE COLLAR AROUND MANHOLES		
33.	PEDESTRIAN MALL PAVEMENT LAYOUTS		
34.	PEDESTRIAN MALL-DETAILS		
35.	GAZEBO FLOOR PLAN		
36.	GAZEBO FOUNDATION PLAN AND DETAILS		
37.	GAZEBO STRUCTURAL PLAN AND ROOF DETAILS		
38.	TYPICAL SECTIONS AND STREET DETAILS		
39.	BLOCK WALL, RAMPS, & ALLEY DRIVEWAY DETAILS		
40.	LANDSCAPING PLAN		
41.	LANDSCAPING PLAN		
42.	IRRIGATION PLAN		
43.	IRRIGATION PLAN		
44.	TRAFFIC DELINEATION		
45.	TRAFFIC DELINEATION		
46.	ELECTRICAL LEGEND		
47.	ELECTRICAL SITE PLAN		
48.	LIGHTING PLAN		
49.	ELECTRICAL DETAILS		
50.	ELECTRICAL REFERENCE STANDARDS		
51.	PEDESTRIAN MALL LIGHTING DETAILS		
revisions			

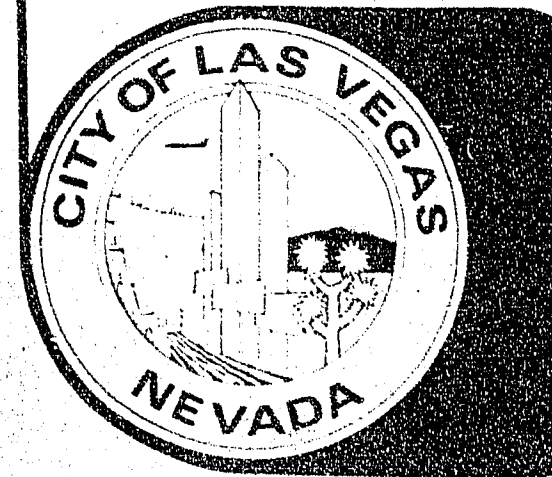


ADDENDED 4/25/86
 BID No. 86.1715.14

Downtown Transportation Center

OFFSITE IMPROVEMENTS

PEDESTRIAN MALL PROJECTS

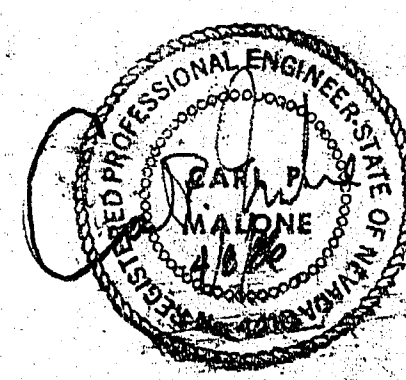

CONTRACT
 DRAWING
 APRIL 25, 1986

date
 MARCH 10, 1986
 drawing number
 590-2E
 sheet 1 of 51

30-13-48