



PROFILE A-A
(EAST F.L. OF CASINO CTR.)

SCALE: H: 1" = 20.0'
V: 1" = 2.0'

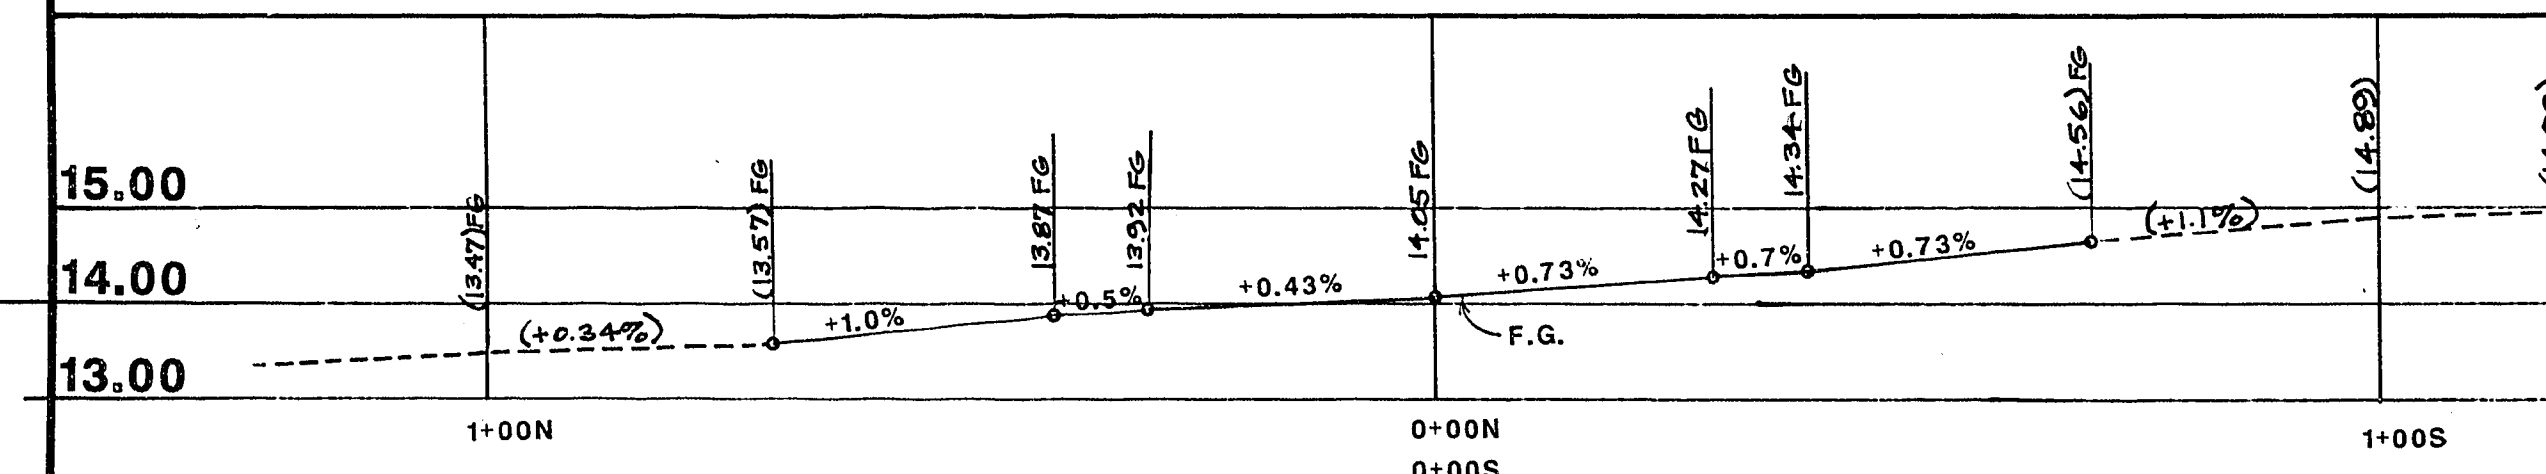


PROFILE B-B
(C.L. OF CASINO CTR.)

SCALE: H: 1" = 20.0'
V: 1" = 2.0'

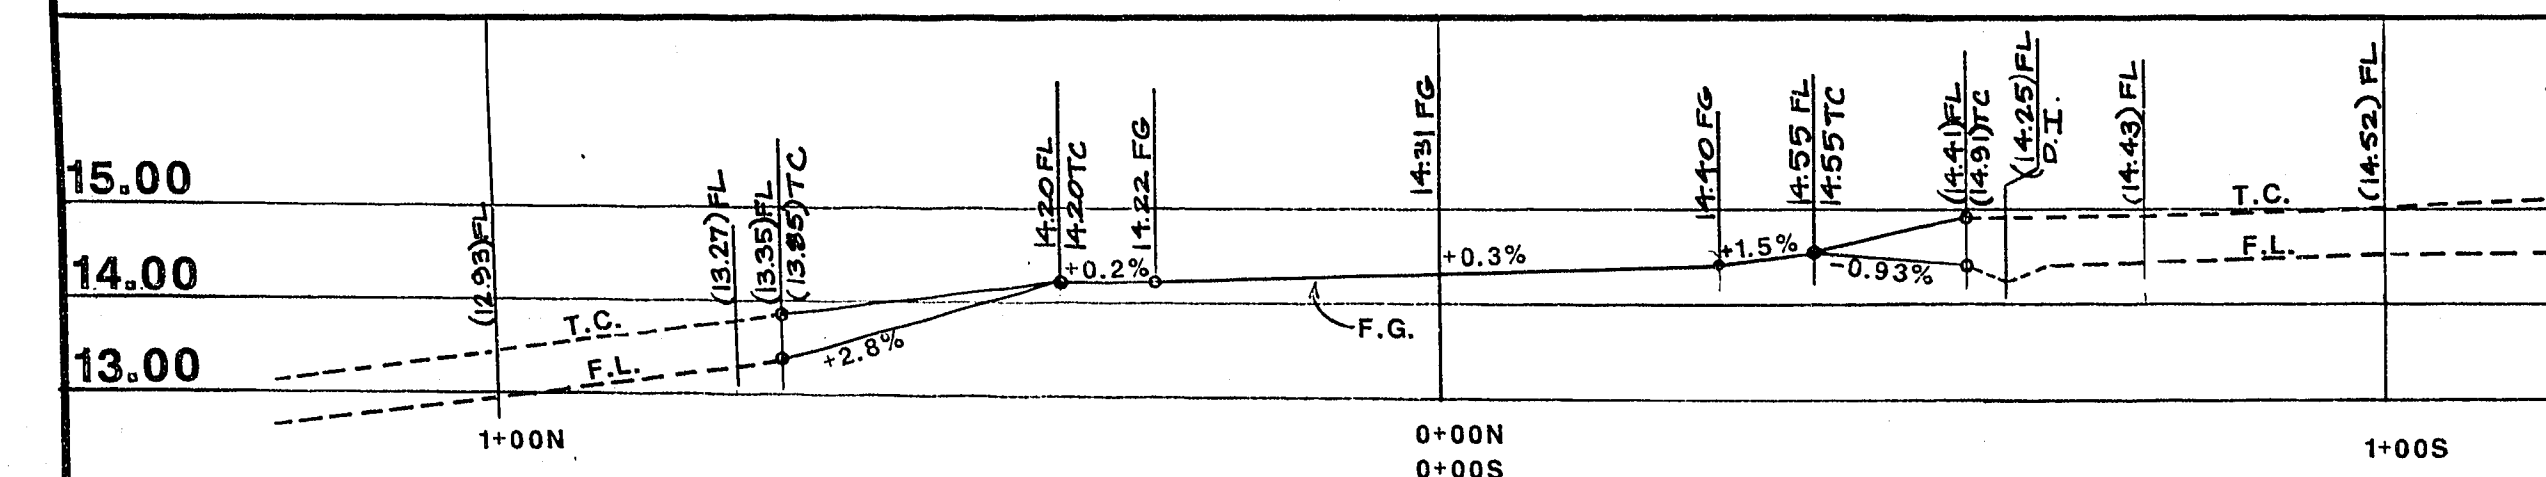

PROFILE C-C
(WEST F.L. OF CASINO CTR.)

SCALE: H: 1" = 20.0'
V: 1" = 2.0'

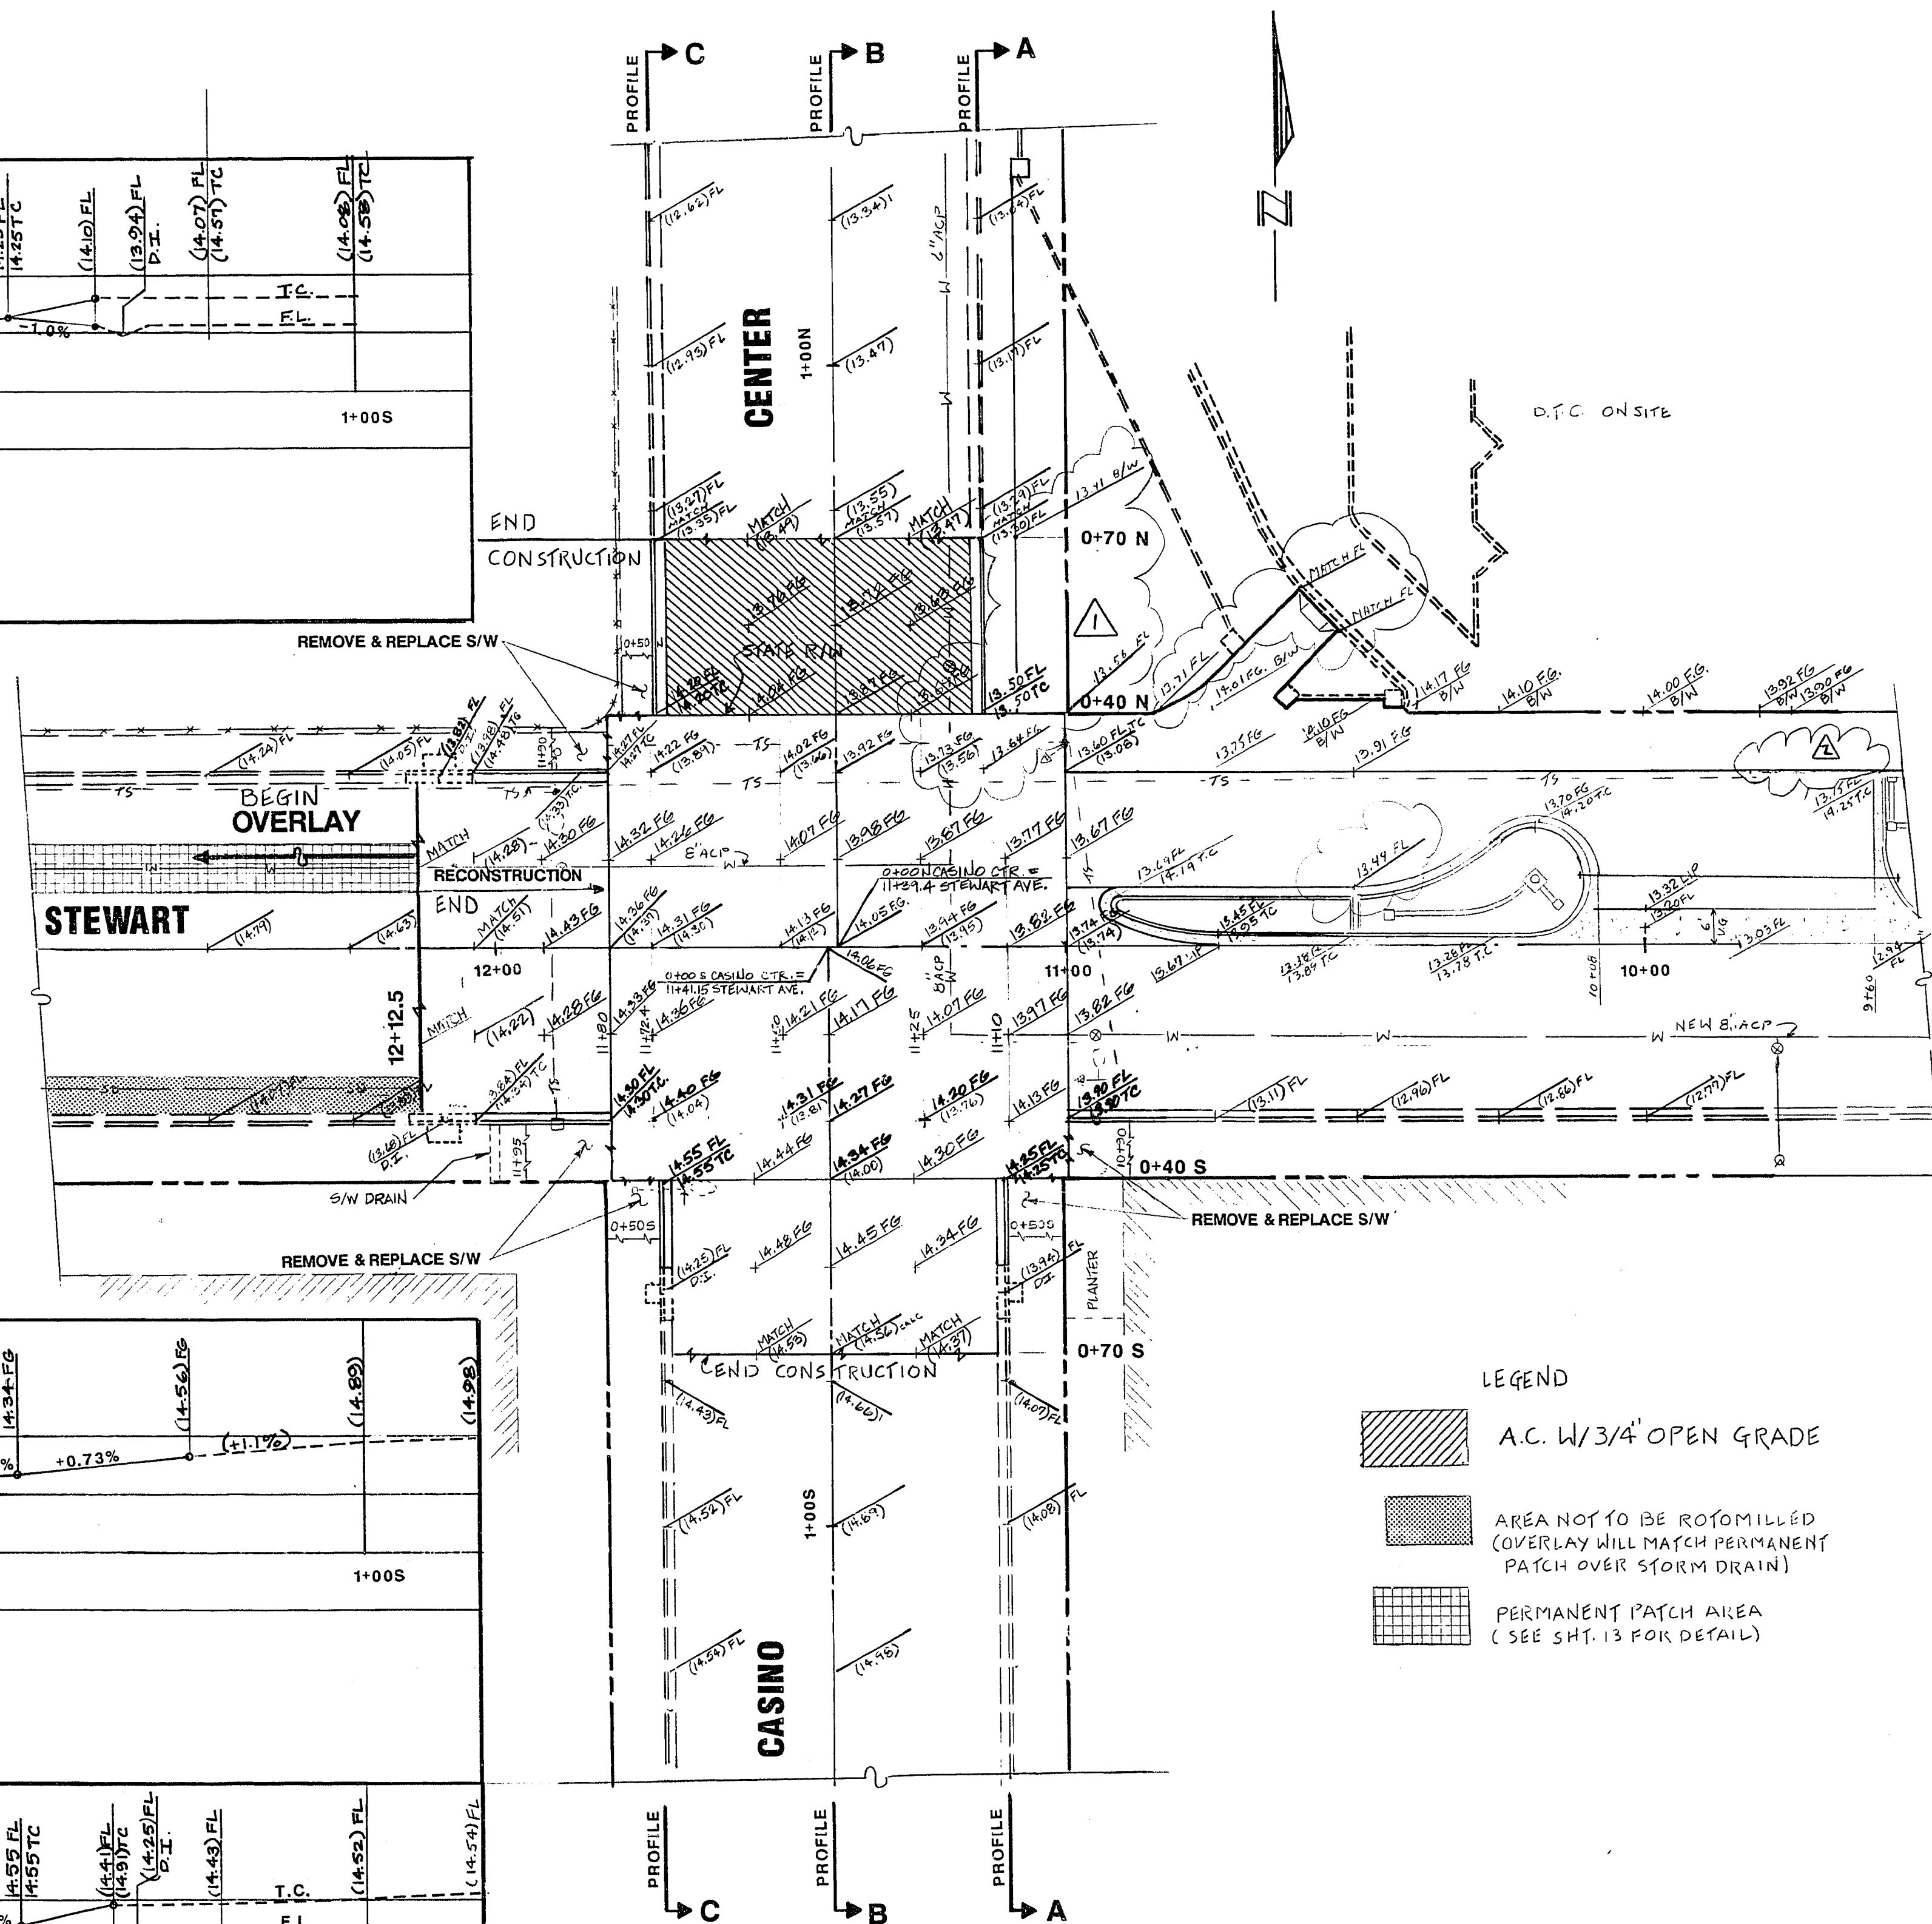

CONTRACT
DRAWING
APRIL 25, 1986

Avoid cutting underground
utility lines. It's costly.


Call
before you
Dig.

1-800-227-2600
UNDERGROUND SERVICE (USA)



Drawing no. 18
590-2E 51

Department of Public Services Engineering Design Division
DOWNTOWN TRANSPORTATION CENTER
OFFSITE IMPROVEMENTS
INTERSECTION -
STEWART AVE. & CASINO CENTER
GRADING PLAN AND PROFILE

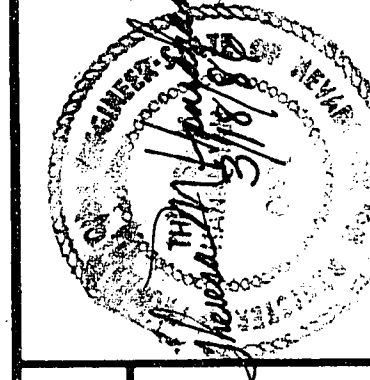

Scale (h) 1" = 20'
Scale (v) 1" = 2'
Fid. bk. no.
Design by NELSON STONE
Checked by NELSON STONE, J.D.B.
Drawn by NELSON STONE, J.D.B.
Approved by the City Engineer
Date

Revisions	Date
FROM LINE REVIEW	8/1/86
REVISED SIDEWALK	8/1/86

REVISED 8/5/86