




City of Las Vegas, Nevada
**Department of
Design and Development**
Thomas B. Graham, AICP, RLA, Director

ARCHITECTURAL DESIGN DIVISION
DESIGN BY: DATE: 1/8/87
DRAWN BY:

REVISIONS	DATE

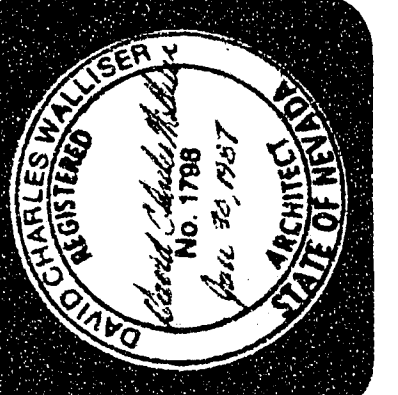


DOWNTOWN TRANSPORTATION CENTER AMENITIES


Tivoli Lighting Elevations

PROJECT NO.
WU9040
DRAWING NO.
590-2F
SHEET 30 OF 41
A30

NOTE: ----- INDICATES
TIVOLI LIGHT TUBE INSTALLED ON
EXISTING BUILDING AS PER
MANUFACTURERS RECOMMENDATIONS
AND AS SHOWN IN DETAILS INDICATED.

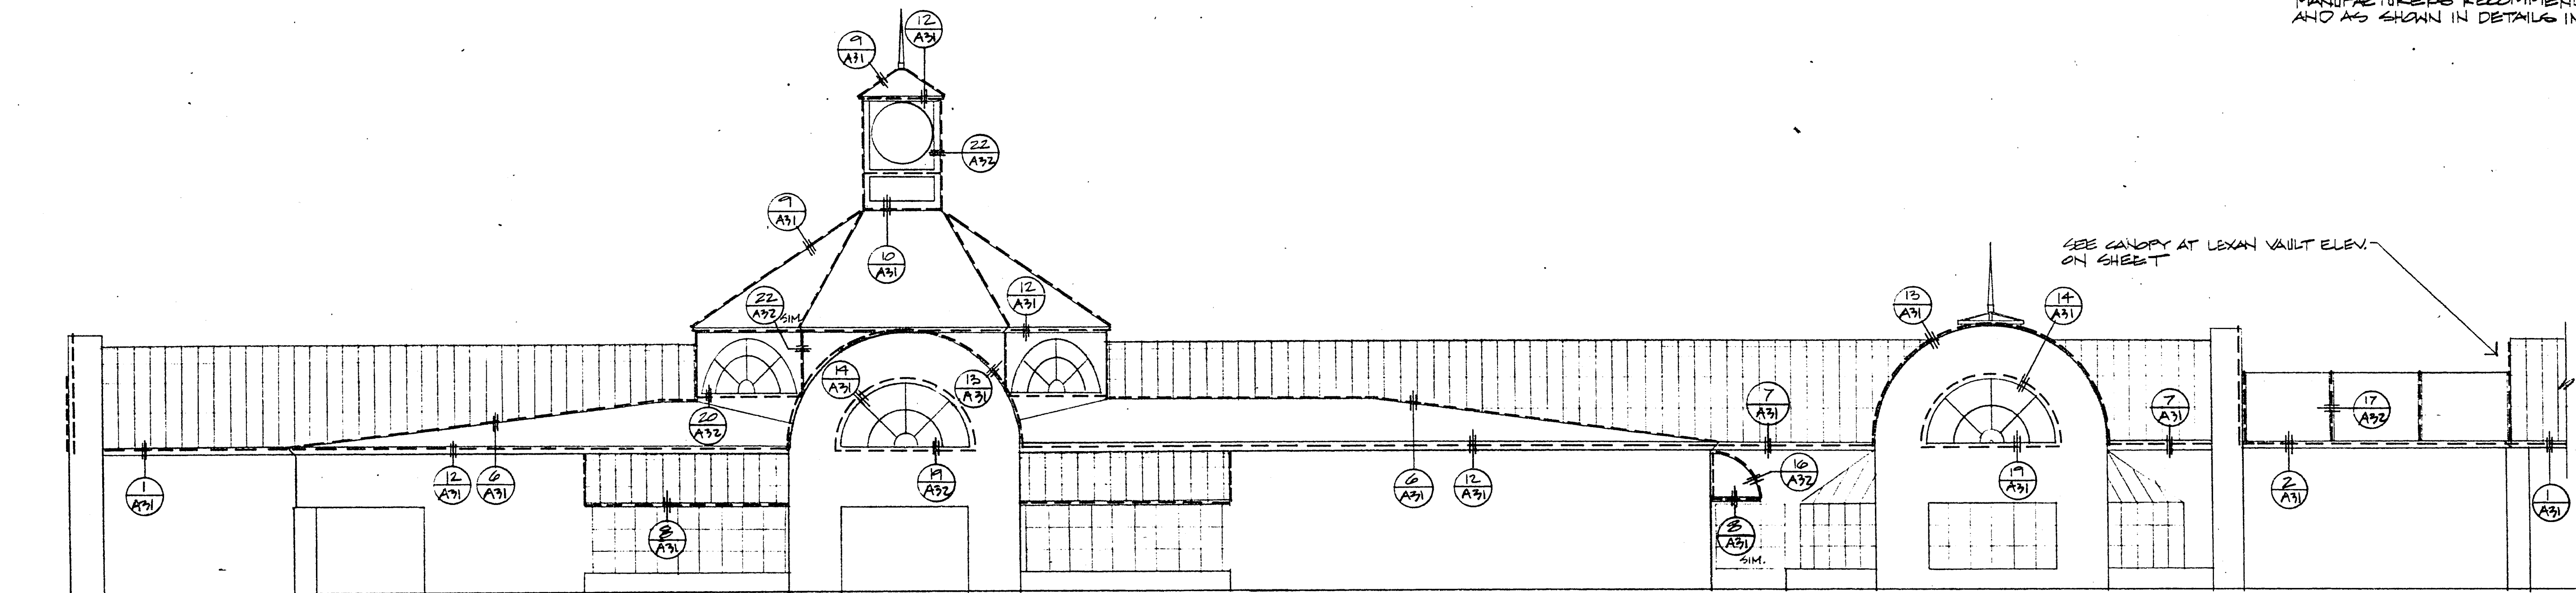

WEST ELEVATION
3/8" = 1'-0"

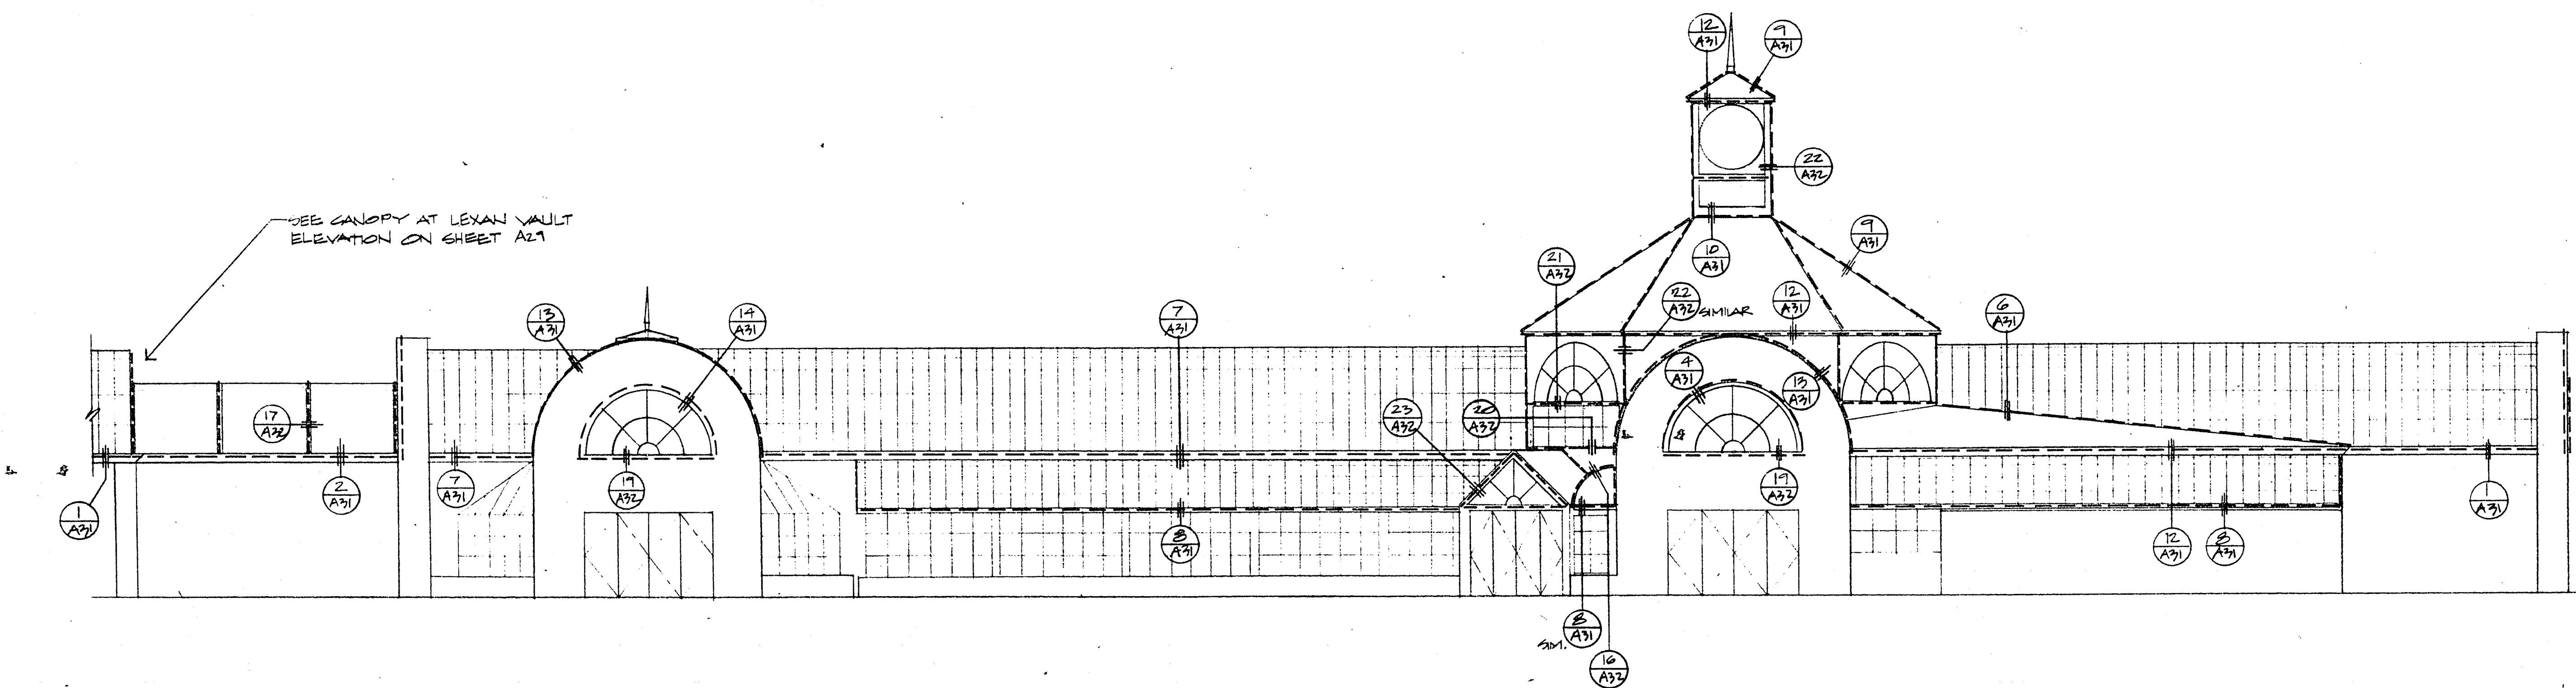

EAST ELEVATION
3/8" = 1'-0"

30-13-34