



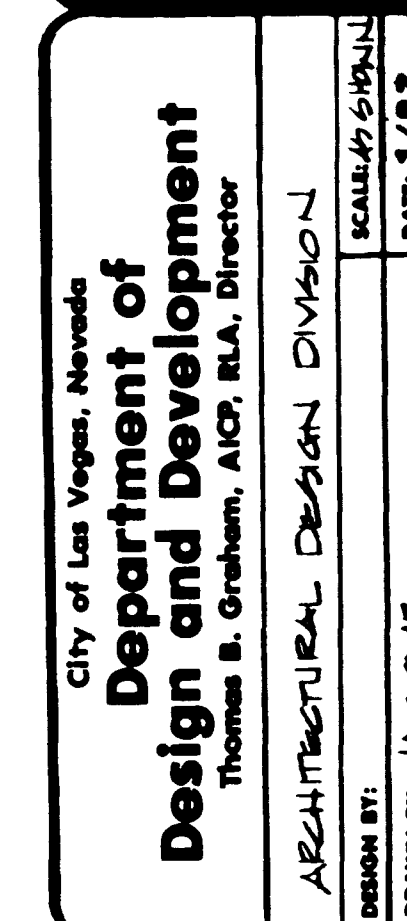

DOWNTOWN TRANSPORTATION CENTER AMENITIES

Tivoli Lighting Plan & Elevations

PROJECT NO.
WU9040
DRAWING NO.
590-2F
SHEET 29 OF 41
A29

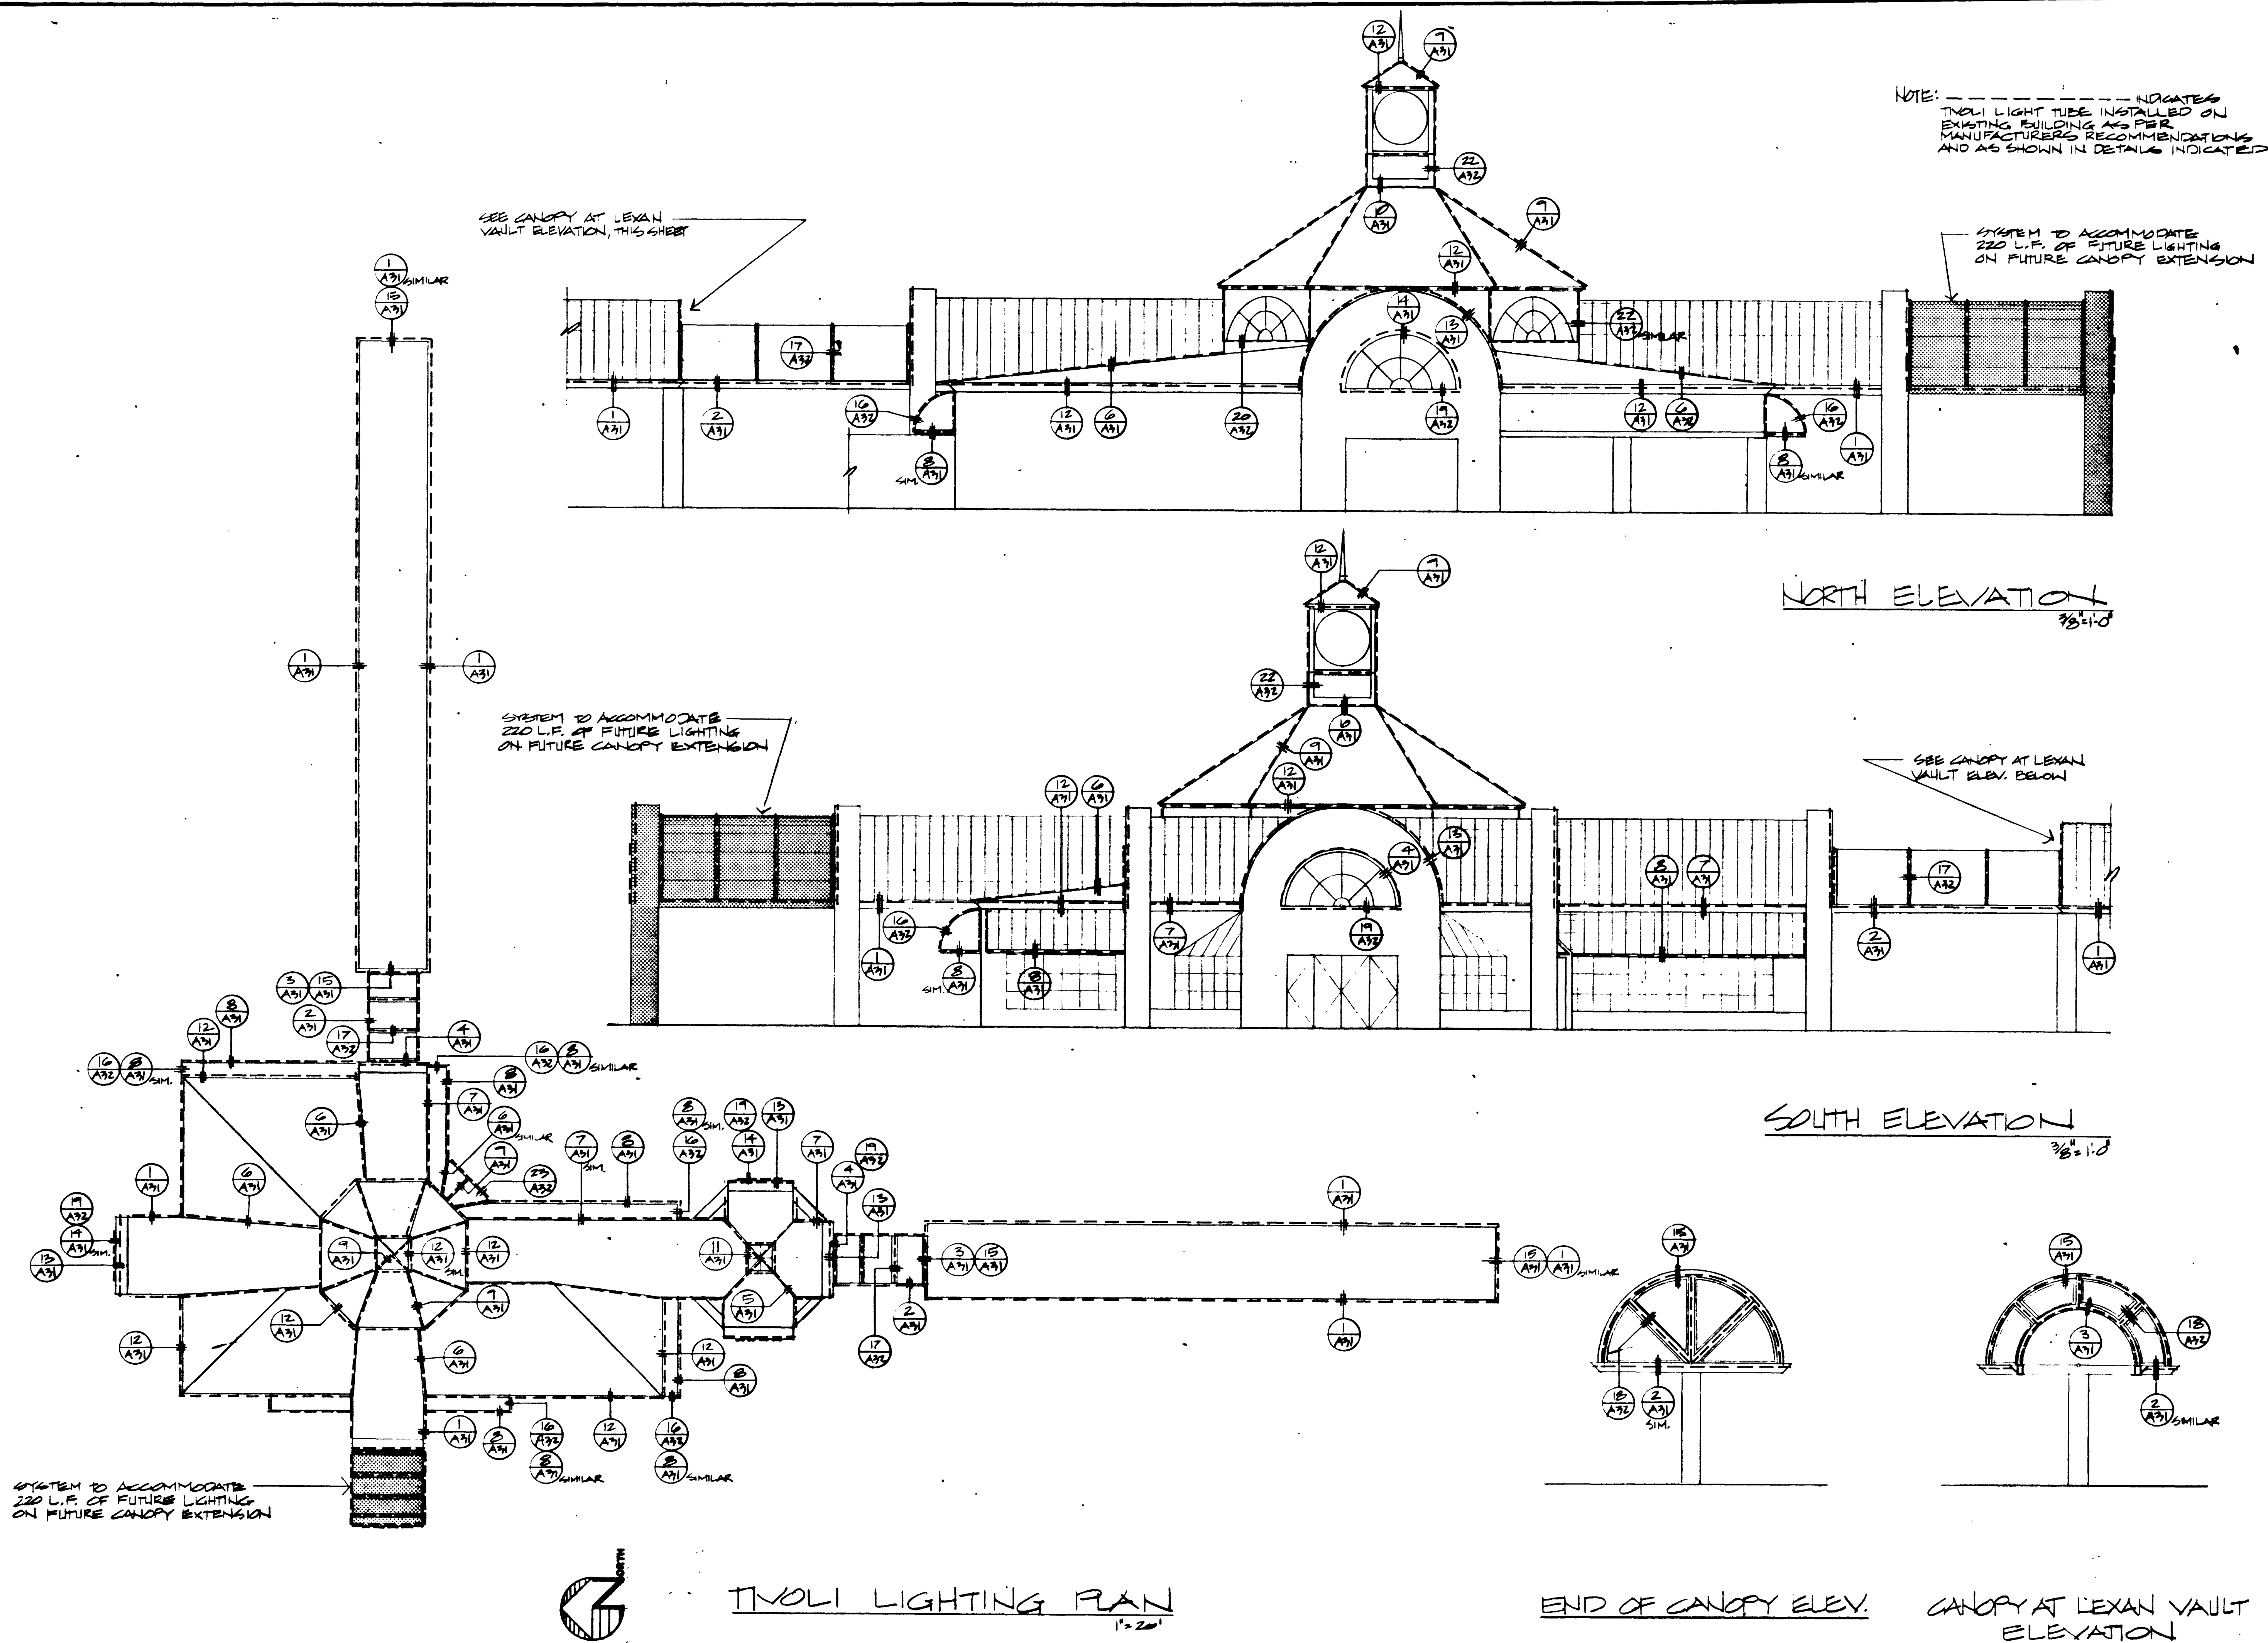

1668

