

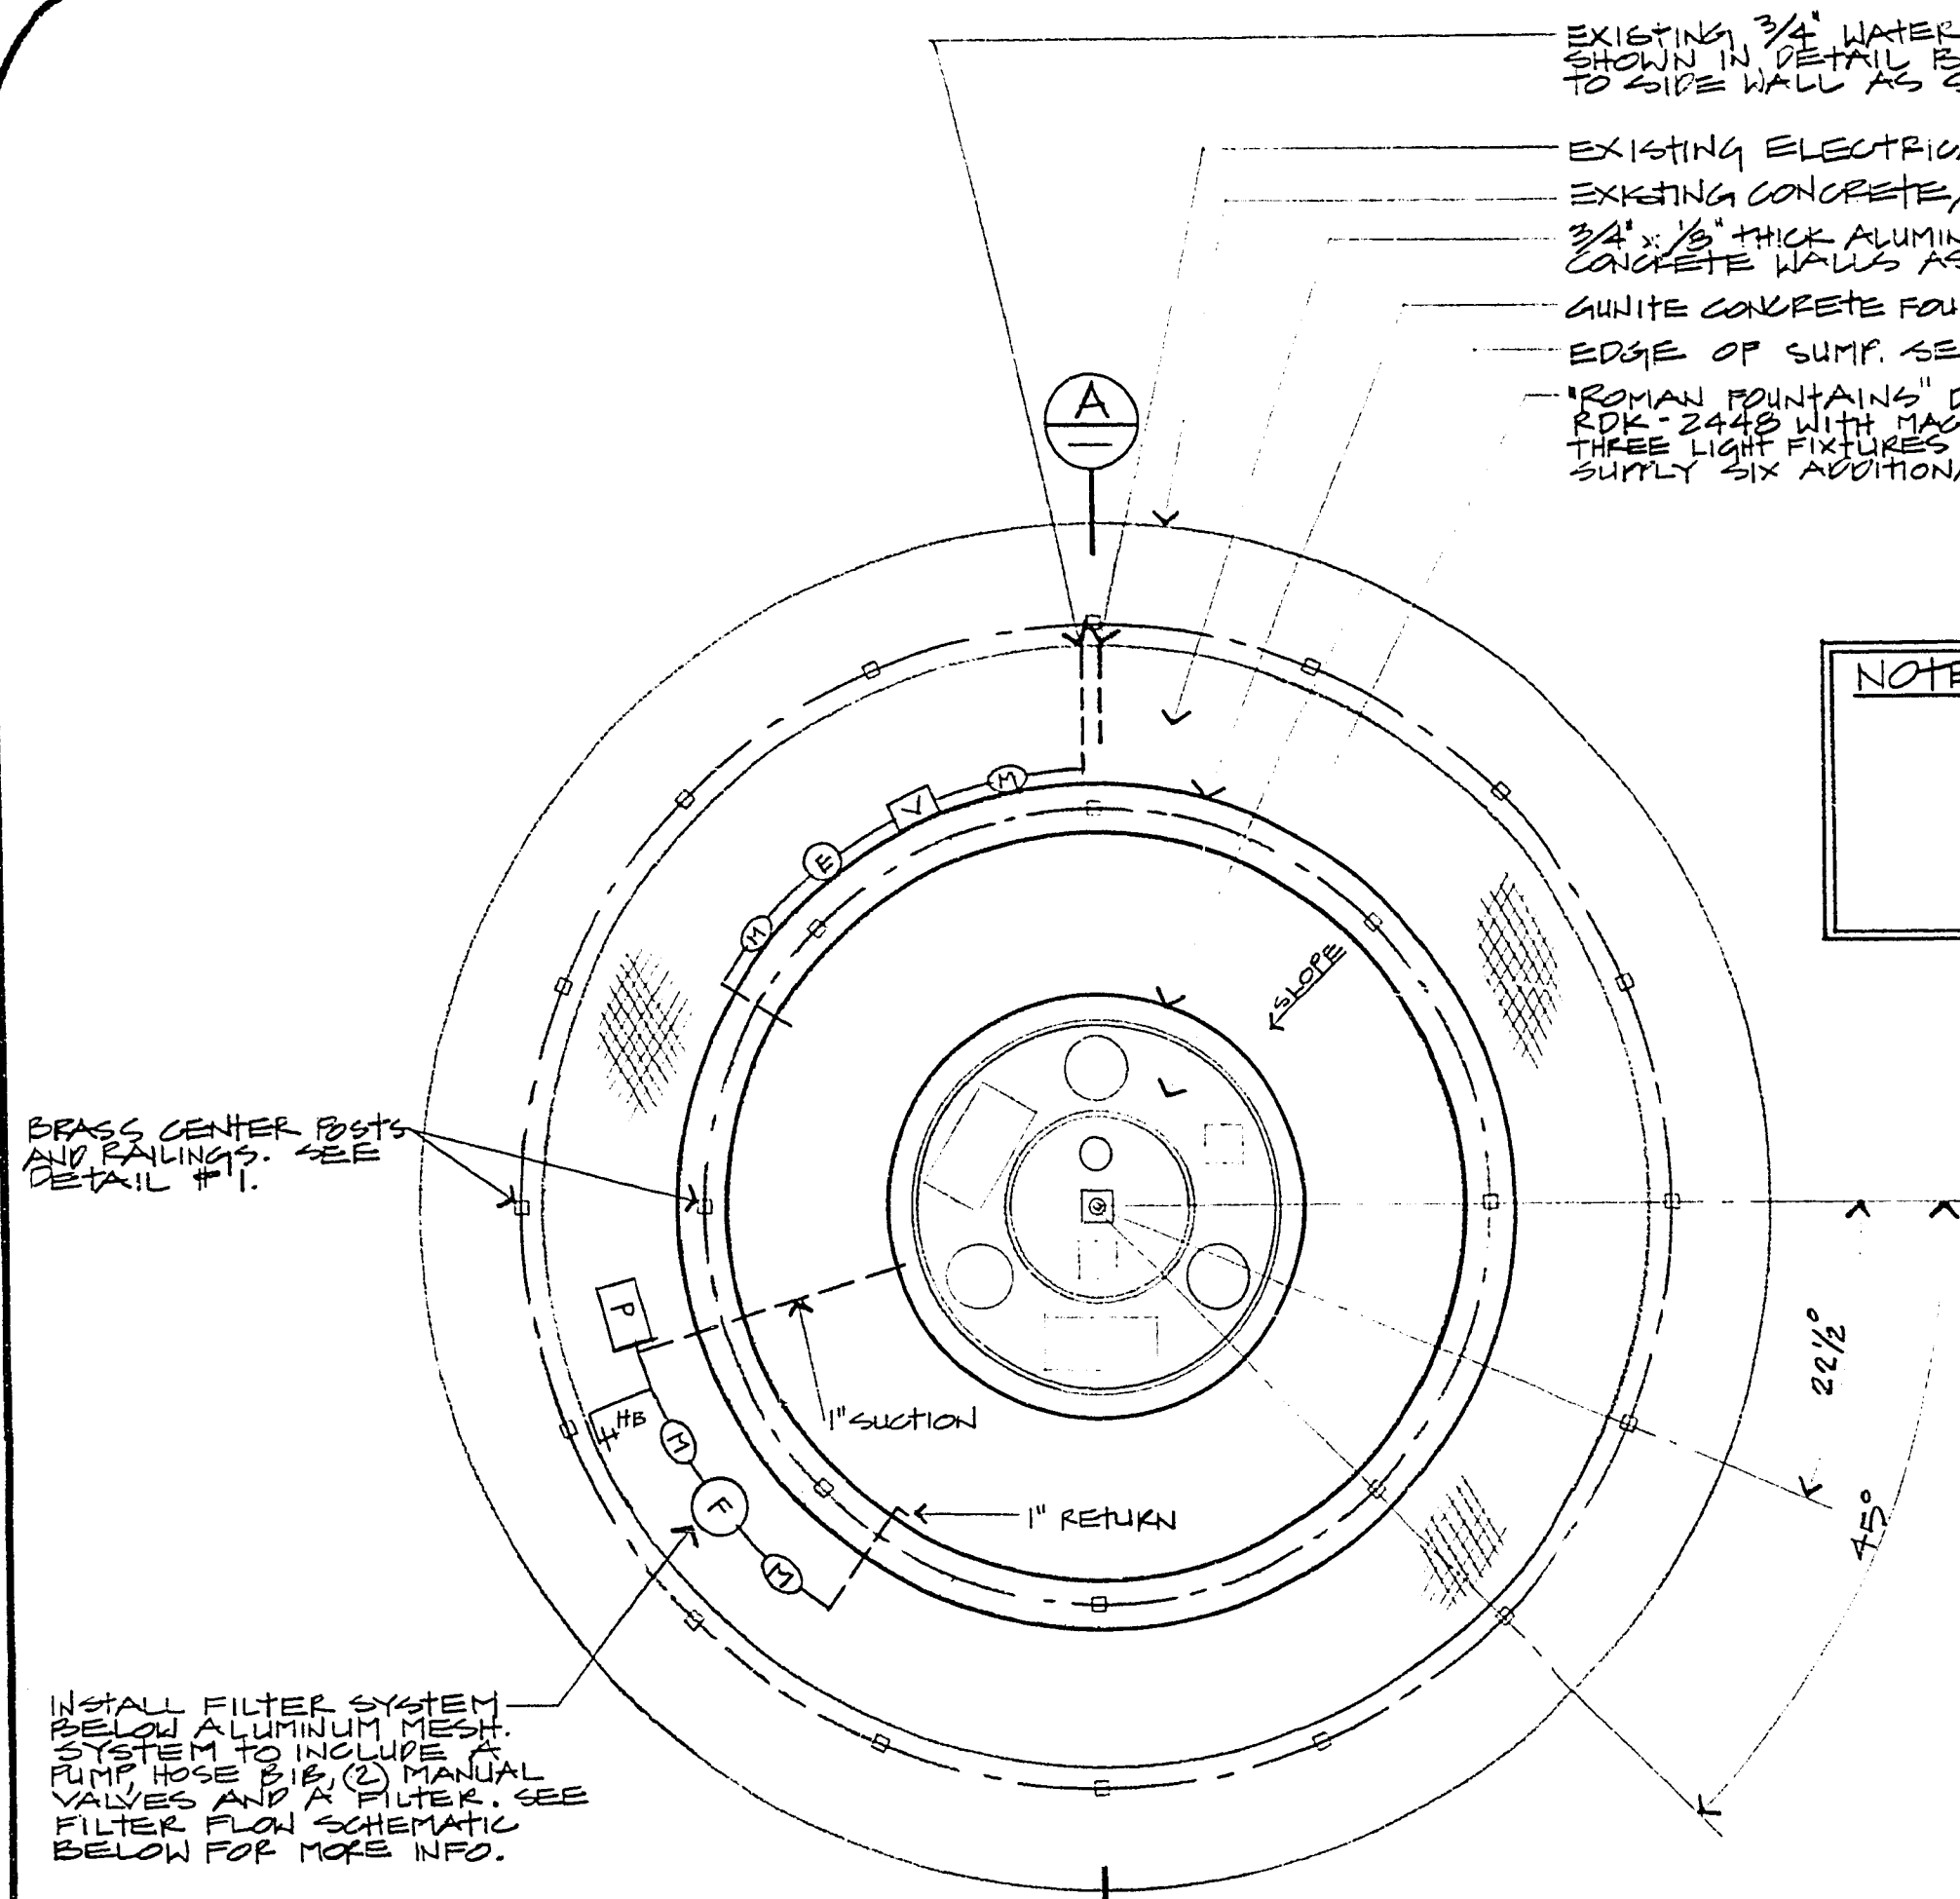


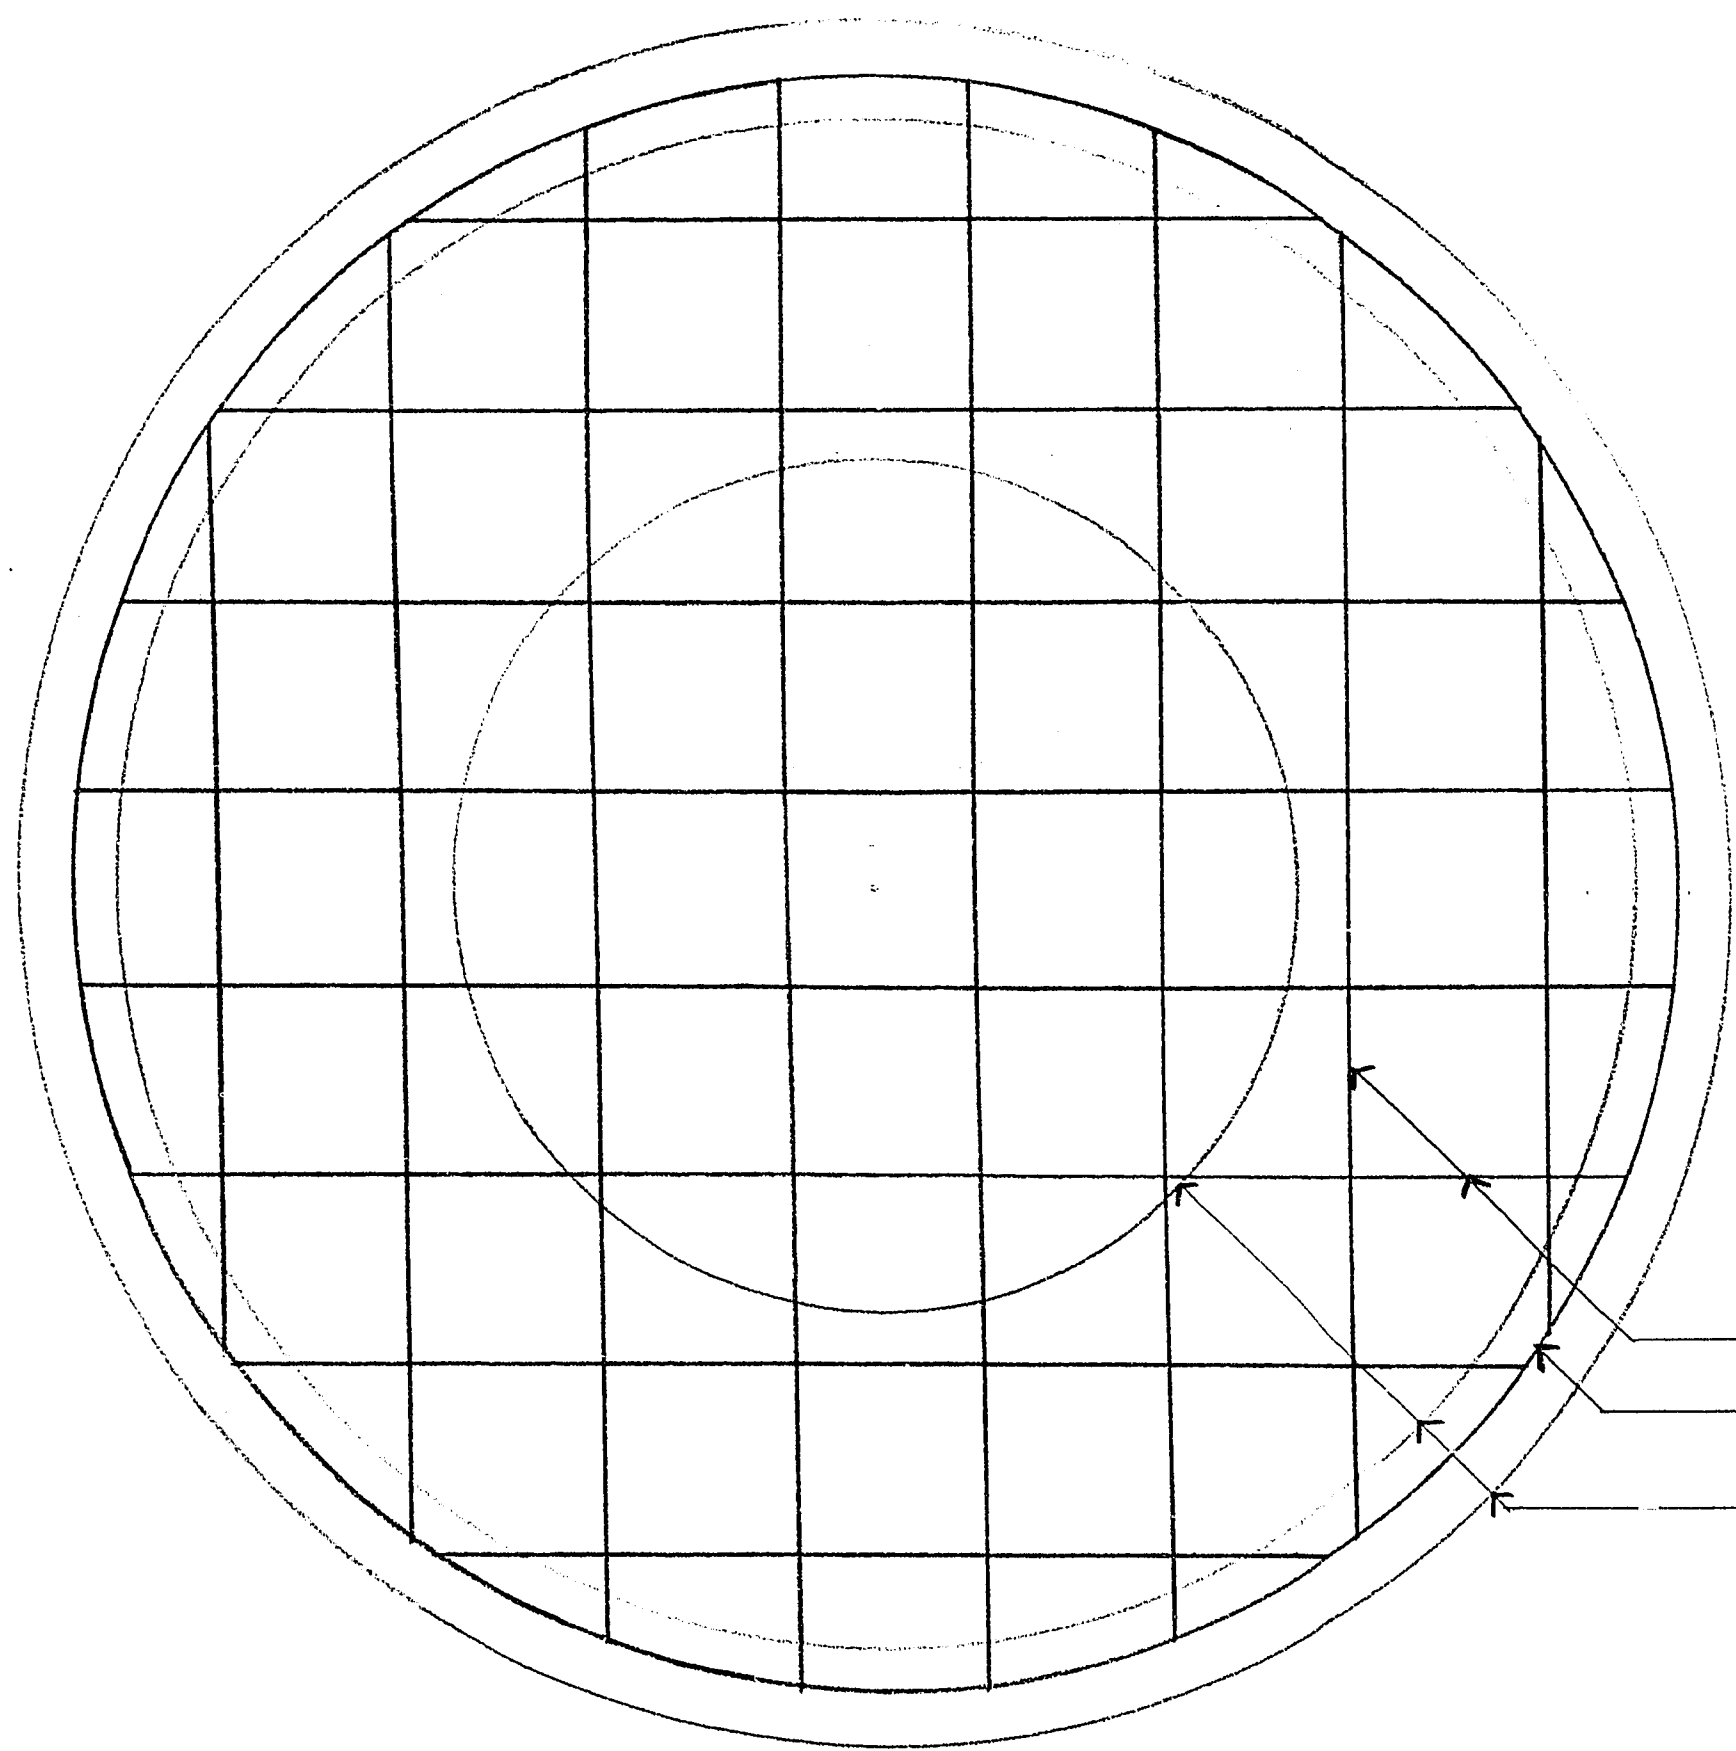

FOUNTAIN PLAN VIEW

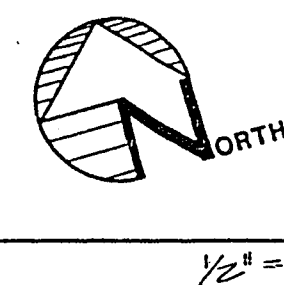

FOUNTAIN REBAR PLAN

- EXISTING 3/4" WATER LINE. CONNECT TO VALVES AS SHOWN IN DETAIL BELOW. SECURE VACUUM BREAKER TO SIDE WALL AS SHOWN IN DETAIL.
- EXISTING ELECTRICAL CONDUIT.
- EXISTING CONCRETE/BRICK VENEER PLASTER (SHAVED).
- 3/4" x 1/8" THICK ALUMINUM FLATTENED MESH. ATTACH TO CONCRETE WALLS AS SHOWN IN CROSS SECTION.
- WHITE CONCRETE FOUNTAIN RING WITH CERAMIC TILE.
- EDGE OF SUMP. SEE CROSS SECTION.
- "ROMAN FOUNTAIN" DUAL SPRAY RING KIT, MODEL RDK-2448 WITH MACHINED BRASS SPRAY RINGS. THREE LIGHT FIXTURES WITH 50W FLOOD BLUE LENS. SUPPLY SIX ADDITIONAL LENSES - (3) GREEN & (3) AMBER.


NOTE: FOUNTAIN EQUIPMENT SHOWN IN PLAN VIEW & CROSS SECTION 'A' IS FOR DIAGRAMMATICAL PURPOSES ONLY. CONTRACTOR TO SUBMIT SHOP DRAWINGS FOR APPROVAL PRIOR TO CONSTRUCTION.

SEE ELECTRICAL SHEETS E2 & E4 FOR WORK ASSOCIATED WITH THIS SHEET.


EXISTING 3/4" WATER LINE AND ELECTRICAL CONDUIT. SEE PLUMBING DETAILS THIS SHEET AND ELECTRICAL FOR MORE INFORMATION.

EXISTING CONCRETE FOOTING.


SEE DETAIL BELOW FOR PLUMBING EQUIPMENT IN THIS SPACE.

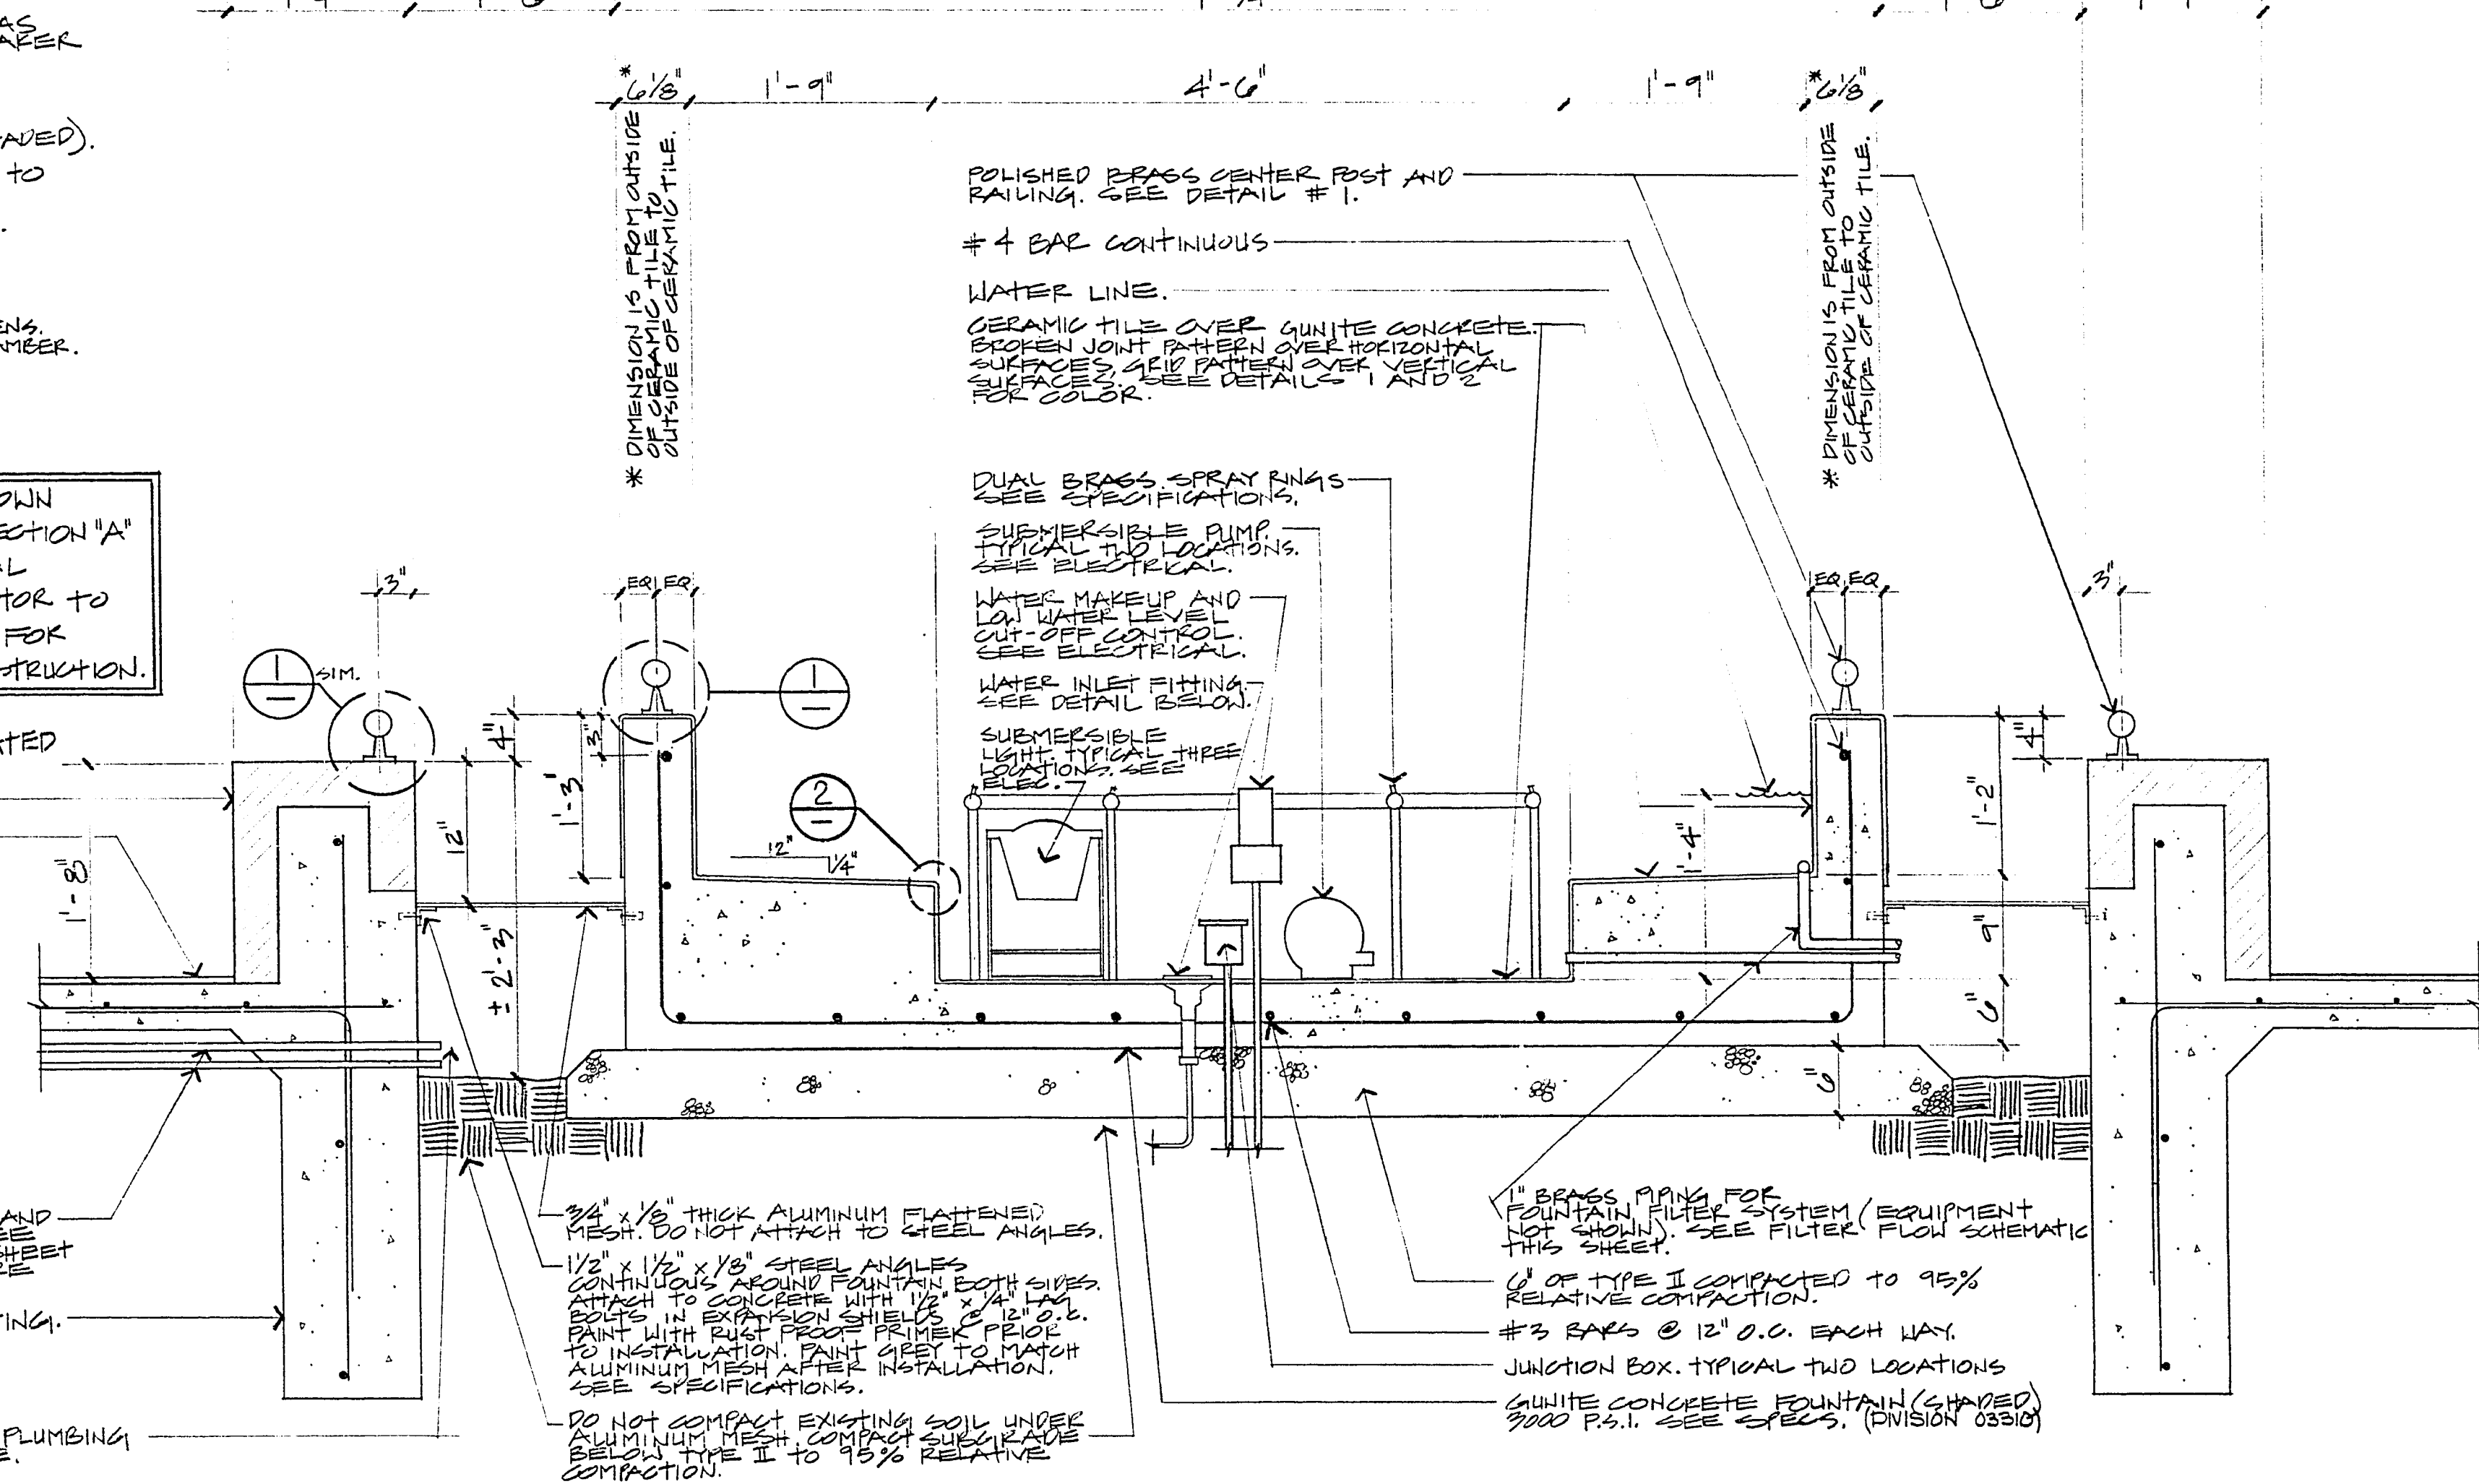

CROSS SECTION

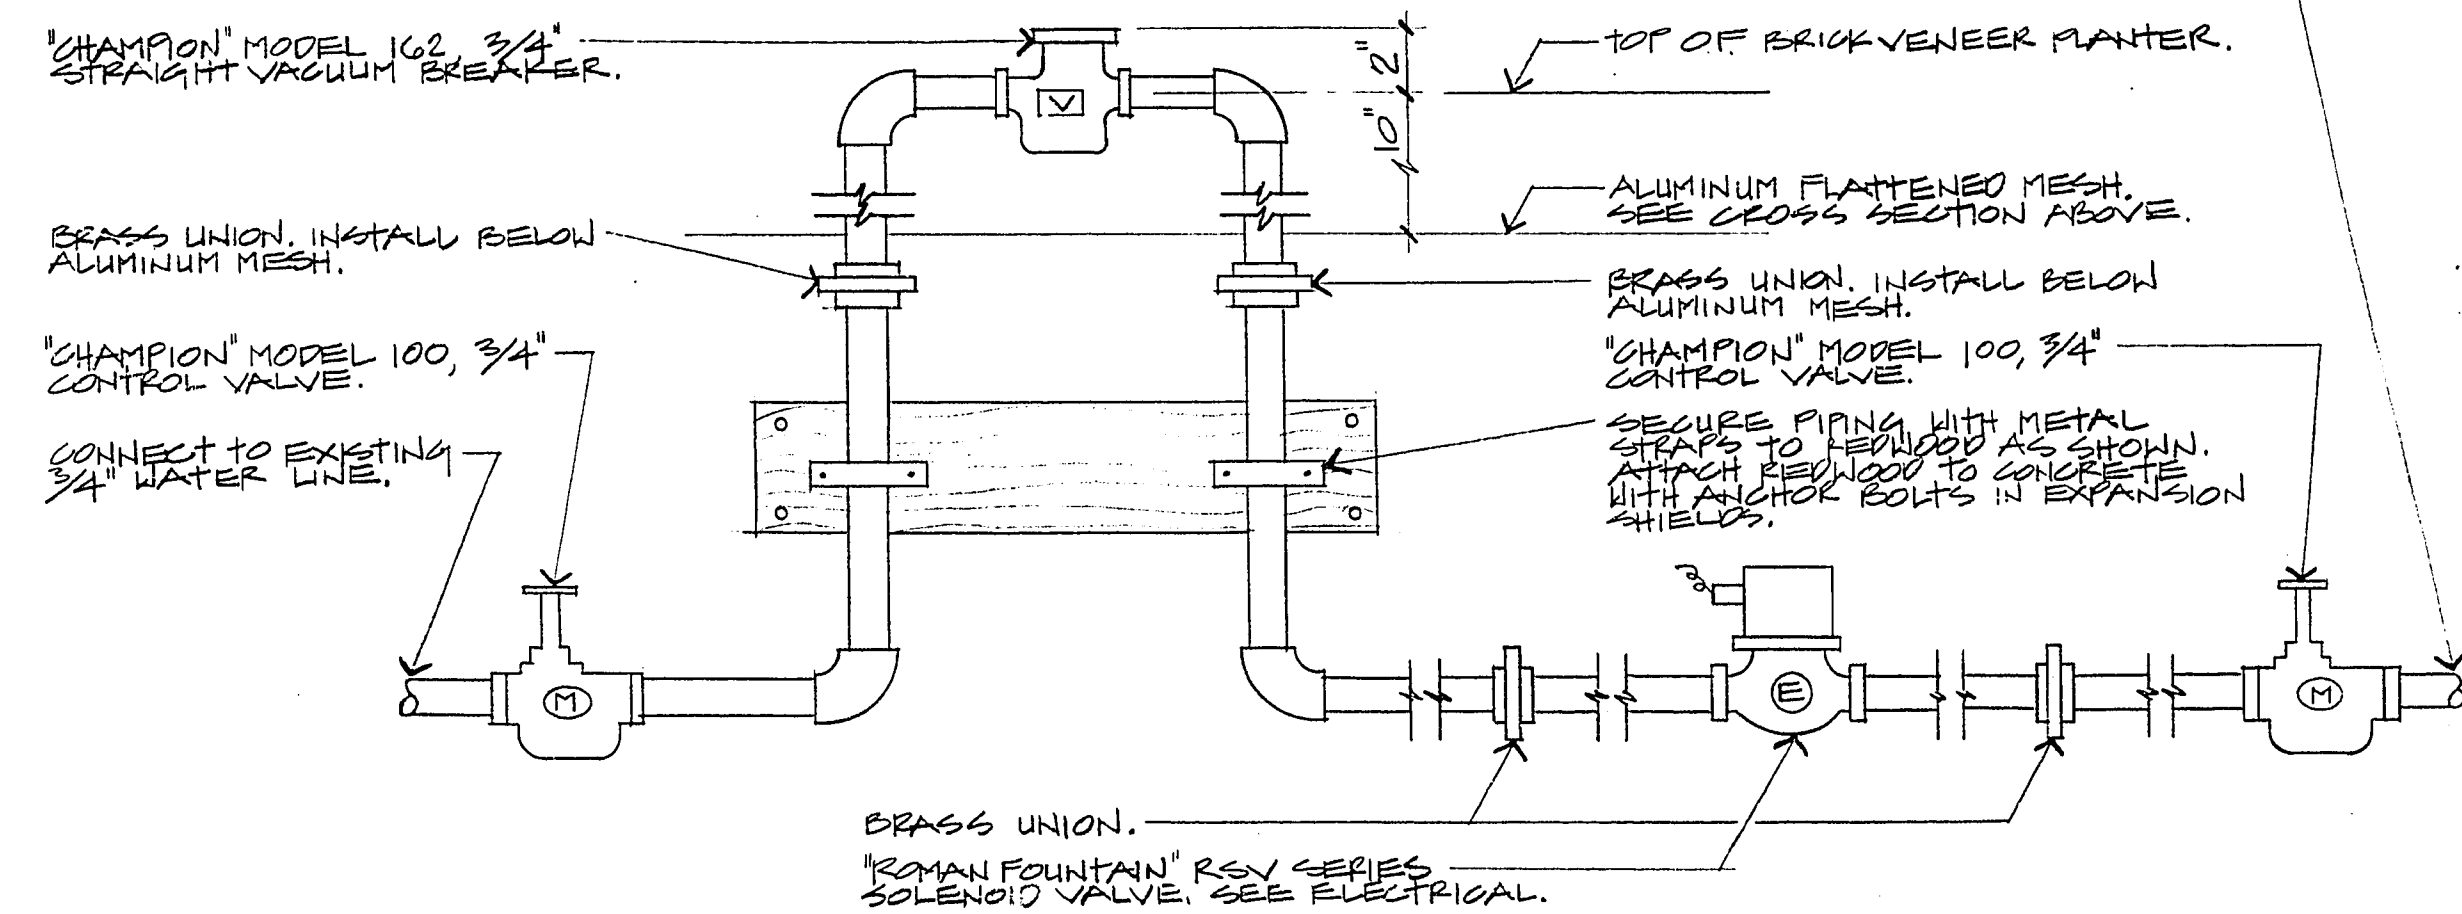


PLUMBING DETAIL

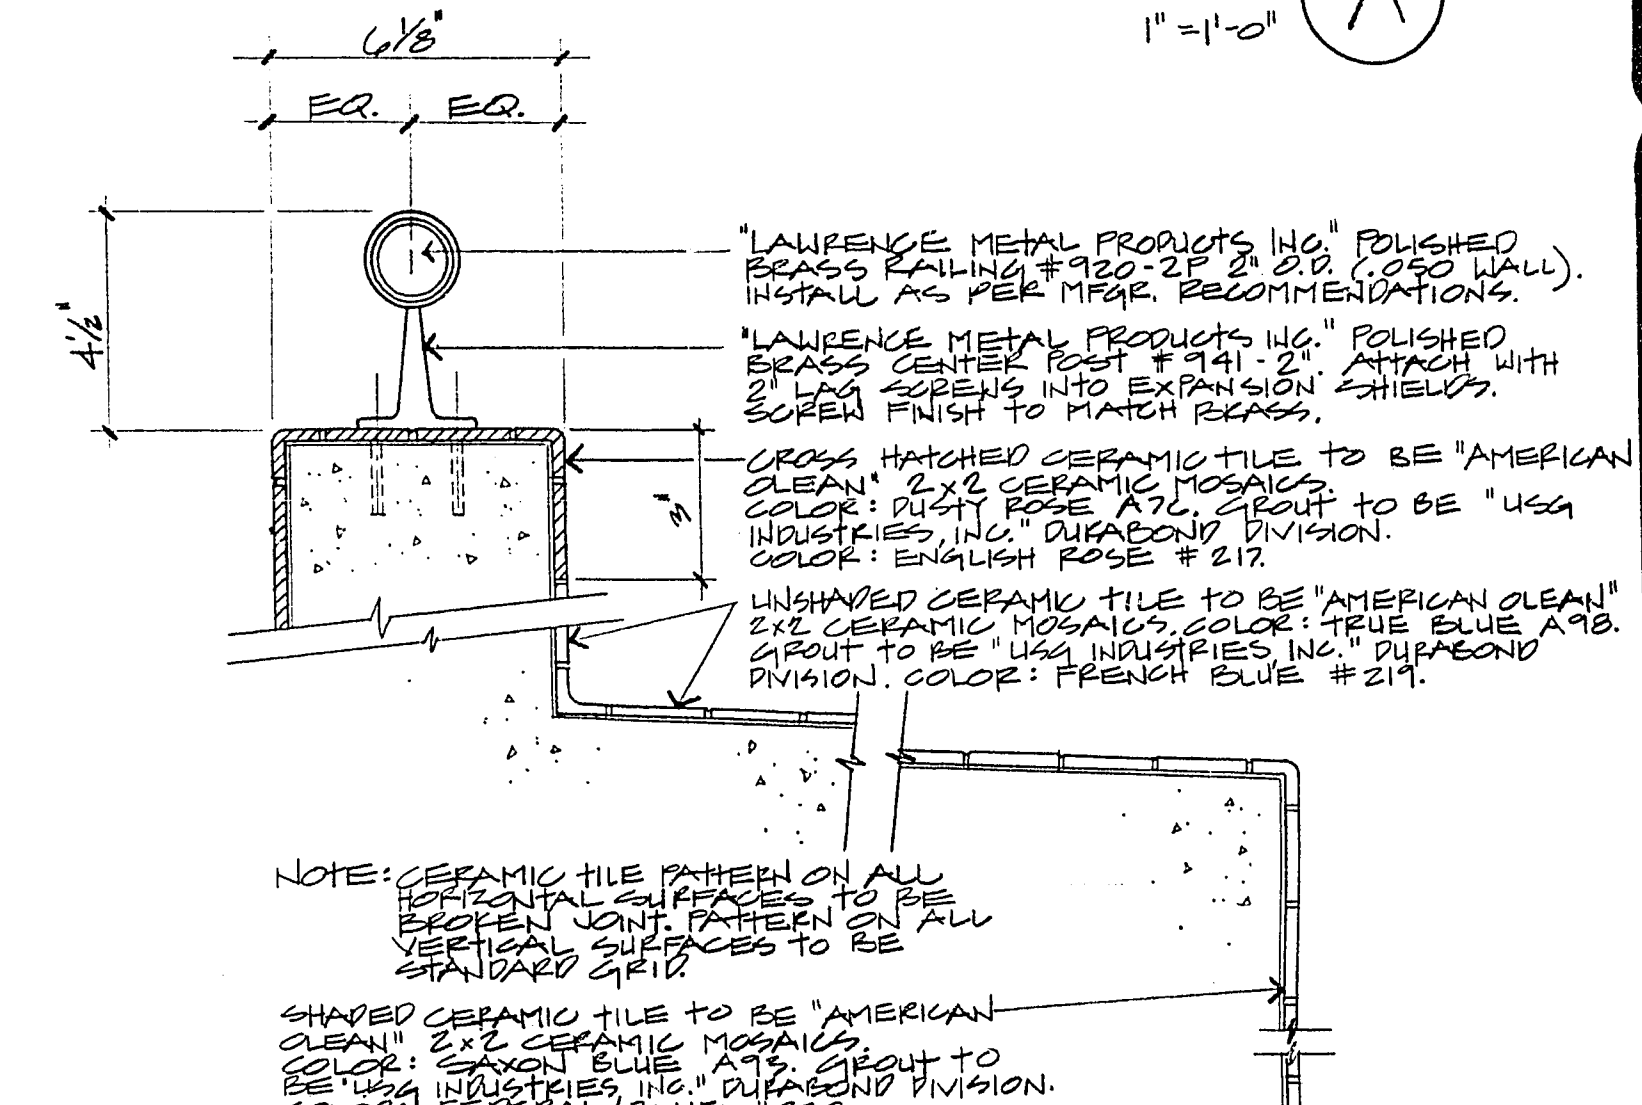

DETAIL 1

DETAIL 2

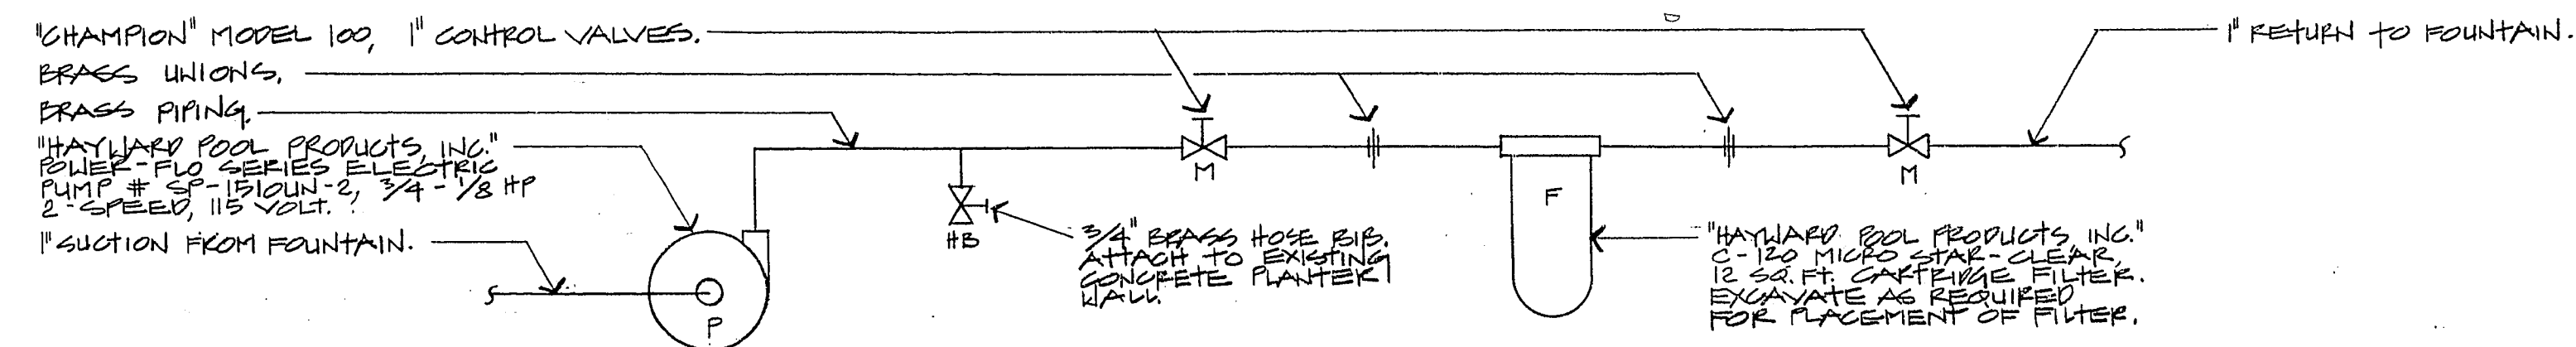

FILTER FLOW SCHEMATIC


ALL EQUIPMENT TO BE INSTALLED BELOW ALUMINUM MESH.

NO SCALE



City of Las Vegas, Nevada
Department of Design and Development
 Thomas B. Graham, AICP, RLA, Director

REVISIONS	DATE

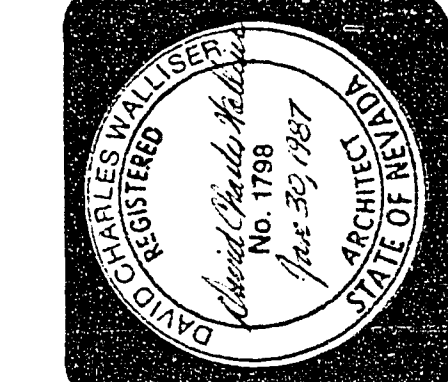

DOWNTOWN TRANSPORTATION CENTER AMENITIES

Display Fountain Plan & Details

BID GROUP # 4 ADDITIVE ITEM # 1

PROJECT NO.
WU9040

DRAWING NO.
590-2F

SHEET 24 OF 41

A24

30-13-28