


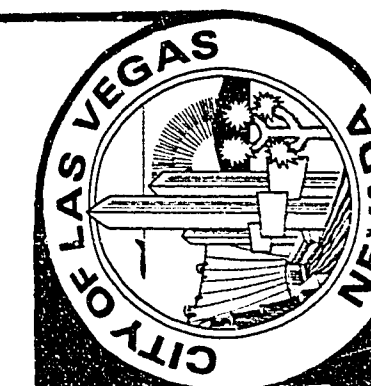

City of Las Vegas, Nevada
**Department of
Design and Development**
Thomas B. Graham, AICP, R.A., Director

DESIGN BY: DATE: 1/87
DRAWN BY:

REVISIONS
DATE





DOWNTOWN TRANSPORTATION CENTER AMENITIES


Miscellaneous Cabinet Details

PROJECT NO.
WU9040
DRAWING NO.
590-2F
SHEET 21 OF 41
A21


30-13-25

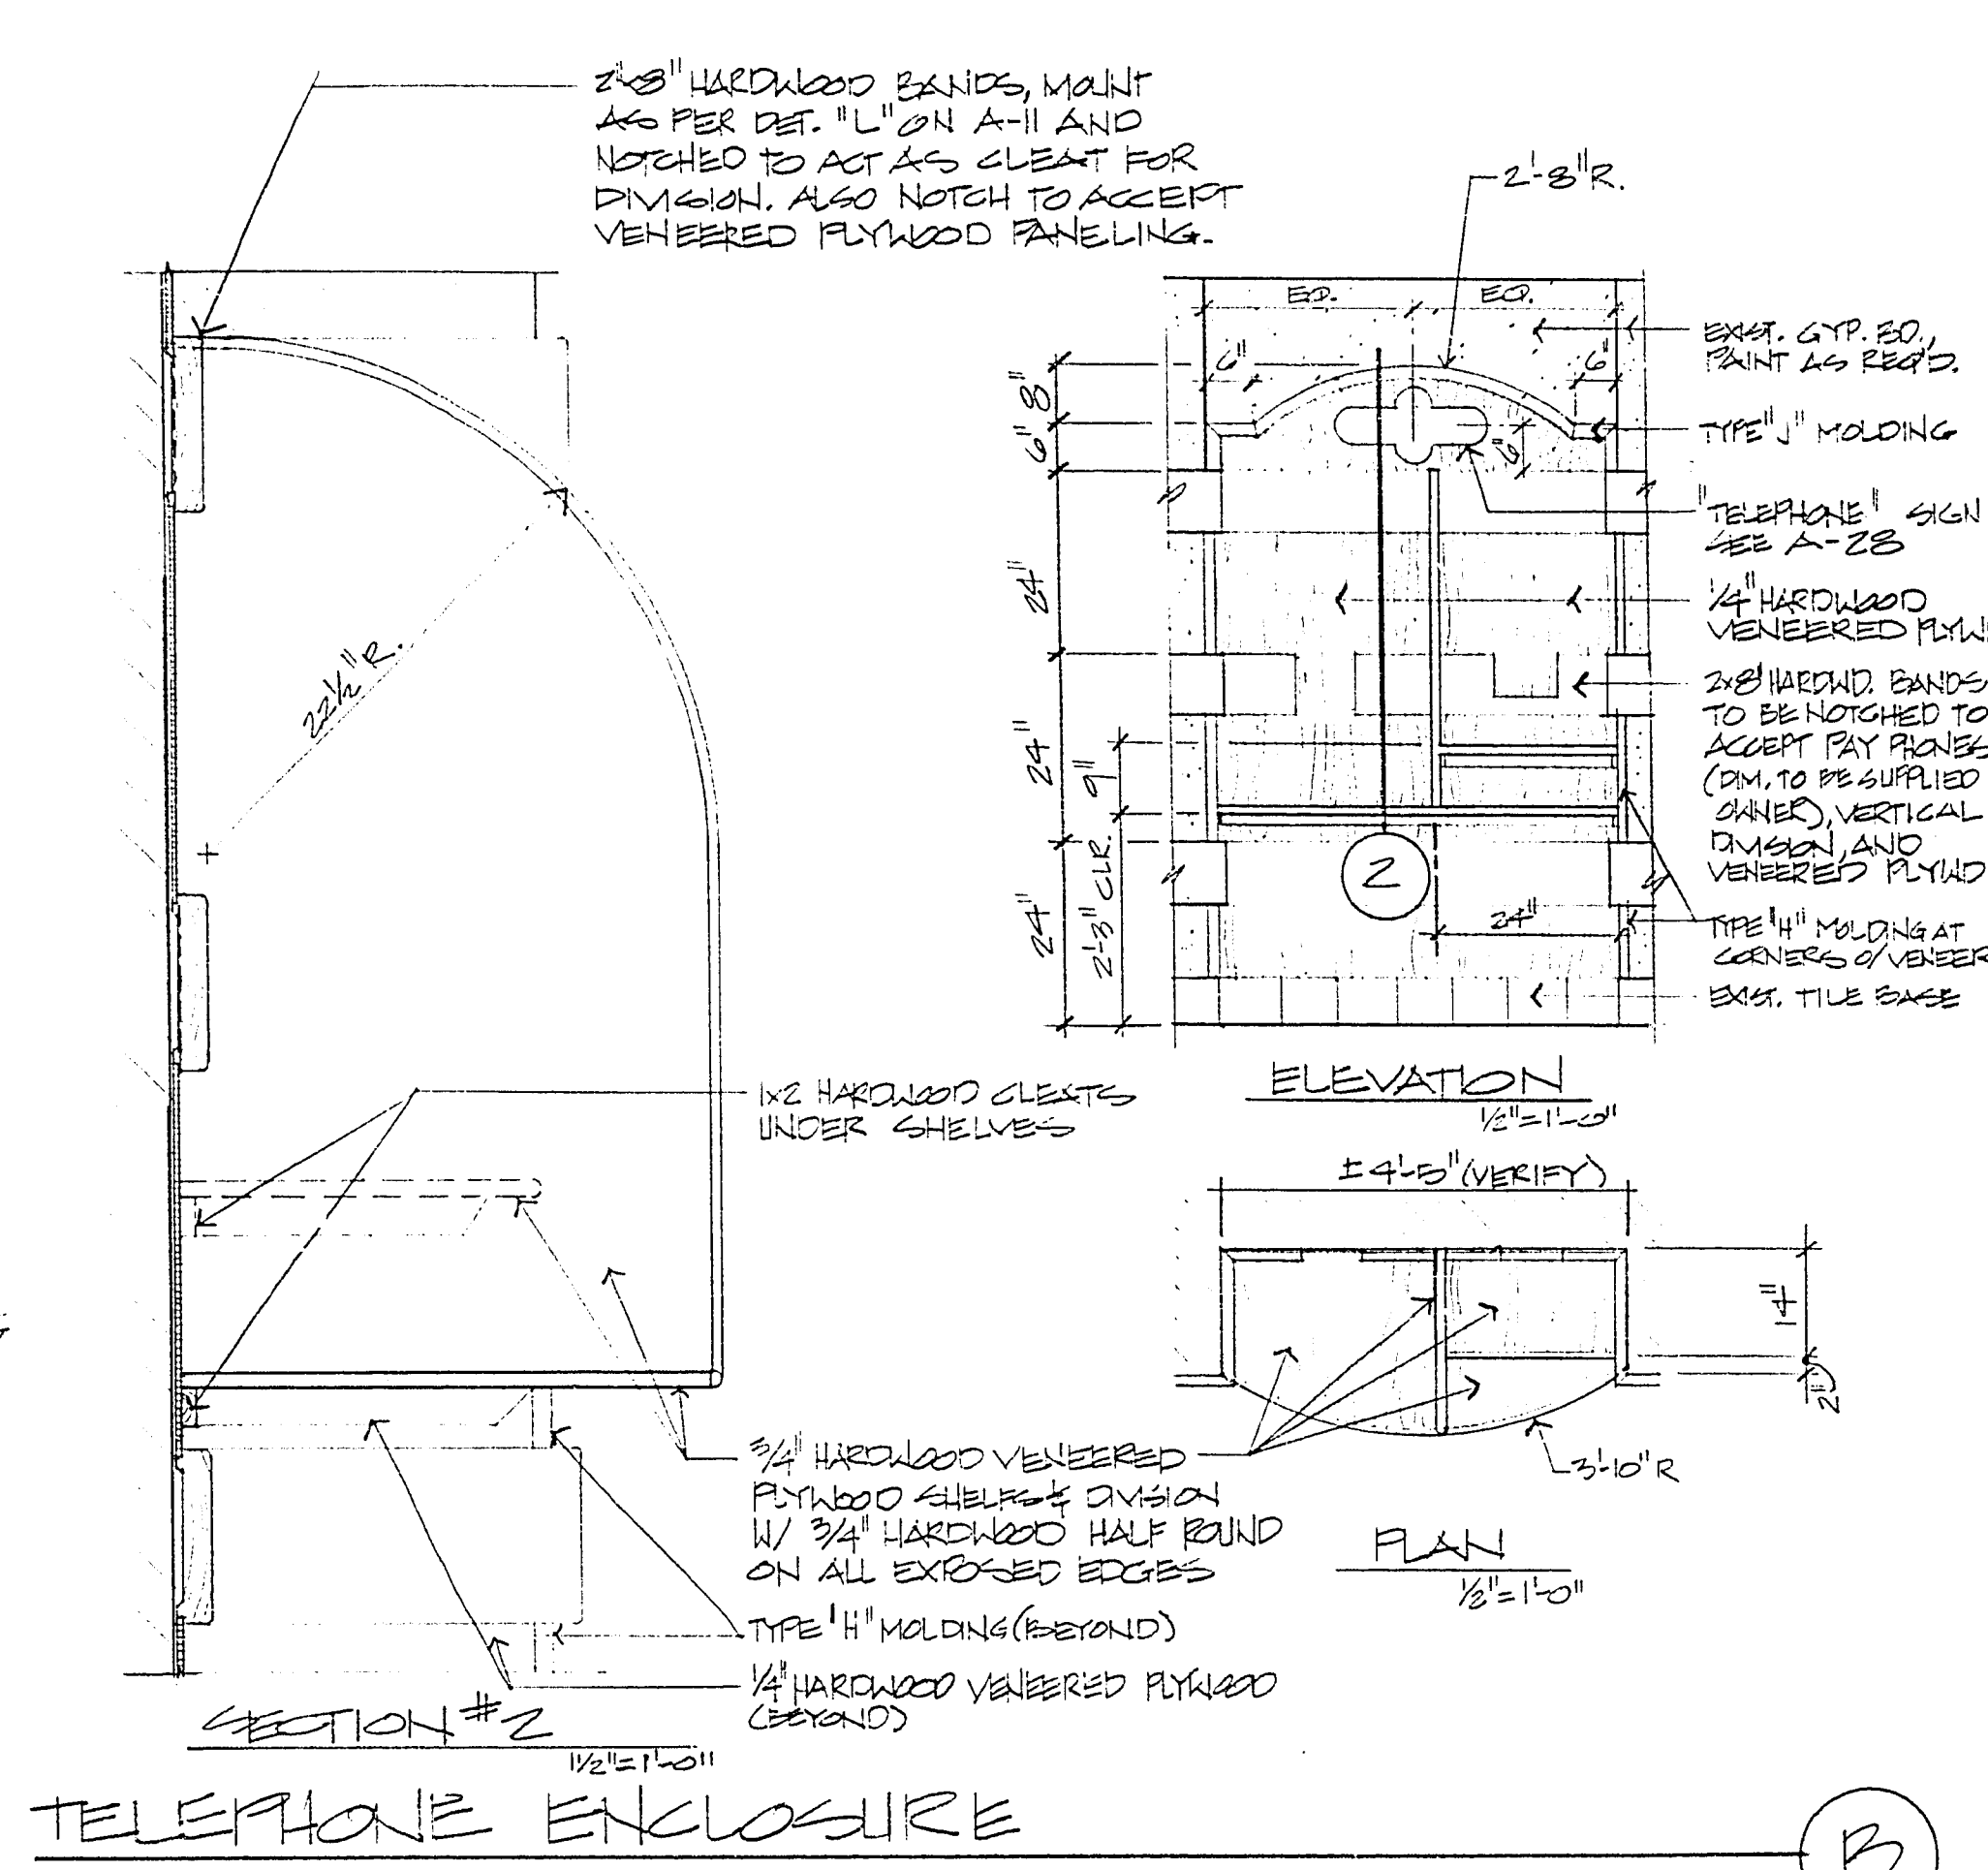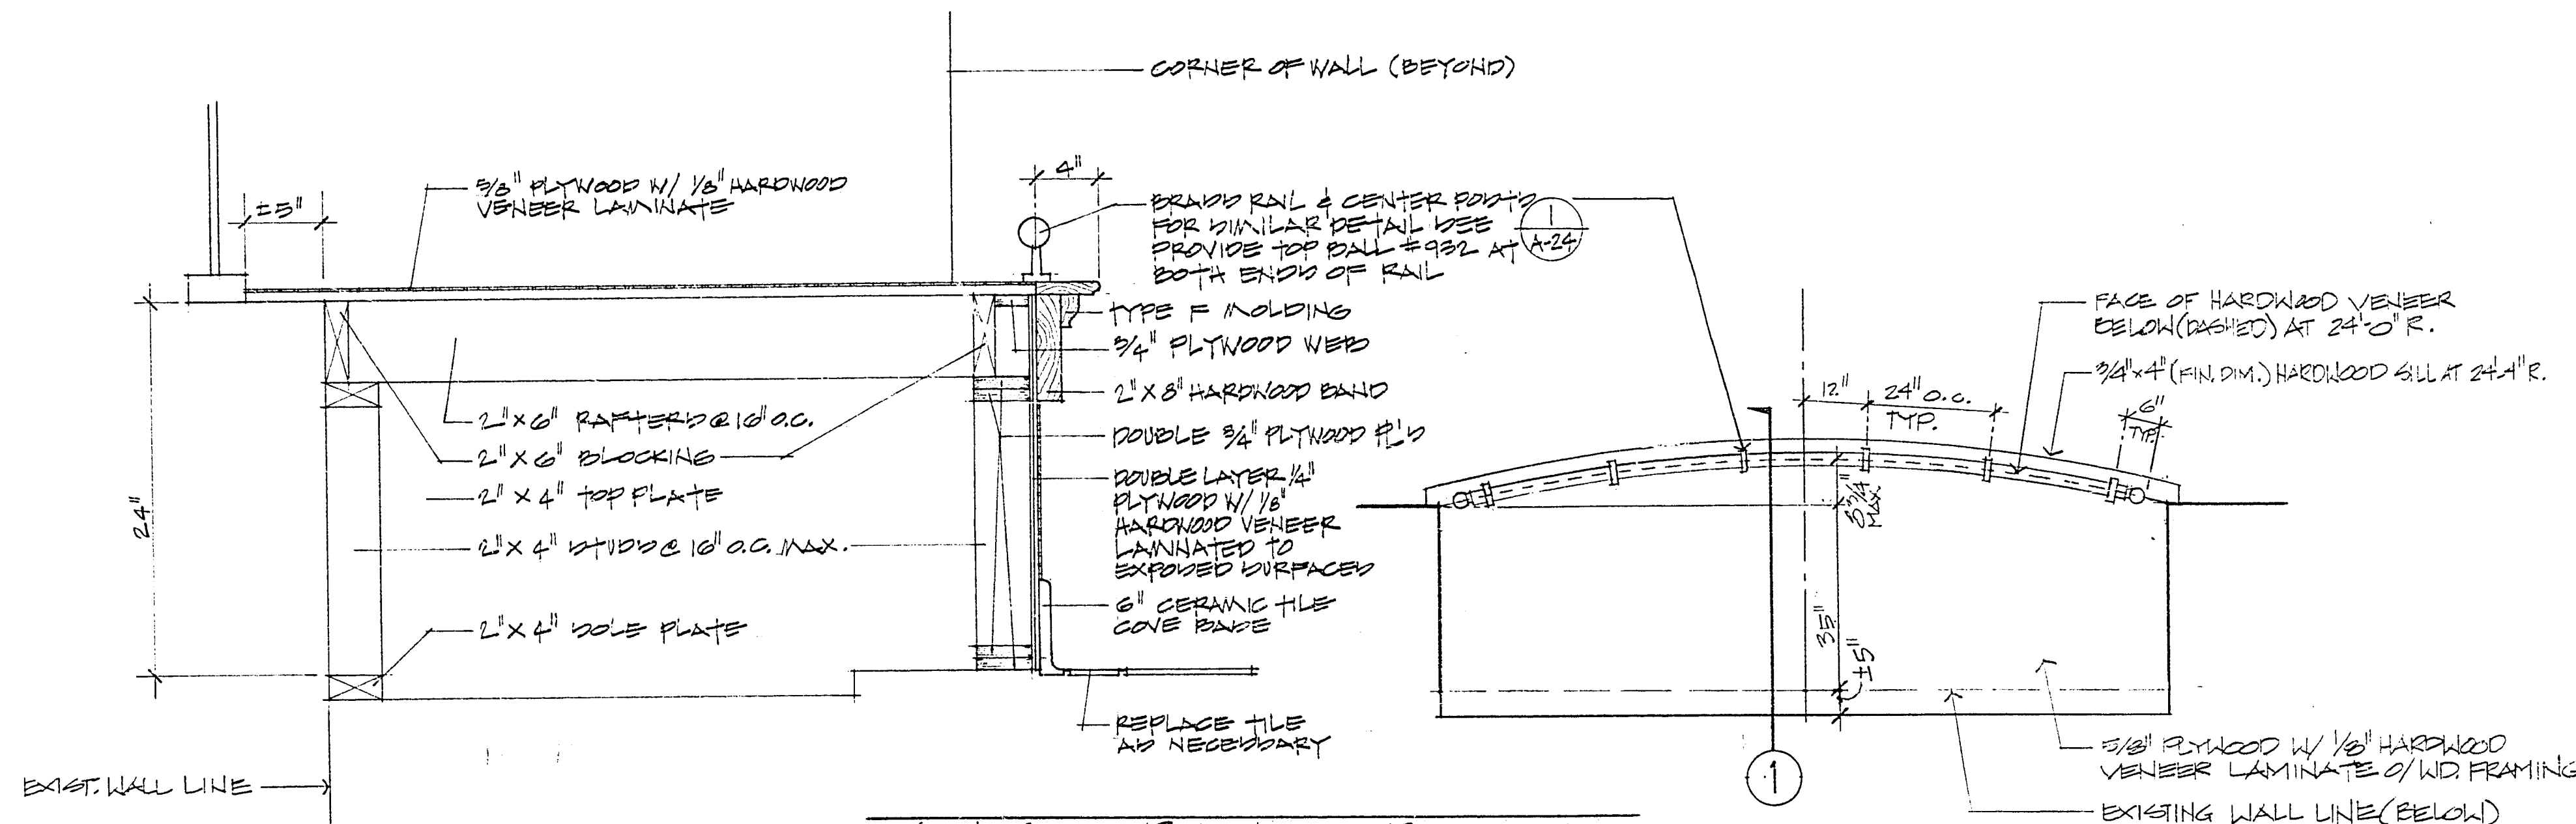

DETAILS "C, D, E, F, G" AND RELATED ELECTRICAL WORK,
PART OF BID GROUP I, ADDITIVE ITEM #4

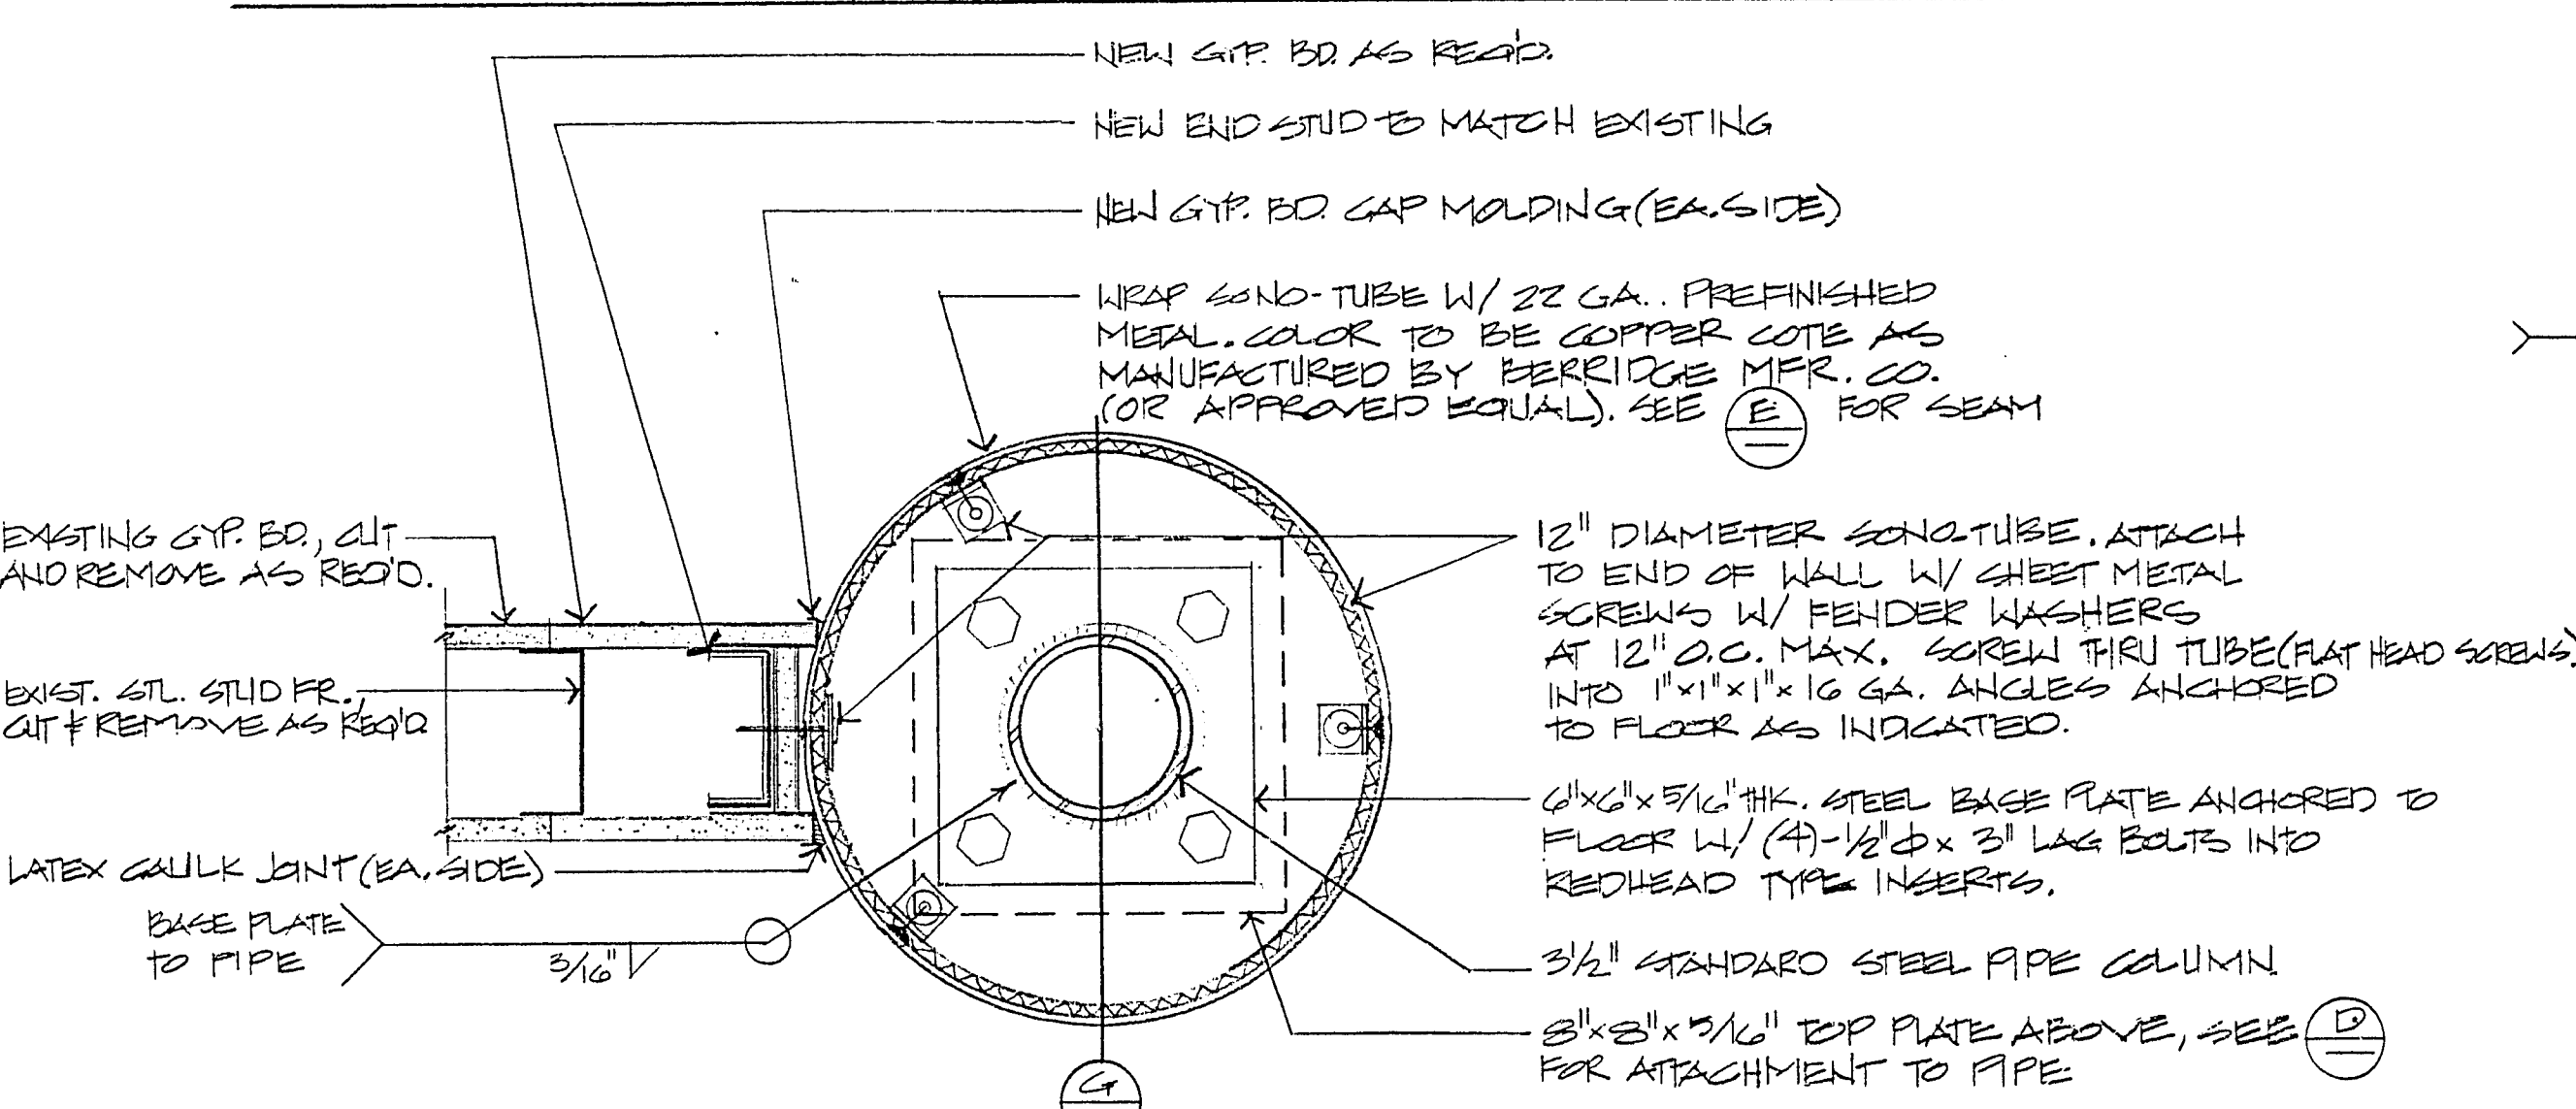

NOTE: FOR MID-WALL INSTALLATION, SEE (F)
LIGHT FIXTURE PEDESTAL-MID-WALL SECTION

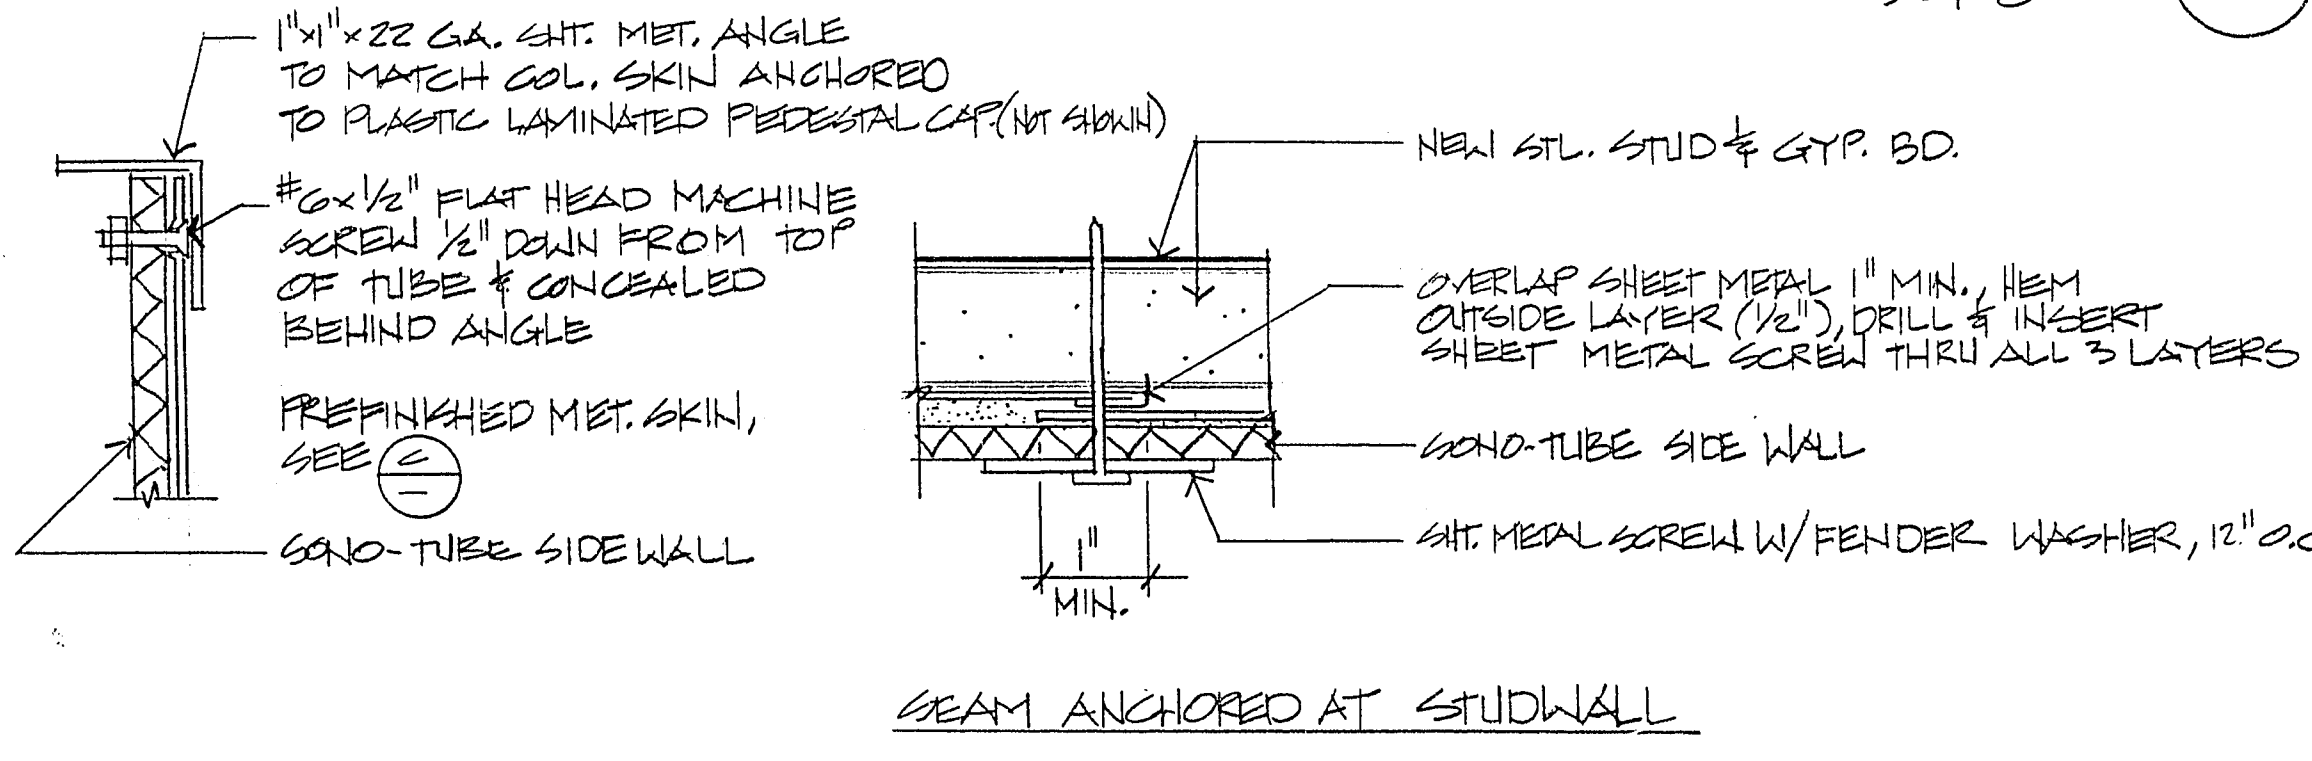

PREFINISHED METAL SEAM DETAILS
NO SCALE

