


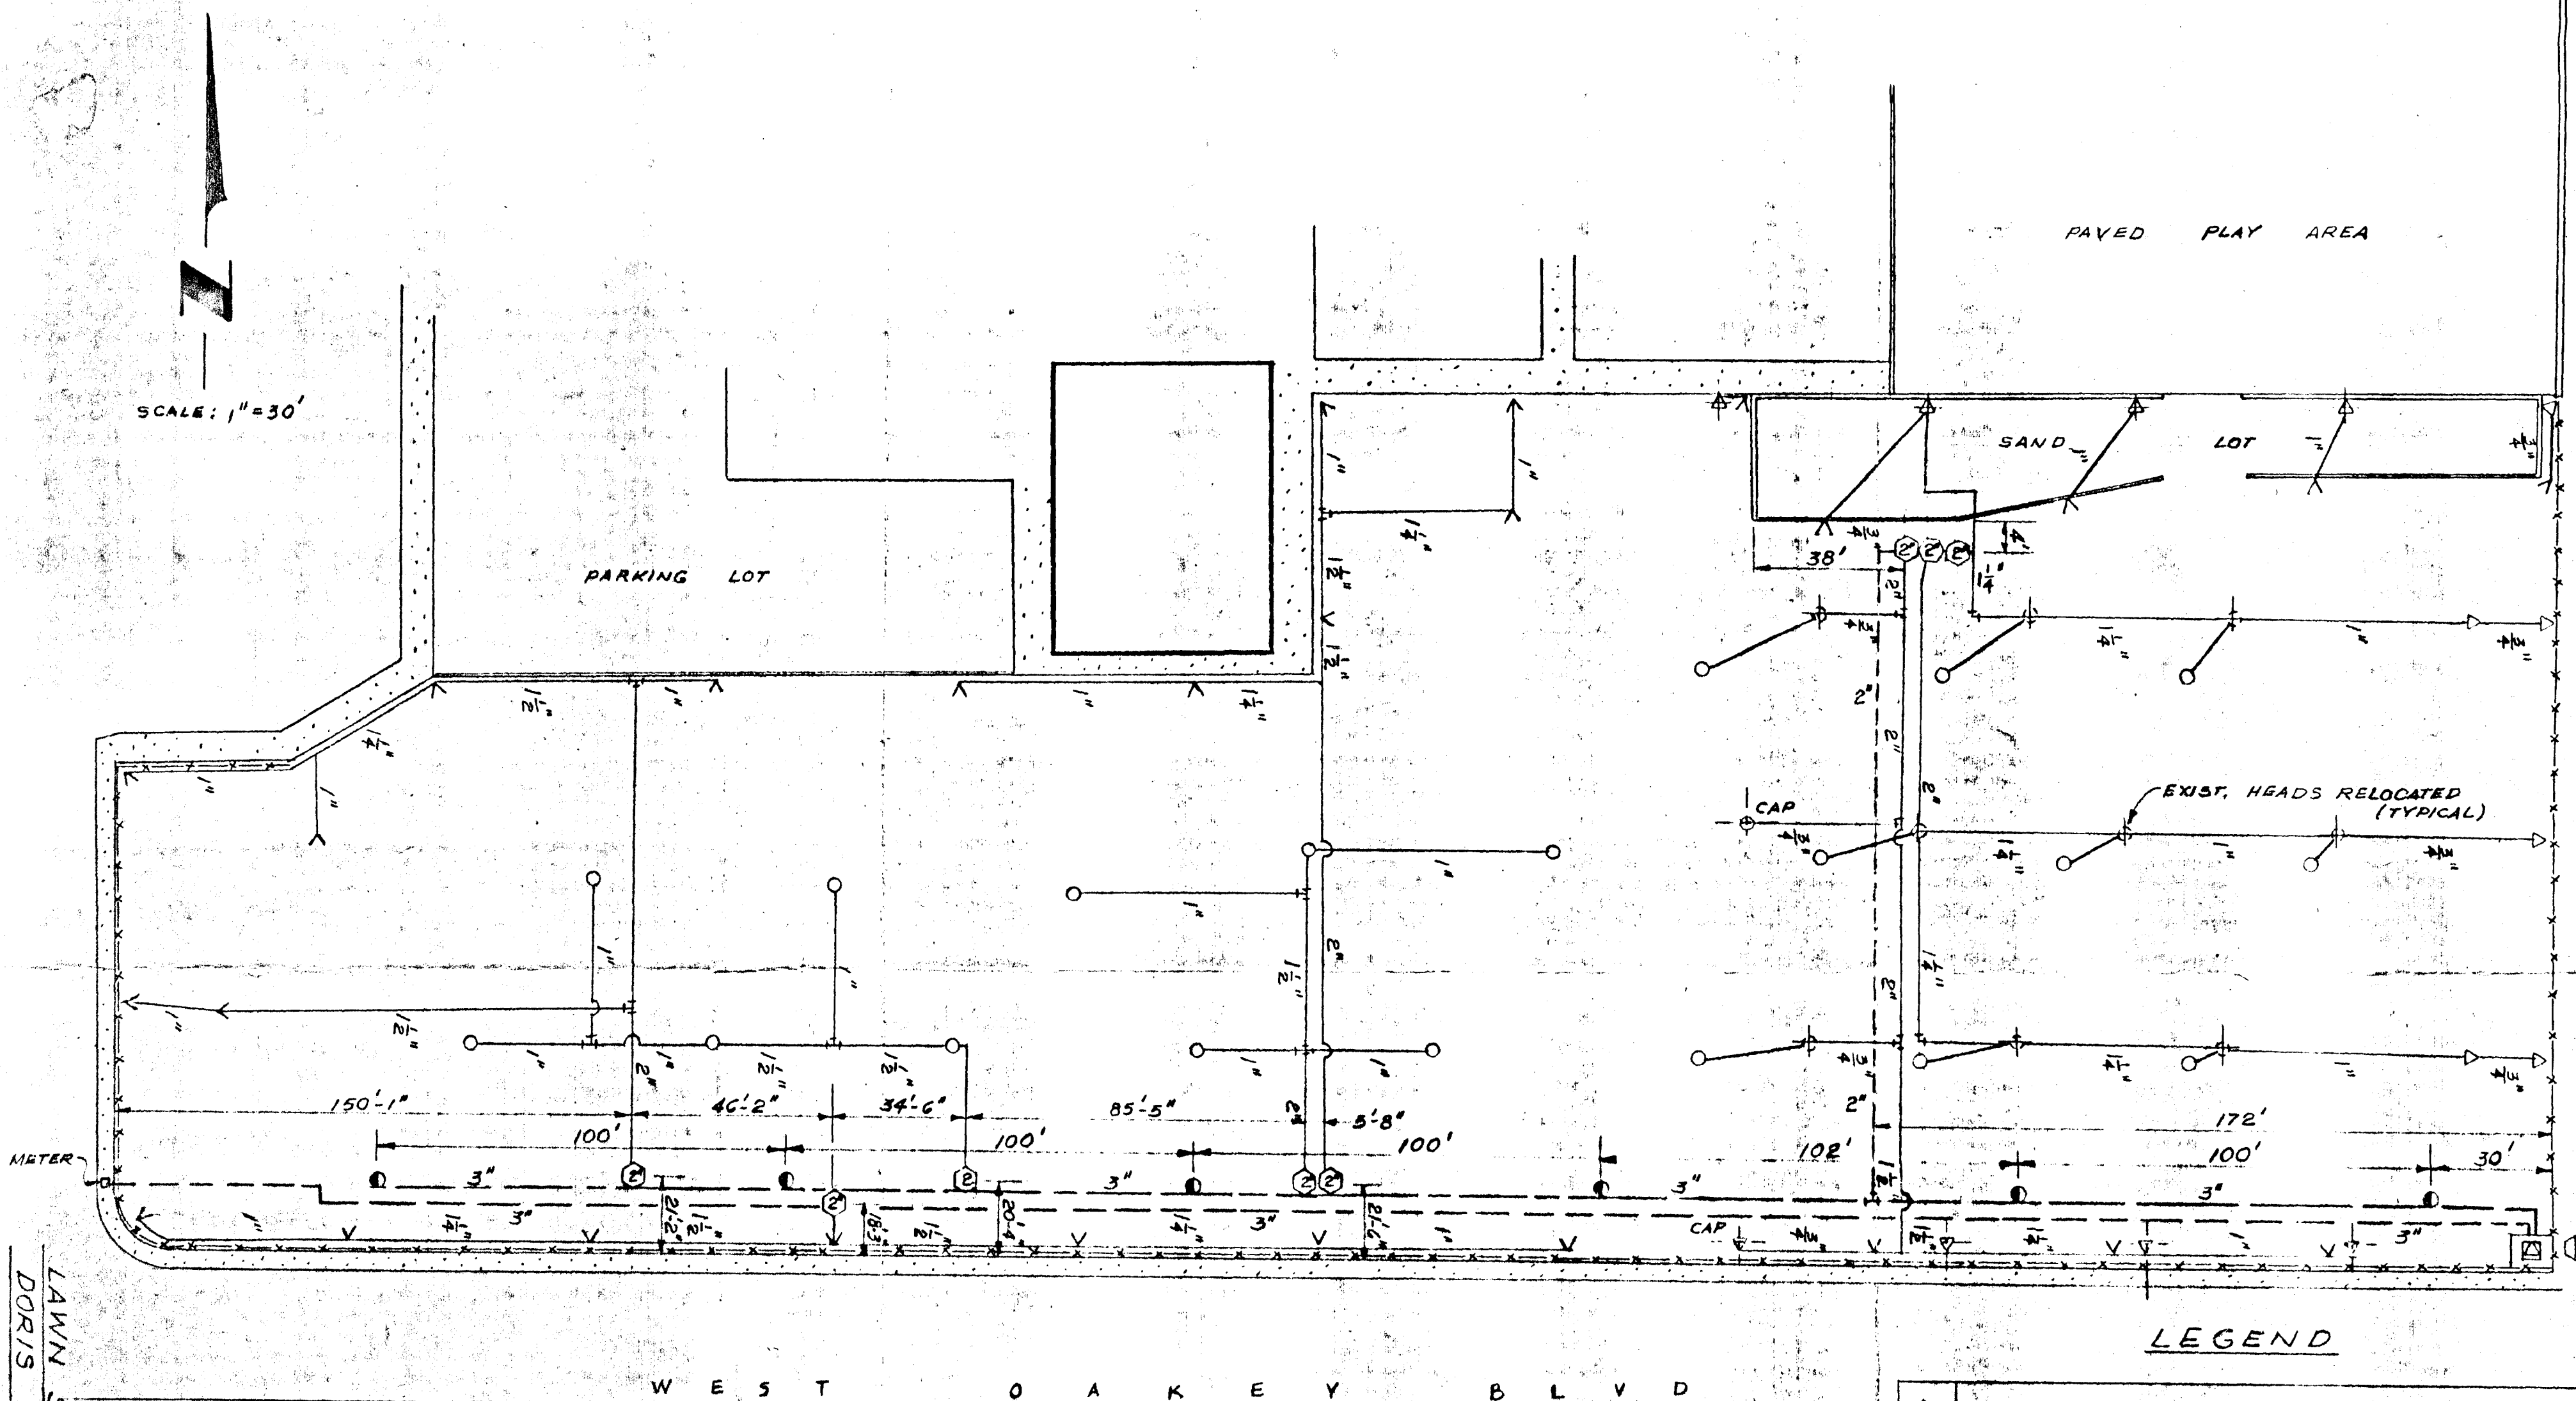

LEGEND

	FEBCO 770 VACUUM BREAKER
	RAINBIRD 41 IMPACT SPRINKLER
	RAINBIRD 47 IMPACT SPRINKLER
	ORIGINAL SPRINKLER HEADS
	QUICK COUPLER - RAINBIRD
	ACE II CONTROLLER
	AUTOMATIC VALVE - RAINBIRD
	5" CLASS 200 MAIN

LAWN SPRINKLER PLAN
DORIS HANCOCK ELEMENTARY
(AS BUILT)

school facilities department
architectural section

2832 east flamingo rd. las vegas, nevada 736-5256

c.c.s.d.
county school district

date 12-15-71	drawn by
revision	checked by
sheet 1	715-85-2

715-85