

TJKROB CONSULTING ENGINEERS, INC.
 1919 S. JONES BLVD. SUITE B
 LAS VEGAS, NEVADA 89146
 (702) 871-3621
ELECTRICAL ENGINEERING

POGGEMEYER DESIGN GROUP
 2601 NORTH TENAYA WAY
 LAS VEGAS, NEVADA 89128 (702) 255-8100
ENGINEERS PLANNERS SURVEYORS LANDSCAPE ARCHITECTS

GREELEY AND HANSEN ENGINEERS
 4625 SOUTH POLARIS AVENUE, SUITE 210
 LAS VEGAS, NEVADA 89103 (702) 706-7062
5-1-85



DESIGNED	SW
DRAWN	FT
CHECKED	MBH

NO.	DATE	APPD	REVISION

CITY OF LAS VEGAS, NEVADA
 DEPARTMENT OF PUBLIC WORKS
 NORTHWEST WATER RESOURCE CENTER
 100% DESIGN

TRAFFIC IMPROVEMENTS
 STA 13+33.95 TO 37+55.28
 TRAFFIC PLAN

PROJ. NO.	7190
DWG	PDG 11
SHEET	101 OF 106
DATE	07.21.98
REV	0

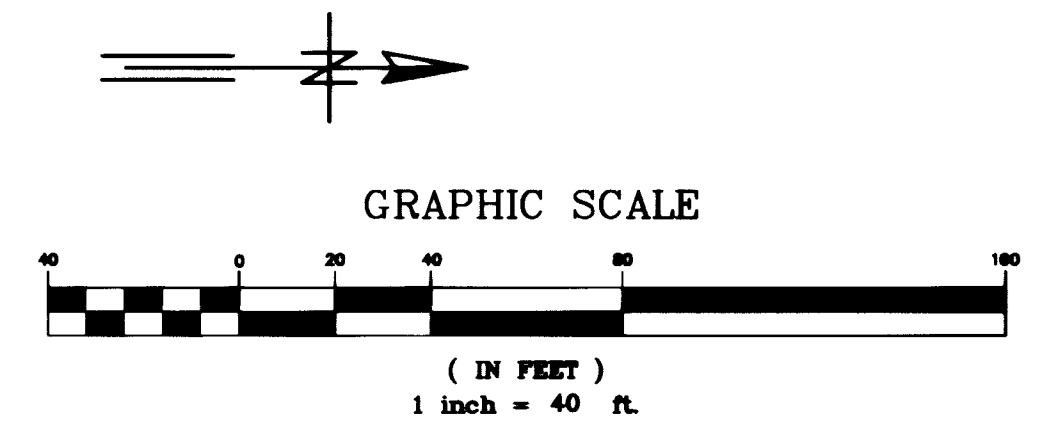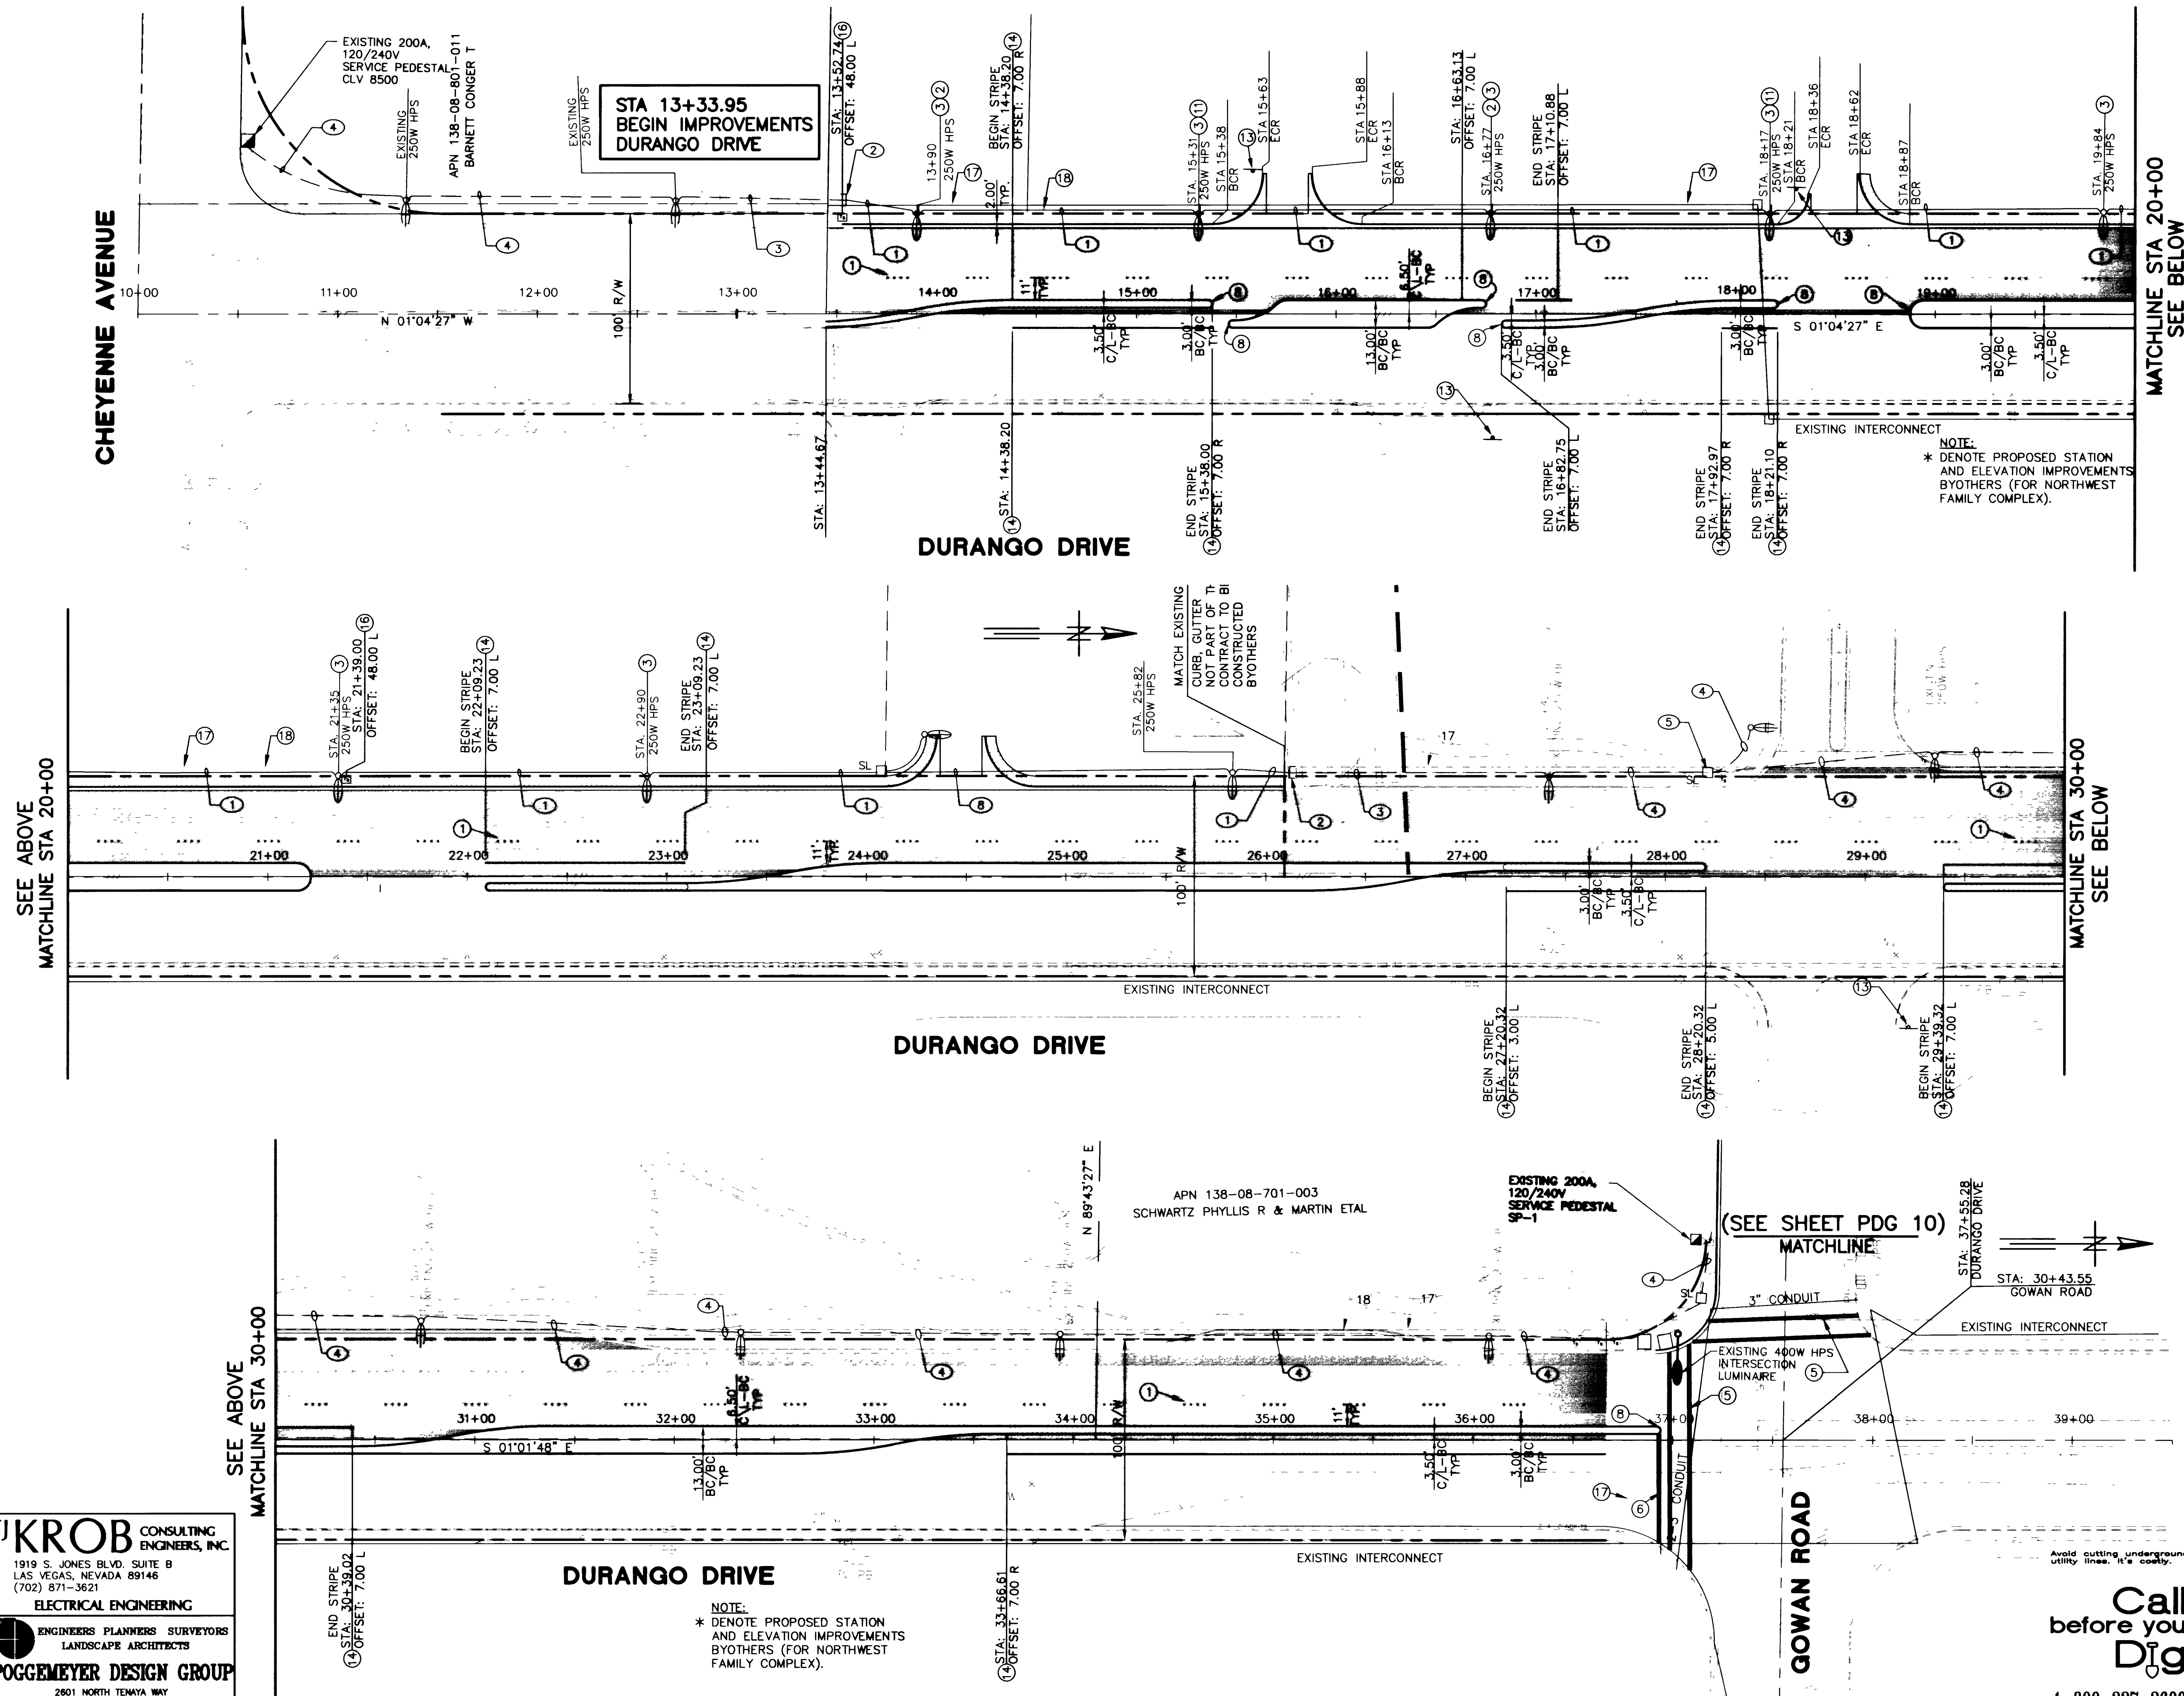

TRAFFIC NOTES:

- INSTALL TYPE 5 LANE IN ACCORDANCE WITH STANDARD DRAWING NO. 244A.
- INSTALL R7-1 "NO PARKING ANY TIME" SIGN WITH SUPPLEMENTAL DIRECTIONAL PLATE.
- INSTALL STREET LIGHT IN ACCORDANCE WITH UNIFORM STANDARD DRAWING NO. 311, 8'-0" MAST ARM, UNIFORM STANDARD DRAWING NO. 314, FOUNDATION ON UNIFORM STANDARD DRAWING NO. 321 AND 250W HIGH PRESSURE SODIUM LUMINAIRE. SEE LEGEND ON SHEET PDG 12.
- INSTALL 10' LONG CROSSWALK PER USD No.254.
- INSTALL 24"COLD POLYMER FILM STOP BAR.
- INSTALL MEDIAN NOSE MARKINGS IN ACCORDANCE WITH STANDARD DRAWING NO. 248.
- INSTALL NO. 5 PULLBOX IN ACCORDANCE WITH STANDARD DRAWING NO. 404.120.
- INSTALL R2-1 SPEED LIMIT SIGN 24"x 30" (35 MPH).
- INSTALL R2-1 SPEED LIMIT SIGN 24"x 30" (45 MPH).
- INSTALL TYPE 2 CENTERLINE IN ACCORDANCE WITH STANDARD DRAWING NO. 244.
- INSTALL R1-1 STOP SIGN.
- STANDARD PAVEMENT MARKERS ADDED PER TURN LANE IN ACCORDANCE WITH STANDARD DRAWING NO. 246.
- INSTALL NO. 3 1/2 PULLBOX IN ACCORDANCE WITH UNIFORM STANDARD DRAWING NO. 404.110.
- INSTALL 3" INTERCONNECT CONDUIT IN ACCORDANCE WITH SPECIFICATION 623G.02.01. (WITH 25 PAIR #22 AWG WIRES TYP)
- 3" CONDUIT FOR FUTURE FIBER OPTIC LINE WITH PULL WIRE AND PULL BOX EVERY 300.00'.

STREET LIGHTING NOTES:

- 2#4, 1#8, 2" PVC.
- CONNECT TO EXISTING CIRCUIT. PROVIDE 2#4, 1#8 THW FROM EXISTING LUMINAIRE AND POLE TO NEW LUMINAIRE AND POLE WITHOUT SPLICES.
- 2#4, 1#8 IN EXISTING 2" PVC (SEE NOTE 2).
- EXISTING 2#4, 1#8, 2" PVC.
- EXISTING PULLBOX.
- 2" PVC WITH PULLSTRING.
- 2#4, 1#8, 2" PVC. CONNECT TO EXISTING CONDUIT, EXTEND NEW WIRE TO EXISTING LUMINAIRE. DO NOT CONNECT WIRES AT EITHER END OF CONDUIT.
- 2#4, 1#8, 2" PVC. DO NOT CONNECT WIRES AT EITHER END OF CONDUIT.
- 2#4, 1#8 IN EXISTING 2" PVC (SEE NOTE 7).

RECORD DRAWINGS NOT FOR CONSTRUCTION

- TO ALTER THESE DOCUMENTS FOR ANOTHER PROJECT BY ANYONE OTHER THAN THE ORIGINAL ARCHITECT IS A VIOLATION OF NRS 623.
- THIS RECORD DRAWING HAS BEEN PREPARED IN PART, BASED UPON INFORMATION FURNISHED BY THE GENERAL CONTRACTOR. WHILE THIS INFORMATION IS BELIEVED TO BE RELIABLE, THE DESIGN PROFESSIONAL CANNOT ASSURE ITS ACCURACY, AND THIS IS NOT RESPONSIBLE FOR THE ACCURACY OF THIS RECORD DRAWING OR FOR ANY ERRORS OR OMISSIONS WHICH MAY HAVE BEEN INCORPORATED INTO IT AS A RESULT. THE DESIGN PROFESSIONAL CANNOT AND DOES NOT WARRANT THEIR ACCURACY.
- INFORMATION THAT MAY BE INCLUDED WOULD BE SIGNIFICANT CHANGES TO ROOM ARRANGEMENTS ON THE FLOOR PLANS AND ASSOCIATED DRAWINGS. MINOR DIMENSION OR CONSTRUCTION DETAIL CHANGES MAY NOT BE INCLUDED.

CONTRACTOR _____ DATE _____

Call before you Dig
 1-800-227-2600