

Avoid cutting underground utility lines. It's costly.

**Call
before you
Dig**


1-800-227-2600

NOTES:

1. DO NOT INSTALL STEPS IN MANHOLES
2. TRENCH SECTION BACKFILL AND BEDDING ACCORDING TO STANDARD DRAWINGS SD-168 AND SD-11, GRANULAR BEDDING, OF "DESIGN AND CONSTRUCTION STANDARDS FOR WASTEWATER COLLECTION SYSTEMS", LATEST EDITION.

MATCH LINE STA RS20+00 - SEE DWG RS01

MATCH LINE STATION RS20+00 - SEE DWG RS01

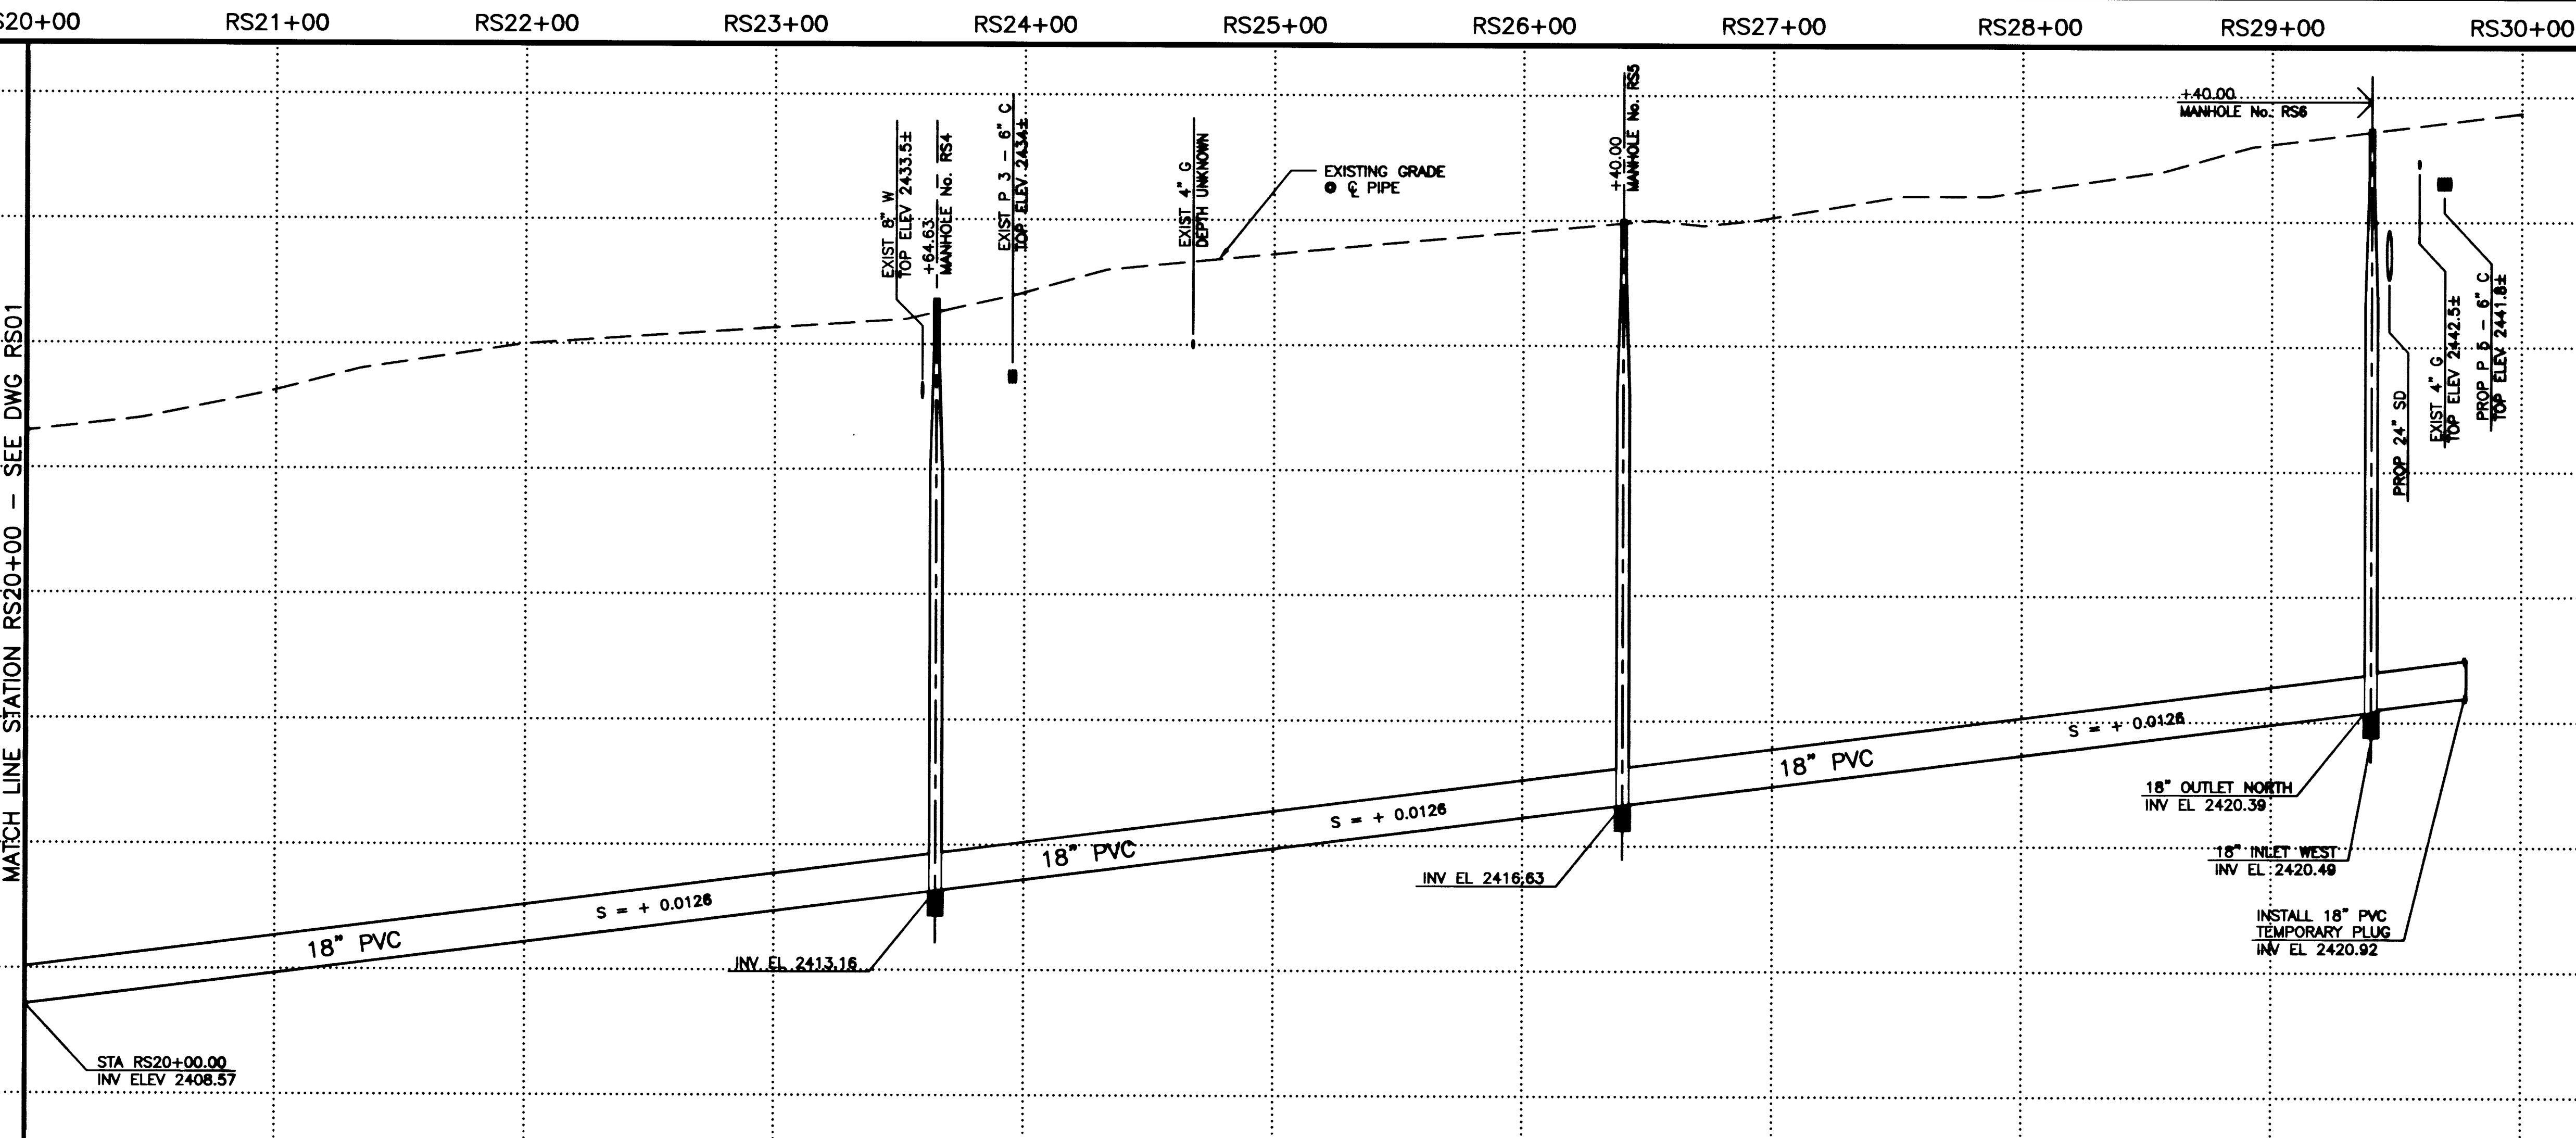

DEPARTMENT OF PUBLIC WORKS

PROJECT:
Northwest Water Resource Center
DURANGO DRIVE IMPROVEMENTS
RESIDUAL SEWER

SHEET:
PLAN AND PROFILE
STA RS20+00 TO STA RS29+77

DRAWING NO. 106
RS02 106

REVISIONS		SCALE (H) 1" = 40'		SCALE (V) 1" = 4'		DATE		DESIGN BY VRK		DATE			
										GREELEY AND HANSEN ENGINEERS 4625 SOUTH POLARIS AVENUE, SUITE 210 LAS VEGAS, NEVADA 89103			
												W.A. #	
												DATE	
												DATE	