



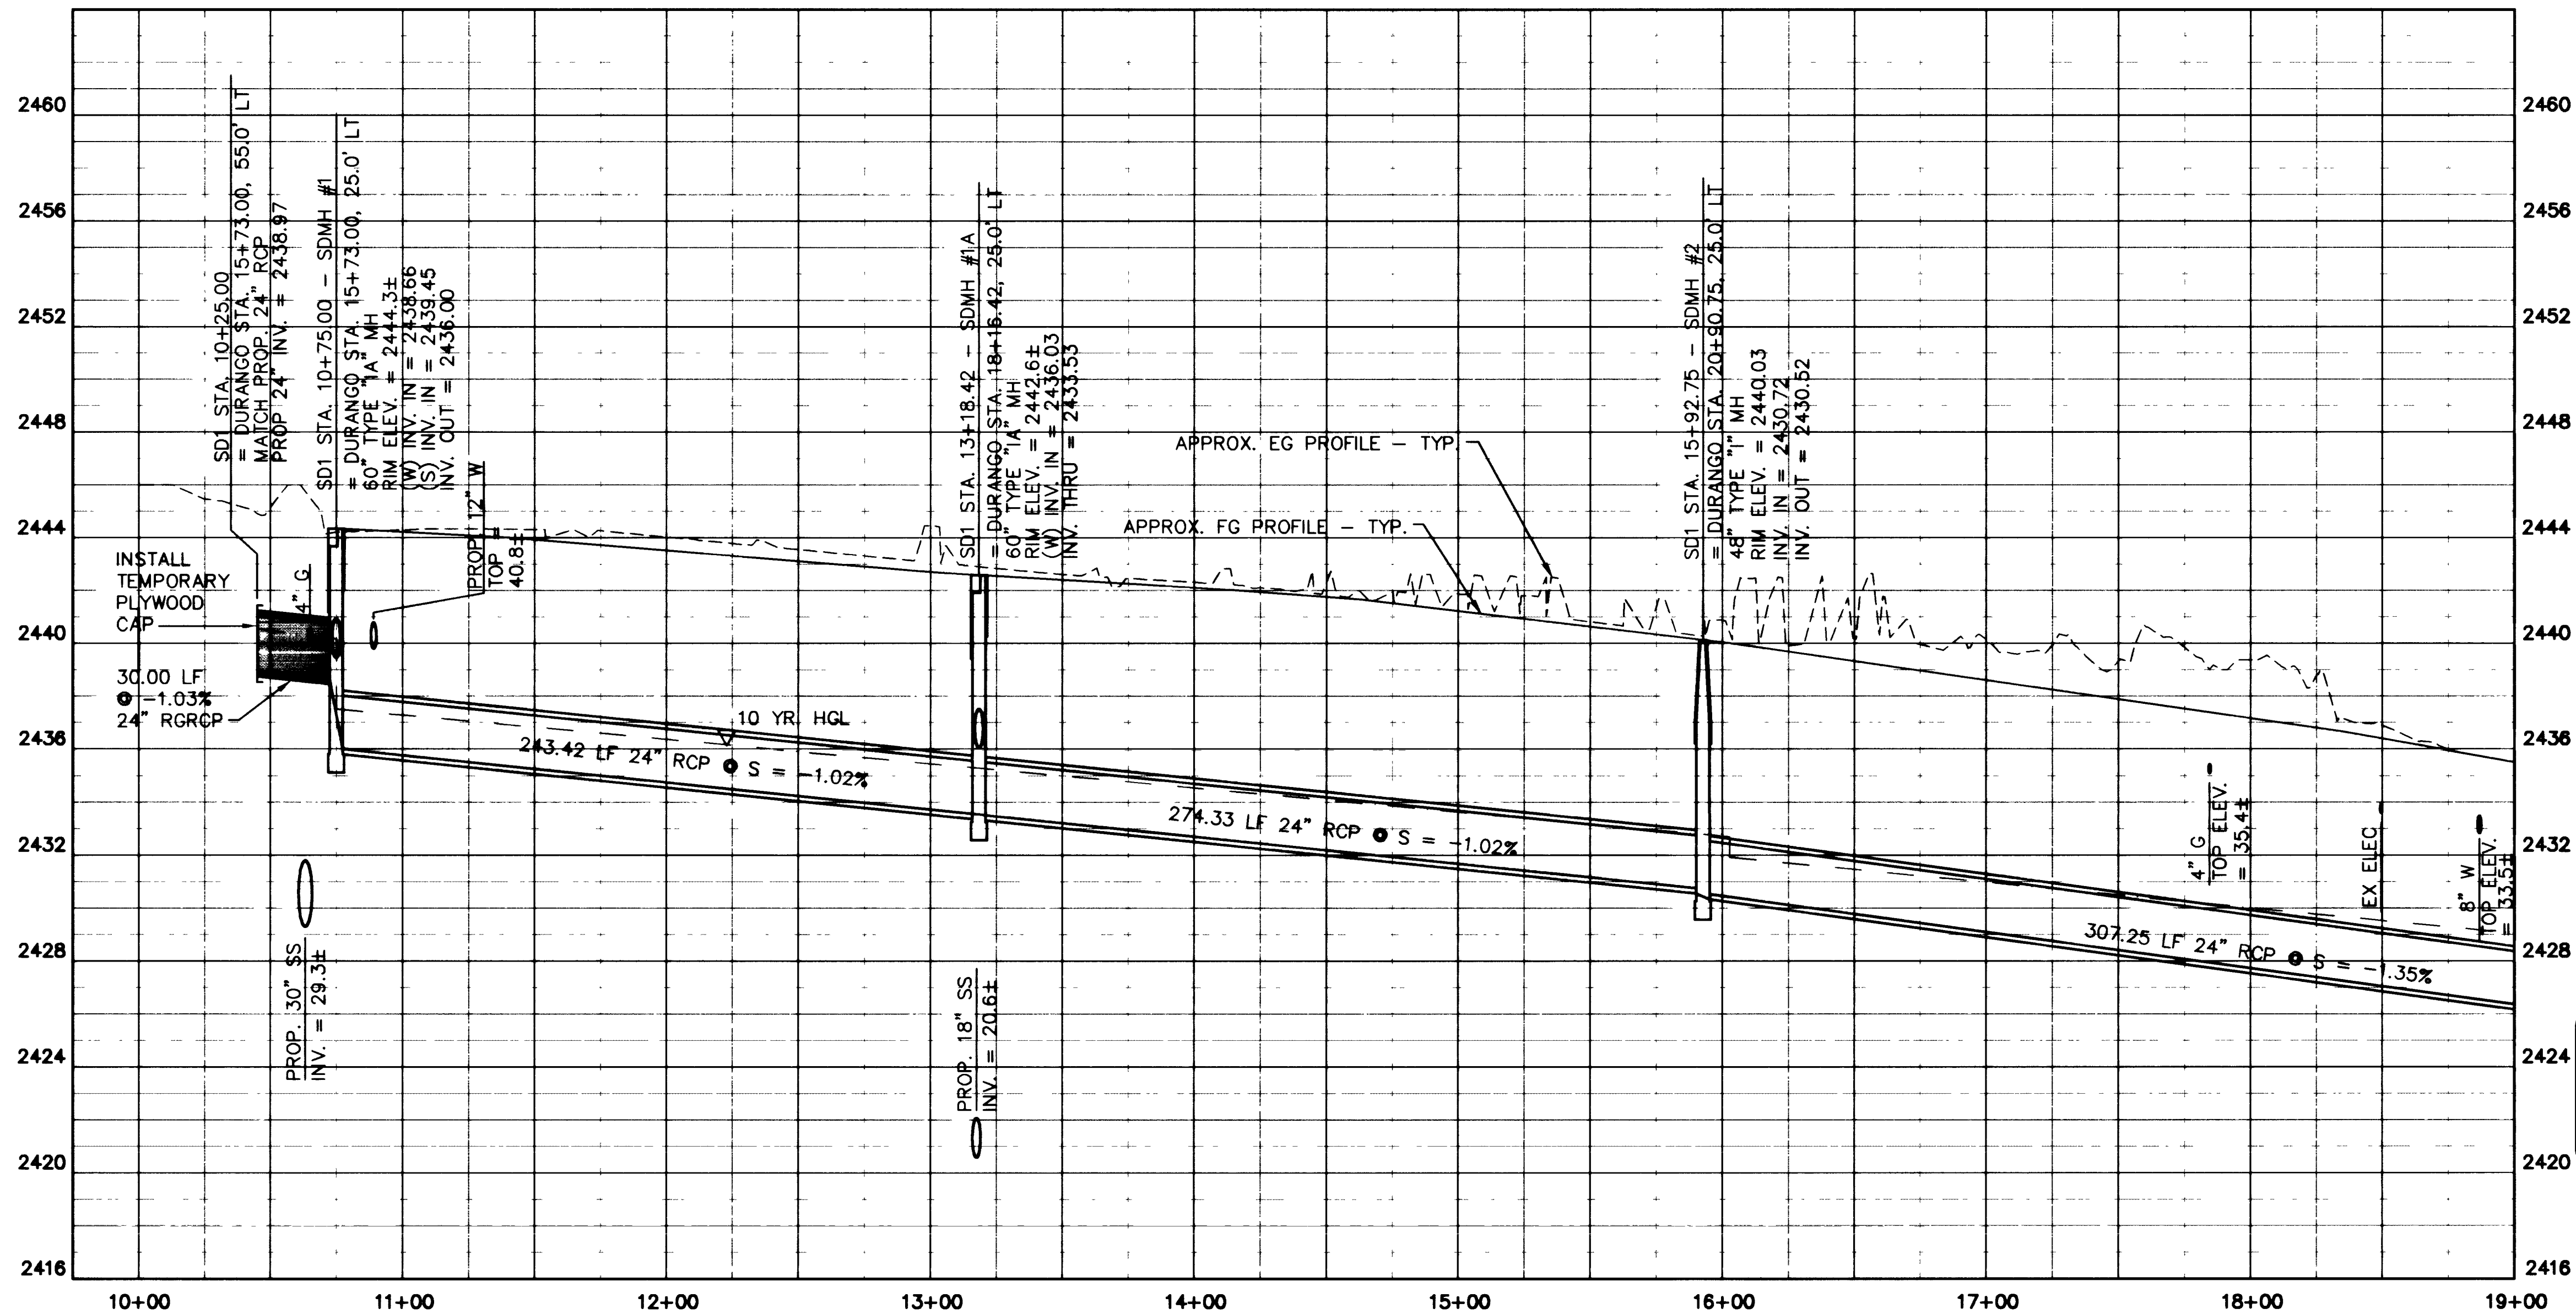

NOTES:
1. ALL RCP IS TO BE CLASS III.

APPROVED
LAS VEGAS VALLEY WATER DISTRICT
DATE

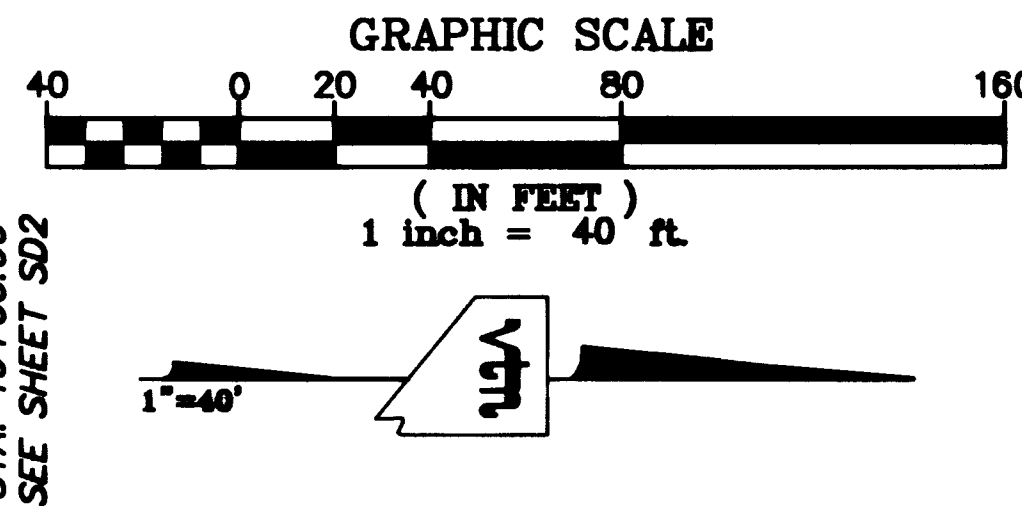

STORM DRAIN PLAN AND PROFILE
SD1 STA. 10+00 TO STA. 19+00
DURANGO DRIVE

DURANGO DRIVE IMPROVEMENTS
CHEYENNE AVENUE TO LONE MOUNTAIN ROAD

WD. NO. **5249**
BY **JL/LMW/DJB**
DATE **07/17/98**
SCALE: HORIZ. 1"=40'
VERT. 1"=4'
DRAWING **SD1**
SHEET **52** OF **106**
SHEETS

DEPARTMENT OF PUBLIC WORKS
CITY OF LAS VEGAS, NEVADA

CONSULTING ENGINEERS • PLANNERS • LAND SURVEYORS
2727 SOUTH RAINBOW BOULEVARD
LAS VEGAS, NEVADA 89102-5148 PHONE (702) 873-7550 FAX (702) 362-2597

vtm nevada

REV	DATE	BY	REVISION