
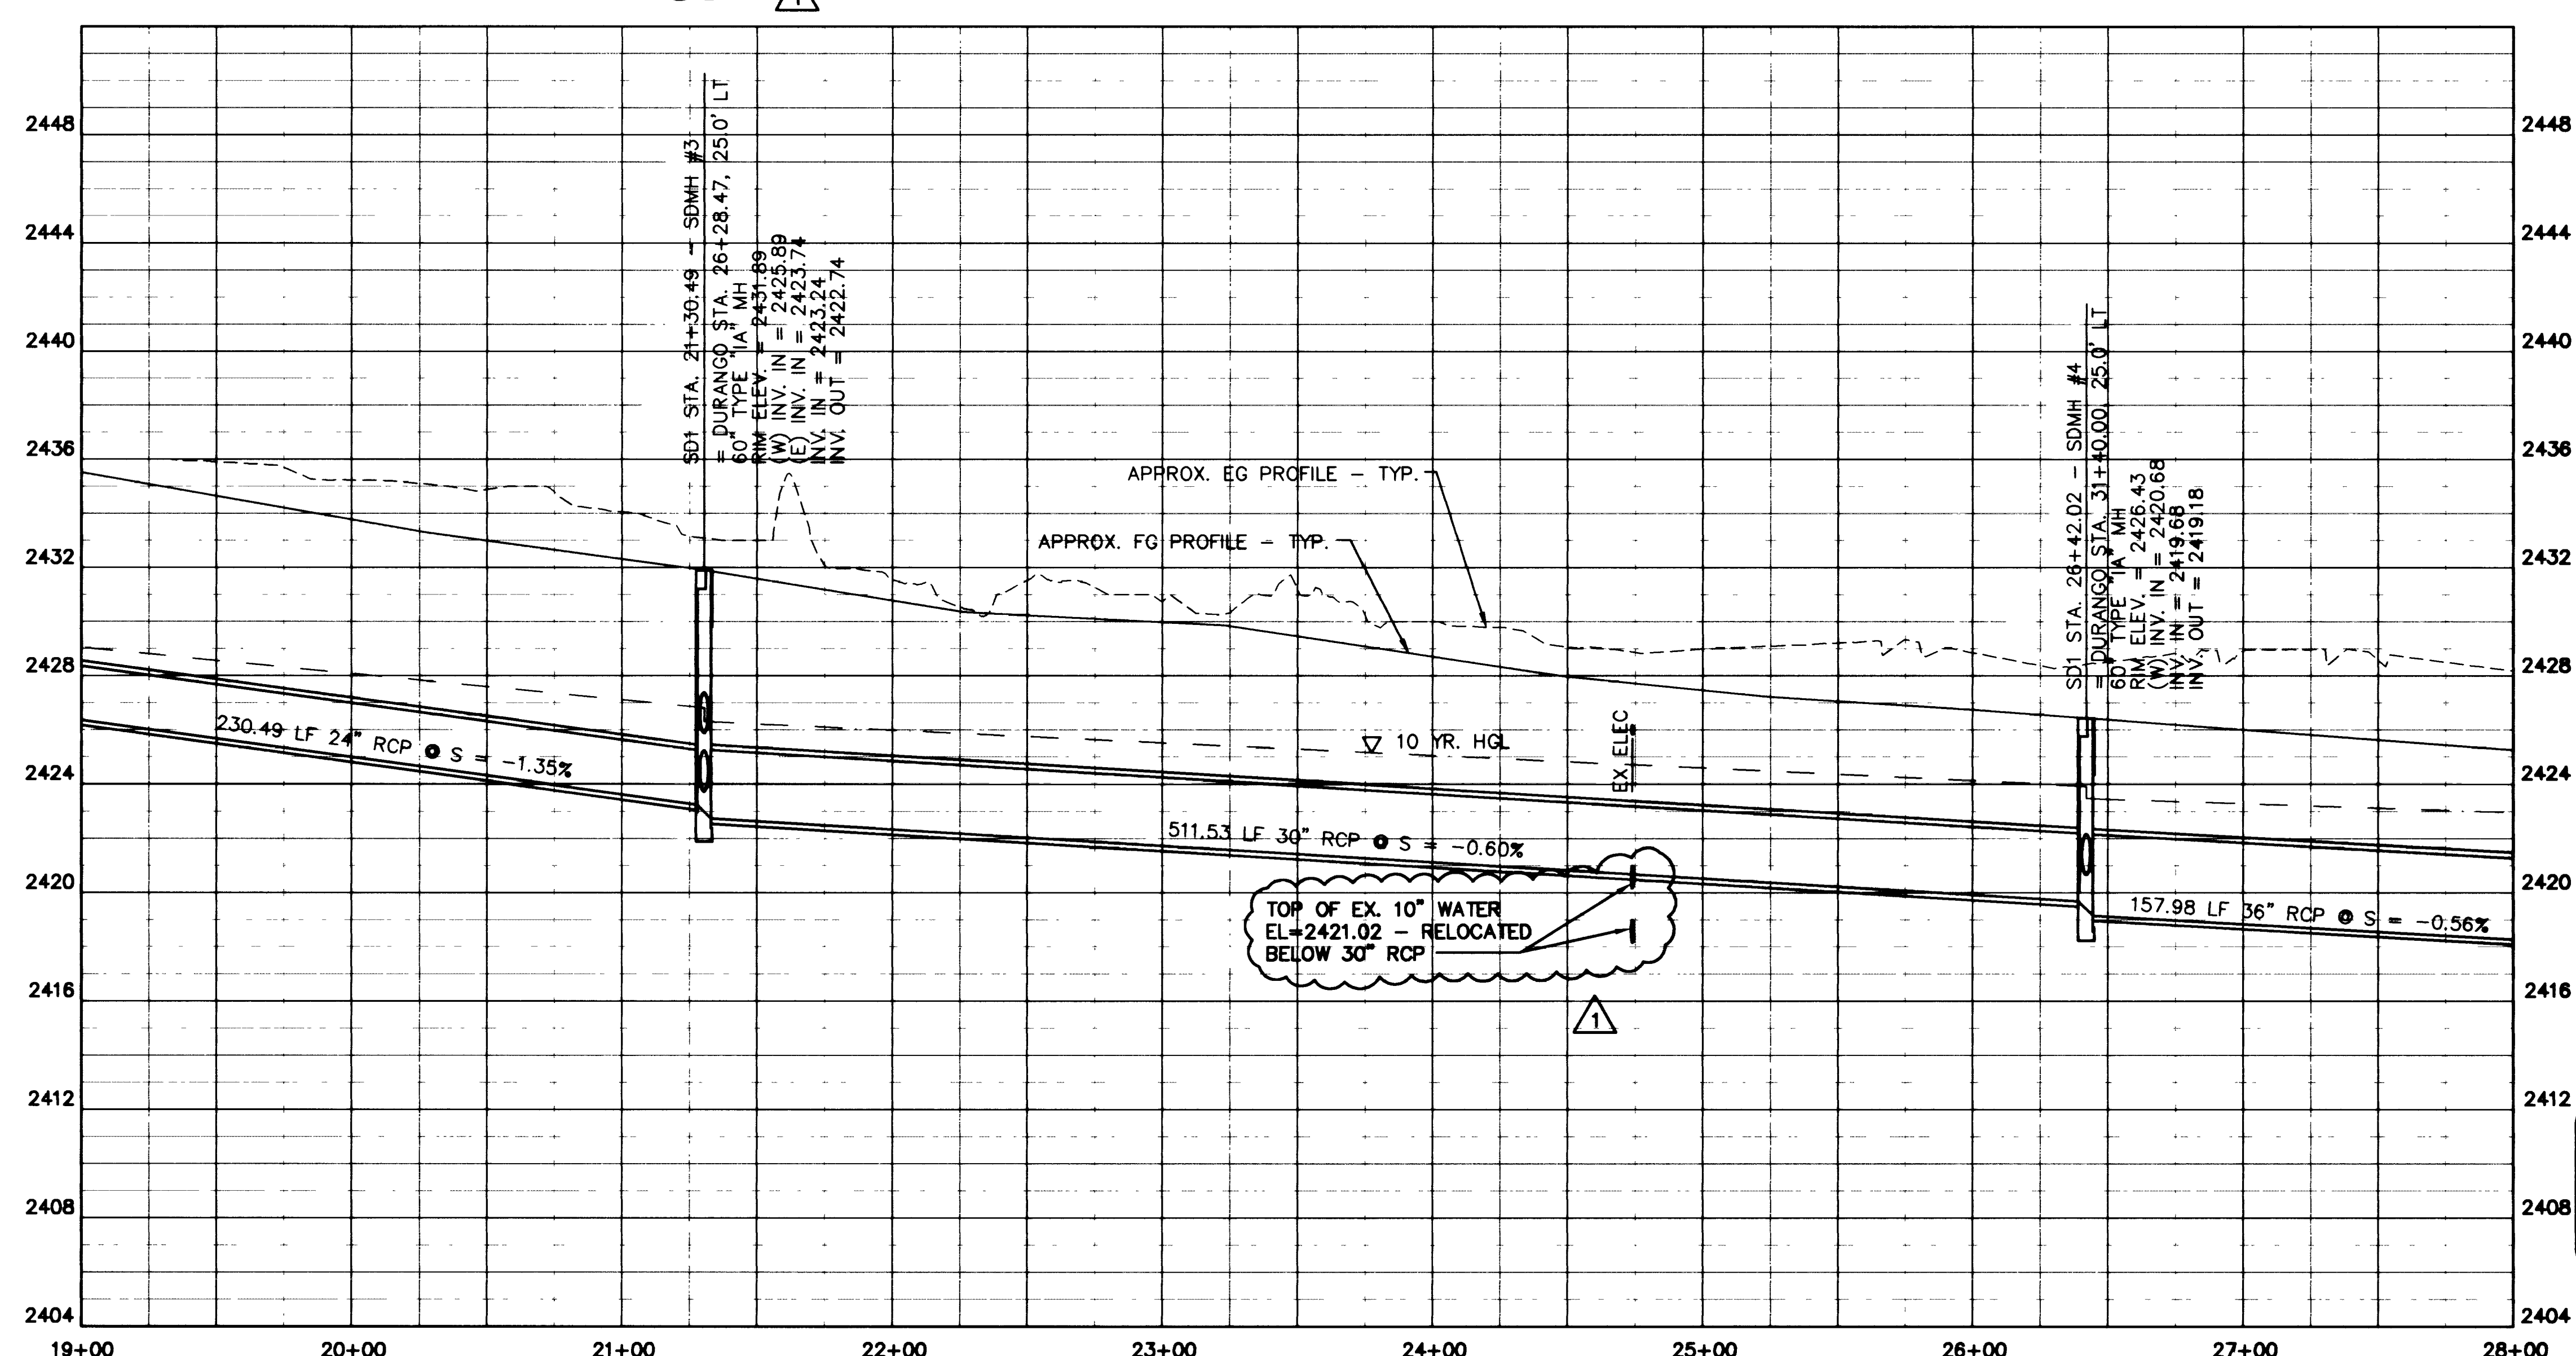
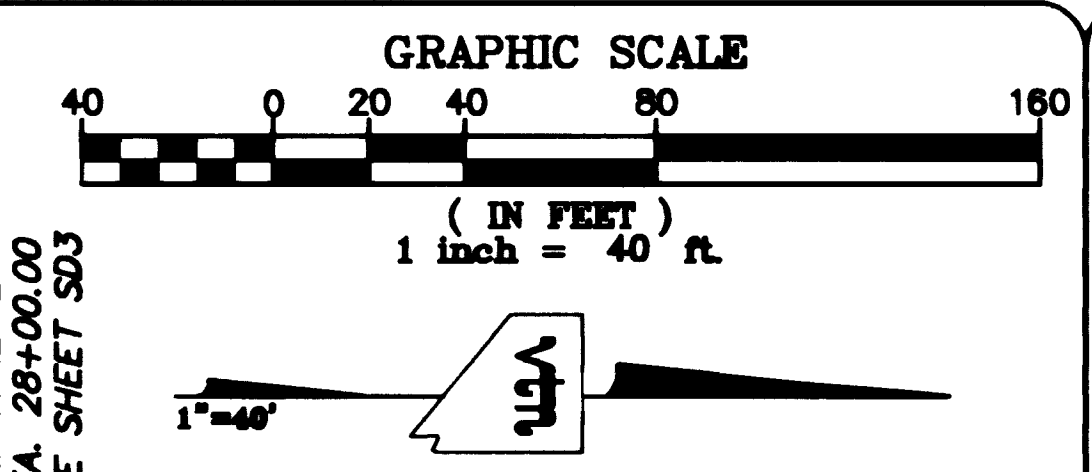


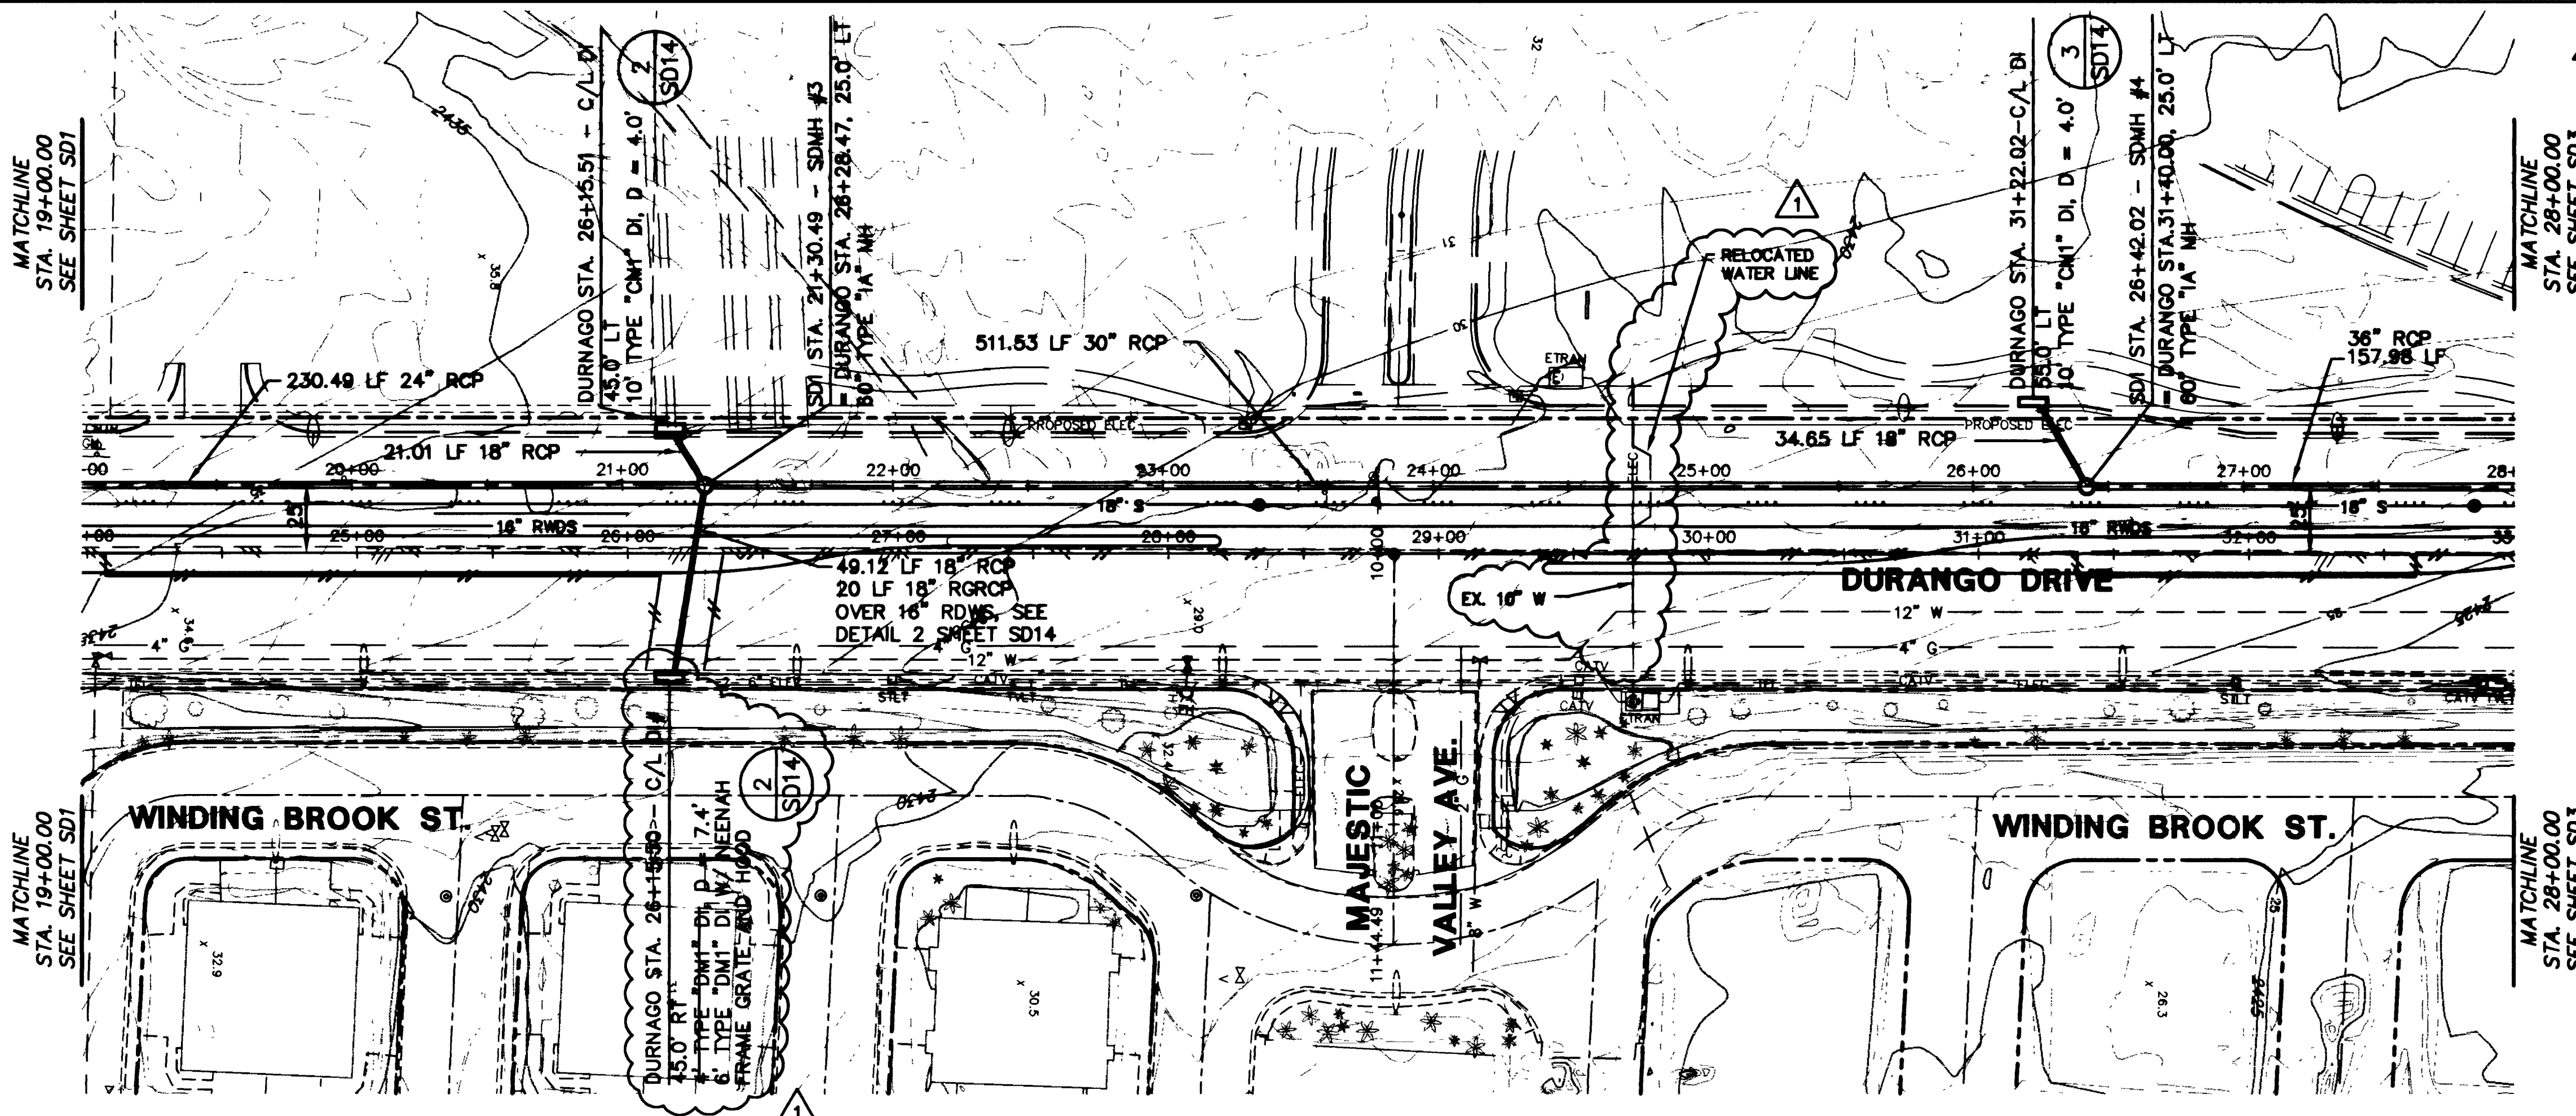

NOTES:
1. ALL RCP IS TO BE CLASS III.

APPROVED
LAS VEGAS VALLEY WATER DISTRICT
DATE

DEPARTMENT OF PUBLIC WORKS
CITY OF LAS VEGAS, NEVADA

CONSULTING ENGINEERS • PLANNERS • LAND SURVEYORS
2727 SOUTH RAINBOW BOULEVARD
LAS VEGAS, NEVADA 89102-5148 PHONE (702) 873-7550 FAX (702) 362-2597

vtm nevada

REV	DATE	BY	REVISION
1			
2			
3			
4			
5			
6			
7			
8			
9			
10			

REVISIONS PER AS-BUILTS

STORM DRAIN PLAN AND PROFILE
SD1 STA. 19+00 TO STA. 28+00
DURANGO DRIVE
DURANGO DRIVE IMPROVEMENTS
CHEYENNE AVENUE TO LONE MOUNTAIN ROAD

PROJECT

SEAL

WO. NO. 5249

BY JL/LMW/DJB

DATE 07/17/98

SCALE HORIZ. 1"=40'
VERT. 1"=4'

DRAWING 53 OF 106 SHEETS

SD2