
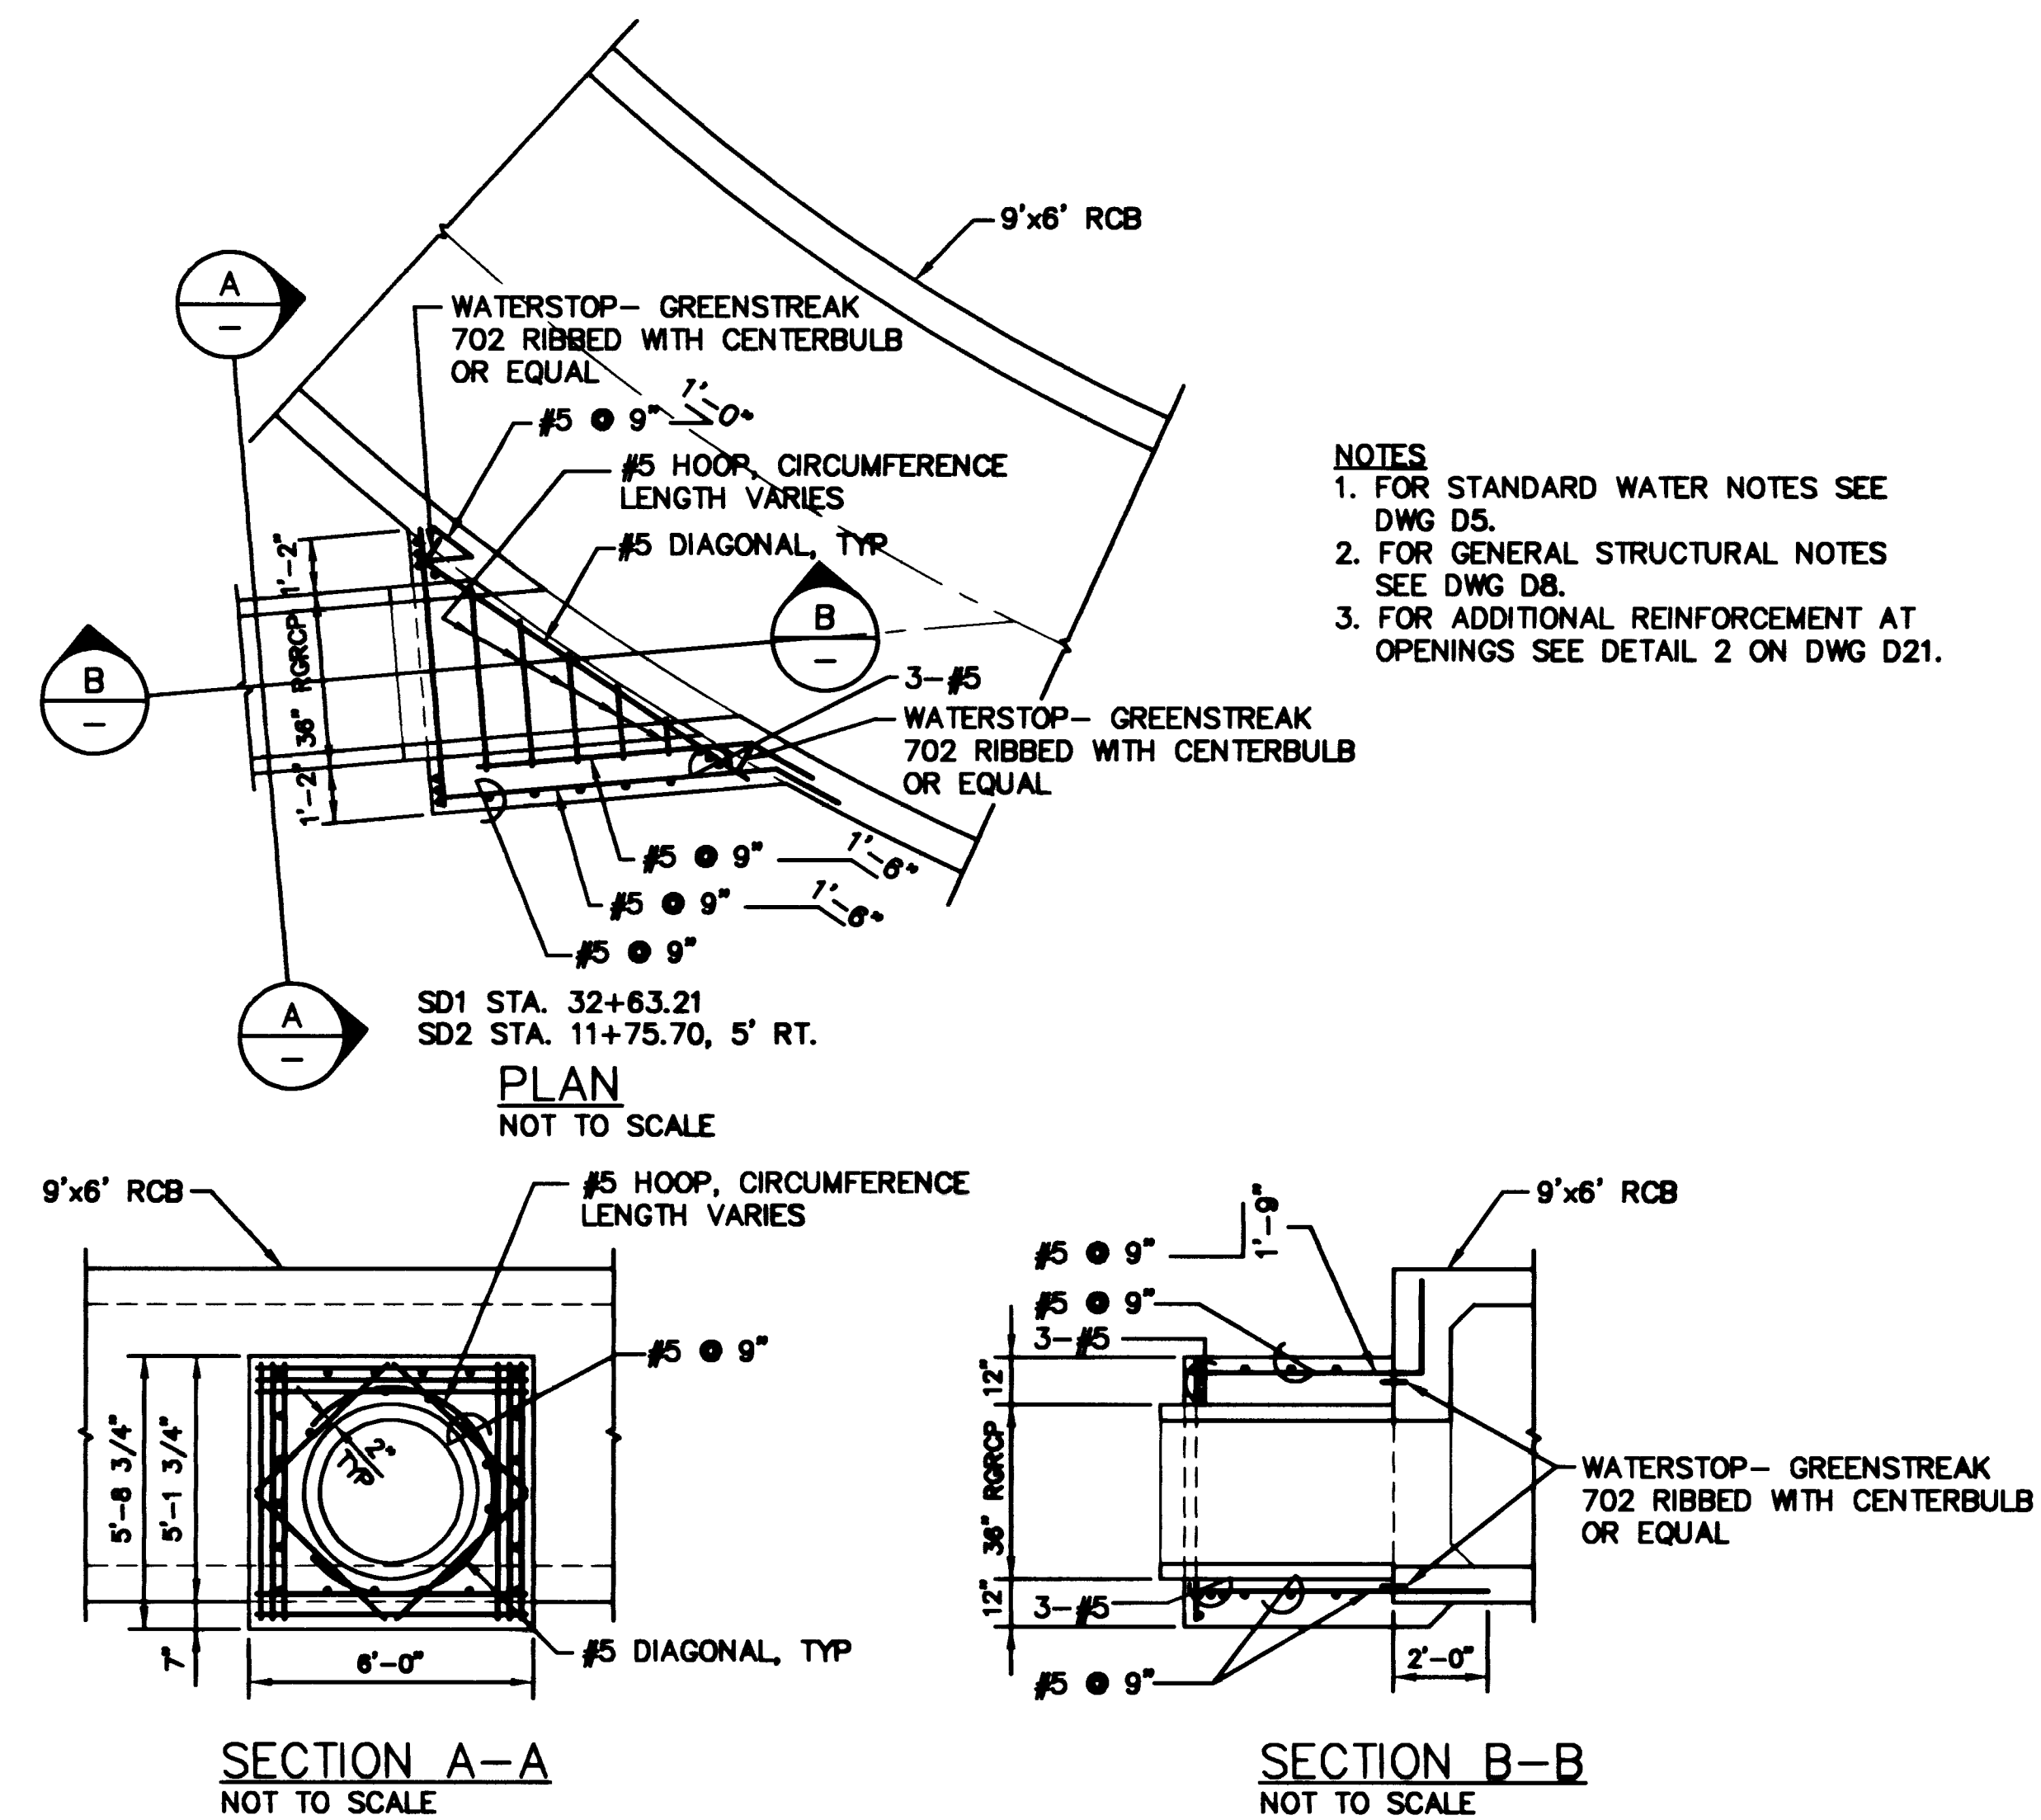
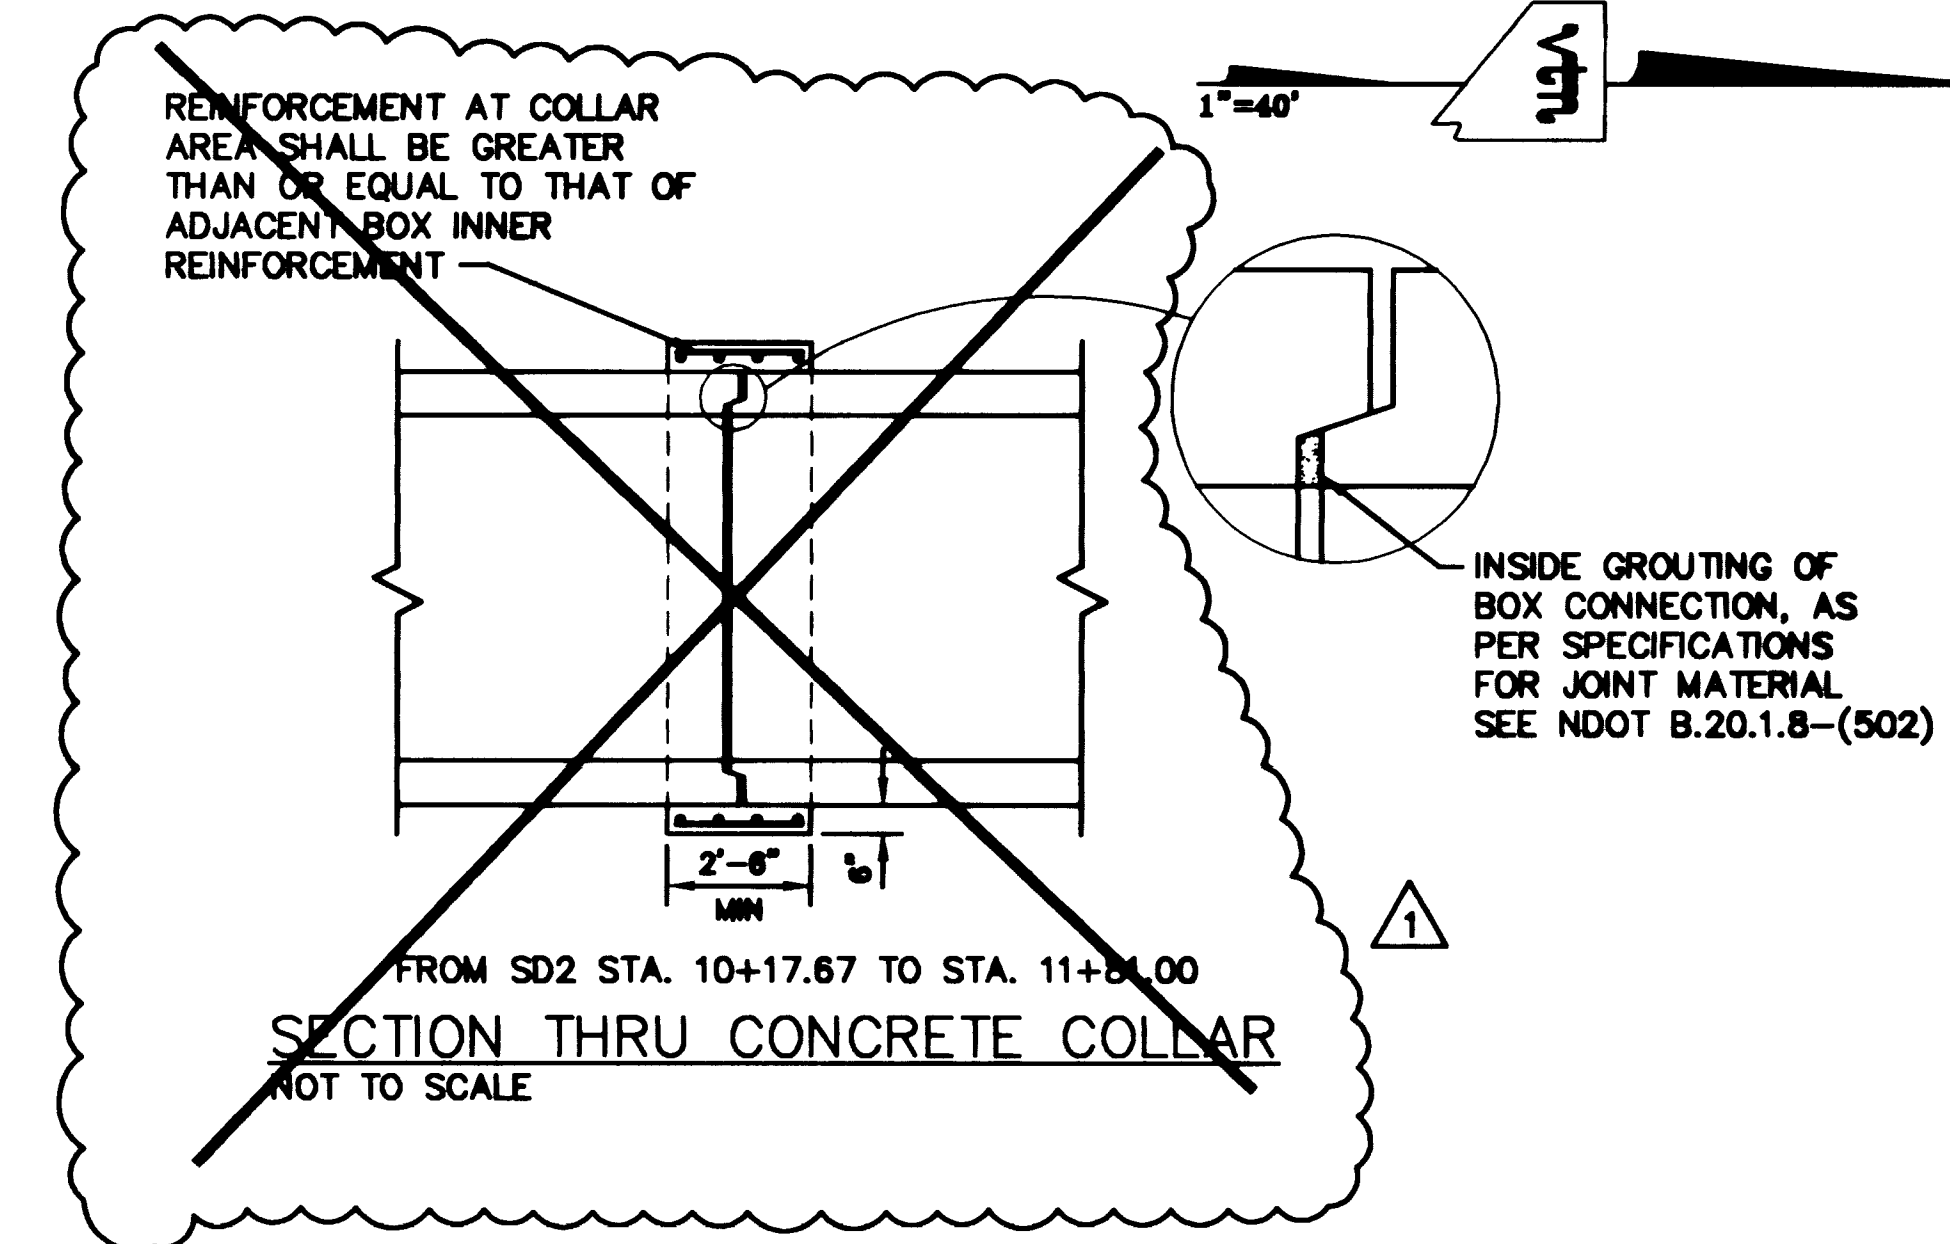


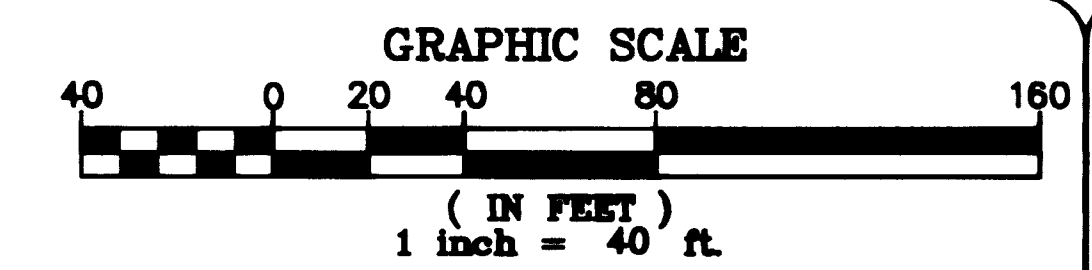

- NOTES**
1. FOR STANDARD WATER NOTES SEE DWG D5.
 2. FOR GENERAL STRUCTURAL NOTES SEE DWG D8.
 3. FOR ADDITIONAL REINFORCEMENT AT OPENINGS SEE DETAIL 2 ON DWG D21.

NOTES:
1. ALL RCP IS TO BE CLASS III.

APPROVED

LAS VEGAS VALLEY WATER DISTRICT DATE

DEPARTMENT OF PUBLIC WORKS
CITY OF LAS VEGAS, NEVADA

vtm
nevada

REV	DATE	BY	REVISION
CONSULTING ENGINEERS • PLANNERS • LAND SURVEYORS			
2727 SOUTH RAINBOW BOULEVARD			
LAS VEGAS, NEVADA 89102-5148 PHONE (702) 873-7550 FAX (702) 362-2597			

STORM DRAIN PLAN AND PROFILE
SD1 STA. 28+00 TO STA. 32+63.21
DURANGO DRIVE

DURANGO DRIVE IMPROVEMENTS
CHEYENNE AVENUE TO LONE MOUNTAIN ROAD

WO. NO. 5249	
BY	JL/LMW/DJE
DATE	07/17/98
SCALE	HORIZ. 1"=40' VERT. 1"=4'
DRAWING SD3	SHEET 54 OF 106 SHEETS