

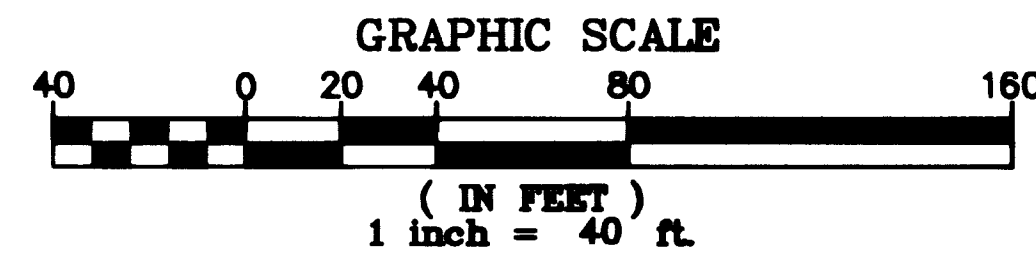


VIEWS: MS = "M", PS = "P.L.T"
I:\CAD\PROJECTS\5249\5249-SD.DWG

32239

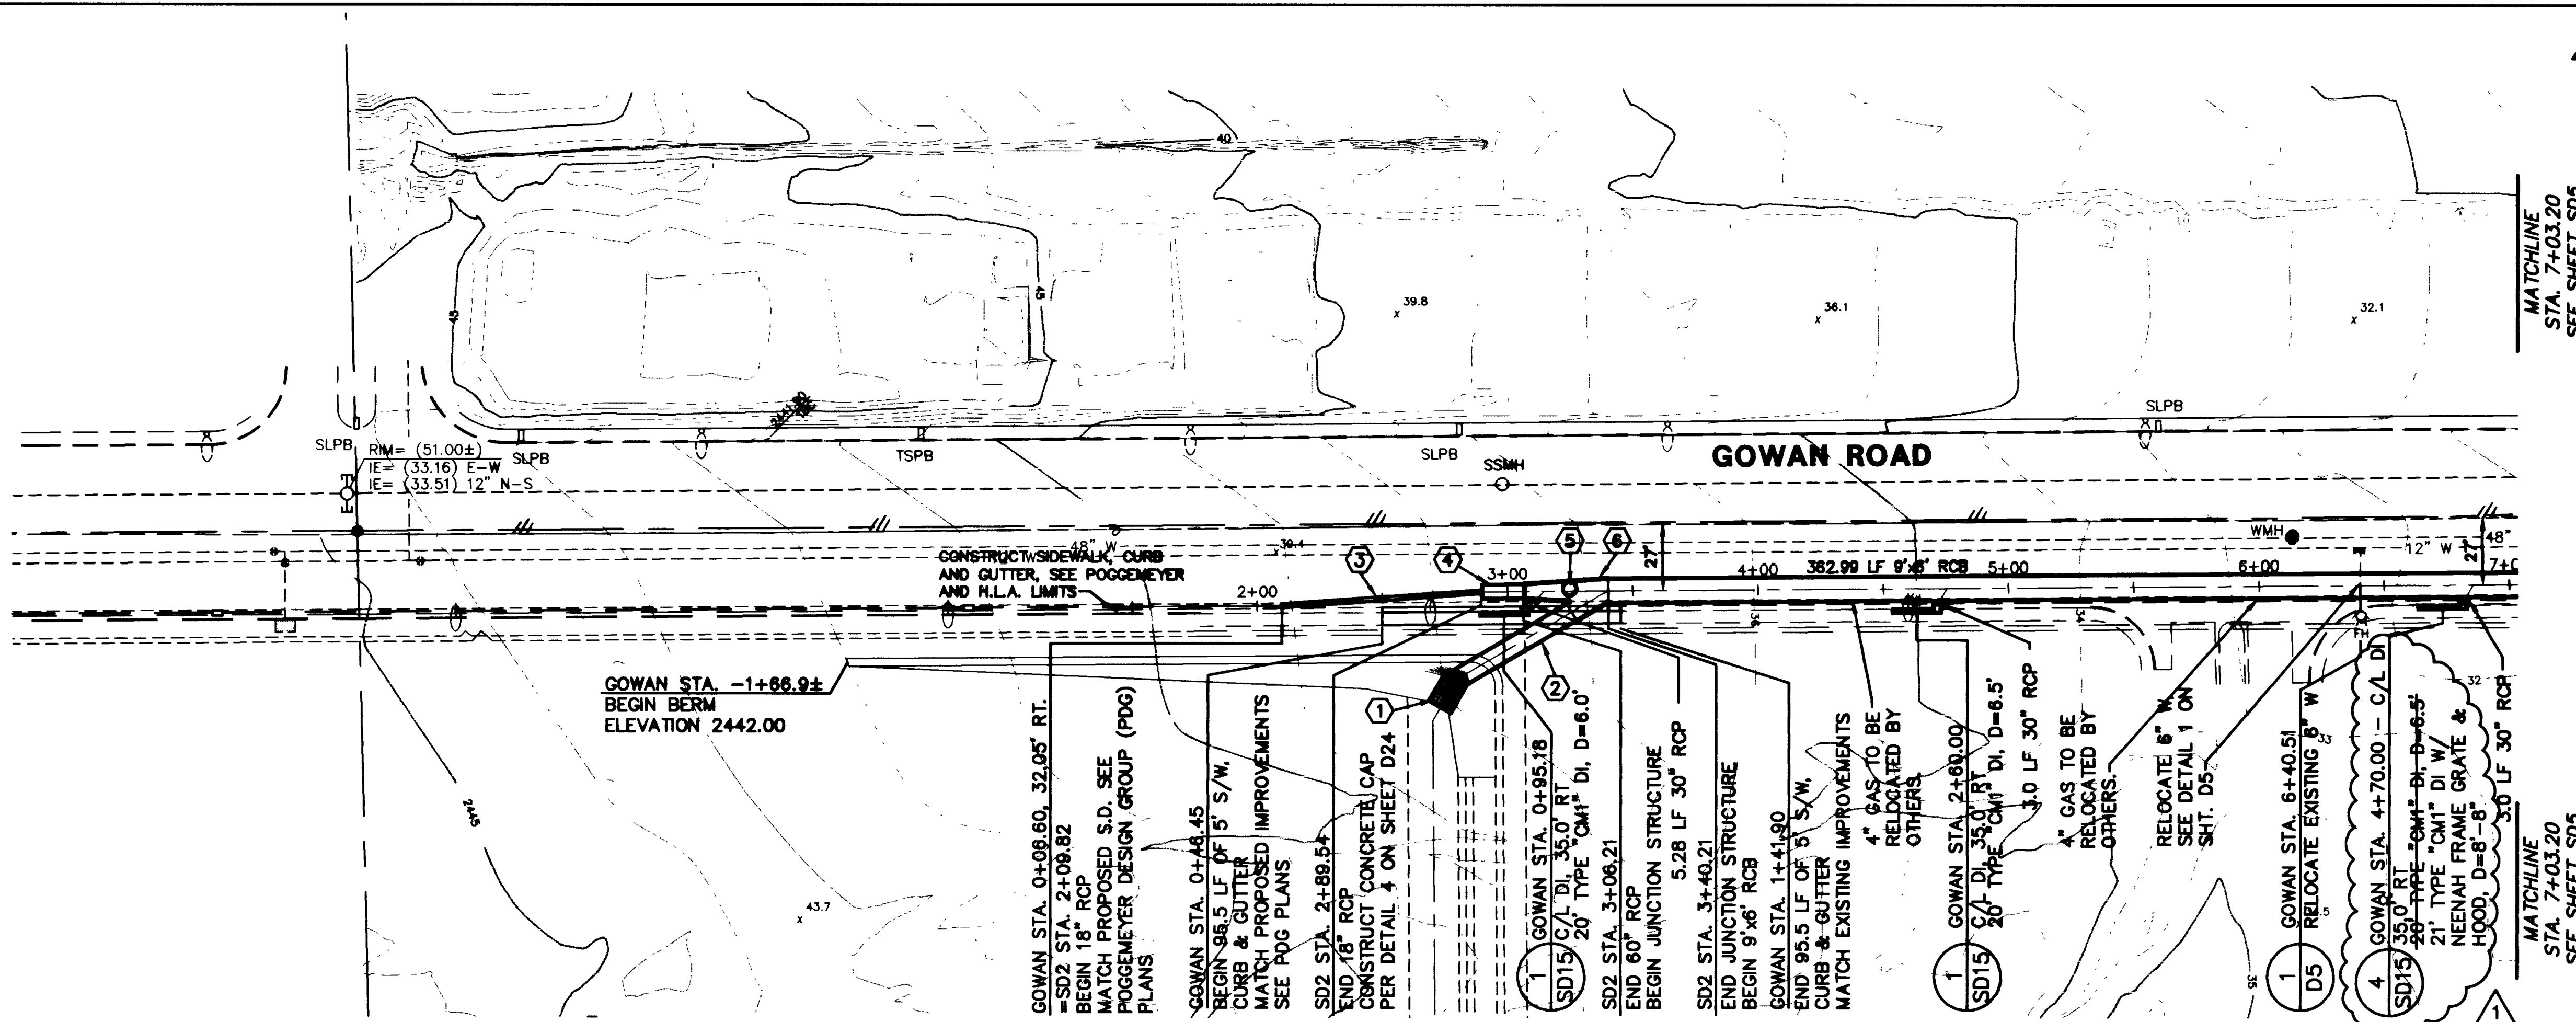

1. CONSTRUCT FIELD INLET PER DETAILS ON SHEET D17-D20.
2. 53.42 LF PRECAST 7'x6' RCB, SEE DETAIL 2 ON SHEET SD15.
3. 79.73 LF 18" RCP
4. 16 LF 60" RCP
5. 60" TYPE IA MANHOLE
6. 34 LF 60" RCP TO 9' x 6' RCB TRANSITION / JUNCTION STRUCTURE SEE DETAILS ON SHEET D8.

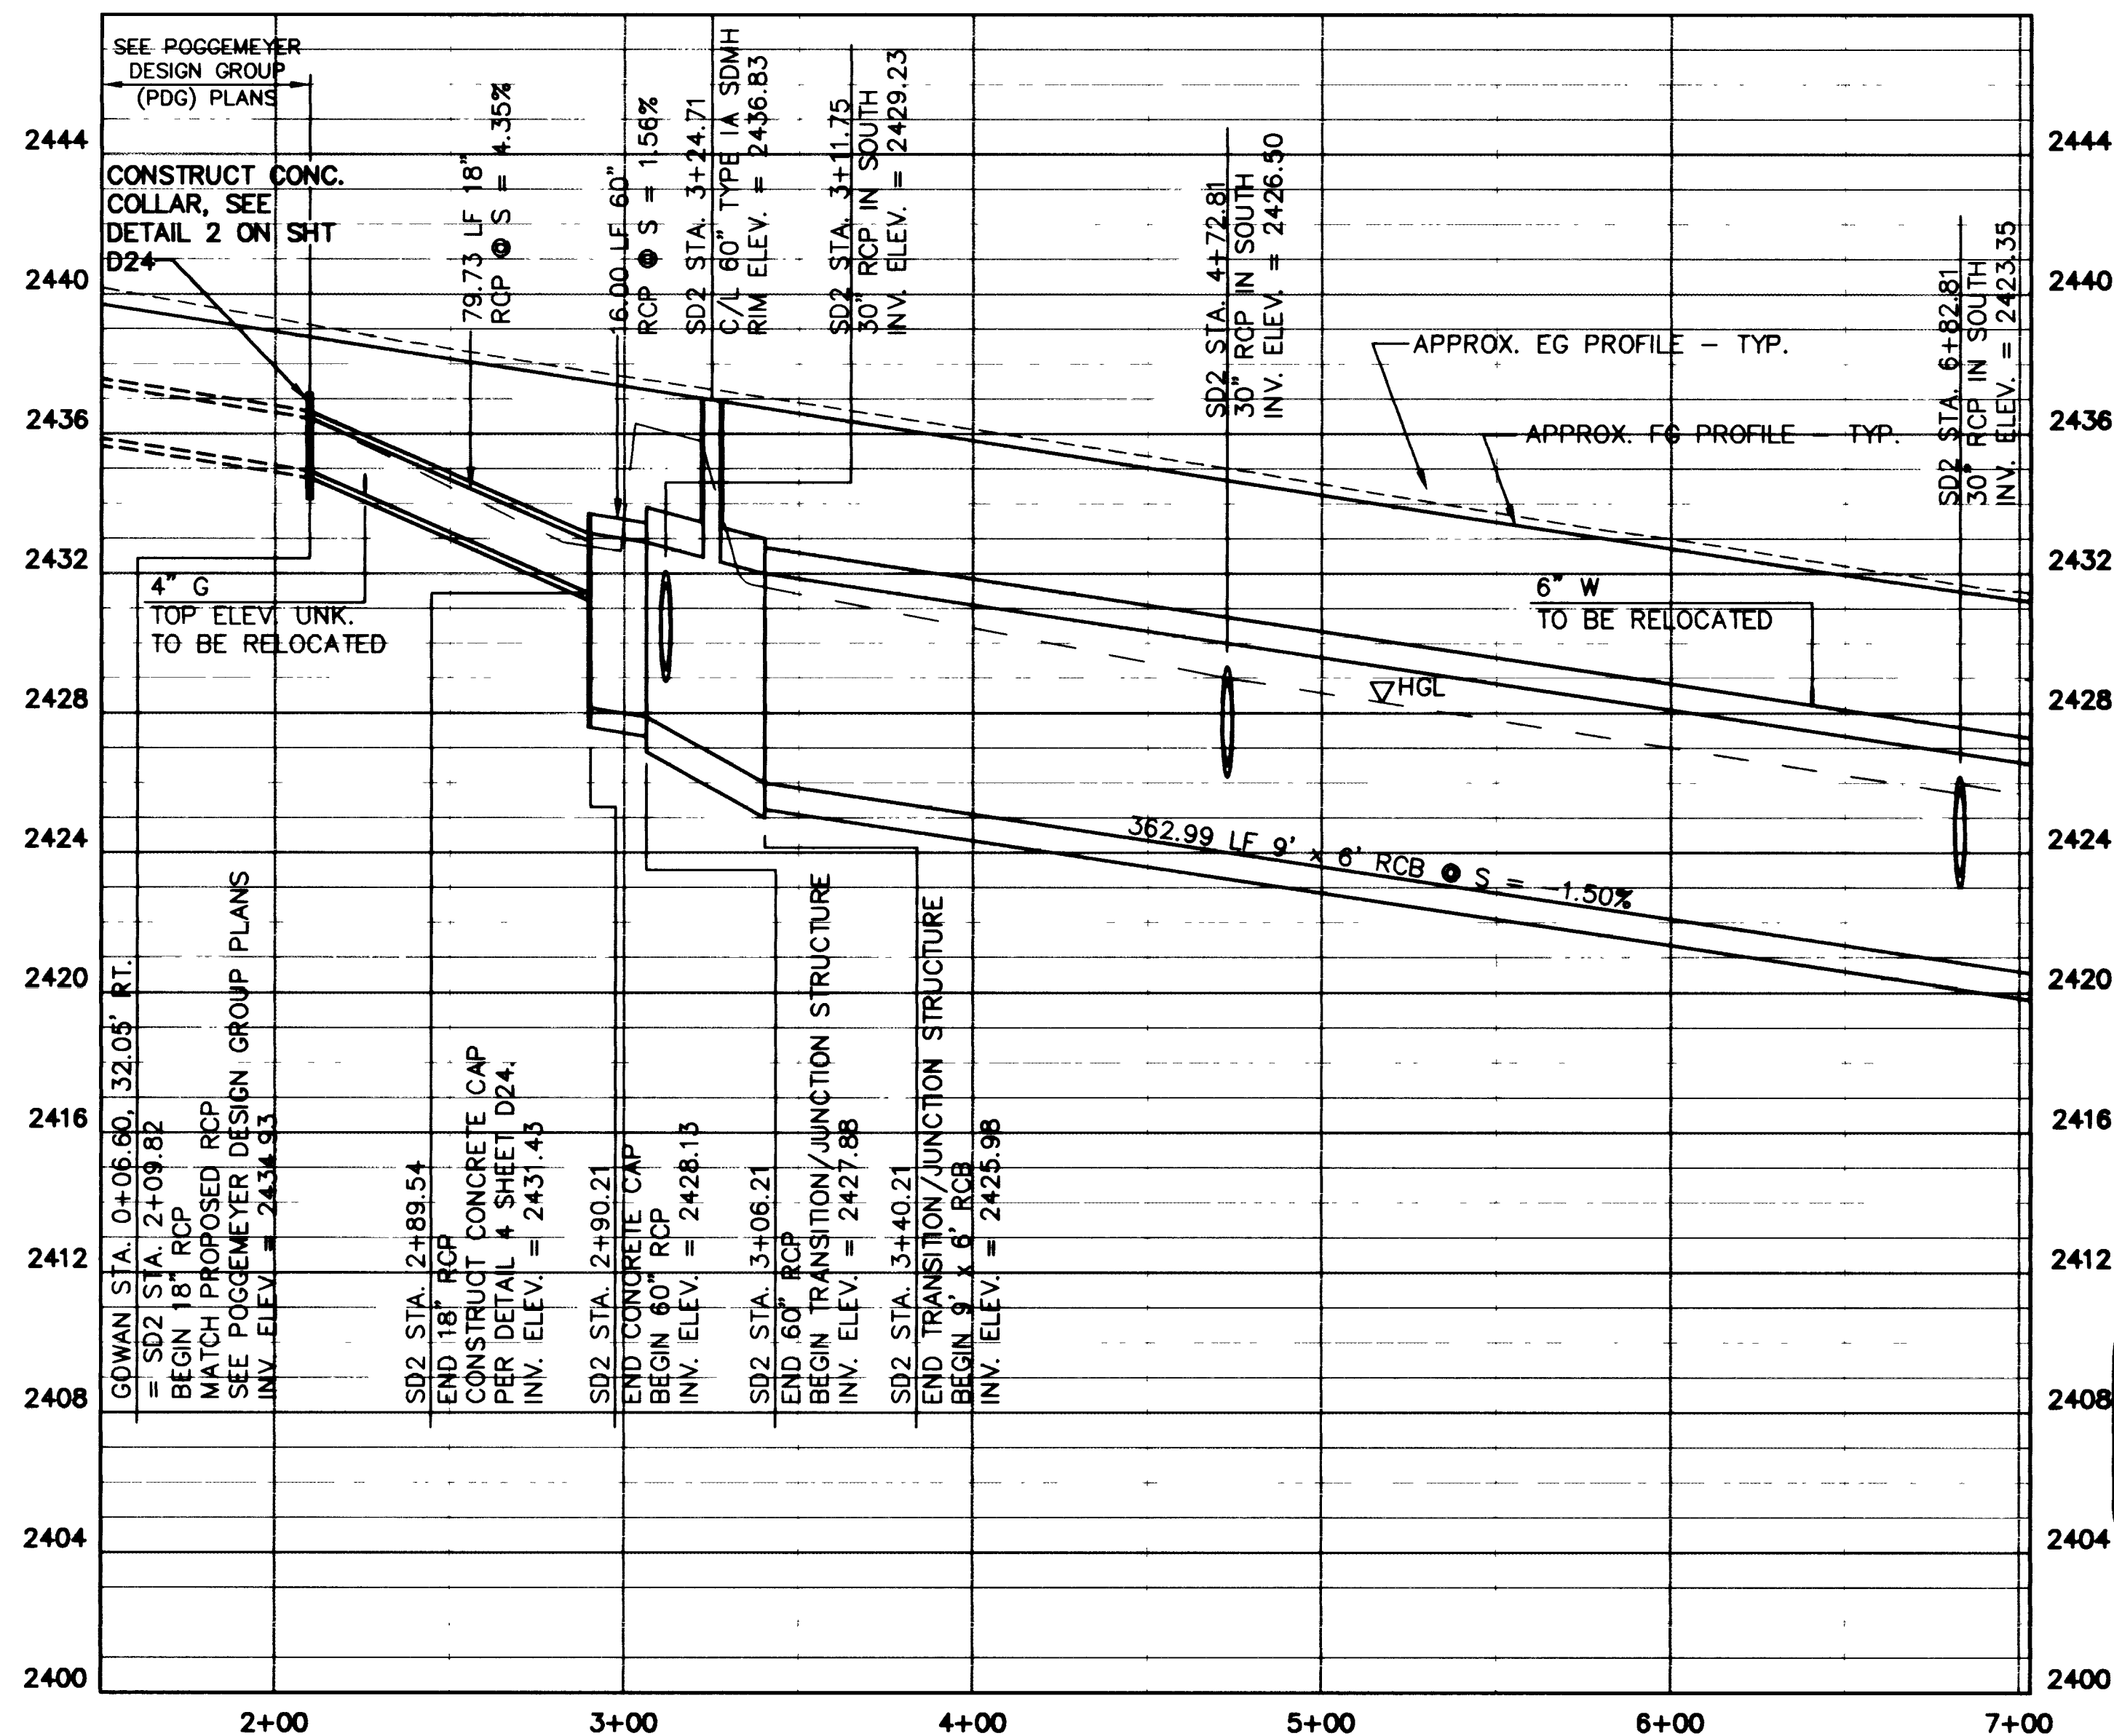

- NOTES:
1. ALL RCP IS TO BE CLASS III.
 2. ALL MH SHOWN ON THIS SHEET TO HAVE 30" RING & COVER
 3. ALL RCB SHALL BE PRECAST RCB.
 4. INSTALL MH STEPS PER STD. DWG. #410 AT MH RISER AND RCB.

APPROVED	
LAS VEGAS VALLEY WATER DISTRICT	DATE

DEPARTMENT OF PUBLIC WORKS	
CITY OF LAS VEGAS, NEVADA	
CONSULTING ENGINEERS	PLANNERS • LAND SURVEYORS
2727 SOUTH RAINBOW BOULEVARD	
LAS VEGAS, NEVADA 89102-5148 PHONE (702) 873-7550 FAX (702) 362-2597	

STORM DRAIN PLAN AND PROFILE	
SD2 STA. 0+00.00 TO 7+03.20	
GOWAN ROAD	
DURANGO DRIVE IMPROVEMENTS	
CHEYENNE AVENUE TO LONE MOUNTAIN ROAD	

W.D. NO.	5249
BY	JL, LMW
DATE	07/17/98
SCALE	HORIZ. 1"=40' VERT. 1"=4'
DRAWING	SHEET 55 OF 106 SHEETS
SD4	

RECORD DRAWING 03/23/01