
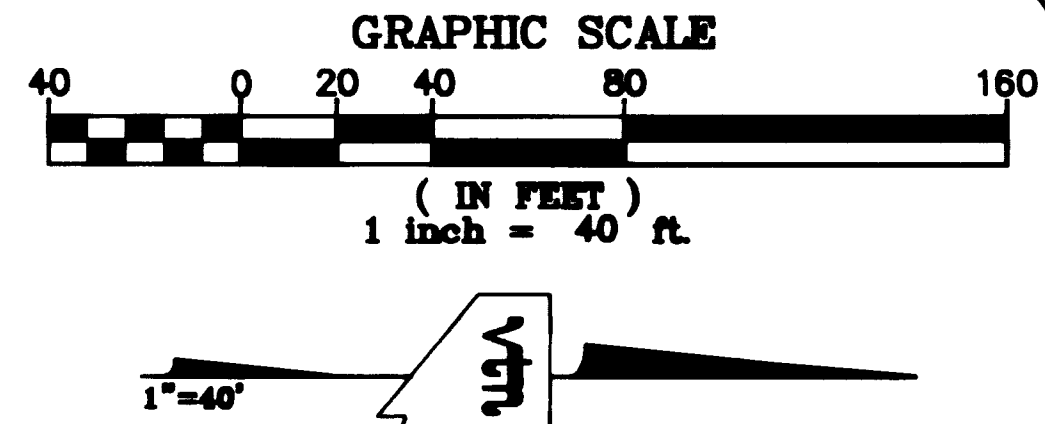
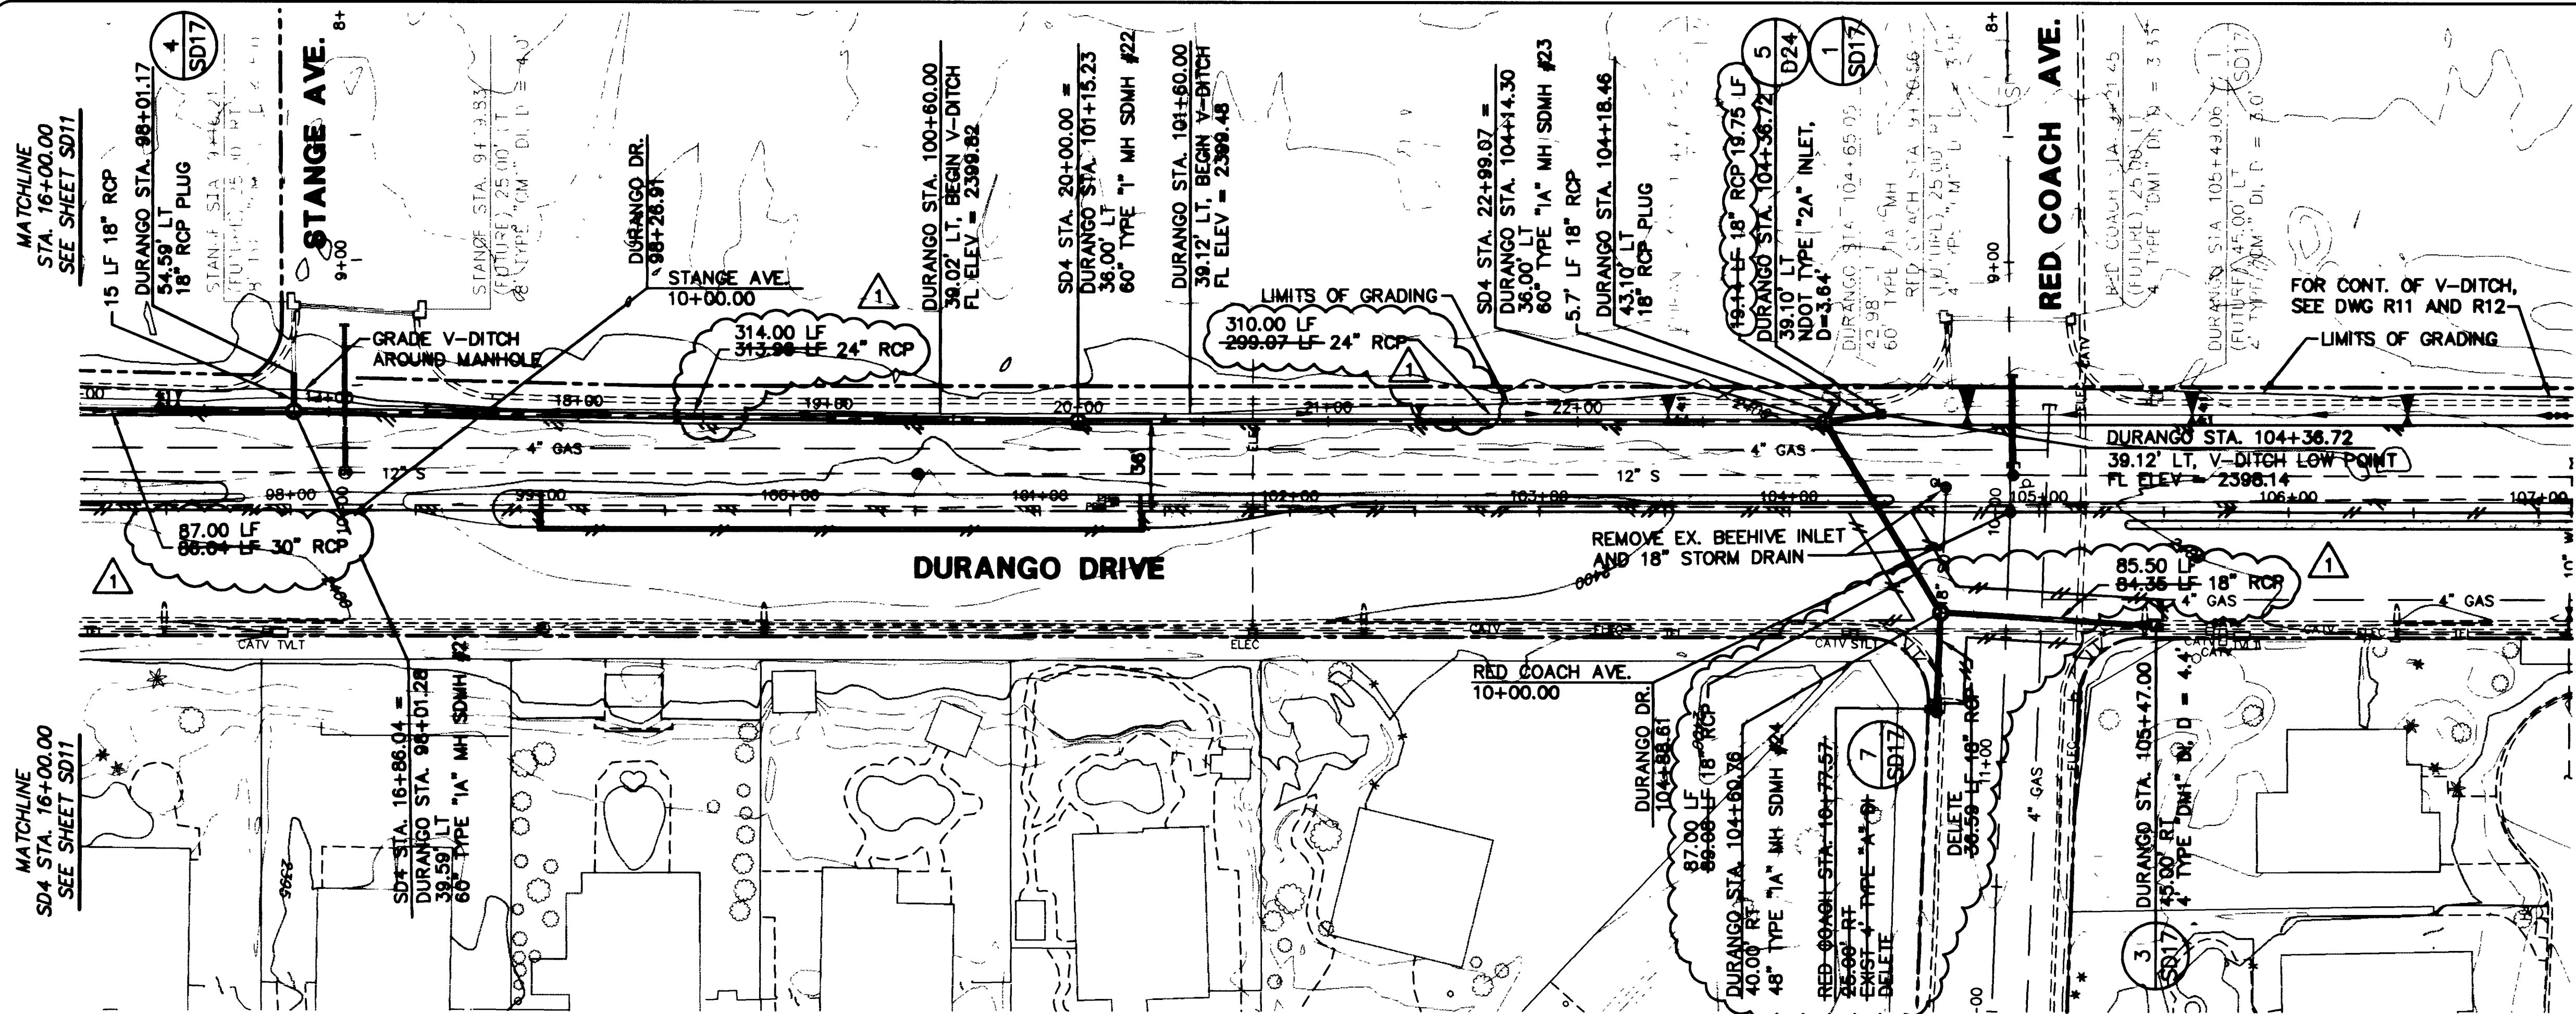


NEWS: MS = "J", PS = "PLT"
P:\CAD\DWG\MS\5249\5249-SD.DWG

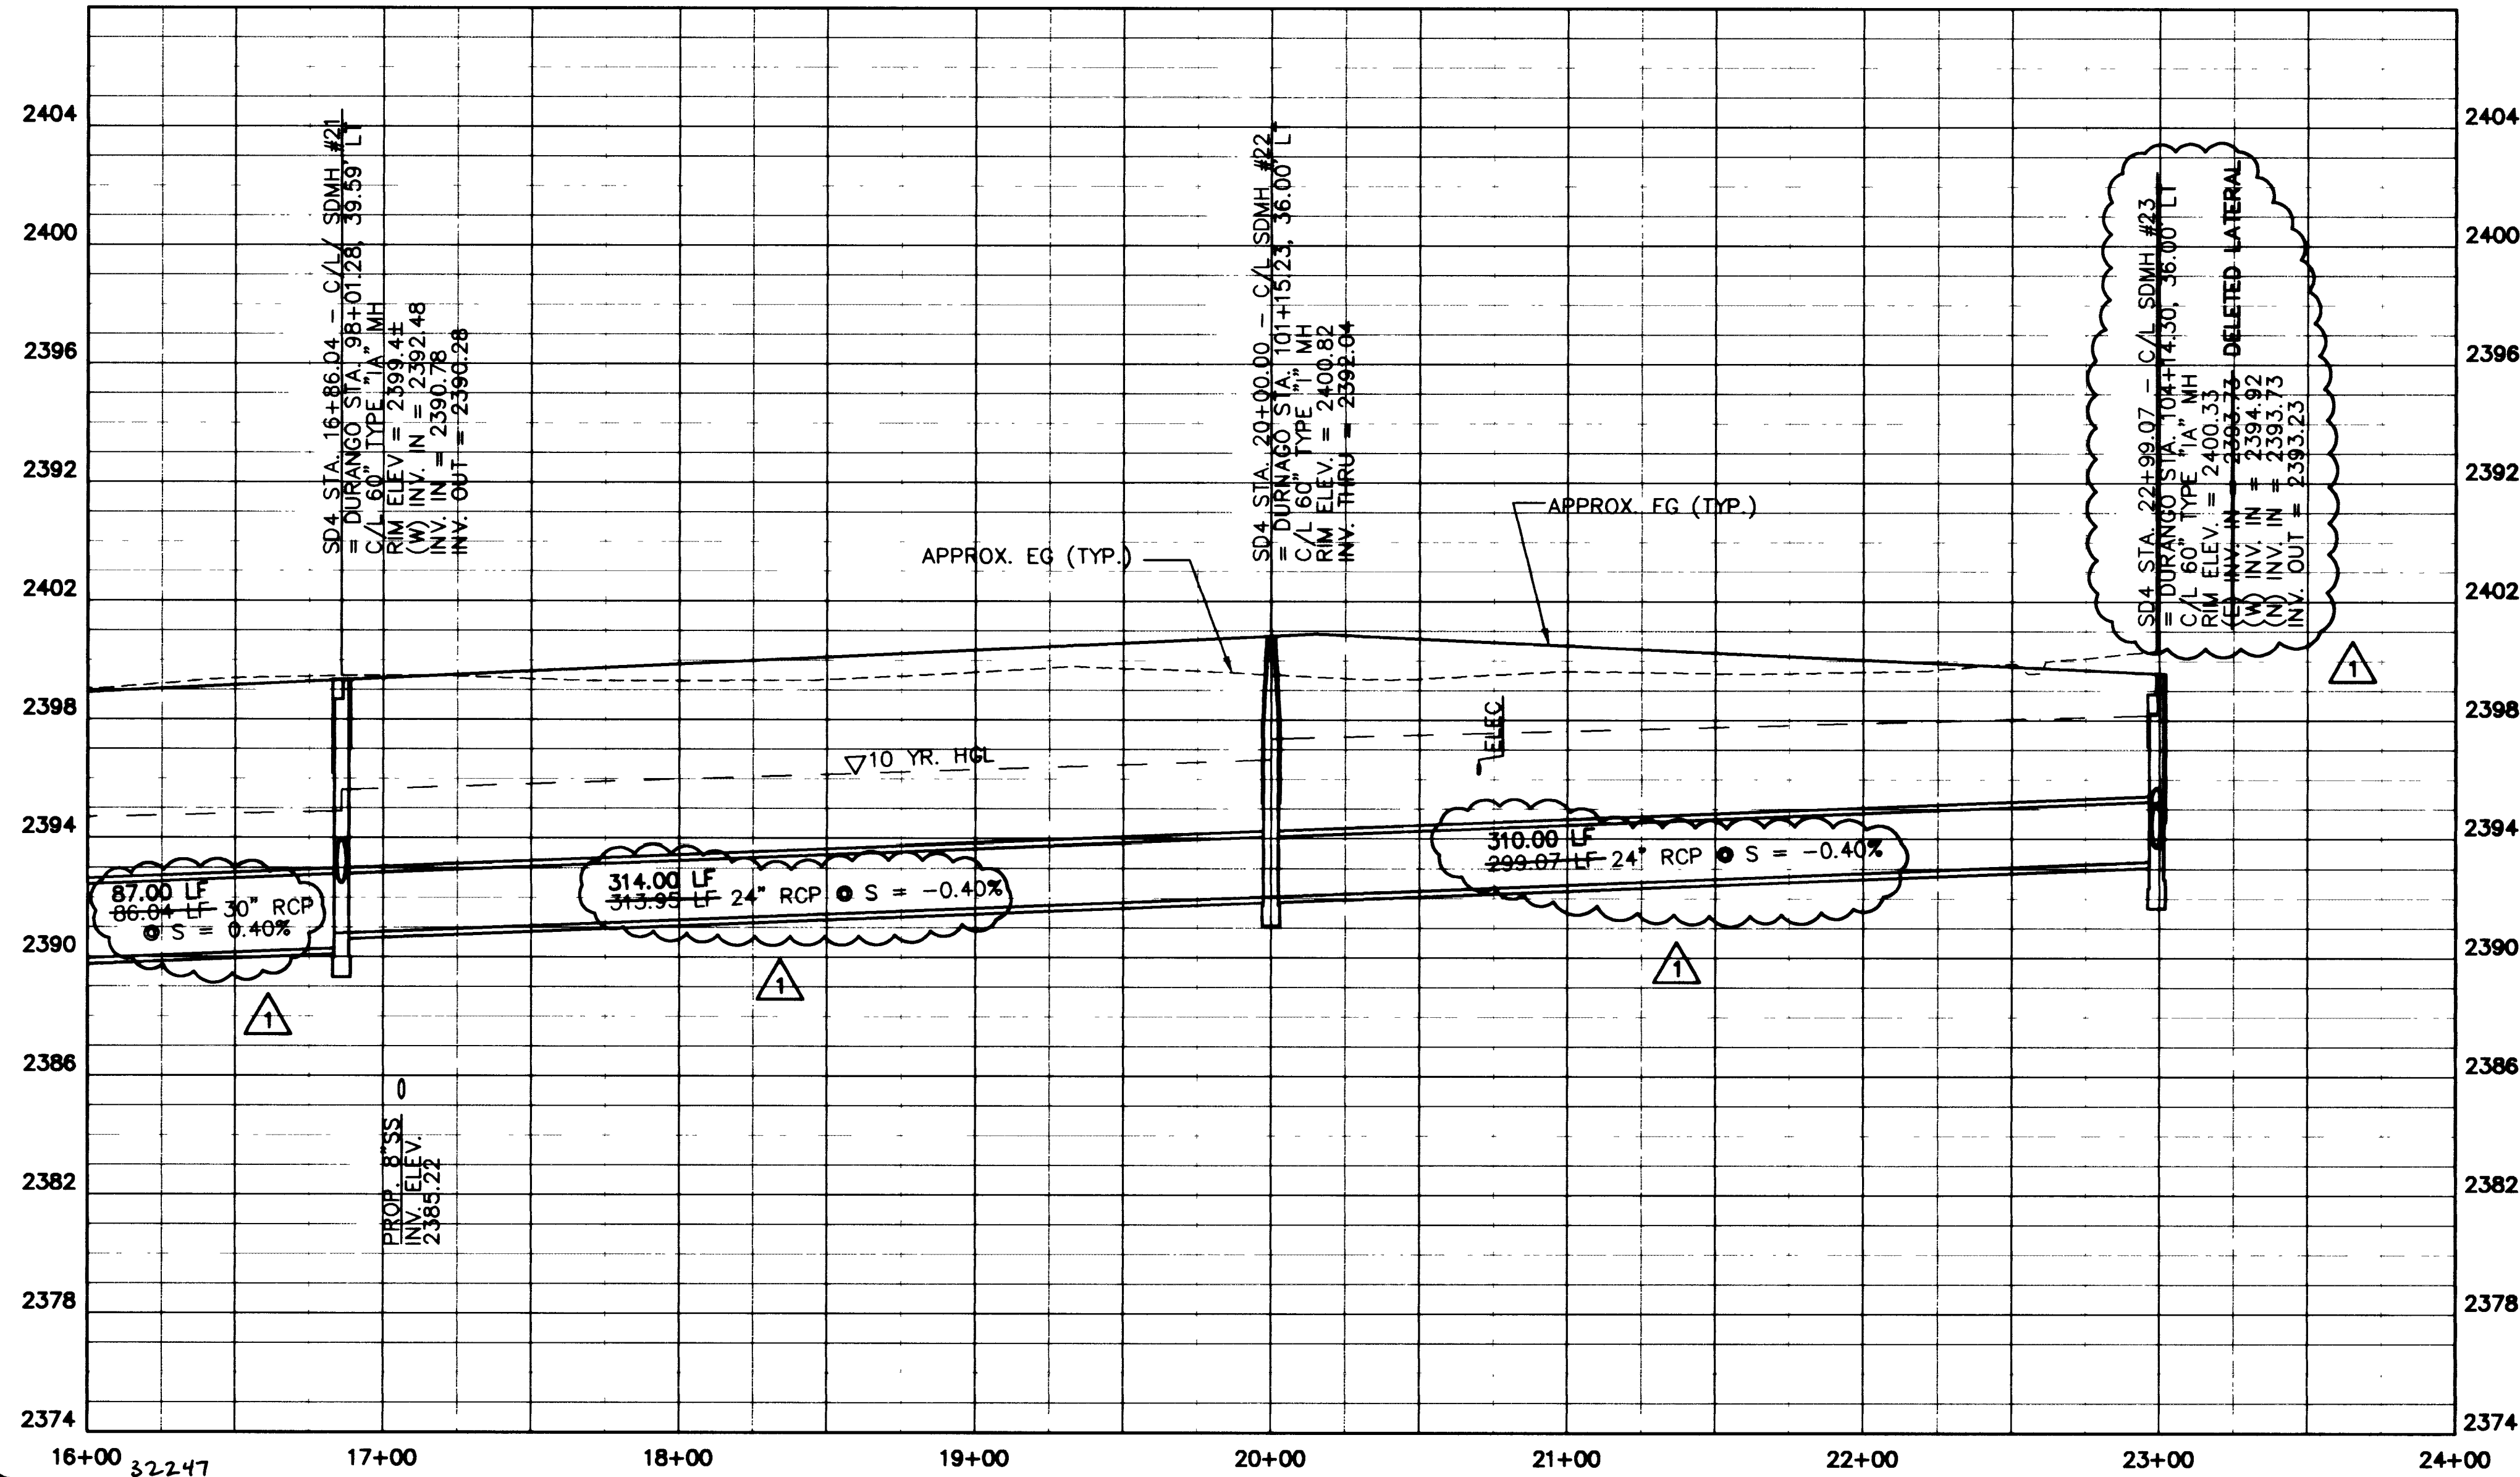

NOTES:
1. ALL RCP IS TO BE CLASS III.

DEPARTMENT OF PUBLIC WORKS CITY OF LAS VEGAS, NEVADA		CONSULTING ENGINEERS • PLANNERS • LAND SURVEYORS 2727 SOUTH RAINBOW BOULEVARD LAS VEGAS, NEVADA 89102-5148 PHONE (702) 873-7550 FAX (702) 362-2597	
STORM DRAIN PLAN AND PROFILE SD4 STA. 16+00 TO STA. 22+99.07 DURANGO DRIVE		DURANGO DRIVE IMPROVEMENTS CHEYENNE AVENUE TO LONE MOUNTAIN ROAD	
NO. NO. 5249		BY JL/LMW/DJB	
DATE 07/17/98		SCALE HORIZ. 1"=40' VERT. 1"=4'	
DRAWING SD12		SHEET 63 OF 106 SHEETS	