

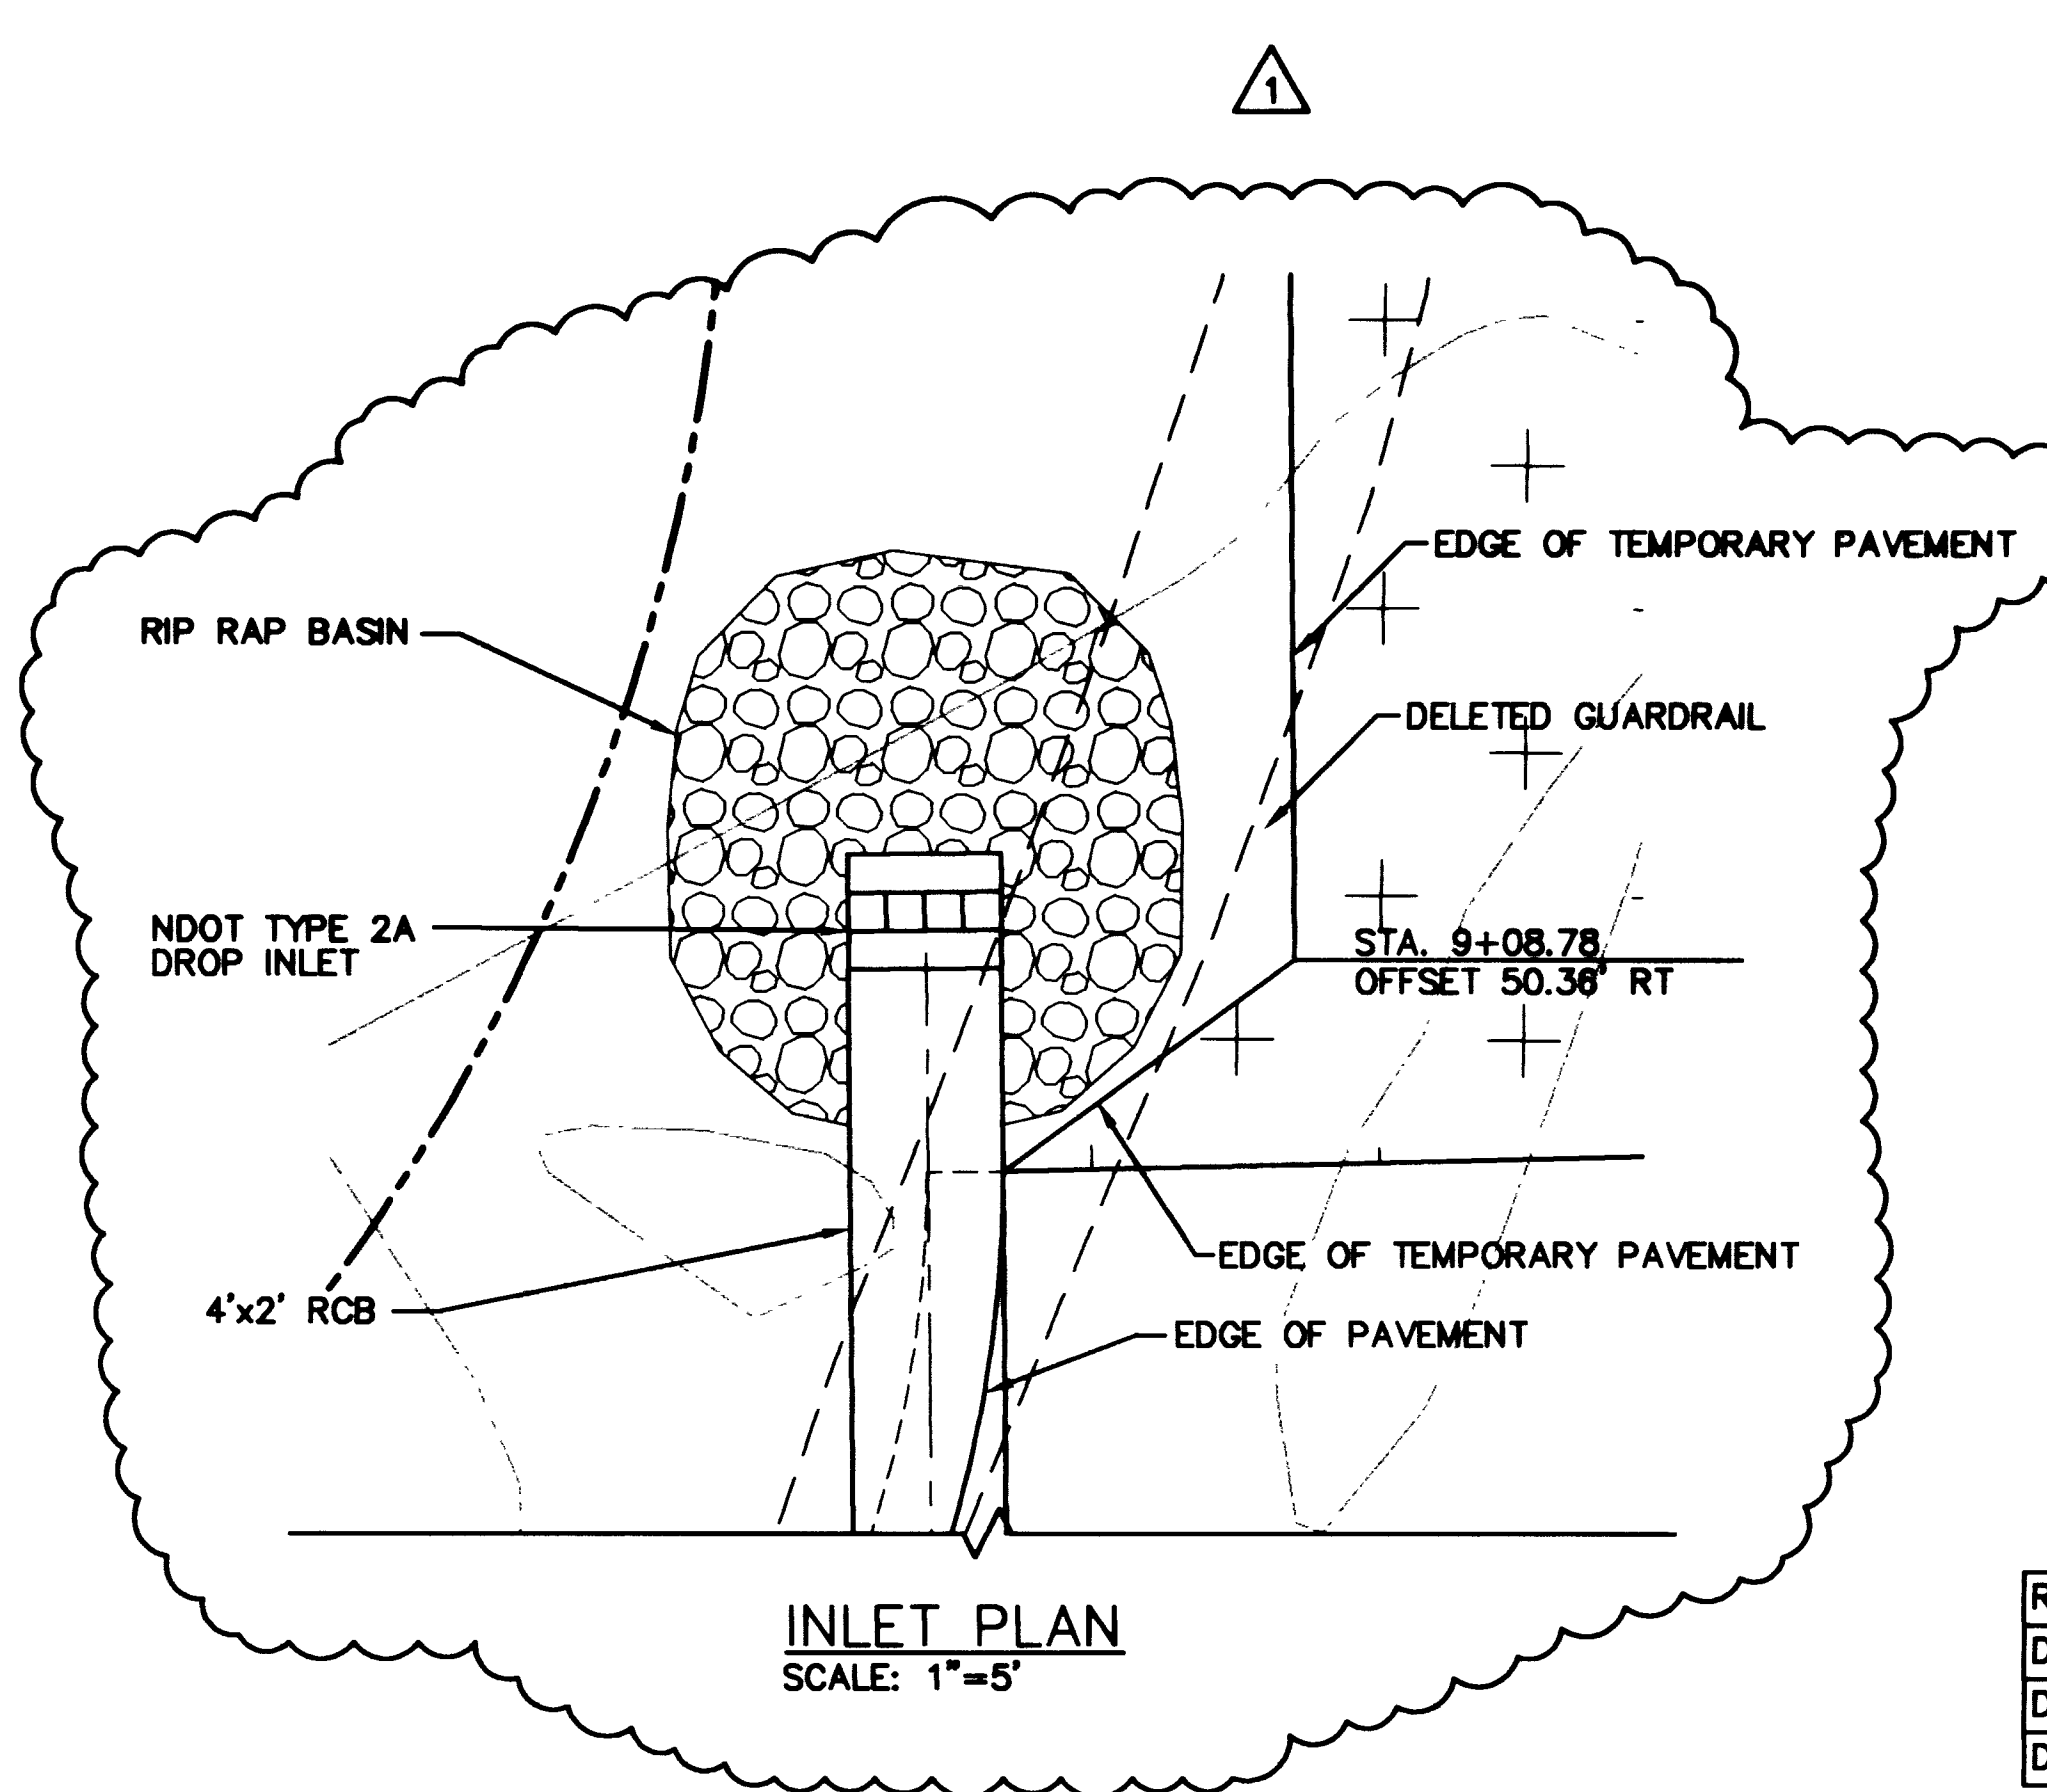
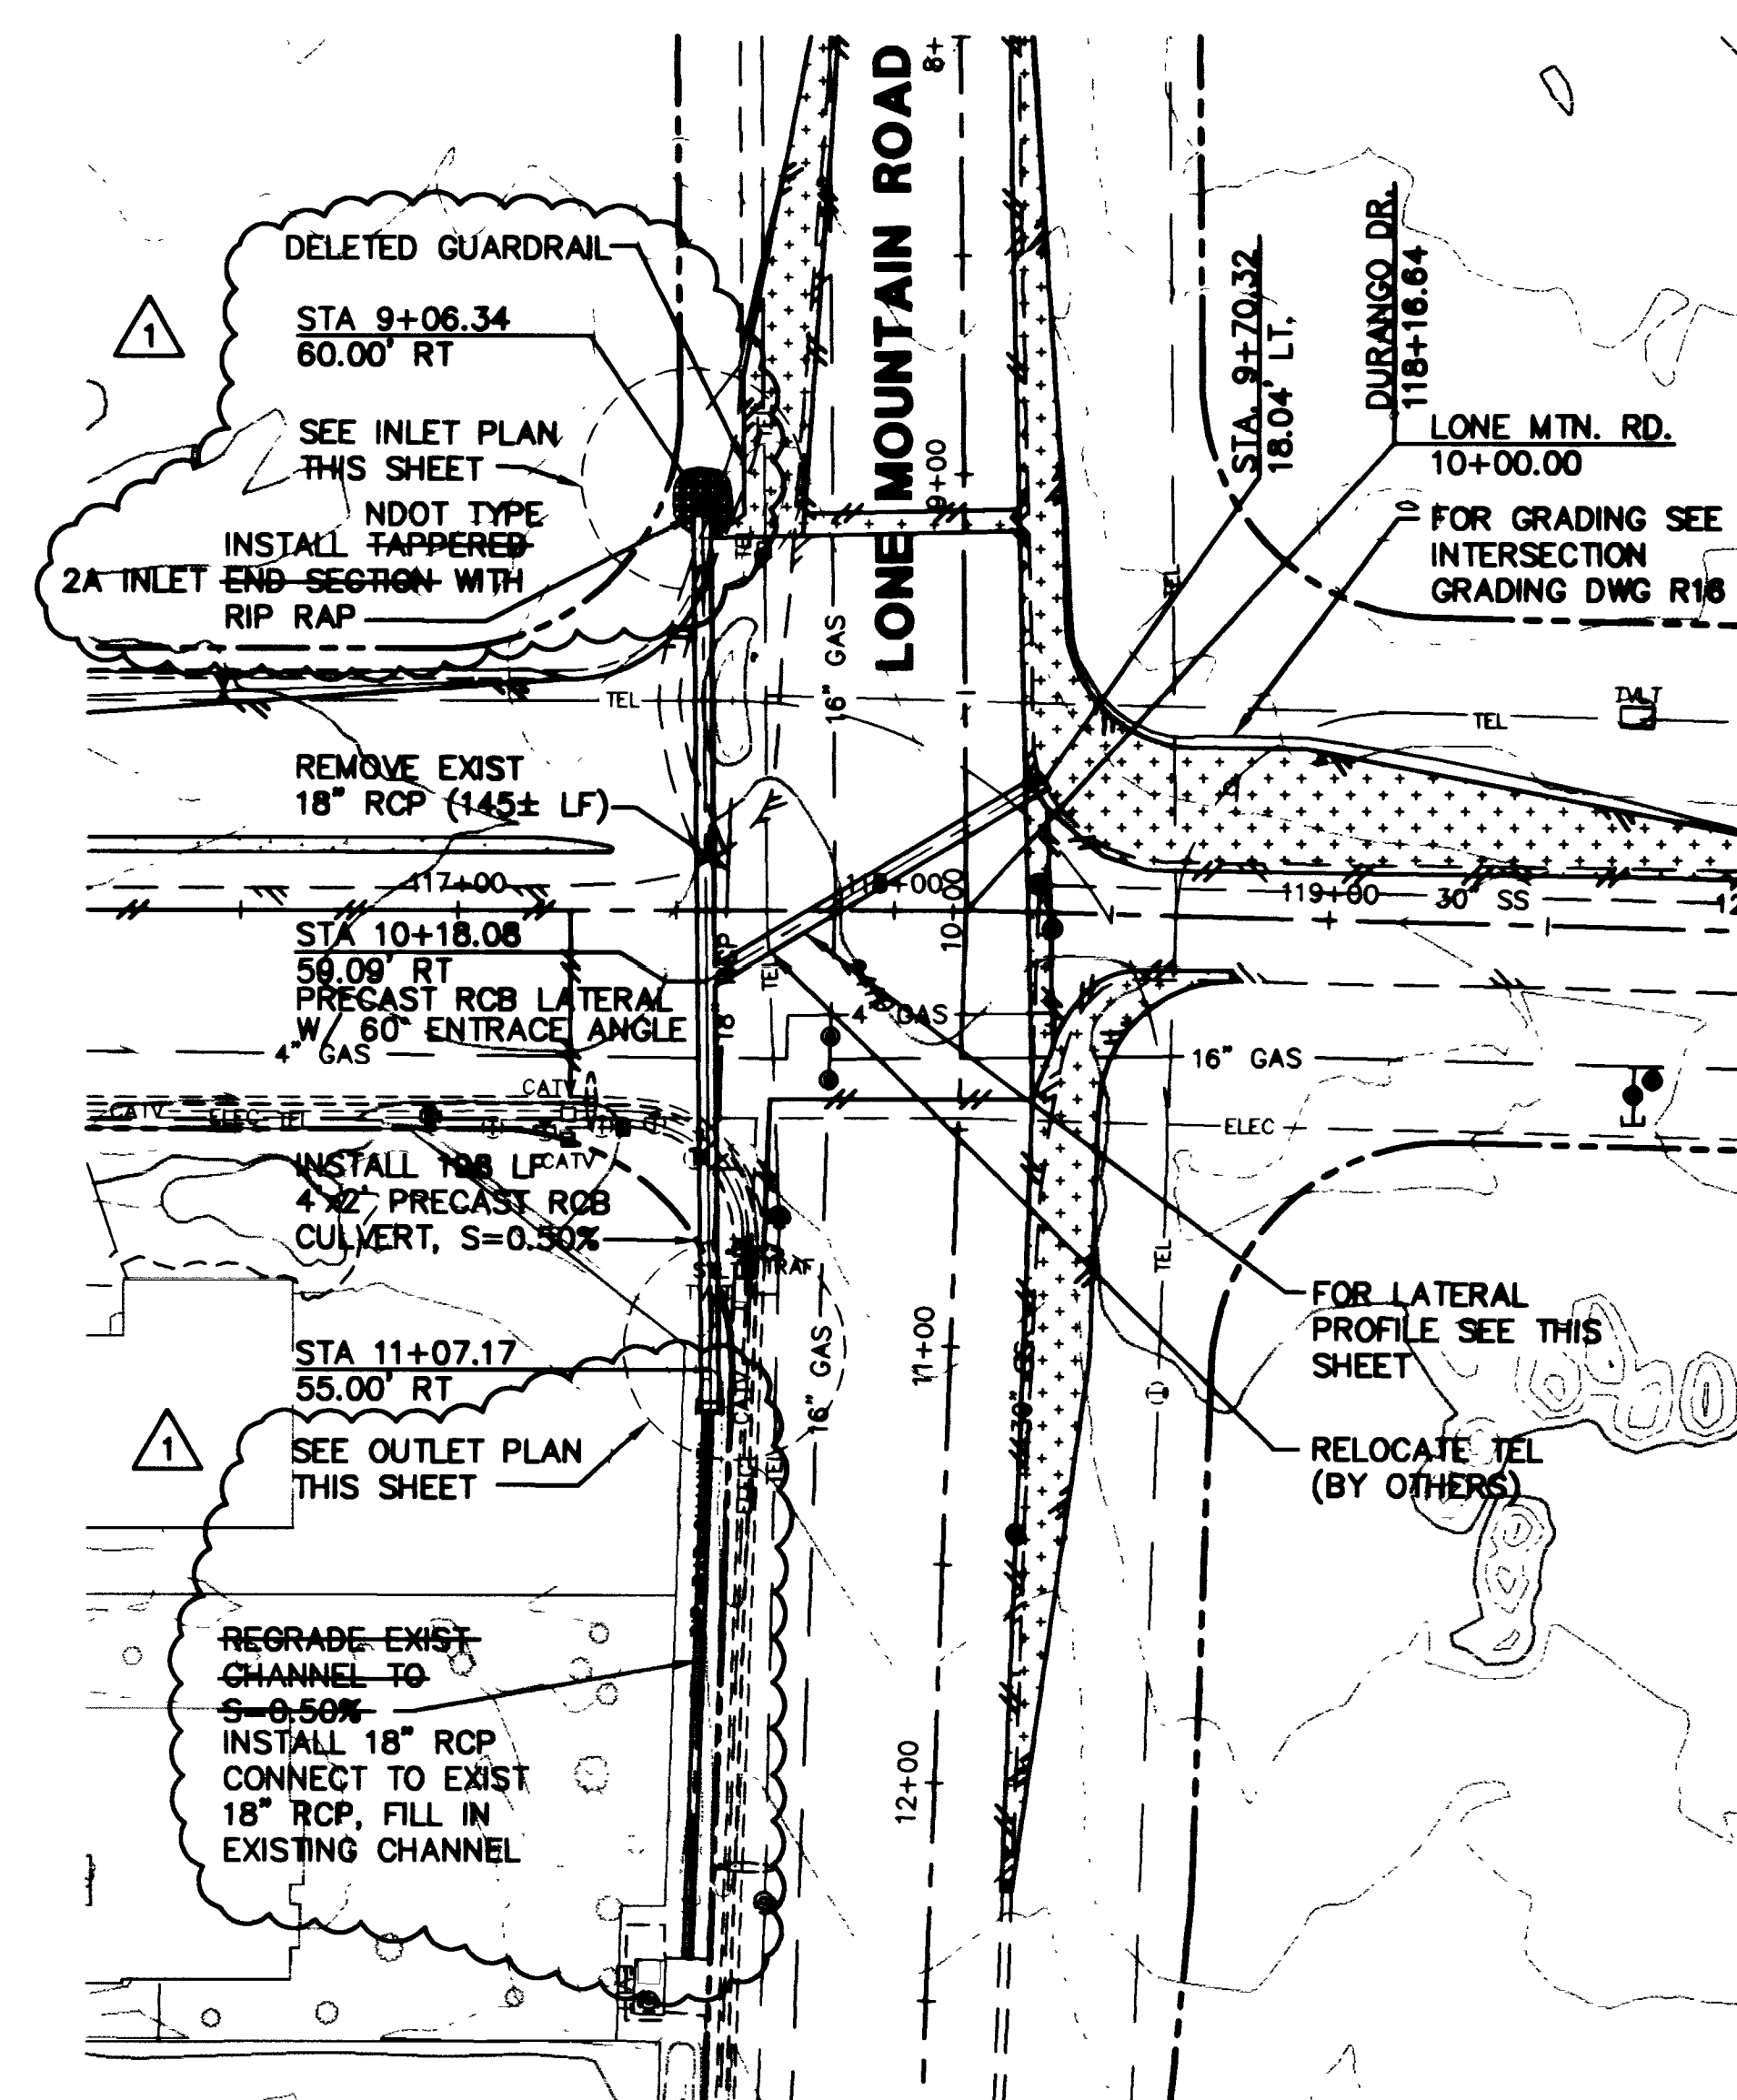
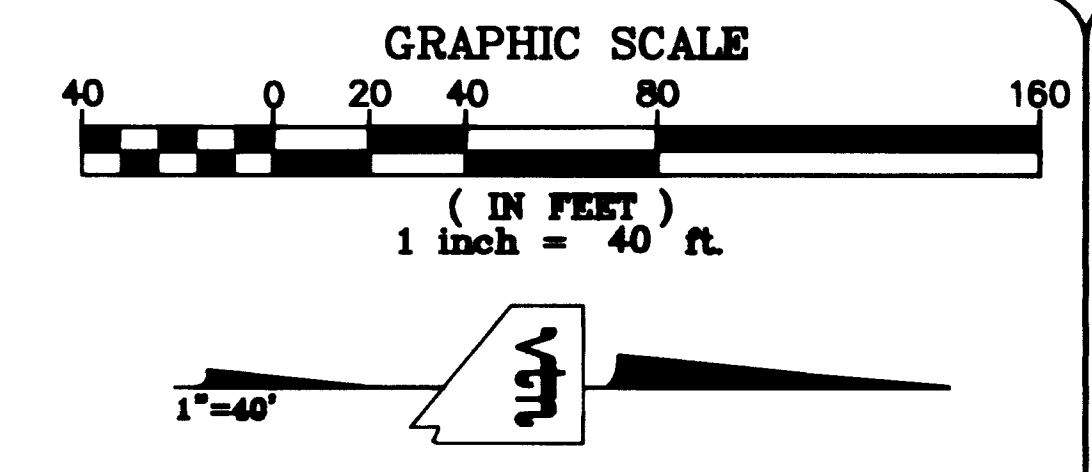
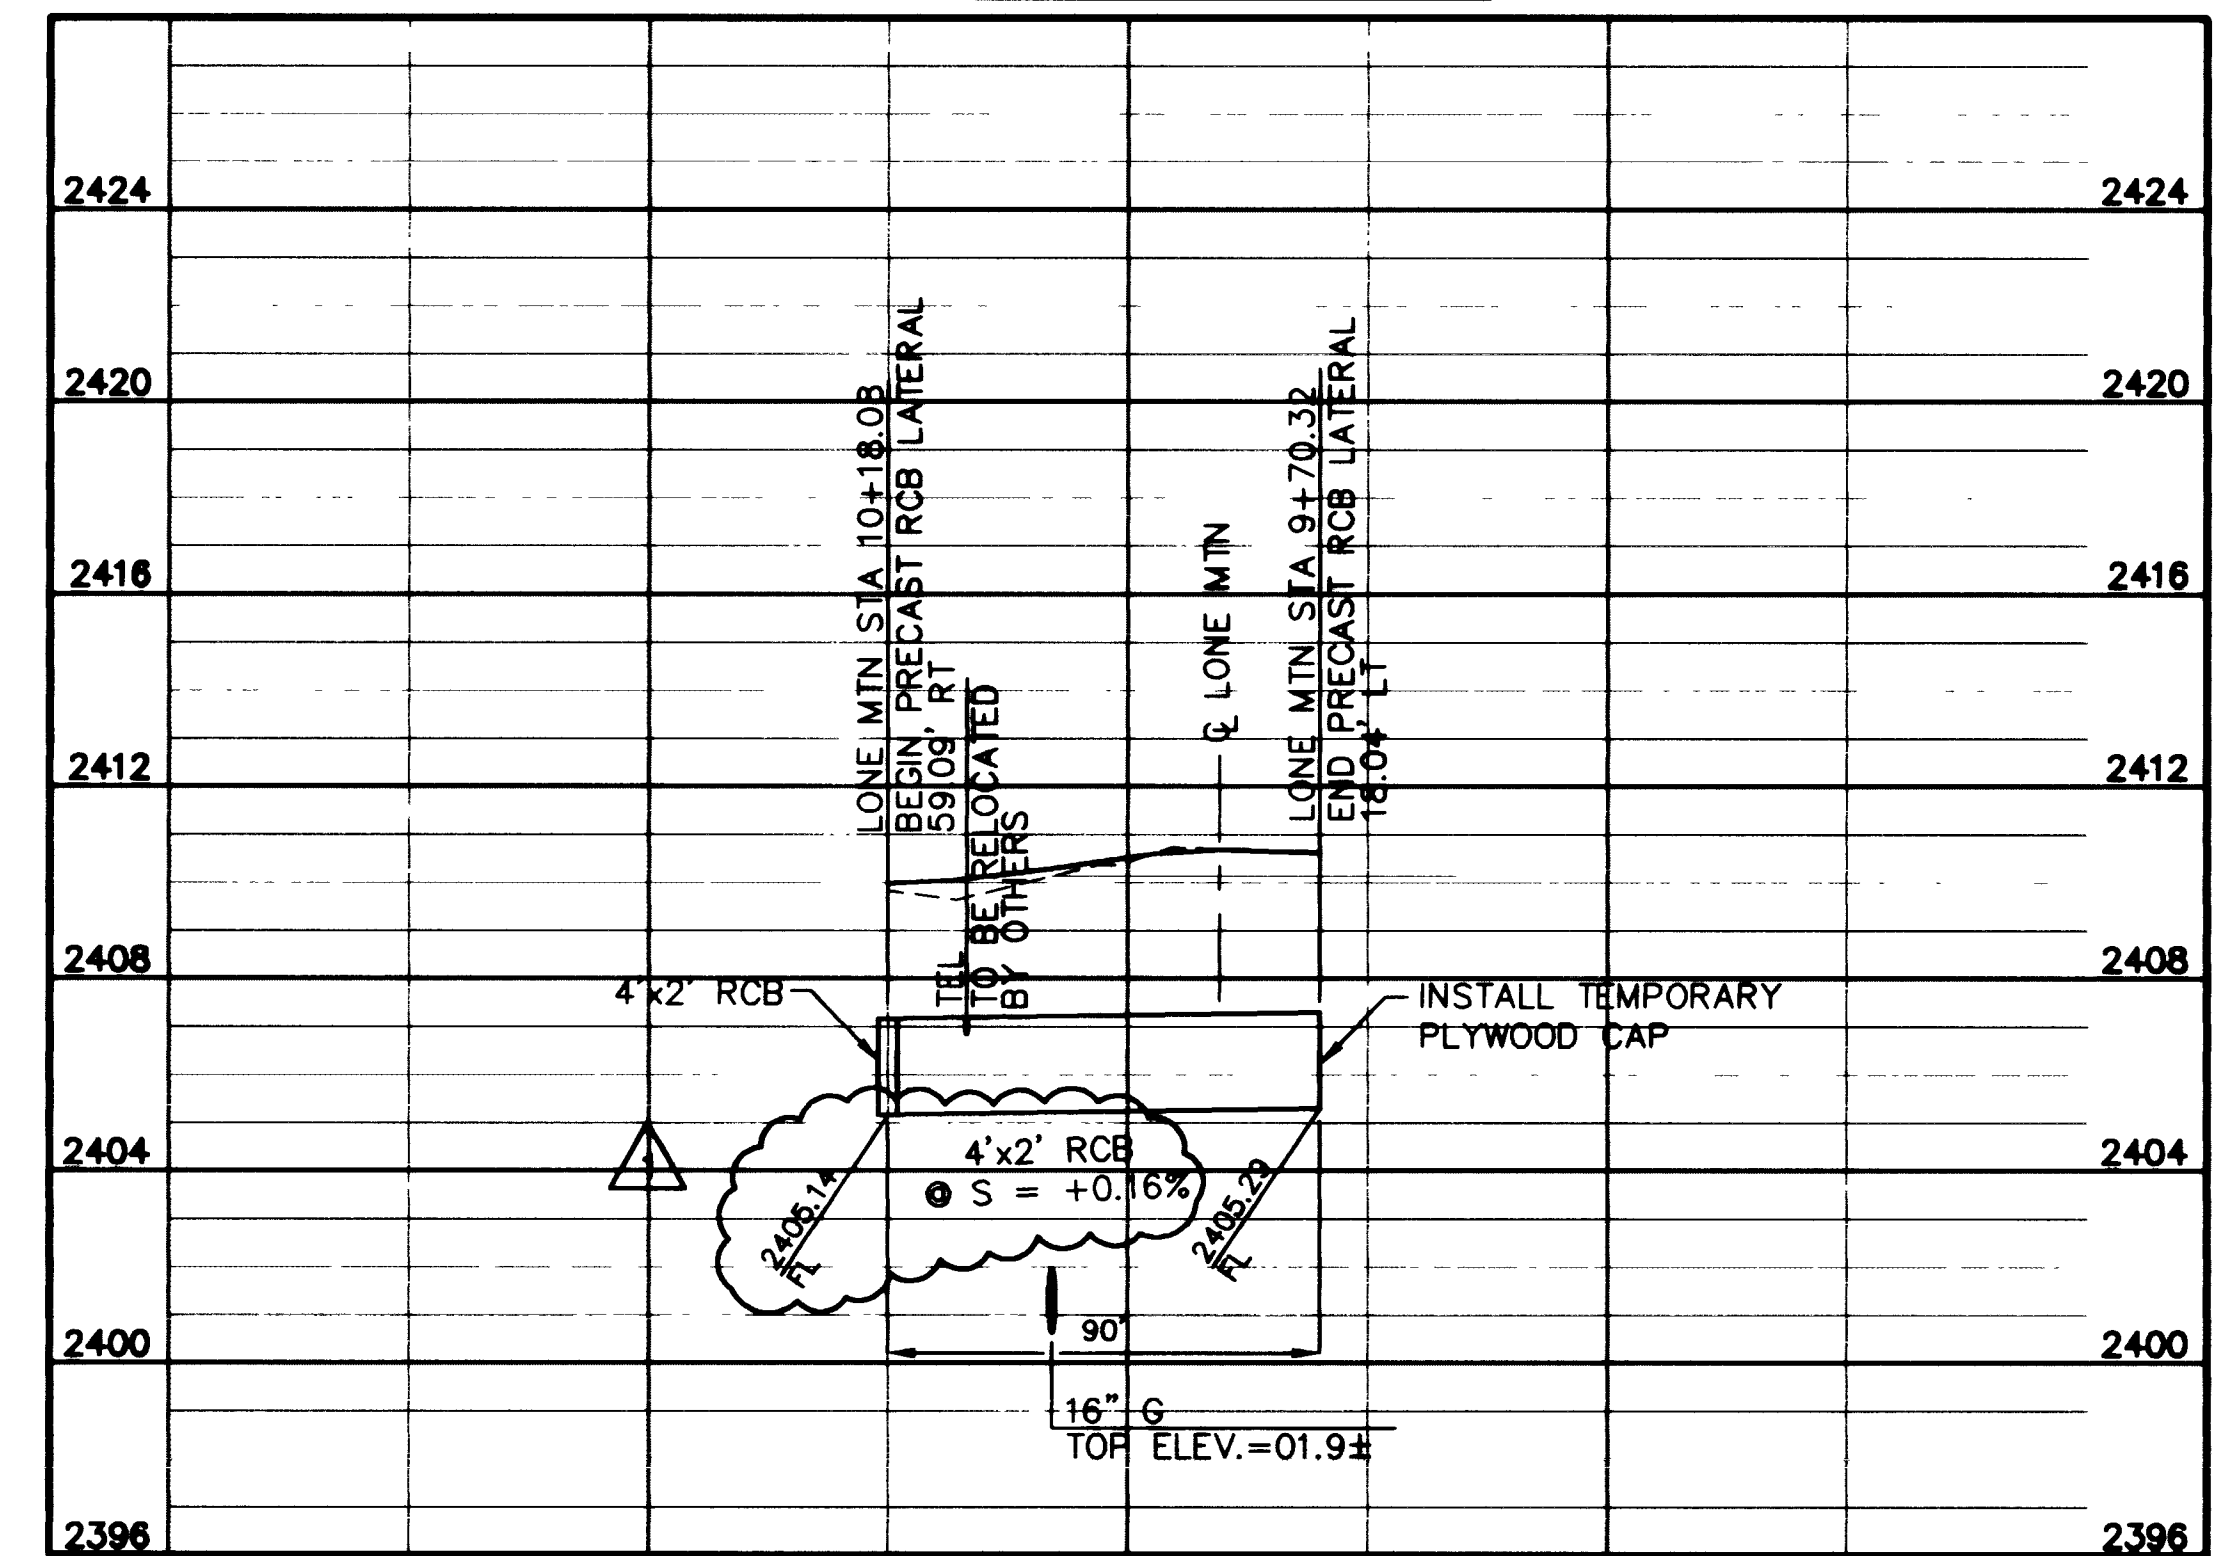


Views: MS = "L", PS = "PLT"
I:\CAD\DWG\13449\13449-SD.DWG

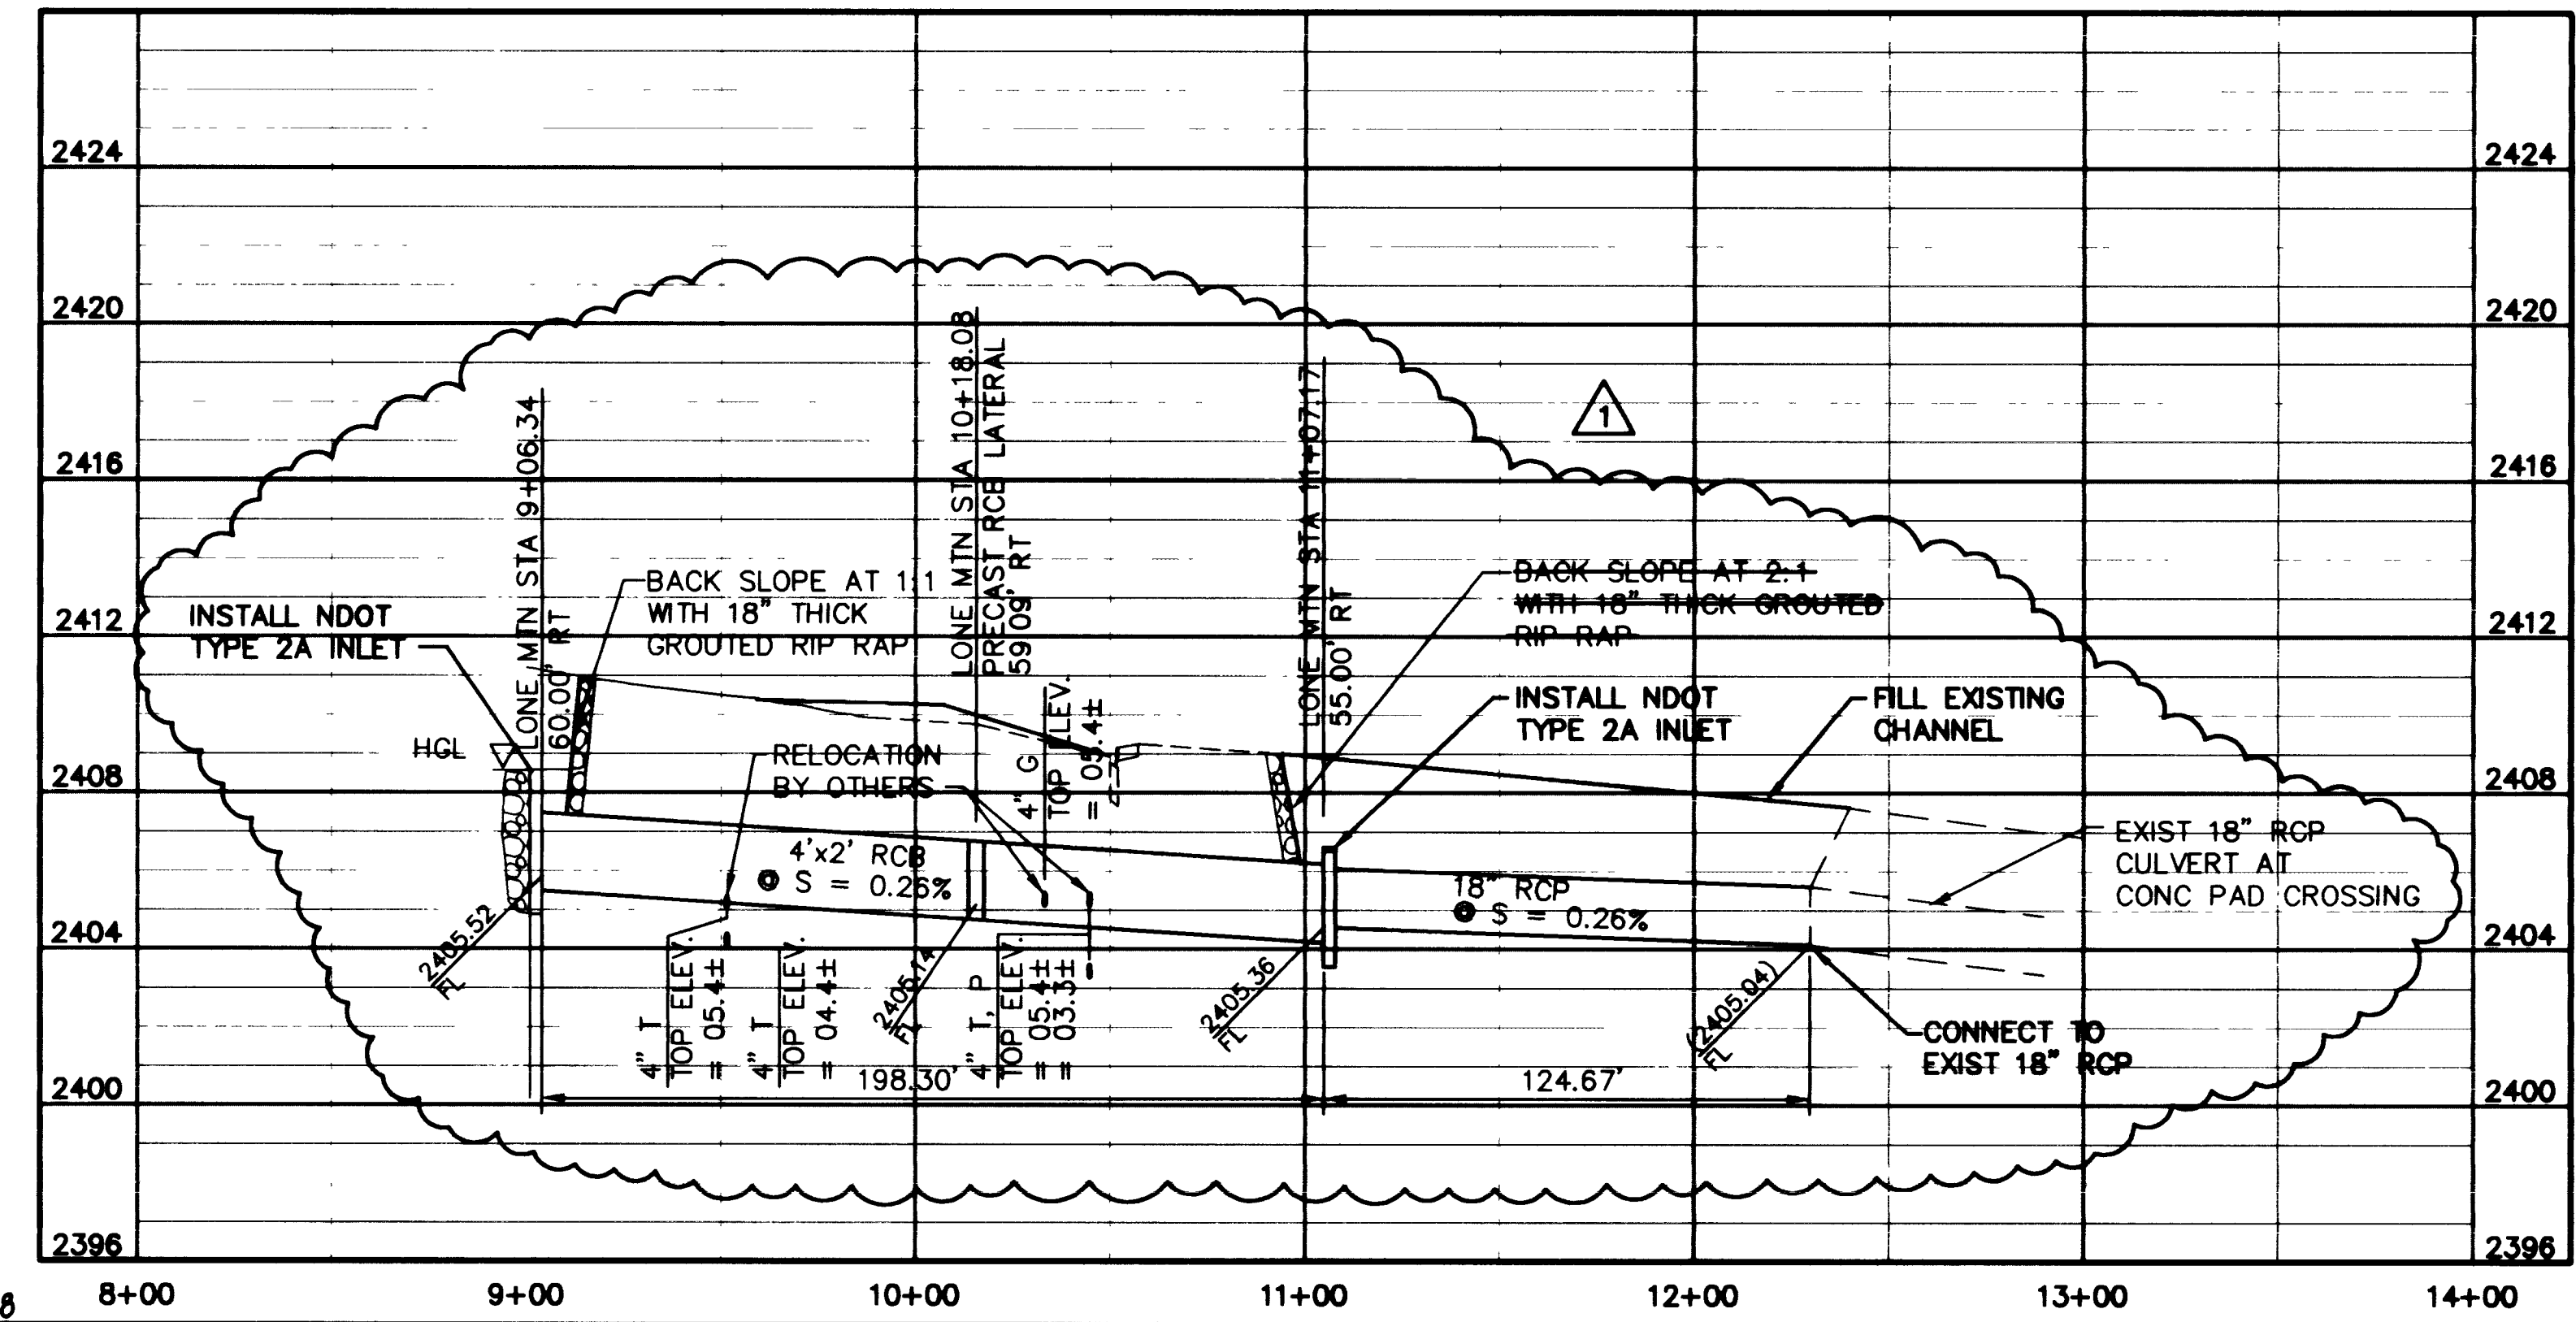

RIP RAP TABLE	
D15	= 6"
D50	= 9"
D85	= 12"

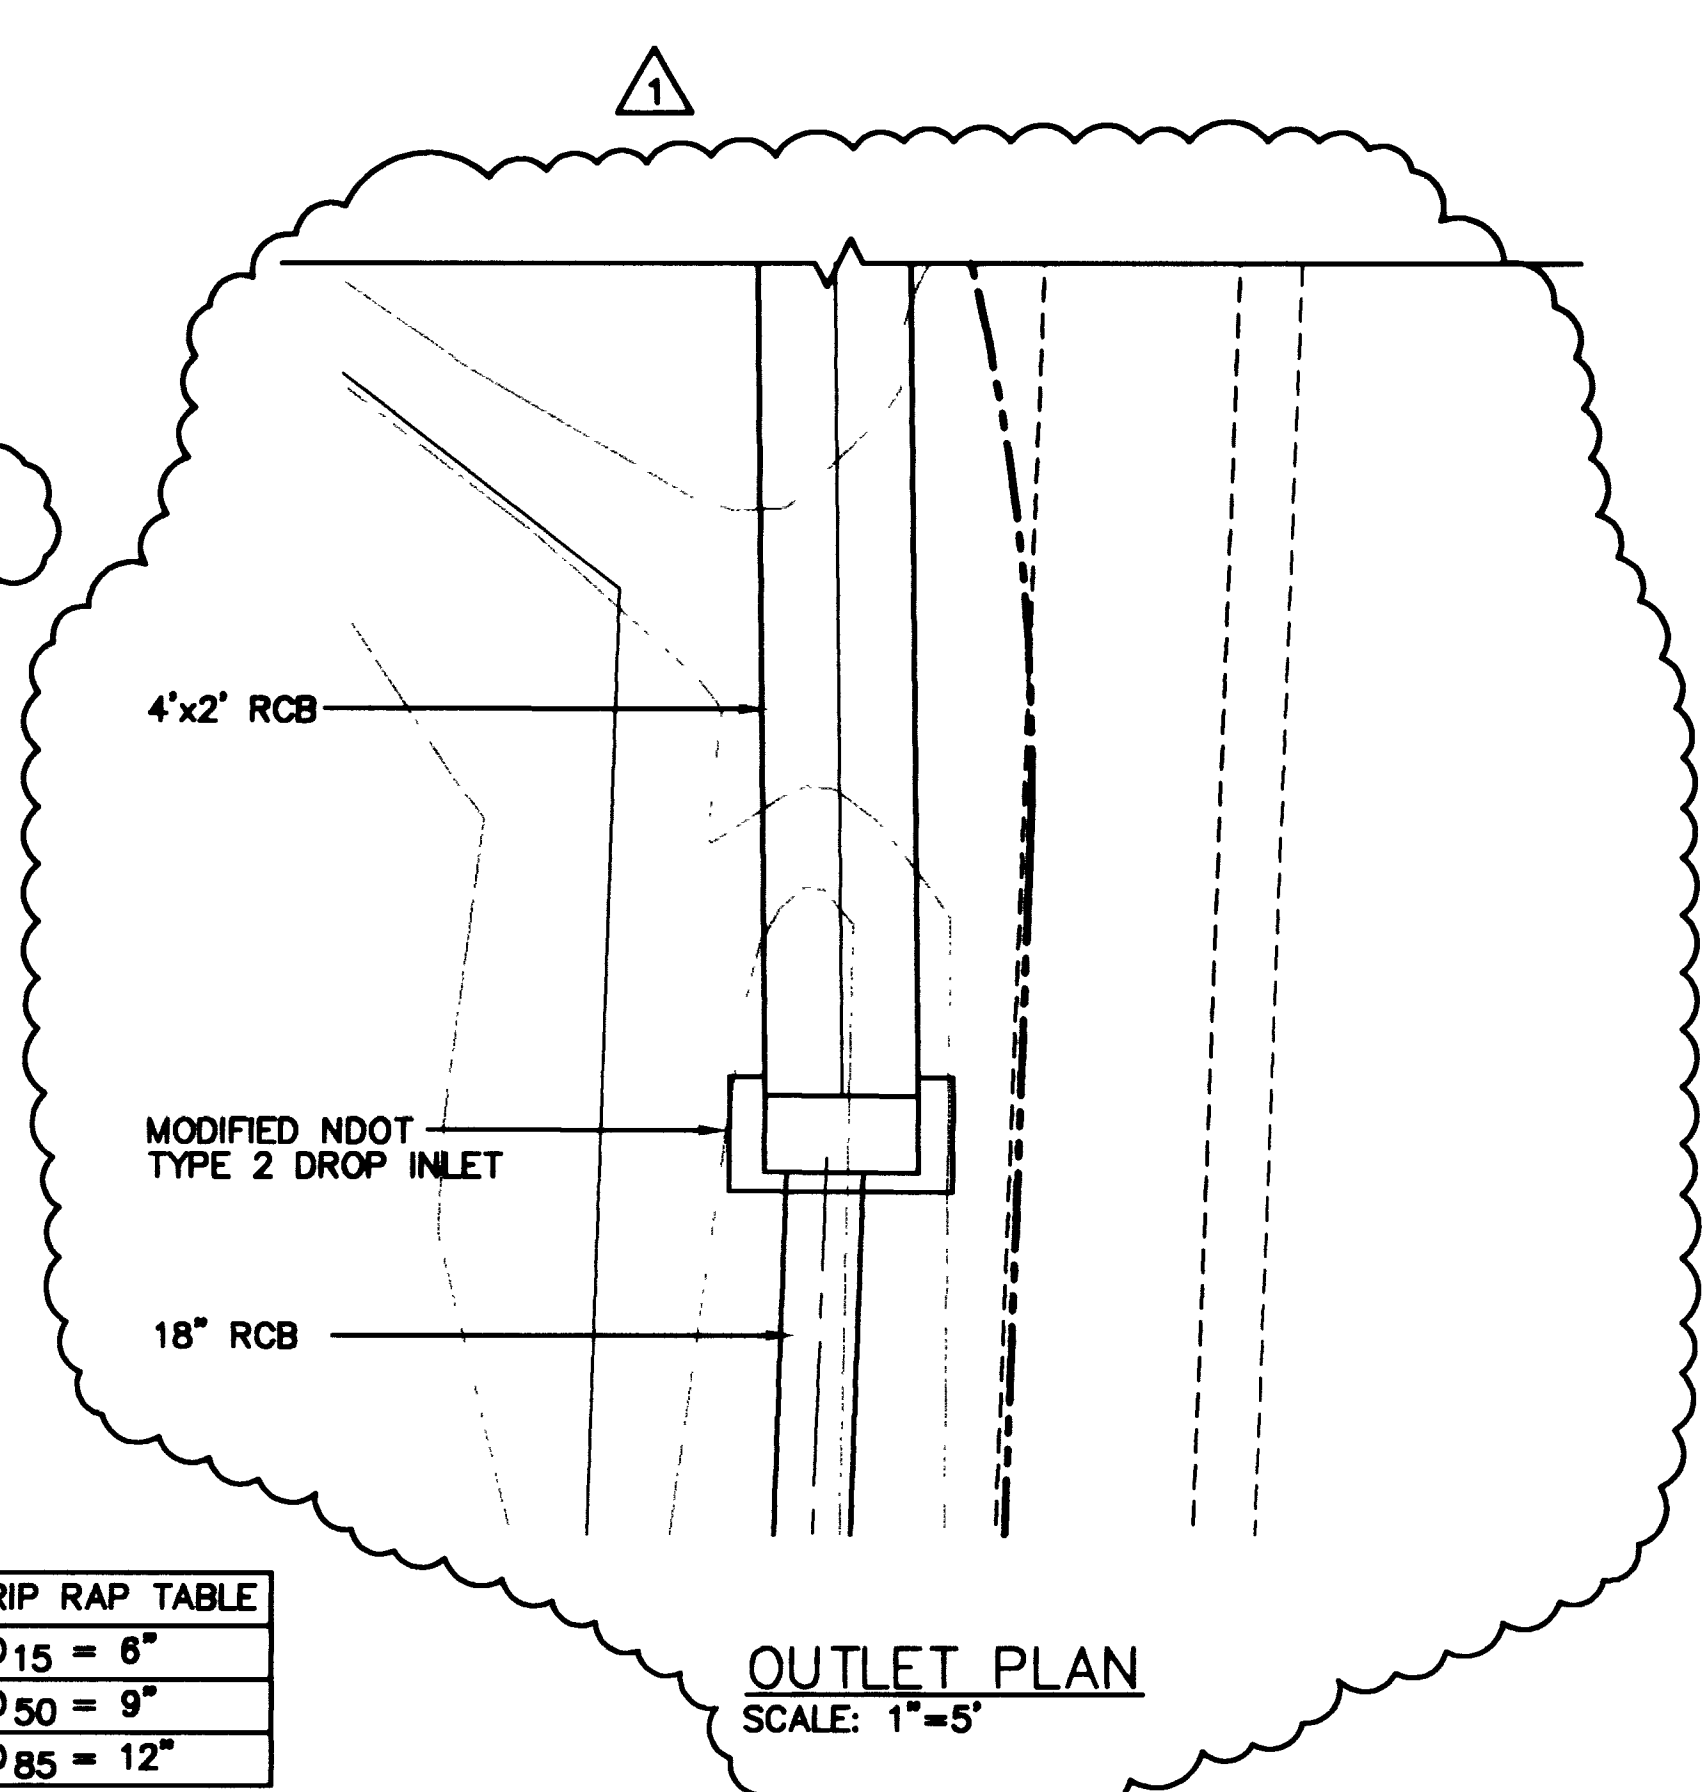

DEPARTMENT OF PUBLIC WORKS CITY OF LAS VEGAS, NEVADA	02/12/01	KJO	REVISED PER AS-BUILTS
	DATE	BY	REVISION
CONSULTING ENGINEERS • PLANNERS • LAND SURVEYORS 2727 SOUTH RAINBOW BOULEVARD LAS VEGAS, NEVADA 89102-5148 PHONE (702) 873-7550 FAX (702) 362-2597			
STORM DRAIN PLAN AND PROFILE STORM DRAIN EXTENSION LONE MOUNTAIN / DURANGO DURANGO DRIVE IMPROVEMENTS CHEYENNE AVENUE TO LONE MOUNTAIN ROAD			
NO. NO. 5249		BY JL/LMW	
DATE 07/17/98		SCALE HORIZ. 1"=40' VERT. 1"=4'	
DRAWING SD13		SHEET 64 OF 106 SHEETS	