
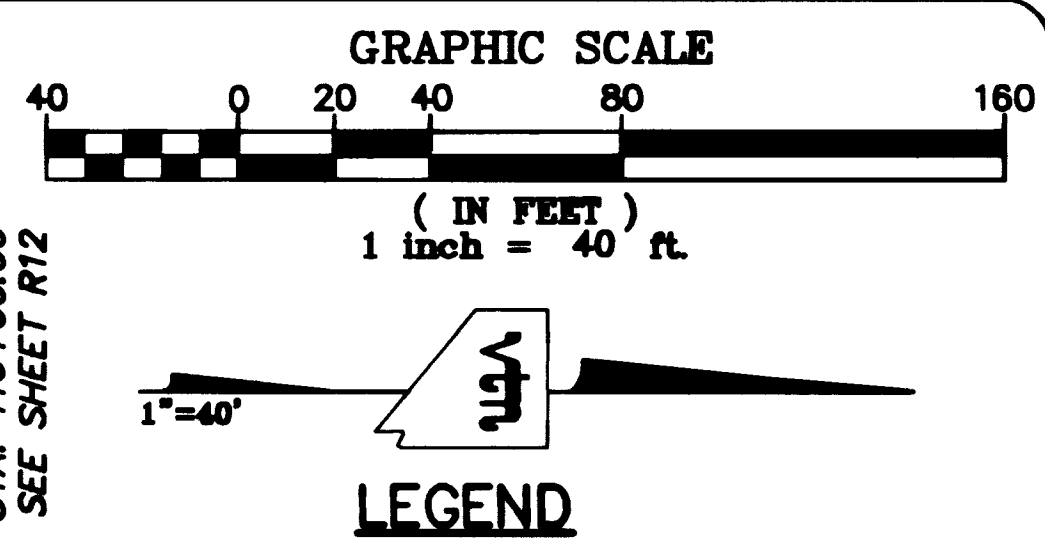


1:\CAD\WORK\15249\15249-DWG
VIEWS: MS = "K", PS = "PLT"
15249

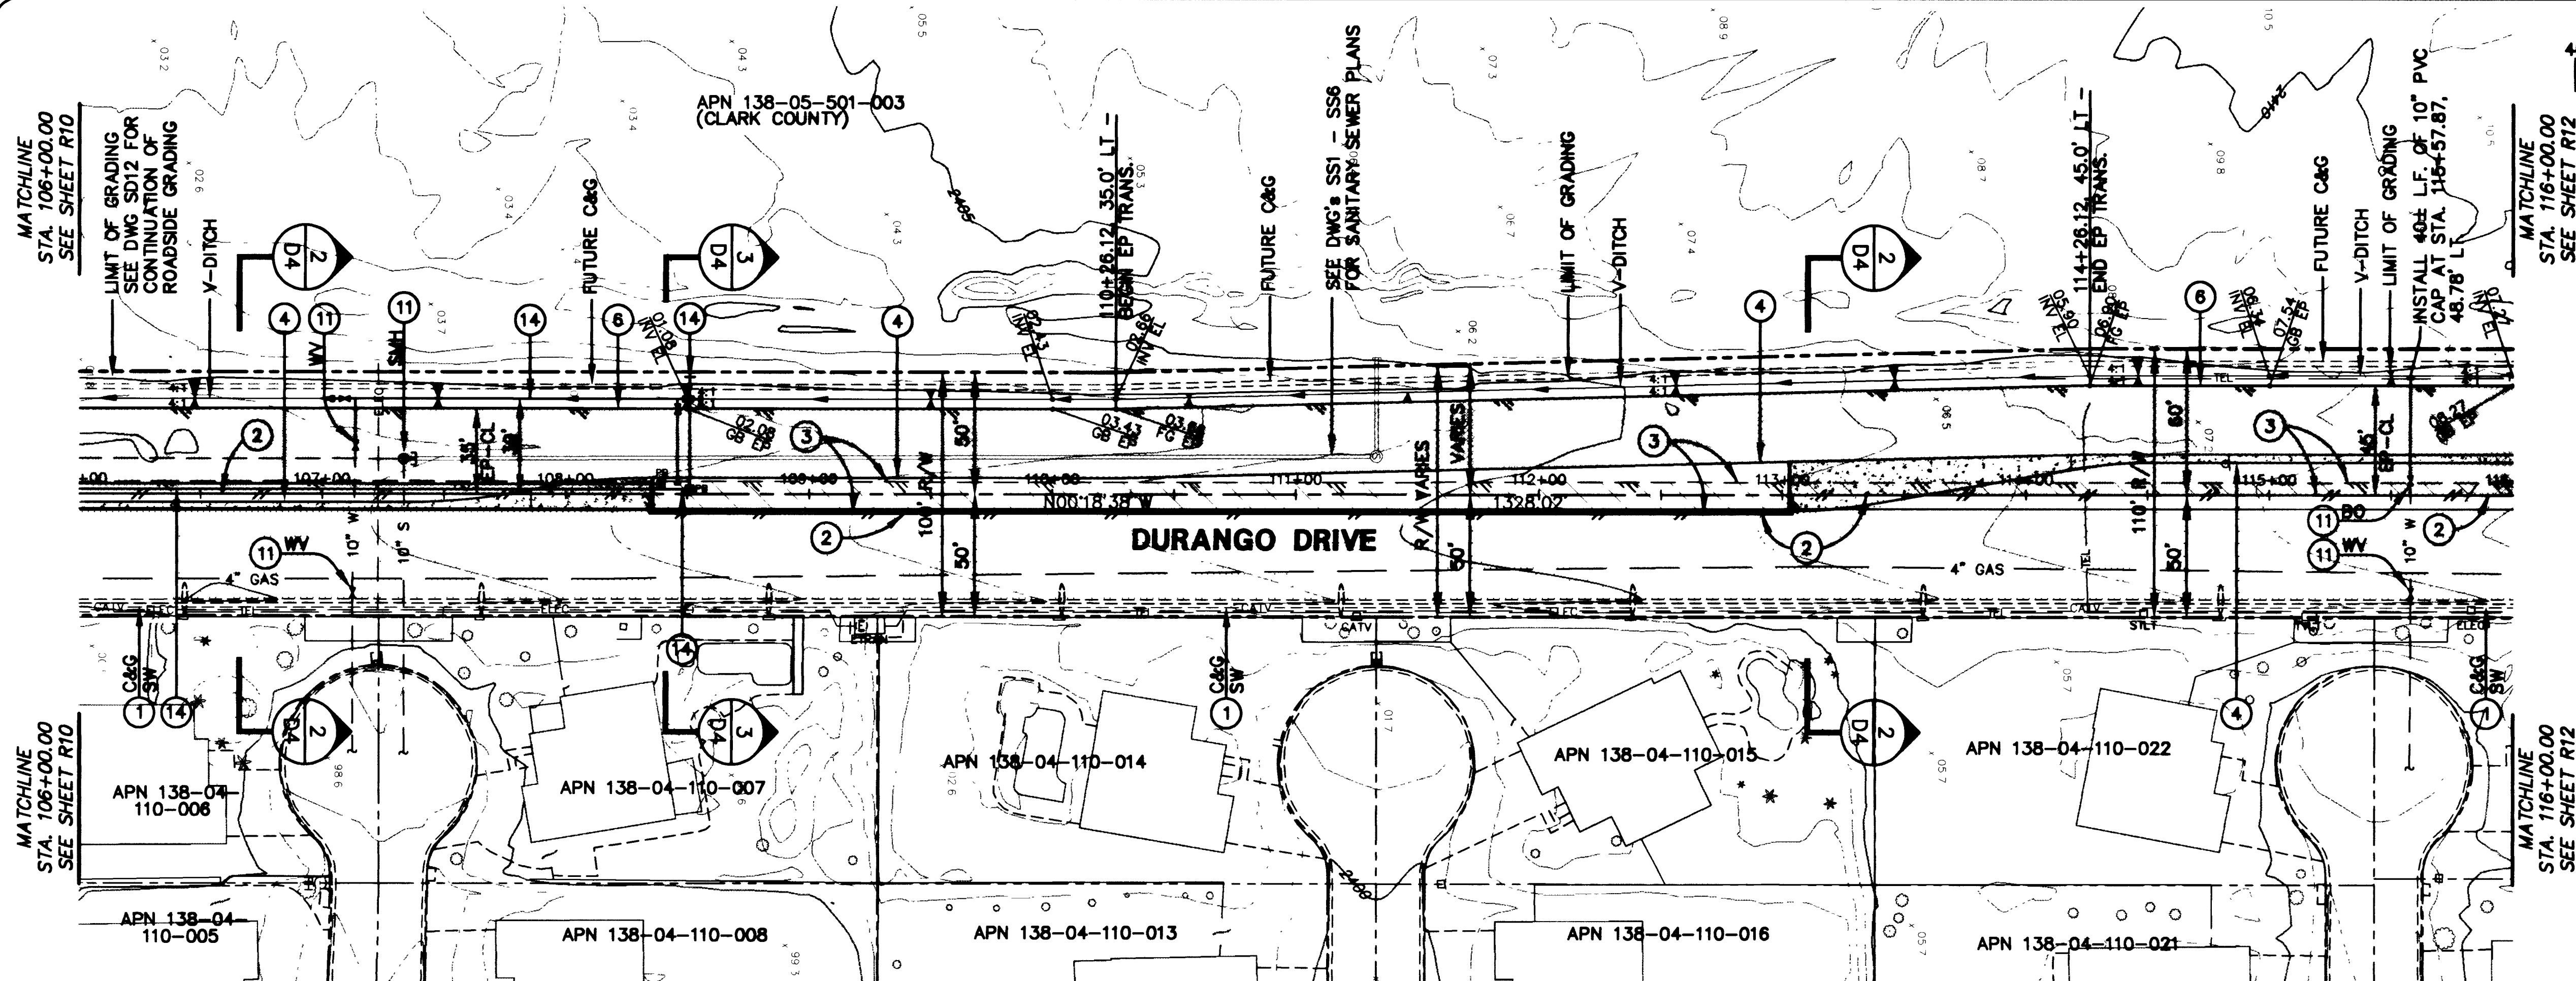

APPROVED

LAS VEGAS VALLEY WATER DISTRICT DATE

CONSTRUCTION NOTES

- 1 PROTECT IN PLACE
- 2 SAWCUT & MATCH
- 3 REMOVE EXISTING A.C., AGGREGATE BASE AND/OR CONCRETE
- 4 CONSTRUCT MEDIAN ISLAND SEE MEDIAN ISLAND GEOMETRICS AND IRRIGATION PLAN DWG's R17 - R21
- 5 CONSTRUCT PAVEMENT CROWN TRANSITION SEE MEDIAN ISLAND GEOMETRICS AND IRRIGATION PLAN DWG's R17 - R21
- 6 EDGE OF NEW A.C. PAVEMENT
- 7 REMOVE A.C. WALKWAY
- 8 CONSTRUCT "L" TYPE CURB AND GUTTER PER USD NO. 218
- 9 CONSTRUCT CURB AND GUTTER AND SIDEWALK RAMP CASE II PER USD NO. 235
- 10 18" CMP
- 11 ADJUST TO FINISH GRADE
- 12 CONSTRUCT 6" TYPE II AGGREGATE BASE AT 95% COMPACTION
- 13 RELOCATE
- 14 CONSTRUCT MEDIAN ISLAND IRRIGATION FACILITIES FOR FUTURE CONNECTION SEE MEDIAN ISLAND GEOMETRICS AND IRRIGATION PLAN DWG's R17 - R21
- 15 REESTABLISH SURVEY MONUMENT TO FINISH GRADE PER STANDARD DWGS. AND STANDARD SPECS.
- 16 ESTABLISH SURVEY MONUMENT TO FINISH GRADE PER STANDARD DWGS. AND STANDARD SPECS.
- 17 CONSTRUCT CURB AND GUTTER AND MODIFIED SIDEWALK RAMP CASE II PER DETAIL 6 ON SHT D24
- 18 CONSTRUCT GUARDRAIL SEE DWG SD13

FOR STRIPING, STREET LIGHTS AND TRAFFIC SIGNAL PLANS SEE DWG's T1 - T15

CONSULTING ENGINEERS • PLANNERS • LAND SURVEYORS
2727 SOUTH RAINBOW BOULEVARD
LAS VEGAS, NEVADA 89102-5148 PHONE (702) 873-7550 FAX (702) 362-2597

DEPARTMENT OF PUBLIC WORKS
CITY OF LAS VEGAS, NEVADA

vtm nevada

TITLE ROADWAY PLAN AND PROFILE
STA. 106+00.00 TO STA. 116+00.00
DURANGO DRIVE

PROJECT DURANGO DRIVE IMPROVEMENTS
CHEYENNE AVENUE TO LONE MOUNTAIN ROAD

SEAL

NO. NO. **5249**

BY **JL/TMM**
DATE **07/17/98**

SCALE: HORIZ. 1"=40'
VERT. 1"=40'

DRAWING **R11** SHEET **41** OF **106** SHEETS