
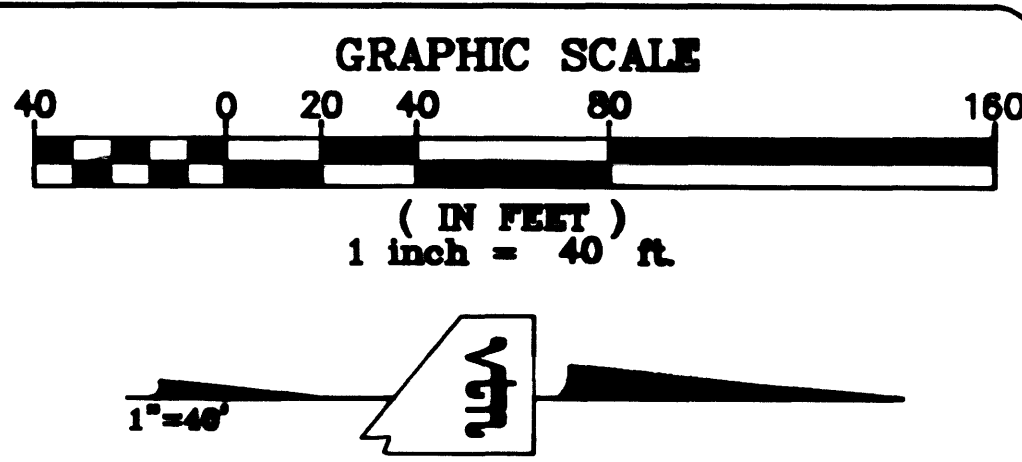
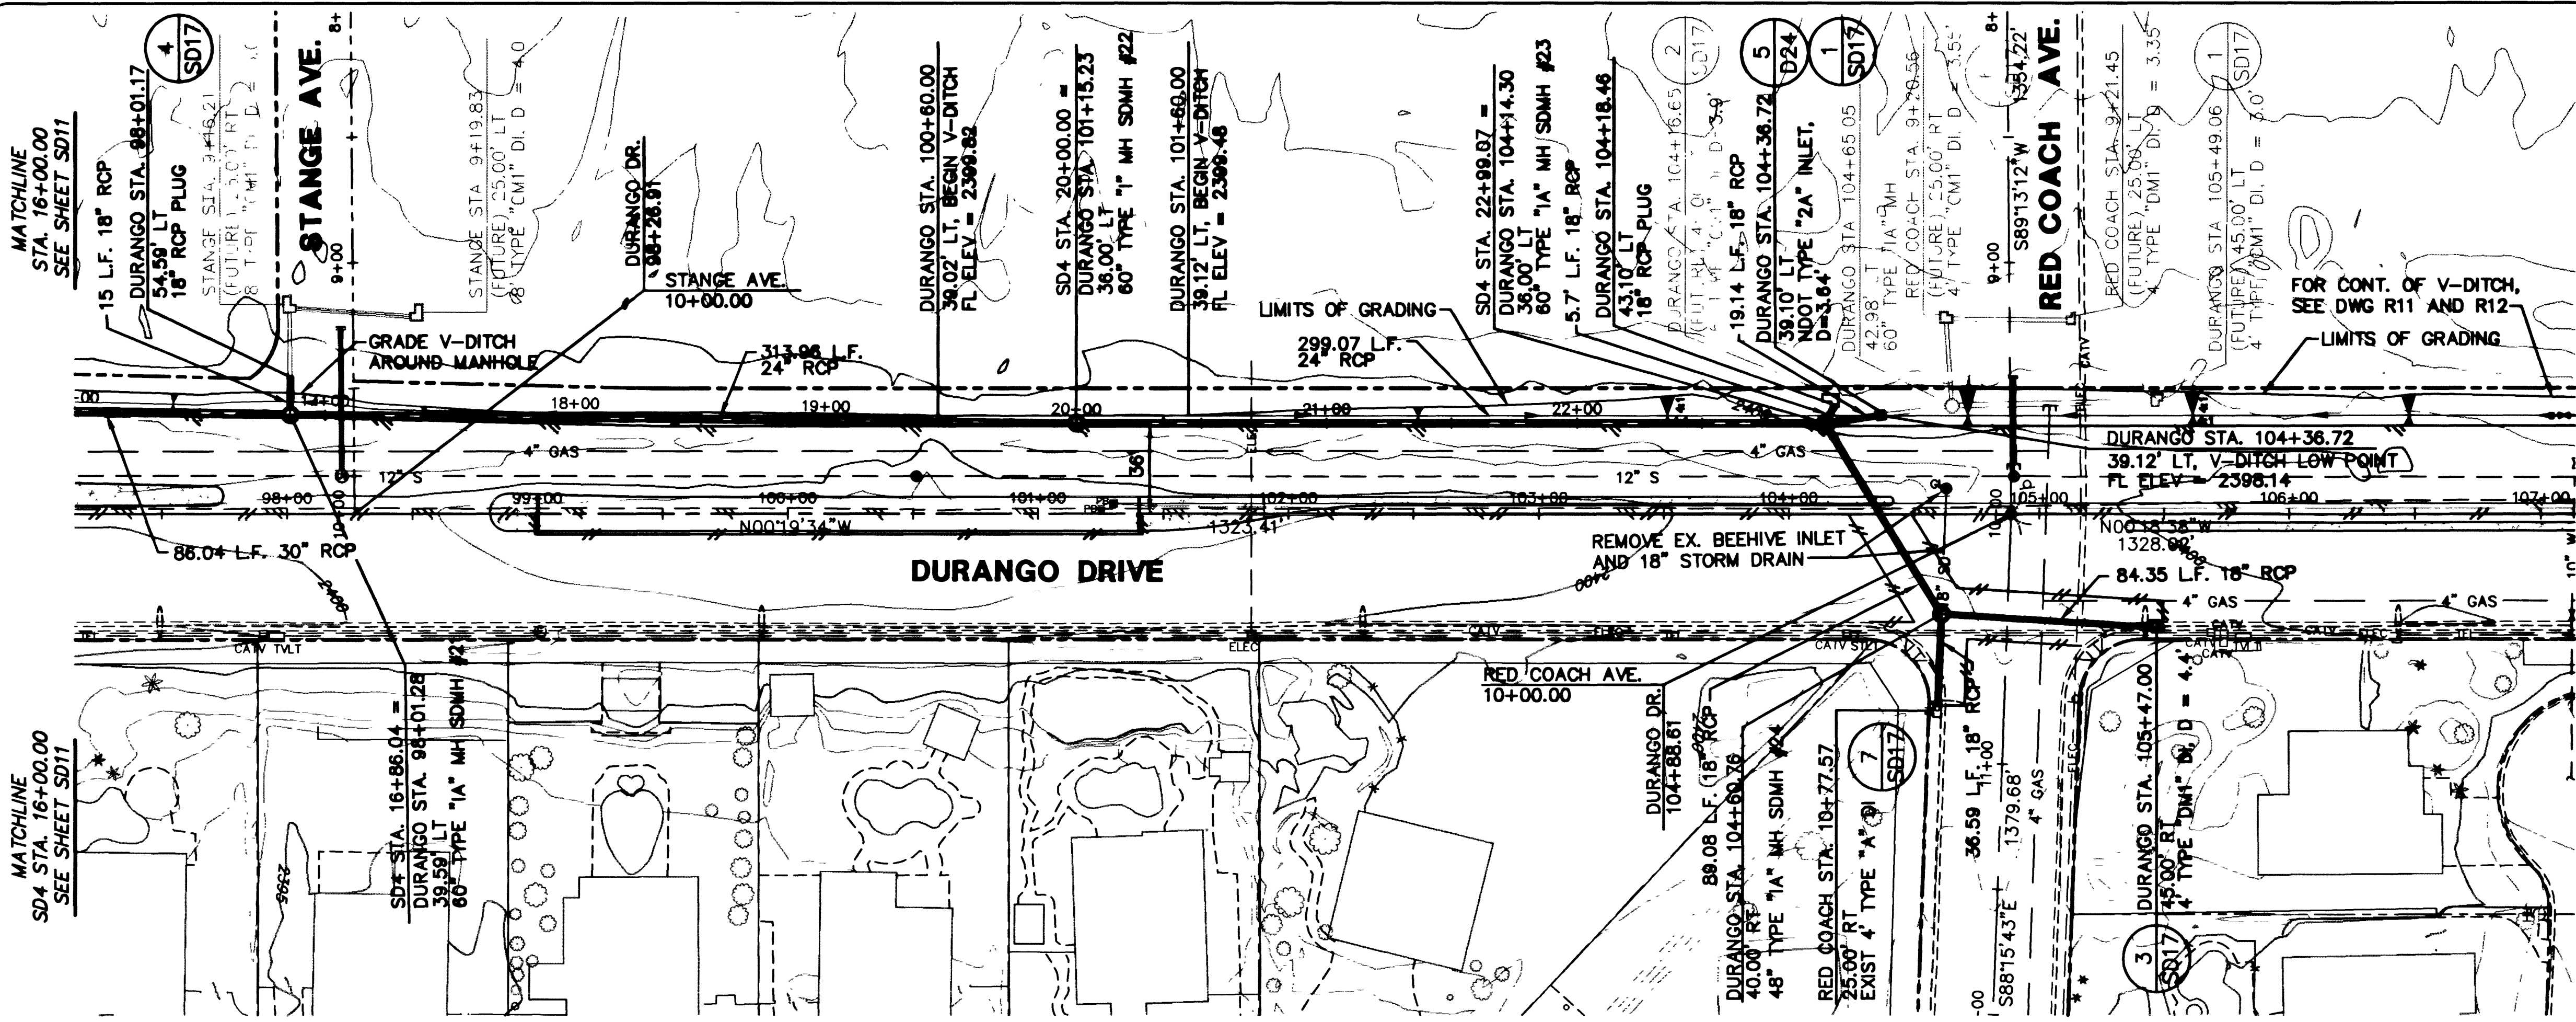


VENIS: MS = "J", PS = "PLT"
I:\CAD\DWG\5249\5249-SD.DWG

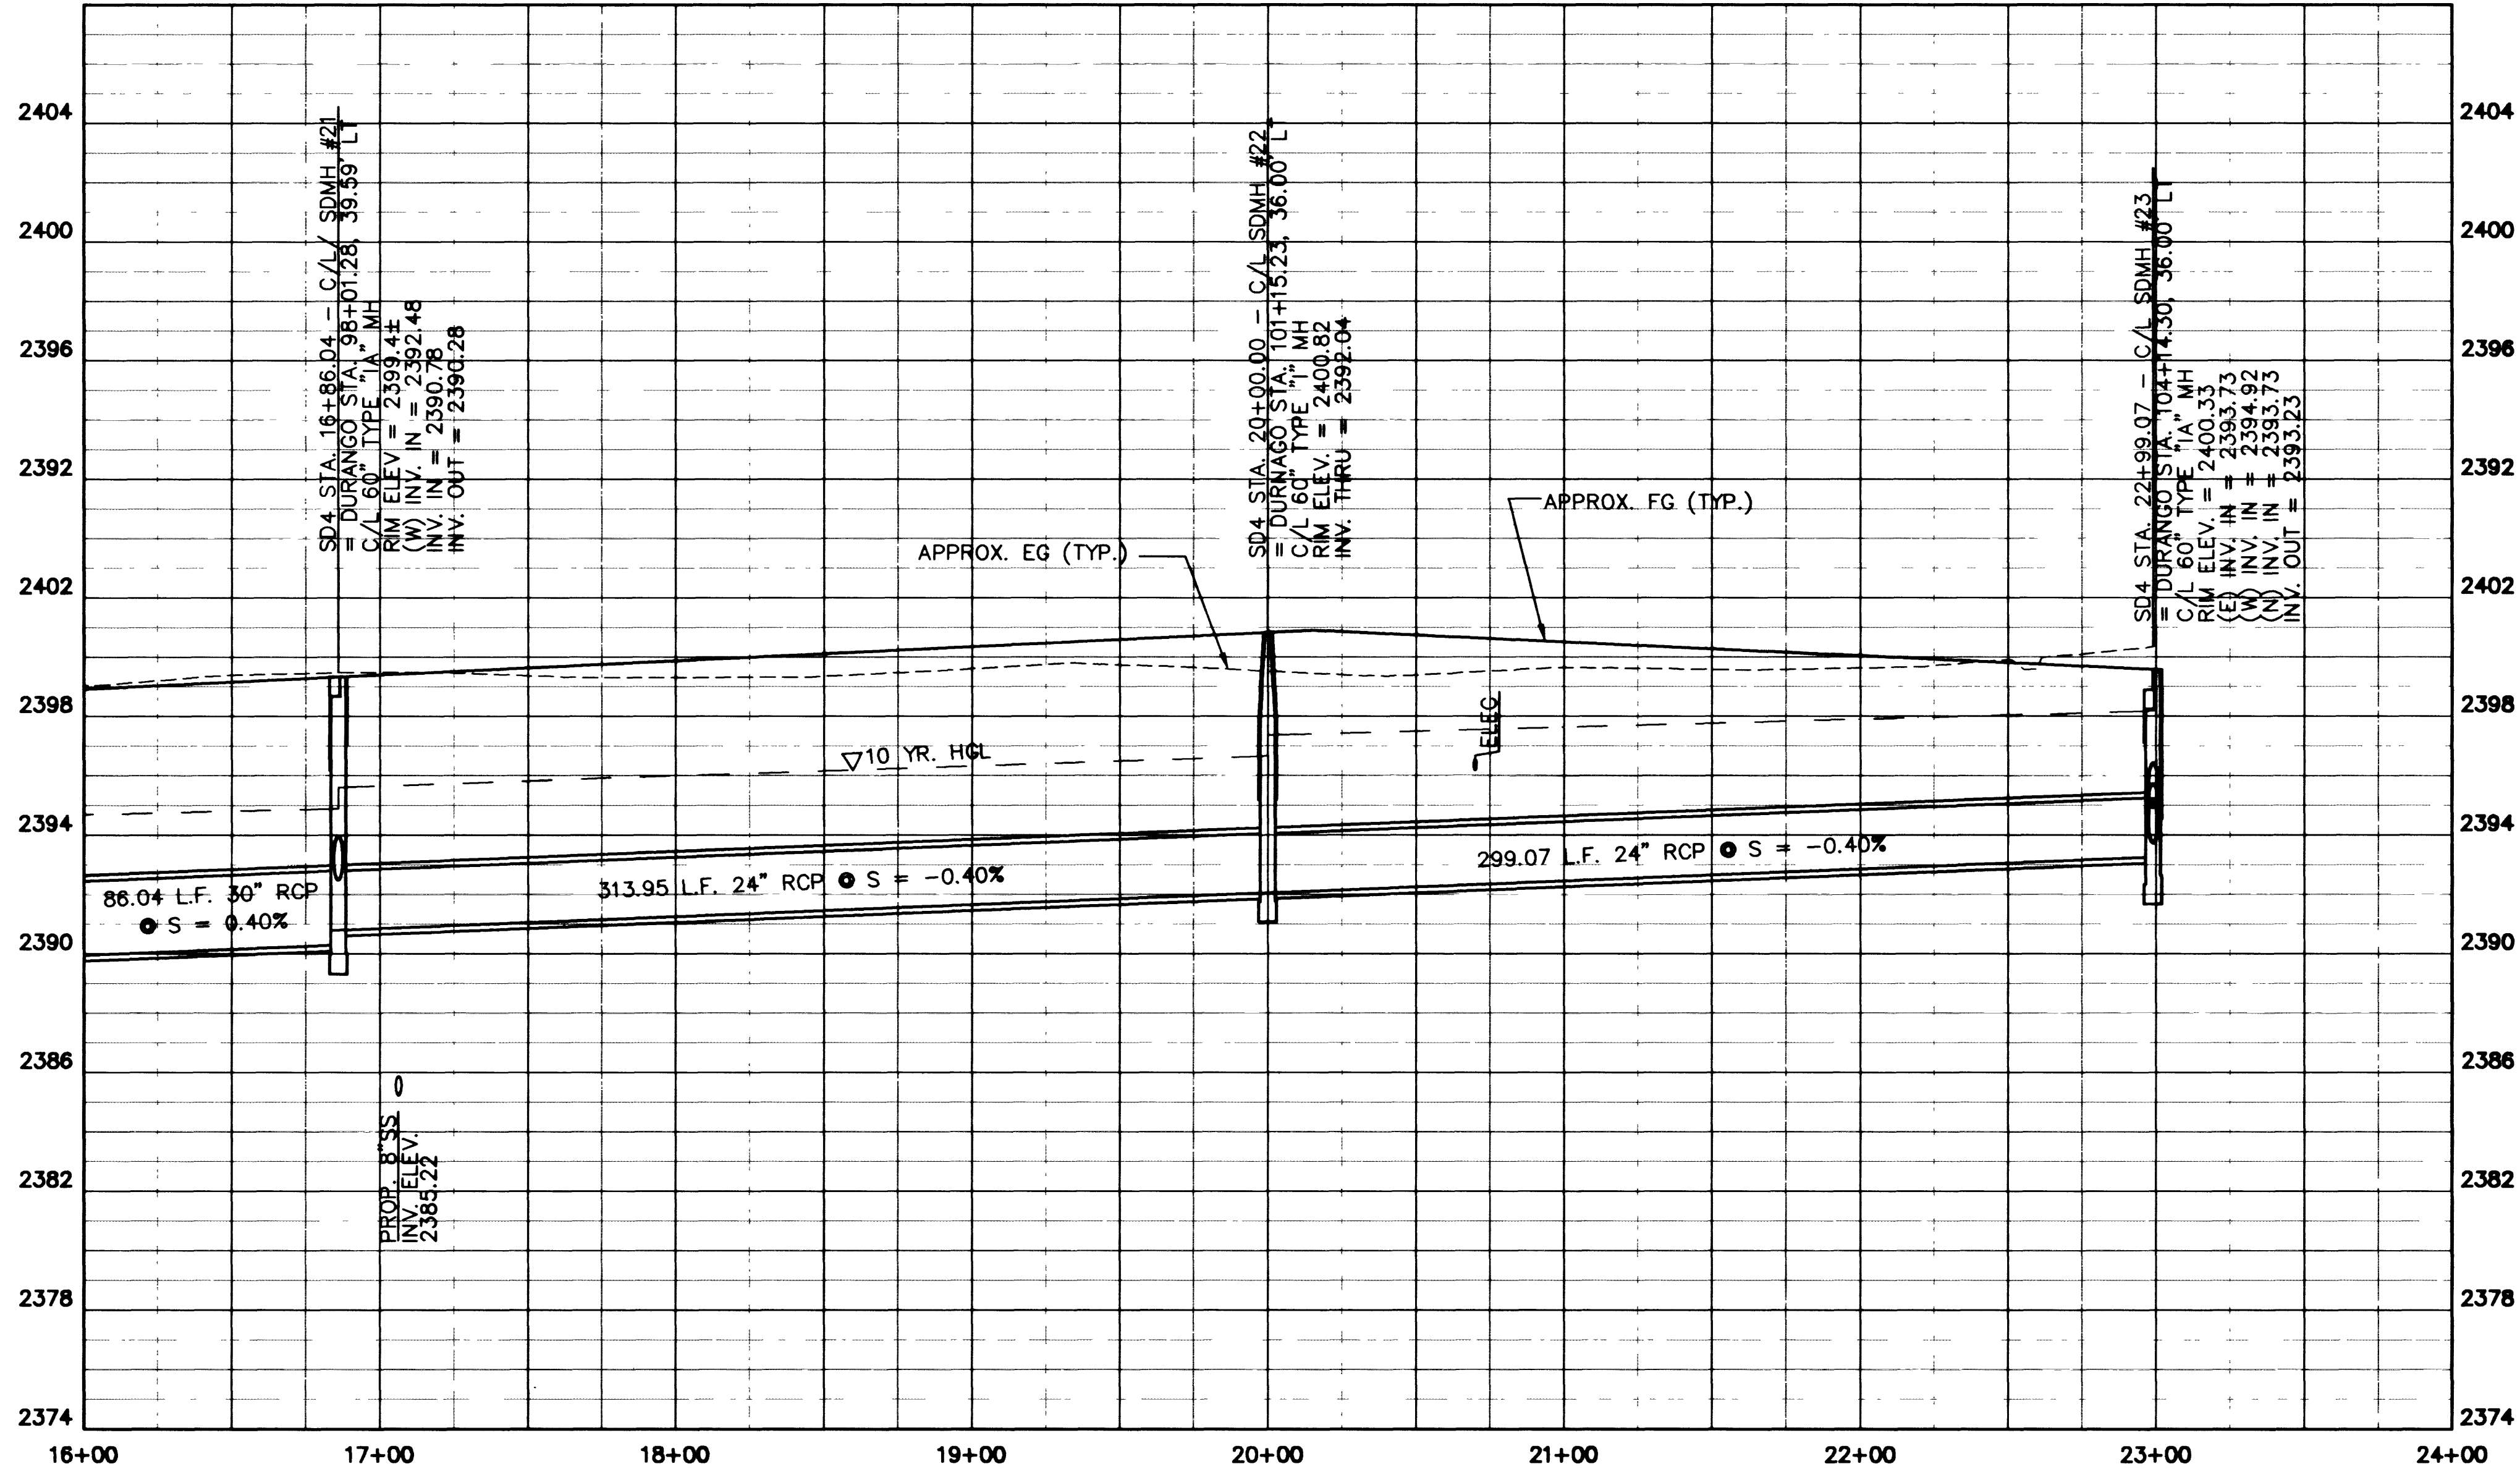

NOTES:
1. ALL RCP IS TO BE CLASS III.

STORM DRAIN PLAN AND PROFILE
SD4 STA. 16+00 TO STA. 22+99.07
DURANGO DRIVE
CHEYENNE AVENUE TO LONE MOUNTAIN ROAD

SD12	
BY	JL/LMW/DJB
DATE	07/17/98
SCALE	HORIZ. 1"=40' VERT. 1"=4'
DRAWING	SHEET 63 OF 106

DEPARTMENT OF PUBLIC WORKS CITY OF LAS VEGAS, NEVADA	
REVISION	DATE
CONSULTING ENGINEERS • PLANNERS • LAND SURVEYORS 2727 SOUTH RAINBOW BOULEVARD LAS VEGAS, NEVADA 89102-5148 PHONE (702) 873-7550 FAX (702) 382-2597	

