
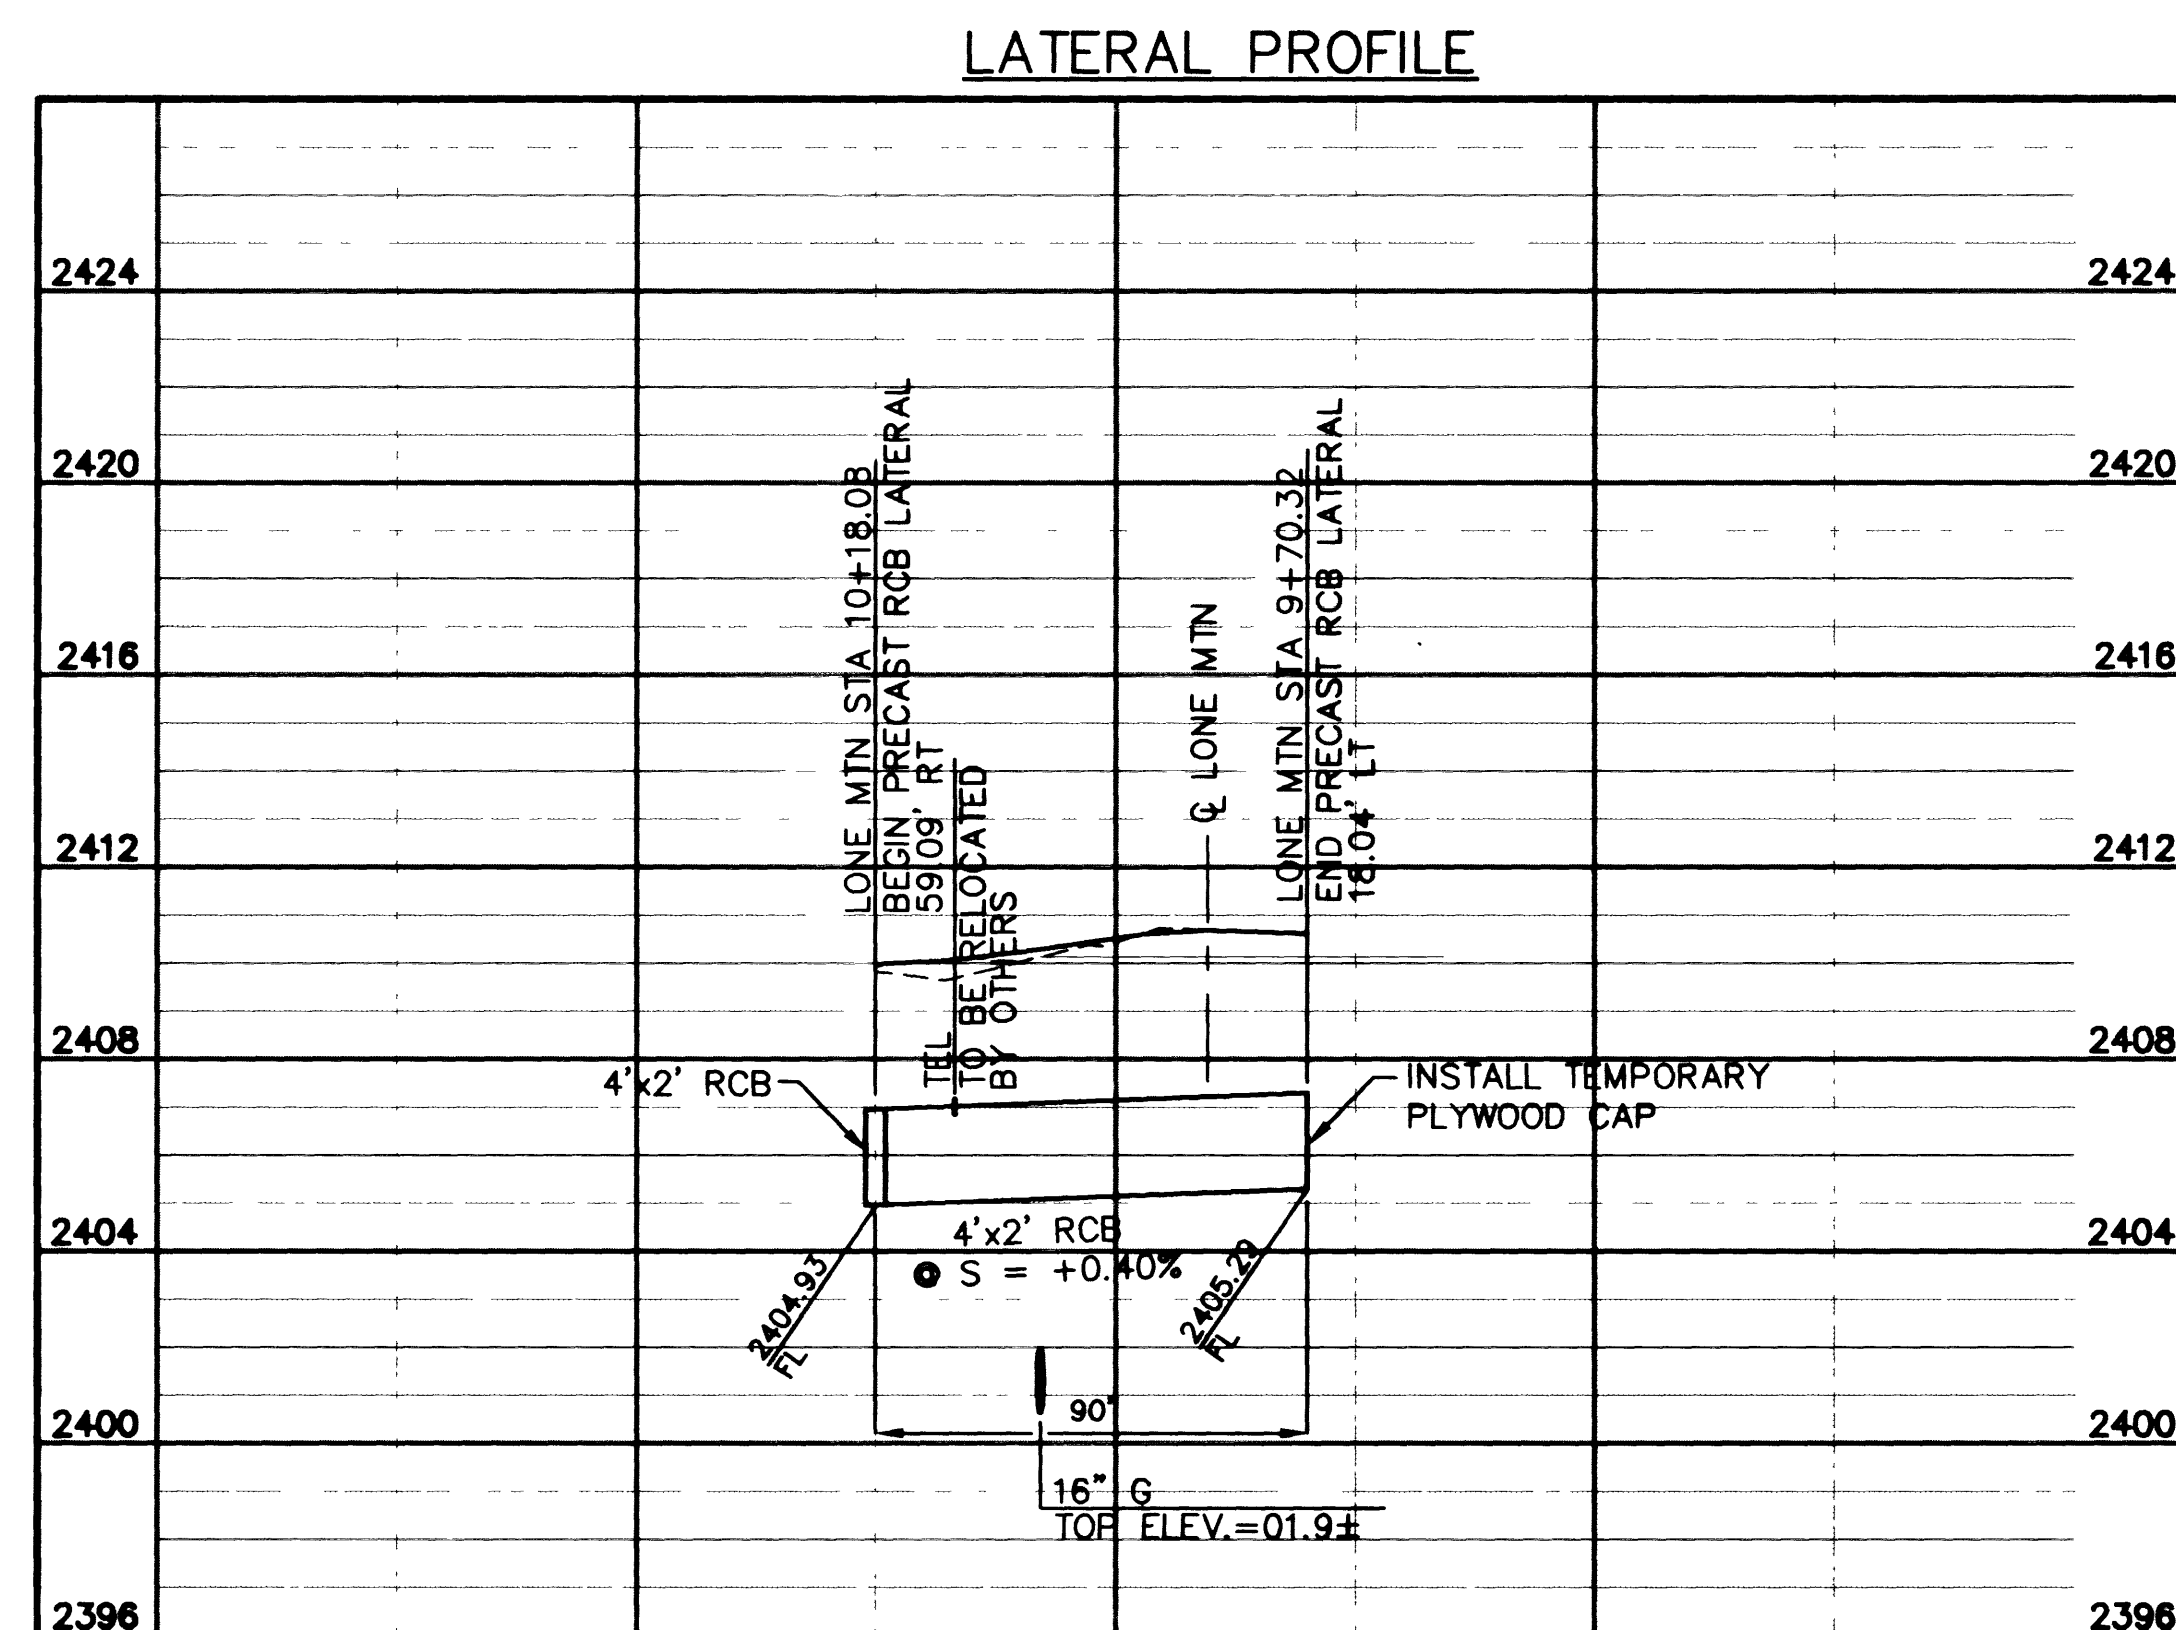
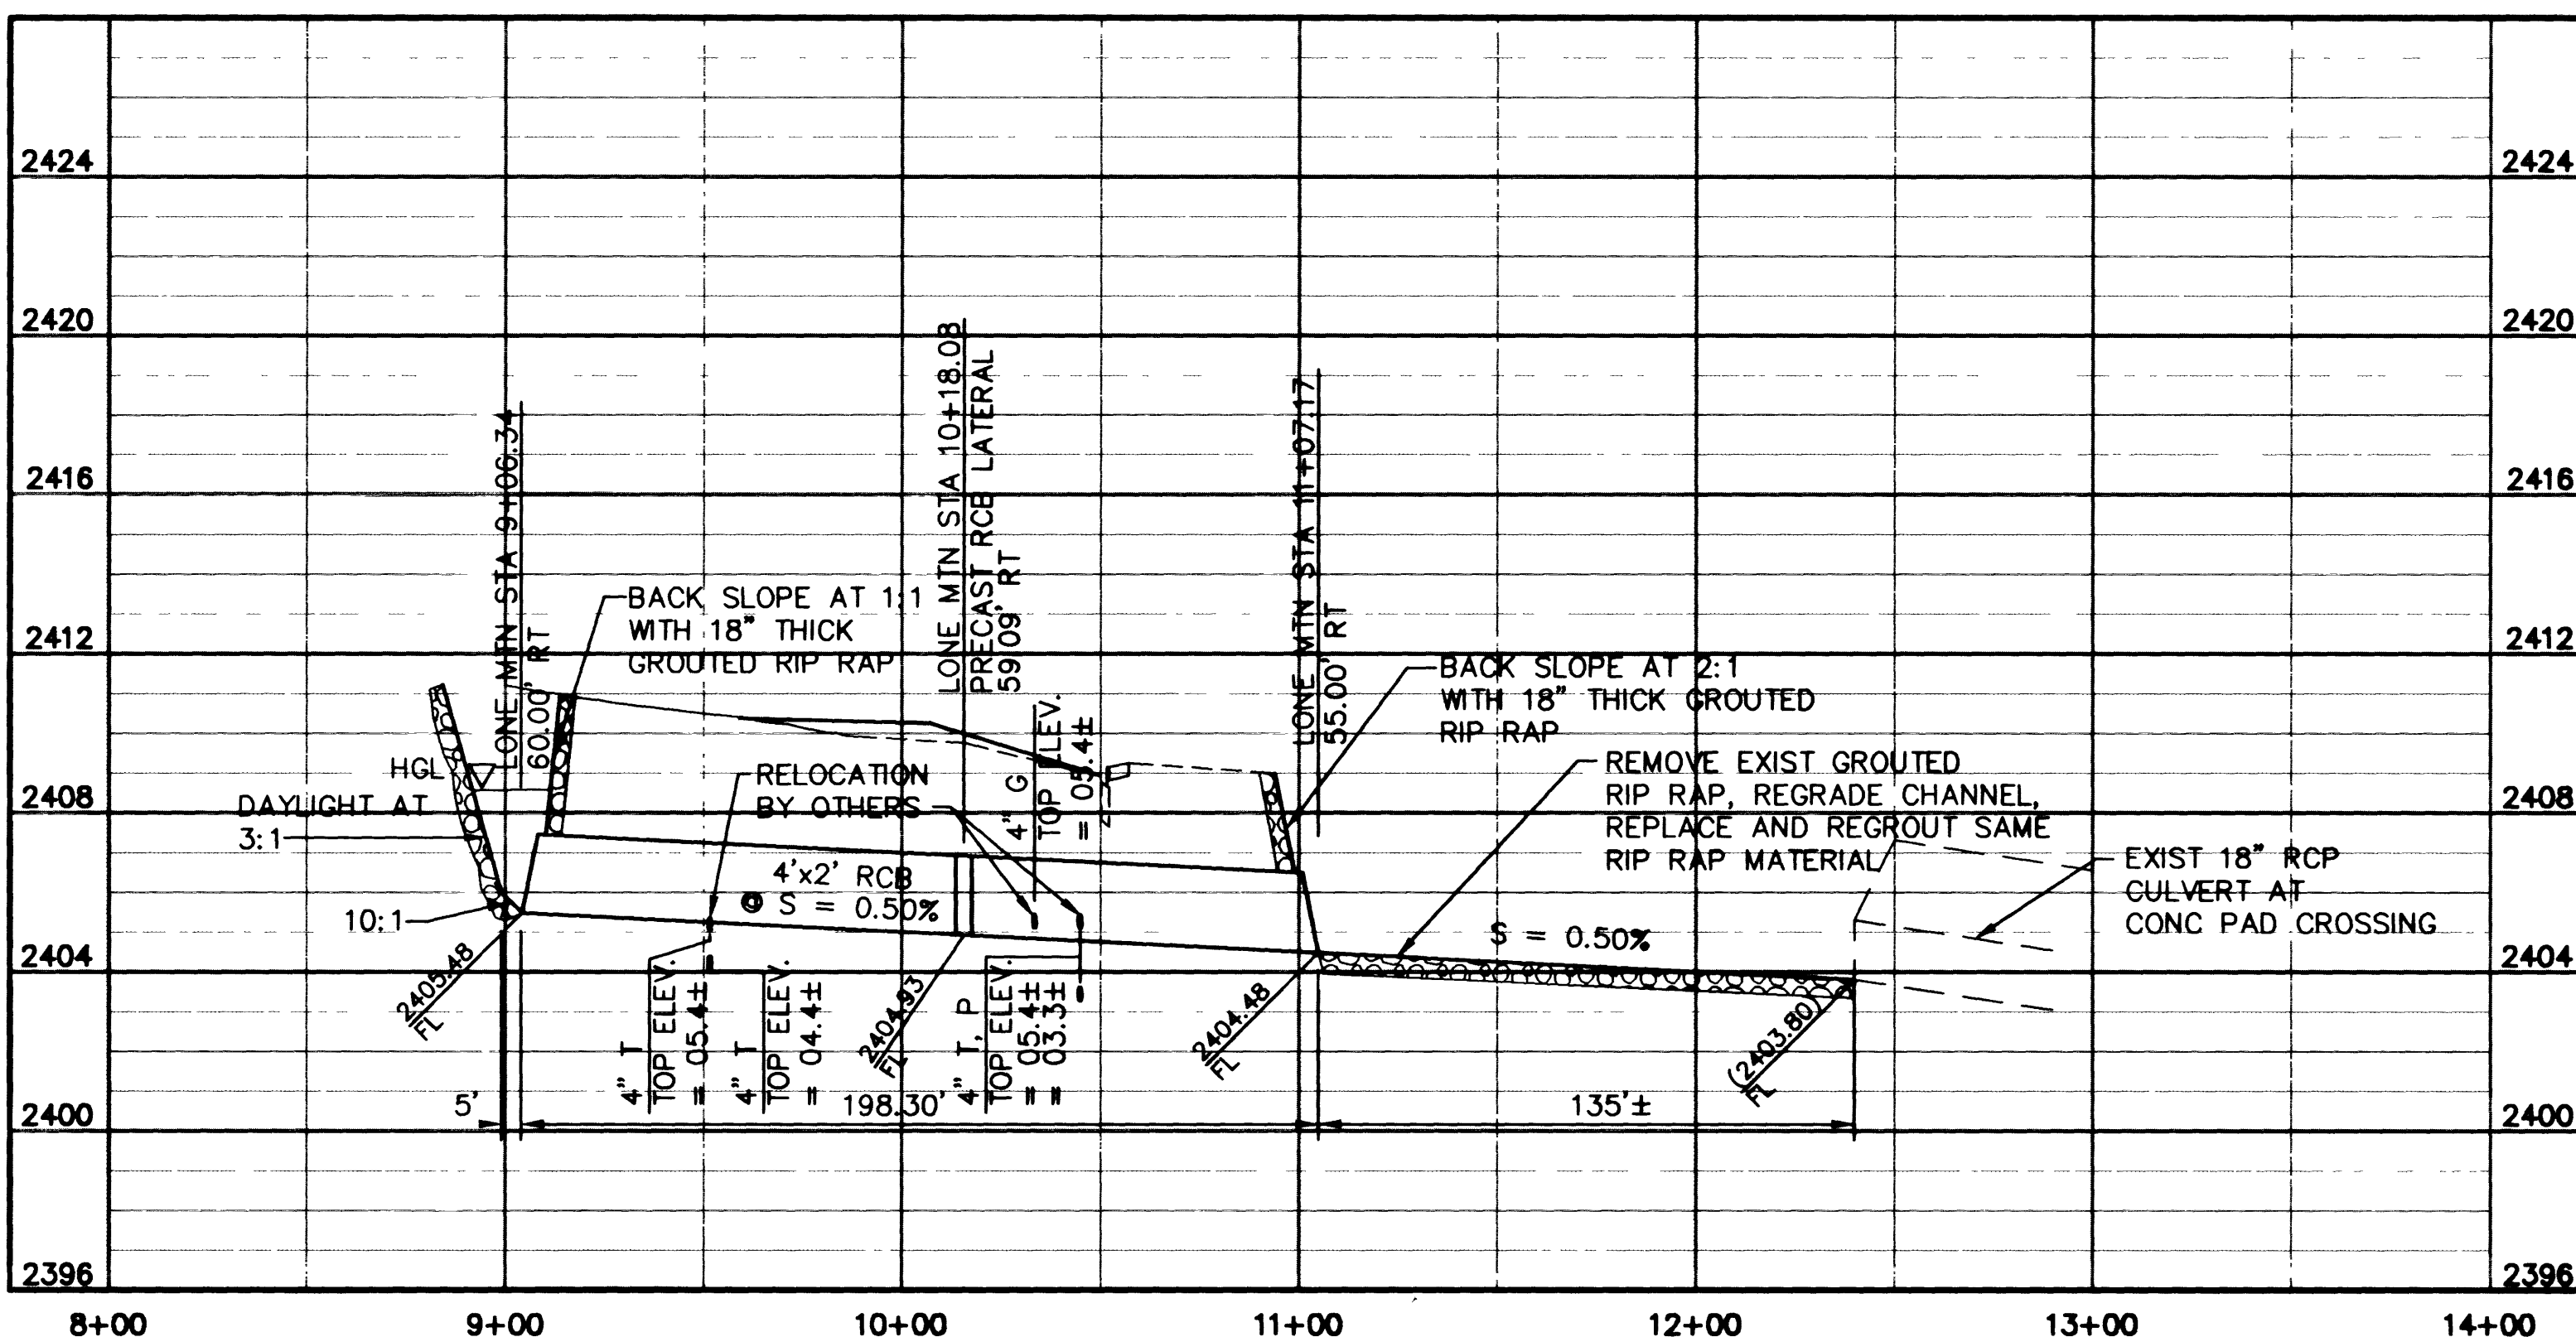
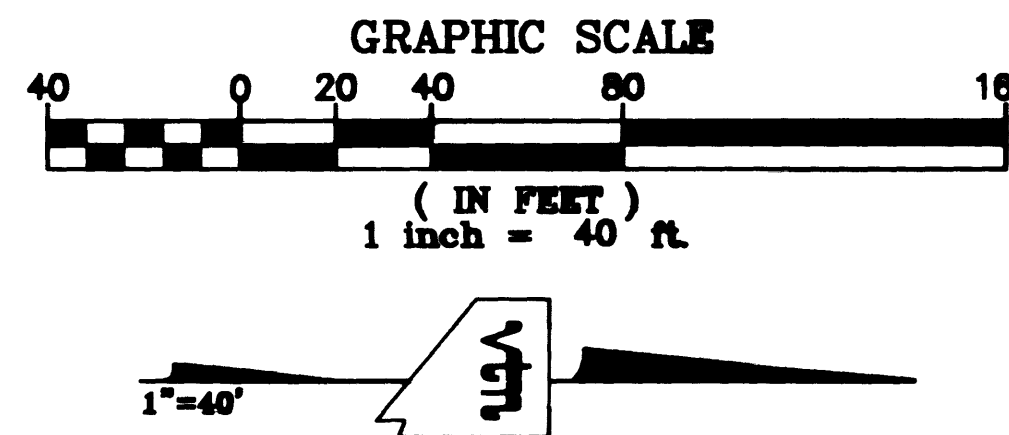
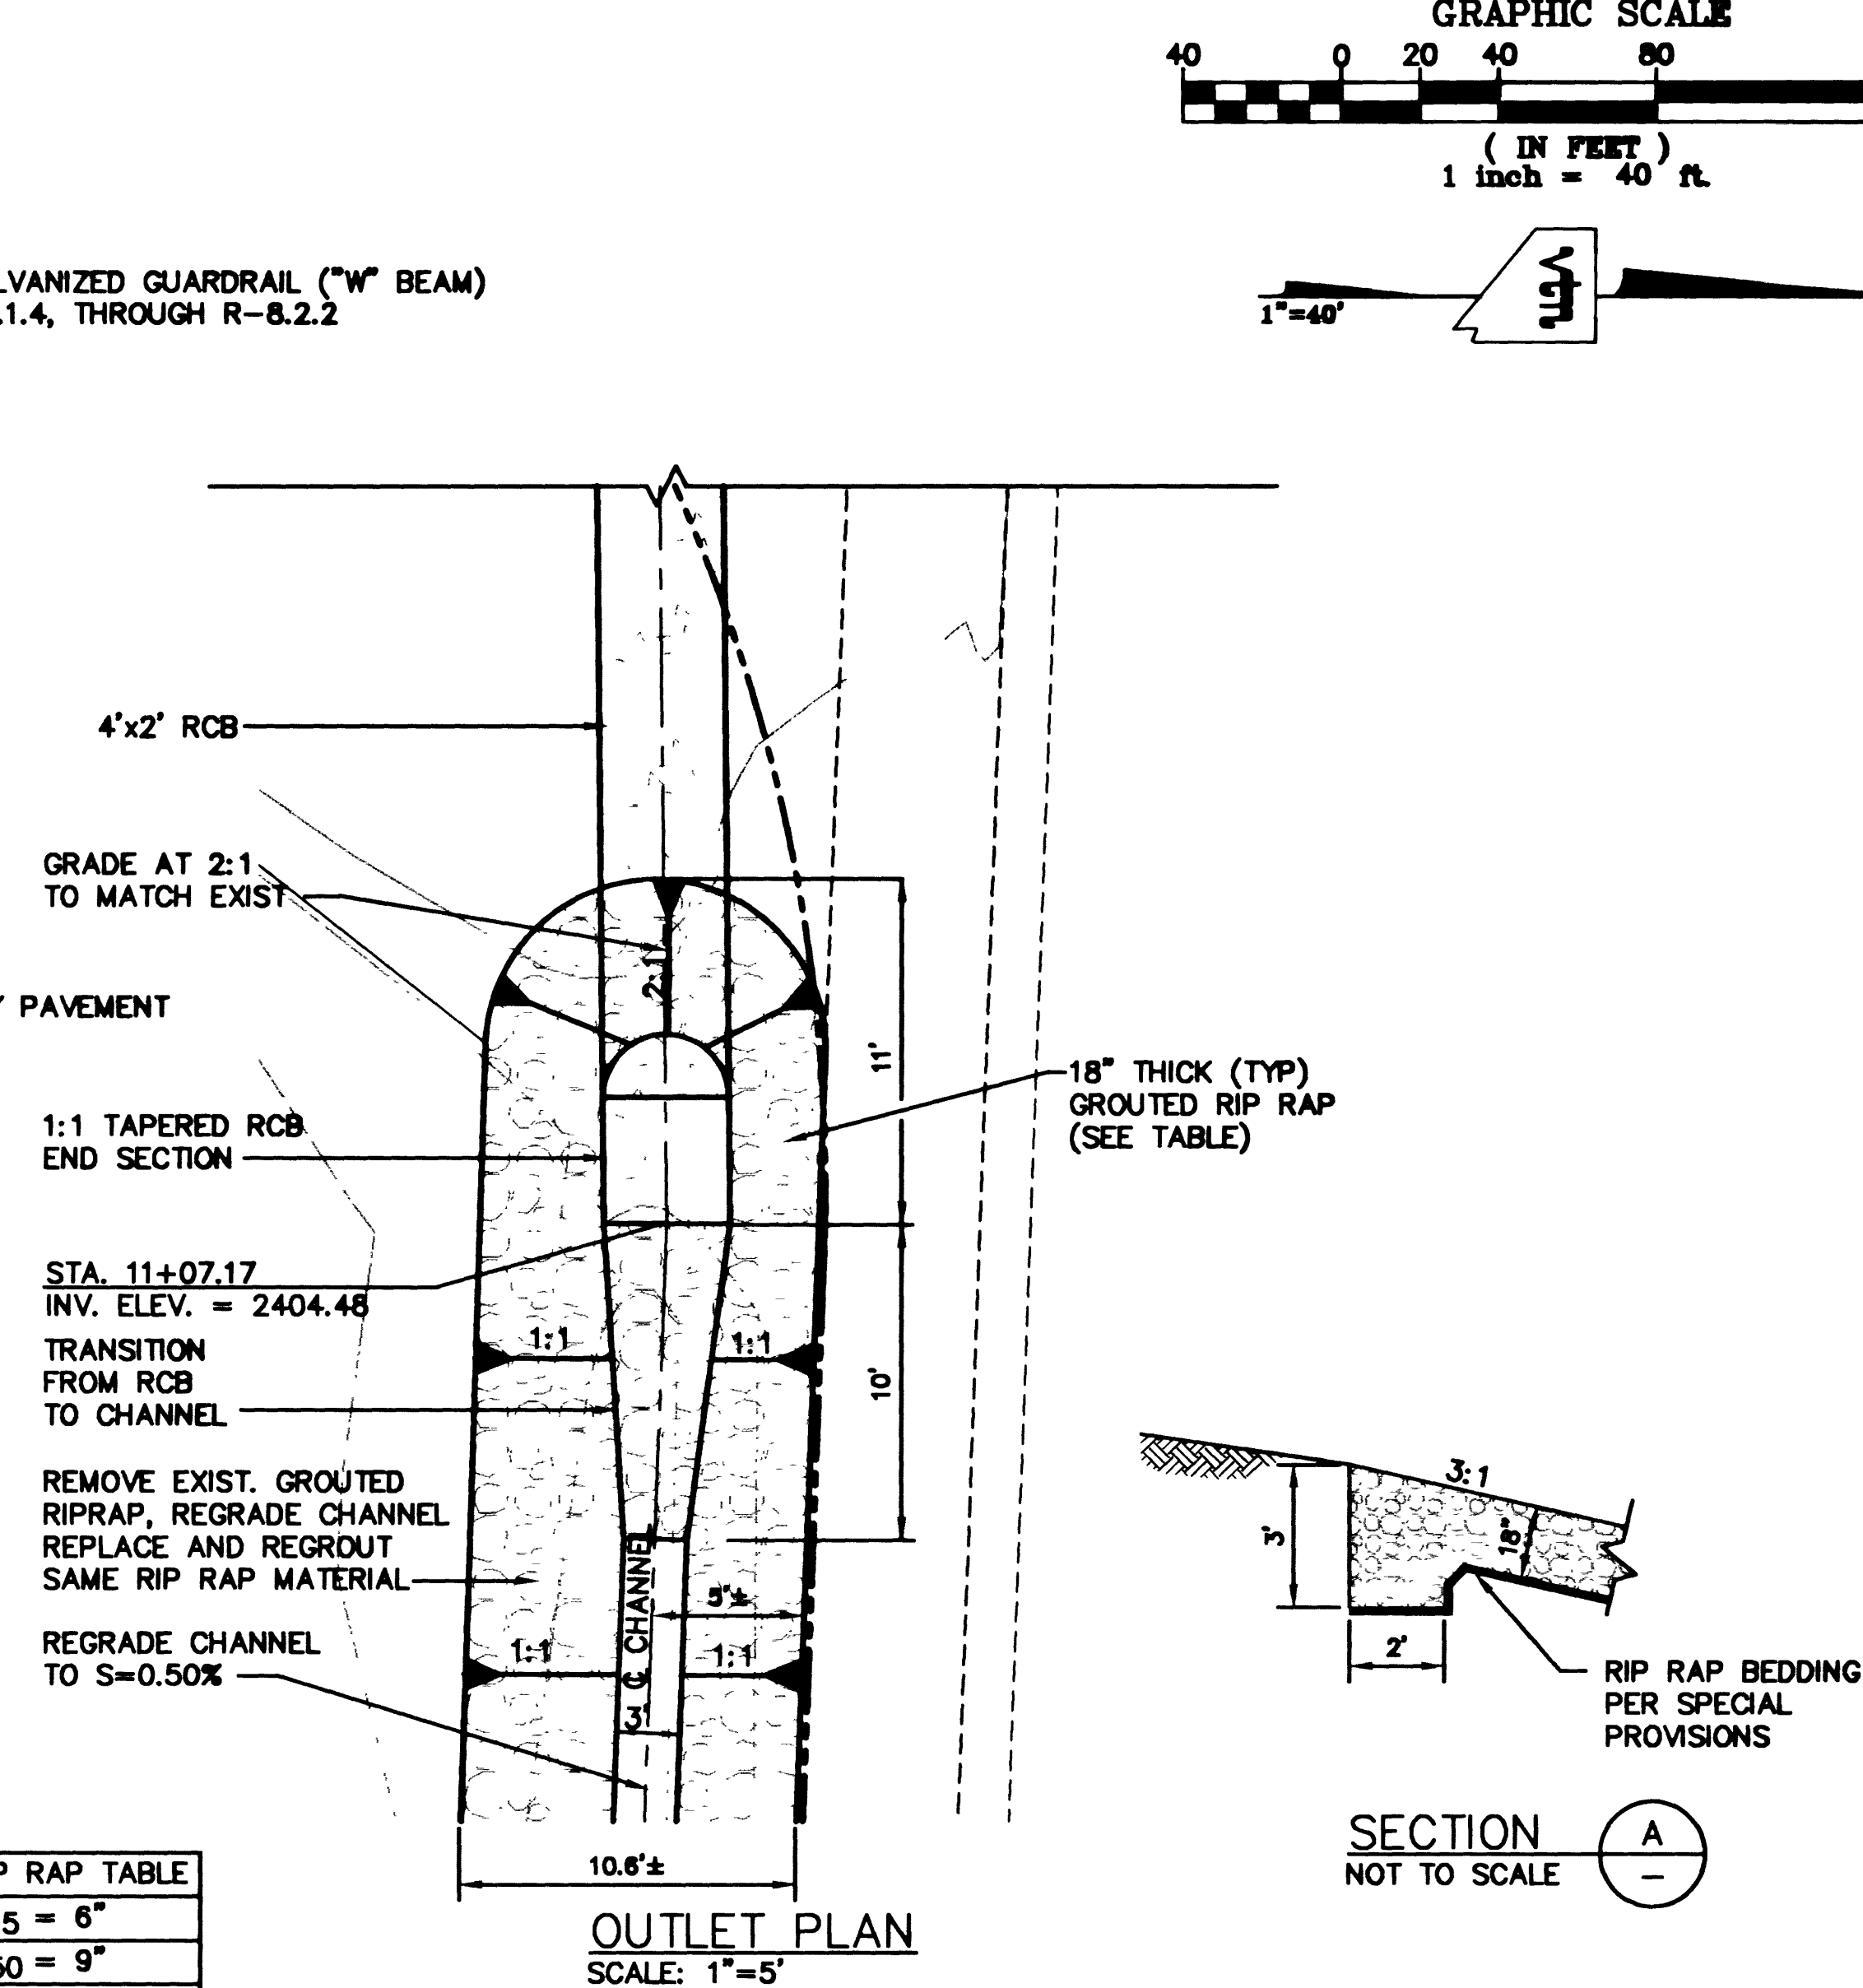
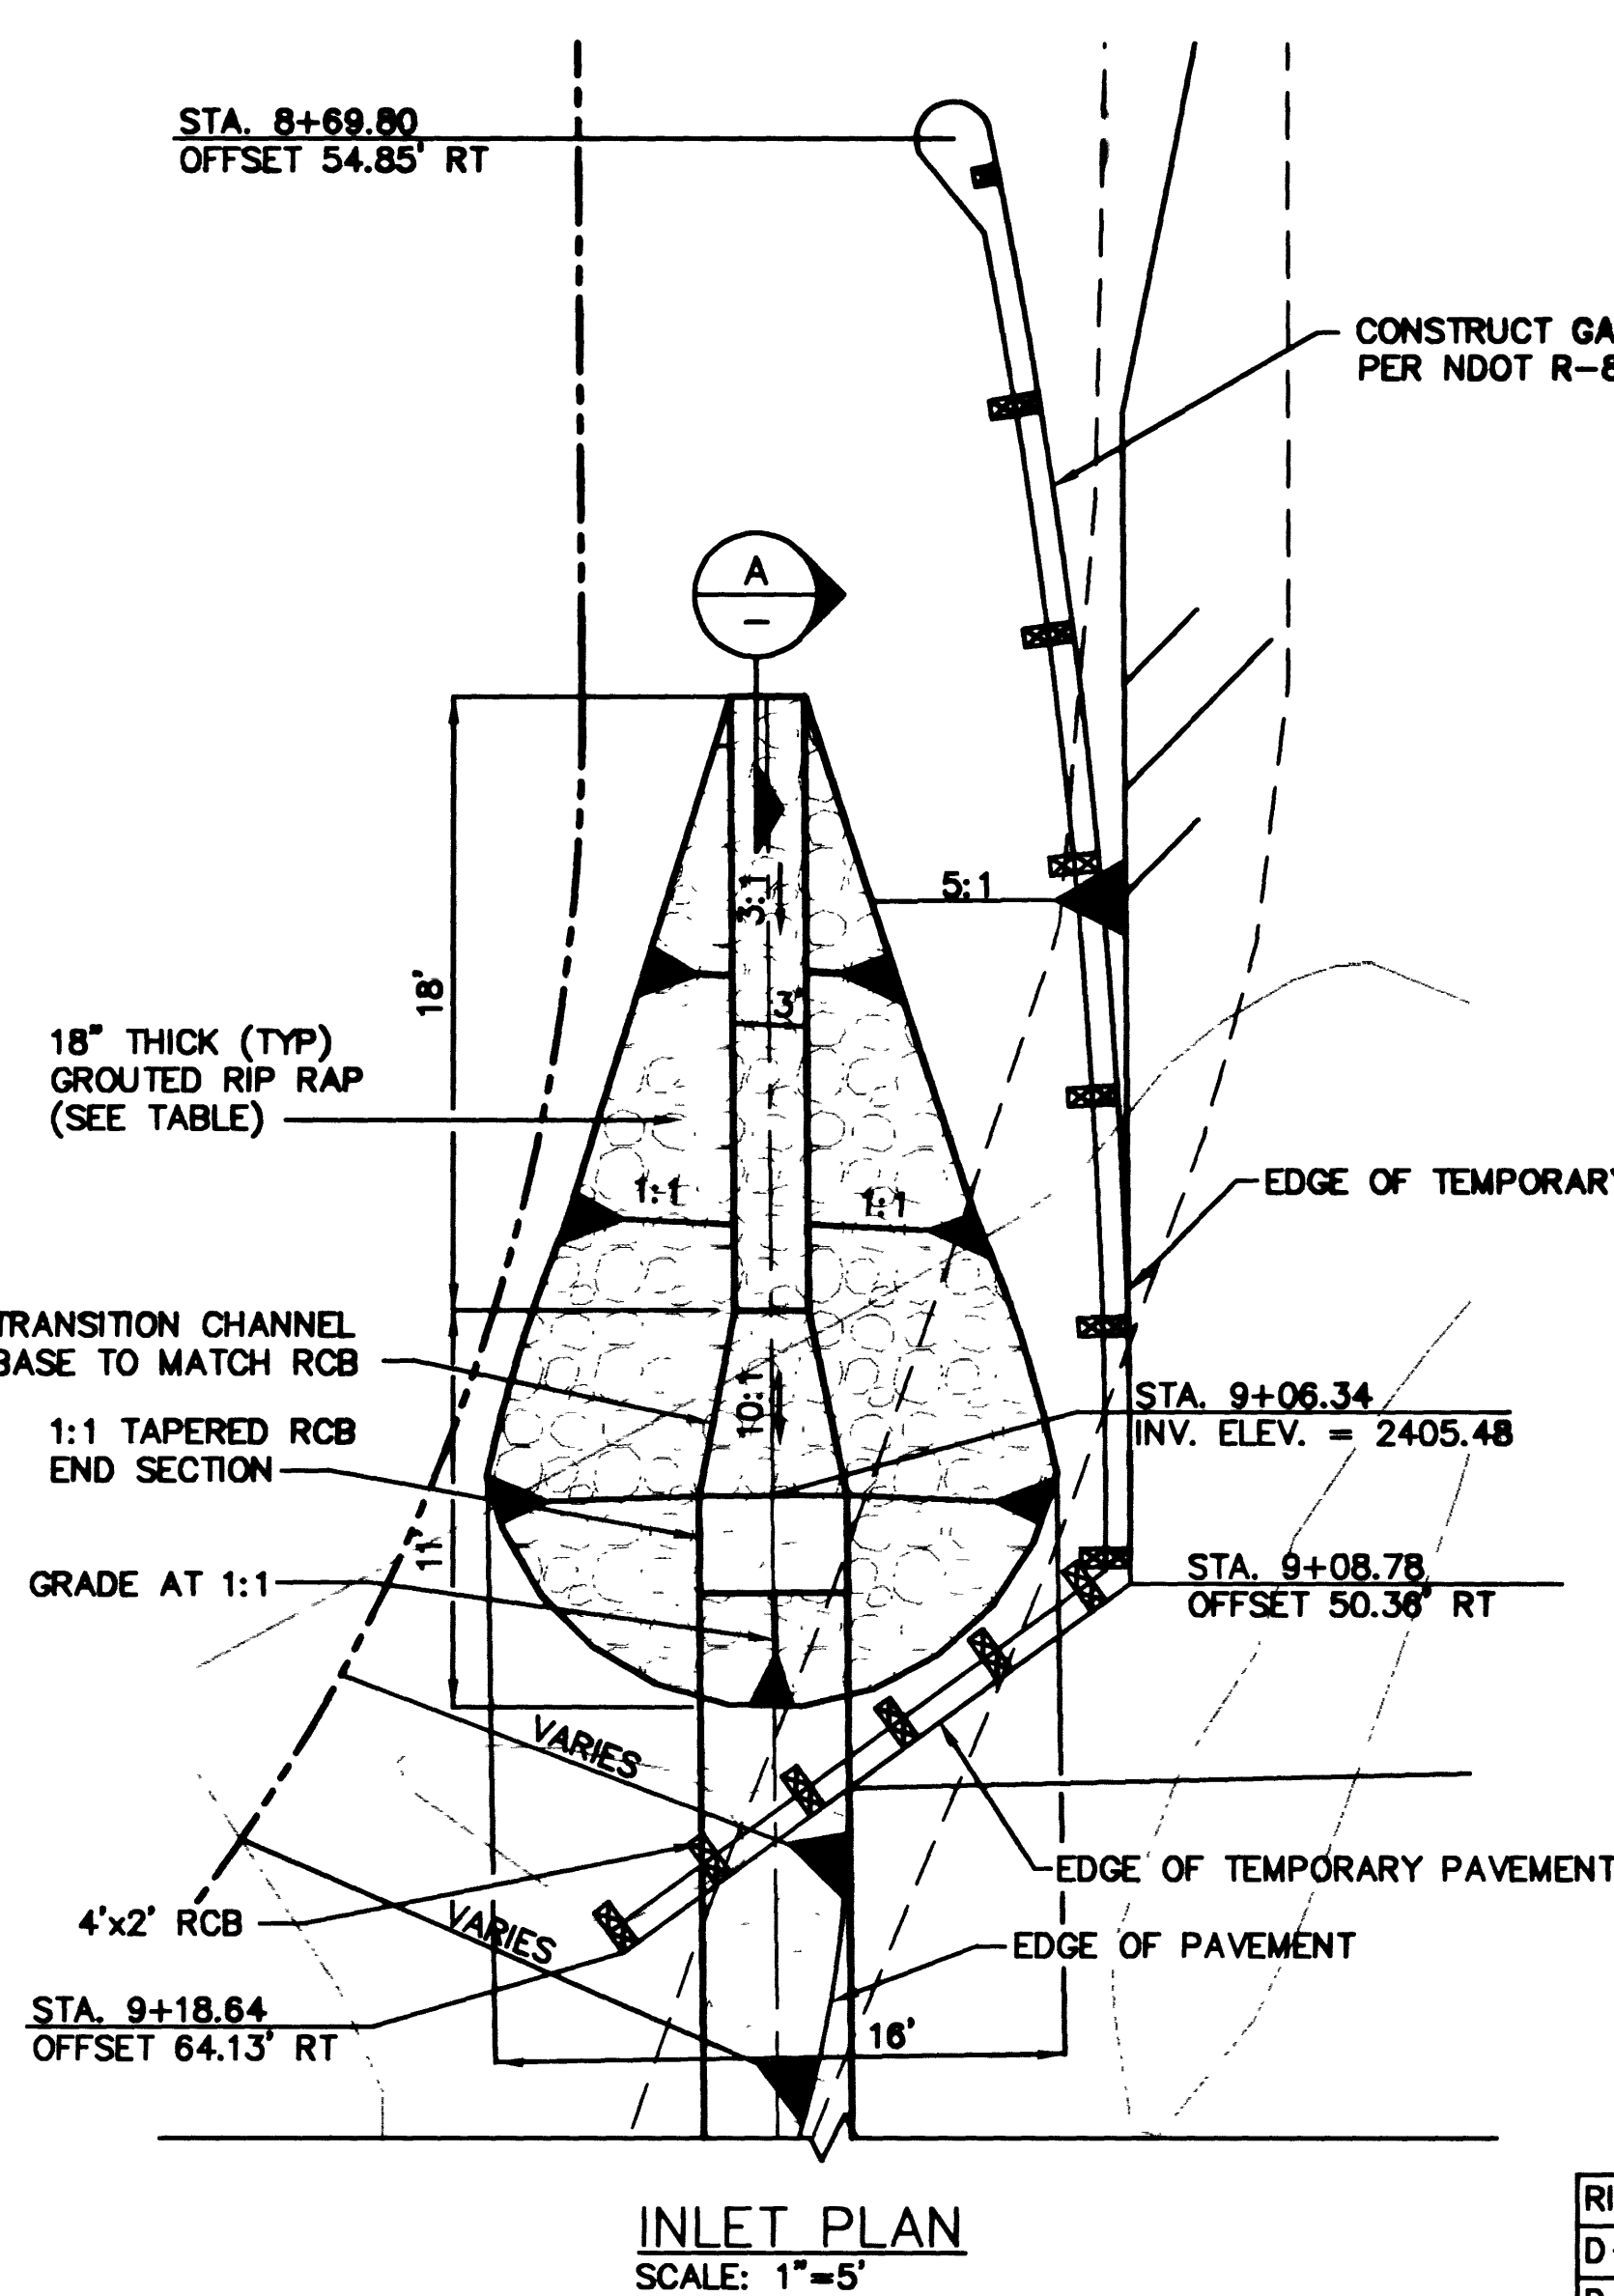


NEKS: US = 7.1, PS = 79.1
I:\CAD\PROJECTS\249\249-SD.DWG

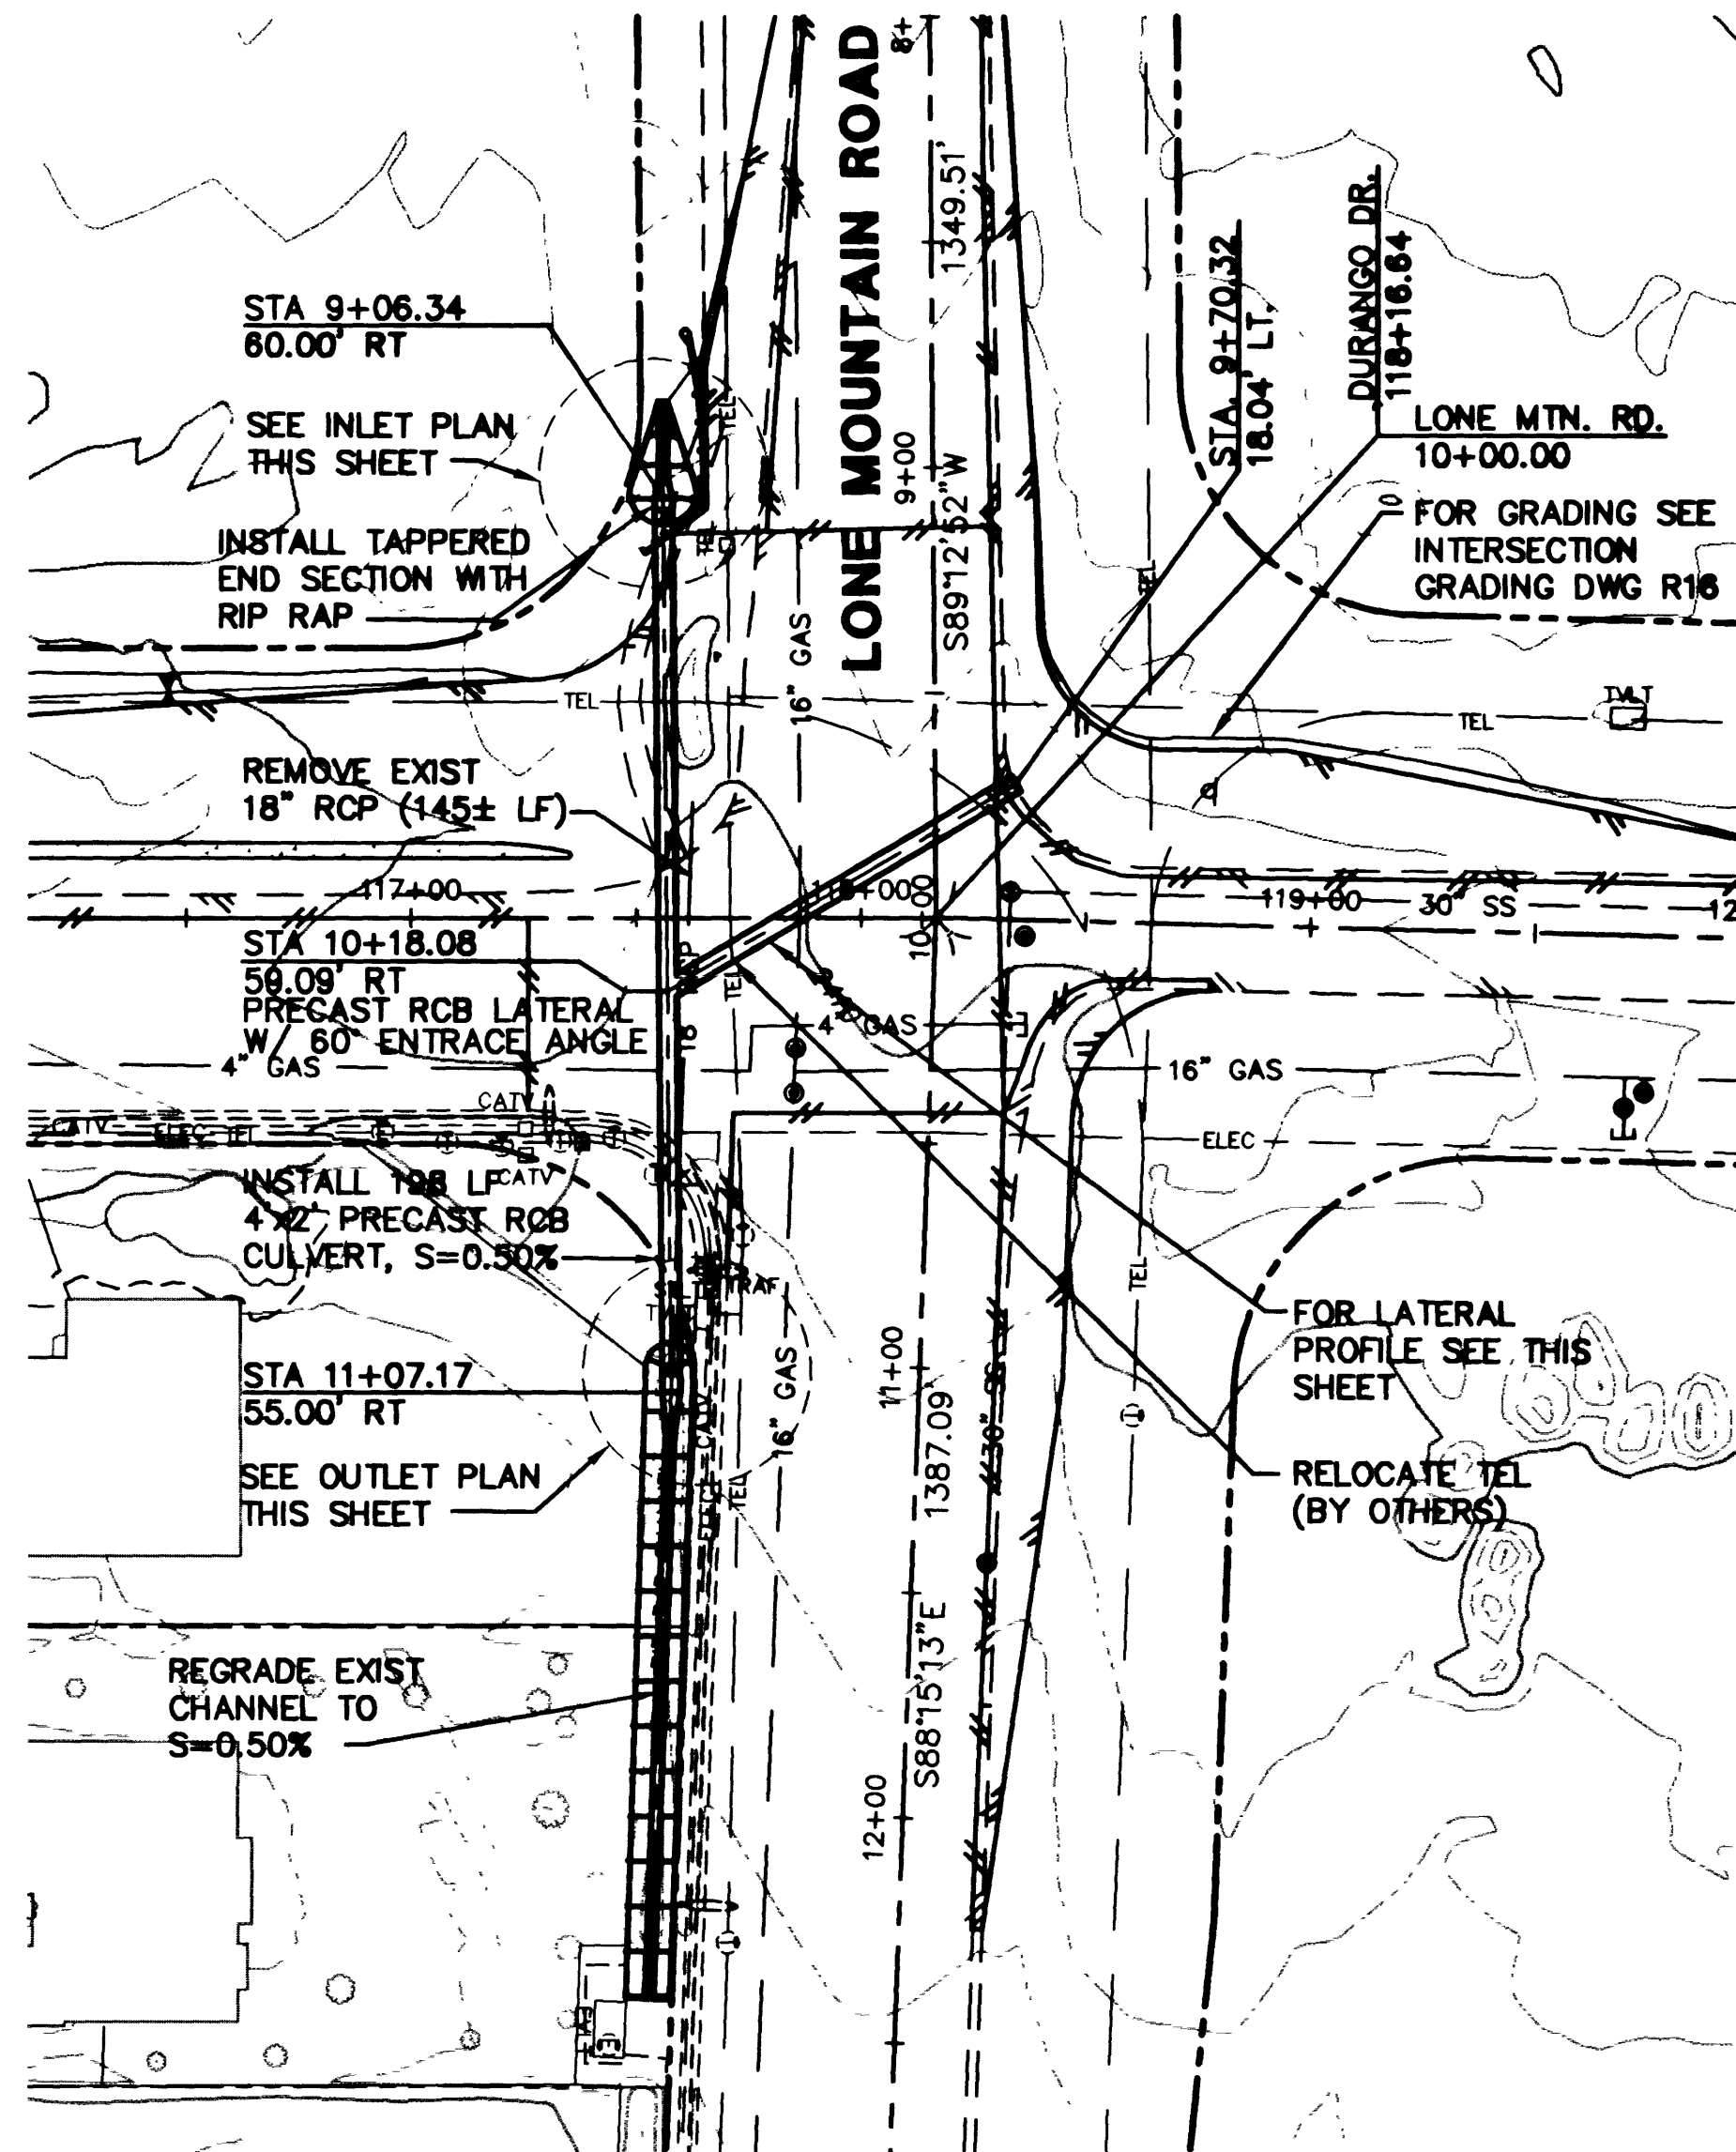

DEPARTMENT OF PUBLIC WORKS
CITY OF LAS VEGAS, NEVADA

CONSULTING ENGINEERS • PLANNERS • LAND SURVEYORS
2727 SOUTH RAINBOW BOULEVARD
LAS VEGAS, NEVADA 89102-5148 PHONE (702) 873-7550 FAX (702) 362-2597

vtm nevada

REV	DATE	BY	REASON

STORM DRAIN PLAN AND PROFILE
STORM DRAIN EXTENSION
LONE MOUNTAIN / DURANGO
DURANGO DRIVE IMPROVEMENTS
CHEYENNE AVENUE TO LONE MOUNTAIN ROAD

SEAL
JOINER S. LAGIPCAN
CIVIL
No. 12551

WO. NO. 5249
BY JL/LMW
DATE 07/17/98
SCALE HORIZ. 1"=40'
VERT. 1"=4'
DRAWING SHEET 64 OF 106 SHEETS
SD13