
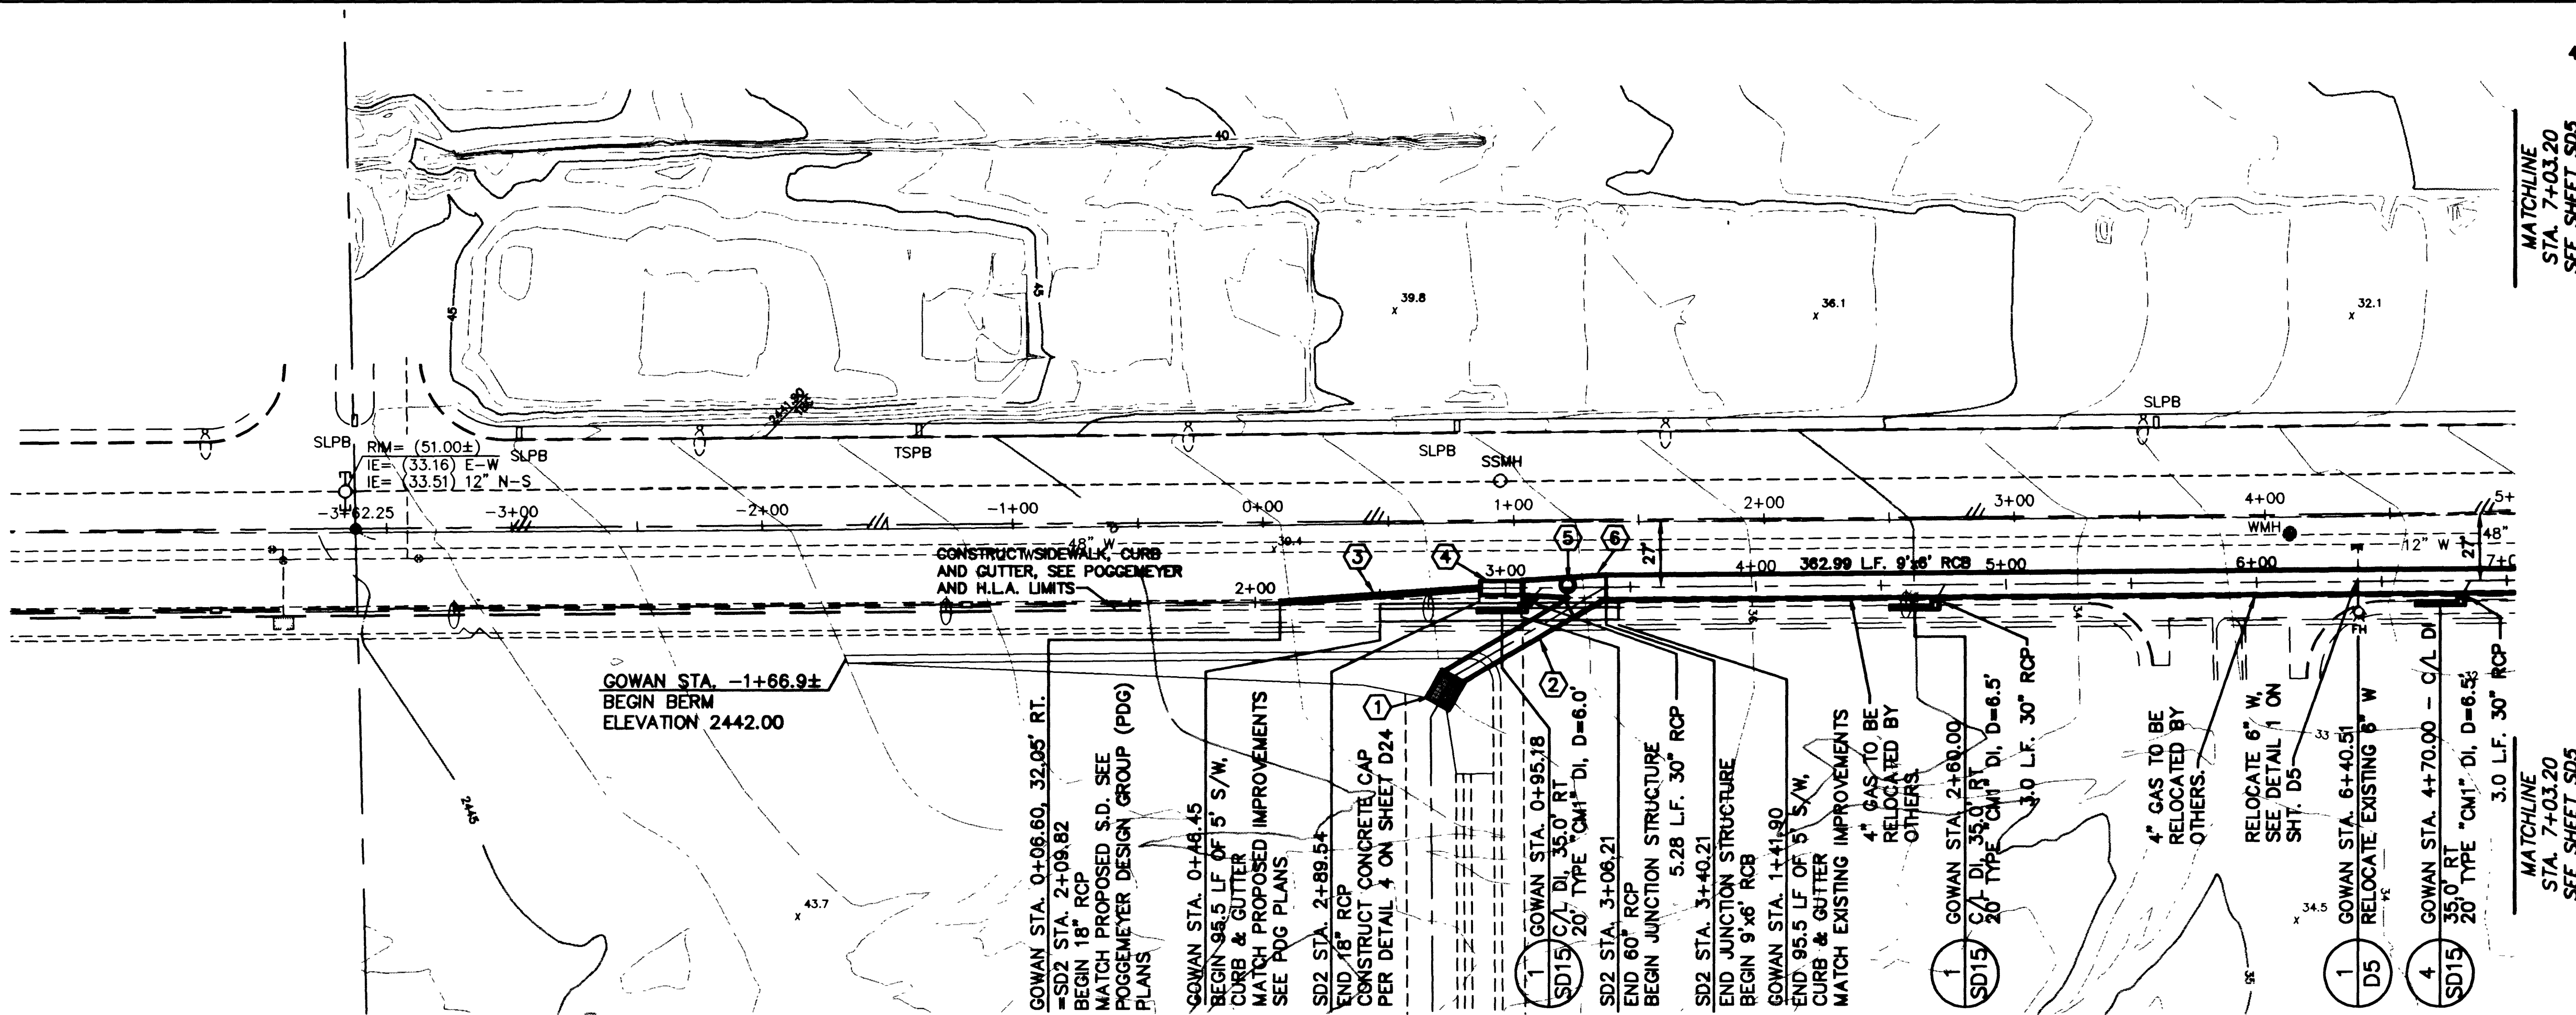


MATCHLINE
STA. 7+03.20
SEE SHEET SD5

MATCHLINE
STA. 7+03.20
SEE SHEET SD5

- ① CONSTRUCT FIELD INLET PER DETAILS ON SHEET D17-D20.
- ② 53.42 L.F. PRECAST 7'x6' RCB, SEE DETAIL 2 ON SHEET SD15.
- ③ 79.73 L.F. 18" RCP
- ④ 16 L.F. 60" RCP
- ⑤ 60" TYPE IA MANHOLE
- ⑥ 34 L.F. 60" RCP TO 9' x 6' RCB TRANSITION / JUNCTION STRUCTURE
SEE DETAILS ON SHEET D8.

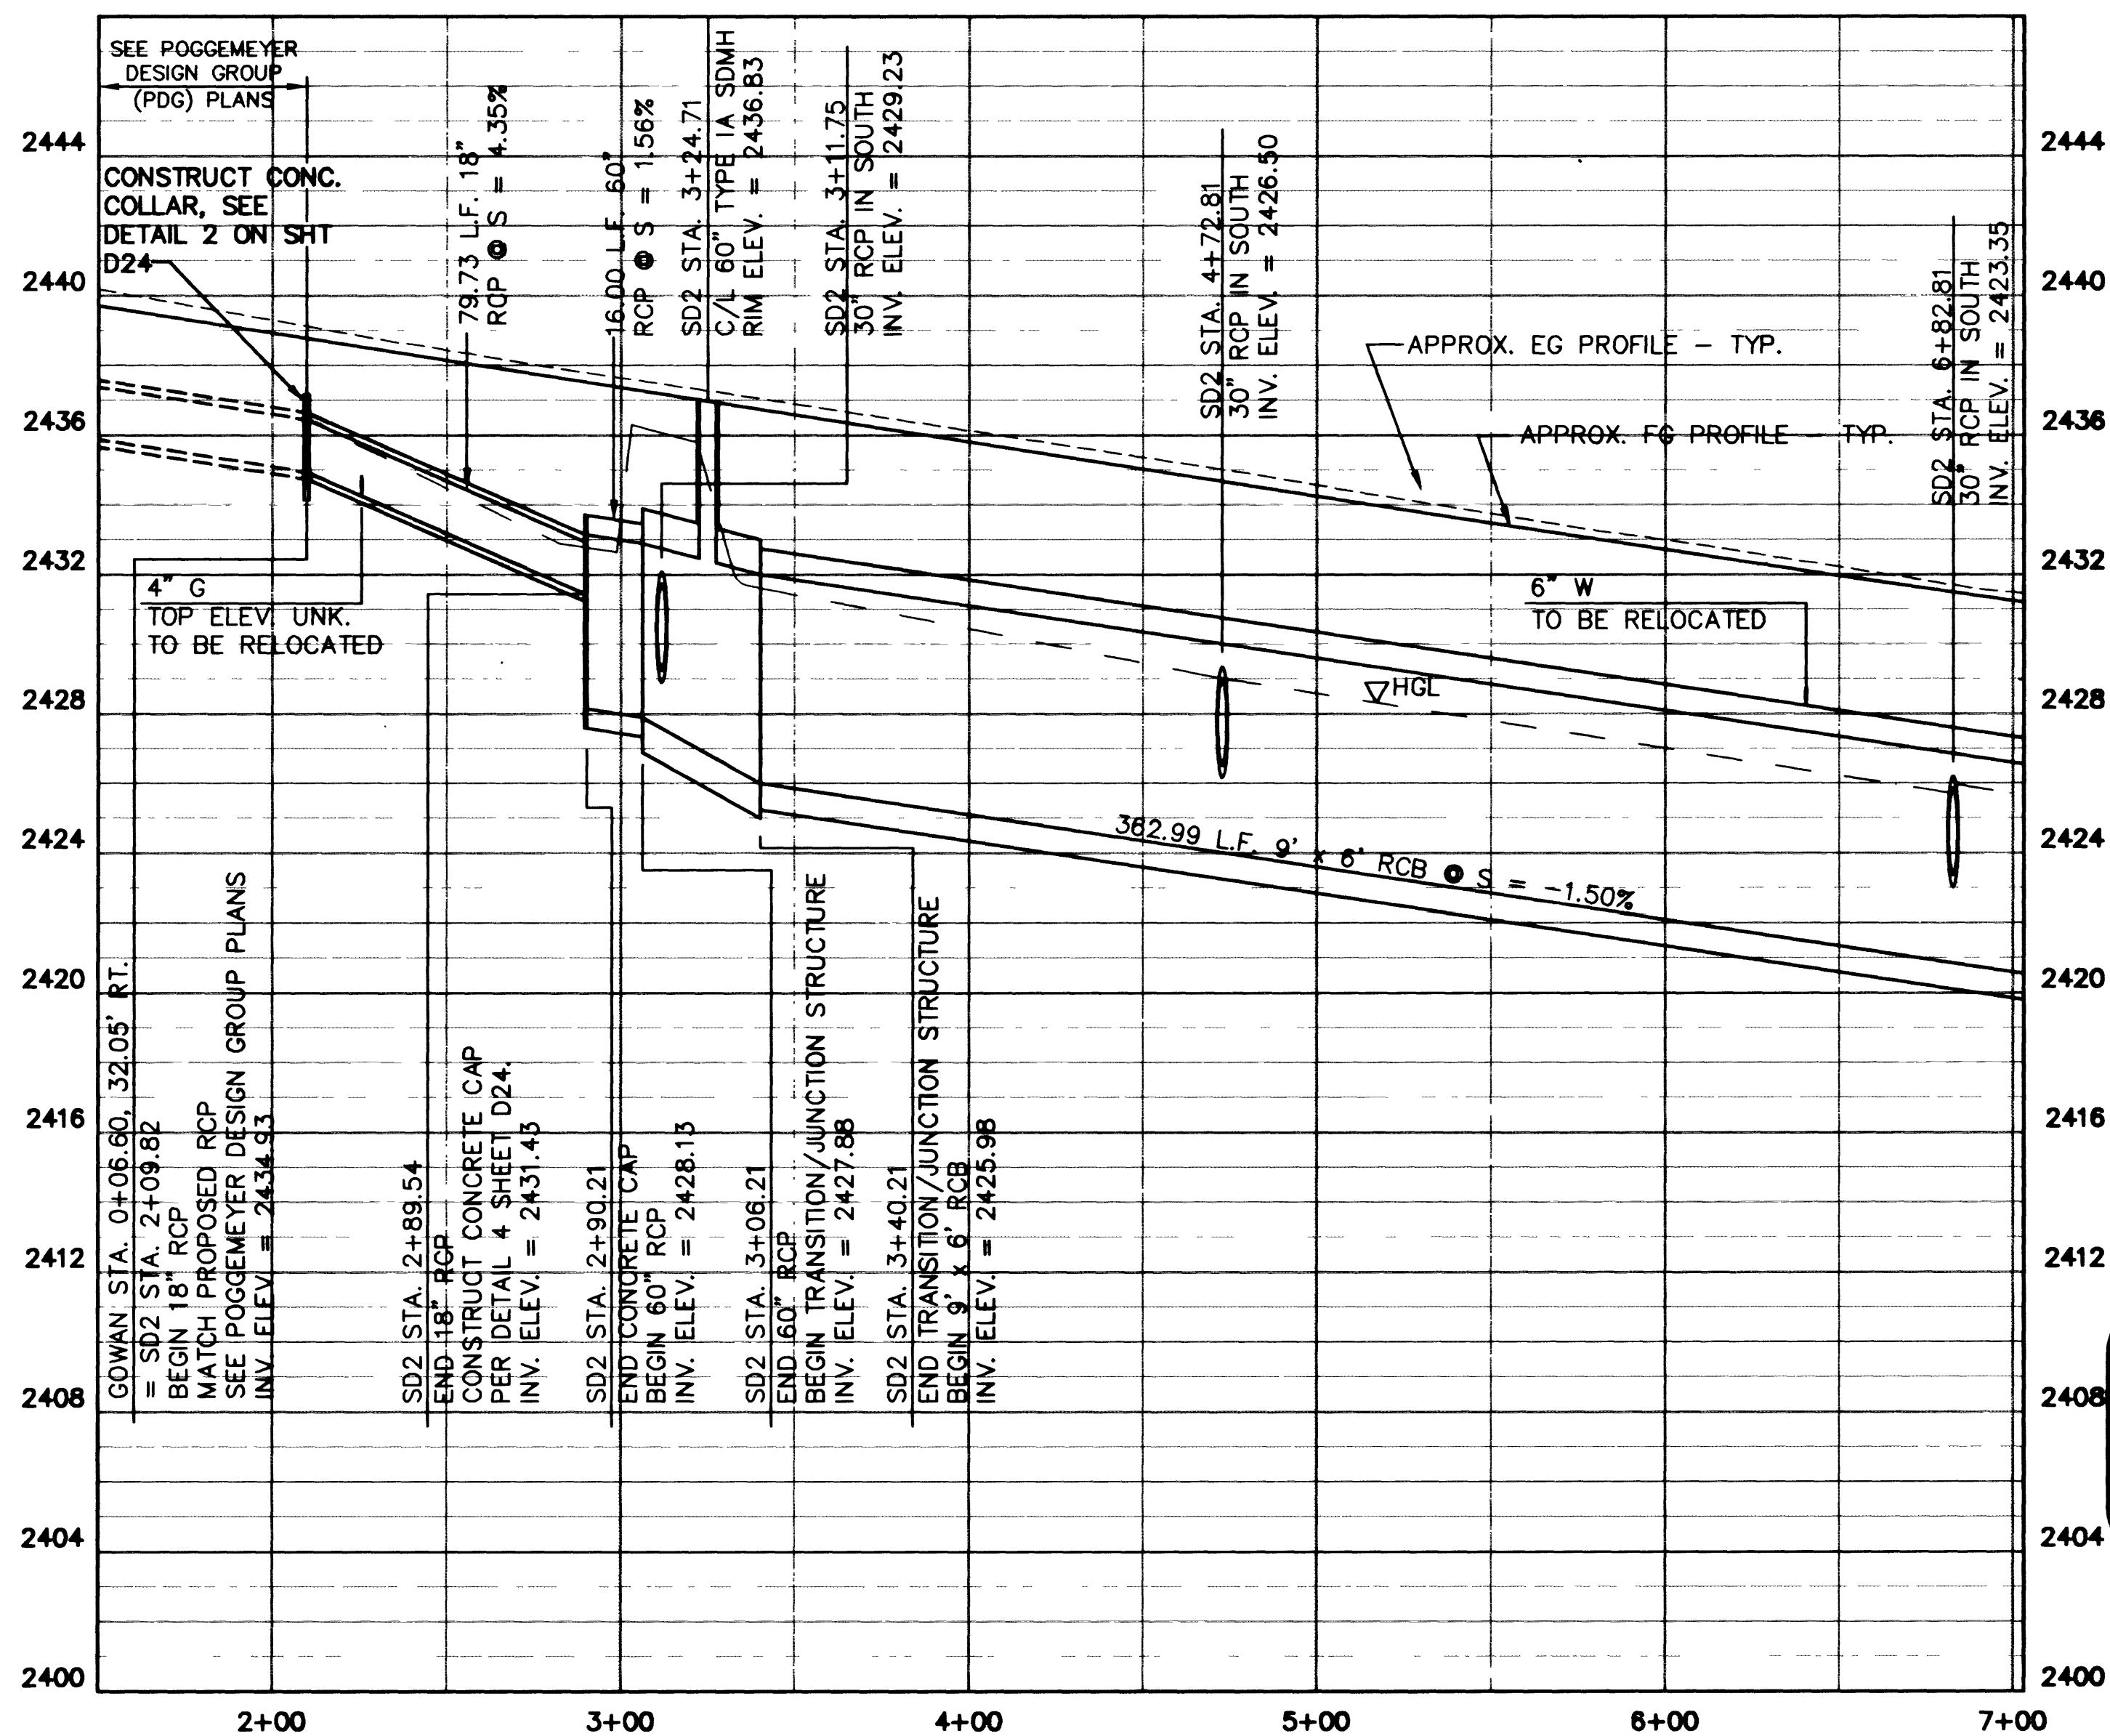

- NOTES:
1. ALL RCP IS TO BE CLASS III.
 2. ALL MH SHOWN ON THIS SHEET TO HAVE 30" RING & COVER
 3. ALL RCB SHALL BE PRECAST RCB.
 4. INSTALL MH STEPS PER STD. DWG. #410 AT MH RISER AND RCB.

APPROVED
[Signature] 12/22/98
LAS VEGAS VALLEY WATER DISTRICT DATE

STORM DRAIN PLAN AND PROFILE
SD2 STA. 0+00.00 TO 7+03.20
GOWAN ROAD

DURANGO DRIVE IMPROVEMENTS
CHEYENNE AVENUE TO LONE MOUNTAIN ROAD

SEAL PROFESSIONAL ENGINEER-STATE OF NEVADA JOHNER S. LAGACAN CIVIL No. 12801	
WD. NO.	5249
BY	JL,LMW
DATE	07/17/98
SCALE	HORIZ. 1"=40' VERT. 1"=4'
DRAWING	SHEET 55 OF 106 SHEETS

DEPARTMENT OF PUBLIC WORKS
CITY OF LAS VEGAS, NEVADA

vtm nevada

CONSULTING ENGINEERS • PLANNERS • LAND SURVEYORS
2727 SOUTH RAINBOW BOULEVARD
LAS VEGAS, NEVADA 89102-5148 PHONE (702) 873-7550 FAX (702) 362-2597