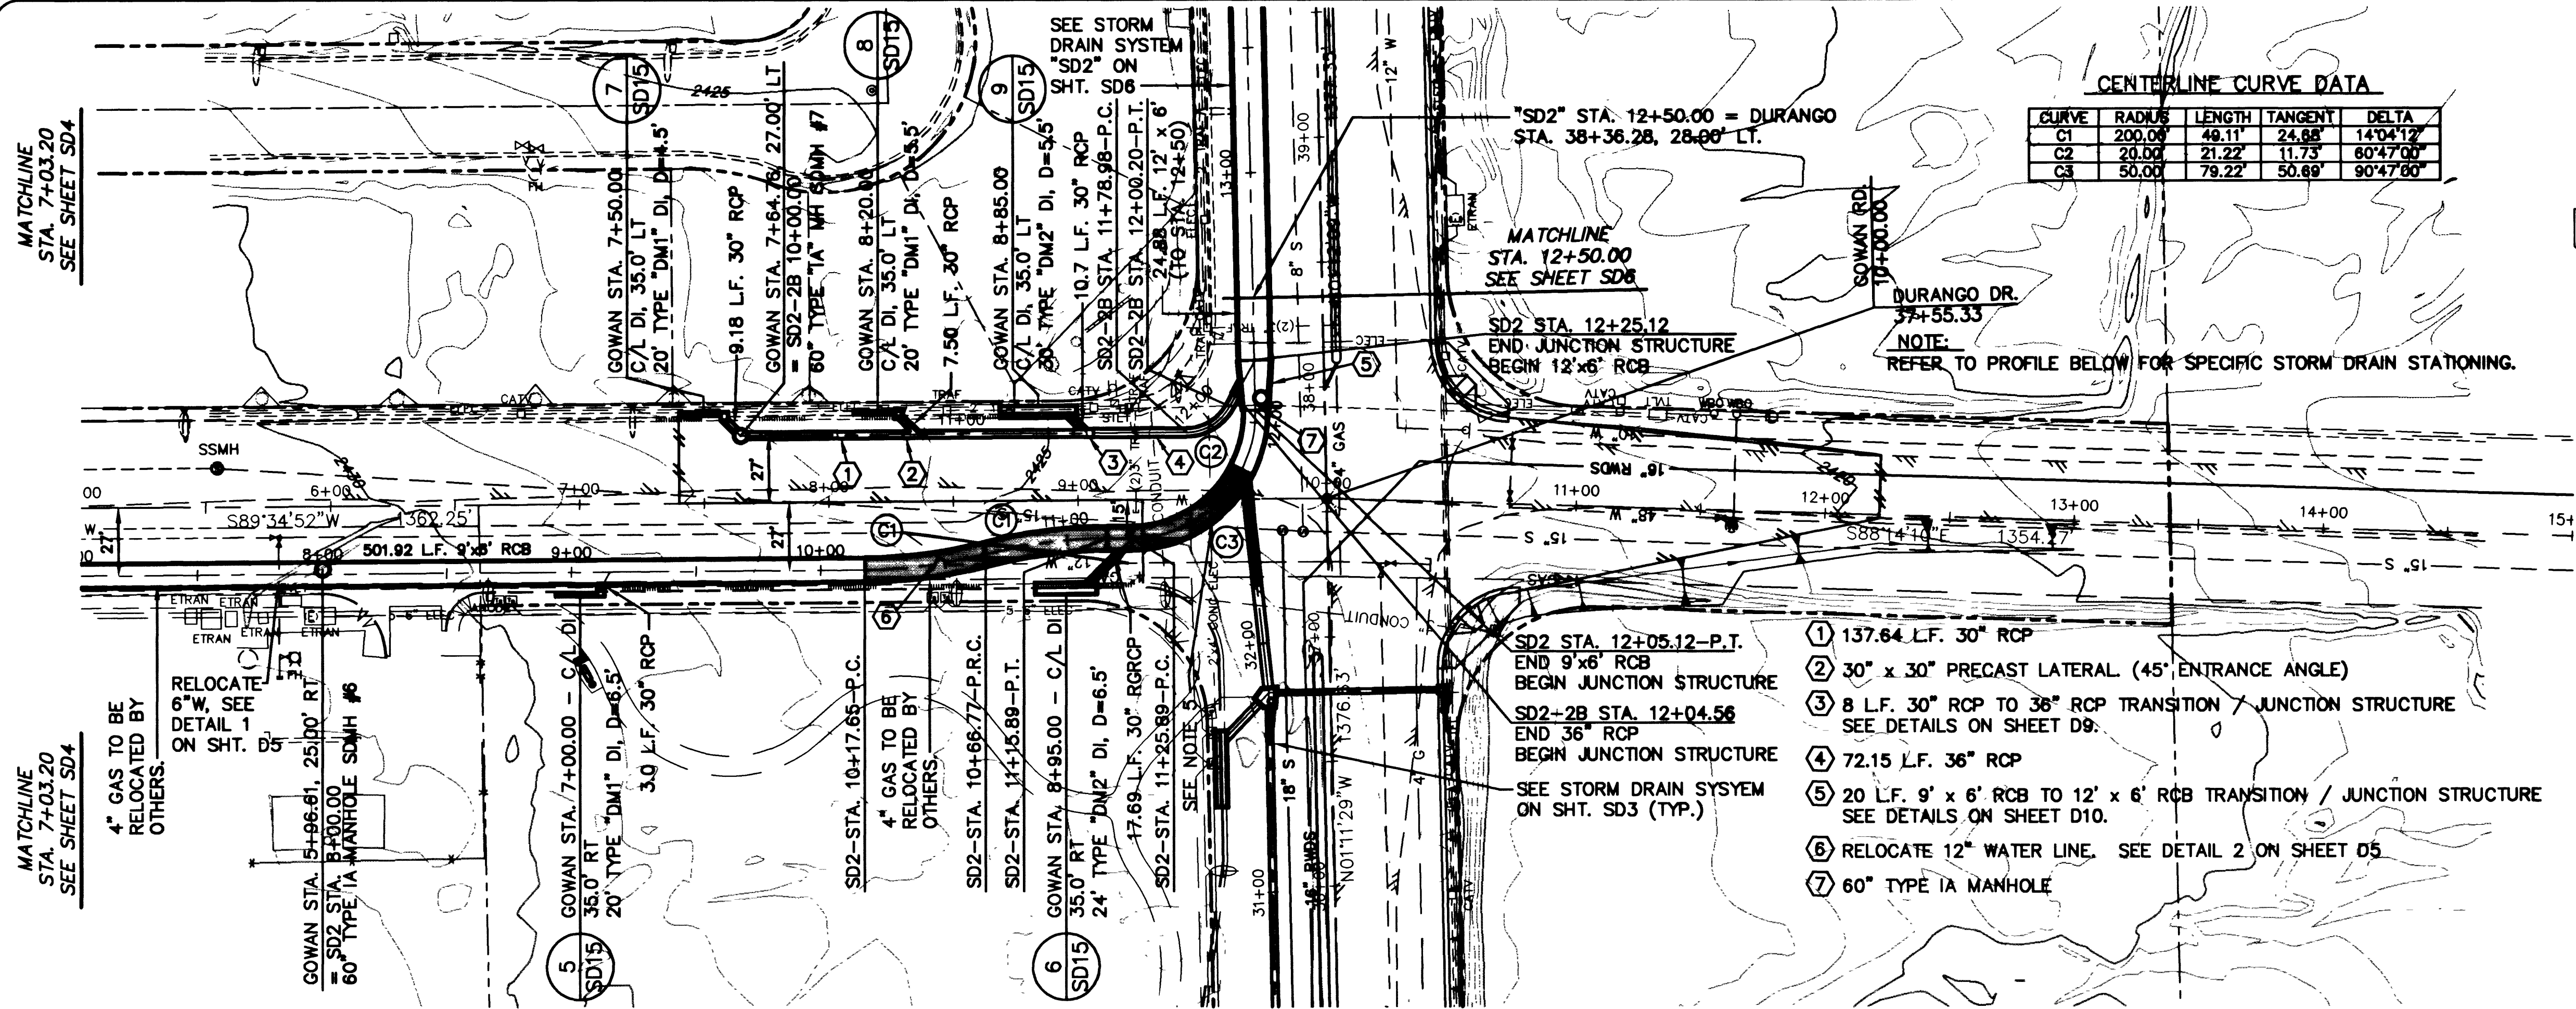
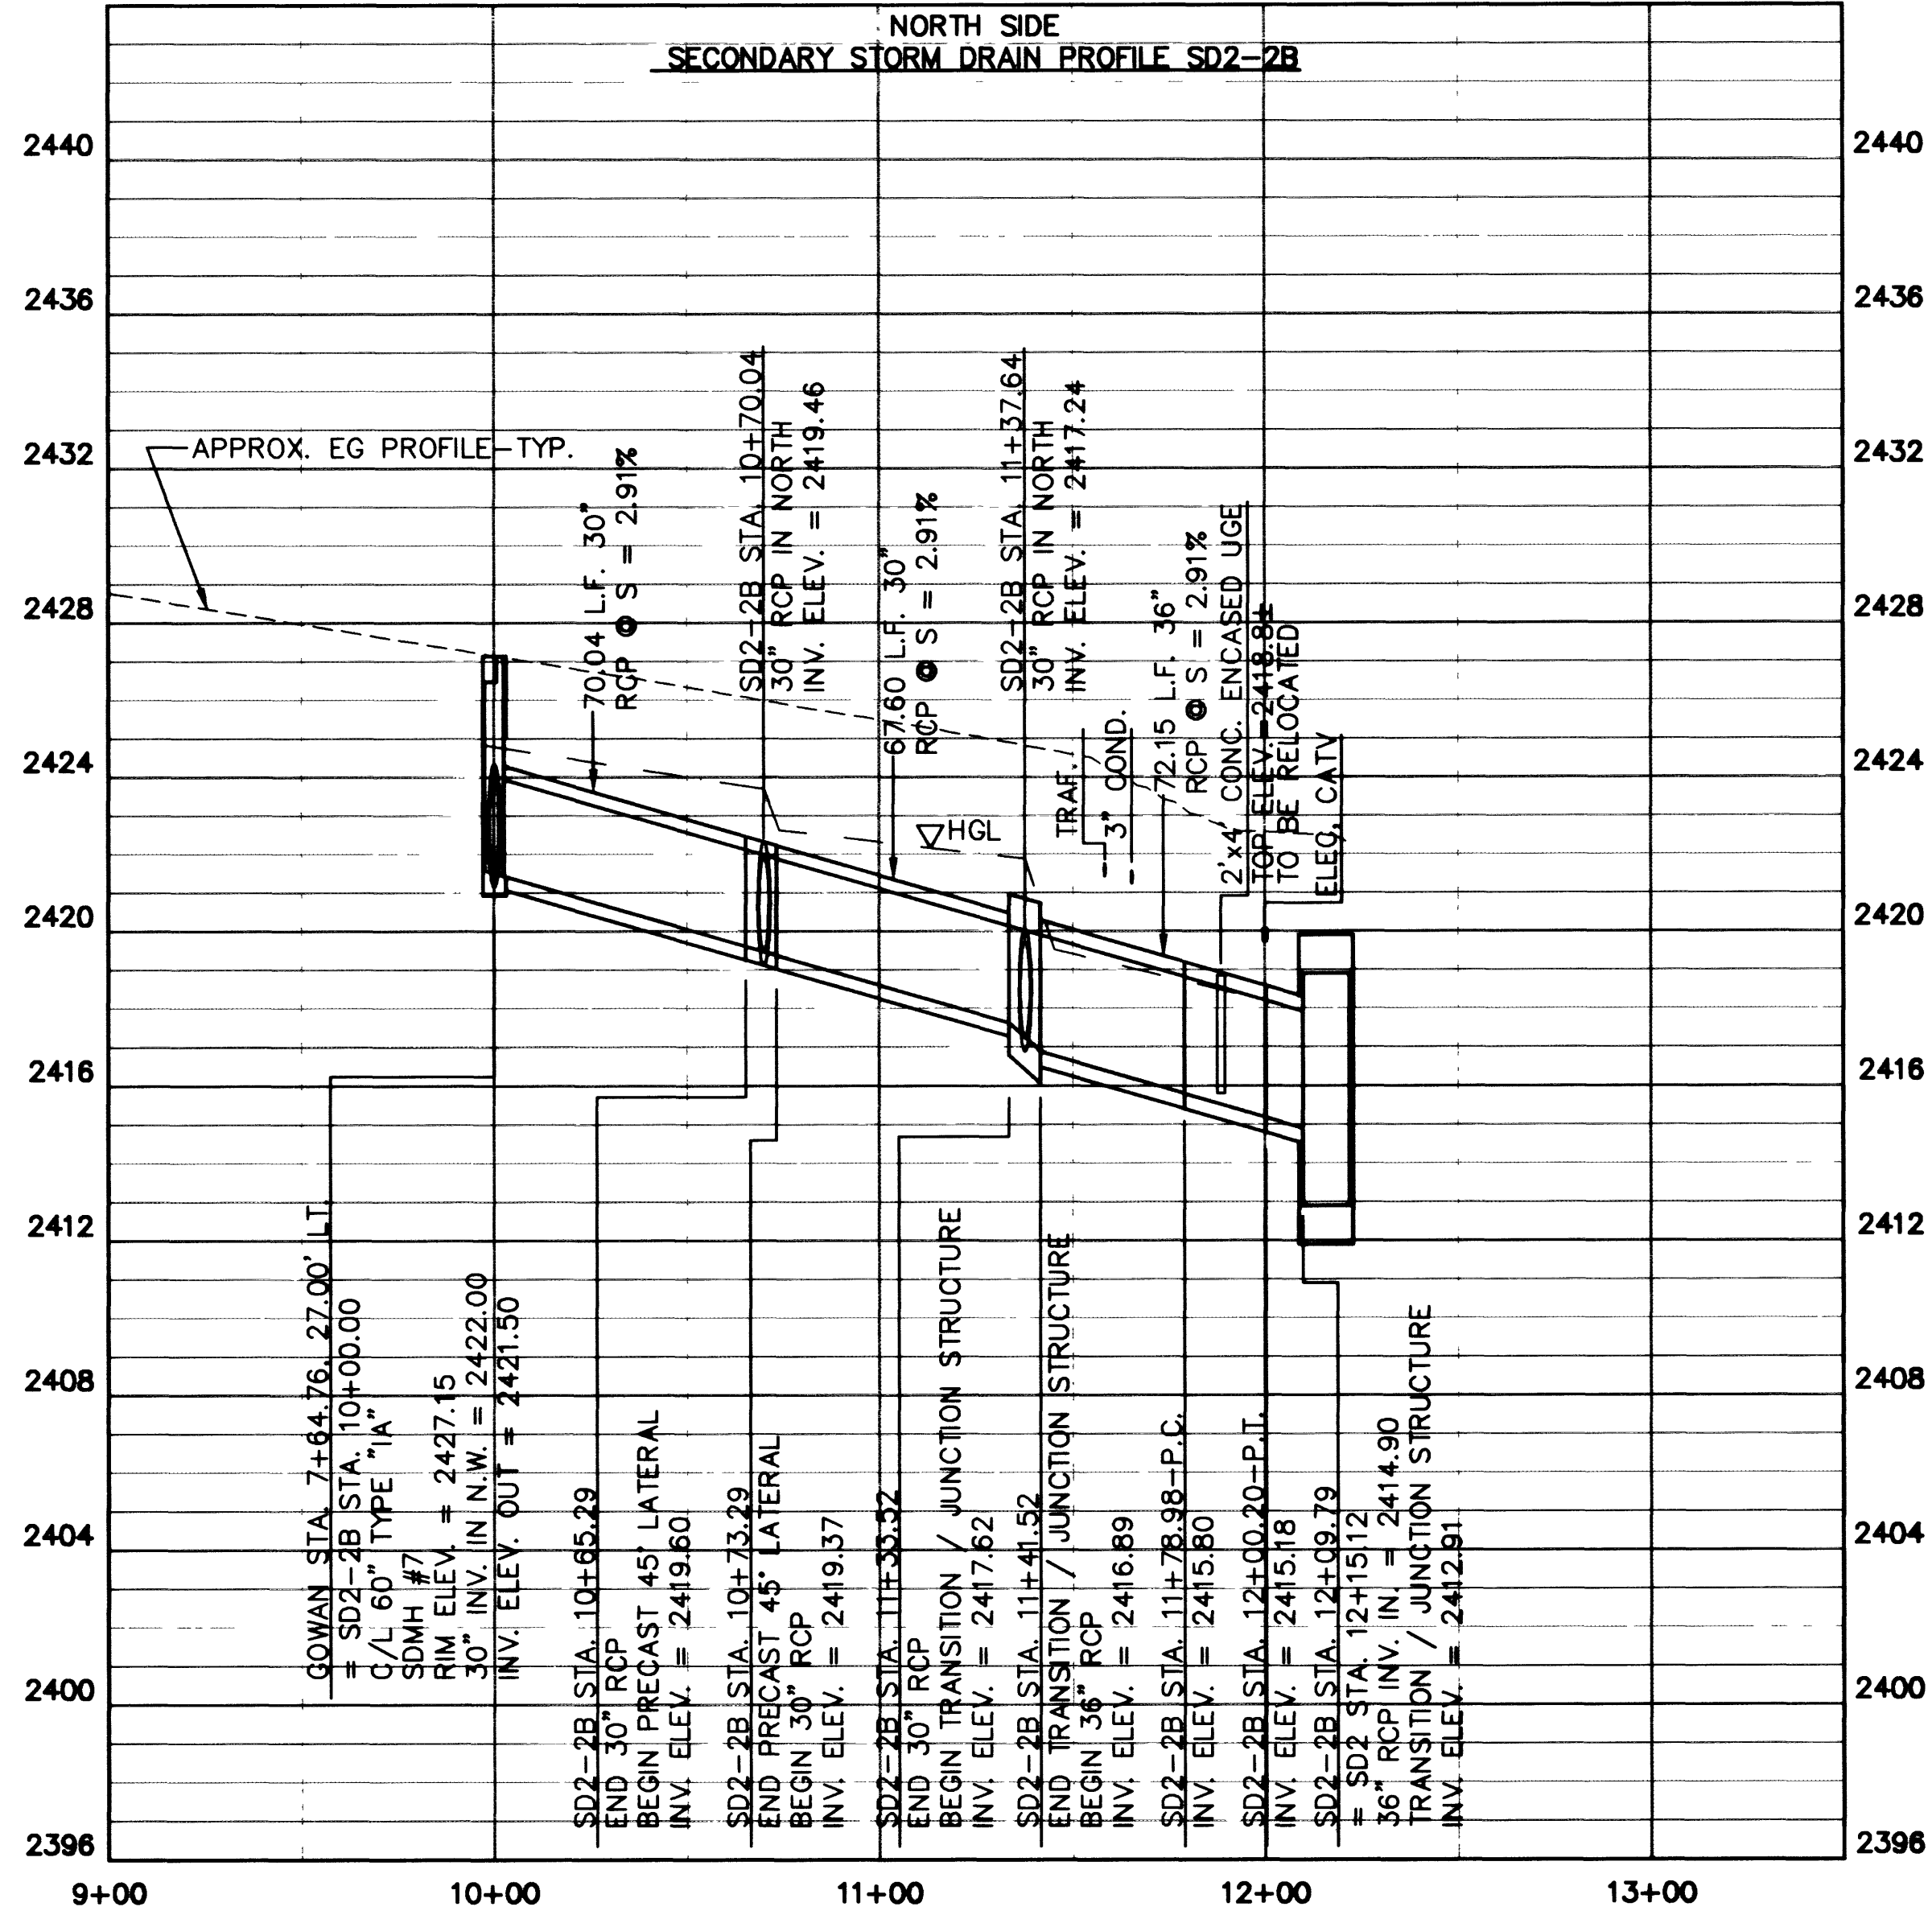
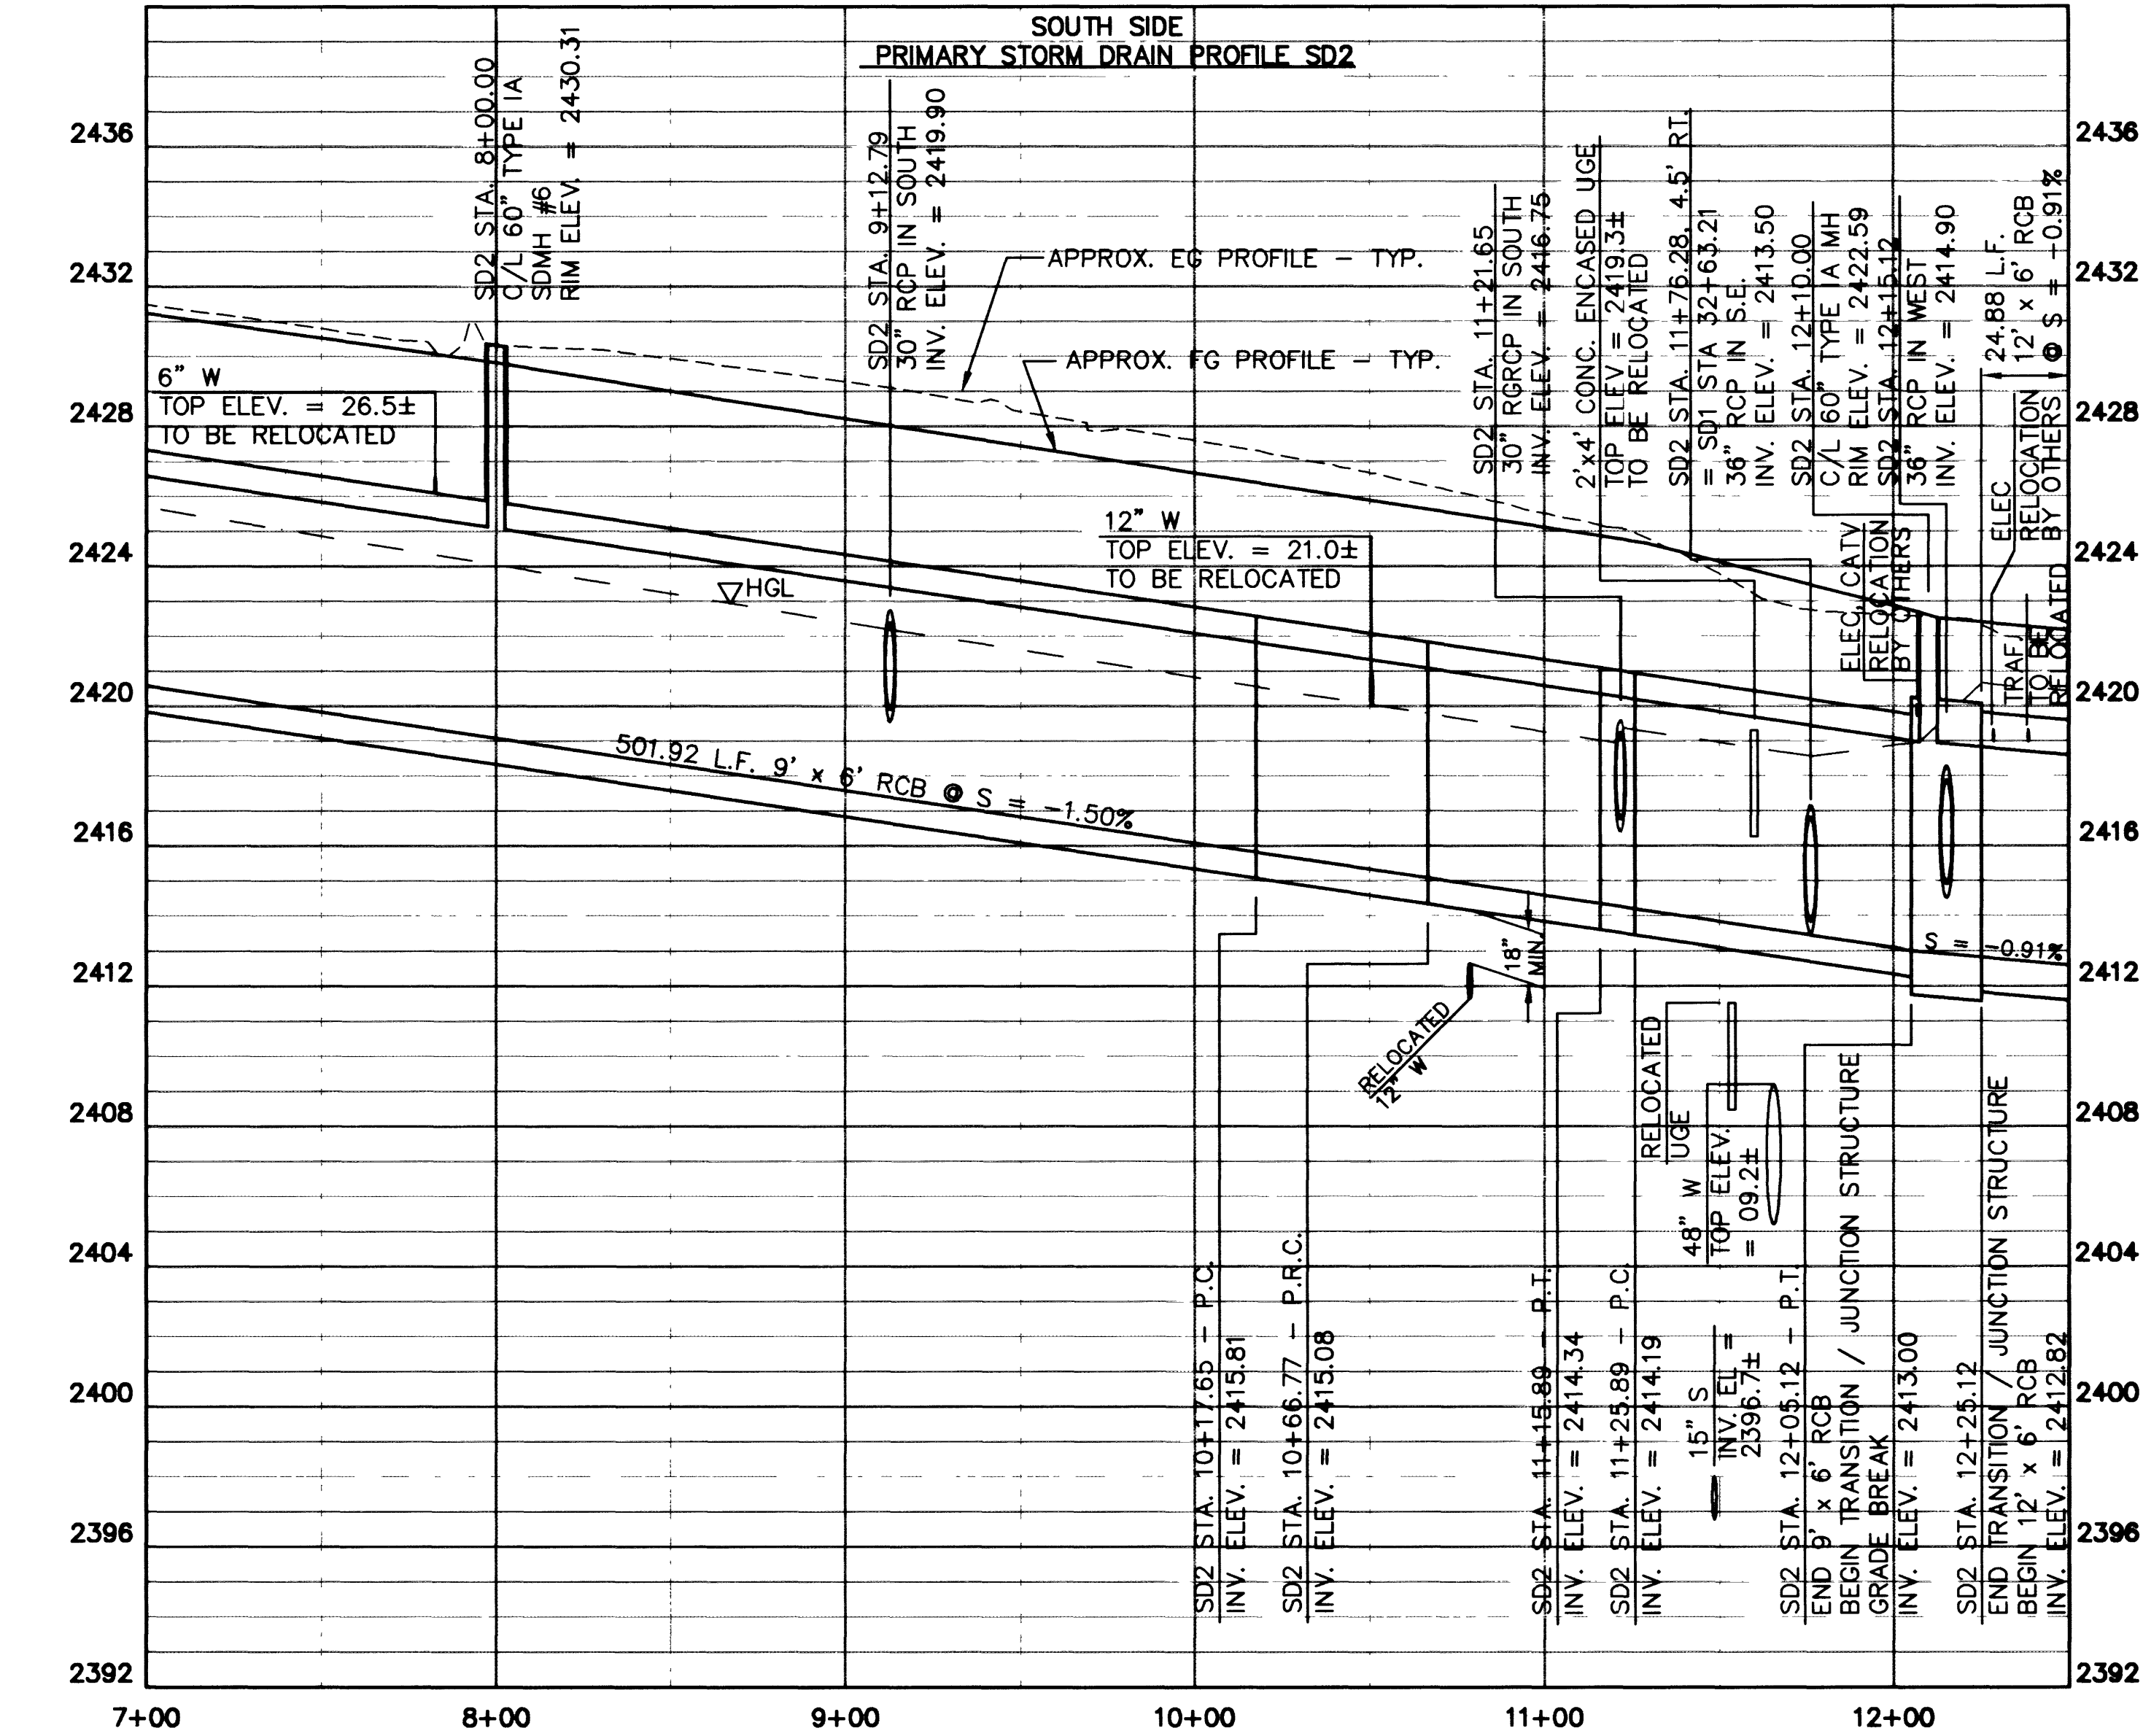


DEPARTMENT OF PUBLIC WORKS
CITY OF LAS VEGAS, NEVADA

CONSULTING ENGINEERS • PLANNERS • LAND SURVEYORS
2727 SOUTH RAINBOW BOULEVARD
LAS VEGAS, NEVADA 89102-5148 PHONE (702) 873-7550 FAX (702) 362-2597

vtm nevada

STORM DRAIN PLAN AND PROFILE
SD2 STA. 7+03.20 TO 12+50.00
DURANGO DRIVE IMPROVEMENTS
CHEYENNE AVENUE TO LONE MOUNTAIN ROAD

NO. 5249
BY: JLMW
DATE: 07/17/98
SCALE: HORIZ. 1"=40'
VERT. 1"=40'
SHEET 56 OF 106