


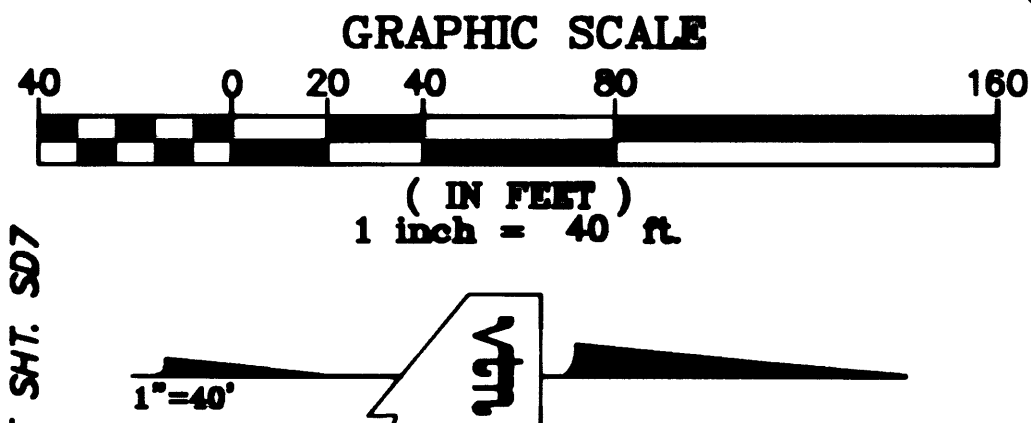


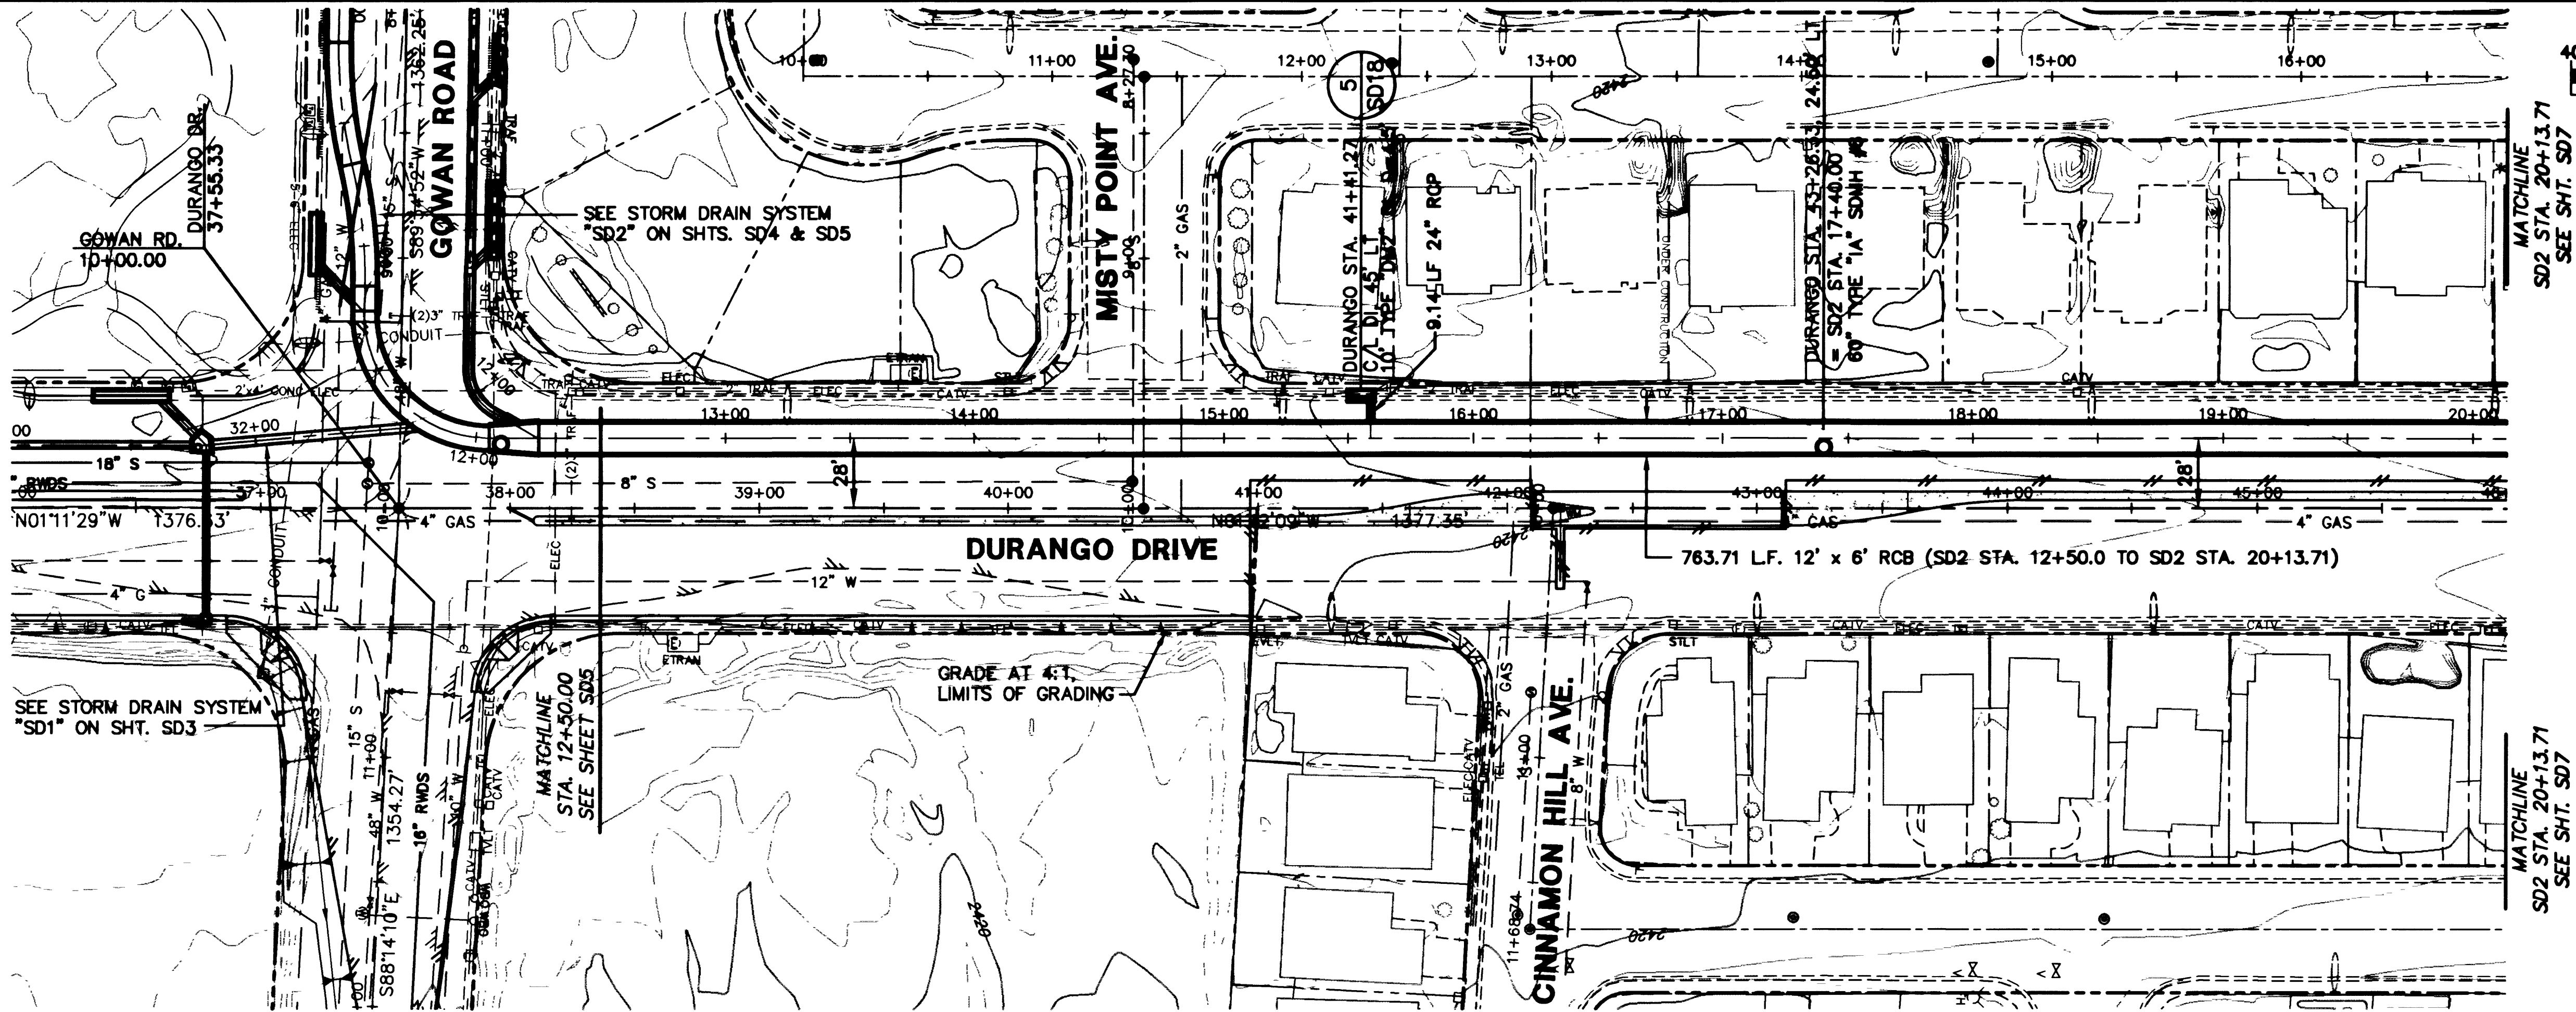

- NOTES:
1. ALL RCP IS TO BE CLASS III.
 2. ALL MH SHOWN ON THIS SHEET TO HAVE 30" RING & COVER
 3. ALL RCB SHALL BE PRECAST RCB.
 4. INSTALL MH STEPS PER STD. DWG. #410 AT MH RISER AND RCB.

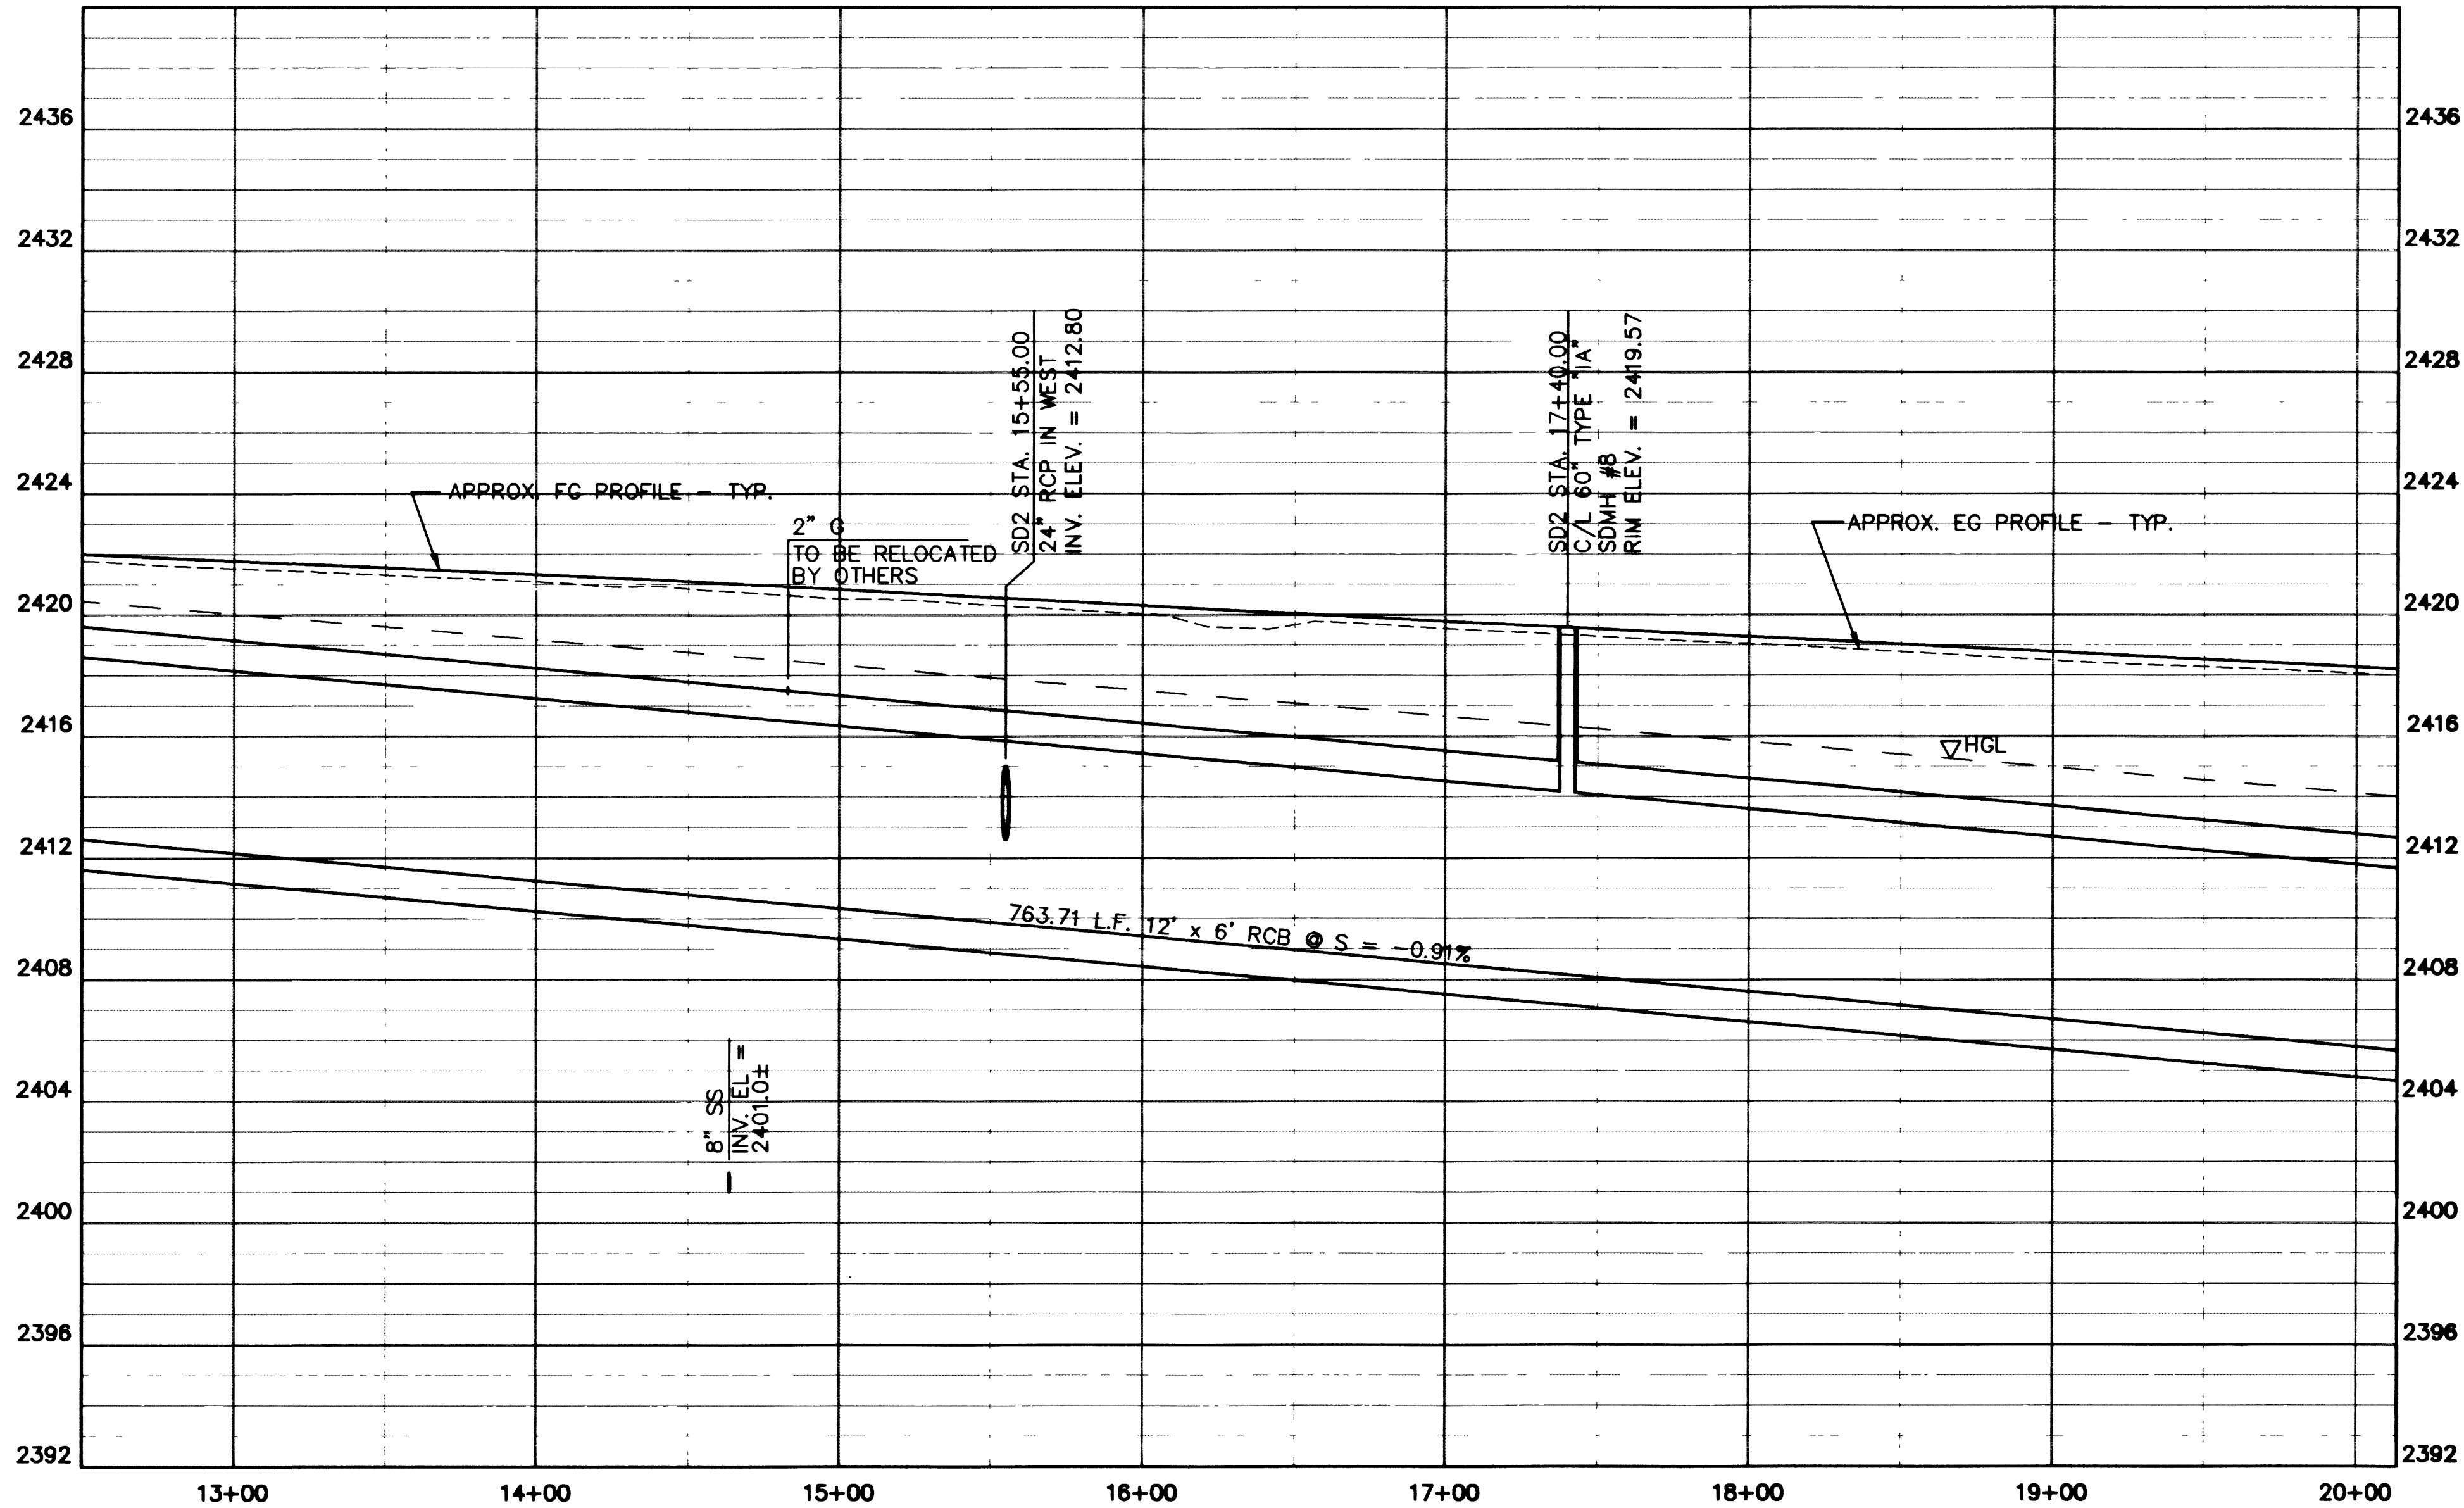

STORM DRAIN PLAN AND PROFILE
 SD2 STA. 12+50.00 TO 20+13.71
 DURANGO DRIVE
 CHEYENNE AVENUE TO LONE MOUNTAIN ROAD

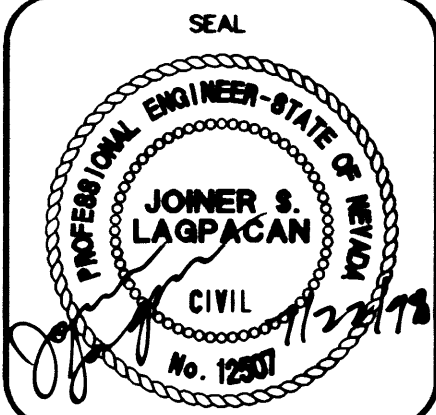

NO. NO. 5249
 BY J.L.M.W.B.M.
 DATE 07/17/98
 SCALE HORIZ. 1"=40'
 VERT. 1"=4'
 DRAWING SD6
 SHEET 57 OF 106
 SHEETS

DEPARTMENT OF PUBLIC WORKS
 CITY OF LAS VEGAS, NEVADA



CONSULTING ENGINEERS • PLANNERS • LAND SURVEYORS
 2727 SOUTH RAINBOW BOULEVARD
 LAS VEGAS, NEVADA 89102-5148 PHONE (702) 873-7550 FAX (702) 362-2597