

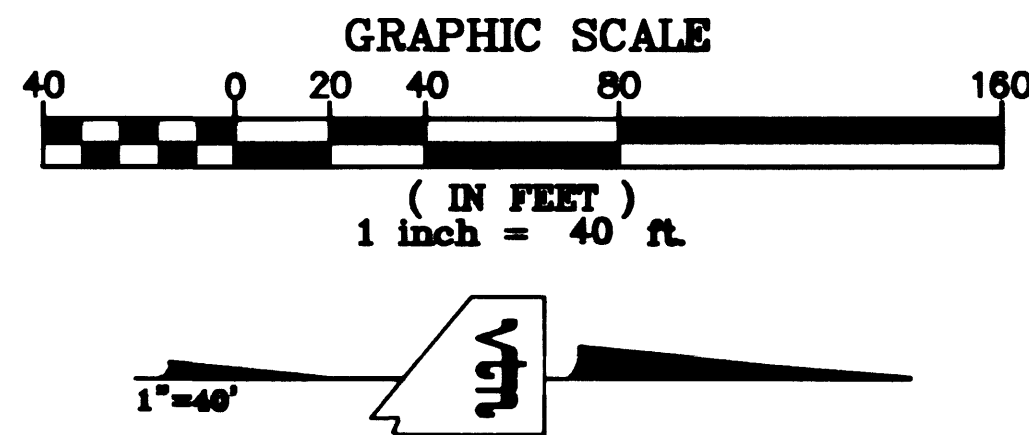
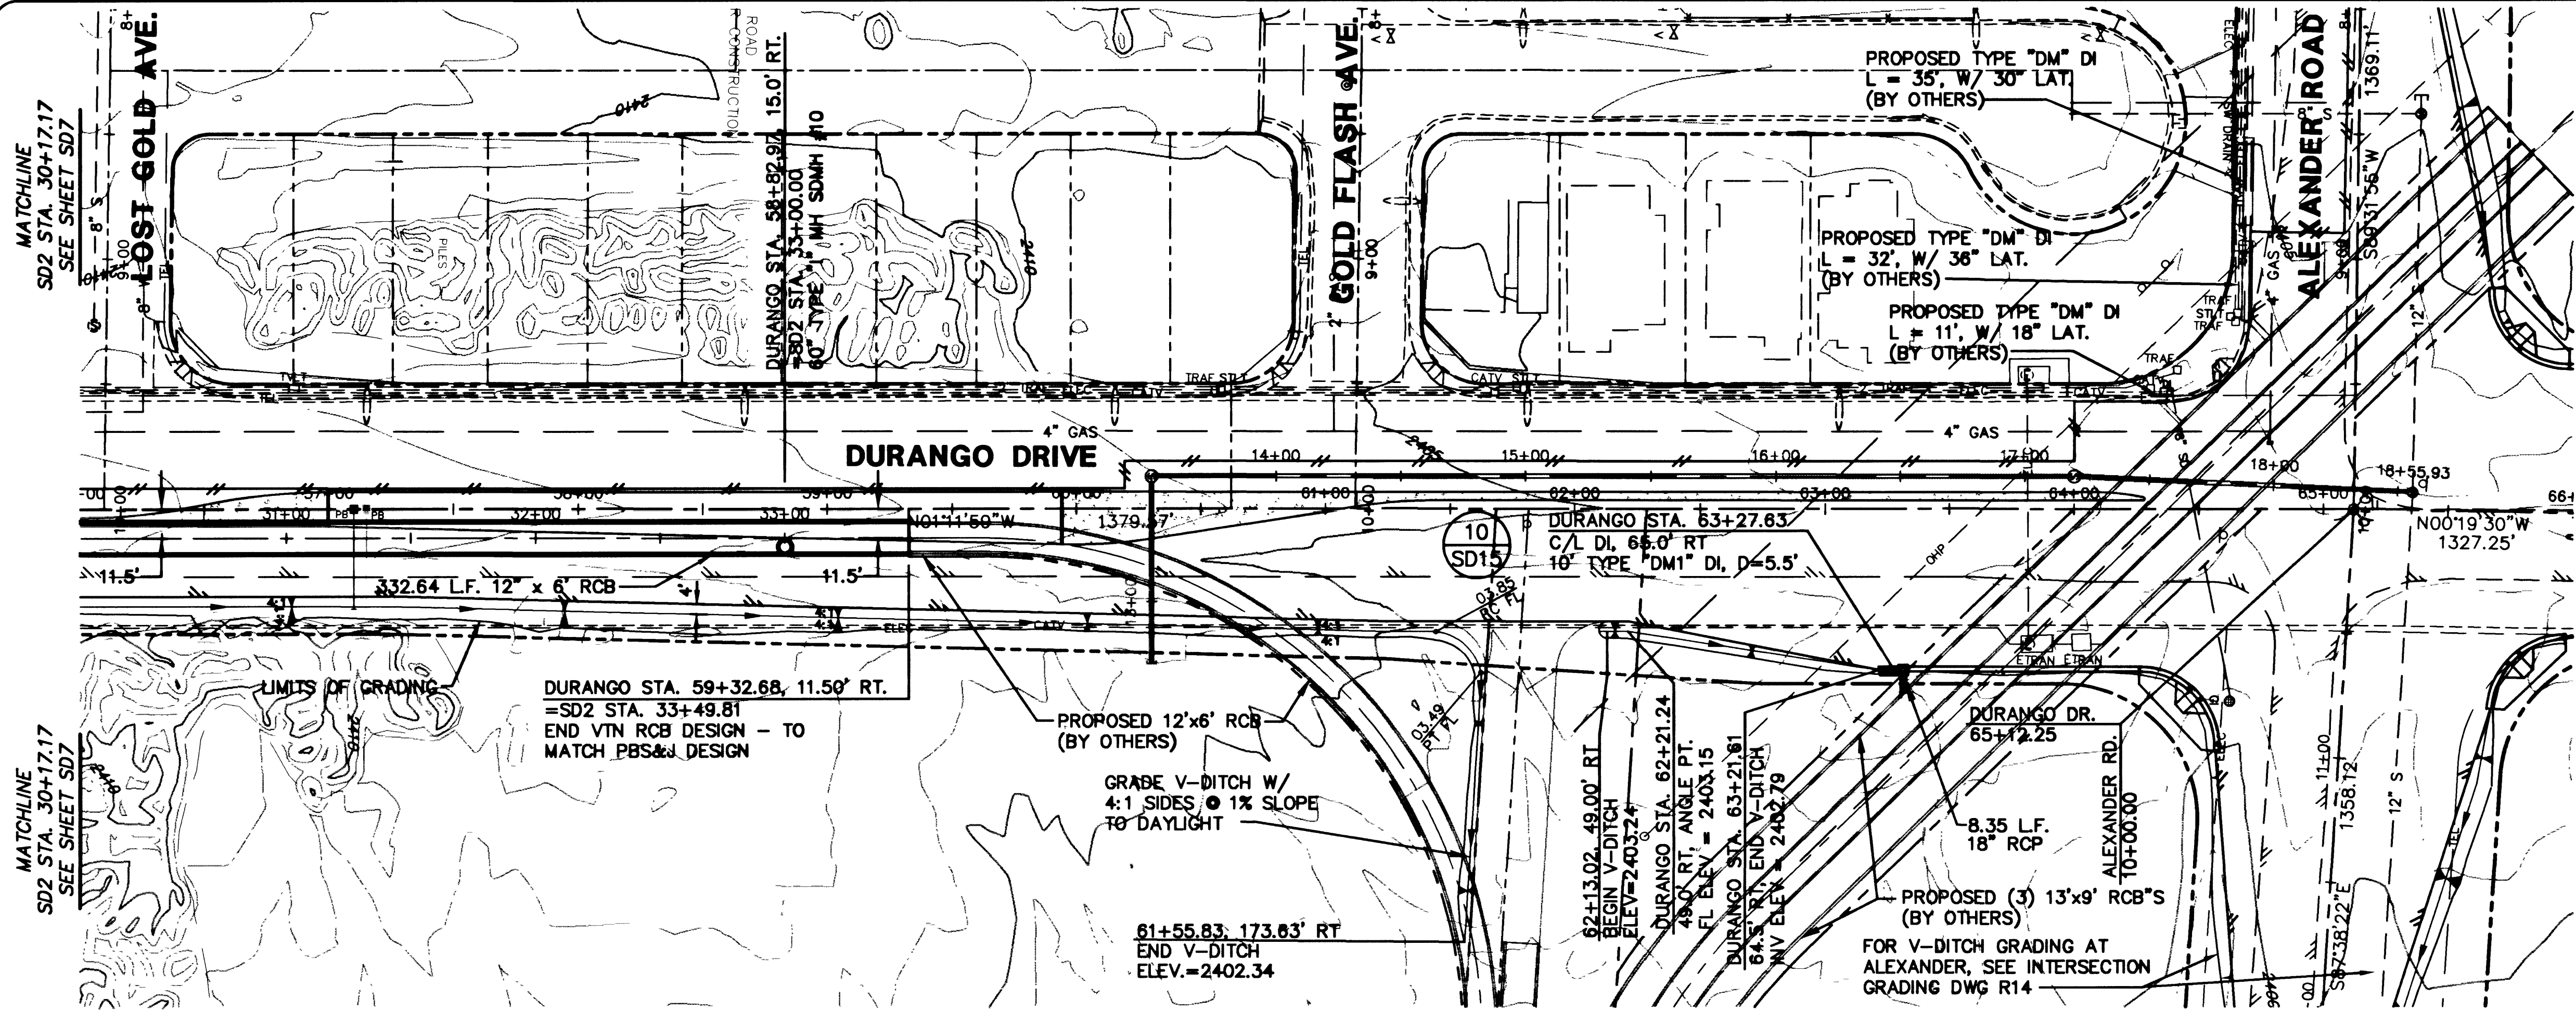


NEWS: MS = "T", PS = "PLT"
P:\CADD\DWG\13249\13249-SD.DWG

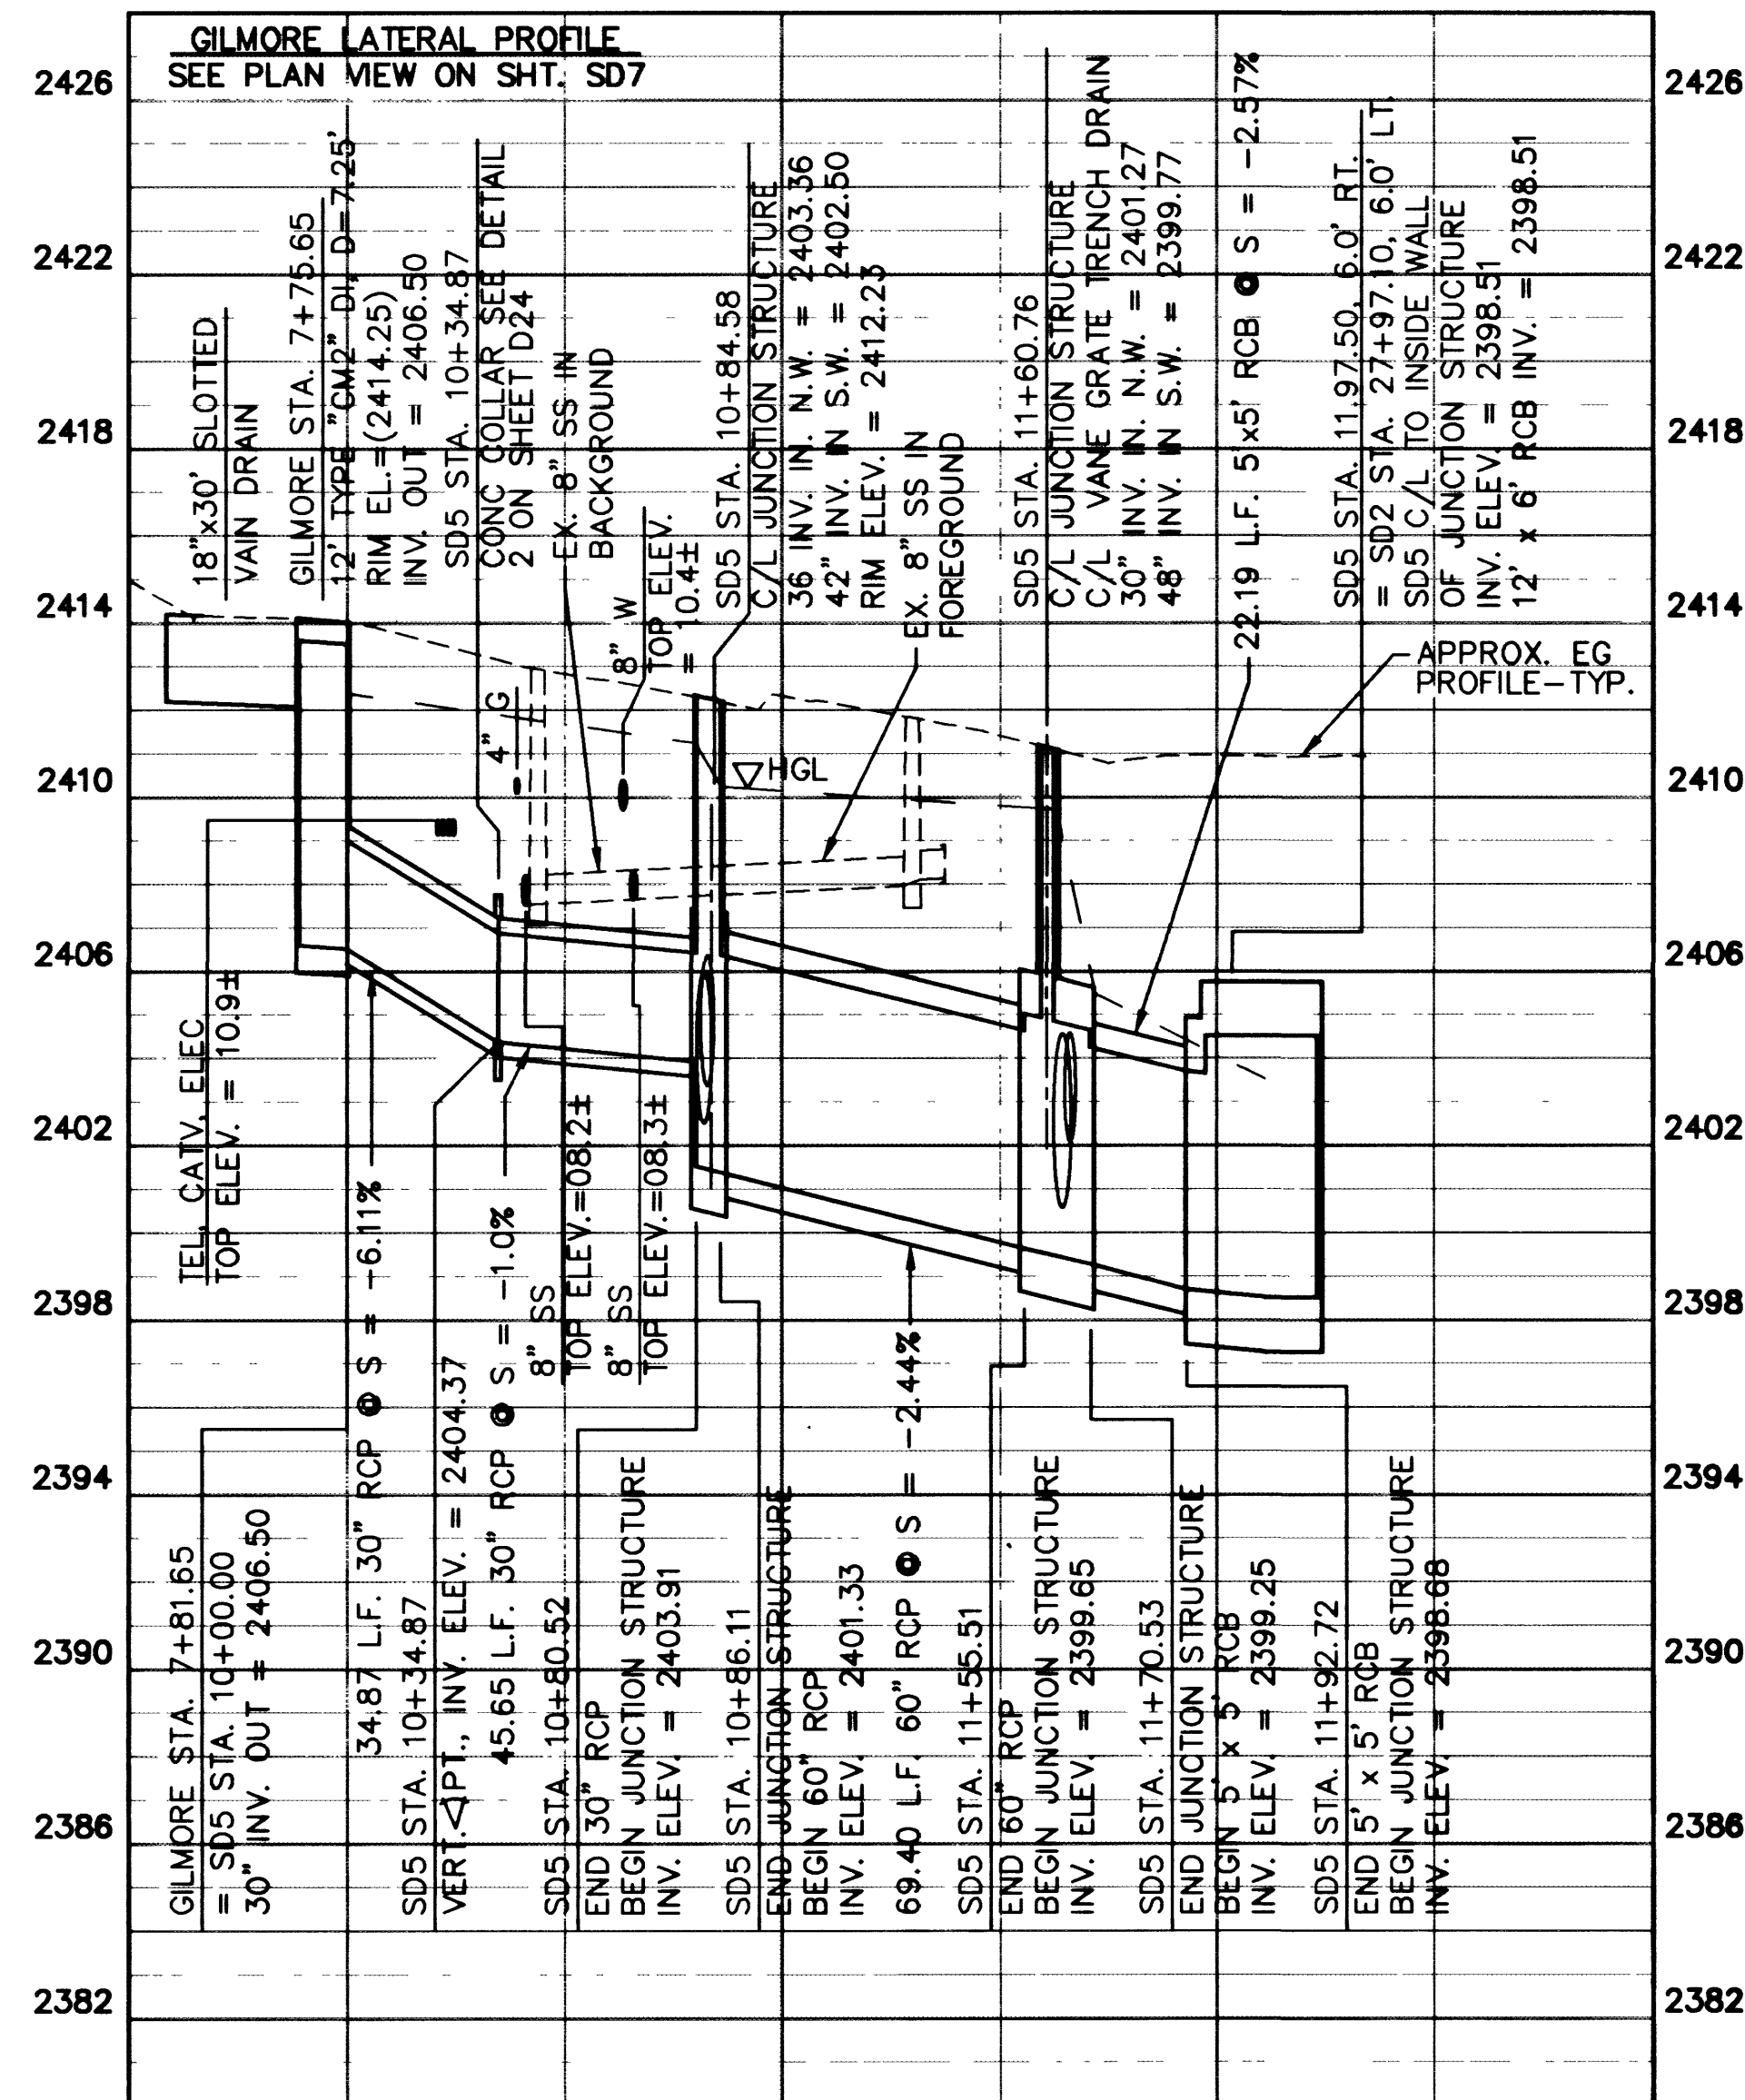

- NOTES:
1. ALL RCP IS TO BE CLASS III.
 2. ALL MH SHOWN ON THIS SHEET TO HAVE 30" RING & COVER
 3. ALL RCB SHALL BE PRECAST RCB.
 4. INSTALL MH STEPS PER STD. DWG. #410 AT MH RISER AND RCB.

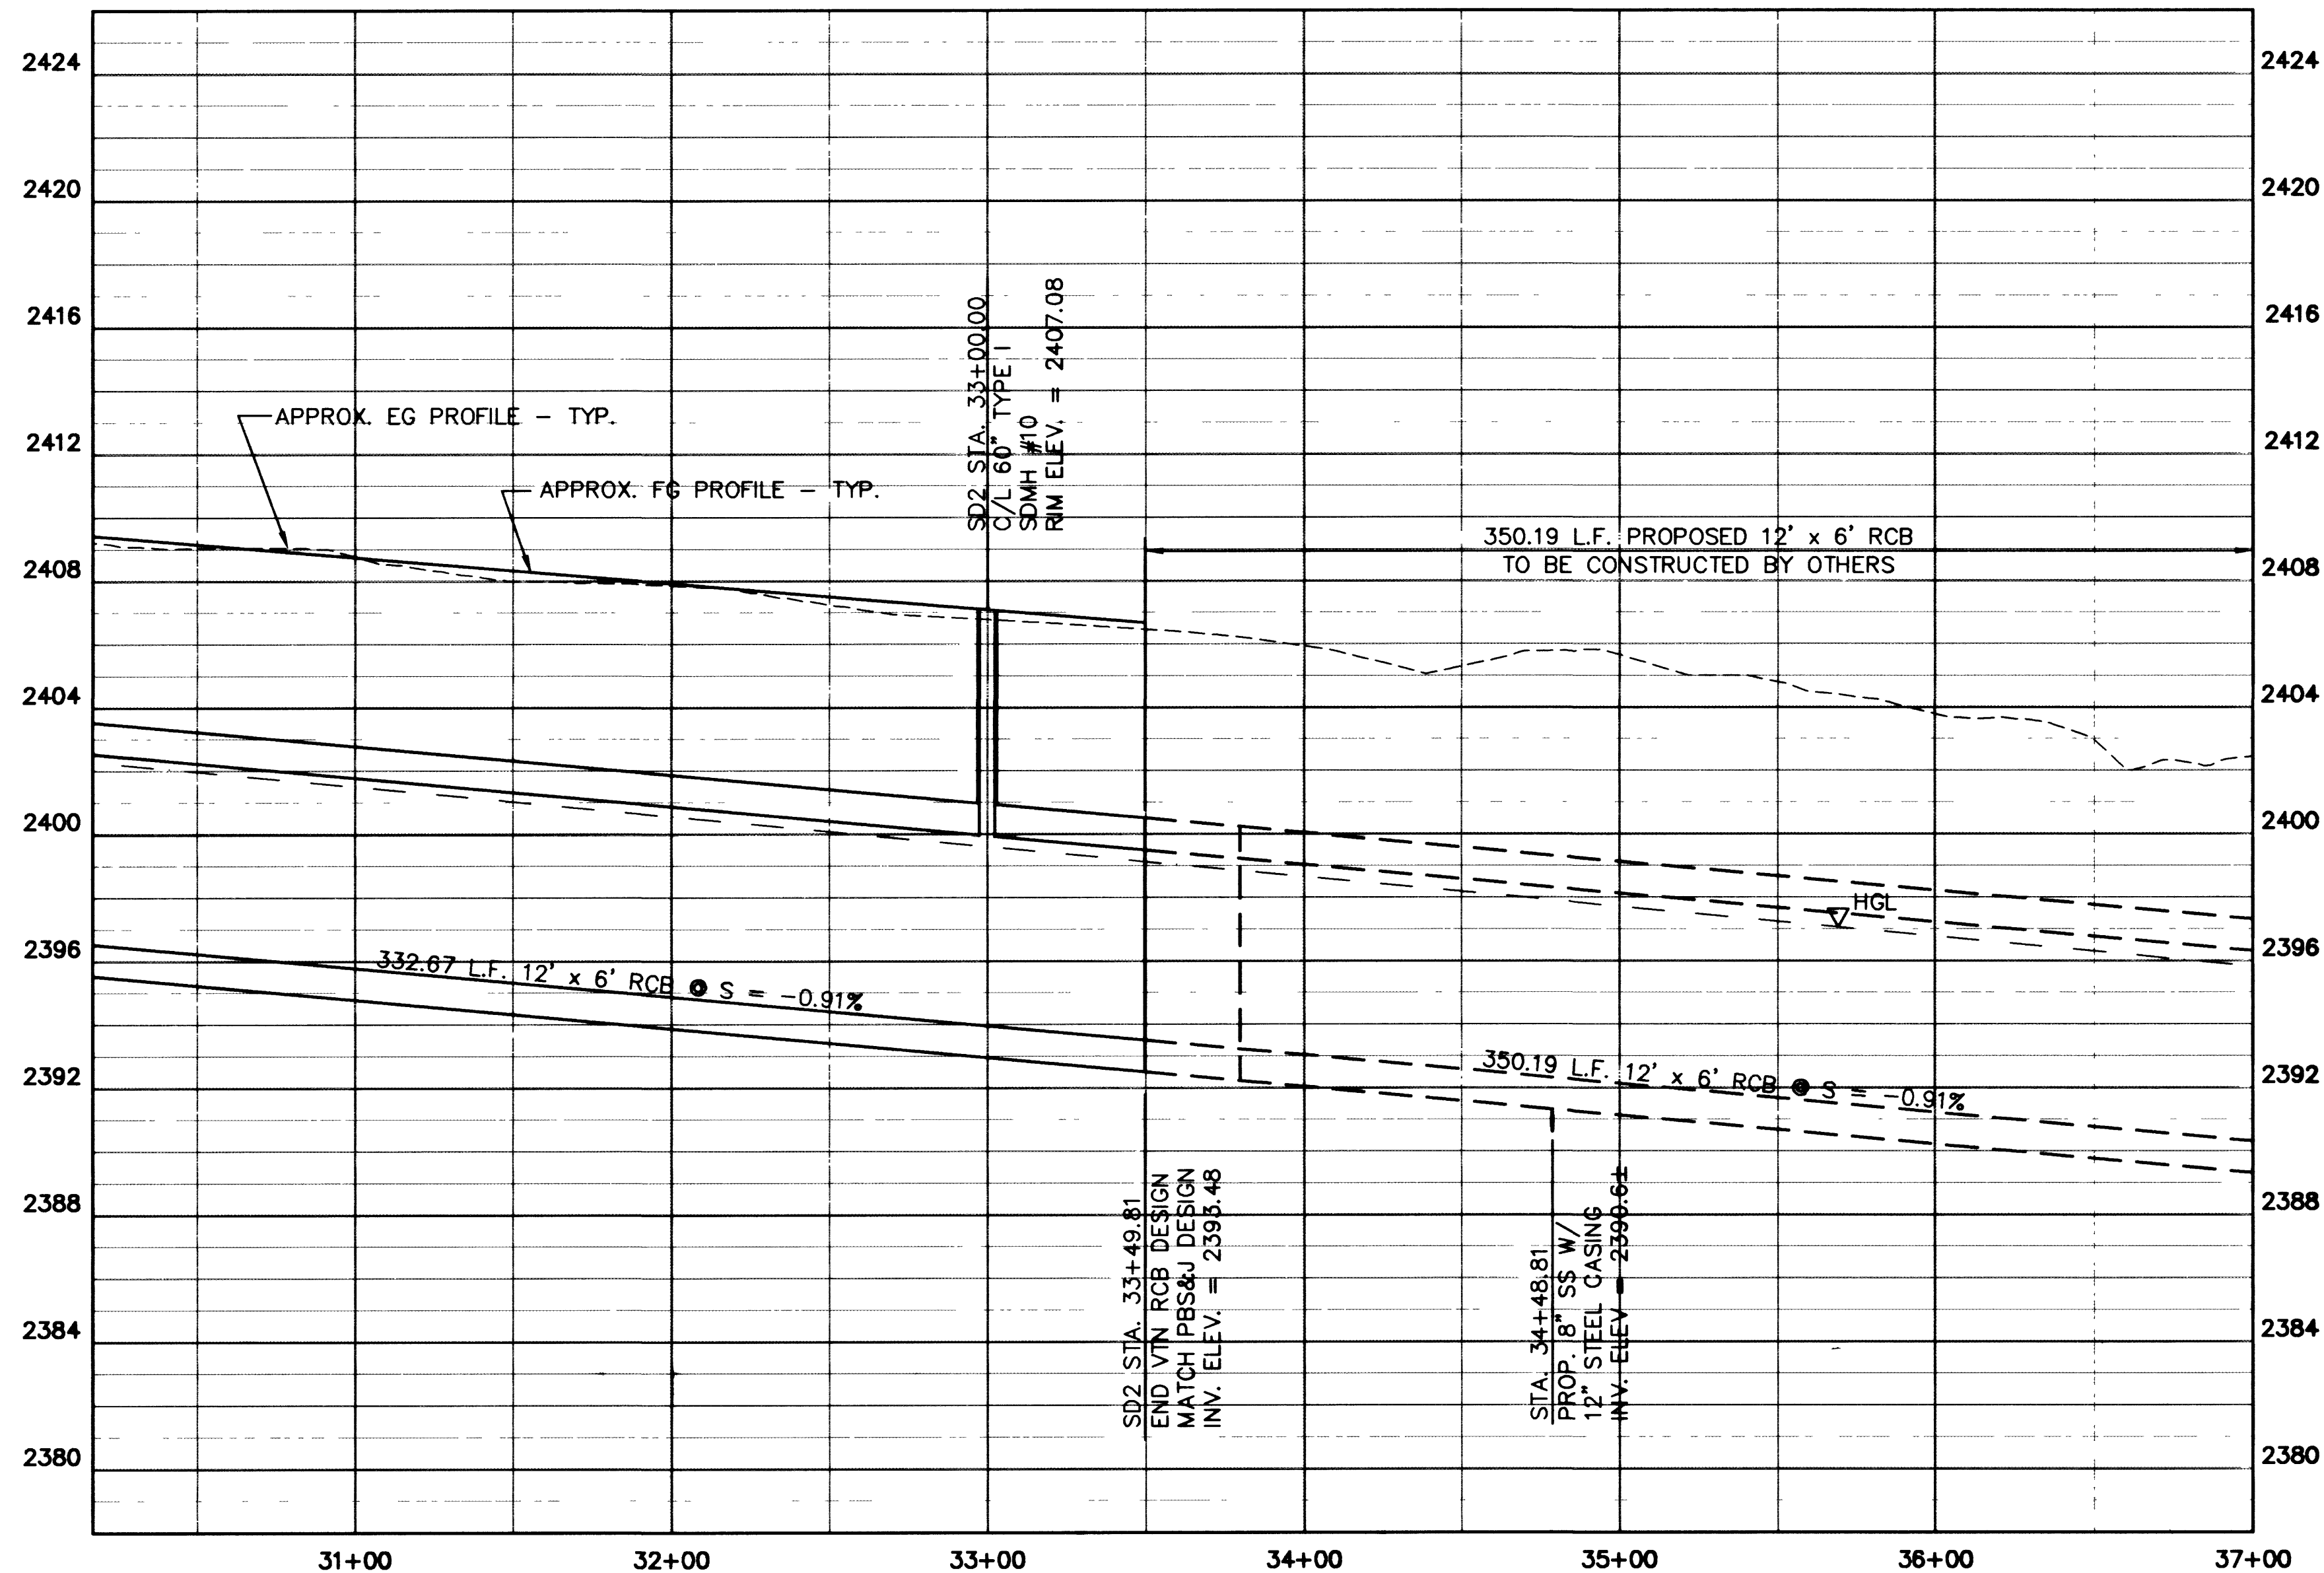

STORM DRAIN PLAN AND PROFILE
SD2 STA. 30+17.14 TO STA. 37+00.00
DURANGO DRIVE
CHEYENNE AVENUE TO LONE MOUNTAIN ROAD

NO. NO.	5249
BY	JL, LMW, WBM
DATE	07/17/98
SCALE	HORIZ. 1"=40' VERT. 1"=4'
DRAWING	SD8
SHEET	59
OF	106
SHEETS	

DEPARTMENT OF PUBLIC WORKS CITY OF LAS VEGAS, NEVADA	CONSULTING ENGINEERS • PLANNERS • LAND SURVEYORS 2727 SOUTH RAINBOW BOULEVARD LAS VEGAS, NEVADA 89102-5148 PHONE (702) 873-7550 FAX (702) 362-2597
---	--