

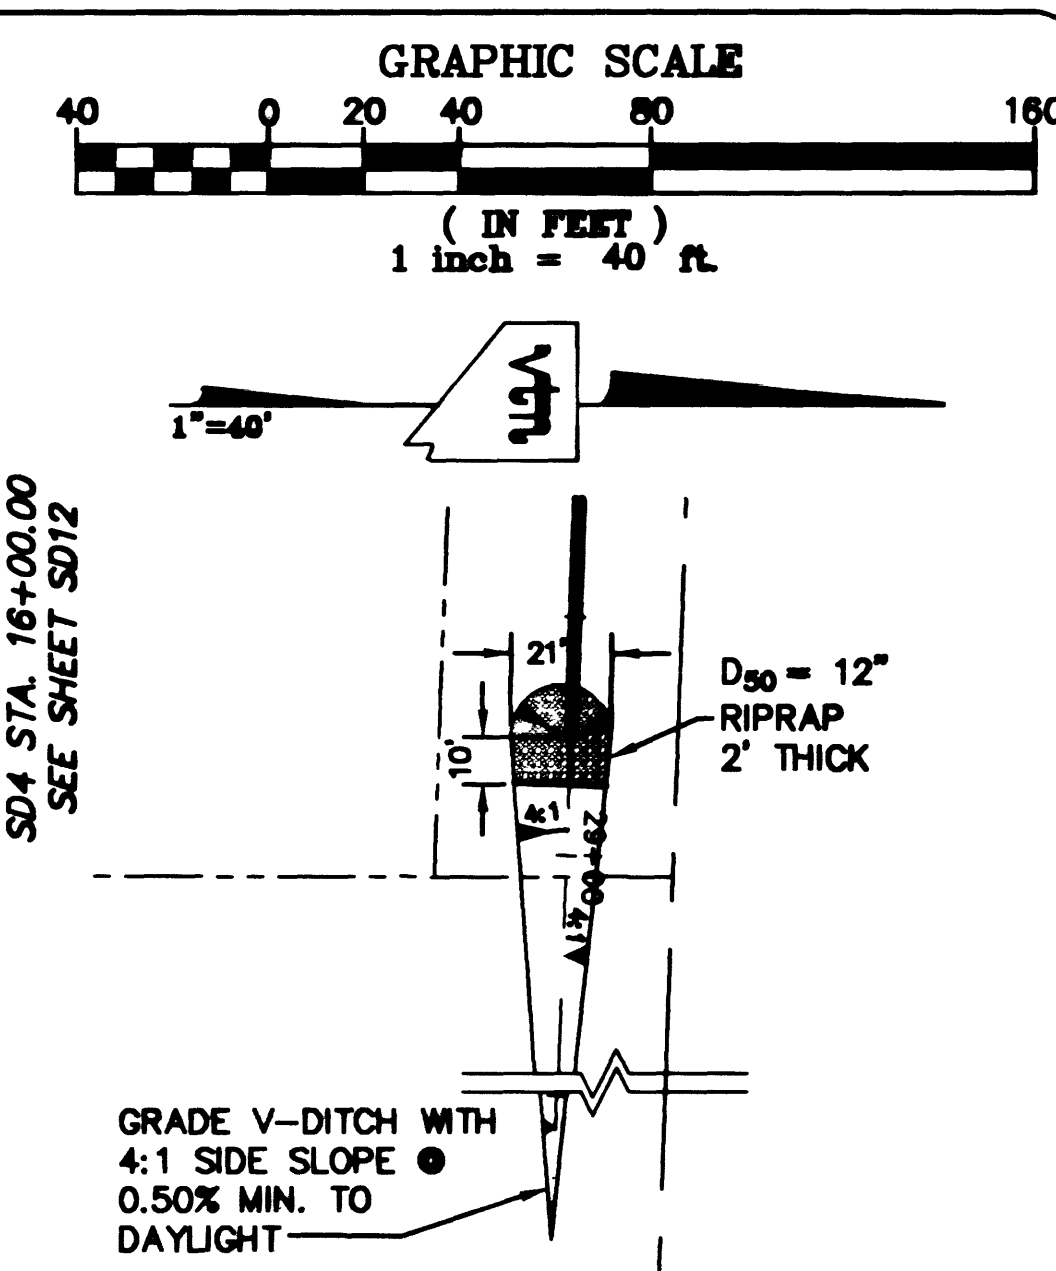


NEWS: MS = "11", PS = "11", PLT = "11"
1: (C:\AD\WORK\5249\5249-SD.DWG)

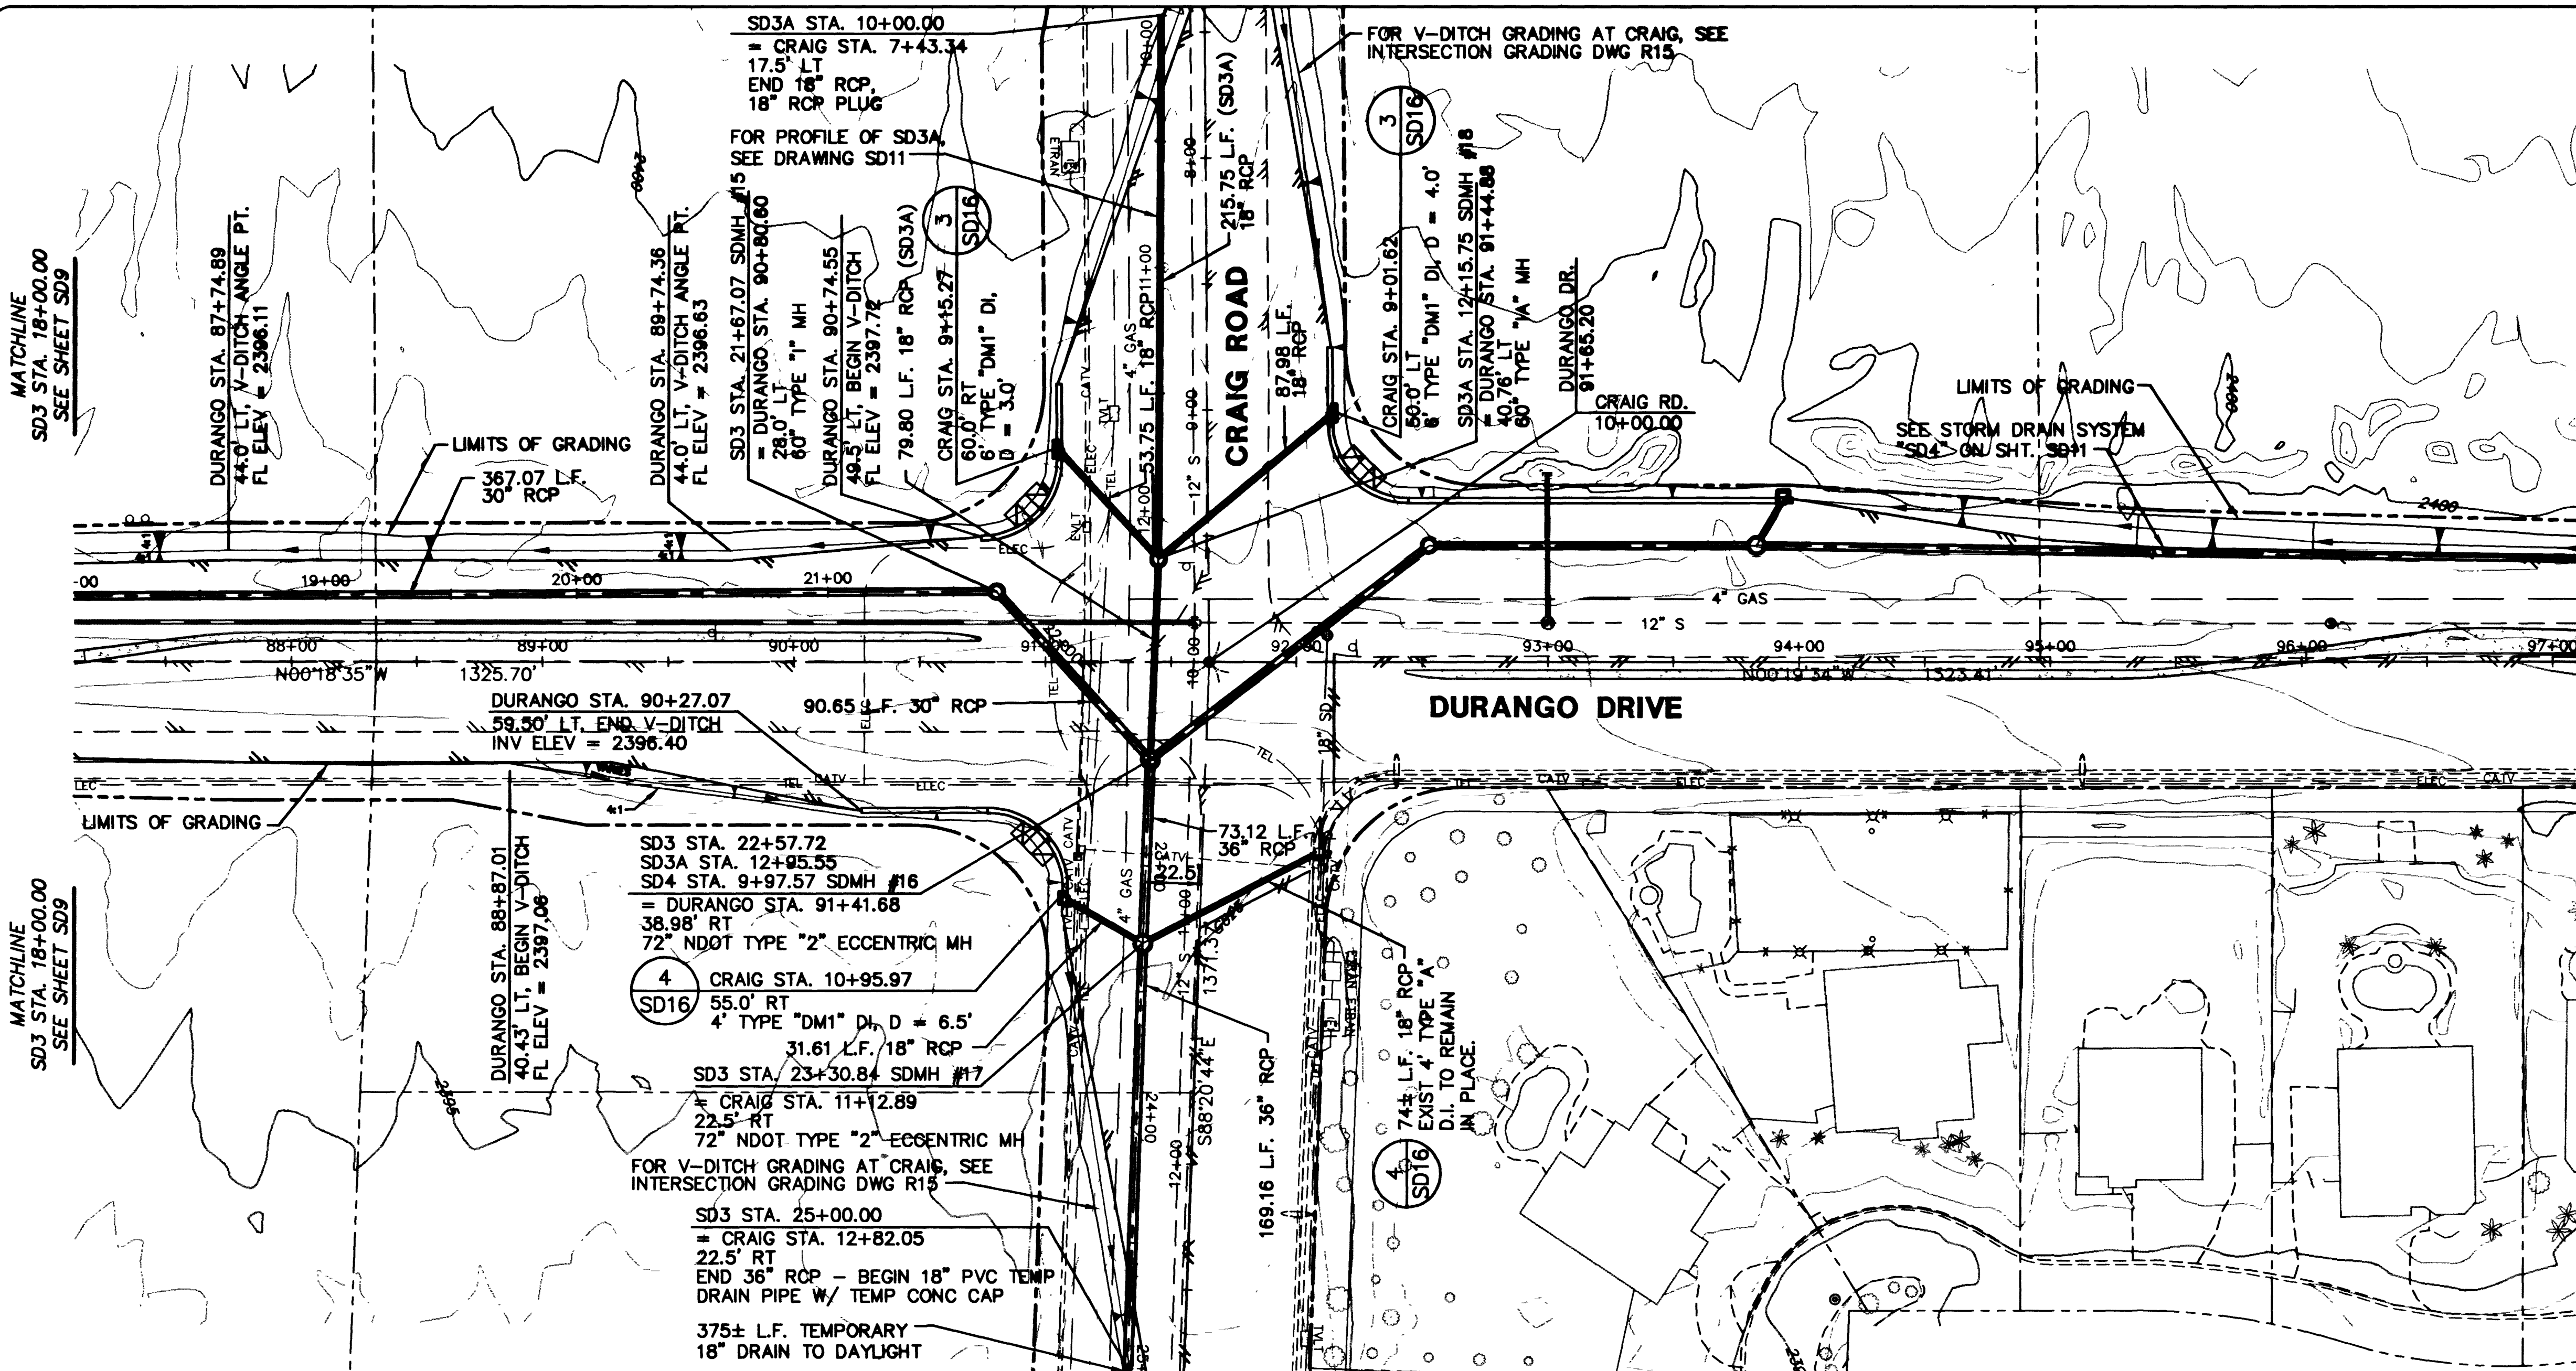

PLAN DAYLIGHT OF 18" TEMP RCP

NOTES:
1. ALL RCP IS TO BE CLASS III.

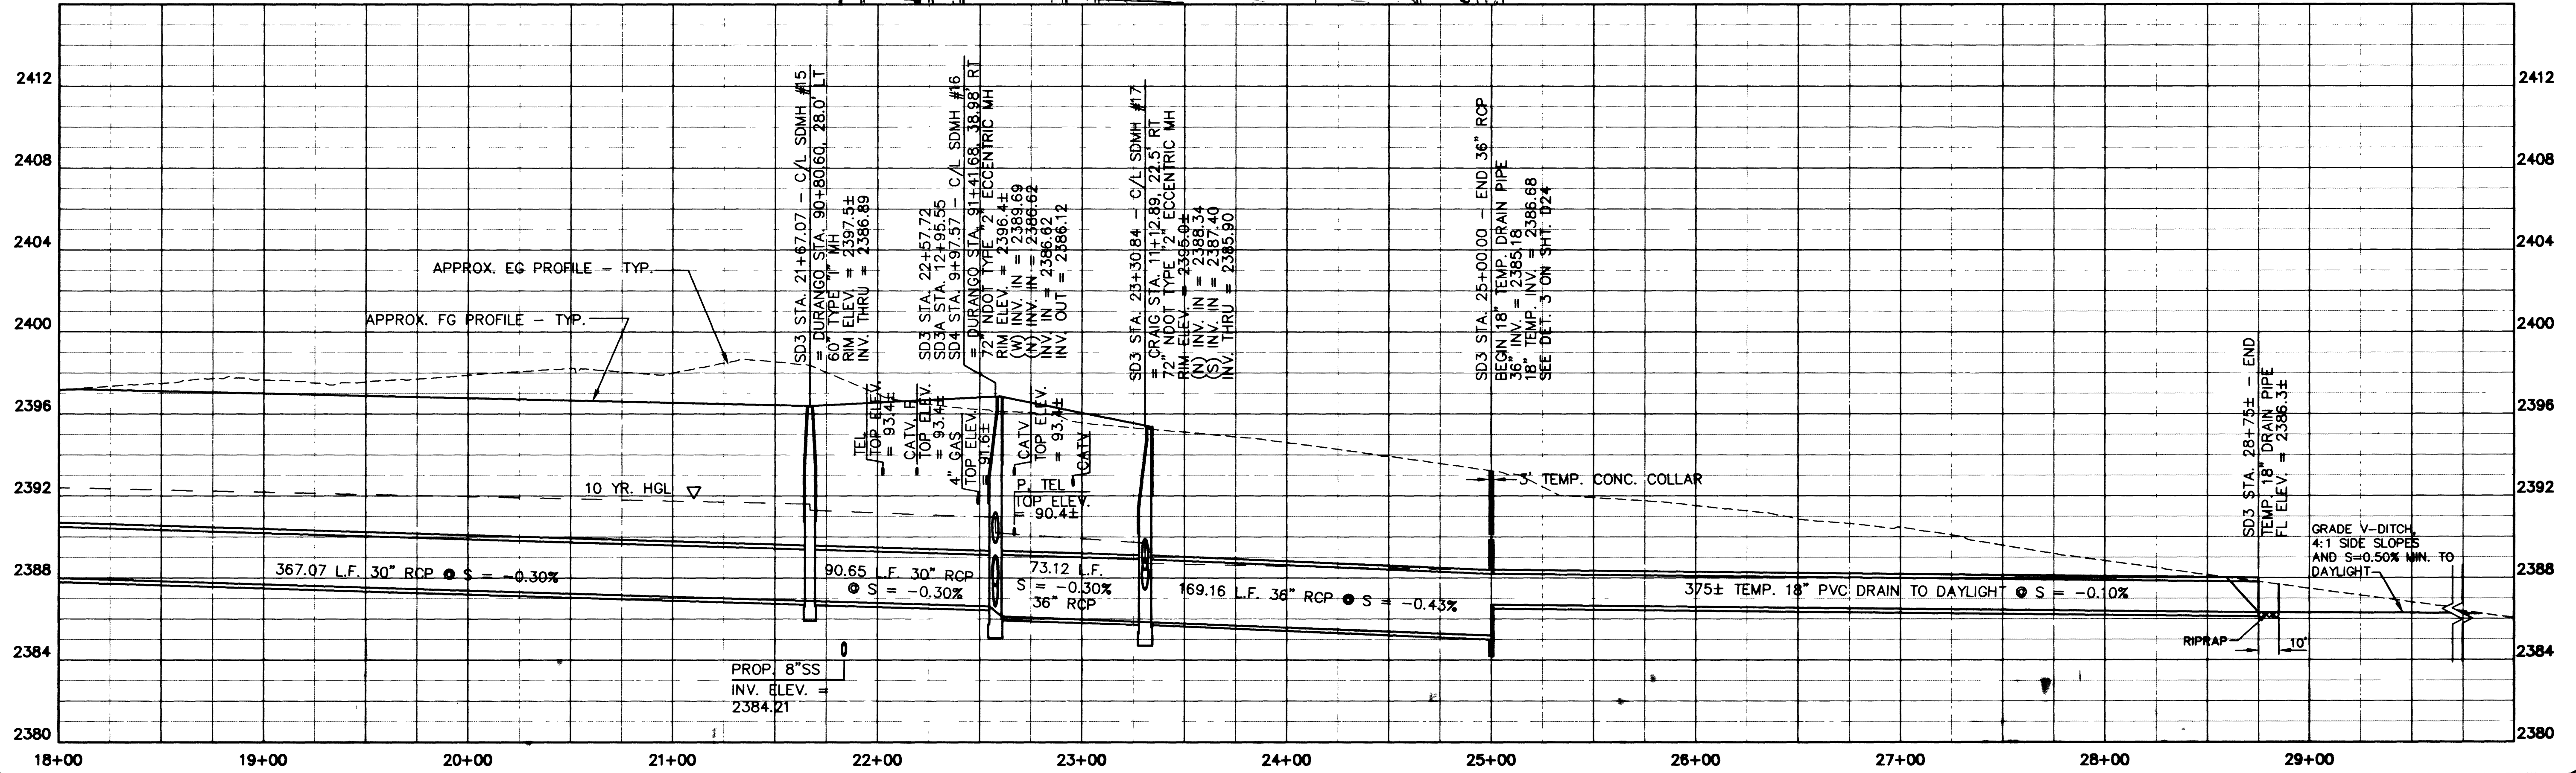

DEPARTMENT OF PUBLIC WORKS		CONSULTING ENGINEERS • PLANNERS • LAND SURVEYORS	
CITY OF LAS VEGAS, NEVADA		2727 SOUTH RAINBOW BOULEVARD LAS VEGAS, NEVADA 89102-5148 PHONE (702) 875-7550 FAX (702) 362-2597	
vtn nevada			

STORM DRAIN PLAN AND PROFILE	
SD3 STA. 18+00 TO TEMP DRAIN	
DURNAGO DRIVE	
PROJECT: DURNAGO DRIVE IMPROVEMENTS	
CHEYENNE AVENUE TO LONE MOUNTAIN ROAD	

SEAL	
JOSEPH S. LAGPACAN	
CIVIL	
No. 12301	

NO. NO.	5249
BY	JL/LMW/DJB
DATE	07/17/98
SCALE	HORIZ. 1"=40' VERT. 1"=4'
DRAWING	SHEET
SD10	61
106 SHEETS	