

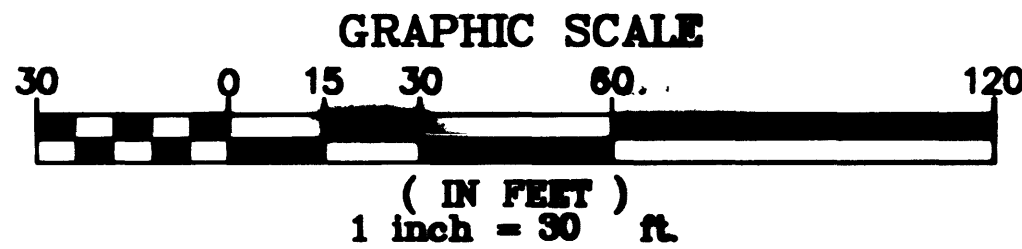


NEWS: MS = "C", PS = "PLT"
I:\CAD\DWG\5249-INT.DWG

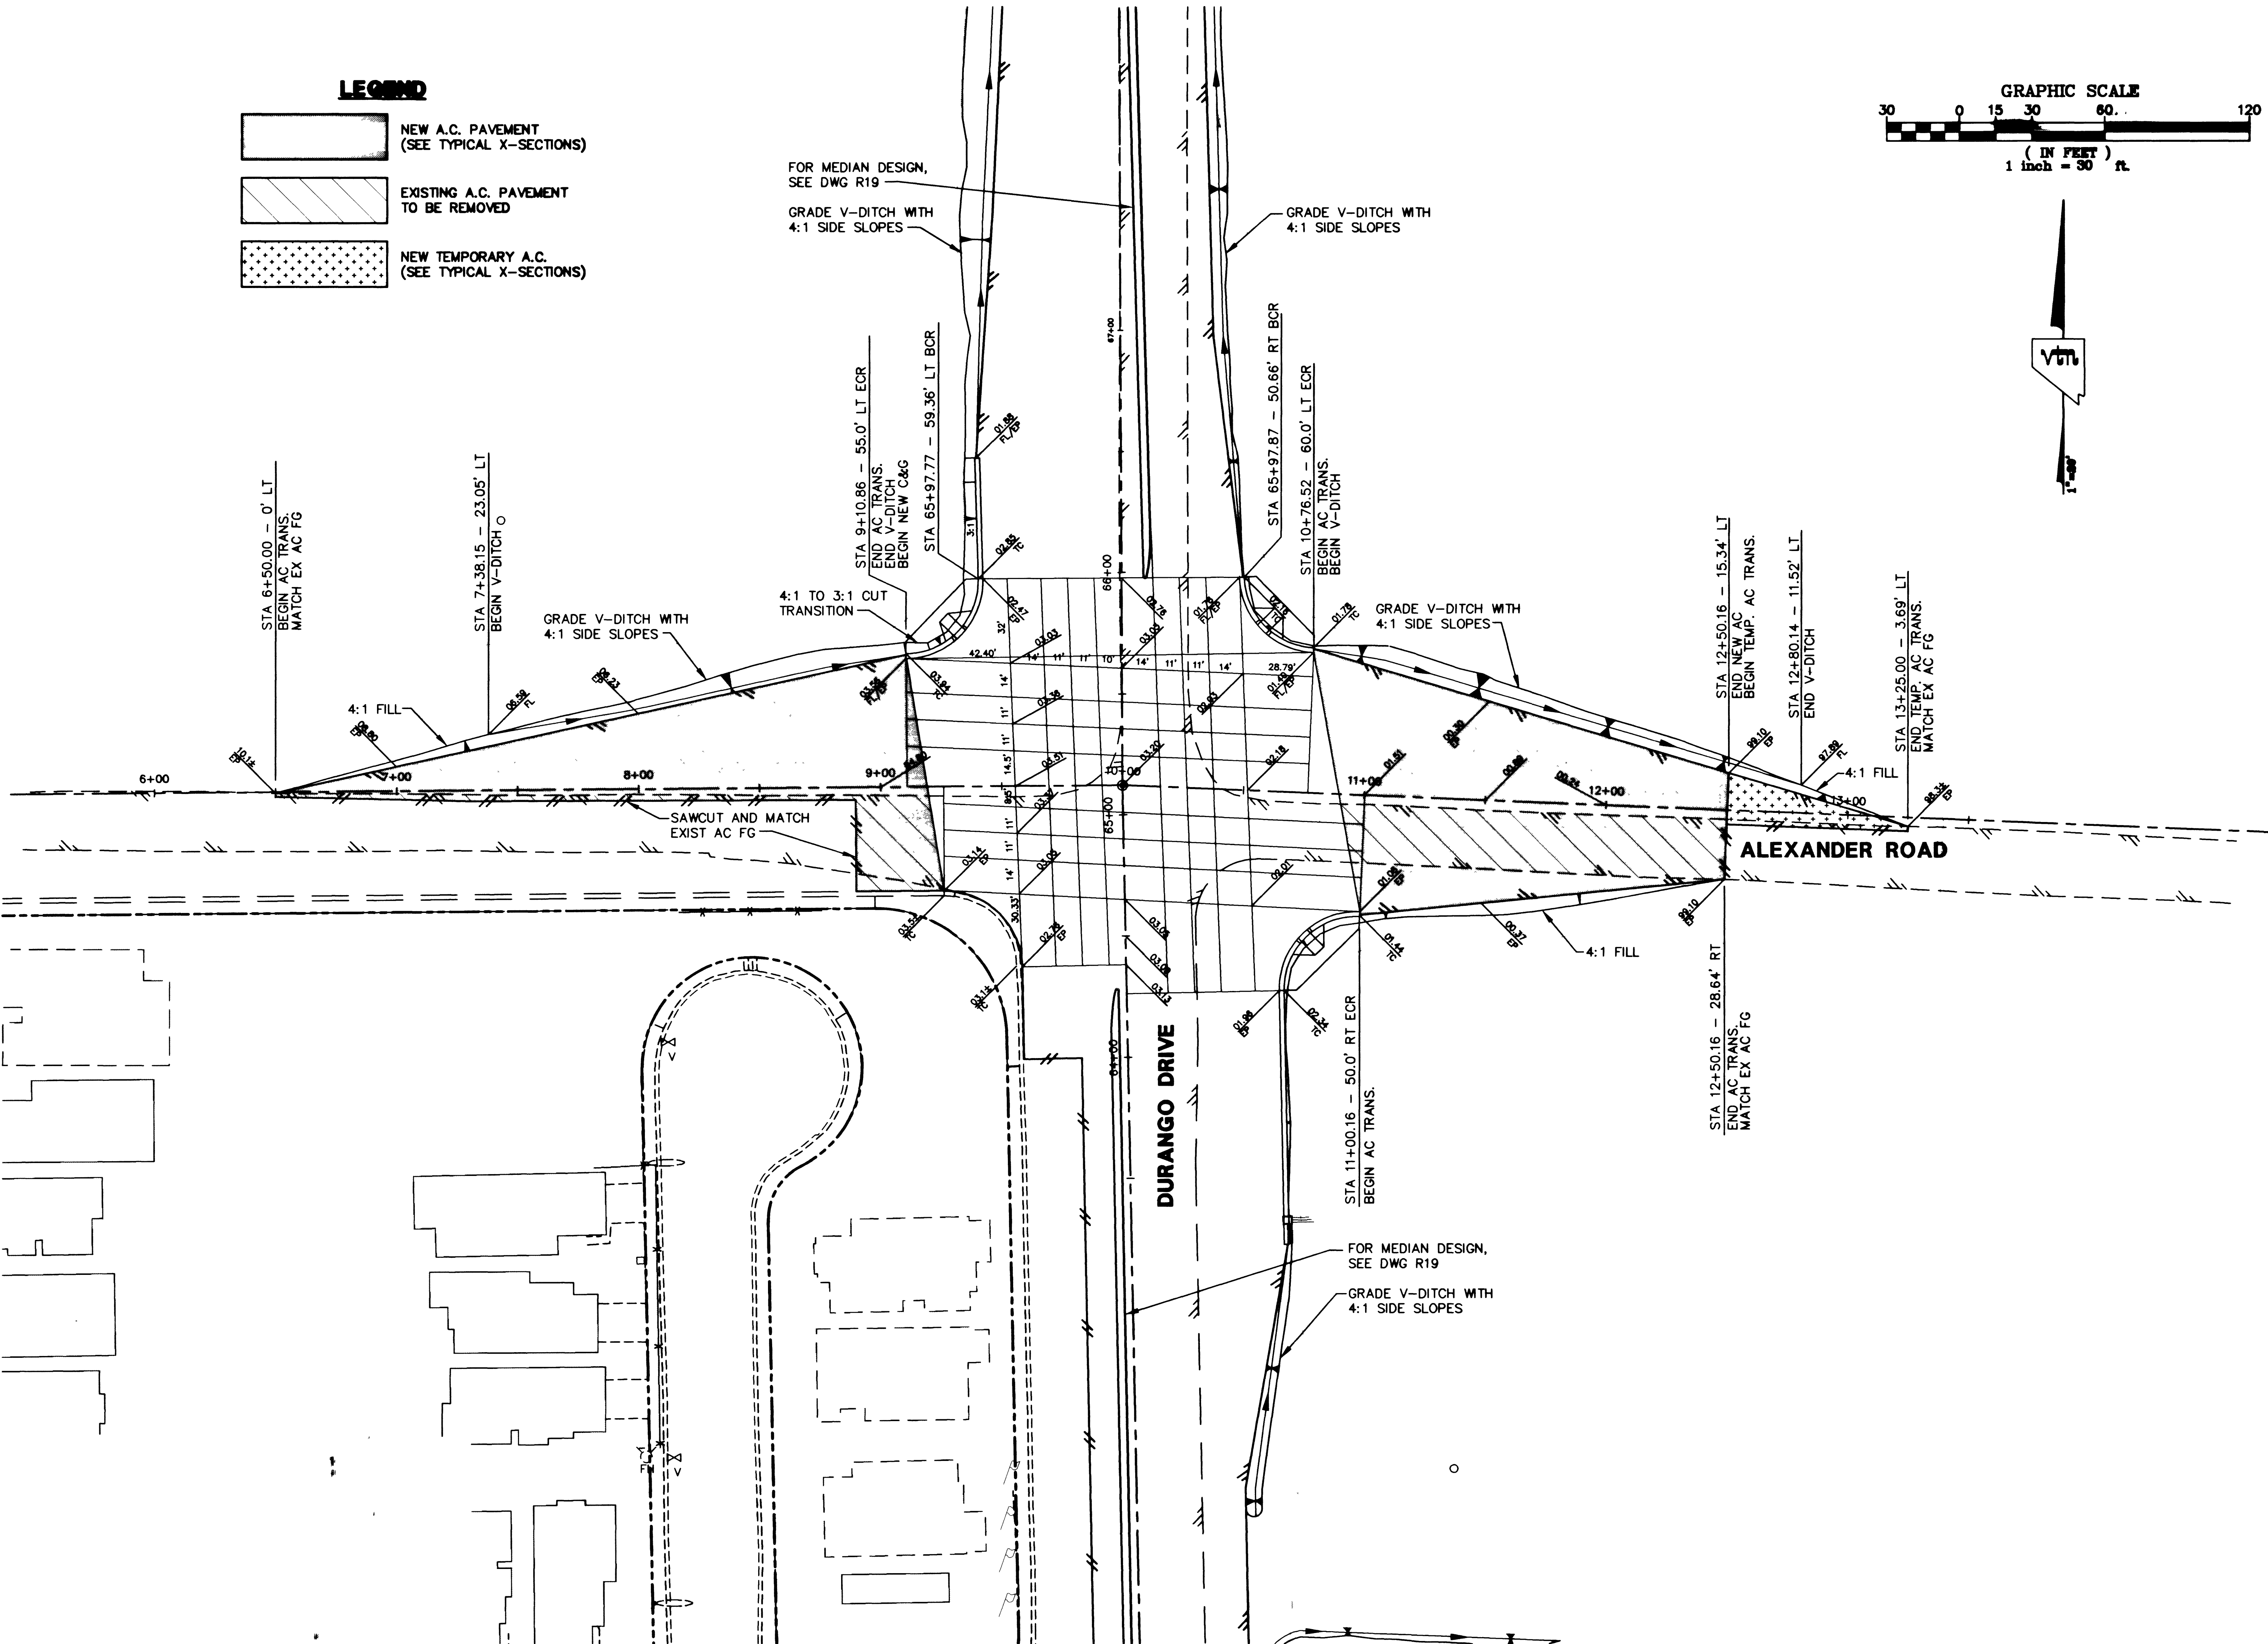


TITLE INTERSECTION GRADING PLAN
ALEXANDER ROAD / DURANGO DR

PROJECT DURANGO DRIVE IMPROVEMENTS
CHEYENNE AVENUE TO LONE MOUNTAIN ROAD

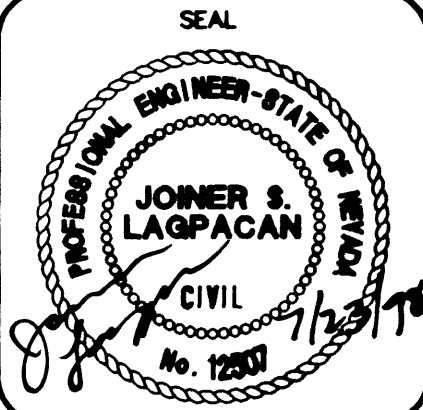

WD. NO.	5249
BY	JL/LMW
DATE	07/17/98
SCALE	HORIZ. 1"=30' VERT. NONE
DRAWING	SHEET 44 OF 106 SHEETS
R14	

DEPARTMENT OF PUBLIC WORKS
CITY OF LAS VEGAS, NEVADA

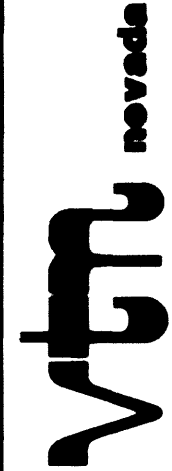

CONSULTING ENGINEERS • PLANNERS • LAND SURVEYORS
2727 SOUTH RAINBOW BOULEVARD
LAS VEGAS, NEVADA 89102-5148 PHONE (702) 873-7550 FAX (702) 362-2597