


MATCHLINE
STA. 116+00.00
SEE ABOVE RIGHT




MATCHLINE
STA. 106+00.00
SEE SHEET T7

MATCHLINE
STA. 106+00.00
SEE SHEET T7

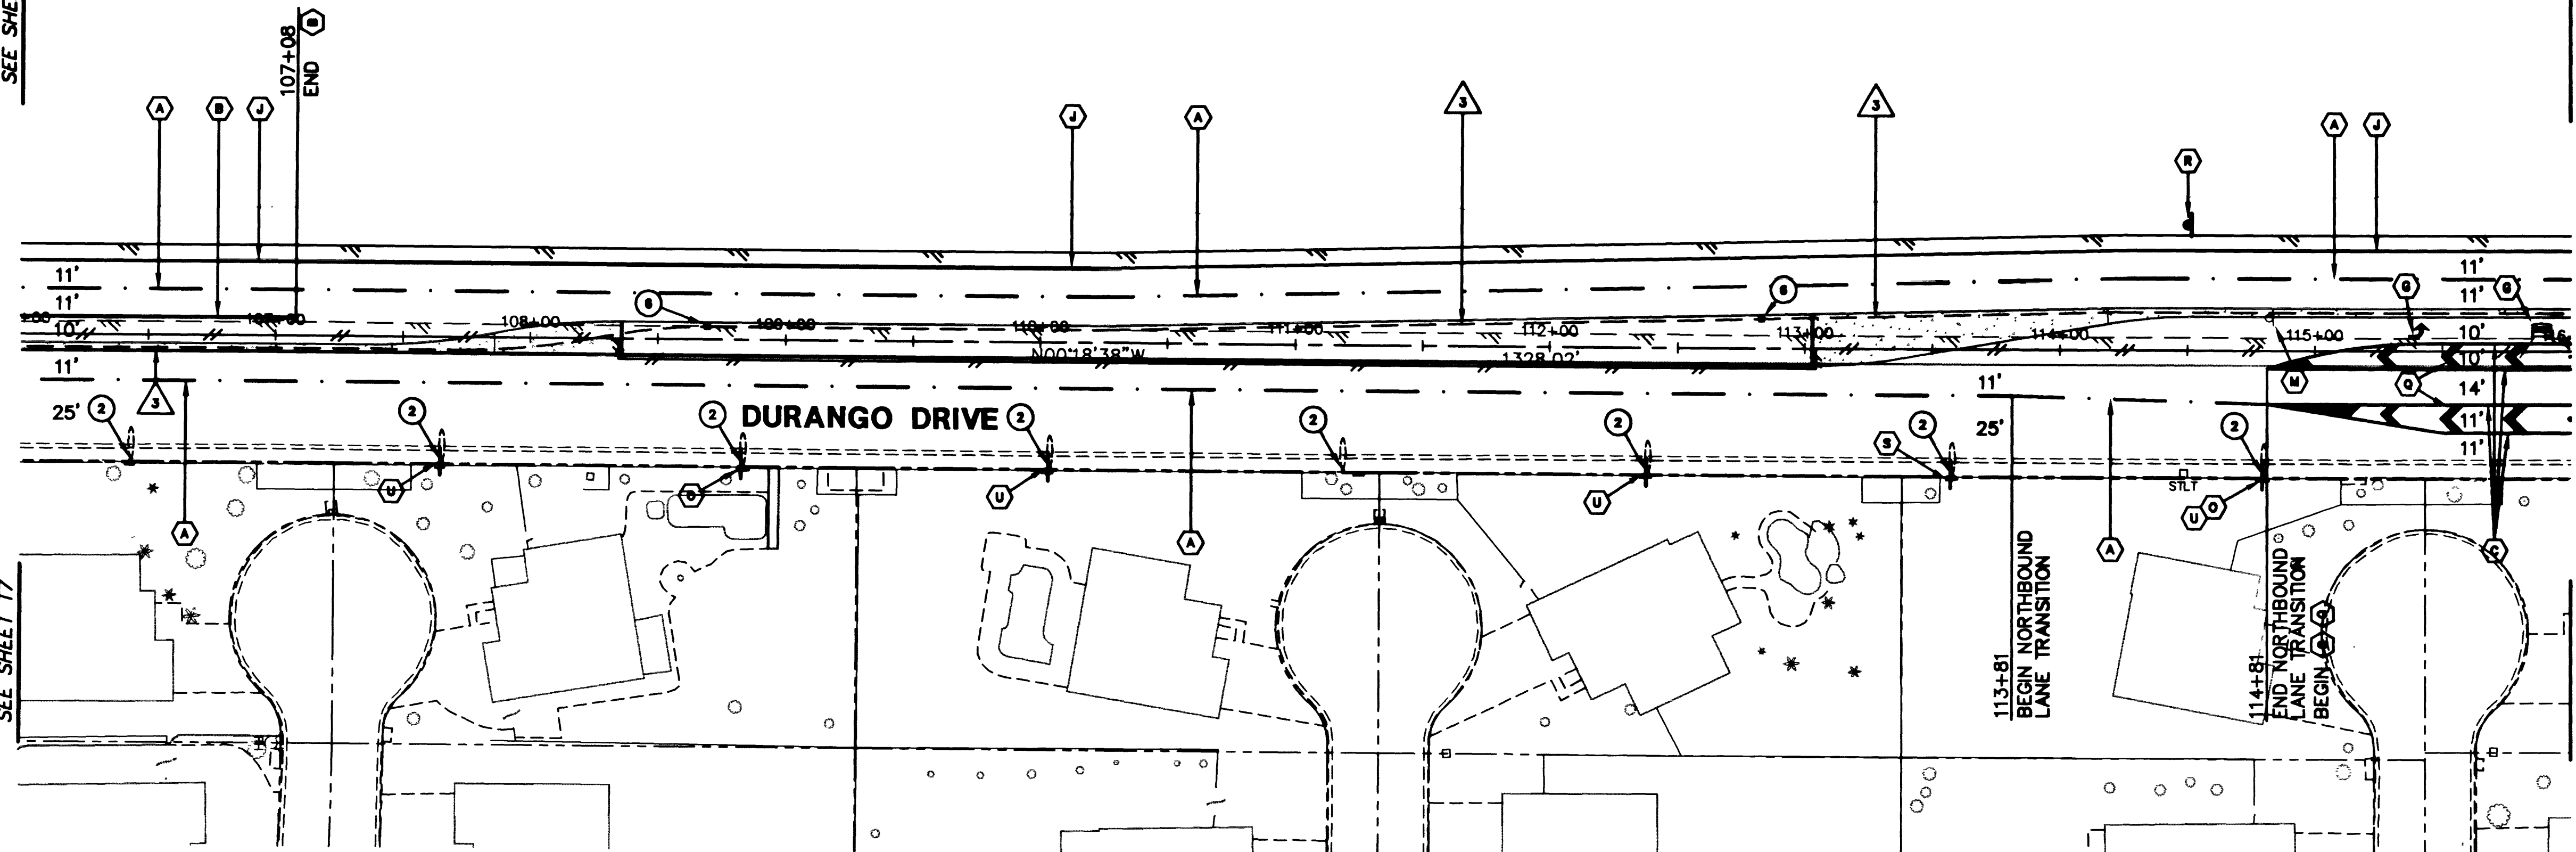

SEE SHEET T15
FOR LONE MOUNTAIN ROAD
TRAFFIC SIGNAL UNDERGROUNDS

SEE SHEET T10 FOR
LONE MOUNTAIN ROAD

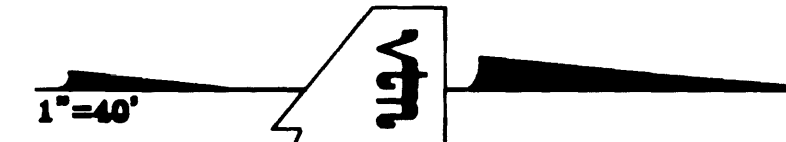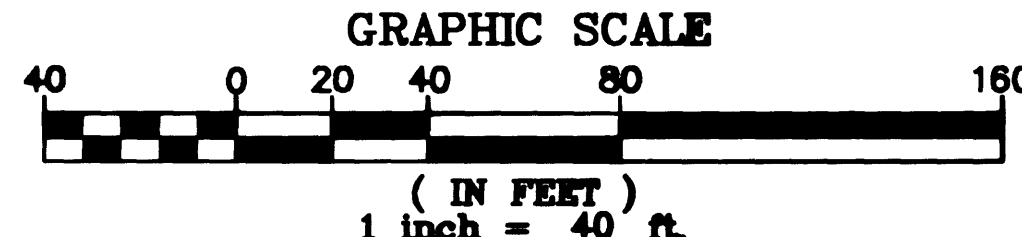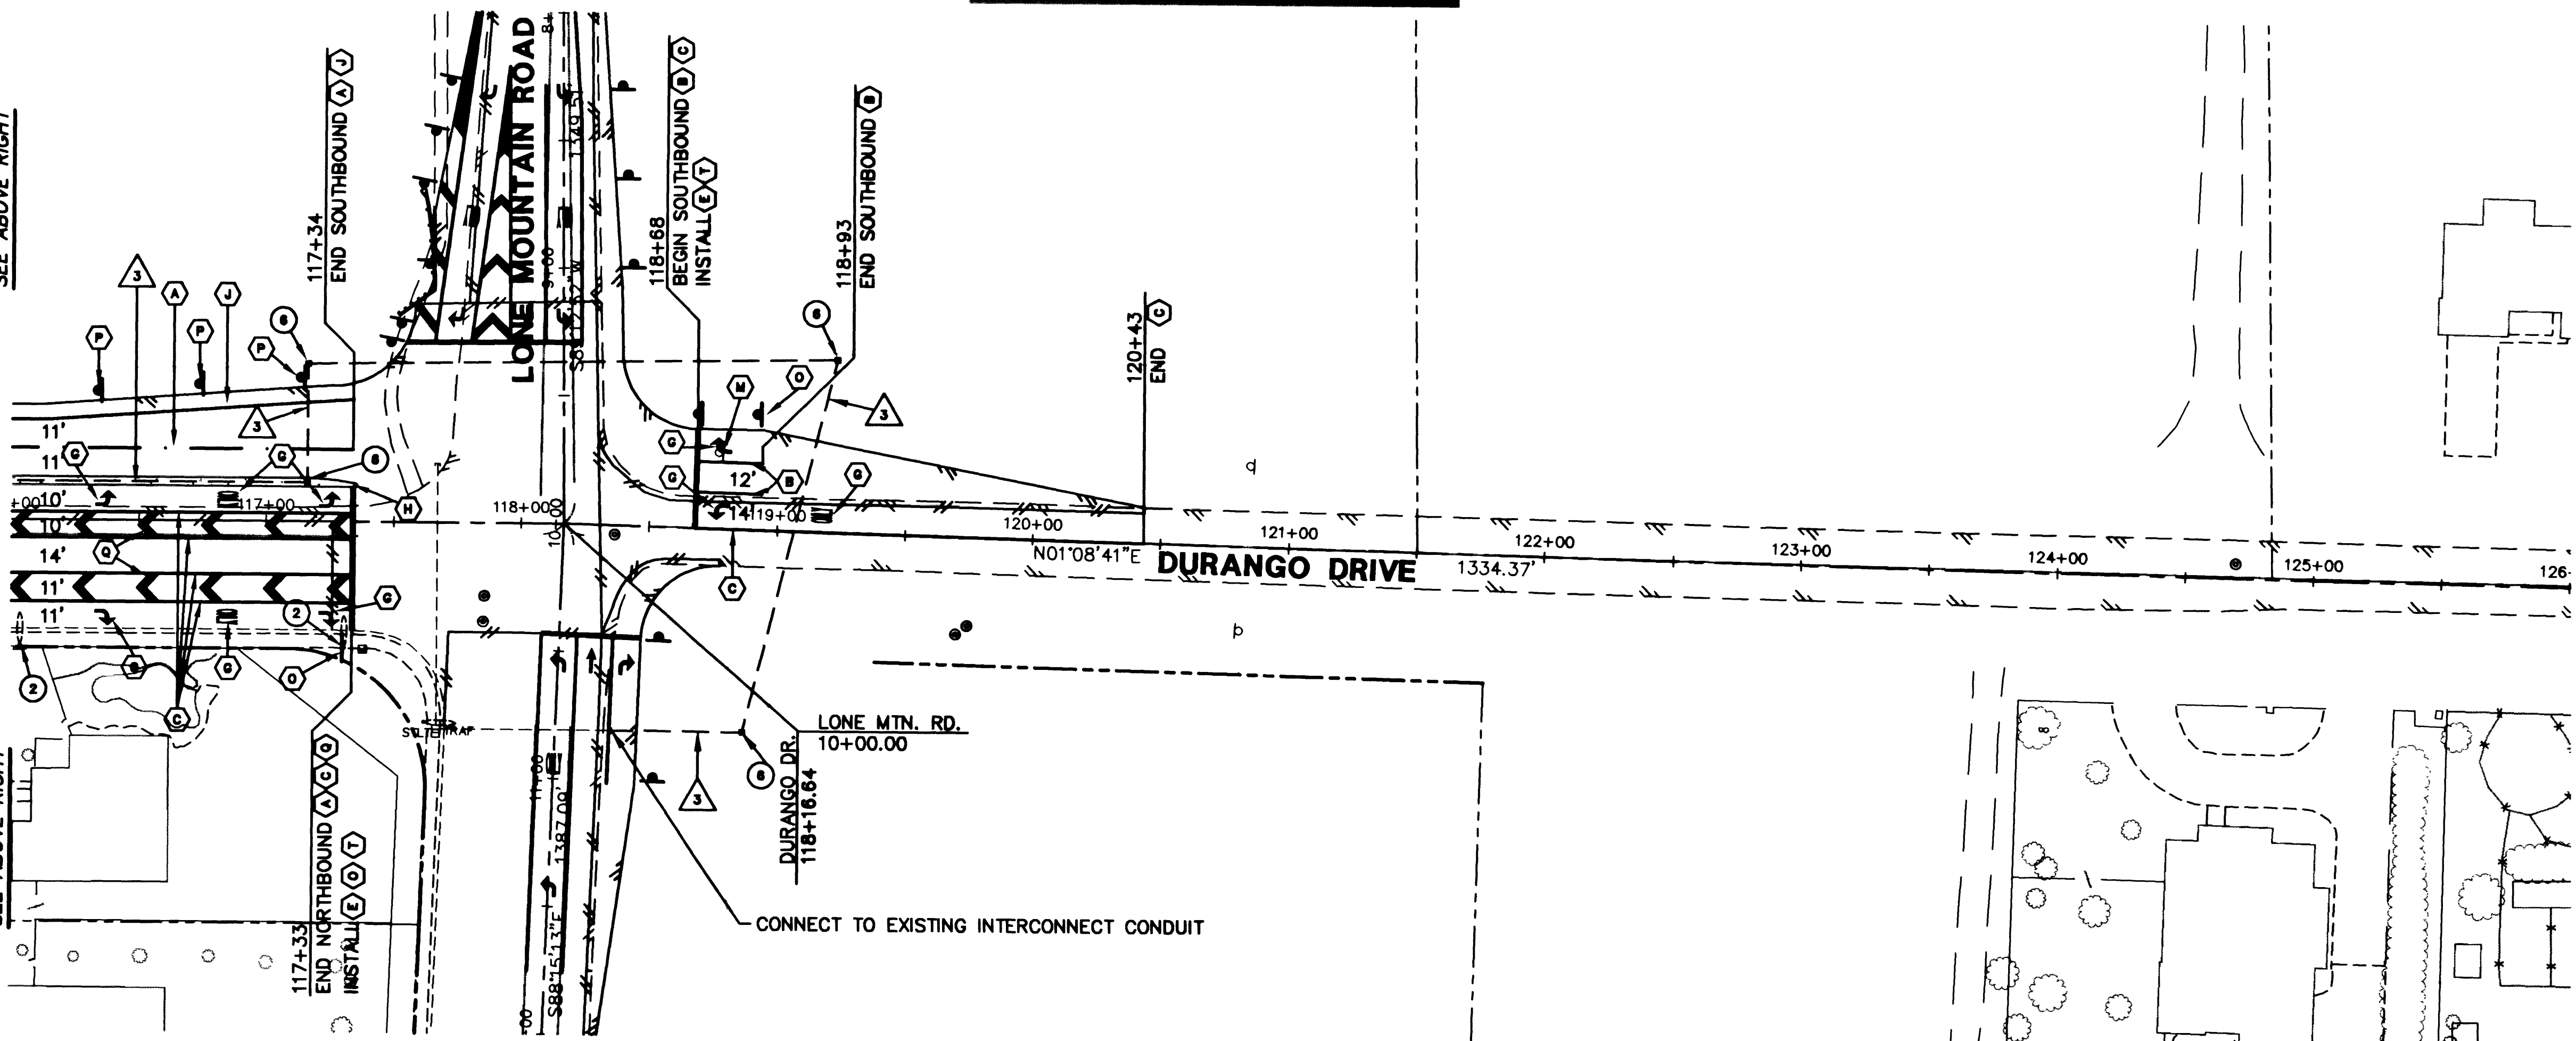

MATCHLINE
STA. 116+00.00
SEE BELOW LEFT

MATCHLINE
STA. 116+00.00
SEE BELOW LEFT

SIGNAGE AND DELINEATION LEGEND

- (A) INSTALL TYPE 4 LANE LINE DELINEATION USING TYPE "A" & "F" MARKERS PER USDOCA STD. DWG. NO. 244A.
- (B) INSTALL WHITE TURN LANE STORAGE LINE DELINEATION USING TYPE "A" & "F" MARKERS PER USDOCA STD. DWG. NO. 248.
- (C) INSTALL YELLOW TYPE 1 CENTERLINE DELINEATION PER USDOCA STD. DWG. NO. 244.
- (D) INSTALL YELLOW TYPE 2 CENTERLINE DELINEATION PER USDOCA STD. DWG. NO. 244.
- (E) INSTALL 24" WIDE STOP BAR USING WHITE COLD POLYMER FILM.
- (F) INSTALL 10' WIDE CROSSWALK USING WHITE COLD POLYMER FILM. SEE TYPICAL DETAIL ON SHEET T1.
- (G) INSTALL ARROWS AND "ONLY" USING WHITE COLD POLYMER FILM.
- (H) INSTALL YELLOW REFLECTIVE MEDIAN NOSE MARKERS PER USDOCA STD. DWG. NO. 248.
- (I) INSTALL WHITE DROP LANE DELINEATION PER USDOCA STD. DWG. NO. 248A.
- (J) INSTALL 4" TYPE II FILM MARKING.
- (K) EXISTING SIGN & POST TO REMAIN.
- (L) EXISTING SIGN ON STREET LIGHT POLE TO REMAIN.
- (M) EXISTING SIGN & POST TO BE REMOVED.
- (N) EXISTING SIGN ON STREET LIGHT POLE TO BE REMOVED.
- (O) INSTALL R3-7R "RIGHT LANE MUST TURN RIGHT" (30"x30").
- (P) INSTALL OM-3R "OBJECT MARKER" SYMBOL (12"x36").
- (Q) INSTALL 24" WIDE CHEVRONS PER USDOCA STD. DWG. 245.
- (R) INSTALL R2-1 "SPEED LIMIT 45" (24"x30").
- (S) INSTALL W3-1A "STOP AHEAD" SYMBOL (36"x36").
- (T) INSTALL R1-1 "STOP SIGN" SYMBOL (30"x30").
- (U) INSTALL R8-3A "NO PARKING" (24"x24") SYMBOL & R7-1AP "ANY TIME W/ DOUBLE HEAD ARROW" SYMBOL (24"x24").
- (V) INSTALL R6-1R "ONE WAY" SYMBOL (36"x12").
- (W) INSTALL R3-2 "NO LEFT TURN" SYMBOL (24" x 24") & R3-4 "NO U-TURN" SYMBOL (24" x 24").

STREET LIGHTING LEGEND

- (1) INSTALL STREET LIGHT POLE AND FOUNDATION WITH 250W LUMINAIRE PER USDOCA STD. DWG. NO. 314.
- (2) EXISTING STREET LIGHT POLE, FOUNDATION & LUMINAIRE TO REMAIN.
- (3) REMOVE EXISTING STREET LIGHT POLE AND LUMINAIRE AND RETURN TO THE CITY OF LAS VEGAS 3100 E. BONANZA.
- (4) INSTALL NO. 3-1/2 STREET LIGHT PULL BOX PER USDOCA STD. DWG. NO. 328.
- (5) INSTALL NO. 5 STREET LIGHT PULL BOX PER USDOCA STD. DWG. NO. 328.
- (6) INSTALL NO. 5 INTERCONNECT CONDUIT PULL BOX PER STD. DWG. 404.120 AT 300' MAXIMUM SPACING.
- (7) SEE TRAFFIC SIGNAL UNDERGROUND PLANS FOR INSTALLATION OF INTERSECTION LUMINAIRES.

WIRING AND CONDUIT LEGEND

- (1) INSTALL 1-1/4" CONDUIT WITH (2) #4 & (1) #8
- (2) INSTALL 1-1/4" CONDUIT ONLY
- (3) INSTALL 3" INTERCONNECT CONDUIT WITH PULL STRING.

NOTES

- 1. ALL WORK TO BE DONE IN ACCORDANCE TO THE UNIFORM STANDARD DRAWINGS AND SPECIFICATIONS FOR PUBLIC WORKS' CONSTRUCTION OFF-SITE IMPROVEMENTS CLARK COUNTY AREA NEVADA AS ADOPTED BY THE CITY OF LAS VEGAS.
- 2. ALL STREET LIGHTING WIRE AND CONDUIT IS 2#4, 1#8, 1 1/4" C UNLESS NOTED OTHERWISE. ALL STREET LIGHTING WIRE SHALL BE COPPER WITH THW INSULATION.
- 3. ALL PULLBOXES ARE NO. 3-1/2 UNLESS NOTED OTHERWISE.
- 4. FIELD VERIFY EXISTING UNDERGROUND CONDUIT AND PULLBOXES. UTILIZE EXISTING CONDUIT WHERE POSSIBLE AND INSTALL NEW CONDUIT AS REQUIRED PER PLANS.

ALL LANE DIMENSIONS ARE
FROM FACE OF MEDIAN CURB TO
LIP OF GUTTER OR EDGE OF A.C.

DEPARTMENT OF PUBLIC WORKS CITY OF LAS VEGAS		CONSULTING ENGINEERS • PLANNERS • LAND SURVEYORS 2727 SOUTH RAINBOW BOULEVARD LAS VEGAS, NEVADA 89102-5148 PHONE (702) 873-7550 FAX (702) 362-2597	
STRIPING & STREET LIGHTING PLAN STA. 106+00.00 TO STA. 126+00.00 DURANGO ROAD		PROJECT DURANGO DRIVE IMPROVEMENTS CHEYENNE AVENUE TO LONE MOUNTAIN ROAD	
SEAL ROBERT L. HOSEA CIVIL No. 1012 8-1998		WO. NO. 5249 RCH BY TMM, WBM DATE 07/17/98 SCALE HORIZ. 1"=40' VERT. NONE DRAWING T8 SHEET 83 OF 106 SHEETS	