
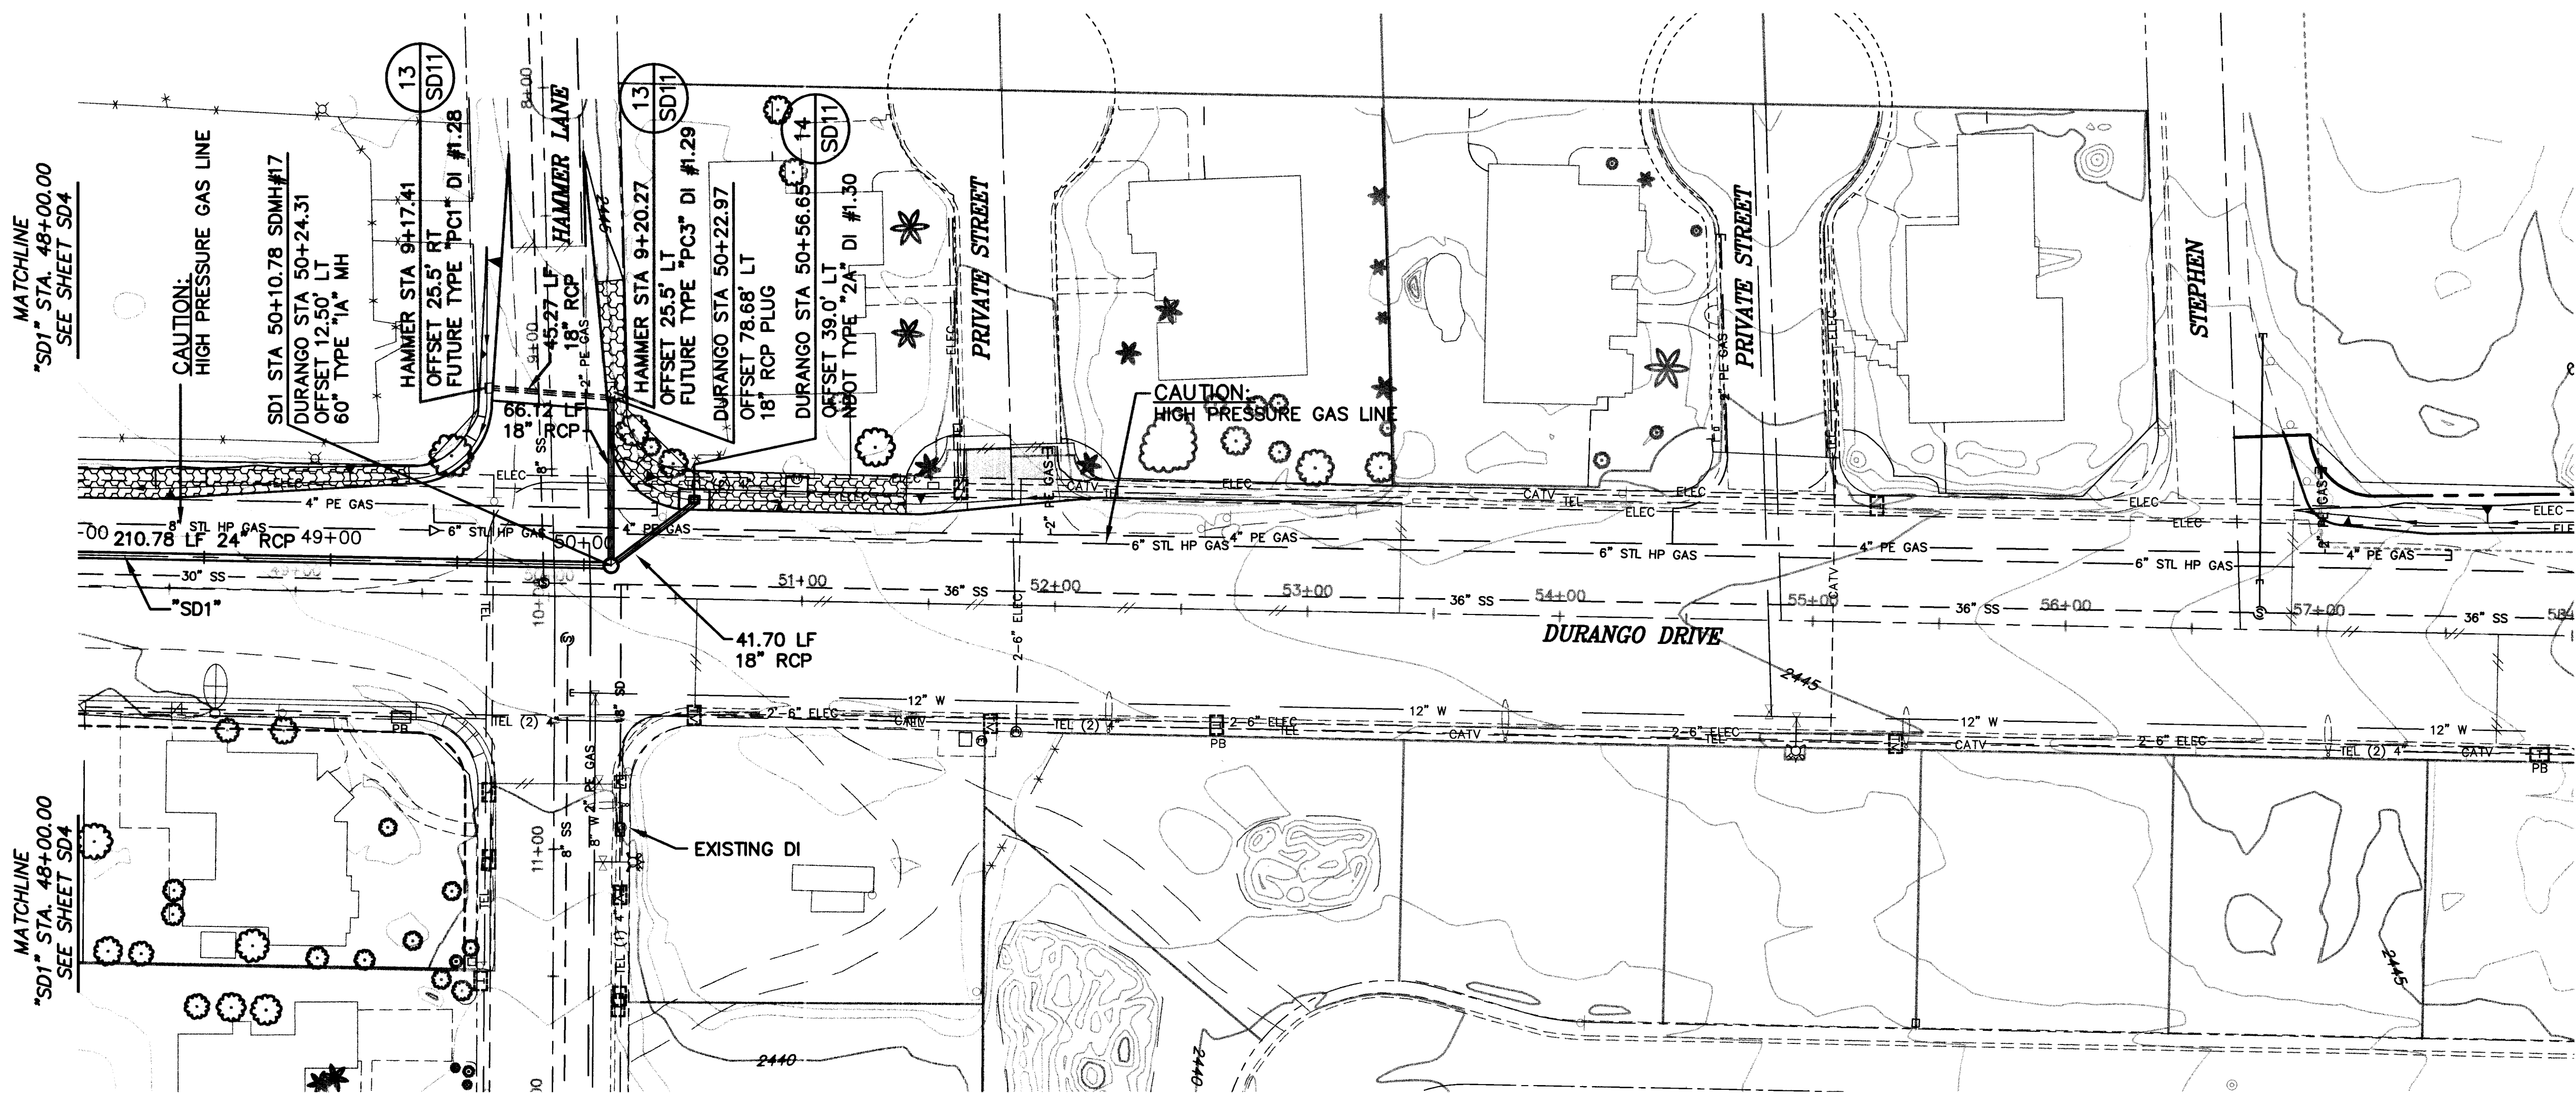



- NOTE:**
1. ALL RCP SHALL BE CLASS III UNLESS NOTED OTHERWISE.
 2. FOR 72" NDOT TYPE "2" MODIFIED MH, SEE NDOT STD. R-4.7.1.
 3. FOR NDOT TYPE "2A" DROP INLET, SEE NDOT STD. R-4.2.1.
 4. FOR RIPRAP APRON AT NDOT TYPE "2A" DROP INLET, SEE DETAIL ON DWG D15.

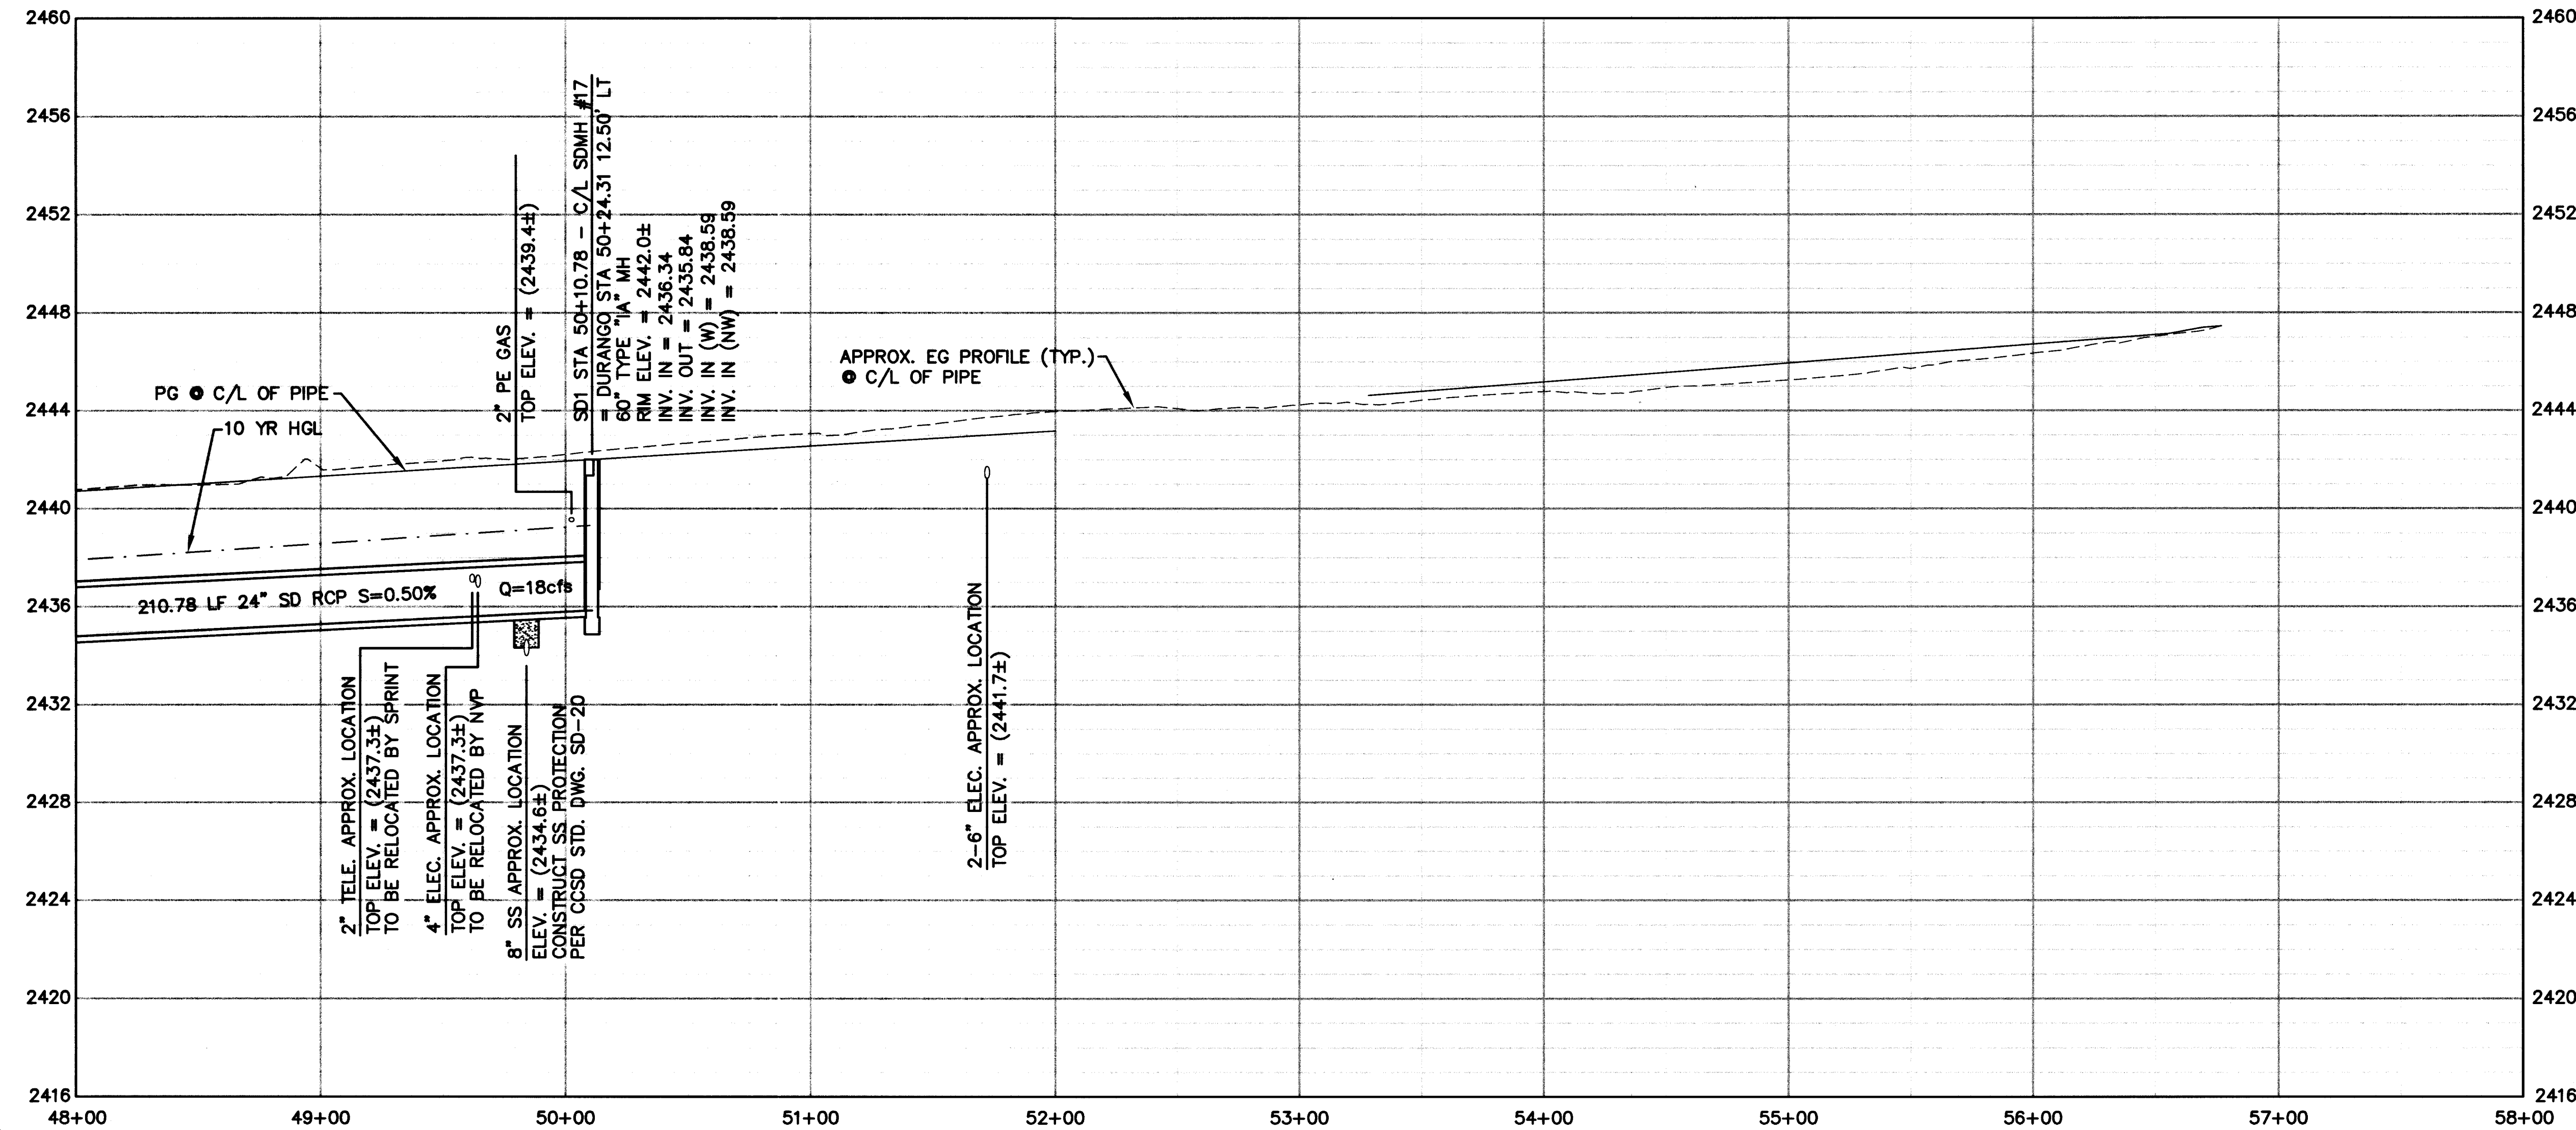

Avoid overhead power line contact.
2 working days
Call before you Overhead
1-702-593-6111
Nevada Power Environment and Safety Services Department

Avoid cutting underground utility lines. It's costly.
2 working days
Call before you Dig
1-800-227-2600
Underground Service Alert (U.S.A.)

DEPARTMENT OF PUBLIC WORKS
CITY OF LAS VEGAS, NEVADA

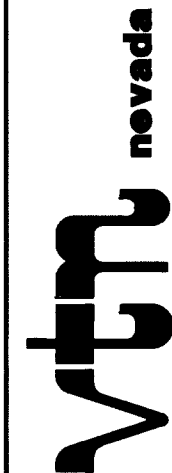

CONSULTING ENGINEERS • PLANNERS • LAND SURVEYORS
2727 SOUTH RAINBOW BOULEVARD
LAS VEGAS, NEVADA 89102-5148 PHONE (702) 873-7550 FAX (702) 362-2597

STORM DRAIN PLAN AND PROFILE
"SD1" STA. 48+00.00 TO "SD1" STA. 58+00.00
DURANGO DRIVE

DURANGO DRIVE IMPROVEMENTS
LONE MOUNTAIN ROAD TO TROPICAL PARKWAY

ORIGINAL CONSTRUCTION DRAWINGS ARE ON FILE WITH THE CITY OF LAS VEGAS.
THE DOCUMENTS WERE SEALED ON 8/13/02 BY KEN D. GILBRETH UNDER LICENSE NO. 9177

WO. NO. 5346
BY JPL
DATE 08/13/02
SCALE HORIZ. 1"=40' VERT. 1"=4'
DRAWING SD5
SHEET 65 OF 84 SHEETS

RECORD DRAWINGS INFORMATION SUPPLIED BY CONTRACTOR - APRIL 2004