
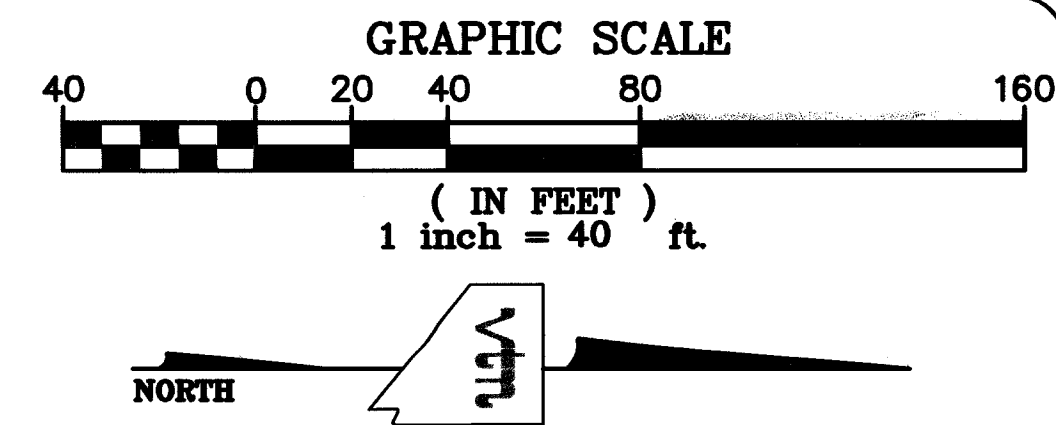


MS "H", "PRF-H" PS "PLT"
I:\CAD\PROJECTS\3546\3546-D.DWG

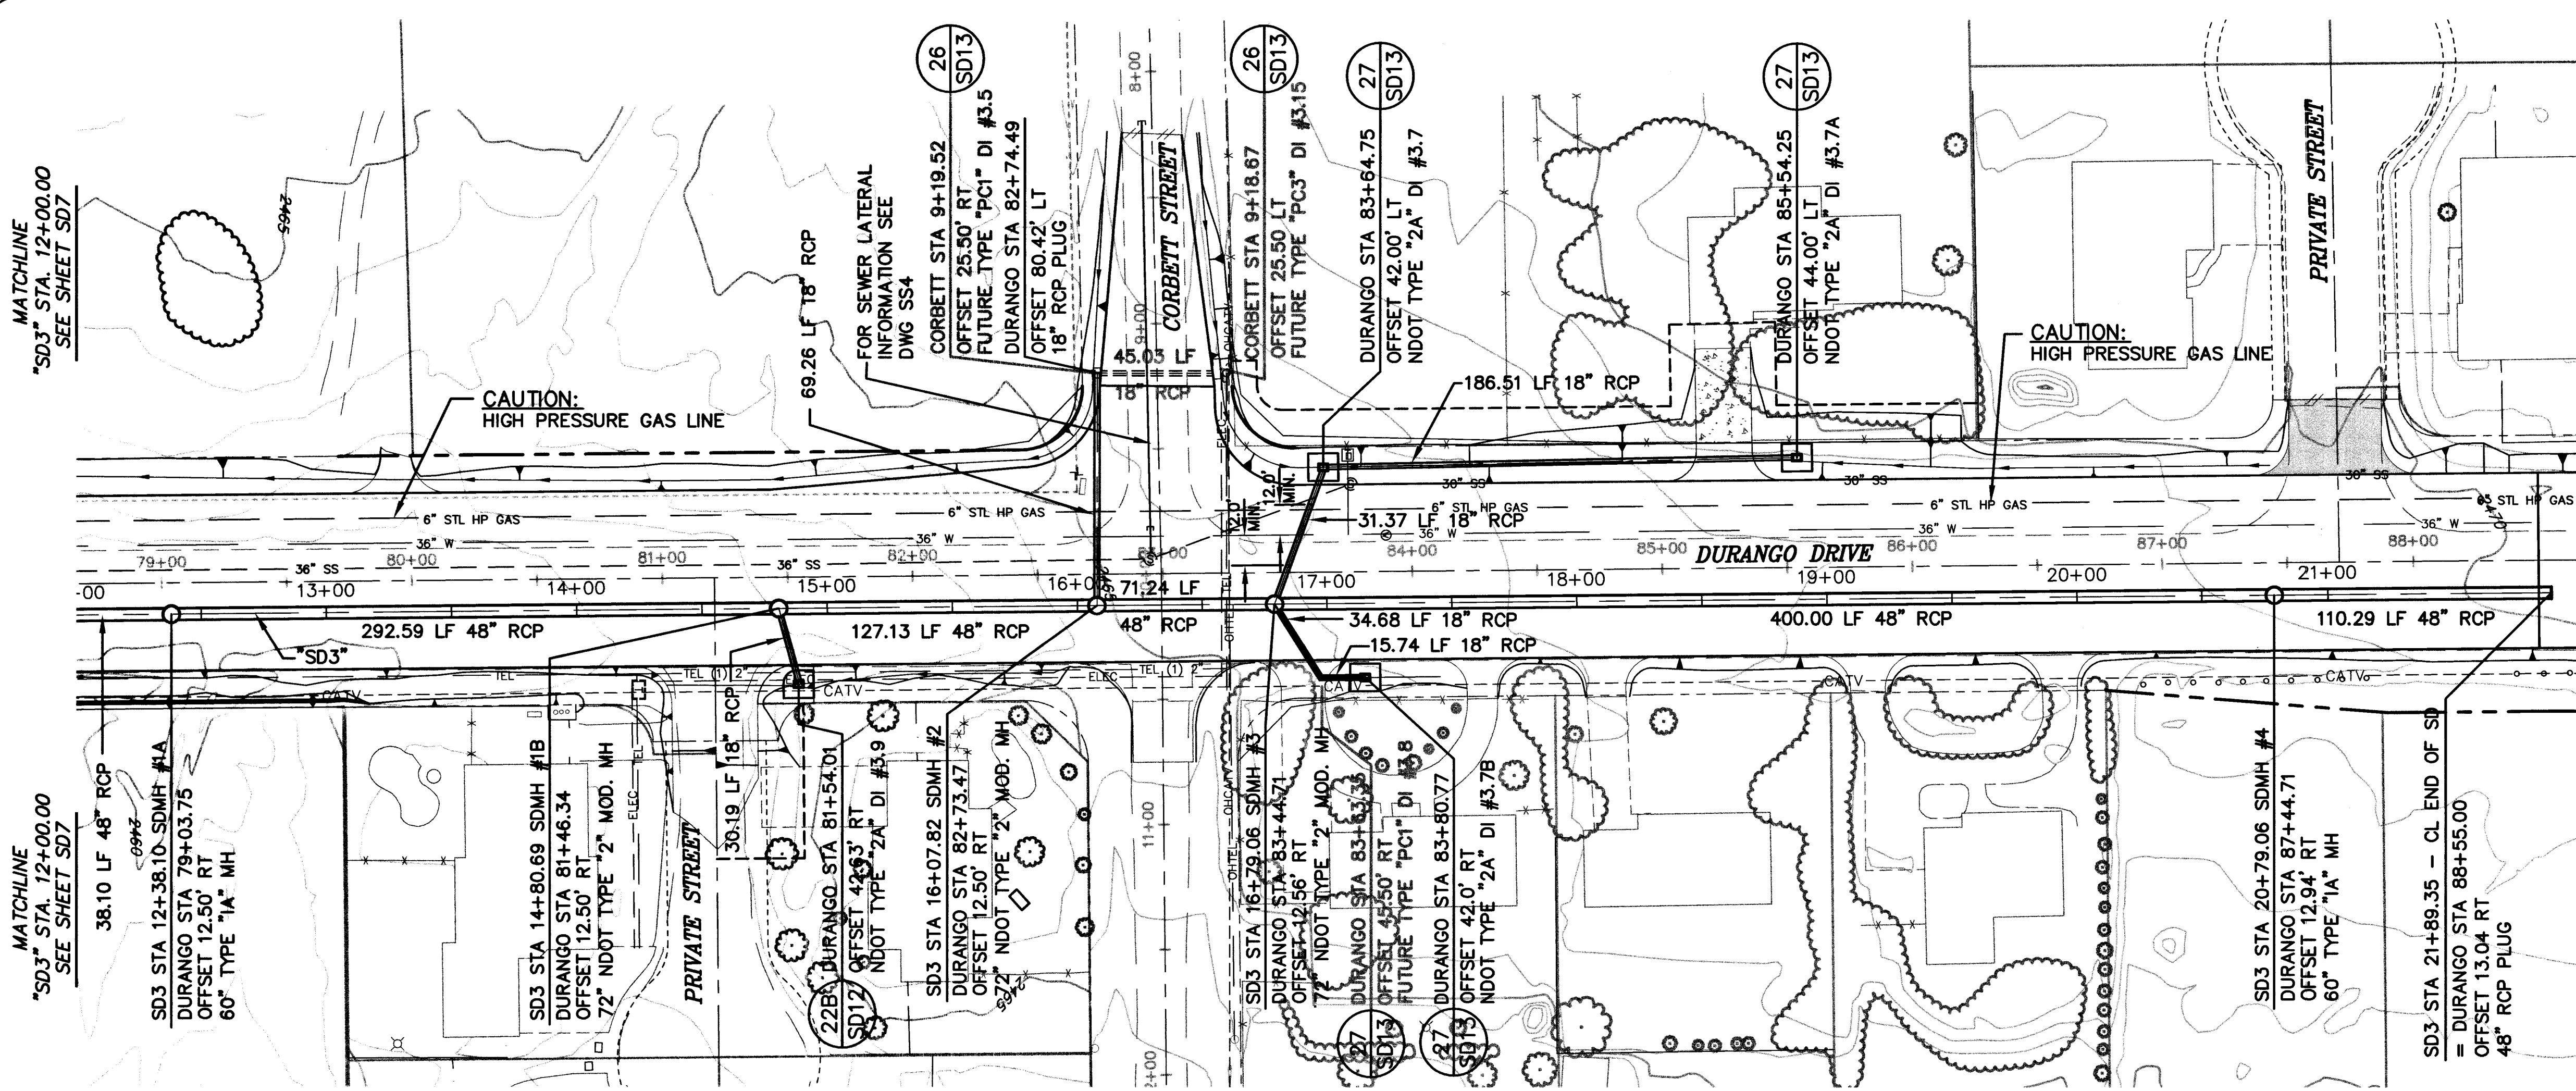


- NOTE:
1. ALL RCP SHALL BE CLASS III UNLESS NOTED OTHERWISE.
 2. FOR 72" NDOT TYPE "2" MODIFIED MH, SEE NDOT STD. R-4.7.1.
 3. FOR NDOT TYPE "2A" DROP INLET, SEE NDOT STD. R-4.2.1.
 4. FOR RIPRAP APRON AT NDOT TYPE "2A" DROP INLET, SEE DETAIL ON DWG D15.

SEE DWG SDBA, SHEET 69 OF 84, REVISION 1

APPROVED

LAS VEGAS VALLEY WATER DISTRICT

DATE

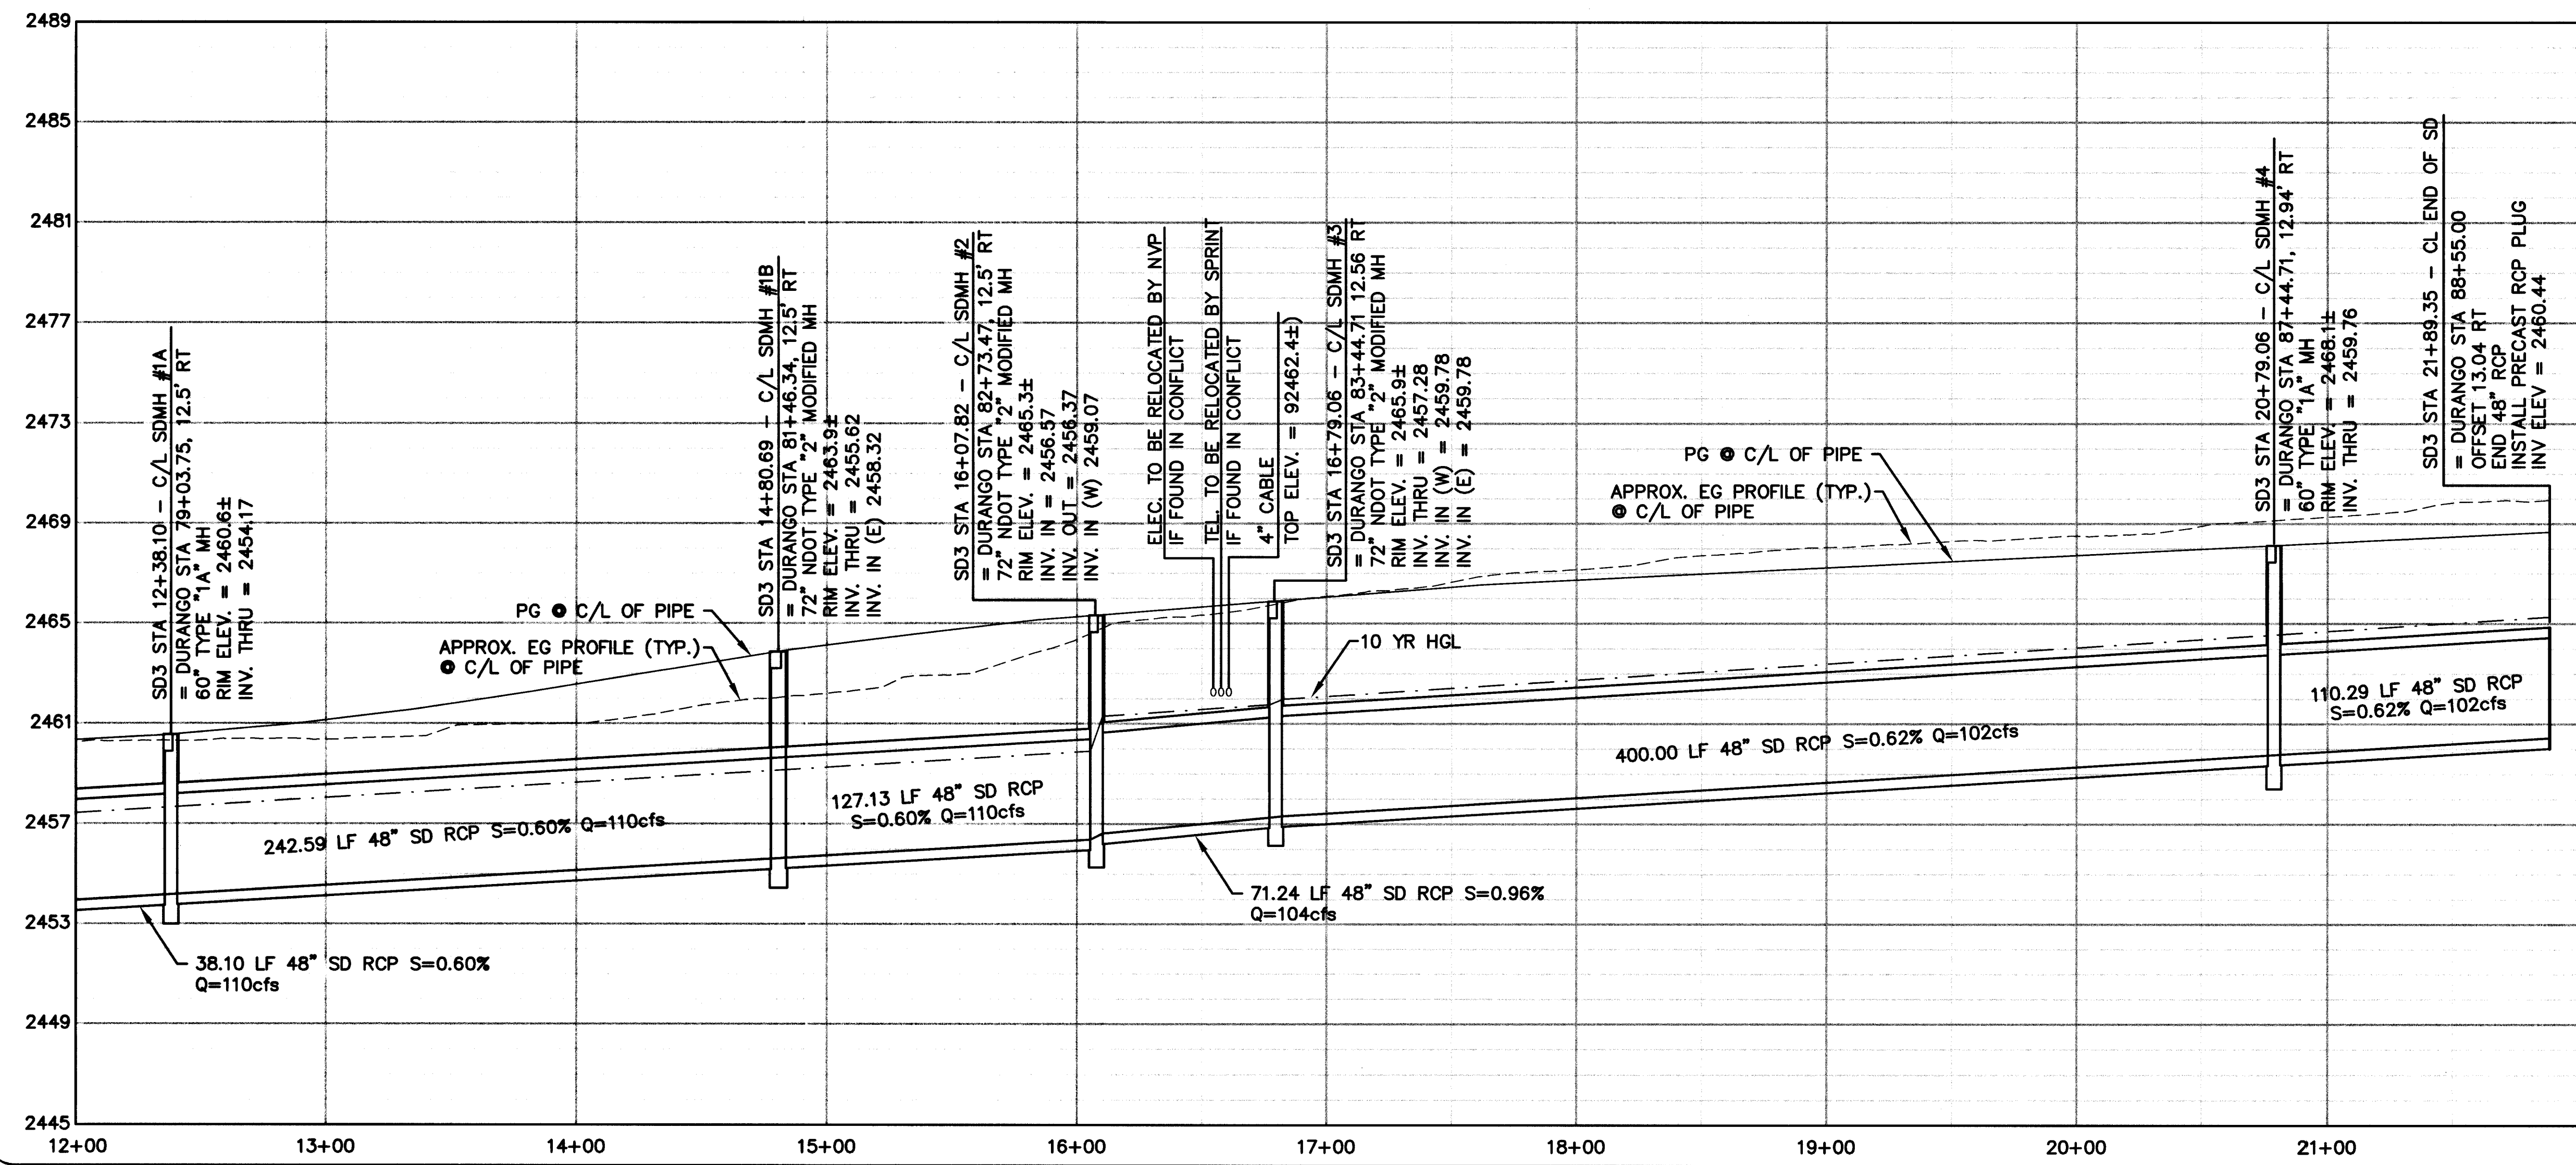

Avoid overhead power line contact.
2 working days

Call before you Overhead

1-702-593-6111

Nevada Power Environment and Safety Services Department

Avoid cutting underground utility lines. It's costly.
2 working days

Call before you Dig

1-800-227-2600

Underground Service Alert (U.S.A.)

DEPARTMENT OF PUBLIC WORKS

CITY OF LAS VEGAS, NEVADA

CONSULTING ENGINEERS • PLANNERS • LAND SURVEYORS

2727 SOUTH RAINBOW BOULEVARD

LAS VEGAS, NEVADA 89102-5148 PHONE (702) 873-7550 FAX (702) 362-2597

RECORD DRAWING INFORMATION PROVIDED BY LV PAVING

REV	DATE	BY	DESCRIPTION
1	7/1/04	DRF	

STORM DRAIN PLAN AND PROFILE

"SD3" STA. 12+00.00 TO "SD3" STA. 21+44.35

DURANGO DRIVE

DURANGO DRIVE IMPROVEMENTS

LONE MOUNTAIN ROAD TO TROPICAL PARKWAY

ORIGINAL CONSTRUCTION DRAWINGS ARE ON FILE WITH THE CITY OF LAS VEGAS.

THE DOCUMENTS WERE SEALED ON 8/13/02 BY KEN D. GILBRETH UNDER LICENSE NO. 9177

WO. NO. 5346

BY JPL

DATE 08/13/02

SCALE HORIZ. 1"=40' VERT. 1"=4'

DRAWING SD8

SHEET 68 OF 84 SHEETS

RECORD DRAWINGS INFORMATION SUPPLIED BY CONTRACTOR - APRIL 2004