
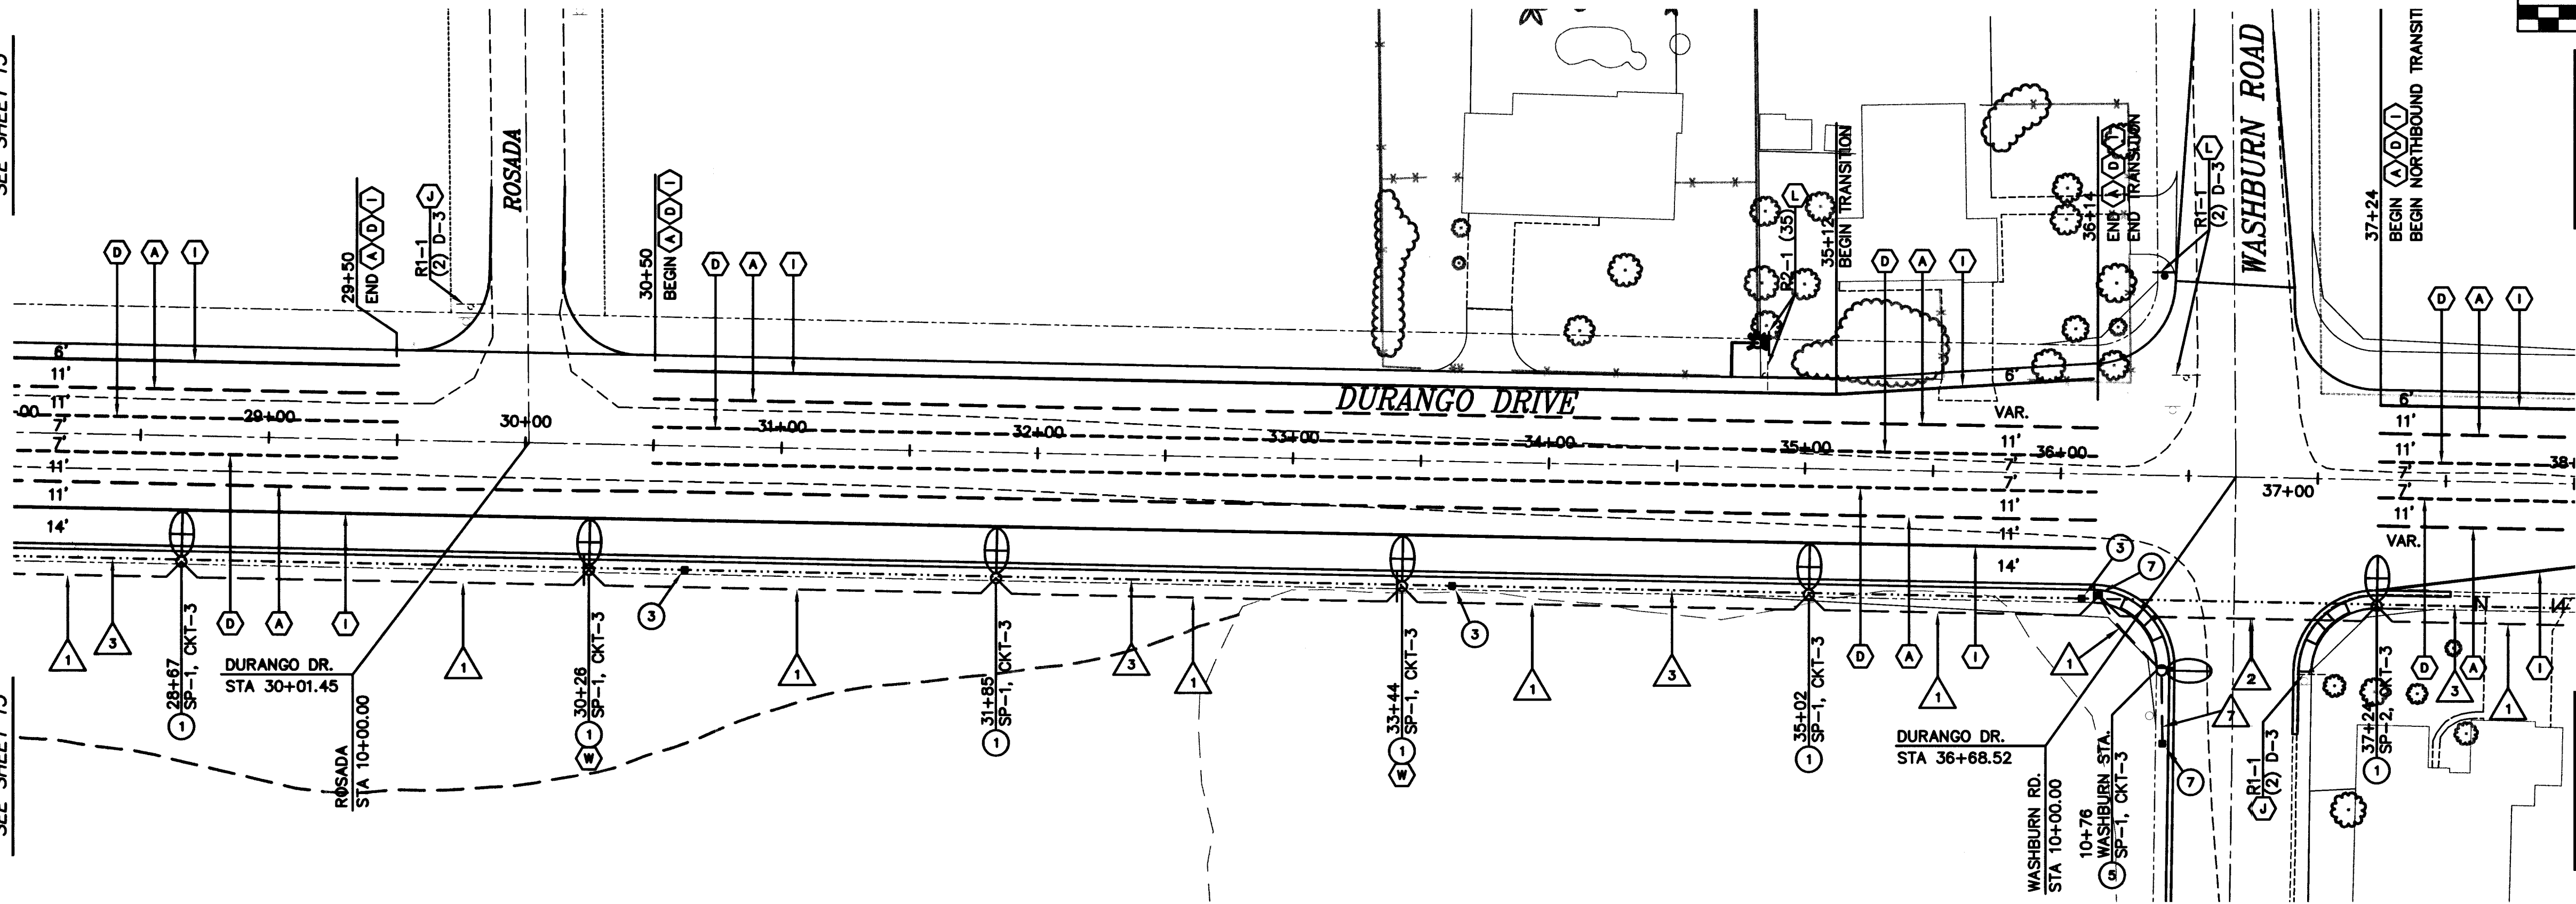


MATCHLINE
STA. 38+00.00
SEE ABOVE RIGHT

MATCHLINE
STA. 38+00.00
SEE ABOVE RIGHT

MATCHLINE
STA. 28+00.00
SEE SHEET T3

MATCHLINE
STA. 28+00.00
SEE SHEET T3

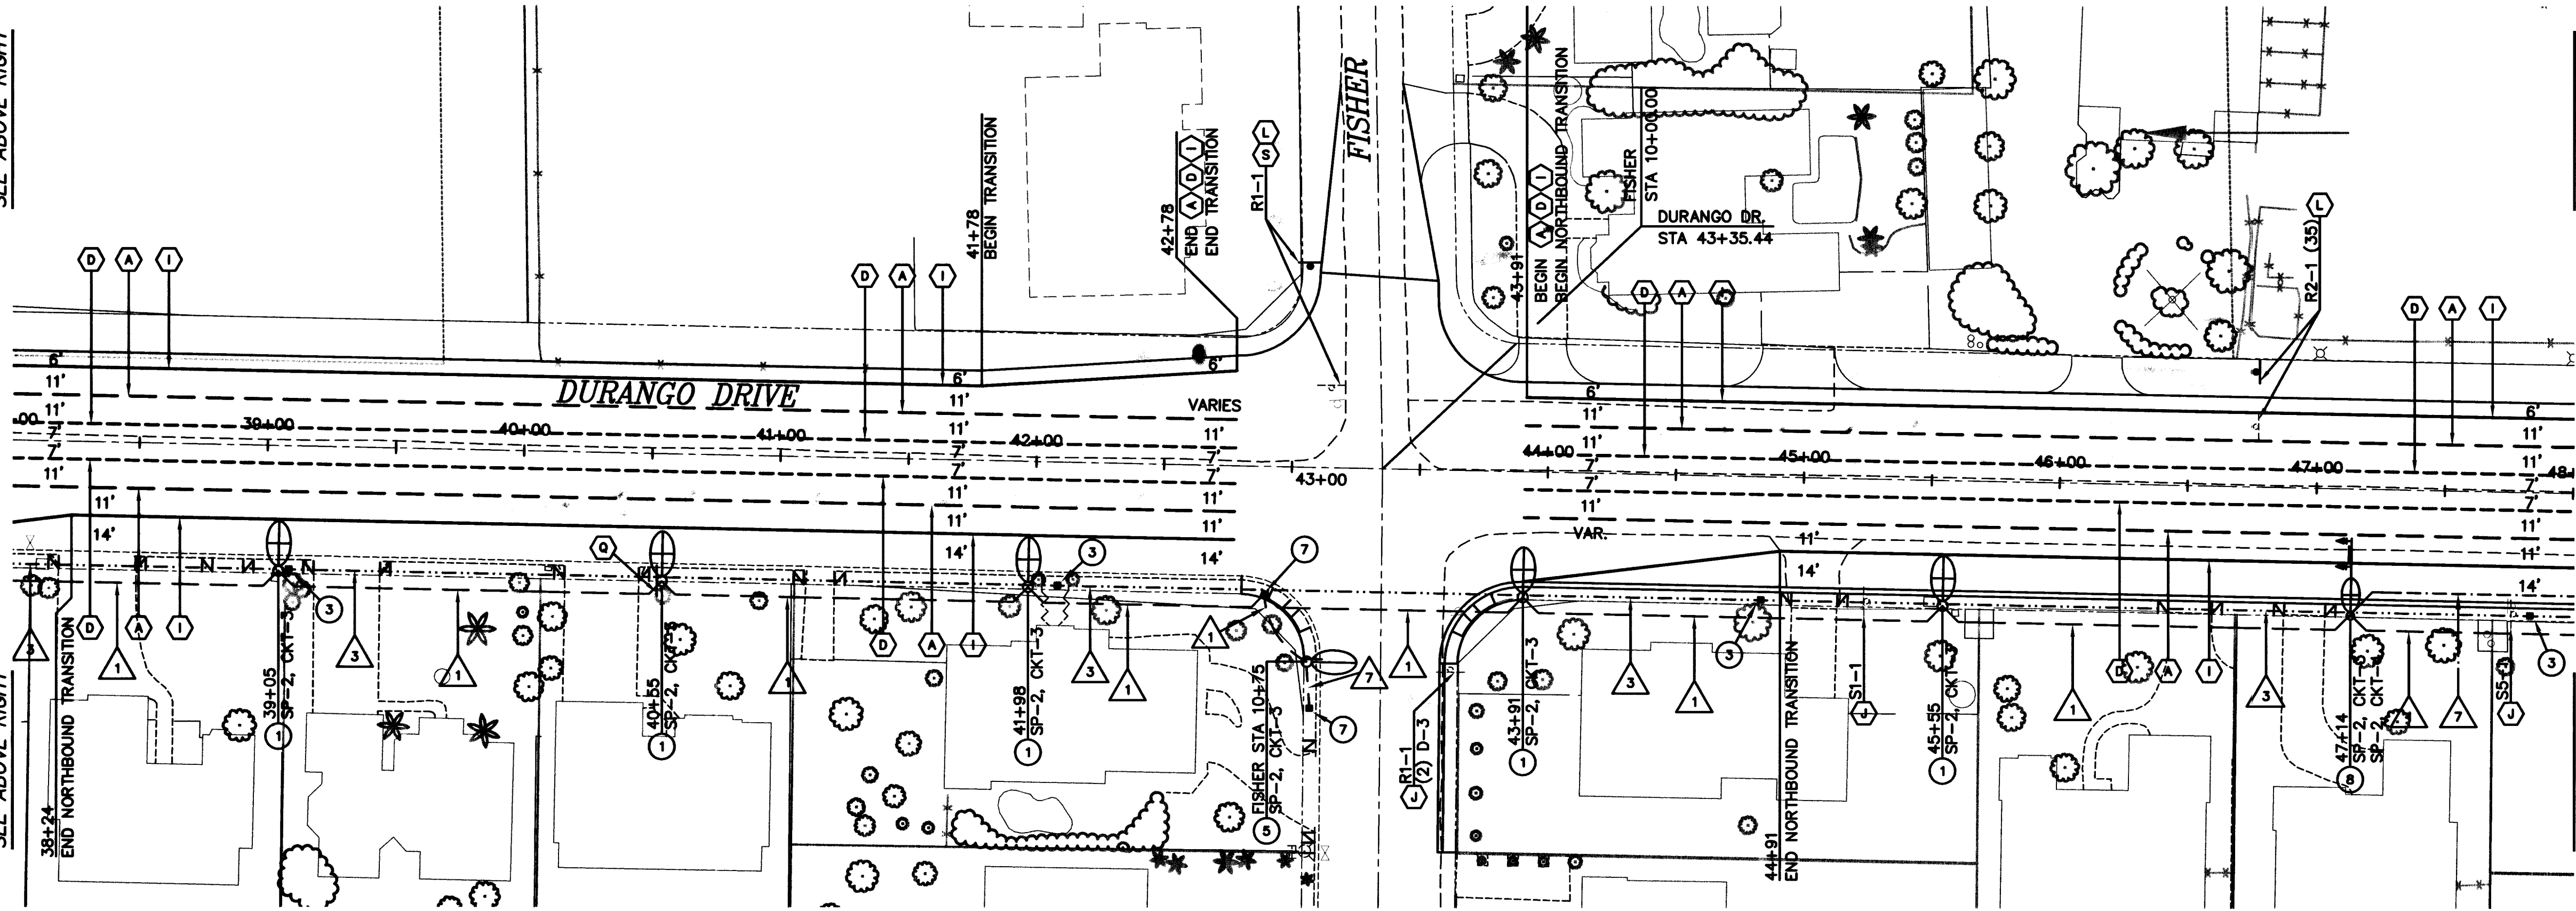


MATCHLINE
STA. 48+00.00
SEE SHEET T5

MATCHLINE
STA. 38+00.00
SEE SHEET T5

MATCHLINE
STA. 38+00.00
SEE BELOW LEFT

MATCHLINE
STA. 38+00.00
SEE BELOW LEFT

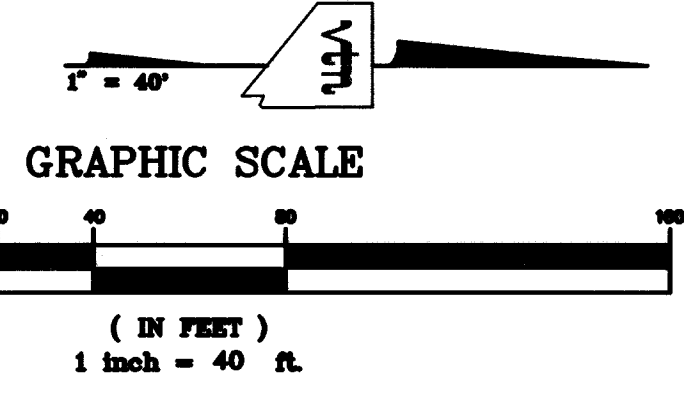

LEGEND

- EXISTING STREET LIGHT
- PROPOSED 150W STREET LIGHT
- PROPOSED 250W STREET LIGHT
- PROPOSED 400W STREET LIGHT

SIGNAGE AND DELINEATION LEGEND

- INSTALL TYPE 4 LANE LINE DELINEATION USING TYPE "A" & "F" MARKERS PER USDOCA STD. DWG. NO. 244A.
- INSTALL WHITE TURN LANE STORAGE LINE DELINEATION USING TYPE "A" & "F" MARKERS PER USDOCA STD. DWG. NO. 246.
- INSTALL YELLOW TYPE 1 CENTERLINE DELINEATION PER USDOCA STD. DWG. NO. 244.
- INSTALL YELLOW TYPE 2 CENTERLINE DELINEATION PER USDOCA STD. DWG. NO. 244.
- INSTALL 24" WIDE STOP BAR USING WHITE TYPE I FILM.
- INSTALL 10' WIDE CROSSWALK USING WHITE TYPE I FILM. SEE TYPICAL DETAIL ON SHEET T1.
- INSTALL 10' WIDE SAFE ROUTE TO SCHOOL CROSSING USING WHITE TYPE I FILM. SEE TYPICAL DETAIL ON SHEET T1.
- INSTALL ARROWS AND "ONLY" USING WHITE TYPE I FILM.
- INSTALL YELLOW REFLECTIVE MEDIAN NOSE MARKERS PER USDOCA STD. DWG. NO. 248.
- INSTALL 4" WIDE WHITE TYPE II FILM MARKING. EDGELINE MARKING SHALL BE INLAID.
- EXISTING SIGN & POST TO REMAIN.
- EXISTING SIGN ON STREET LIGHT POLE TO REMAIN.
- EXISTING SIGN & POST TO BE RELOCATED.
- EXISTING SIGN TO BE REMOVED.
- INSTALL R3-7R "RIGHT LANE MUST TURN RIGHT" (30"x30").
- INSTALL OM-3R "OBJECT MARKER" SYMBOL (12"x36").
- INSTALL 24" WIDE WHITE CHEVRONS USING TYPE I FILM PER USDOCA STD. DWG. 245.
- INSTALL R2-1 "SPEED LIMIT 35" (24"x30").
- INSTALL R1-1 "STOP SIGN" (30"x30").
- INSTALL (2) D3 "STREET NAME" SIGN (12").
- INSTALL W4-2R "LANE REDUCTION" SIGN (36"x36").
- INSTALL R4-7 "KEEP RIGHT" SIGN (24"x30").
- INSTALL GLUE DOWN WHITE FLEXIBLE POSTS.
- INSTALL R8-3A "NO PARKING" SIGN (24" X 24").
- INSTALL W1-1 (R) (L) "HORIZONTAL ALIGNMENT SIGN (30"x30") W/W13-1 (15 MPH) "ADVISORY SPEED" PLAQUE (24"x30").
- INSTALL R6-1 "ONE WAY" SIGN (36"x12").

STREET LIGHTING LEGEND

- INSTALL STREET LIGHT POLE AND FOUNDATION WITH 250W LUMINAIRE PER USDOCA STD. DWG. NO. 314.
- EXISTING STREET LIGHT POLE, FOUNDATION & LUMINAIRE TO REMAIN.
- INSTALL P-30 INTERCONNECT CONDUIT PULL BOX AT 500' MAXIMUM SPACING.
- INSTALL NO. 5 PULL BOX PER STD. DWG. 326.
- INSTALL STREET LIGHT POLE AND FOUNDATION WITH 150W LUMINAIRE PER USDOCA STD. DWG. NO. 314.
- SEE TRAFFIC SIGNAL UNDERGROUND PLANS FOR INSTALLATION OF INTERSECTION LUMINAIRES.
- INSTALL NO. 3-1/2 PULL BOX PER STD. DWG. 326.
- INSTALL SCHOOL FLASHER (25 MPH) SIGN PER STD. DWG. NO. 404.400 (SHEET 1 OF 2) WITH A 30' MAST ARM AND A 250W LUMINAIRE.

WIRING AND CONDUIT LEGEND

- INSTALL 2" CONDUIT WITH (2) #4 & (1) #8
- INSTALL 2" CONDUIT WITH (2) #4 & (1) #8, TAPE ENDS FOR FUTURE RECONFIGURING.
- INSTALL 3" INTERCONNECT CONDUIT WITH #8 GREEN WIRE FOR PULL STRING.
- INSTALL 2" CONDUIT WITH (2) #4, (1) #8, AND (3) #10
- INSTALL 2" CONDUIT WITH (4) #4, (1) #8, AND (6) #10
- INSTALL 2" CONDUIT WITH (4) #4, (1) #8, AND (3) #10
- INSTALL 2" CONDUIT WITH (4) #8.
- INSTALL 2" CONDUIT WITH (4) #4 & (1) #8
- INSTALL 2" CONDUIT WITH #8 GREEN WIRE FOR PULL STRING.

SEAL
ORIGINAL CONSTRUCTION
DRAWINGS ARE ON FILE WITH
THE CITY OF LAS VEGAS.
THE
DOCUMENTS WERE SEALED ON
8/15/02
BY
THOMAS M. ANDERSON
UNDER LICENSE NO.
13946
ELECTRICAL ONLY

WO. NO. 5346
BY RCH
DATE 08/13/02
SCALE HORIZ. 1"=40'
VERT. NONE
DRAWING T4
SHEET 78 OF 84 SHEETS

STRIPING & STREET LIGHTING PLAN
STA 28+00 TO STA 48+00
DURANGO ROAD
PROJECT
DURANGO DRIVE IMPROVEMENTS
LONE MOUNTAIN ROAD TO TROPICAL PARKWAY

DEPARTMENT OF PUBLIC WORKS
CITY OF LAS VEGAS

vtm novada

CONSULTING ENGINEERS • PLANNERS • LAND SURVEYORS
2727 SOUTH RAINBOW BOULEVARD
LAS VEGAS, NEVADA 89102-5148 PHONE (702) 873-7550 FAX (702) 362-2597