
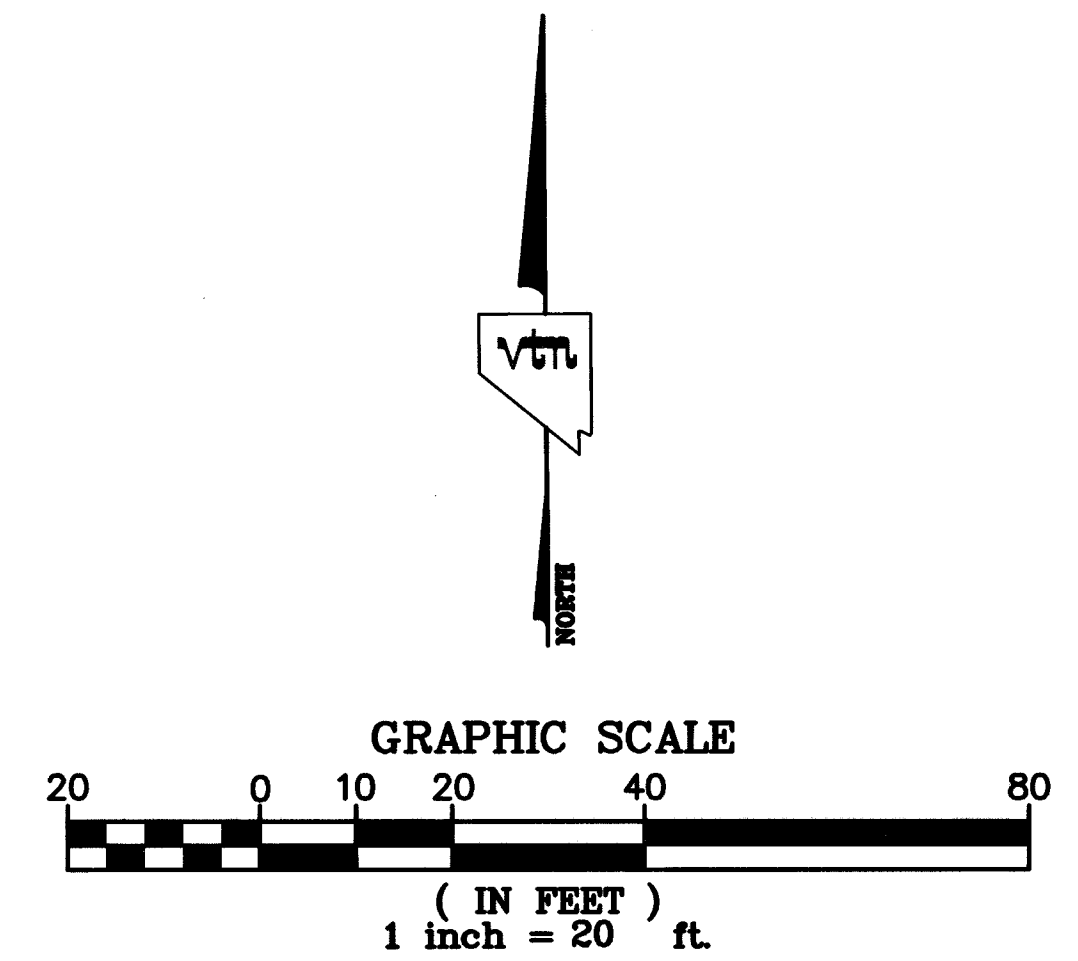



PS "PLT", MS "SIDE-TROP"
 I:\CAD\PL\WORKS\5678\5678-D.DWG

70704

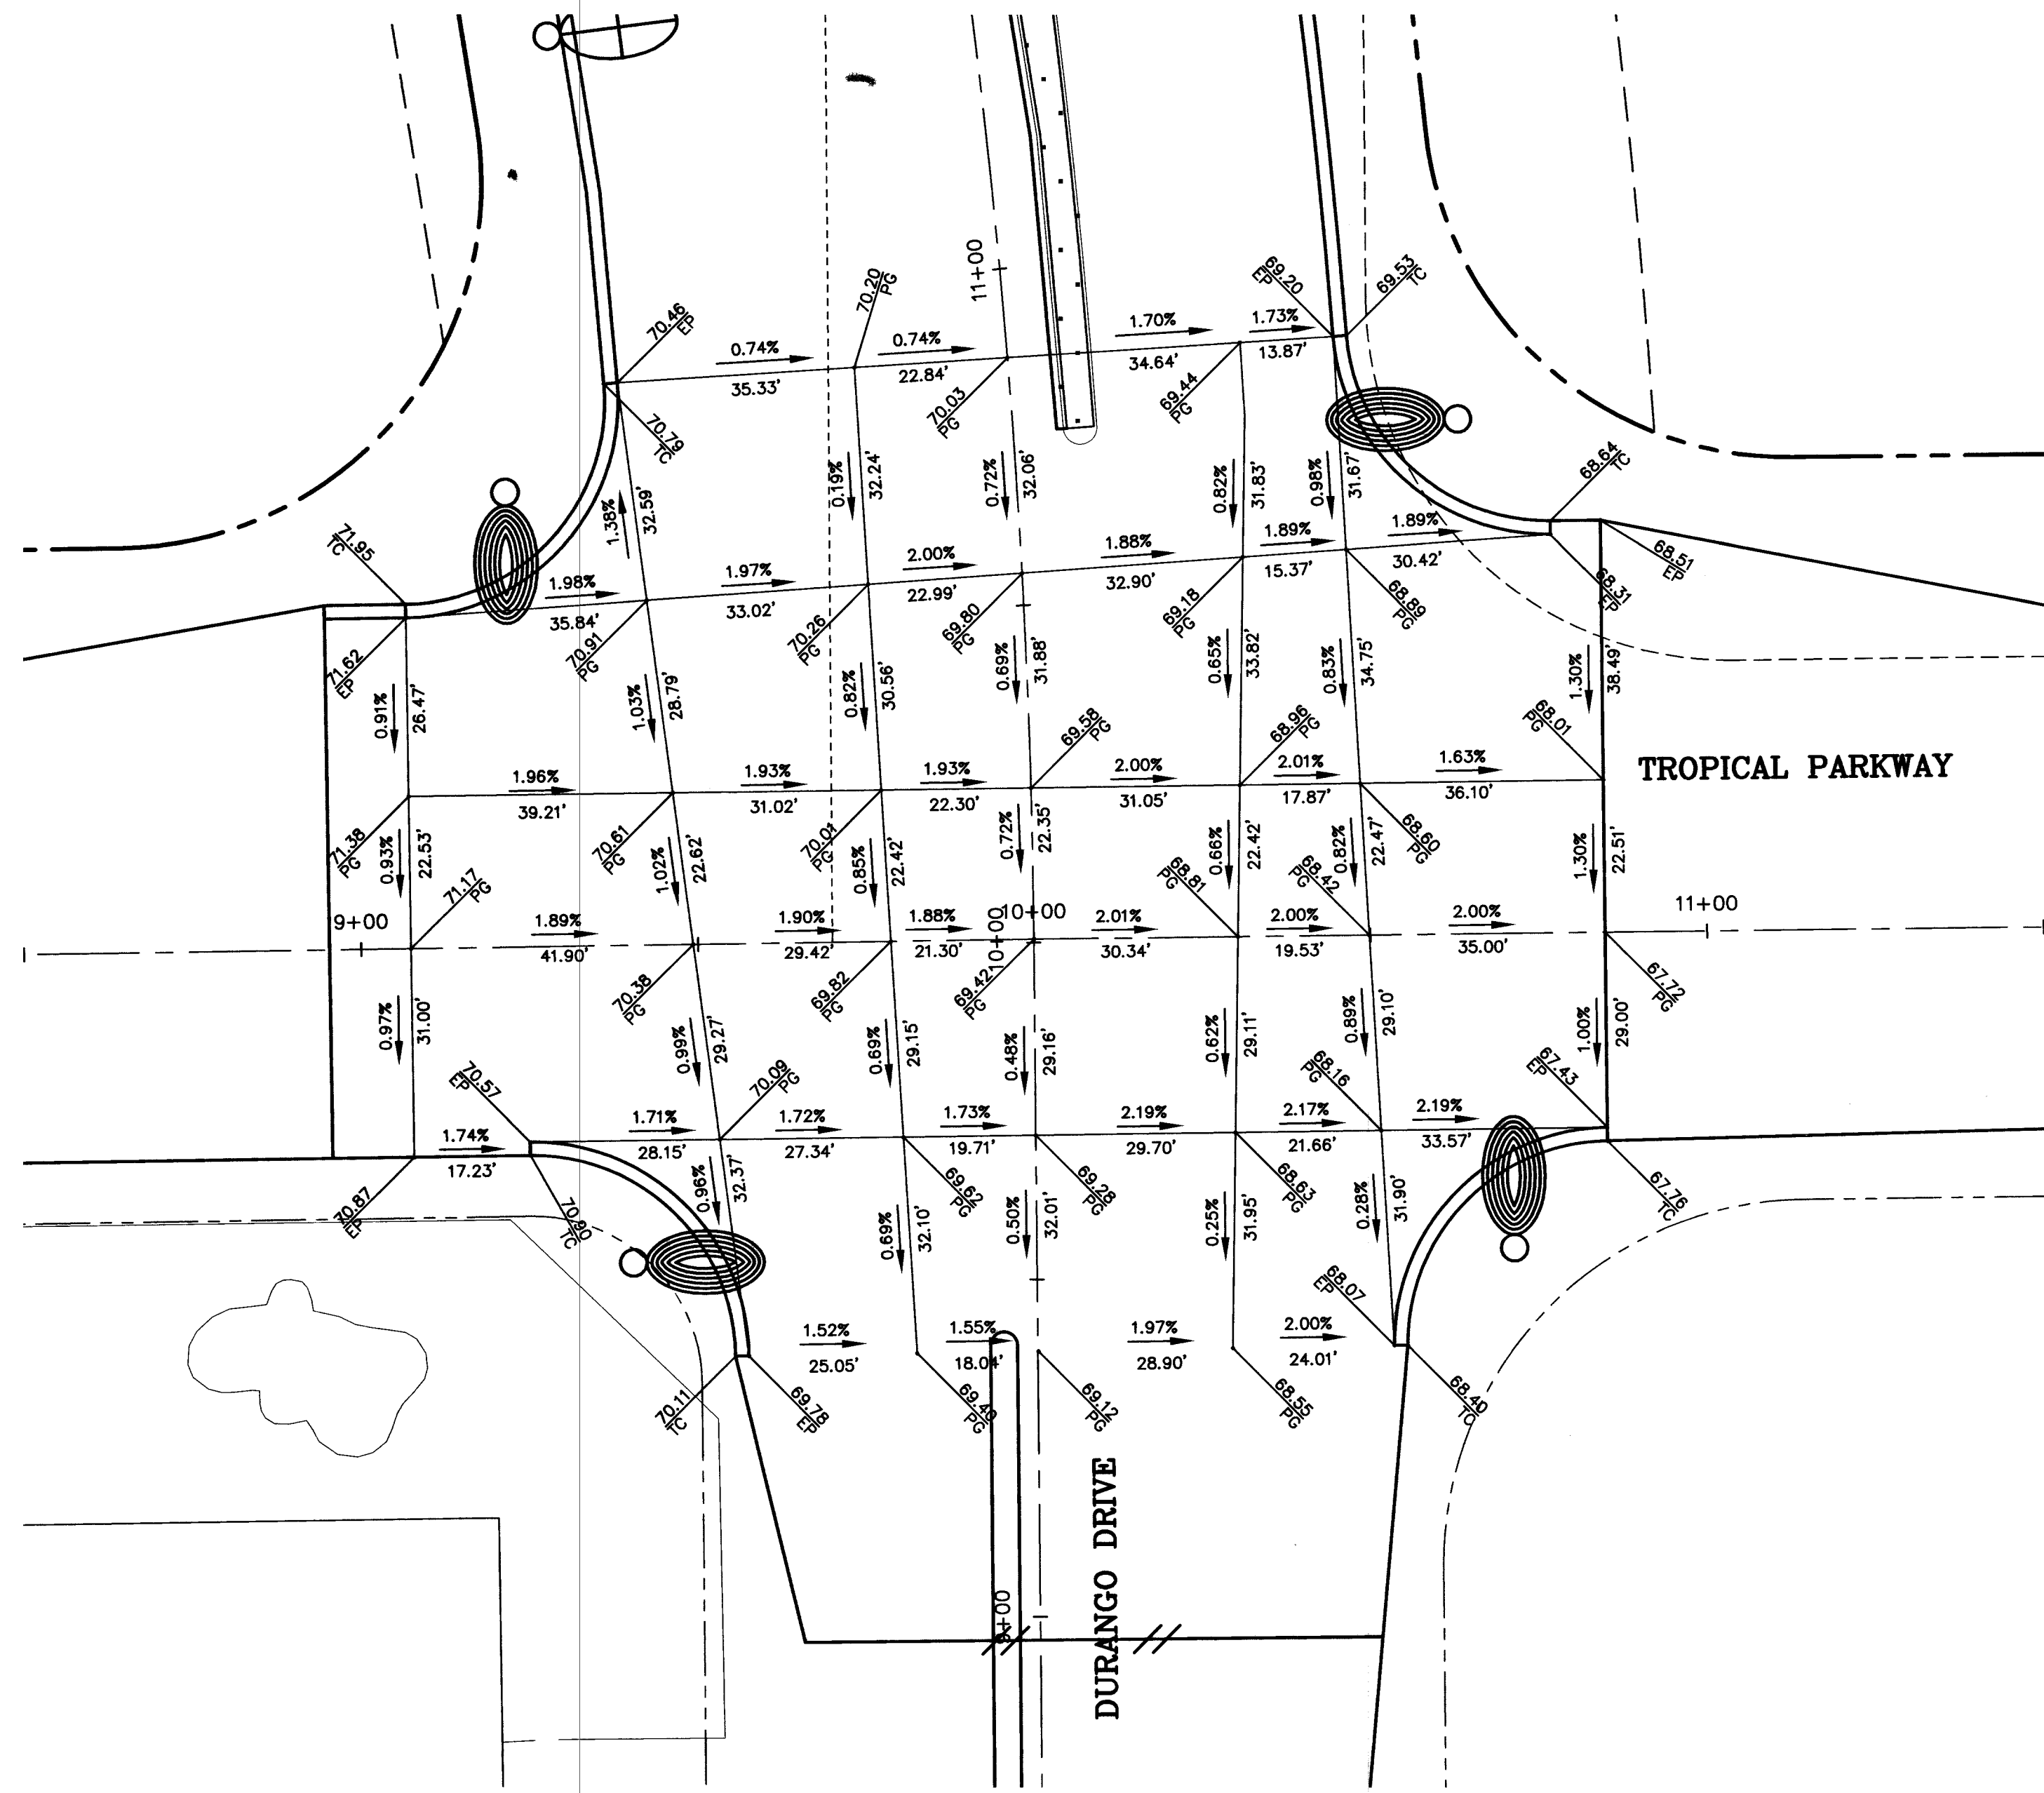


TITLE
**INTERSECTION GRADING PLAN
 DURANGO DRIVE AND
 TROPICAL PARKWAY**

PROJECT
**DURANGO DRIVE IMPROVEMENTS
 TROPICAL PARKWAY TO I-215**

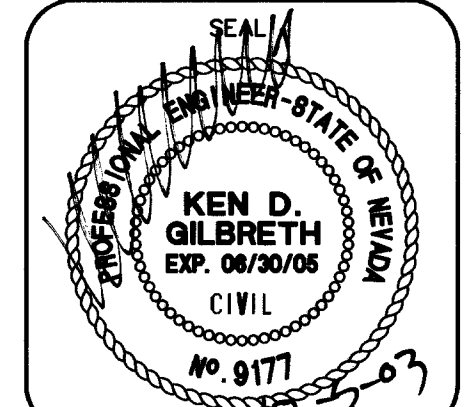

| | |
|---------|----------------------------|
| WO. NO. | 5878 |
| BY | LMW |
| DATE | 12/05/03 |
| SCALE | HORIZ. 1"=20' VERT. N/A |
| DRAWING | R9 |
| SHEET | 31 |
| OF | 71 |
| SHEETS | |

DEPARTMENT OF PUBLIC WORKS
 CITY OF LAS VEGAS

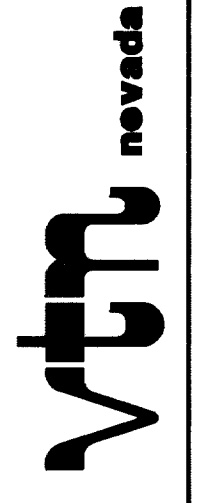

CONSULTING ENGINEERS • PLANNERS • LAND SURVEYORS
 2727 SOUTH RAINBOW BOULEVARD
 LAS VEGAS, NEVADA 89146-5148 PHONE (702) 873-7550 FAX (702) 362-2597

| REV | DATE | BY |
|-----|------|----|
| | | |
| | | |
| | | |
| | | |