

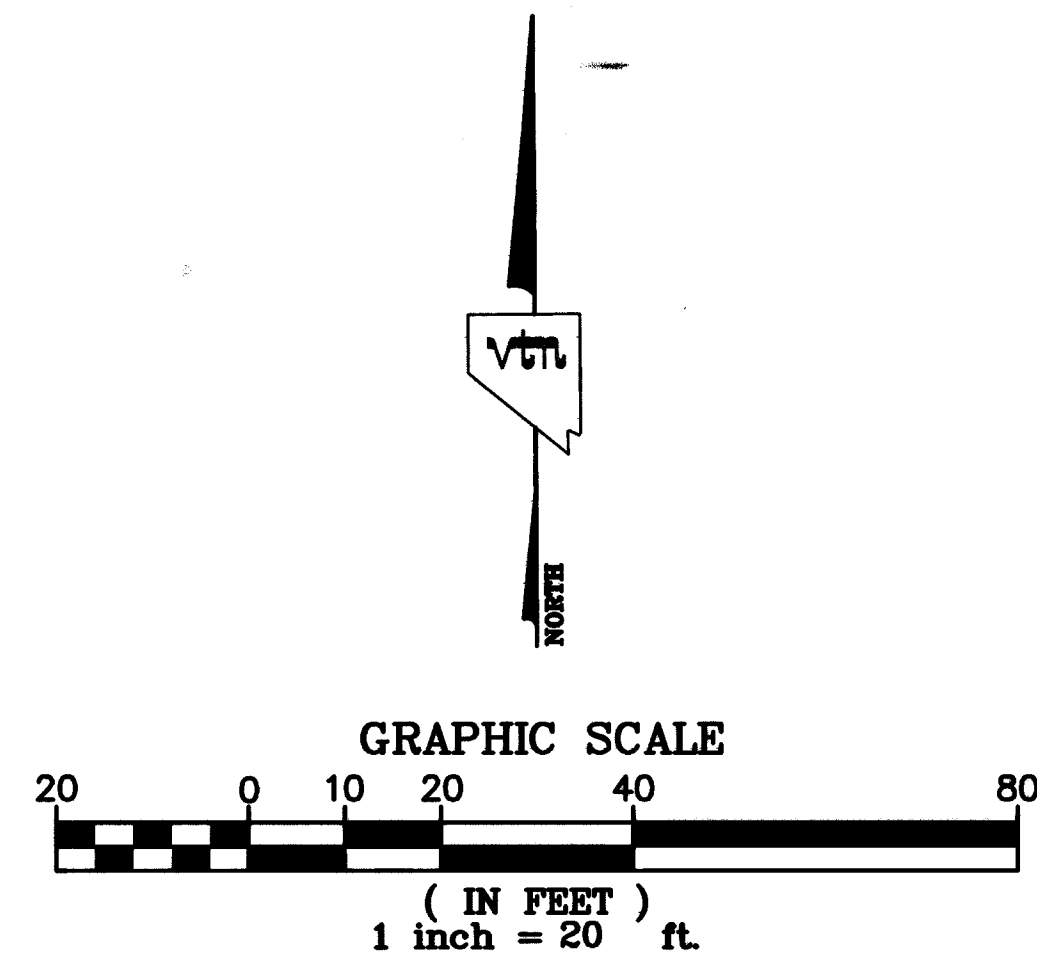


70706

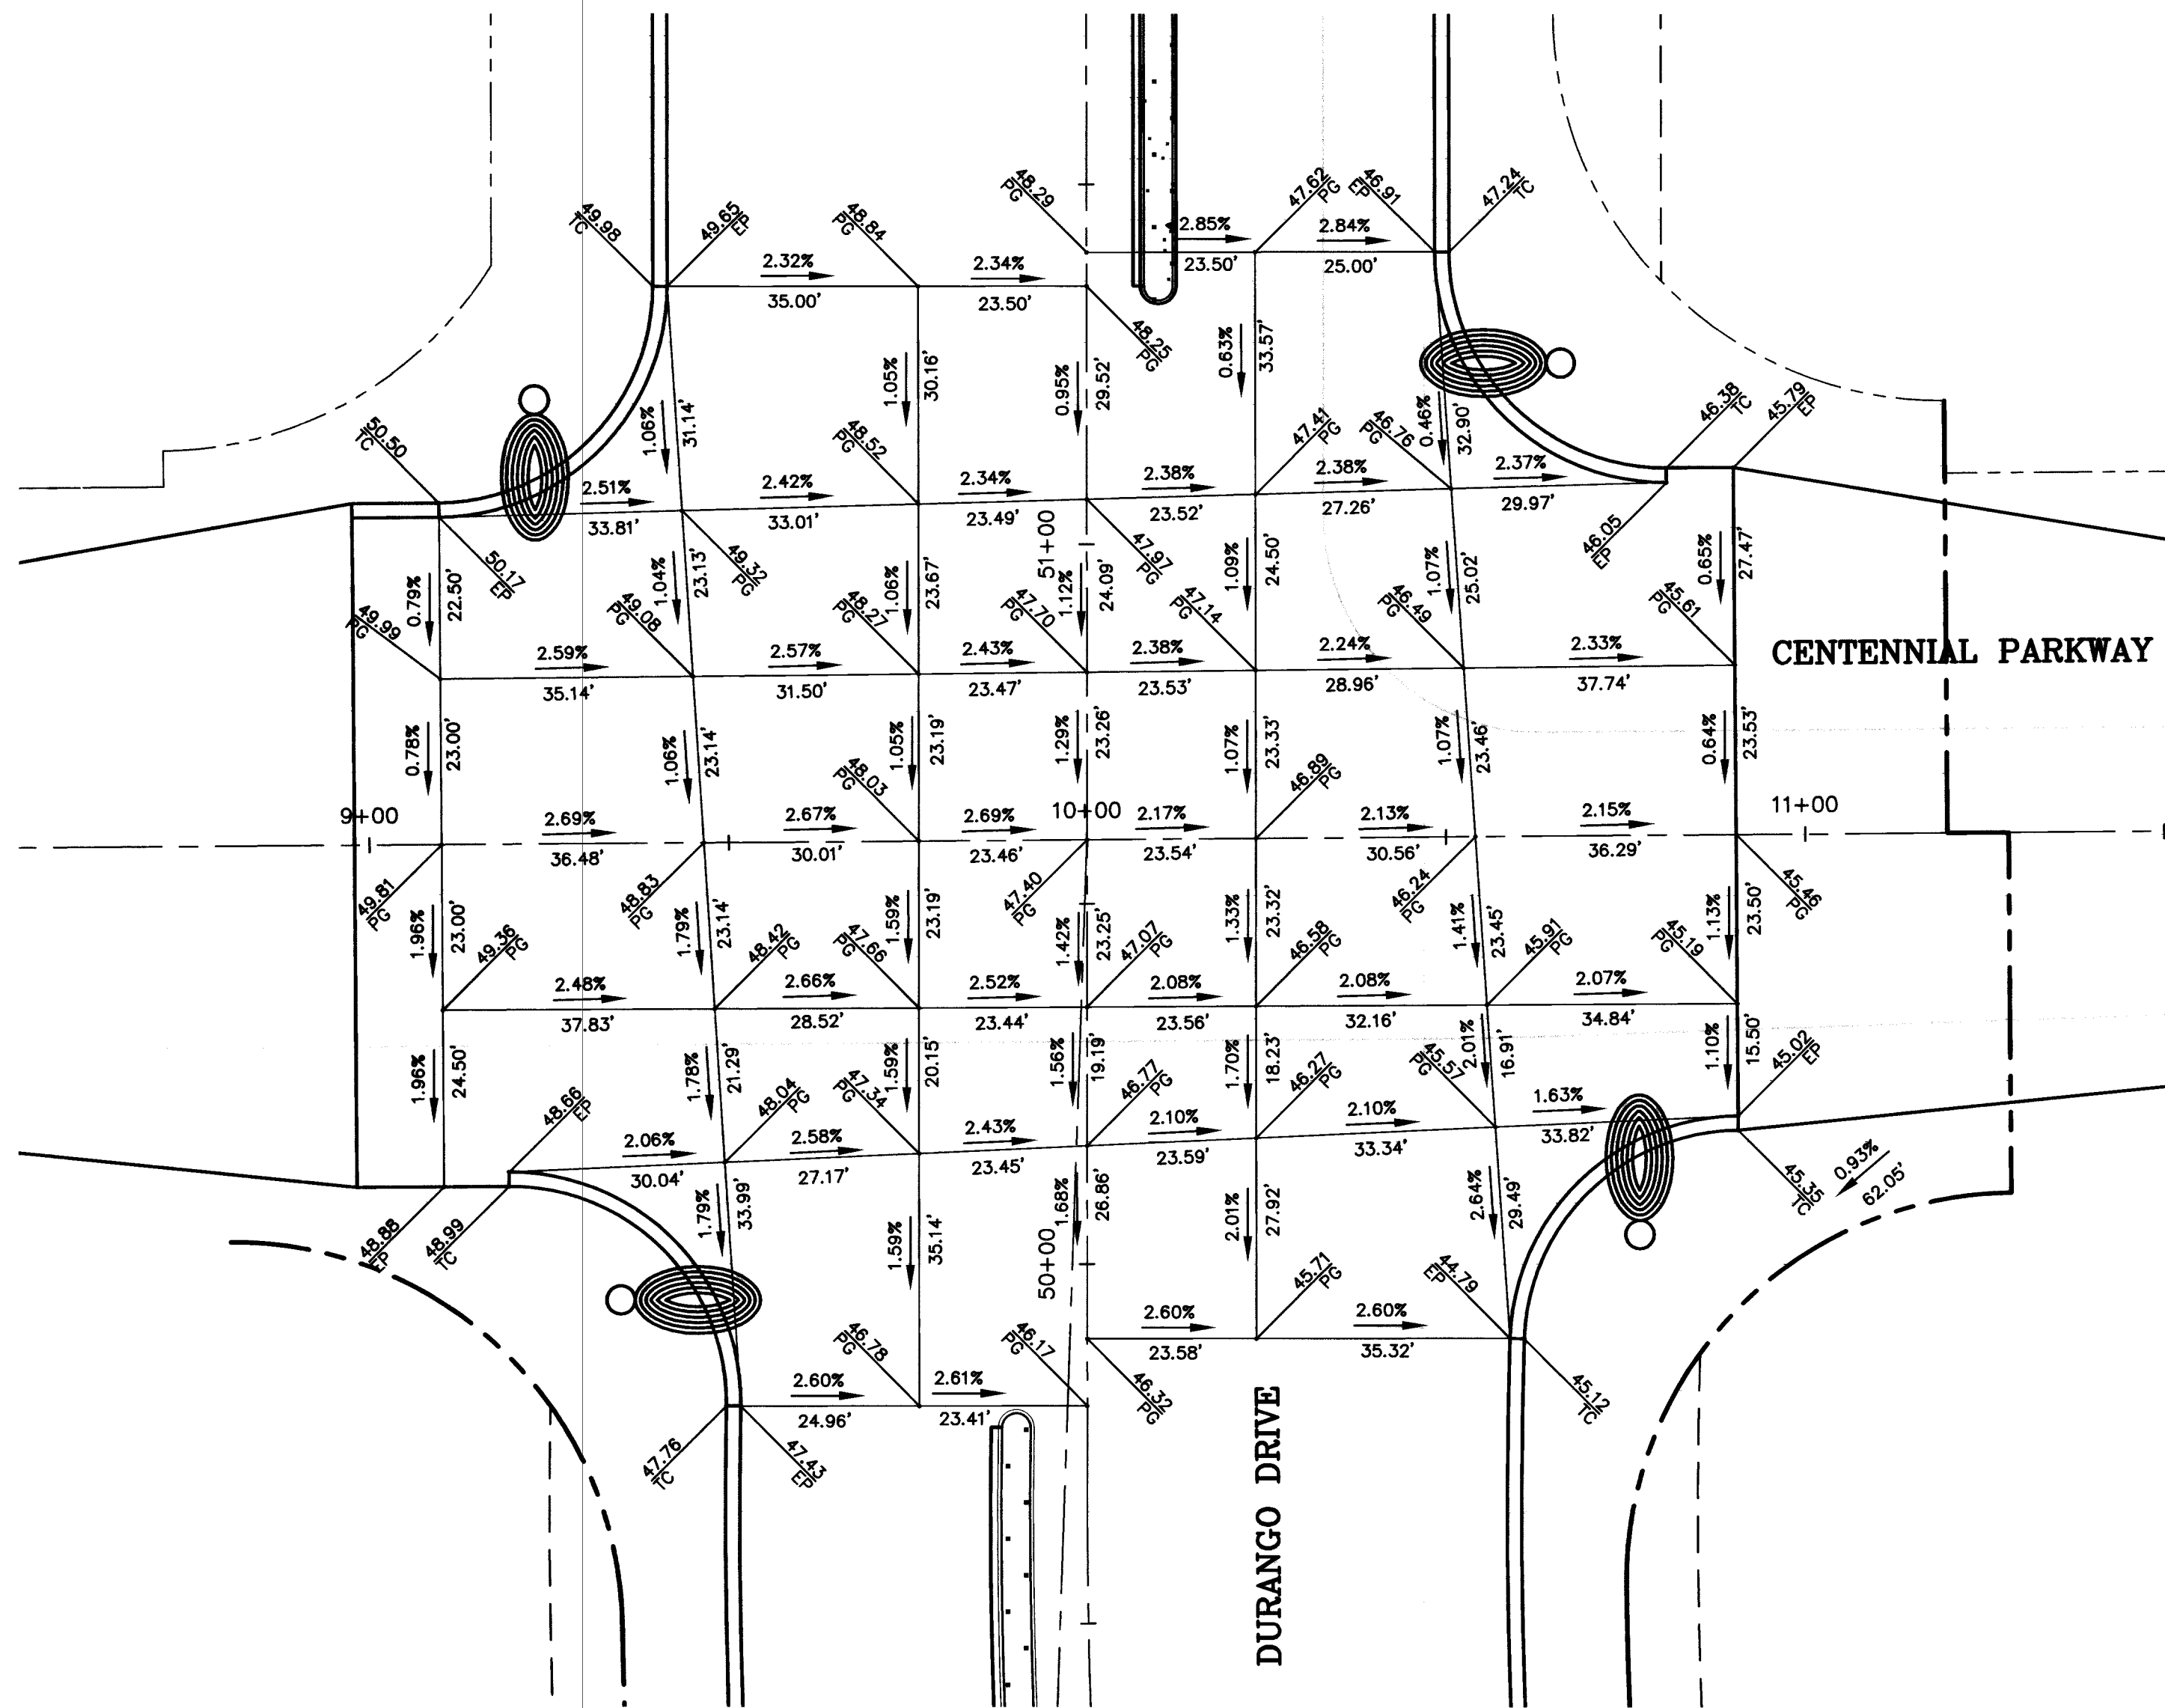


TITLE INTERSECTION GRADING PLAN
DURANGO - EL CAPITAN AND
CENTENNIAL PARKWAY
PROJECT DURANGO DRIVE IMPROVEMENTS
TROPICAL PARKWAY TO I-215

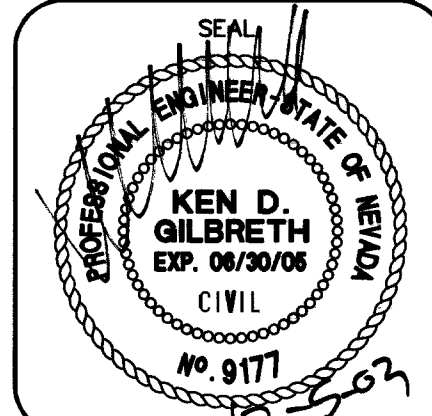

WO. NO.	5678
BY	LMW
DATE	12/05/03
SCALE	HORIZ. 1"=20' VERT. 1"=10'
DRAWING	R11
SHEET	71
OF	71 SHEETS

DEPARTMENT OF PUBLIC WORKS
CITY OF LAS VEGAS

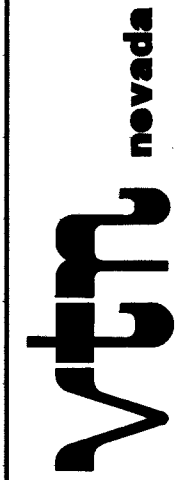

CONSULTING ENGINEERS • PLANNERS • LAND SURVEYORS
2727 SOUTH RAINBOW BOULEVARD
LAS VEGAS, NEVADA 89146-5148 PHONE (702) 873-7550 FAX (702) 362-2597

REV	DATE	BY	REVISION