



69KV TRANSMISSION LINE
EL RANCHO - LYNNWOOD
PROJECT: TL311TMTL5

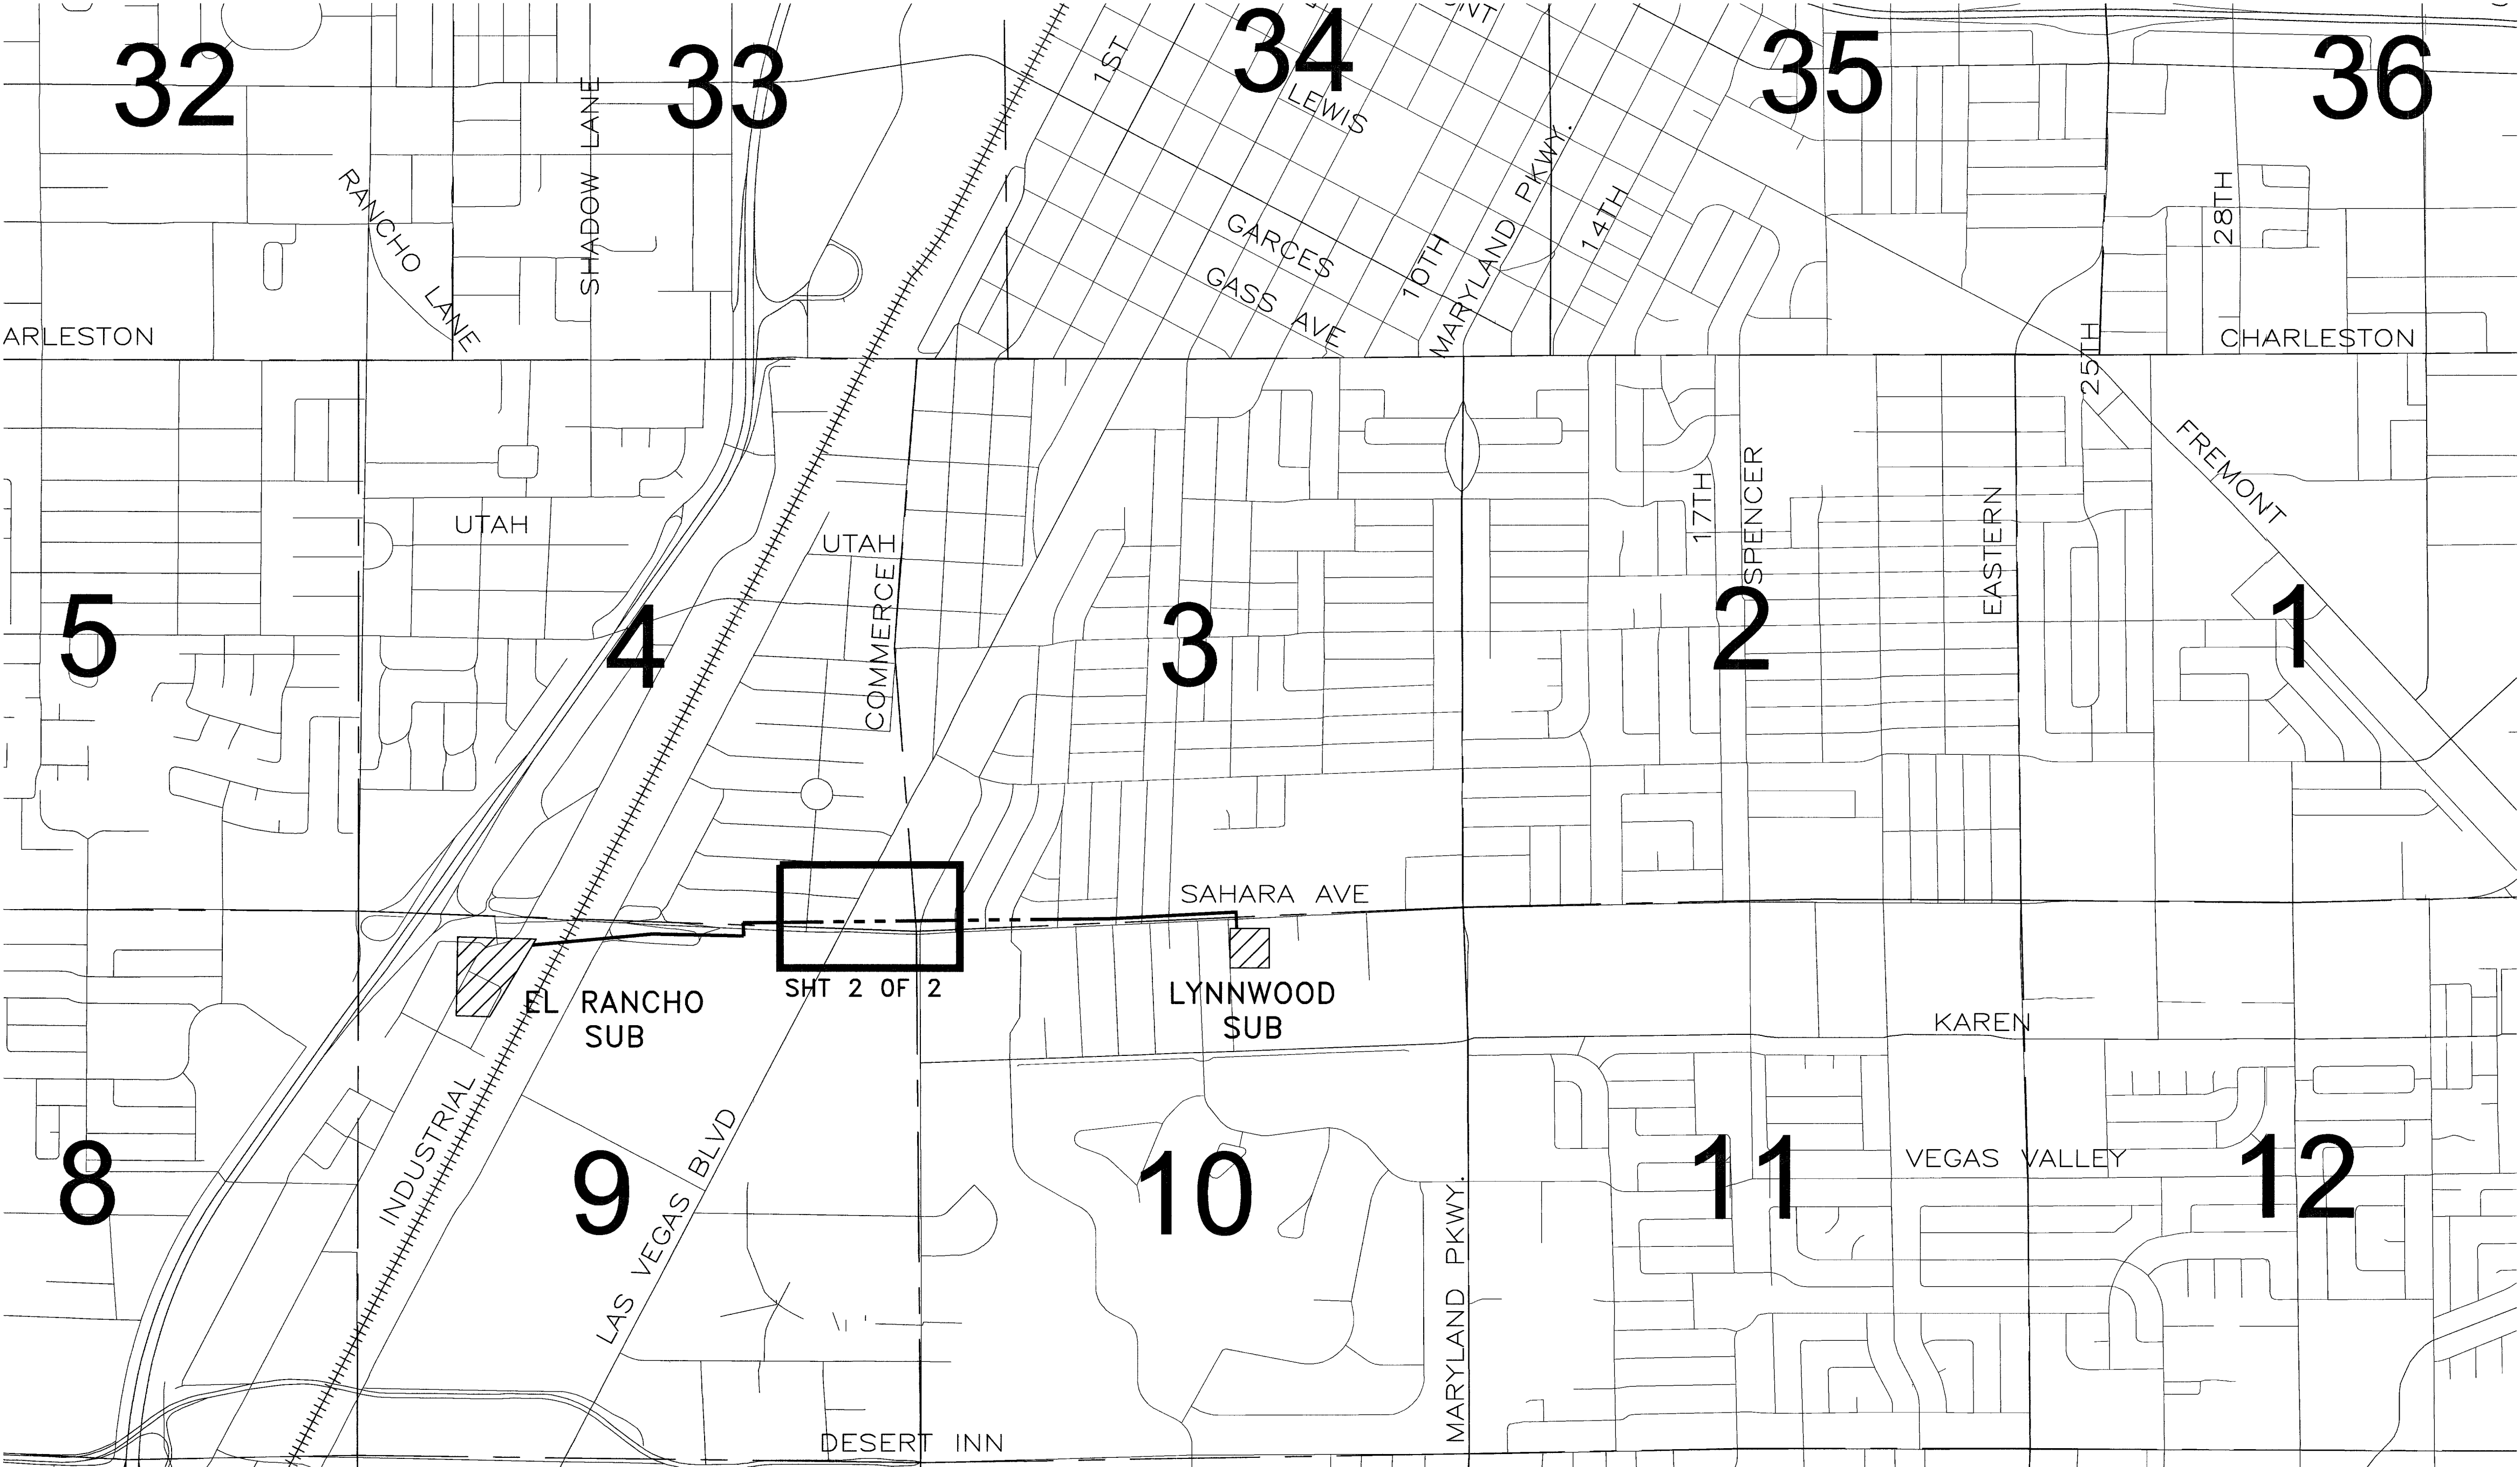

[Signature]
CITY OF LAS VEGAS APPROVAL


[Signature]
DATE

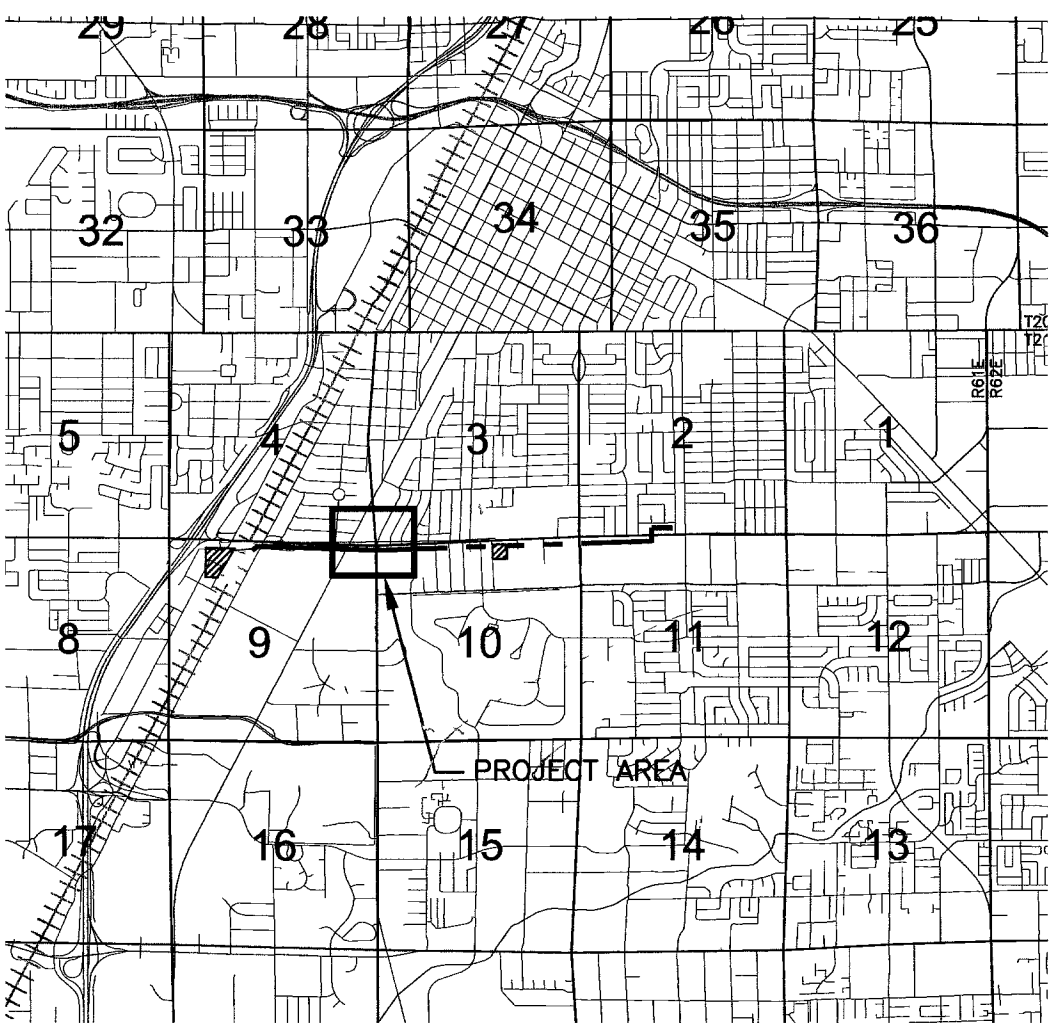


VICINITY MAP
NOT TO SCALE

COVERSHEET LEGEND

- EXISTING TRANSMISSION LINE
- - - SECTION LINE
- [Box] PLAN AND PROFILE SHEET SHOWING STRUCTURES TO BE REMOVED AND INSTALLED

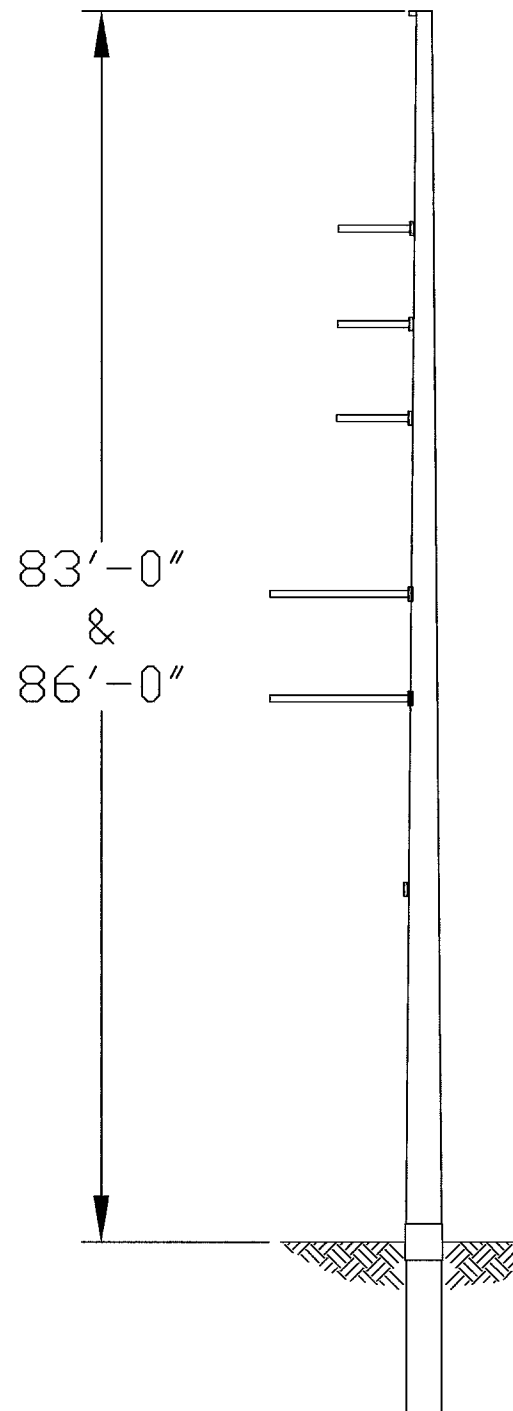

STRUCTURE
TO BE INSTALLED

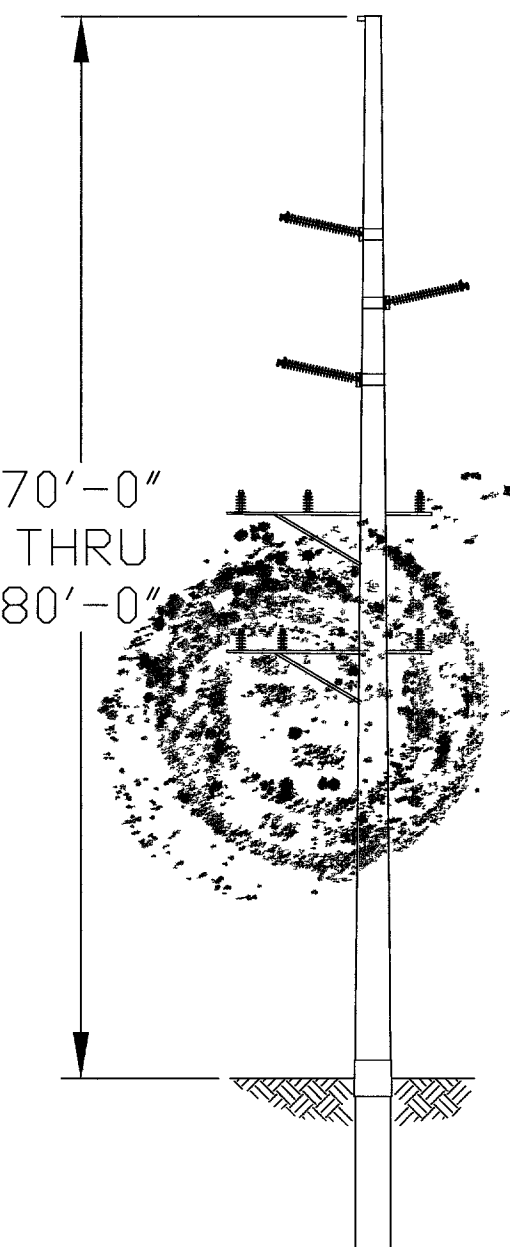

STRUCTURE
TO BE REMOVED


NOTES:
CONTACT PERSON: MIKE CURBY (702) 375-8454
NEVADA POWER COMPANY
DESIGNER / COORDINATOR
6226 WEST SAHARA AVENUE
LAS VEGAS, NEVADA 89146

85026

REV	DESCRIPTION	REVISION RECORD	DRAFT	DATE	DESIGNED	DATE	CKED	DATE	APP'D	DATE	REF.
5											
4											
3											
2											
1											
0	FIRST COVER SHEET										

Nevada Power SM
69KV TRANSMISSION LINE
ADJUST EL RANCHO - LYNNWOOD
COVER SHEET

SCALE: AS NOTED
DWG. 441.69.15-1
PROJ. ID. TL311TMTL5

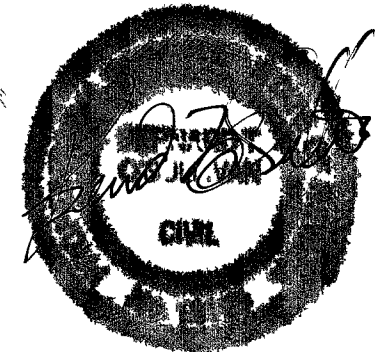

SHEET NO.
1
OF
2

107U 9490-NPC