



UTILITY

- 12" WATER PIPELINE
- 66" WATER PIPELINE
- IN-LINE VALVE VAULT
- ACCESS MANHOLE (TO PIPELINE)
- BLOWOFF
- COMBINATION AIR VALVE
- TEST STATION (CATHODIC)
- REDUCER
- END CAP FOR WATER PIPELINE
- WATER VALVE
- FIRE HYDRANT ASSEMBLY
- WATER METER
- WATER METER SIZE
- SANITARY SEWER MANHOLE
- POWER POLE W/GUY WIRE
- STREET LIGHT (GENERIC SYMBOL NOT RELATED TO WATTAGE)
- POLYGON FOR TRANSMISSION POLE
- ELECTRICAL BOX
- ELECTRICAL PANEL BOX
- CABLE TV
- GAS LINE
- SANITARY SEWER
- UNDERGROUND POWER
- UNDERGROUND TELEPHONE
- VALVE (INITIALS INDICATE OWNERSHIP AND/ OR TYPE)
- GAS CATHODE PROTECTION RECTIFIER
- UTILITY BOX (INITIALS INDICATE OWNER AND / OR TYPE)
- PUBLIC SERVICE UTILITY POLE LINE TO SHOW DIRECTION OF RUN OF OVERHEAD LINE
- UTILITY STUB-OUT
- TRAFFIC CONTROL SIGN
- FIRE ALARM BOX ON PEDESTAL
- FIRE ALARM BOX ON PEDESTAL WITH MANHOLE CASING
- TRAFFIC SIGNAL CONTROLLER
- TRAFFIC SIGNAL CONTROLLER AND NUMBER INDICATES SIZE)
- TRAFFIC SIGNAL WITH LUMINAIRE
- TRAFFIC SIGNAL DETECTOR LOOP
- SERVICE POINT PAD MOUNTED
- 7 GAGE LIGHTING STANDARD
- 11 GAGE LIGHTING STANDARD
- 100 W LUMINAIRE
- 150 W LUMINAIRE
- 200 W LUMINAIRE
- 250 W LUMINAIRE
- 400 W LUMINAIRE
- 750 W LUMINAIRE
- TRAFFIC SIGNAL POLE
- SCHOOL FLASHER
- GATE VALVE
- DOUBLE CHECK DETECTOR ASSEMBLY (DCDA)

PROPOSED

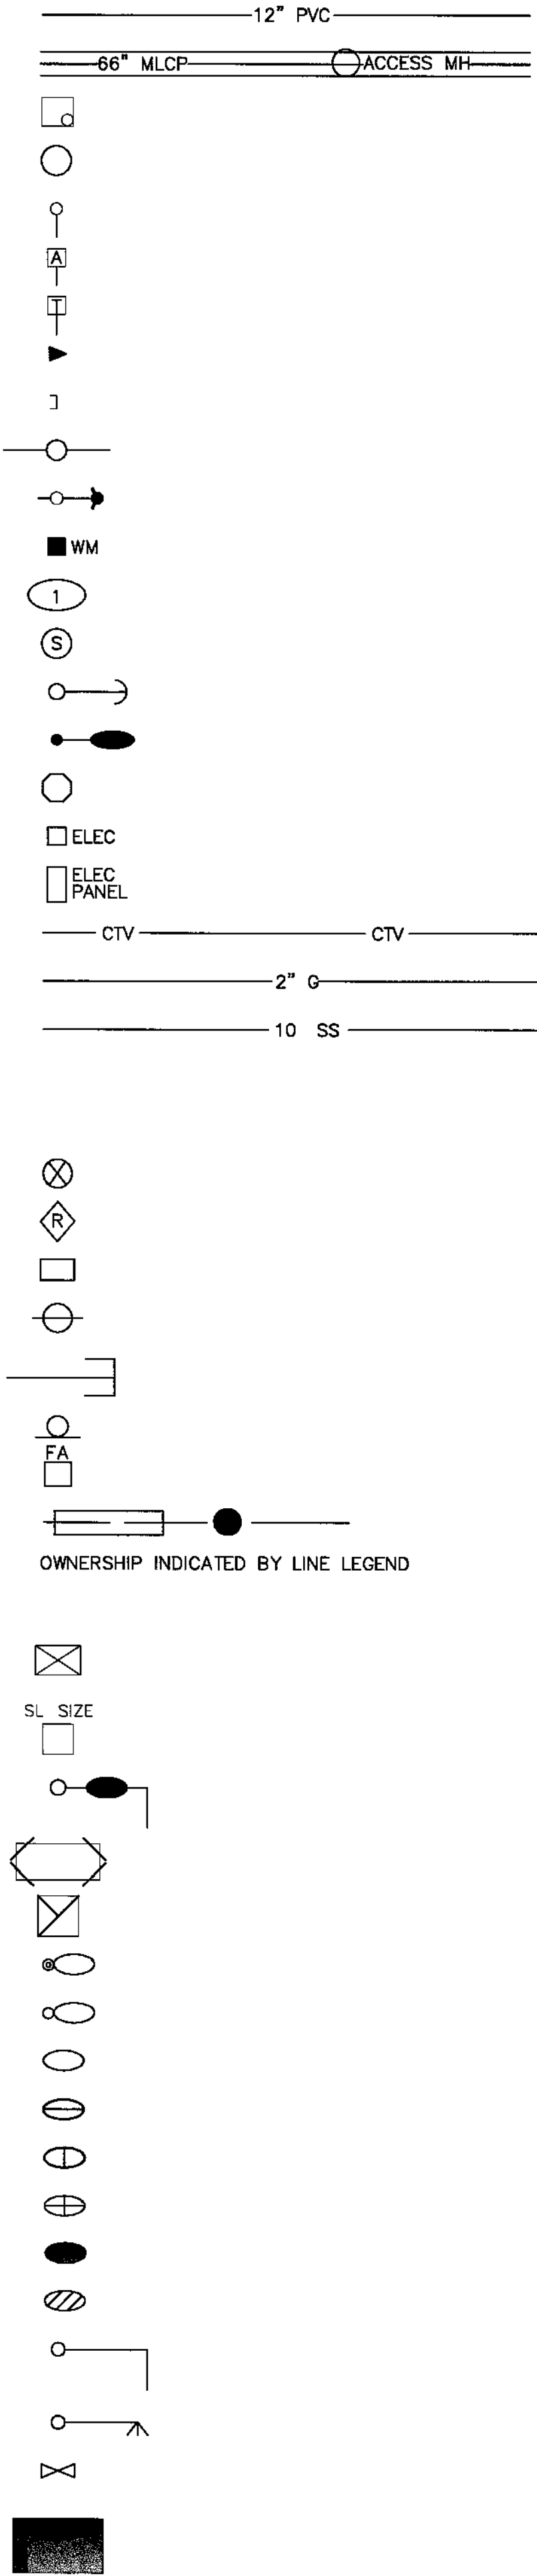

EXISTING

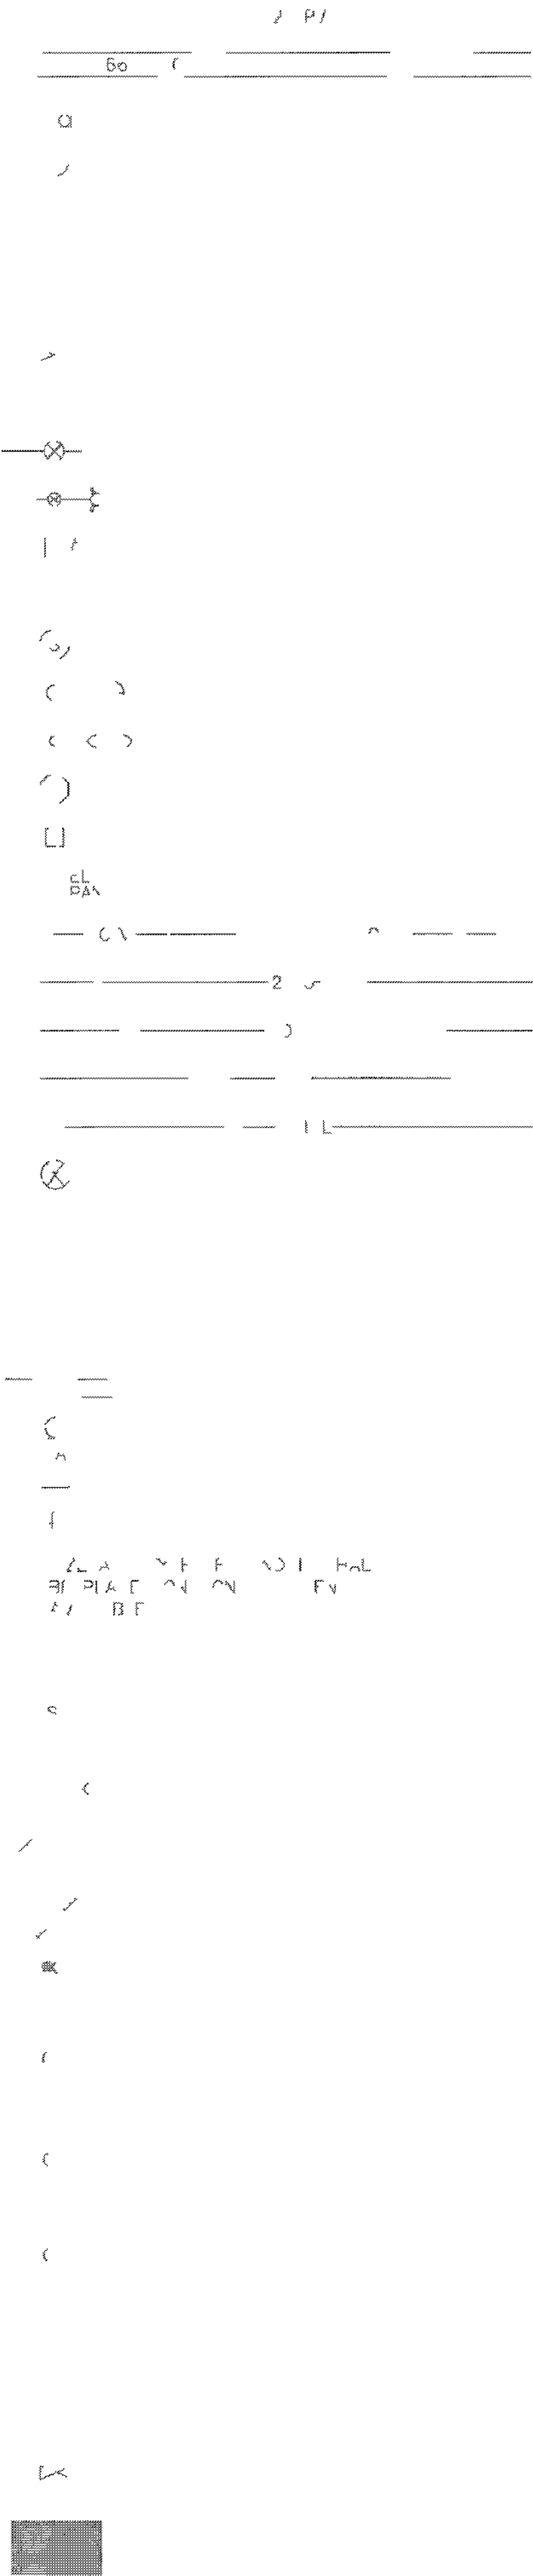

GEOMETRIC

- EDGE OF PAVEMENT
- FENCE
- CURB GUTTER AND SIDEWALK
- CENTER LINE
- BLOCK WALL
- RETAINING WALL
- STREET NAME SIGN
- DRIVEWAY

SITE PLAN

- TRUNK DIA IN INCHES)
- HEDGE (NOTE SIZE & SPECIES)
- STEPS (NOTE TYPE AND NO OF RISERS)
- EXISTING BUILDING & FOUNDATION

MISCELLANEOUS

- ANGLE (HORIZONTAL OR VERTICAL)
- ANGLE OF CURVE
- FIELD WELD
- REFERENCE BUBBLE

- IDENTIFICATION HEXAGON
- CUT LINE-ASPHALT CONC OR PCC CONC
- TEST HOLE
- MISCELLANEOUS SYMBOL (ABBREVIATION INDICATES TYPE)

SURVEY

- SURVEY MONUMENT
- PROPERTY LINE
- RIGHT-OF-WAY LINE
- PATENT RESERVATION OR EASEMENT LINE
- SECTION LINE
- CONCRETE MONUMENT
- CONCRETE MONUMENT SURVEY LINE


DRAINAGE / GRADING

- STORM DRAIN MANHOLE
- CONTOURS
- STORM DRAIN
- DIRECTION OF FLOW
- FLOW LINE OF DITCH OR CHANNEL
- DROP INLET


- ELEVATIONS
- CUT OR FILL SLOPES

- WING TYPE HEADWALL
- VALLEY GUTTER
- PIPE

PROPOSED

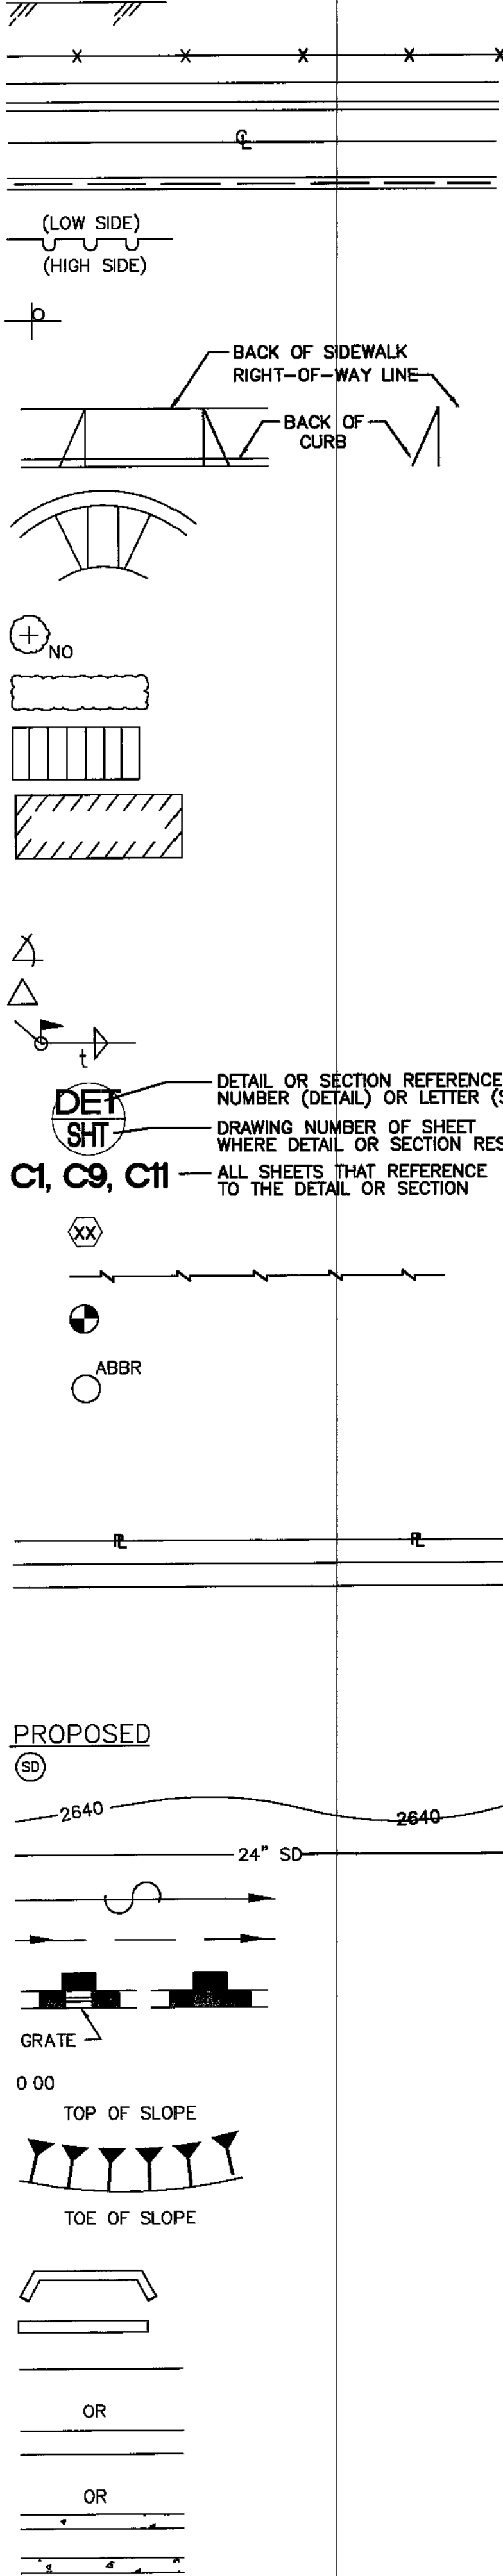

EXISTING

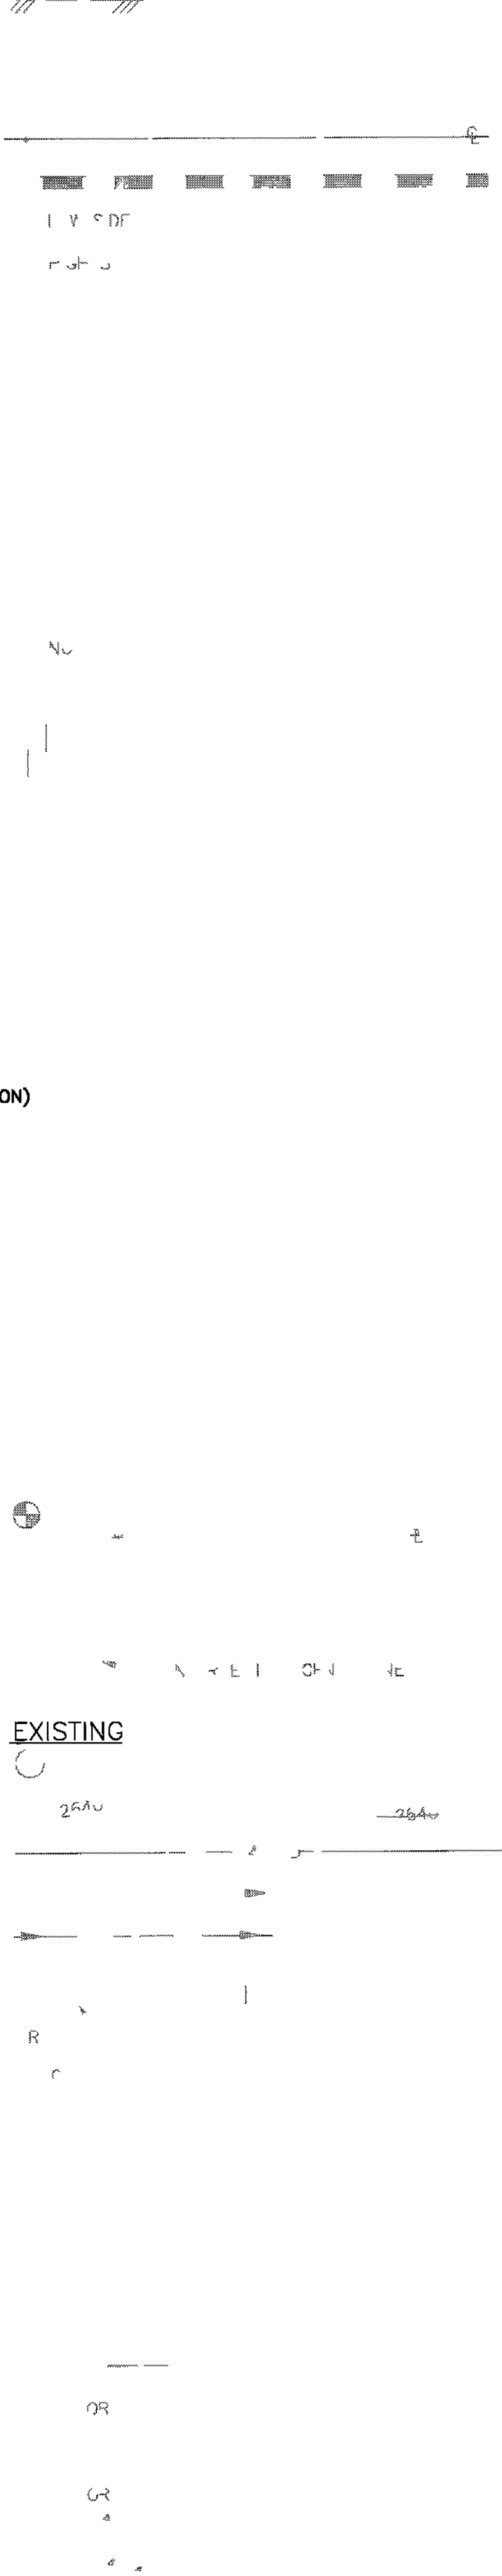

REVISIONS

REV	BY	APPR	DESCRIPTION	DATE

SPECTRUM
SURVEYING & ENGINEERING
7351 W CHARLESTON BLVD SUITE 120
LAS VEGAS, NEVADA 8917
OFFICE (702) 367-7705
FAX (702) 367-8733

DEVELOPER
SR CONSTRUCTION CO
3579 RED ROCK STREET
LAS VEGAS, NV 89103
PHONE (702) 877-6111
FAX (702) 258-6326

LEGEND
APN# 125-36-302-005
5000 NORTH JONES BOULEVARD
LAS VEGAS NV 89130

PROFESSIONAL ENGINEER
RANDOLPH SKORINSKI
EX-06-30-06
CIVIL
Exp No 14985
9/12/06

ENGINEER'S SEAL

CITY PLAN#	COUNTY PLAN#	STATE PLAN#	DATE	JOB NO	DRAWN BY	CHECKED BY	SCALE
			09/12/06	006001			
C4							

CLW *107V4743