

11-4-47

CITY OF LAS VEGAS
REGIONAL STREETS AND HIGHWAYS
CLARK COUNTY
DECATUR BOULEVARD IMPROVEMENTS
WASHINGTON AVENUE TO U.S. HIGHWAY N° 95
PUBLIC WORKS DEPARTMENT-SERVICES DIVISION-ENGINEERING SECTION

BID N° 66.32 CONTRACT N° C.L.V. - 332
SPECIAL IMPROVEMENT DISTRICT NO.481 CITY OF LAS VEGAS
SPECIAL IMPROVEMENT DISTRICT NO.5 COUNTY OF CLARK

- INDEX -

SHEET NO.	DESCRIPTION
1	TITLE SHEET, LOCATION MAP AND INDEX
2	PLAN AND PROFILE, STA. 0+00.00 TO STA. 4+40.00
3	PLAN AND PROFILE, STA. 4+40.00 TO STA. 9+00.00
4	PLAN AND PROFILE, STA. 9+00.00 TO STA. 14+00.00
5	PLAN AND PROFILE, STA. 14+00.00 TO STA. 19+00.00
6	PLAN AND PROFILE, STA. 19+00.00 TO STA. 24+00.00
7	PLAN AND PROFILE, STA. 24+00.00 TO STA. 29+00.00
8	PLAN AND PROFILE, STA. 29+00.00 TO STA. 34+00.00
9	PLAN AND PROFILE, STA. 34+00.00 TO STA. 39+00.00
10	PLAN AND PROFILE, STA. 39+00.00 TO STA. 44+00.00
11	PLAN AND PROFILE, STA. 44+00.00 TO STA. 49+00.00
12	PLAN AND PROFILE, STA. 49+00.00 TO STA. 54+00.00
13	PLAN AND PROFILE, STA. 54+00.00 TO STA. 59+00.00
14	PLAN AND PROFILE, STA. 59+00.00 TO STA. 64+00.00
15	PLAN AND PROFILE, STA. 64+00.00 TO STA. 69+00.00
16	PLAN AND PROFILE, STA. 69+00.00 TO STA. 74+00.00
17	PLAN AND PROFILE, STA. 74+00.00 TO STA. 79+00.00
18	PLAN AND PROFILE, STA. 79+00.00 TO STA. 84+00.00
19	PLAN AND PROFILE, STA. 84+00.00 TO STA. 89+00.00
20	PLAN AND PROFILE, STA. 89+00.00 TO STA. 94+00.00
21	PLAN AND PROFILE, STA. 94+00.00 TO STA. 98+50.00
22	PLAN AND PROFILE, STA. 98+50.00 TO STA. 102+50.00
23	PLAN AND PROFILE, STA. 102+50.00 TO STA. 105+78.68
24	DECATUR BLVD. AND U.S. HIGHWAY N° 95 INTERSECTION
25	TYPICAL SECTION AND DETAIL SHEET
26	DETAIL SHEET
27	DETAIL SHEET
28	LOGS OF BORINGS, SUMMARY OF QUANTITIES
29-35	STREET LIGHTING
36-40	TRAFFIC SIGNALS
41-42	LANDSCAPING
43-44	DRIVEWAY DETAILS
26-A	PLAN PROFILE RCP AT CARMEN BLVD.
26-B	DETAIL OF CURB INLET TYPE II



UTILITY COMPANY	NO SERVICE WITHIN PROJECT	PLANS REVIEWED BY	APPROVED FOR CONSTRUCTION
N.S.H.D. DISTRICT N°1			
CLARK COUNTY ENGINEER		<i>J.P. Sullivan</i>	<i>Jack P. Sullivan</i>
NEVADA POWER COMPANY			
CENTRAL TELEPHONE CO.			
SOUTHWEST GAS CO.			
L.V.V.W.D.			
SUPT. OF SANITATION			
CITY ELECTRICIAN			
FIRE DEPARTMENT			

- MAYOR -
ORAN K. GRAGSON

- COMMISSIONERS -
PHILIP M. MIRABELLI
S. GRANT STEWART
JAMES J. COREY
WESLEY G. HOWERY

- CITY MANAGER -
A. R. TRELEASE


DEPARTMENT OF PUBLIC WORKS	APPROVED FOR CONSTRUCTION	DATE OF APPROVAL
TRAFFIC ENGINEER	<i>Richard P. Sauer</i>	2-26-69
DESIGN SECTION CHIEF	<i>Richard P. Sauer</i>	2-26-69
CONSTRUCTION DIVISION ENGINEER	<i>J.P. Sullivan</i>	3-4-69
SERVICES DIVISION ENGINEER	<i>Richard P. Sauer</i>	8-4-69
DEP. DIRECTOR OF PUBLIC WORKS	<i>Richard P. Sauer</i>	3-5-69
DIRECTOR OF PUBLIC WORKS	<i>Richard P. Sauer</i>	3-5-69
MANAGING ENGINEER REGIONAL STS. & HIGHWAY COMM.	<i>C.P. Buckley</i>	5-1-69
CITY MANAGER	<i>A.R. Trelease</i>	2-27-69

- DIRECTOR OF PUBLIC WORKS -
RICHARD P. SAUER

"AS CONSTRUCTED"


CONTRACT
DRAWING
APR 22 1969

APPROVED DATE	RT	DIV	DATE
	7	0	4/18/69
	1	1	4/18/69
	2	1	4/18/69
	3	1	4/18/69
	4	1	4/18/69
	5	1	4/18/69
	6	1	4/18/69
	7	1	4/18/69
	8	1	4/18/69
	9	1	4/18/69

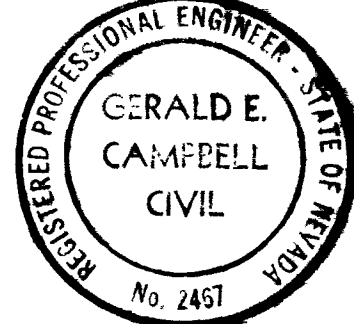

PLANS PREPARED BY
TYSON ENGINEERING COMPANY INC.
Gerald E. Campbell 5/17/69
GERALD E. CAMPBELL P.E. N° 2467

Oran K. Gragson
MAYOR, CITY OF LAS VEGAS
Oran K. Gragson
CITY CLERK
PUBLIC HEARING, DEC. 18, 1968

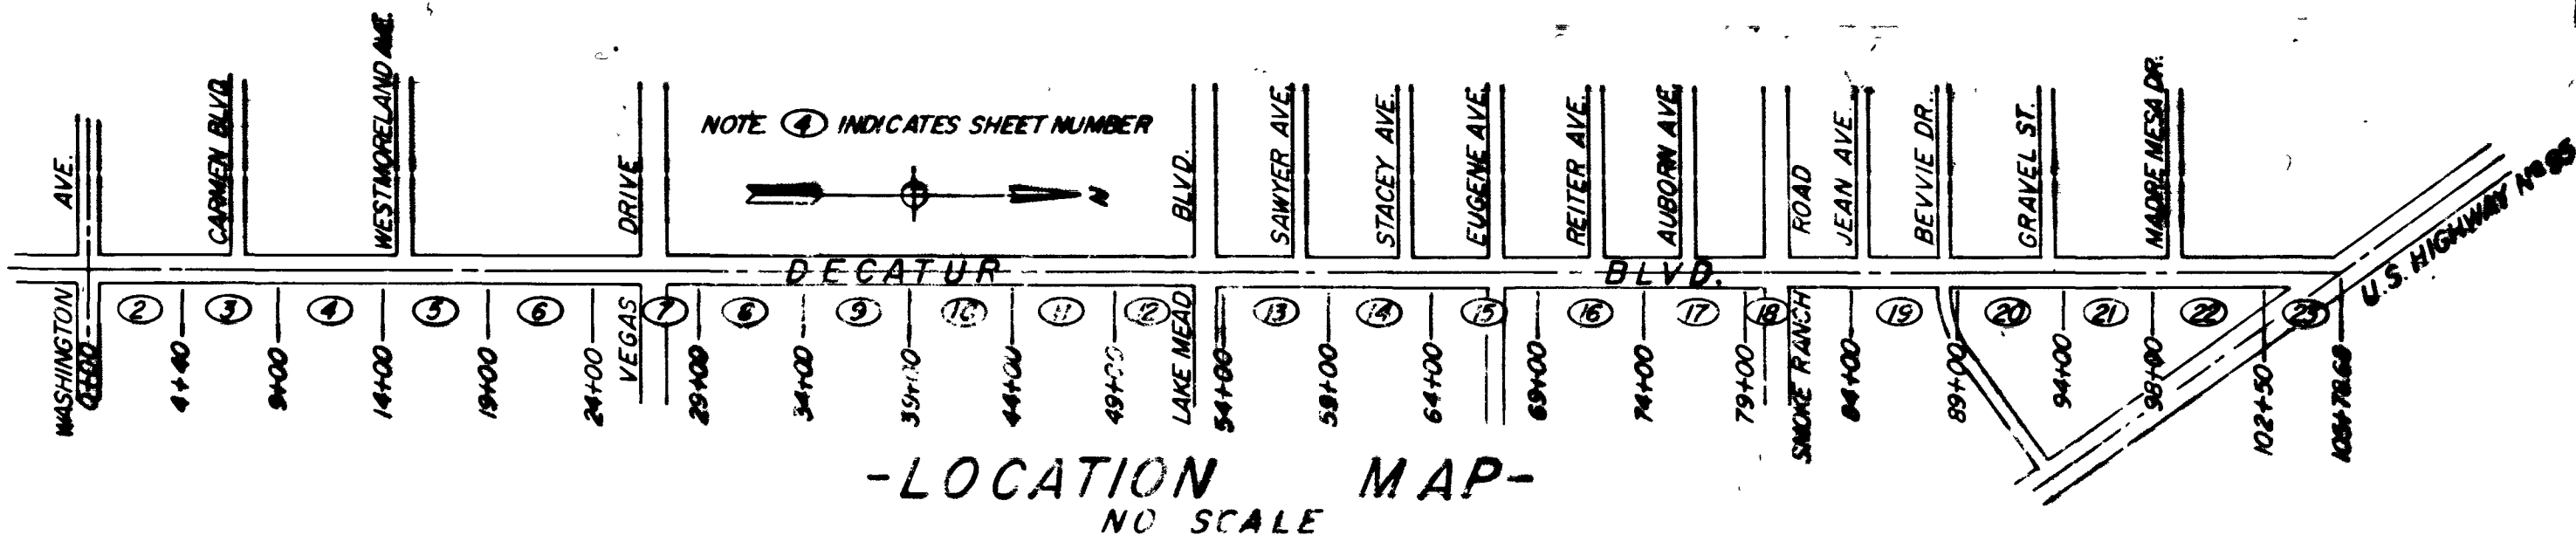

Let's sht 29 thru 35 207-V112
Traffic sht 36 thru 40 -208-V115, 116, 135,
V136 & 150
Median Indsp sht 41 & 42 - 65-19

SHEET 1 OF 42

107-V738
107-V738

