


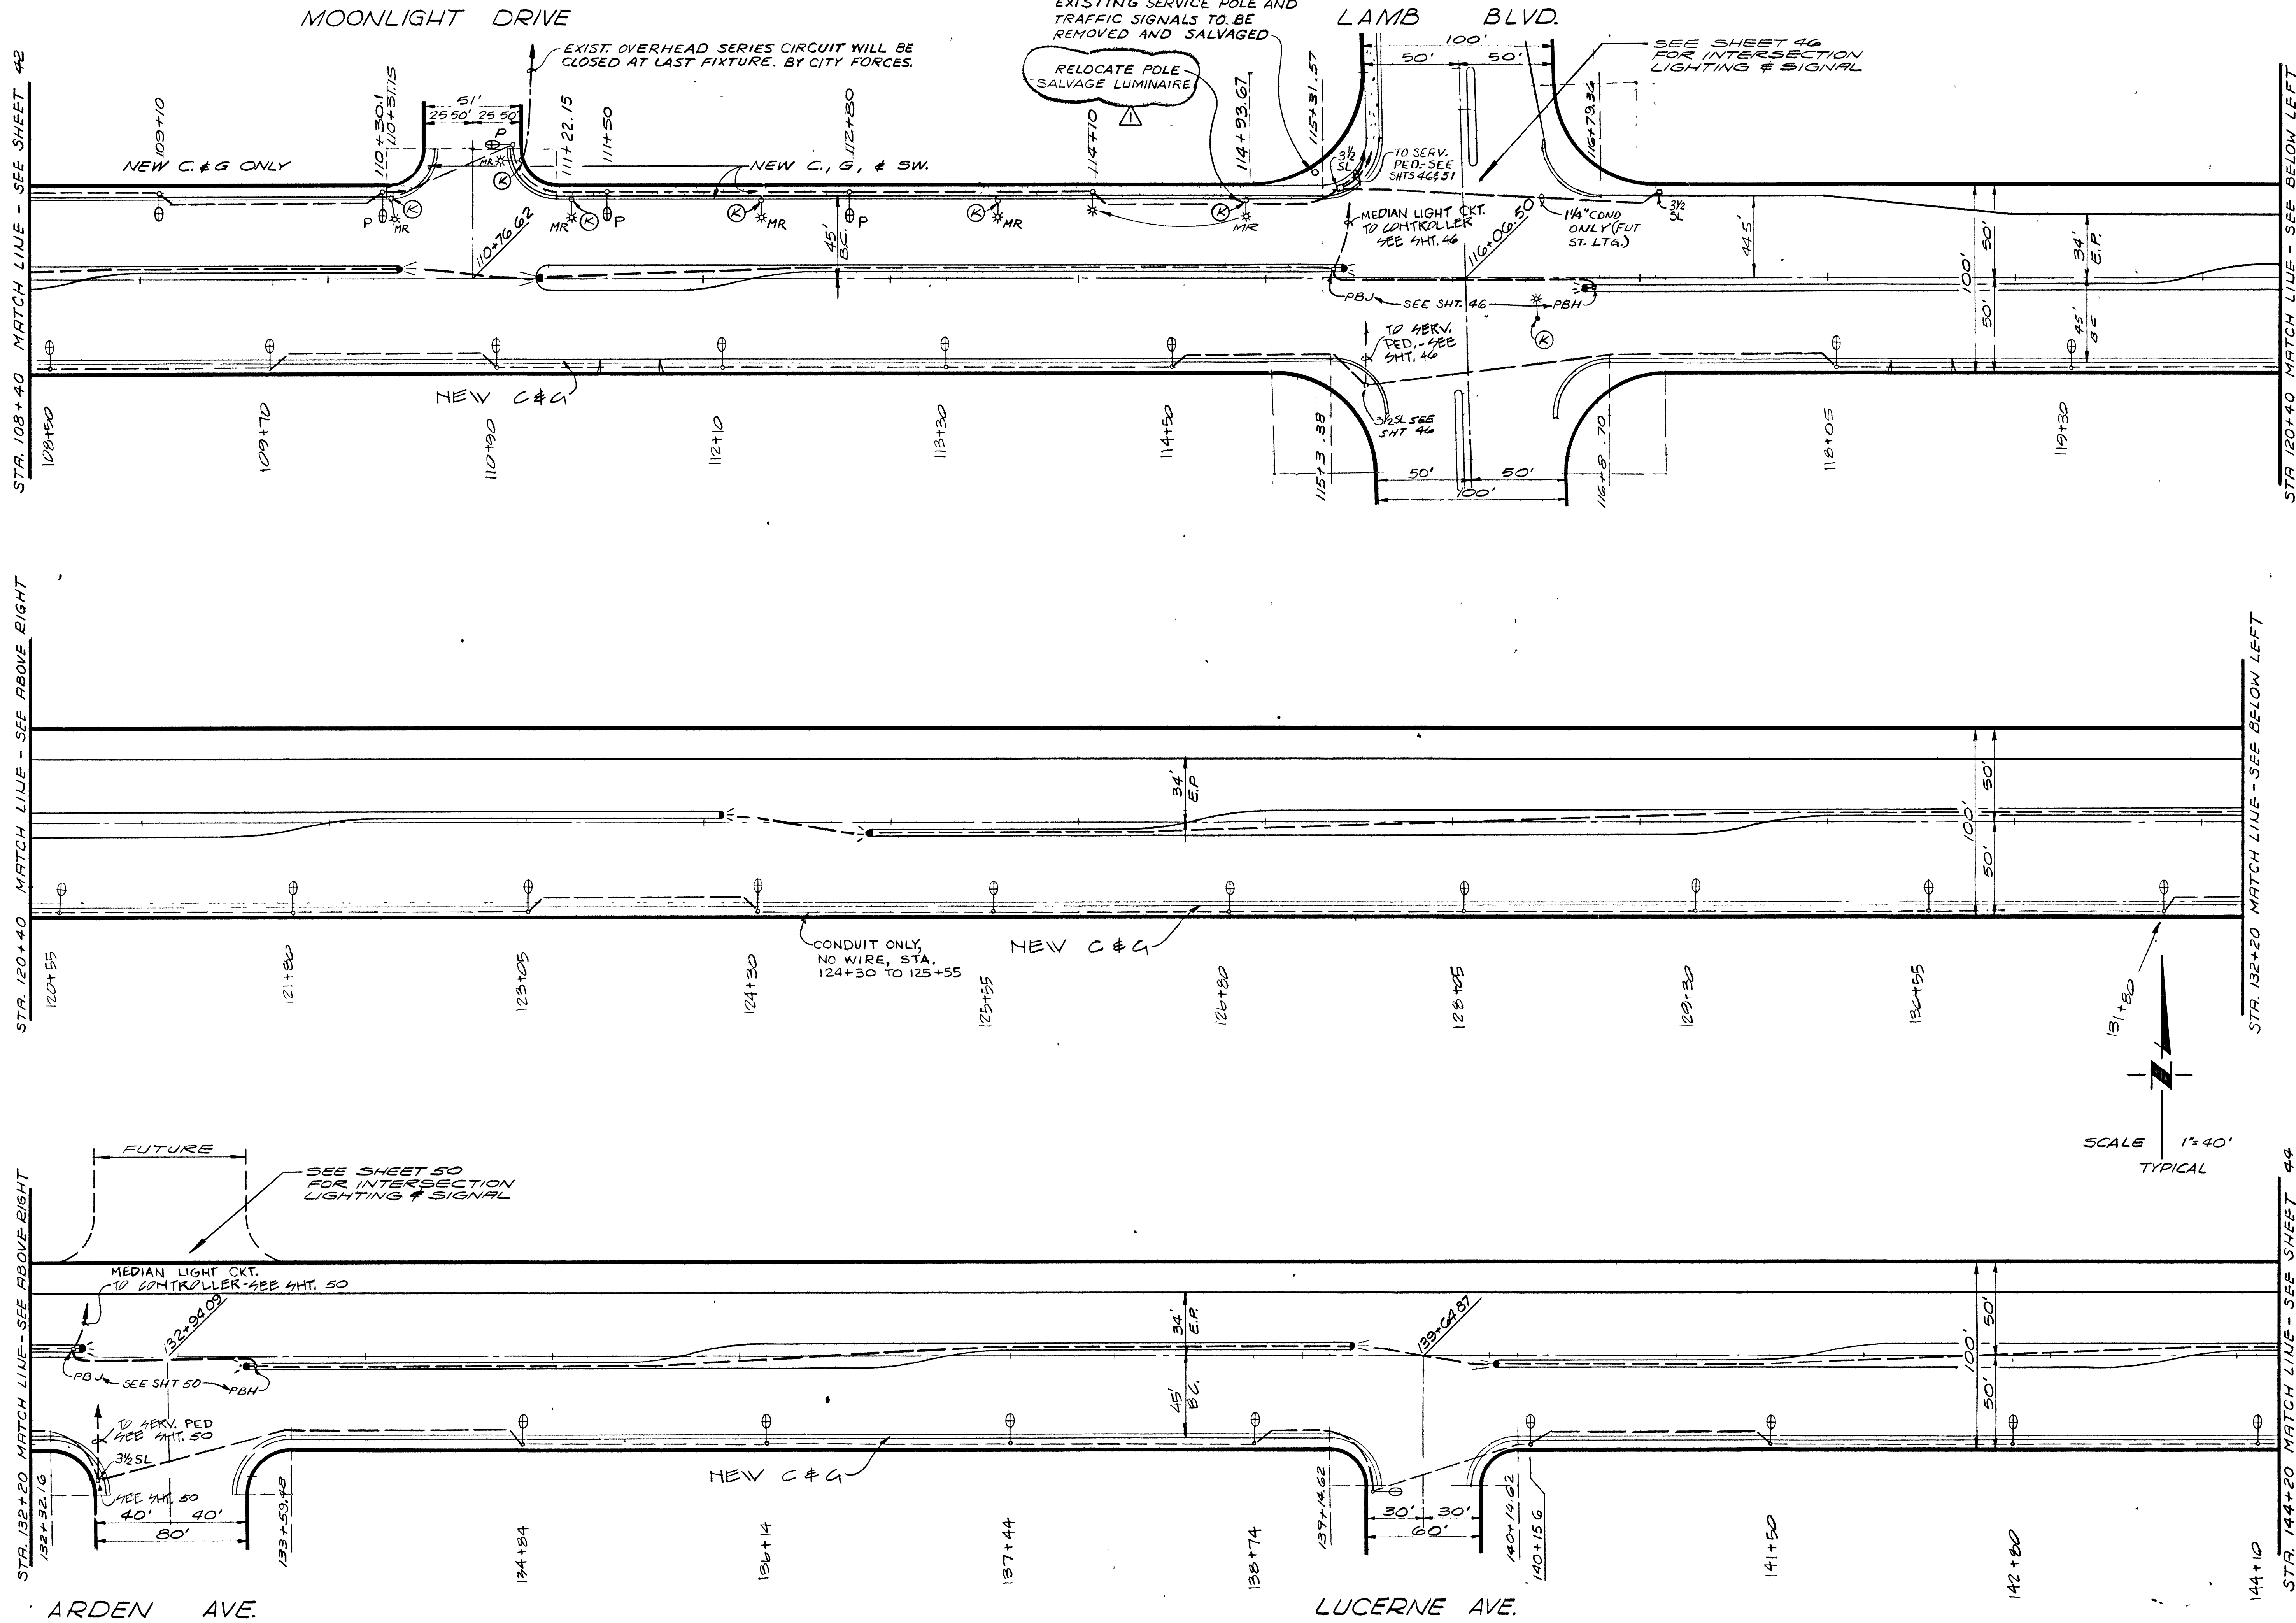

STR. 108+40 MATCH LINE - SEE SHEET 42

STR. 120+40 MATCH LINE - SEE ABOVE RIGHT

STR. 132+20 MATCH LINE - SEE ABOVE RIGHT

STR. 120+40 MATCH LINE - SEE BELOW LEFT

STR. 132+20 MATCH LINE - SEE BELOW LEFT

STR. 144+20 MATCH LINE - SEE SHEET 44

ARDEN AVE.

LUCERNE AVE.

SCALE 1"=40'
TYPICAL

Norbert Schneider REE 3447

AS BUILT DRAWING

SHEET
43
OF 53 SHEETS

REGIONAL STREET AND HIGHWAY COMMISSION, CLARK CO., NEV.
EAST CHARLESTON BLVD FROM FREMONT ST. TO NELLIS BLVD.
STREET AND MEDIAN LIGHTING PLAN
108+40 TO 144+20

WALLACE - MONTGOMERY, A JOINT VENTURE
G. C. WALLACE, Consulting Engineer
MONTGOMERY ENGINEERS OF NEVADA
705-5709
LAS VEGAS, NEVADA

RECOMMENDED
G. C. WALLACE
18/5 5/12/73
DATE
18/5 5/12/73
DATE
23/5 5/2/73
DATE
MONTGOMERY ENGINEERS OF NEVADA, P.E. NO. 5272

DESCRIPTION
AS BUILT
REV
DATE
18/5 5/12/73
DATE
23/5 5/2/73
DATE